

Date: 3/20/2019

Filename: ... \00\HIGHWAY\MSTA1... Title-2.dgn




THE GOLD STAR  
MEMORIAL HIGHWAY

# MAINE TURNPIKE AUTHORITY

DANIEL E. WATHEN, CHAIR  
ROBERT D. STONE, VICE CHAIR  
MICHAEL J. CIANCHETTE, MEMBER  
JOHN E. DORITY, MEMBER  
ANN R. ROBINSON, MEMBER  
THOMAS J. ZUKE, MEMBER  
BRUCE A. VAN NOTE, MEMBER EX-OFFICIO

S. PETER MILLS, EXECUTIVE DIRECTOR

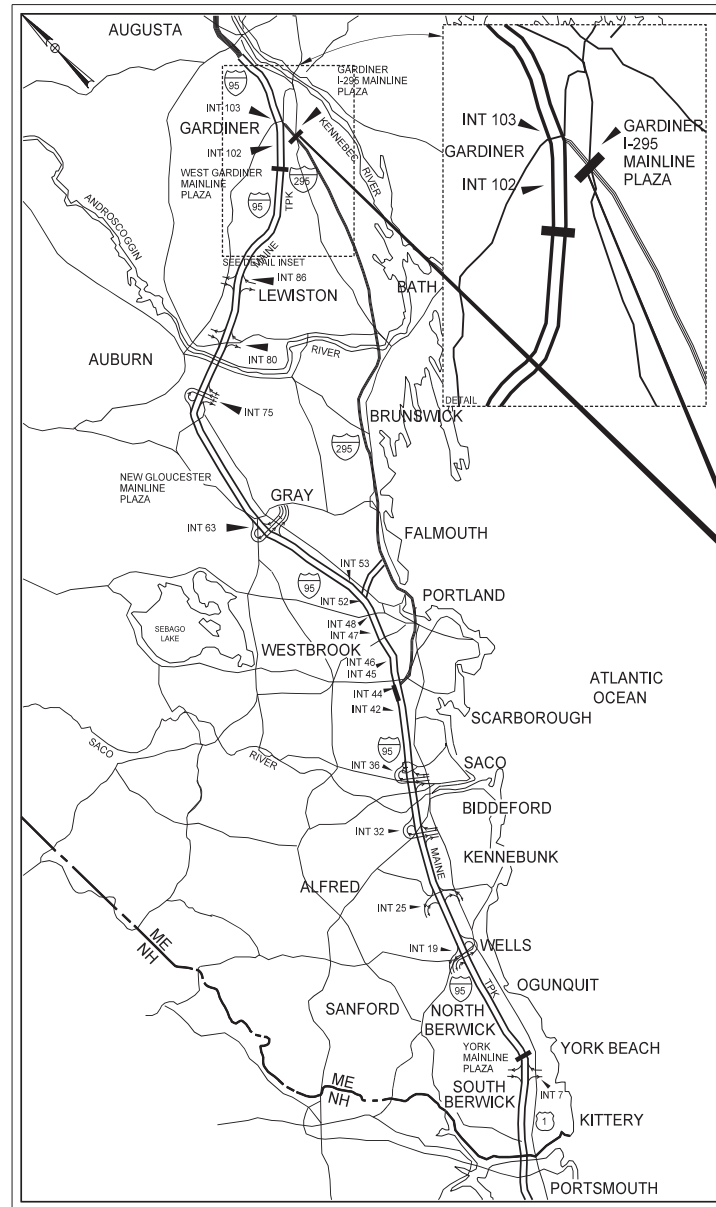

LOCATION MAP

INTERCHANGE 103 BARRIER TOLL PLAZA  
OPEN ROAD TOLLING CONVERSION  
MM 103.0

## INTERCHANGE 103 BARRIER TOLL PLAZA OPEN ROAD TOLLING CONVERSION (MM 103.0) 2019.04 VOLUME 2 OF 3

### INDEX OF SHEETS

#### VOLUME 1 HIGHWAY

SHEET NO.	DESCRIPTION
1	TITLE SHEET
2-4	ESTIMATED QUANTITIES & EARTHWORK SUMMARY
5	GENERAL NOTES
6-12	TYPICAL SECTIONS
13-91	MAINTENANCE OF TRAFFIC PLANS & SECTION
92-99	MAINTENANCE OF TRAFFIC DETAILS & SIGN SUMMARY
100-113	DETAILS
114-133	GENERAL PLANS
134-148	PROFILES
149-167	GEOMETRIC PLANS
168-171	PAVEMENT PLANS
172-205	SIGNING & STRIPING PLANS & DETAILS
206-220	LIGHTING PLANS & DETAILS
221	COMMUNICATION PLAN
222-225	SITE PLANS
226-229	SITE DETAILS
230-231	RETAINING WALL DETAILS
232-234	LIMIT OF DISTURBANCE PLAN

#### VOLUME 2 HIGHWAY

SHEET NO.	DESCRIPTION
235-358	CROSS SECTIONS

#### VOLUME 3

##### PLAZA STRUCTURAL

SHEET NO.	DESCRIPTION
359-410	PLAZA STRUCTURAL PLANS
411-412	PLAZA STAIR ARCHITECTURAL SECTIONS AND DETAILS

##### PLAZA FACILITIES

SHEET NO.	DESCRIPTION
413-418	PLAZA MECHANICAL, ELECTRICAL, & PLUMBING PLANS
419-447	TOLLING SYSTEM PLANS

##### BUILDING ARCHITECTURAL

SHEET NO.	DESCRIPTION
448-462	BUILDING ARCHITECTURAL PLANS

##### BUILDING STRUCTURAL

SHEET NO.	DESCRIPTION
463-472	BUILDING STRUCTURAL PLANS

##### BUILDING FACILITIES



SHEET NO.	DESCRIPTION
473-481	BUILDING PLUMBING PLANS
482-492	BUILDING MECHANICAL PLANS
493-503	BUILDING ELECTRICAL PLANS

CONTRACT 2019.04



Date: 3/20/2019

 Filename: ...:\00\HIGHWAY\MSTA\\_xsect.dgn

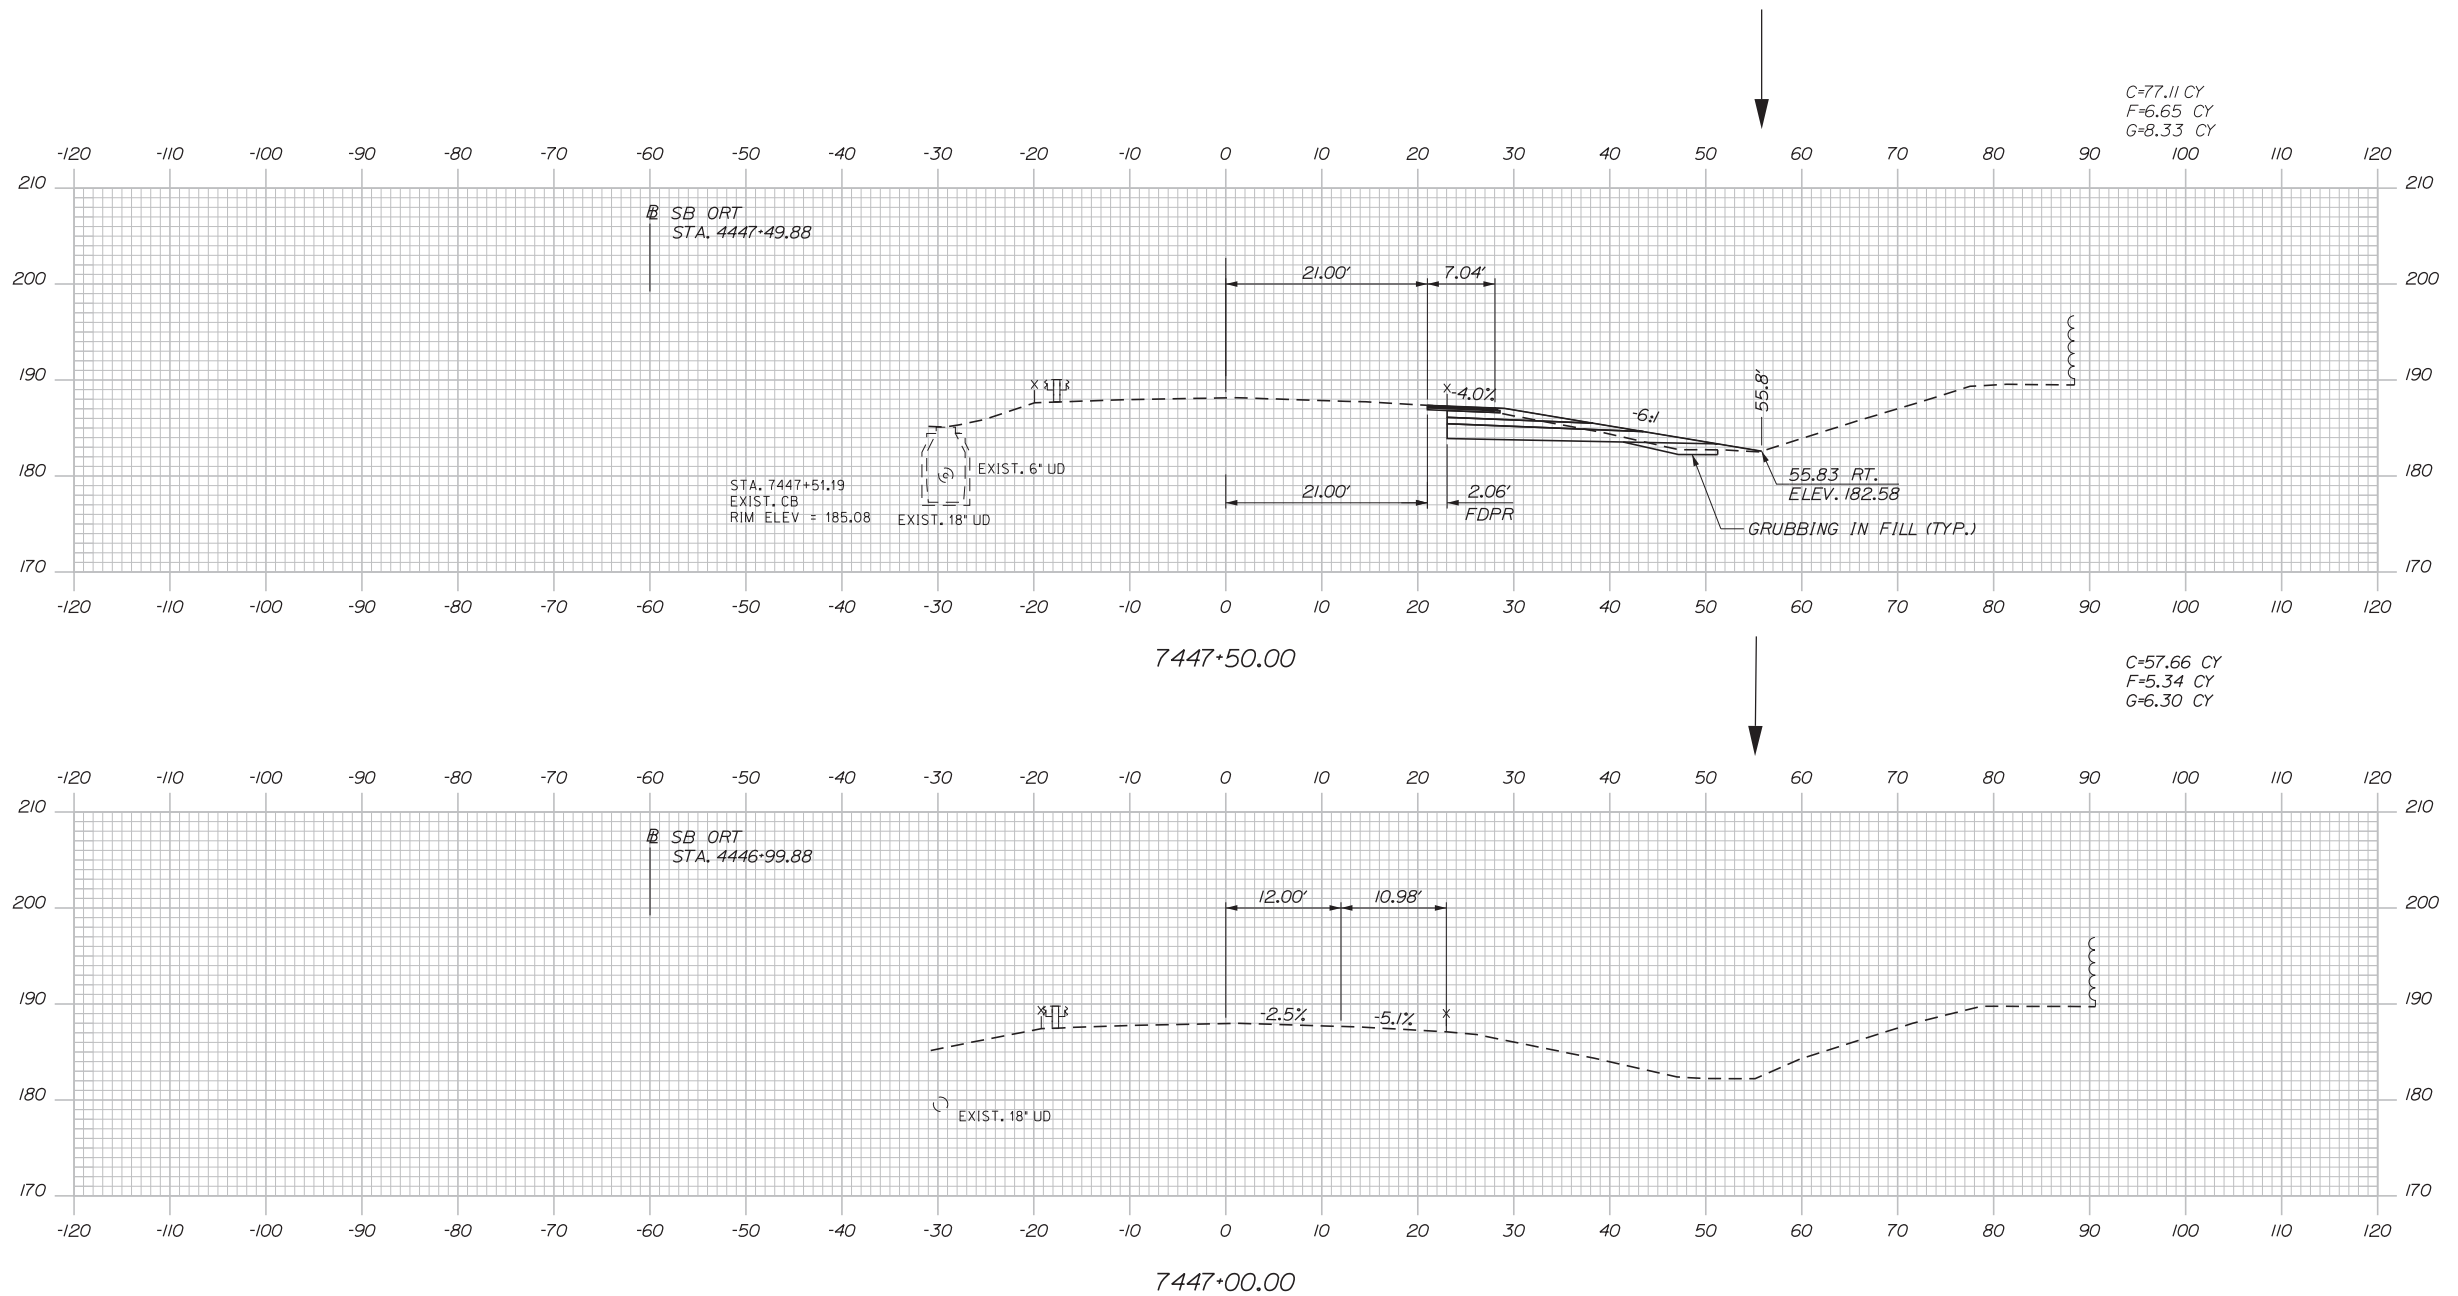

Designed by:



STANTEC CONSULTING SERVICES INC.  
 482 PAYNE ROAD  
 SCARBOROUGH, ME 04074  
 TEL (207) 887-3448  
 FAX (207) 883-3376



**THE GOLD STAR  
 MEMORIAL HIGHWAY**

INTERCHANGE 103  
 ORT CONVERSION  
 NB ORT  
 STA. 7447+00.00 TO STA. 7447+50.00

No.	Revision	By	Date

CONSULTANT PROJECT MANAGER: LAUREN MEEK, PE			
Designed	By	Date	Checked
	PLP	3\20\19	LEM
Drawn	By	Date	In Charge of
	EJB	3\20\19	GAE

MTA PROJECT MANAGER: RALPH NORWOOD, IV, PE, PTOE

 


CONTRACT: 2019.04

SHEET NUMBER: XS-01

235 OF 503

Date: 3/20/2019

Filename: ... \00\HIGHWAY\MSTA\\_xsect.dgn

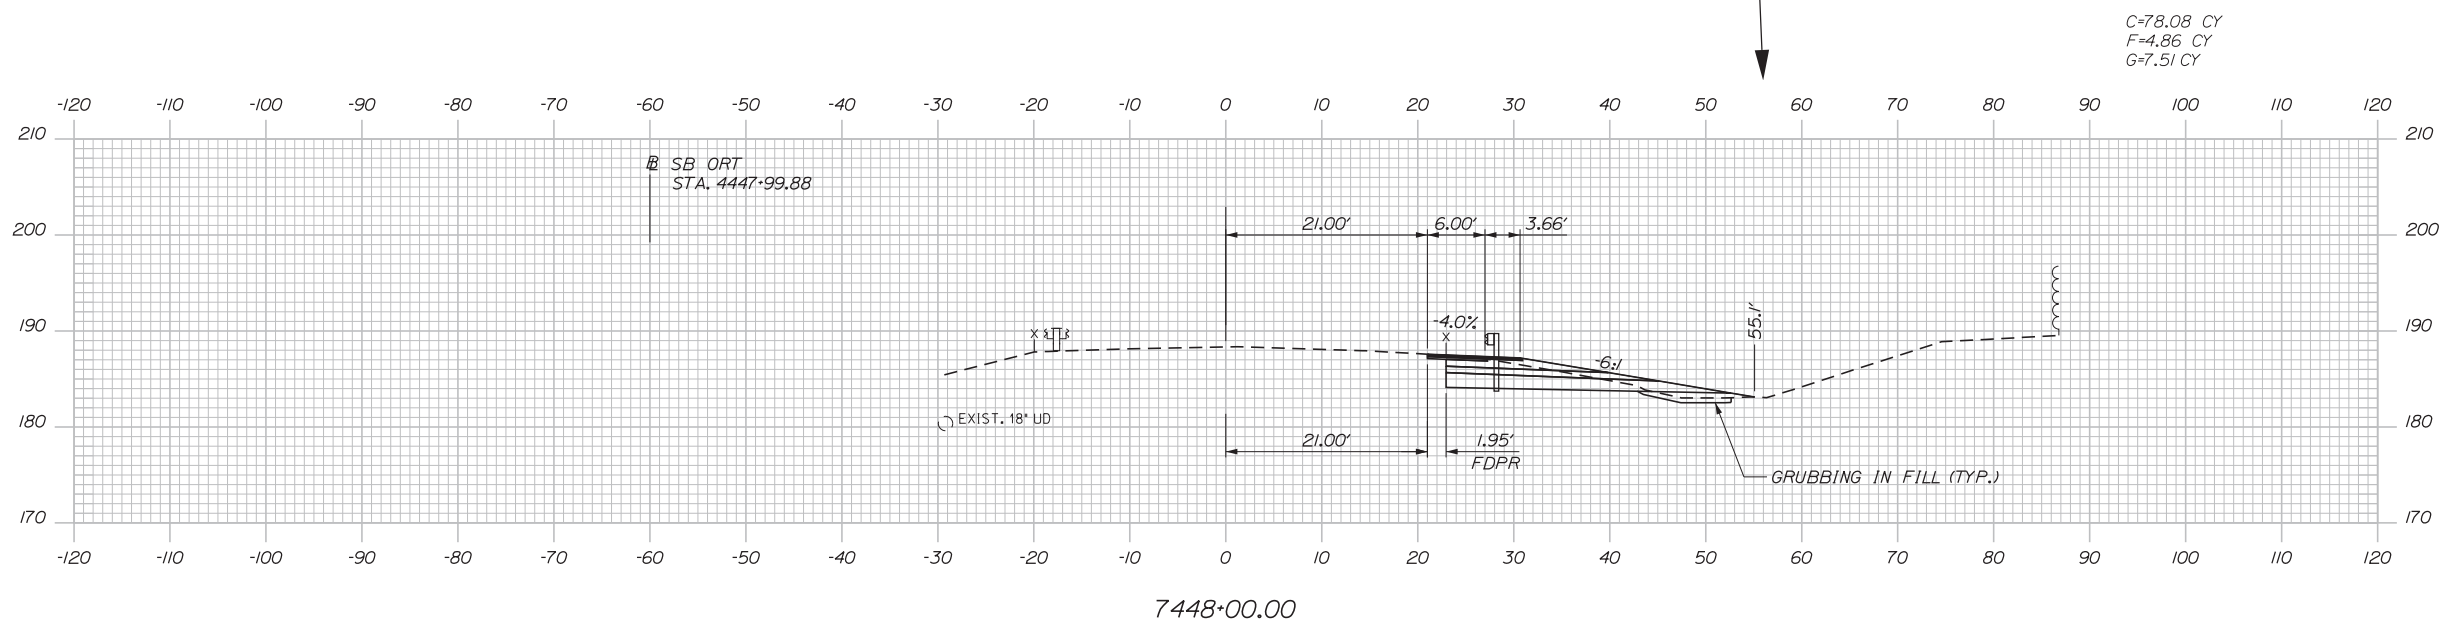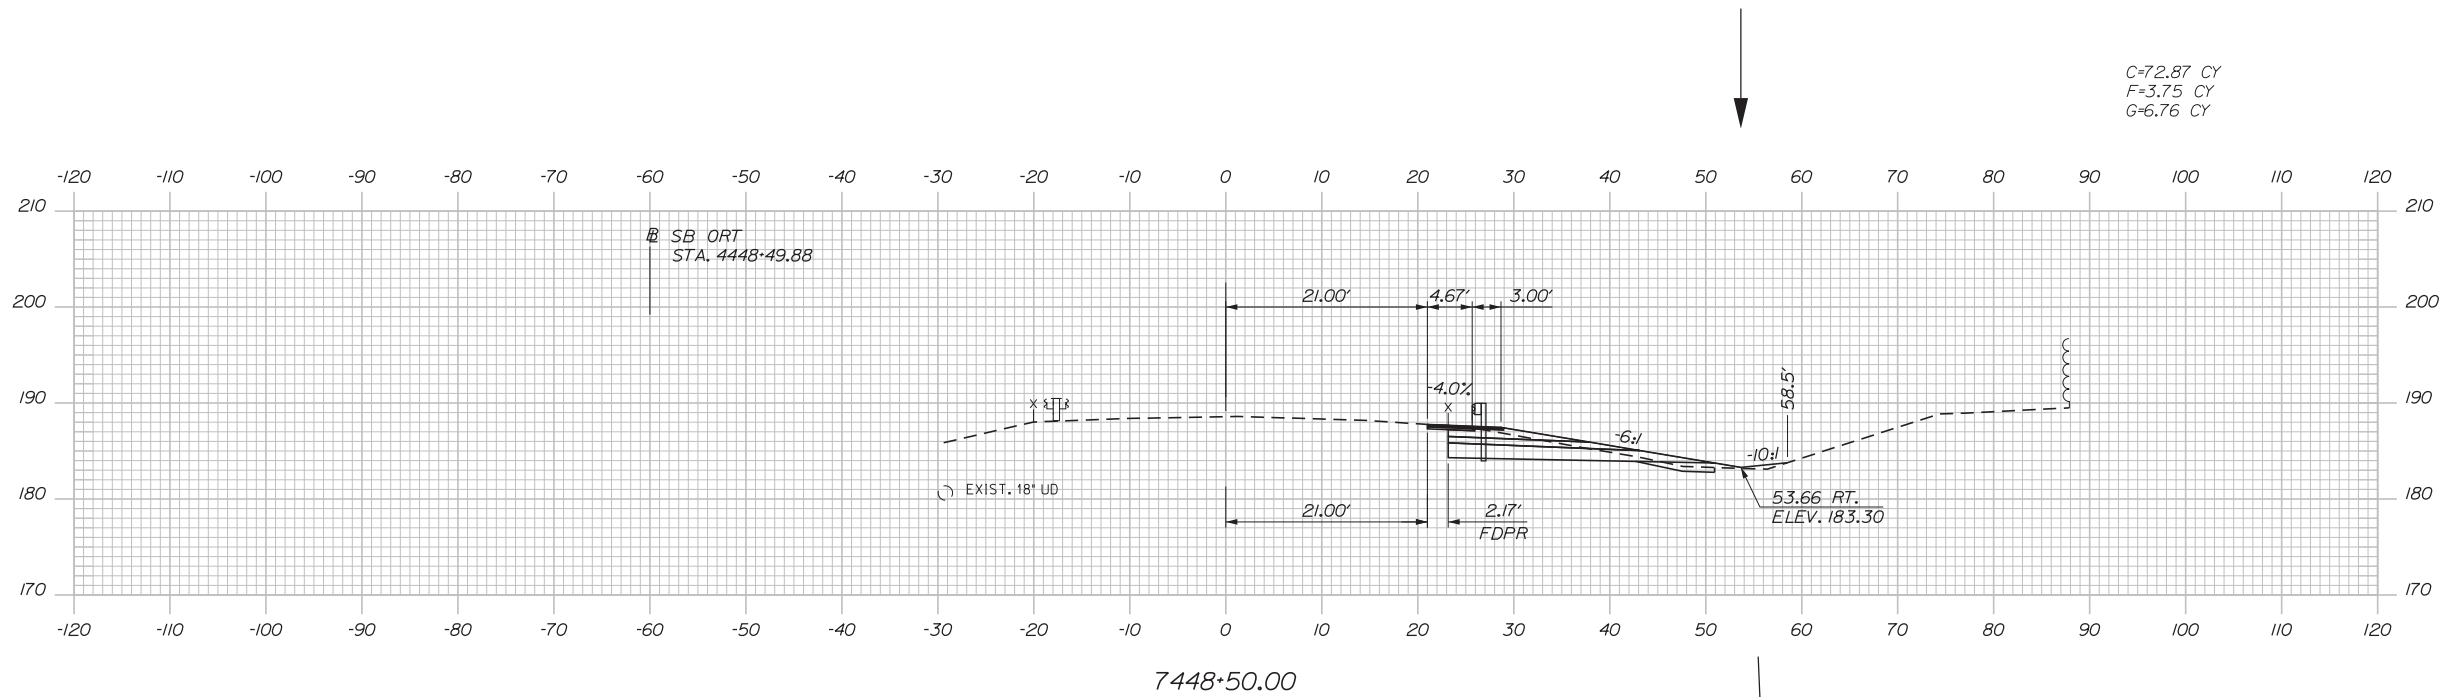

Designed by:



STANTEC CONSULTING SERVICES INC.  
482 PAYNE ROAD  
SCARBOROUGH, ME 04074  
TEL (207) 887-3448  
FAX (207) 883-3376



THE GOLD STAR  
MEMORIAL HIGHWAY

INTERCHANGE 103  
ORT CONVERSION  
NB ORT  
STA. 7448+00.00 TO STA. 7448+50.00

No.	Revision	By	Date

CONSULTANT PROJECT MANAGER: LAUREN MEEK, PE			
Designed	By	Date	Checked
Drawn	By	Date	In Charge of
	PLP	3\20\19	LEM
	EJB	3\20\19	GAE

MTA PROJECT MANAGER: RALPH NORWOOD, IV, PE, PTOE

 


CONTRACT: 2019.04

SHEET NUMBER: XS-02

236 OF 503

Date: 3/20/2019

Filename: ... \00\HIGHWAY\MSTA\\_xsect.dgn

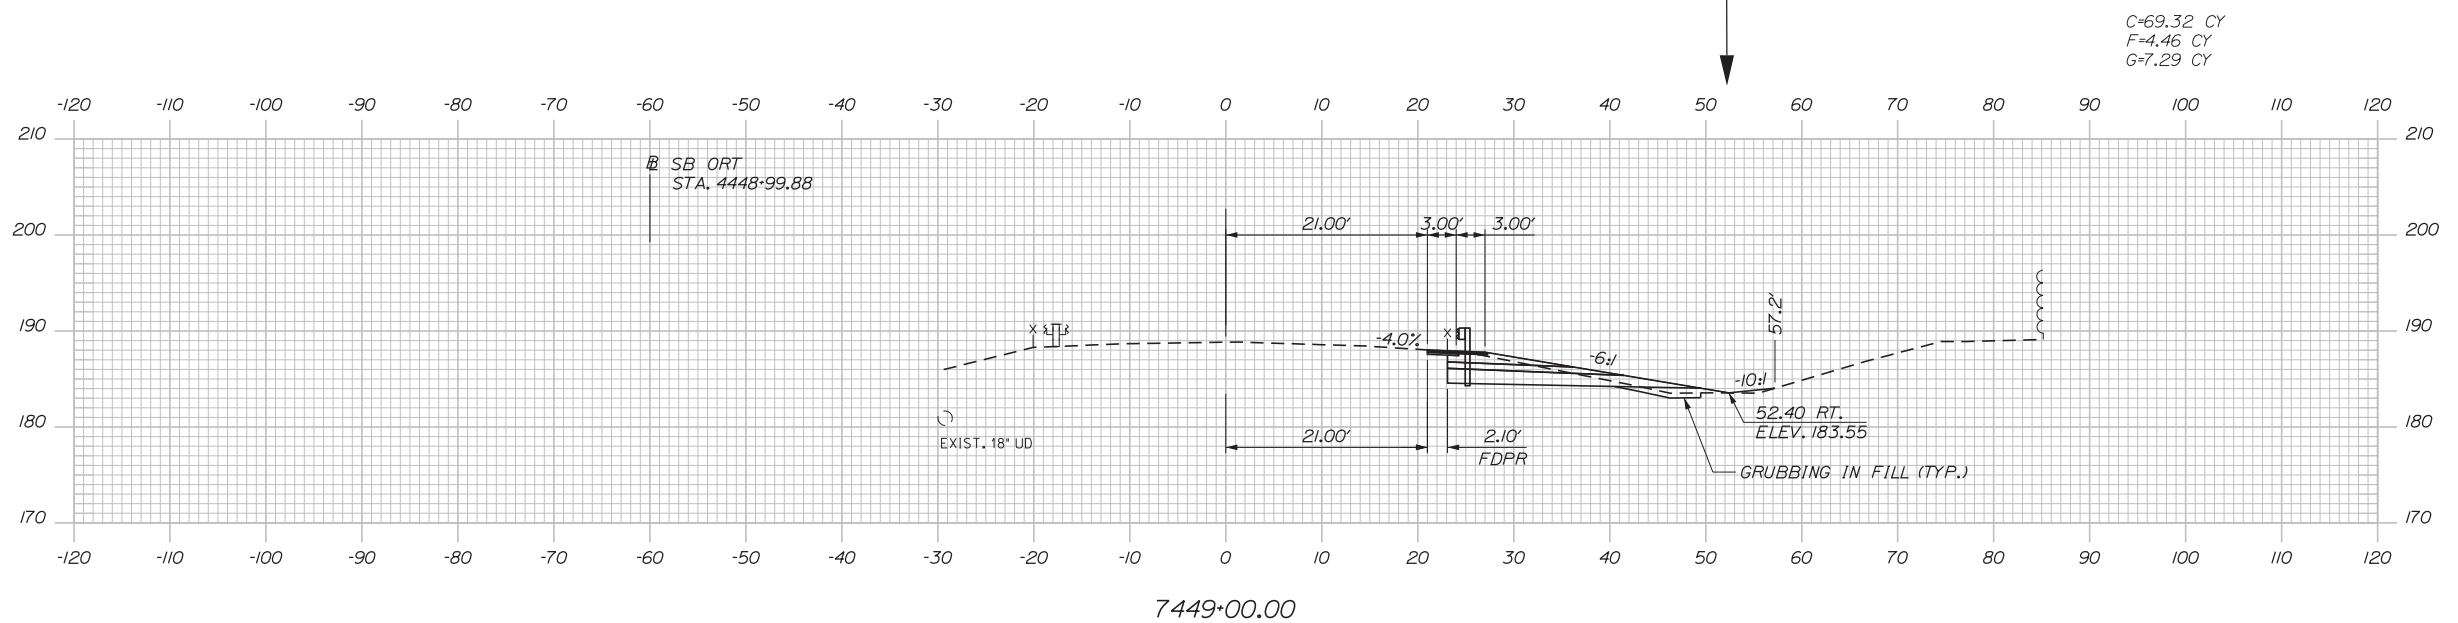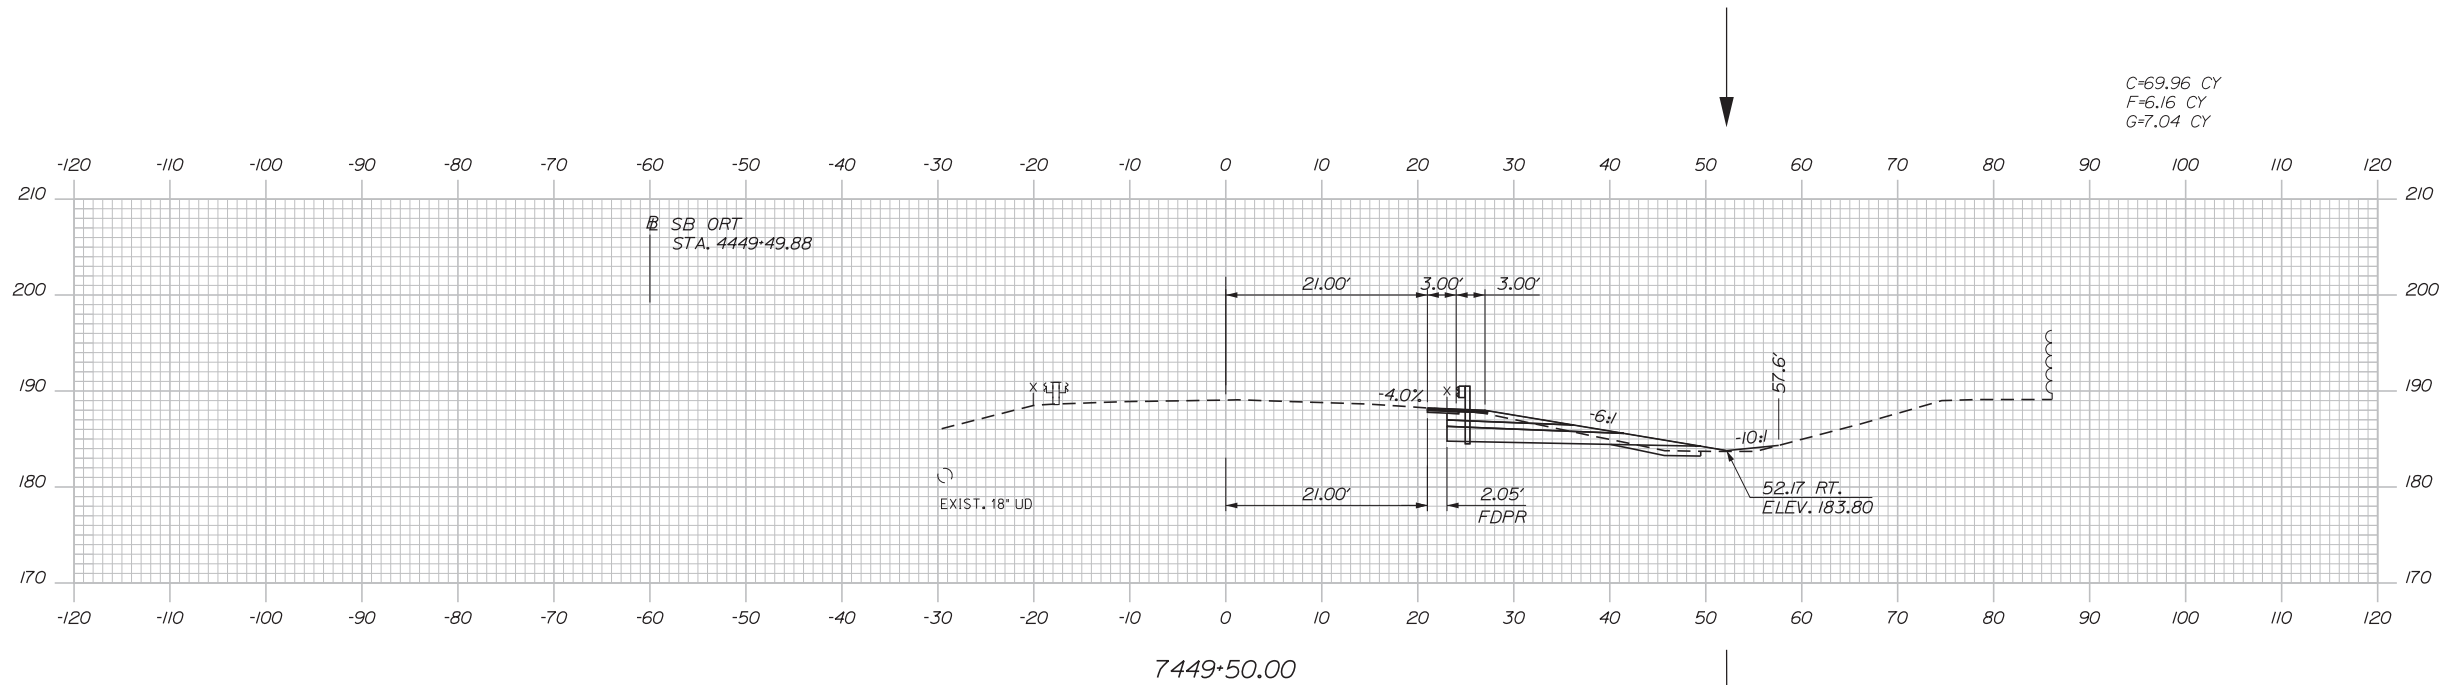

Designed by:



STANTEC CONSULTING SERVICES INC.  
482 PAYNE ROAD  
SCARBOROUGH, ME 04074  
TEL (207) 887-3448  
FAX (207) 883-3376



THE GOLD STAR  
MEMORIAL HIGHWAY

INTERCHANGE 103  
ORT CONVERSION  
NB ORT  
STA. 7449+00.00 TO STA. 7449+50.00

No.	Revision	By	Date

CONSULTANT PROJECT MANAGER: LAUREN MEEK, PE			
Designed	By	Date	Checked
	PLP	3\20\19	LEM
Drawn	By	Date	In Charge of
	EJB	3\20\19	GAE

MTA PROJECT MANAGER: RALPH NORWOOD, IV, PE, PTOE

CONTRACT: 2019.04

 

SHEET NUMBER: XS-03

237 OF 503



Date: 3/20/2019

Filename: ... \00\HIGHWAY\MSTA\\_xsect.dgn

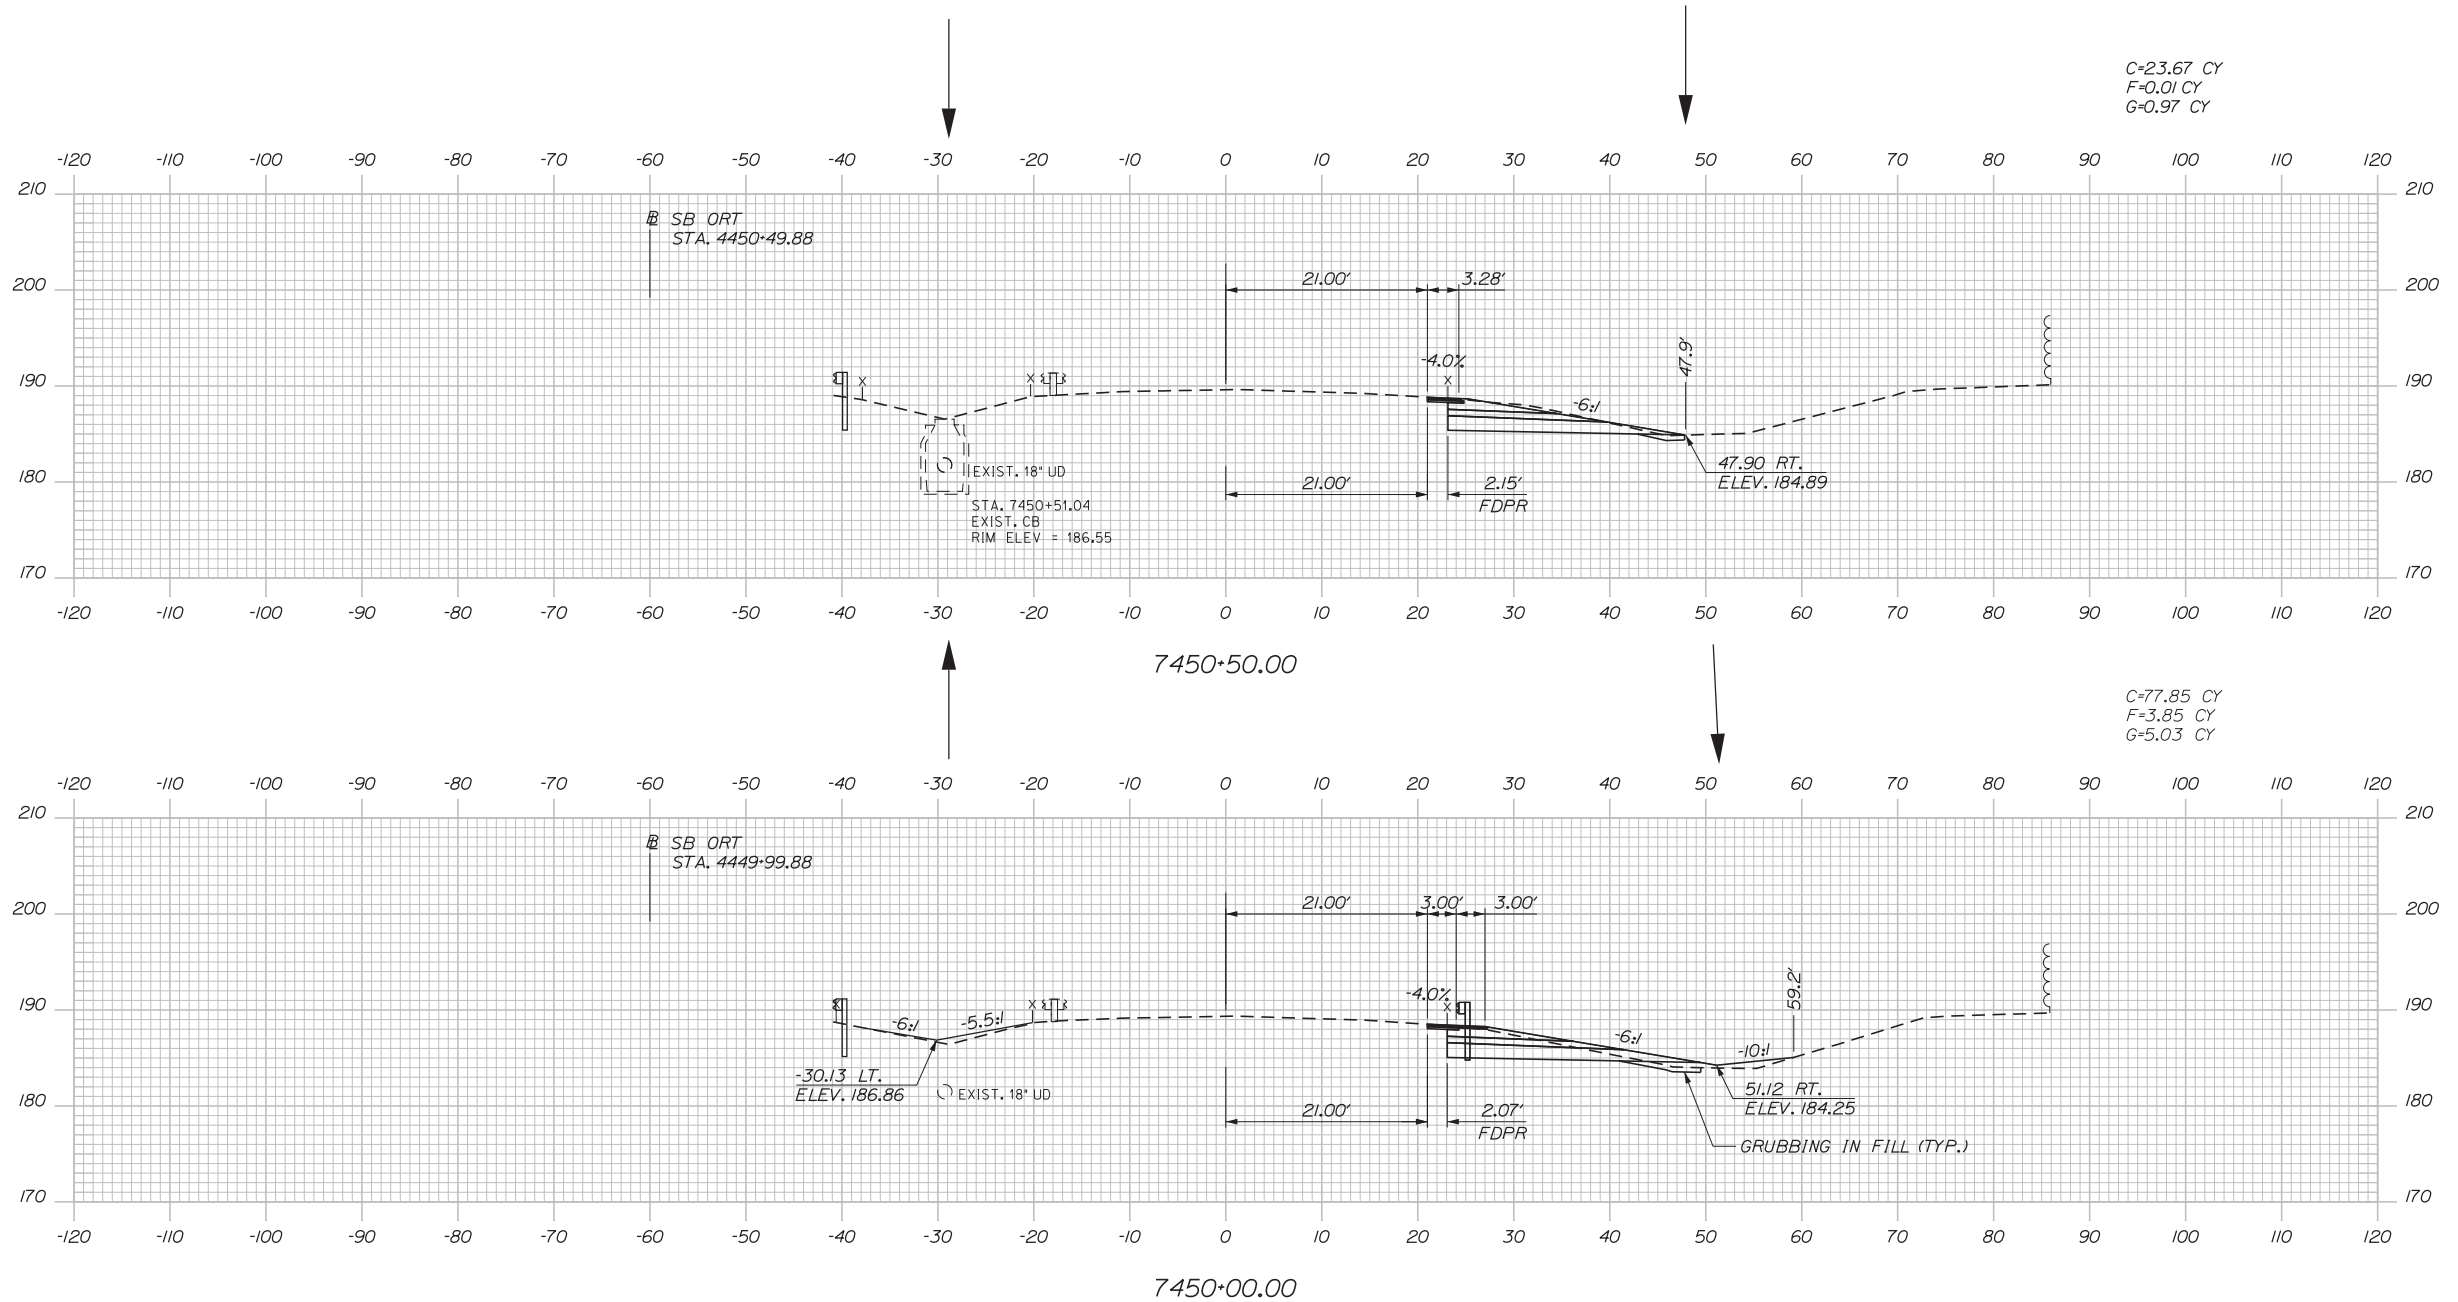

Designed by:

**Stantec**

CONSULTANT PROJECT MANAGER: LAUREN MEEK, PE

No.	Revision	By	Date

	By	Date		By	Date
Designed	PLP	3\20\19	Checked	LEM	3\20\19
Drawn	EJB	3\20\19	In Charge of	GAE	3\20\19

STANTEC CONSULTING SERVICES INC.  
 482 PAYNE ROAD  
 SCARBOROUGH, ME 04074  
 TEL (207) 887-3448  
 FAX (207) 883-3376

**MAINE TURNPIKE**

**THE GOLD STAR MEMORIAL HIGHWAY**


MTA PROJECT MANAGER: RALPH NORWOOD, IV, PE, PTOE

INTERCHANGE 103  
 ORT CONVERSION  
 NB ORT  
 STA. 7450+00.00 TO STA. 7450+50.00

SHEET NUMBER: XS-04  
 CONTRACT: 2019.04  
 238 OF 503


Date: 3/20/2019

Filename: ... \00\HIGHWAY\MSTA\\_xsect.dgn

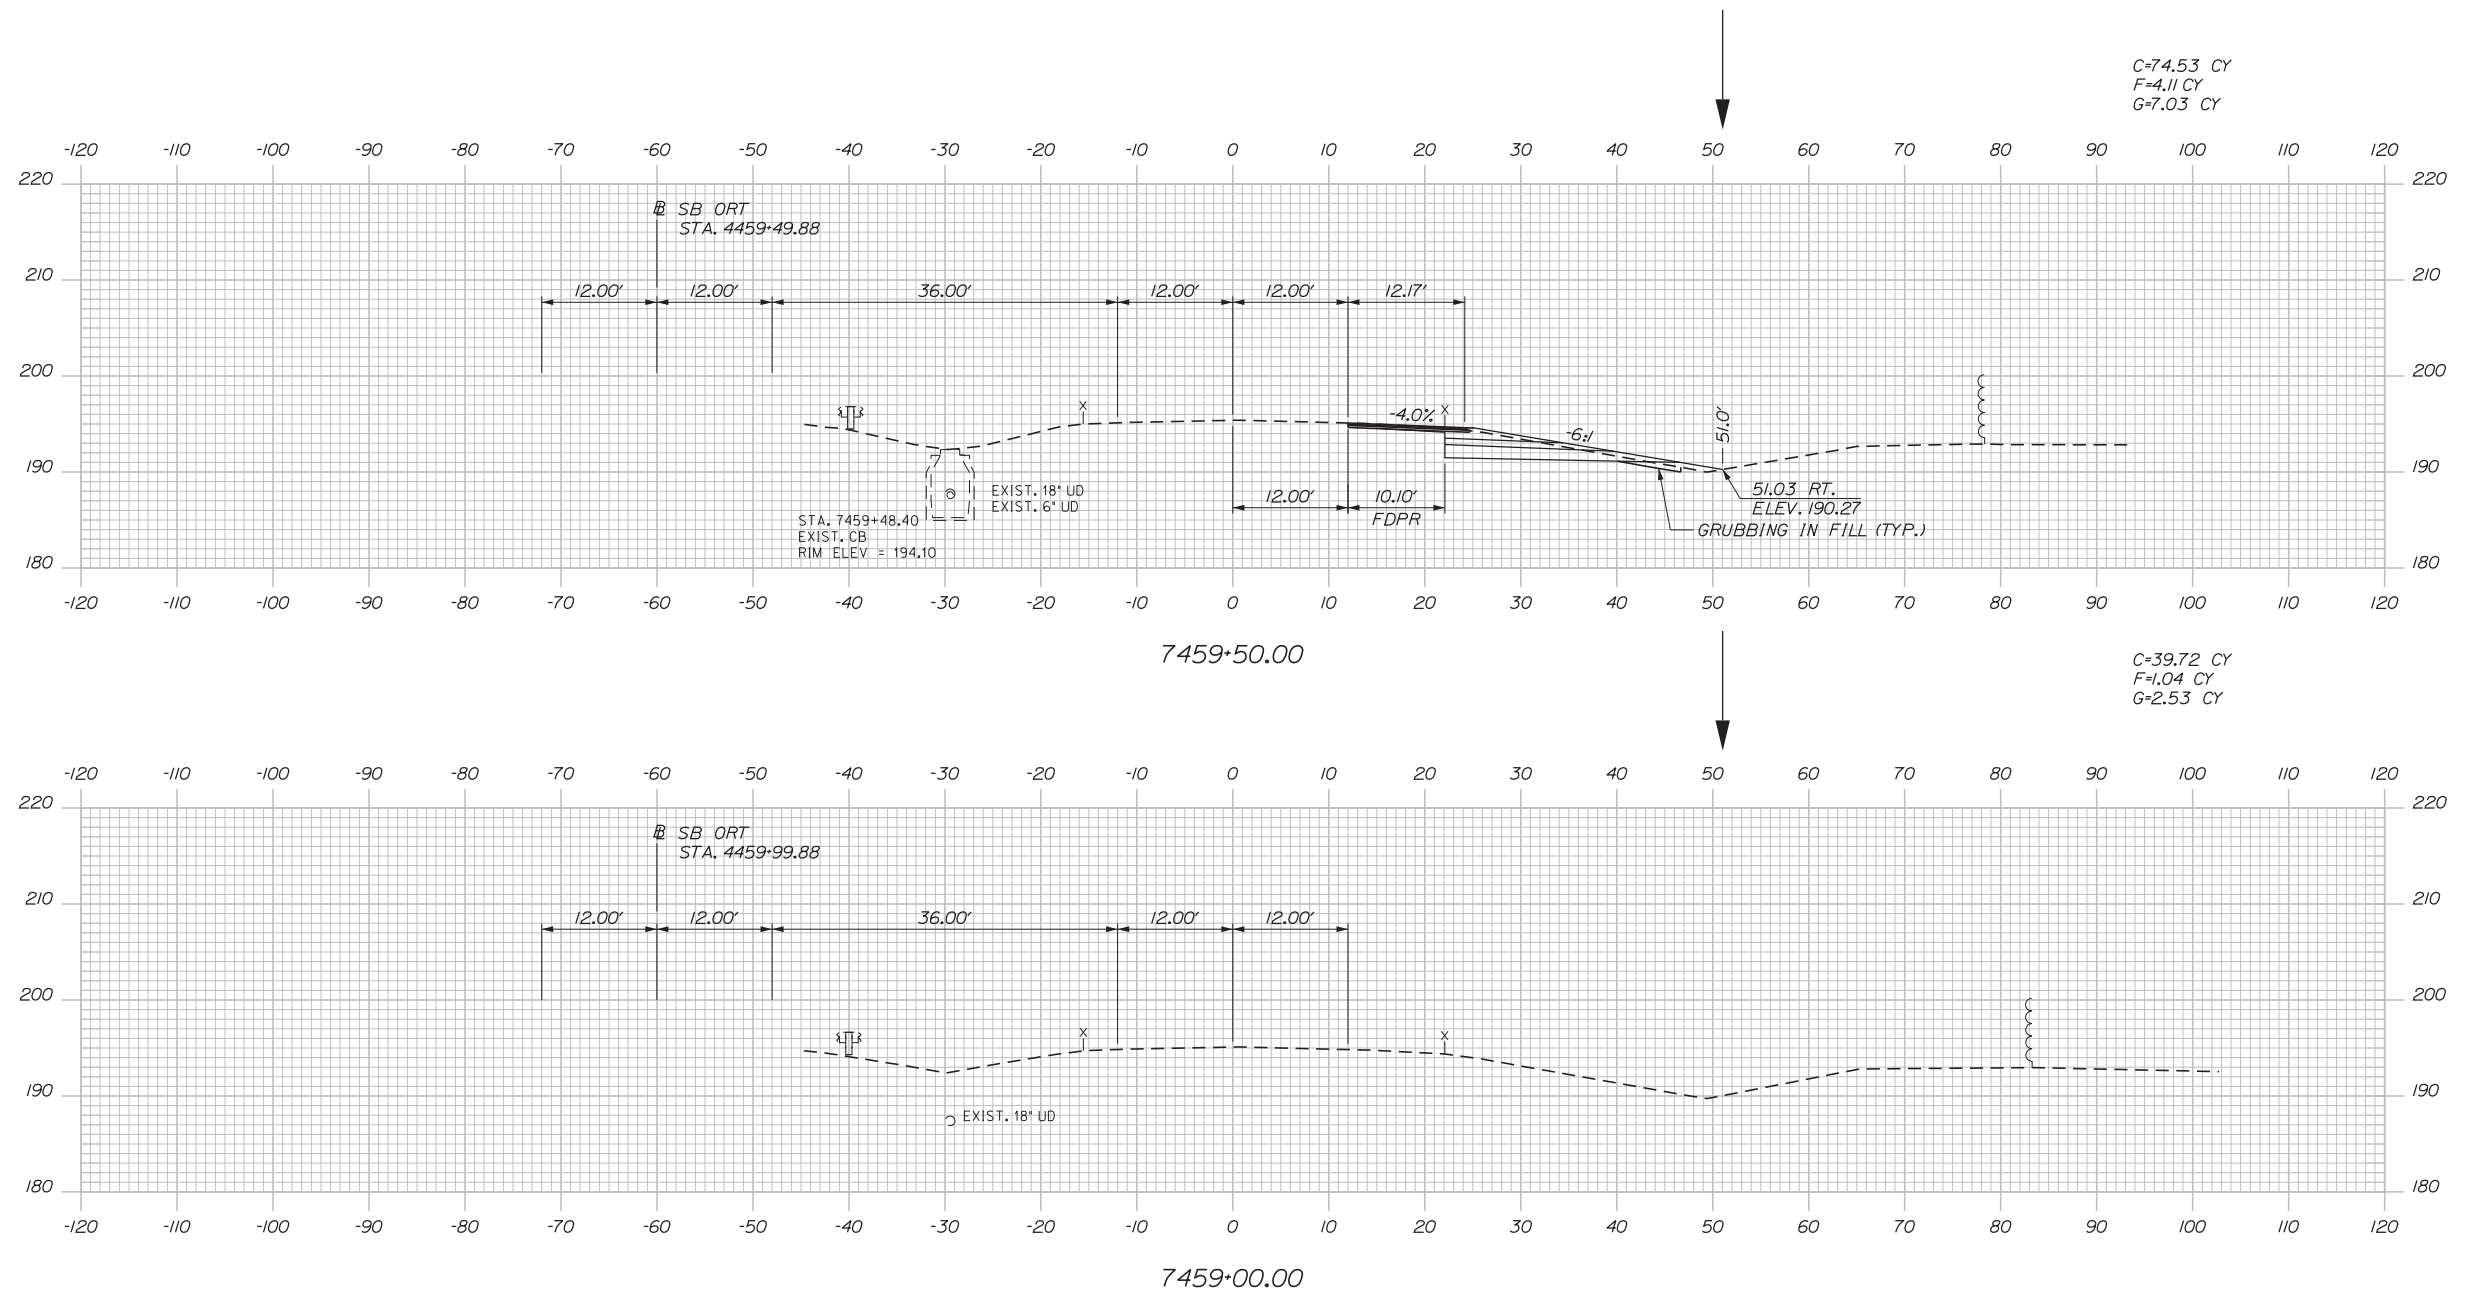

C=74.53 CY  
F=4.11 CY  
G=7.03 CY

 C=39.72 CY  
F=1.04 CY  
G=2.53 CY



Designed by:


**Stantec**

CONSULTANT PROJECT MANAGER: LAUREN MEEK, PE

No.	Revision	By	Date

	By	Date		By	Date
Designed	PLP	3\20\19	Checked	LEM	3\20\19
Drawn	EJB	3\20\19	In Charge of	GAE	3\20\19

STANTEC CONSULTING SERVICES INC.  
482 PAYNE ROAD  
SCARBOROUGH, ME 04074  
TEL (207) 887-3448  
FAX (207) 883-3376

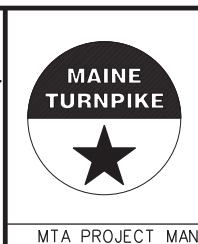



**THE GOLD STAR  
MEMORIAL HIGHWAY**

INTERCHANGE 103  
ORT CONVERSION  
NB ORT  
STA. 7459+00.00 TO STA. 7459+50.00

SHEET NUMBER: XS-05  
CONTRACT: 2019.04  
239 OF 503

Date: 3/20/2019

 Filename: ... \00\HIGHWAY\MSTA\\_xsect.dgn

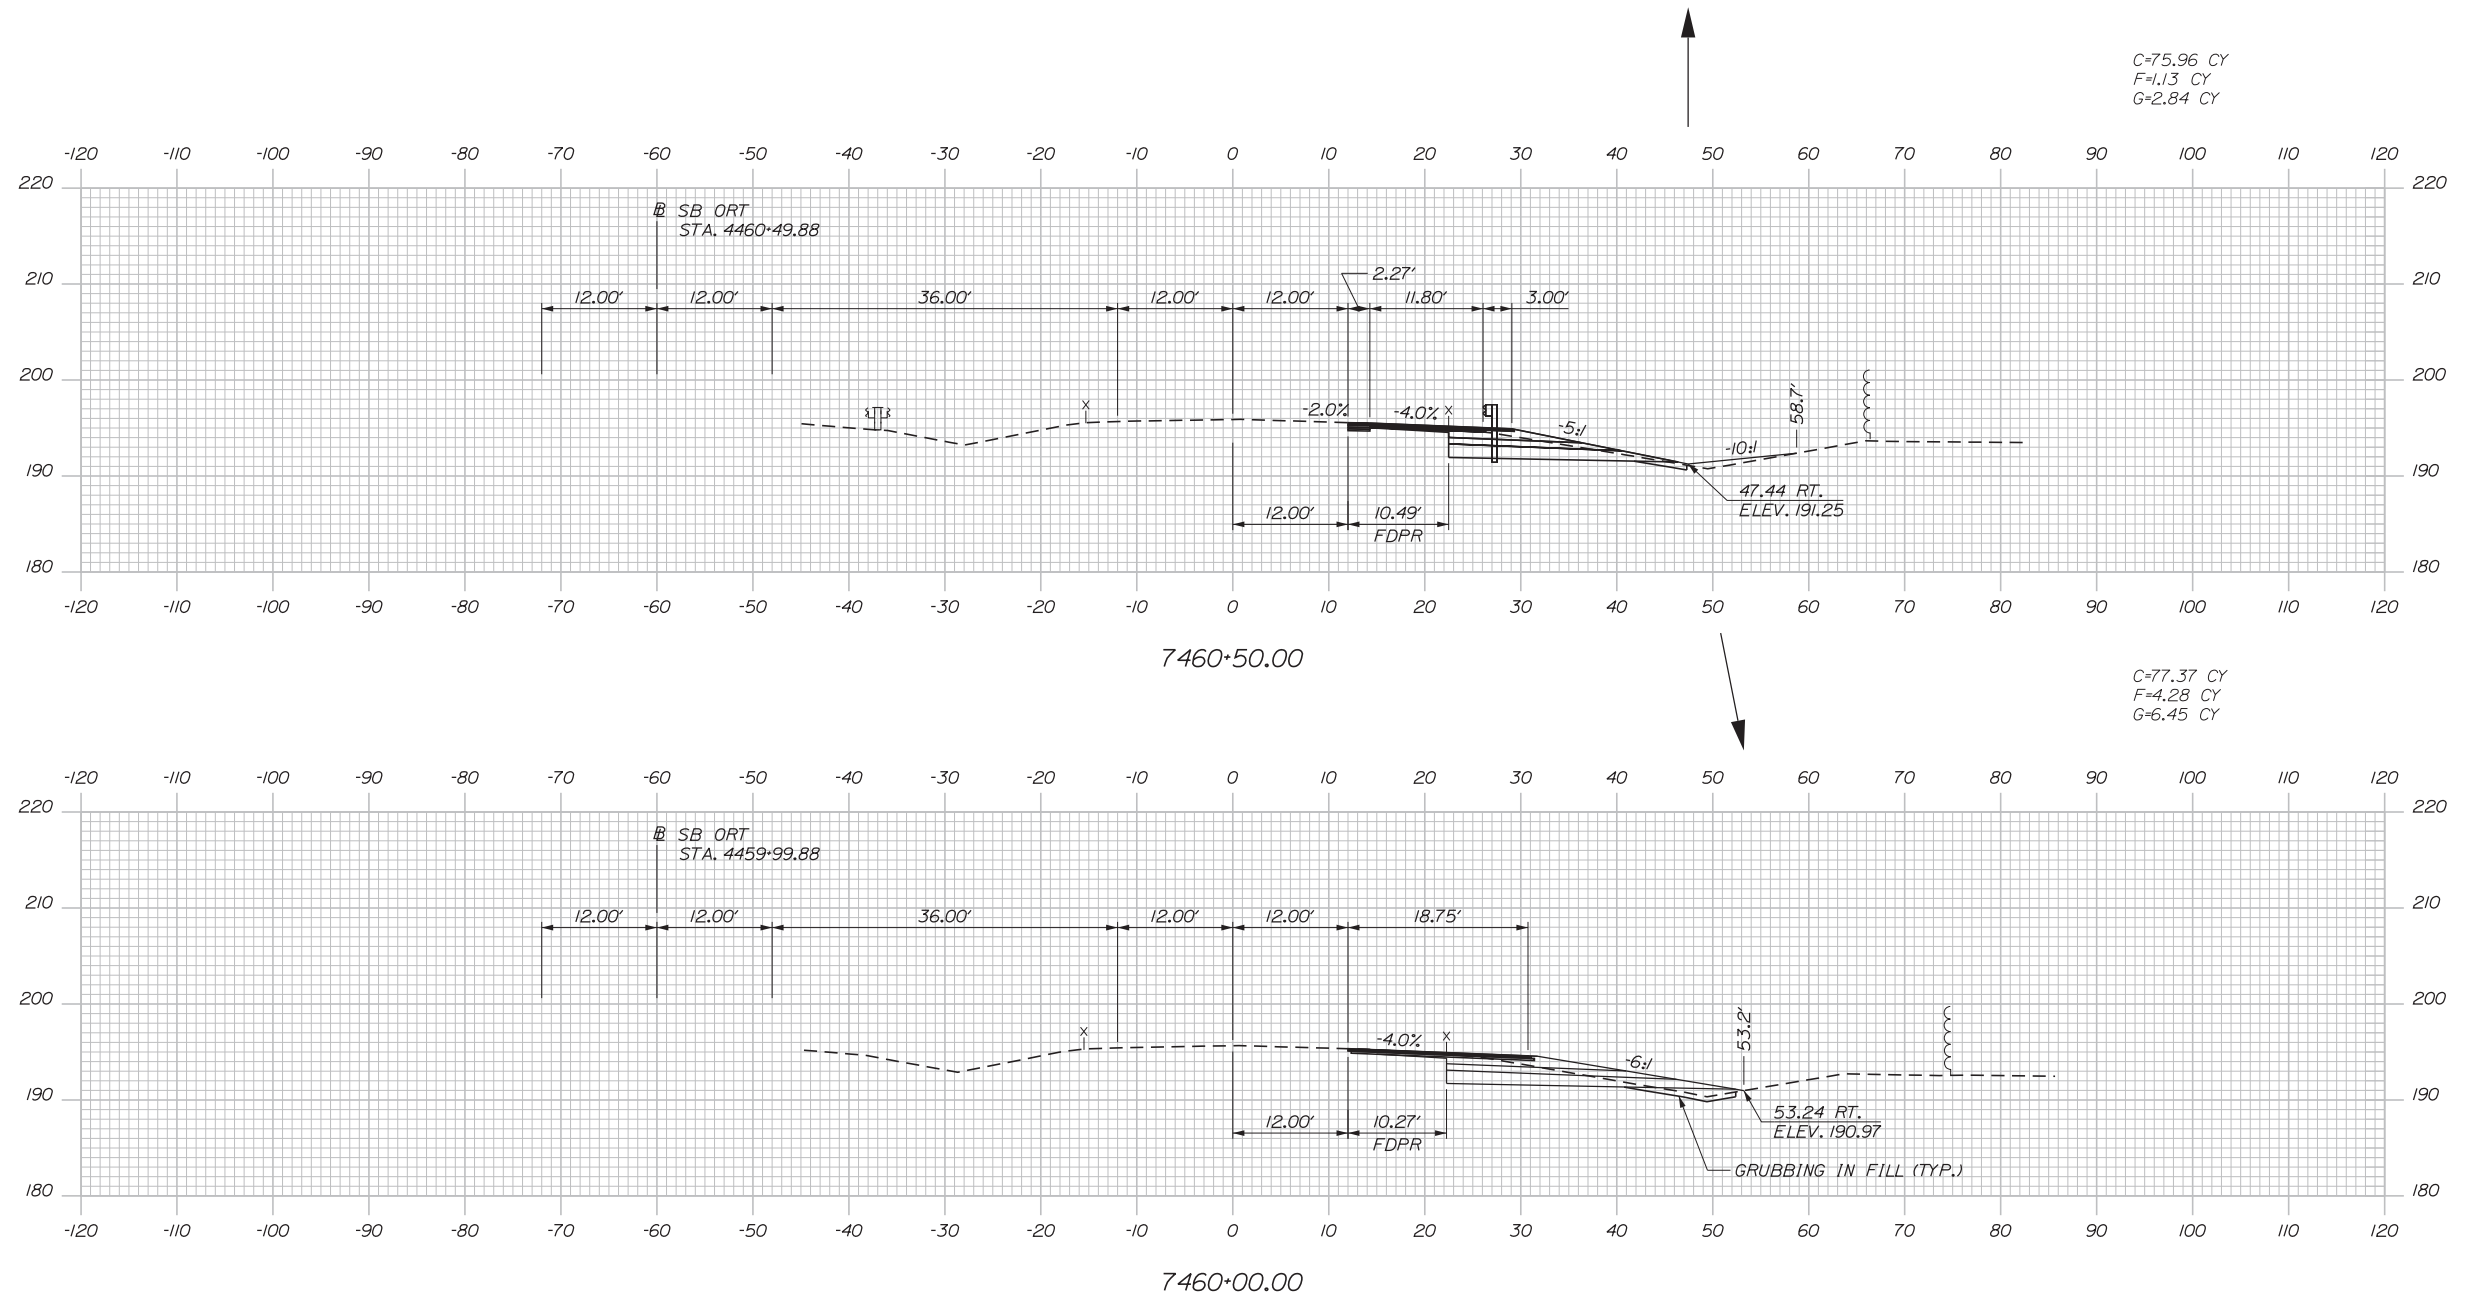

Designed by:



STANTEC CONSULTING SERVICES INC.  
482 PAYNE ROAD  
SCARBOROUGH, ME 04074  
TEL (207) 887-3448  
FAX (207) 883-3376



THE GOLD STAR  
MEMORIAL HIGHWAY

INTERCHANGE 103  
ORT CONVERSION  
NB ORT  
STA. 7460+00.00 TO STA. 7460+50.00

No.	Revision	By	Date

CONSULTANT PROJECT MANAGER: LAUREN MEEK, PE			
Designed	By	Date	Checked
	PLP	3\20\19	LEM
Drawn	By	Date	In Charge of
	EJB	3\20\19	GAE

MTA PROJECT MANAGER: RALPH NORWOOD, IV, PE, PTOE

 


CONTRACT: 2019.04

SHEET NUMBER: XS-06

240 OF 503

Date: 3/20/2019

Filename: ... \00\HIGHWAY\MSTA\\_xsect.dgn

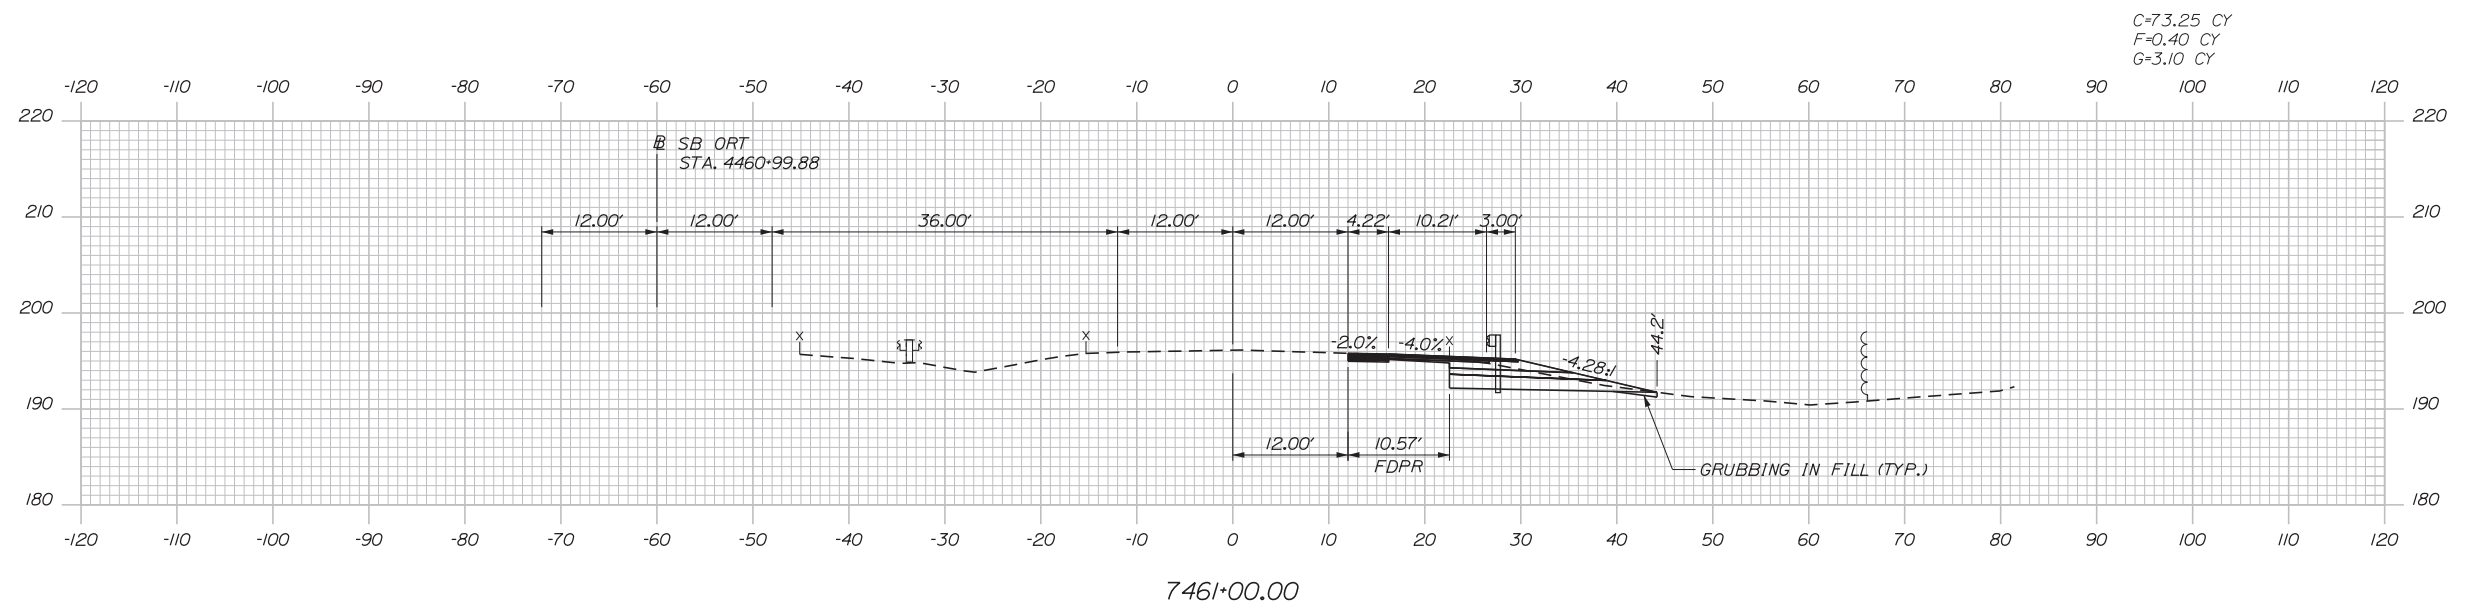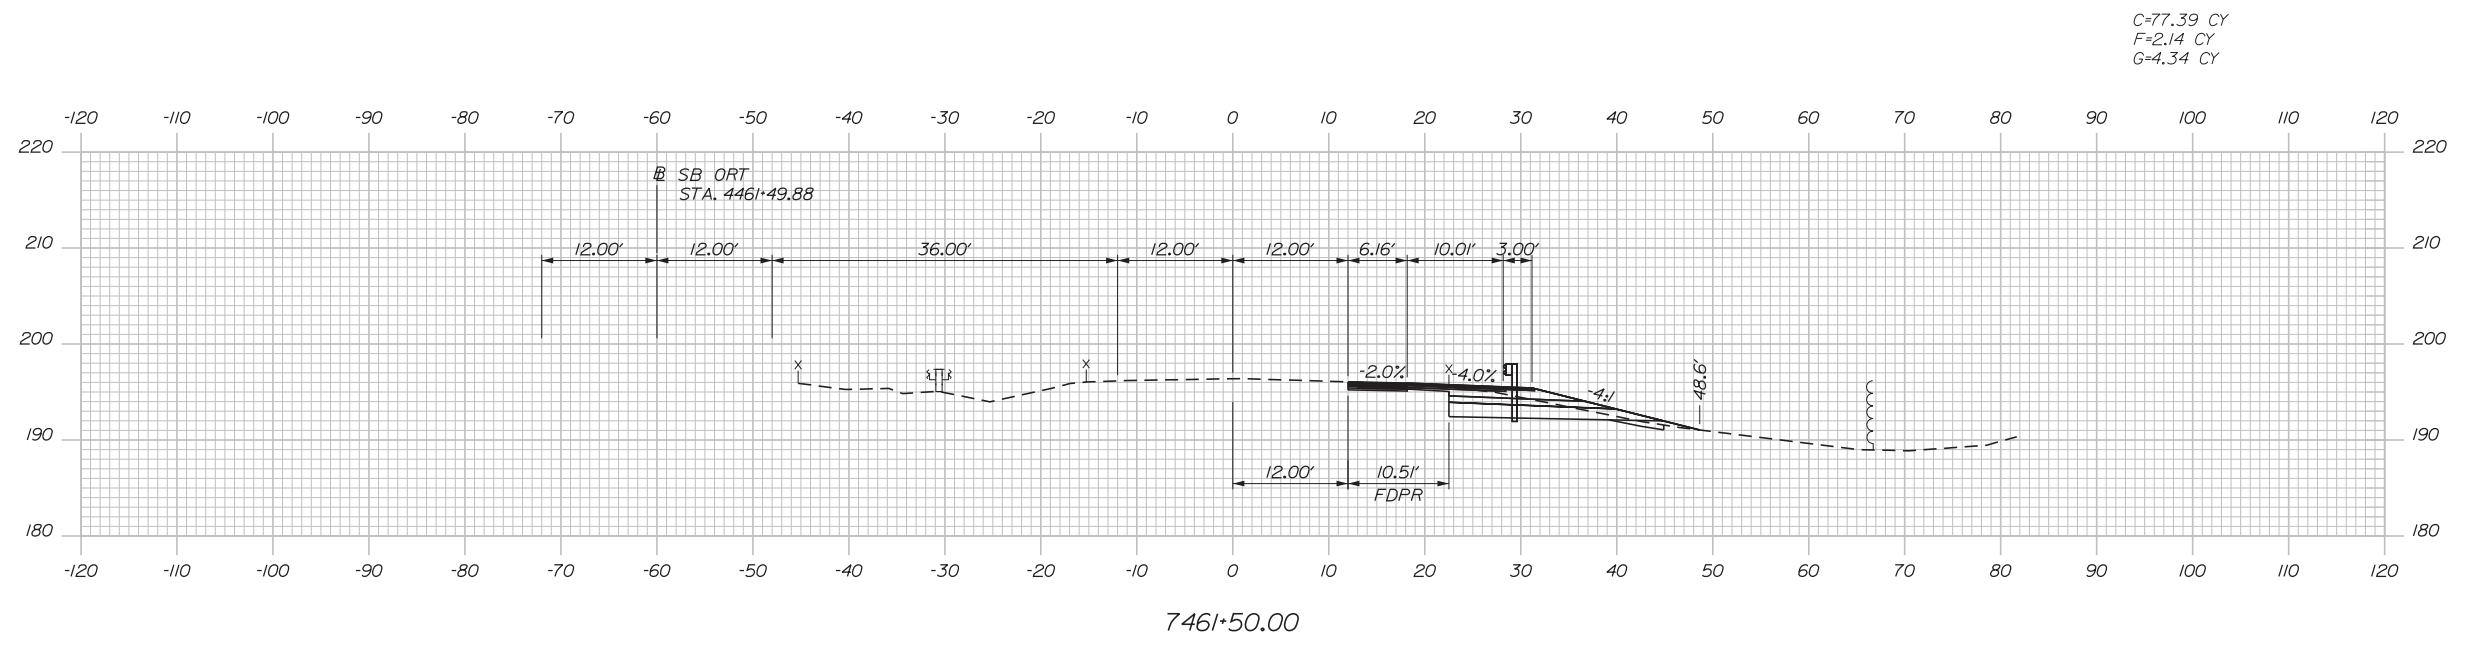

Designed by:


**Stantec**

CONSULTANT PROJECT MANAGER: LAUREN MEEK, PE

No.	Revision	By	Date

	By	Date		By	Date
Designed	PLP	3\20\19	Checked	LEM	3\20\19
Drawn	EJB	3\20\19	In Charge of	GAE	3\20\19

STANTEC CONSULTING SERVICES INC.  
 482 PAYNE ROAD  
 SCARBOROUGH, ME 04074  
 TEL (207) 887-3448  
 FAX (207) 883-3376

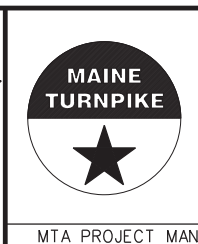


**THE GOLD STAR  
 MEMORIAL HIGHWAY**

INTERCHANGE 103  
 ORT CONVERSION  
 NB ORT  
 STA. 7461+00.00 TO STA. 7461+50.00


SHEET NUMBER: XS-07  
 CONTRACT: 2019.04  
 241 OF 503

Date: 3/20/2019


Filename: ...00\HIGHWAY\MSTA\...xsect.dgn

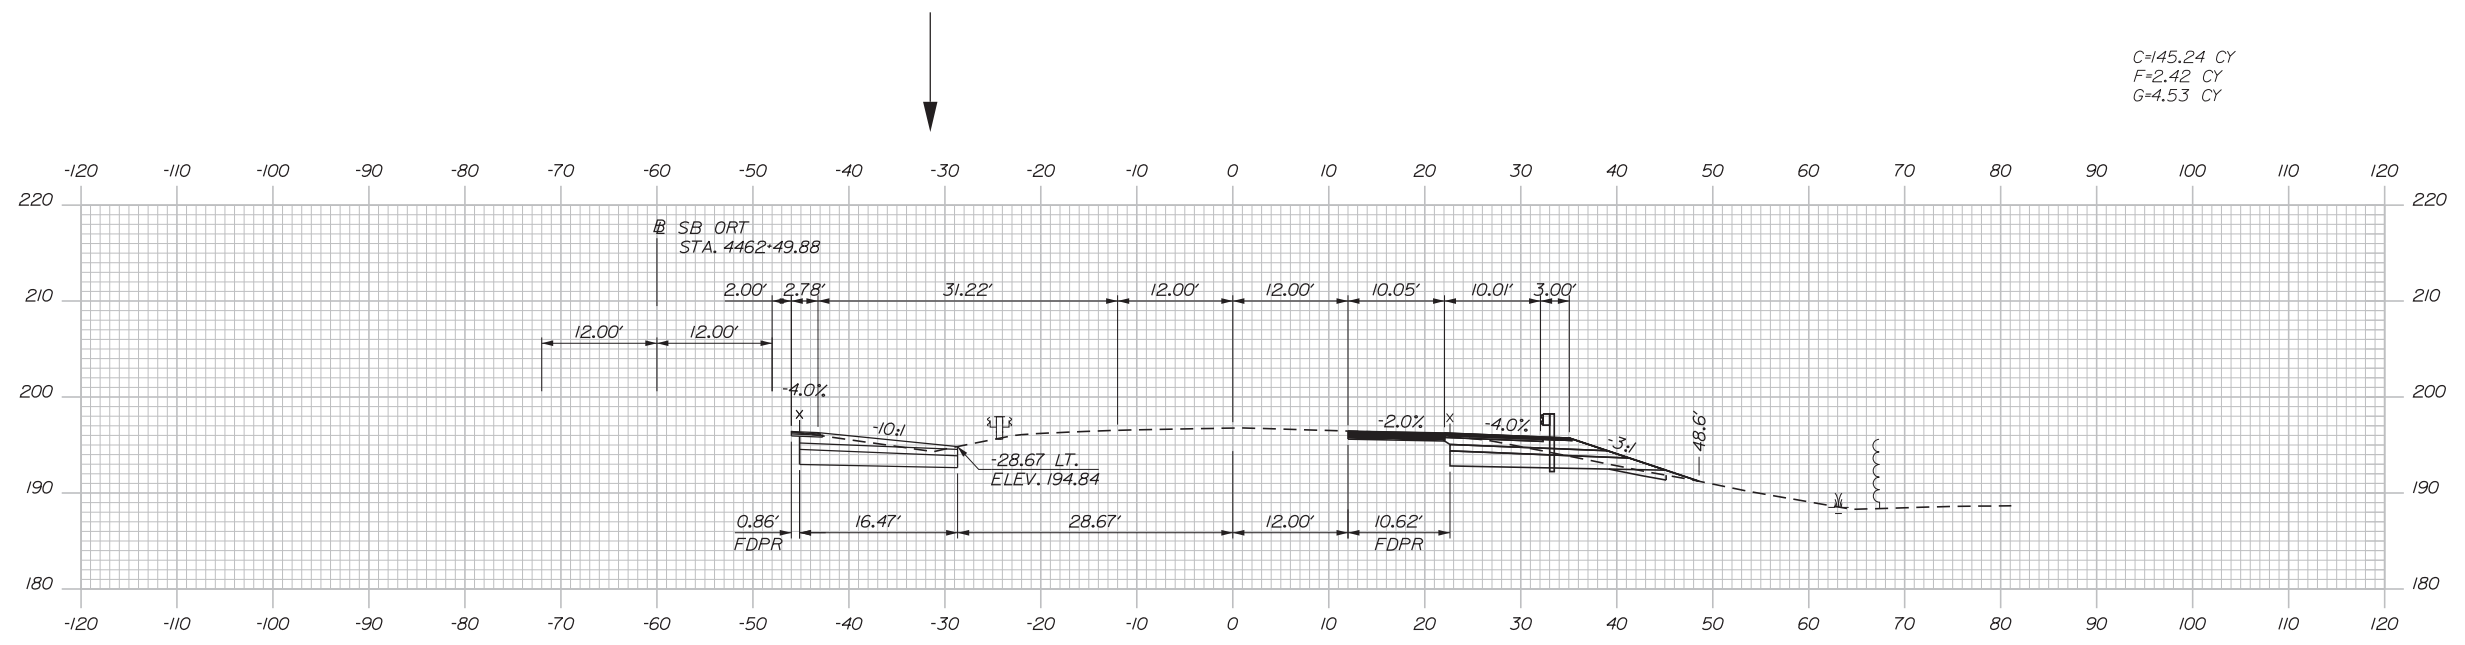

C=145.24 CY  
F=2.42 CY  
G=4.53 CY

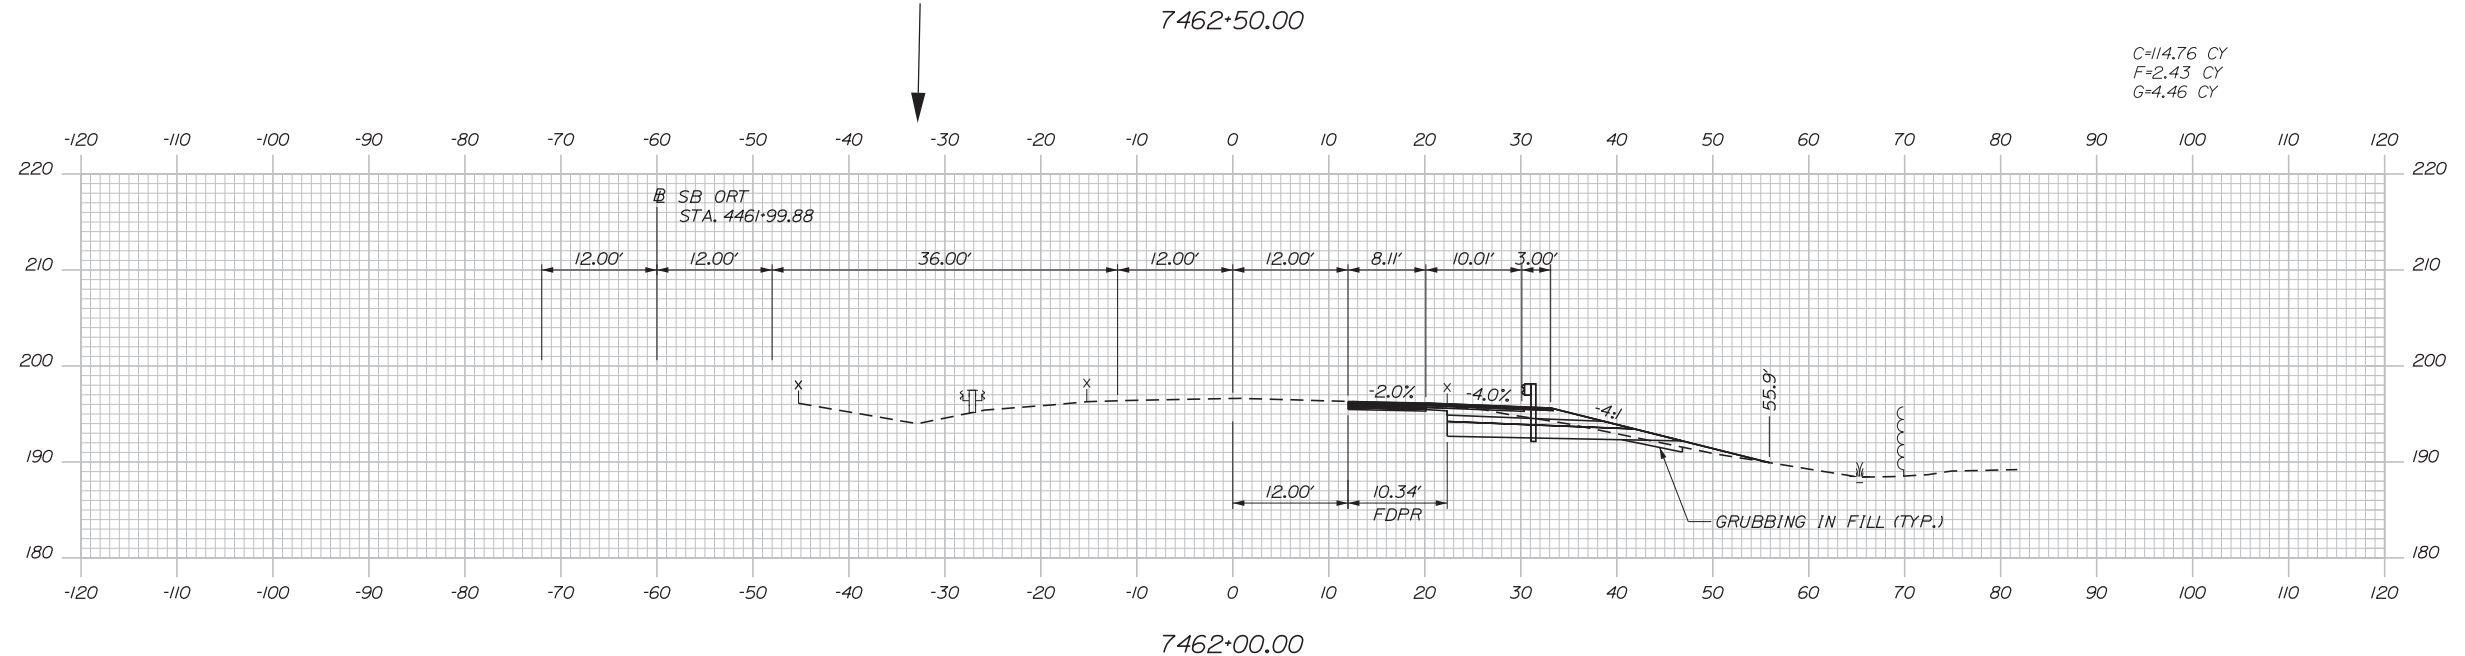

C=114.76 CY  
F=2.43 CY  
G=4.46 CY

 

Designed by:


**Stantec**

CONSULTANT PROJECT MANAGER: LAUREN MEEK, PE

No.	Revision	By	Date

	By	Date		By	Date
Designed	PLP	3\20\19	Checked	LEM	3\20\19
Drawn	EJB	3\20\19	In Charge of	GAE	3\20\19

STANTEC CONSULTING SERVICES INC.  
482 PAYNE ROAD  
SCARBOROUGH, ME 04074  
TEL (207) 887-3448  
FAX (207) 883-3376

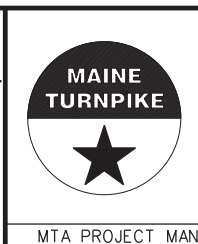

**THE GOLD STAR  
MEMORIAL HIGHWAY**

INTERCHANGE 103  
ORT CONVERSION  
NB ORT  
STA. 7462+00.00 TO STA. 7462+50.00


SHEET NUMBER: XS-08

CONTRACT: 2019.04


242 OF 503

Date: 3/20/2019


Filename: ...:\00\HIGHWAY\MSTA\\_xsect.dgn

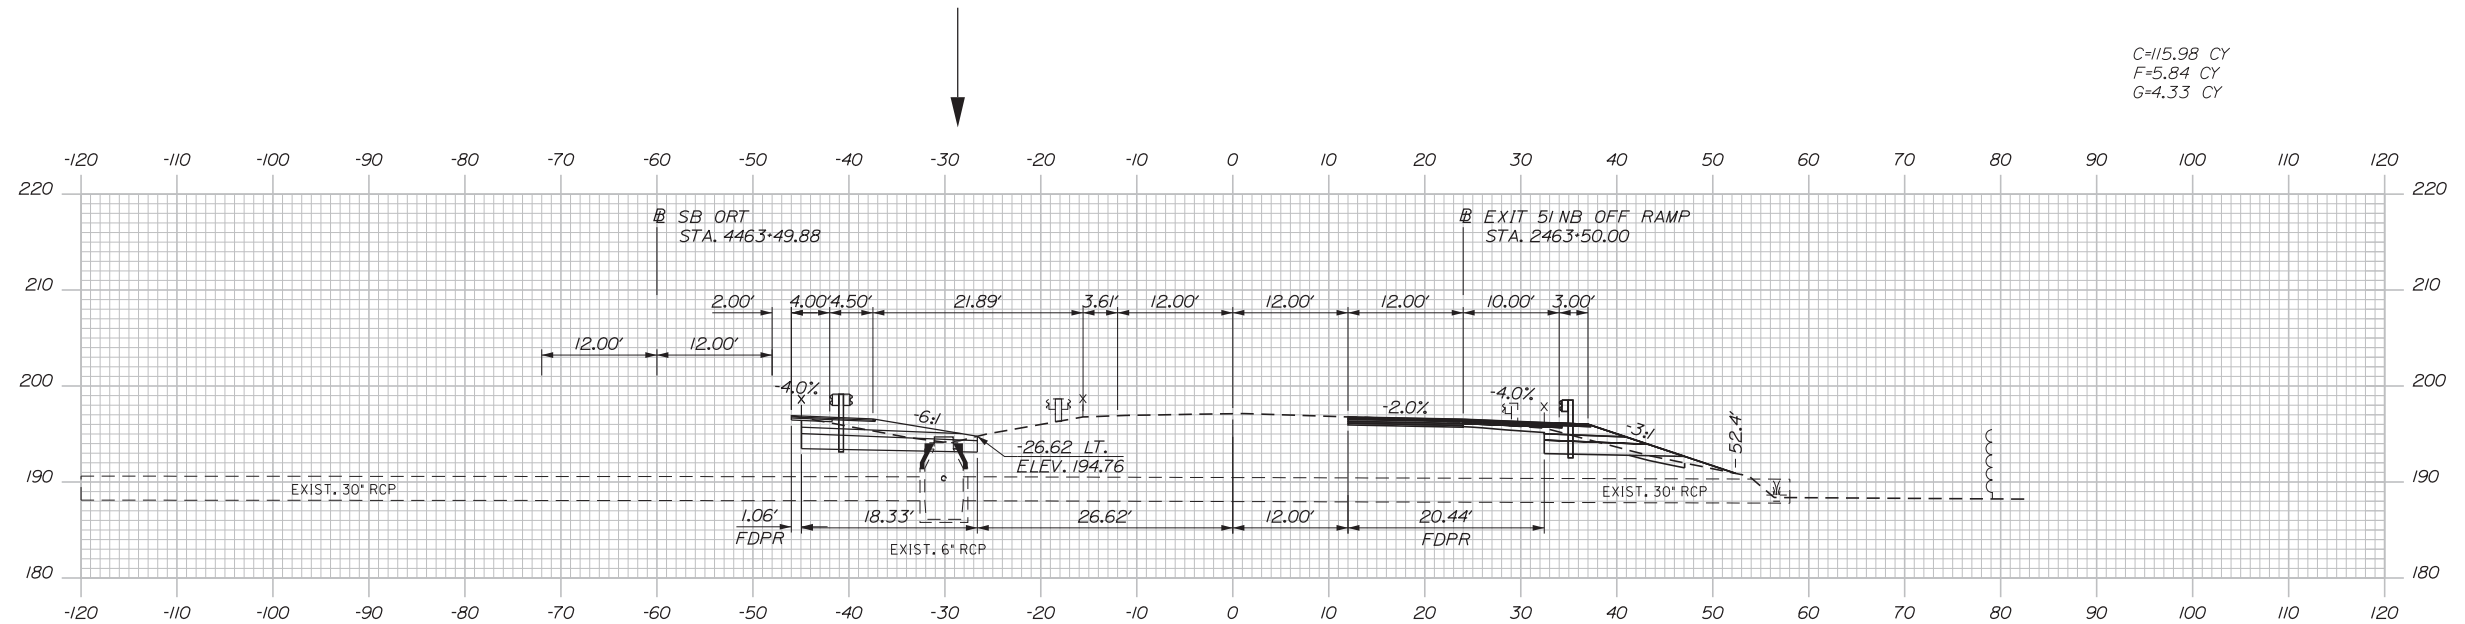

C=115.98 CY  
F=5.84 CY  
G=4.33 CY

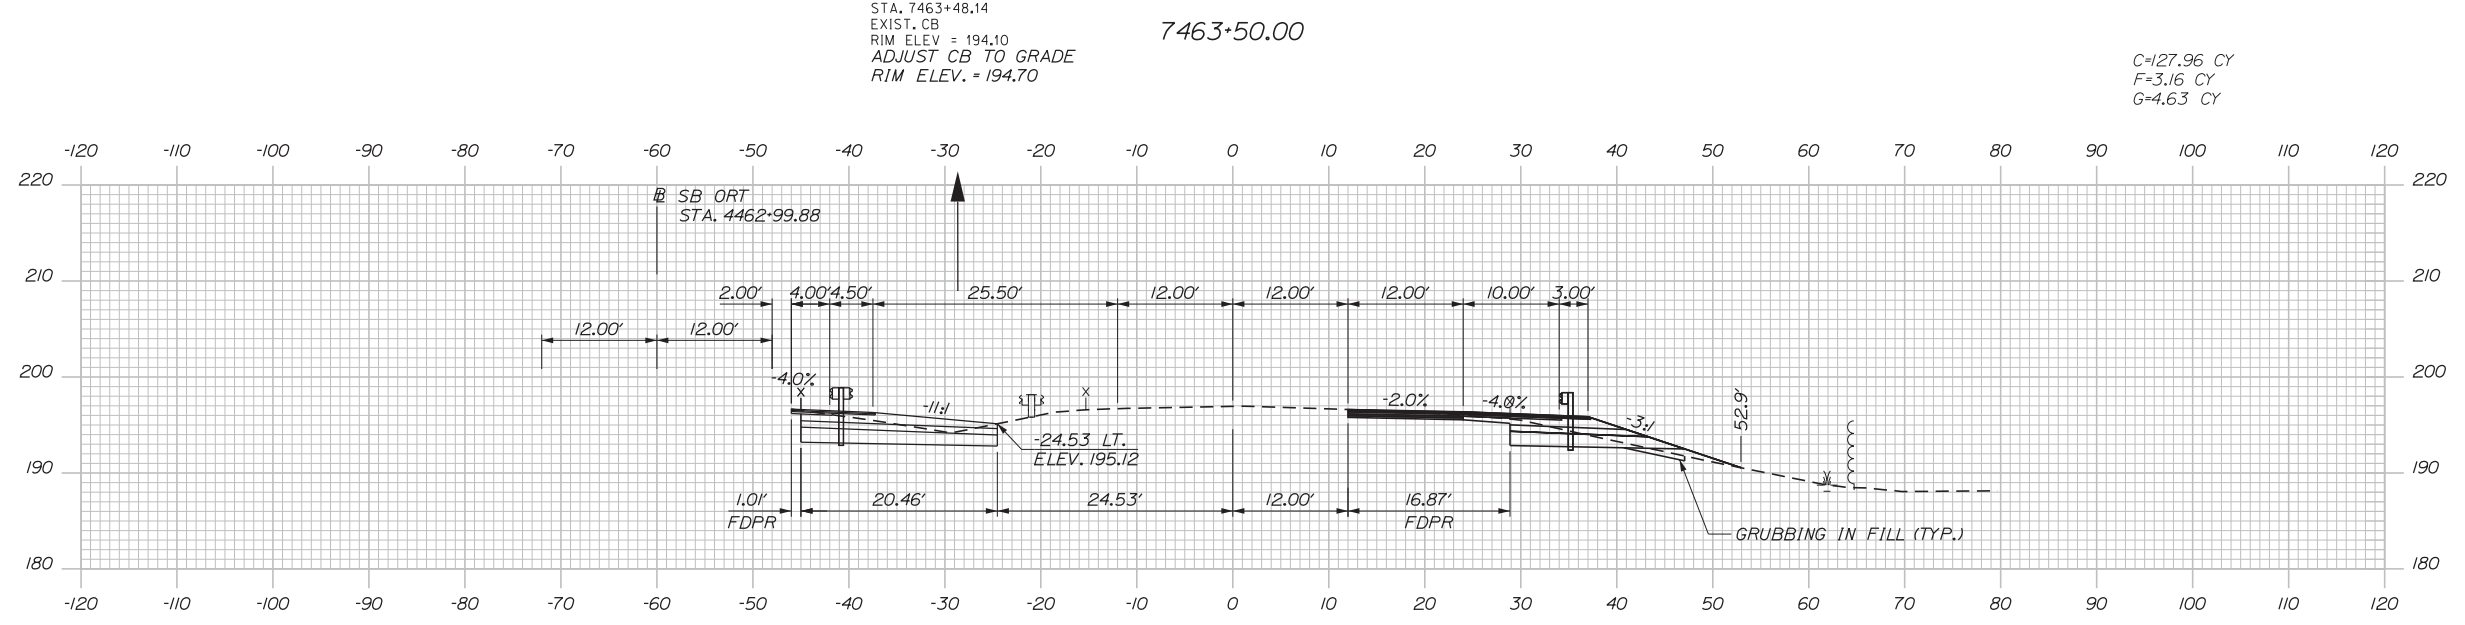

C=127.96 CY  
F=3.16 CY  
G=4.63 CY

 

Designed by:


**Stantec**

CONSULTANT PROJECT MANAGER: LAUREN MEEK, PE

No.	Revision	By	Date

	By	Date		By	Date
Designed	PLP	3\20\19	Checked	LEM	3\20\19
Drawn	EJB	3\20\19	In Charge of	GAE	3\20\19

STANTEC CONSULTING SERVICES INC.  
482 PAYNE ROAD  
SCARBOROUGH, ME 04074  
TEL (207) 887-3448  
FAX (207) 883-3376

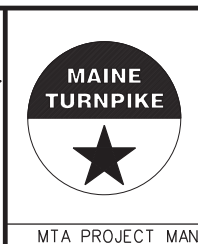

**THE GOLD STAR  
MEMORIAL HIGHWAY**


MTA PROJECT MANAGER: RALPH NORWOOD, IV, PE, PTOE

INTERCHANGE 103  
ORT CONVERSION  
NB ORT  
STA. 7463+00.00 TO STA. 7463+50.00


SHEET NUMBER: XS-09  
CONTRACT: 2019.04  
243 OF 503

Date: 3/20/2019


Filename: ...00\HIGHWAY\MSTA\\_xsect.dgn

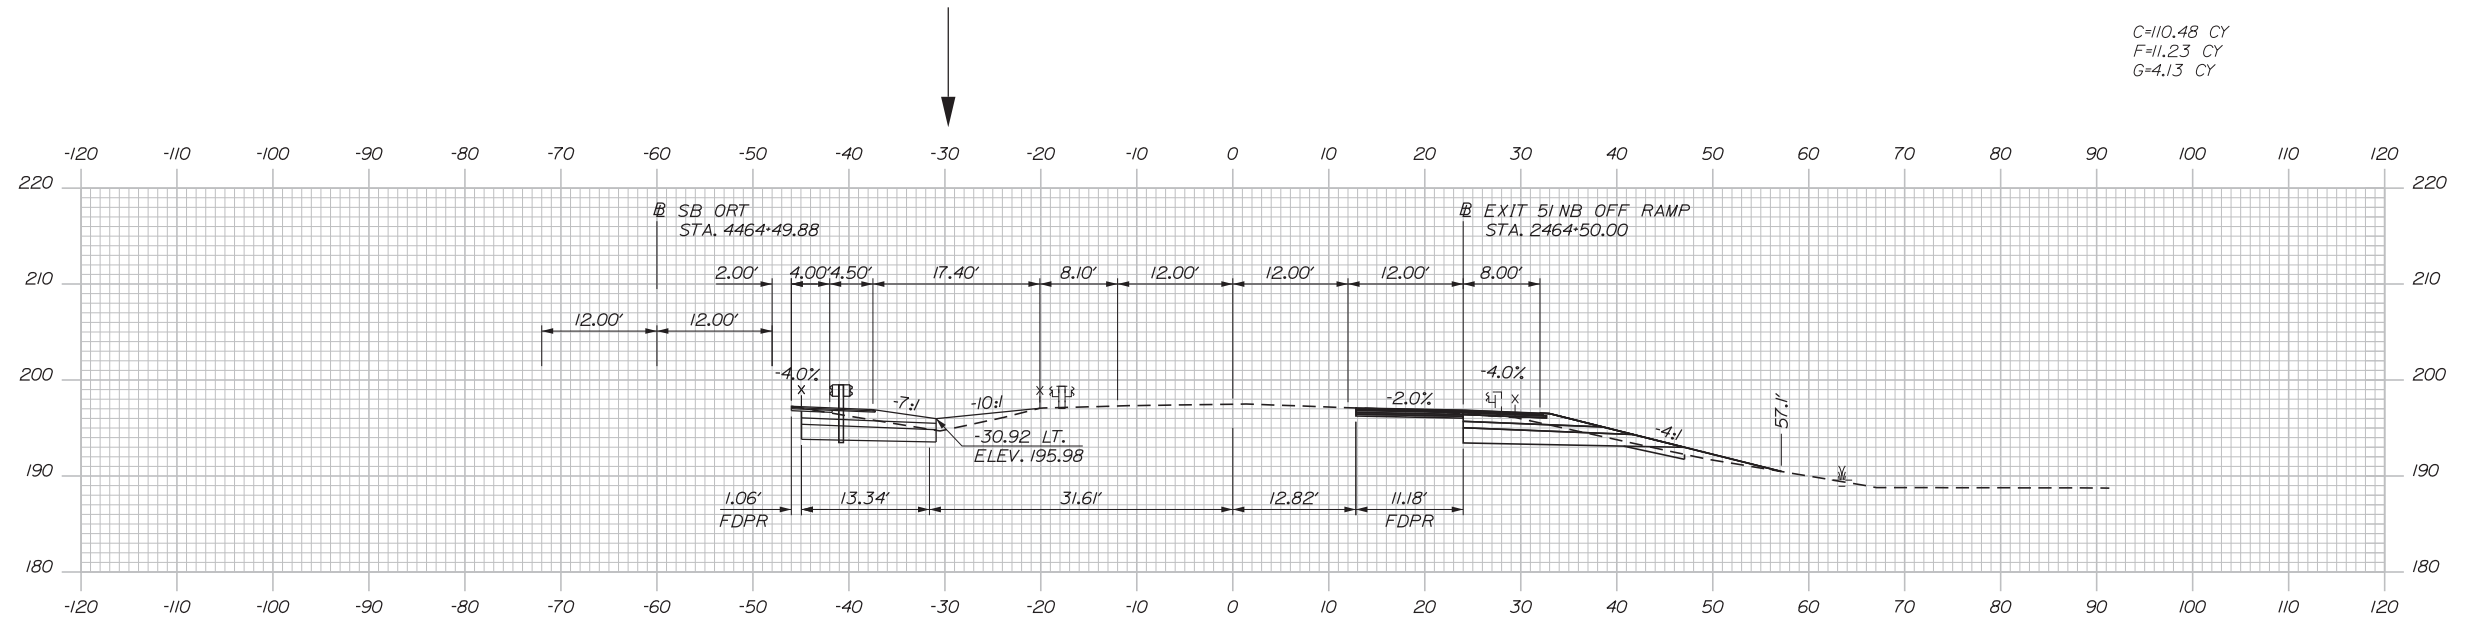

7464+50.00

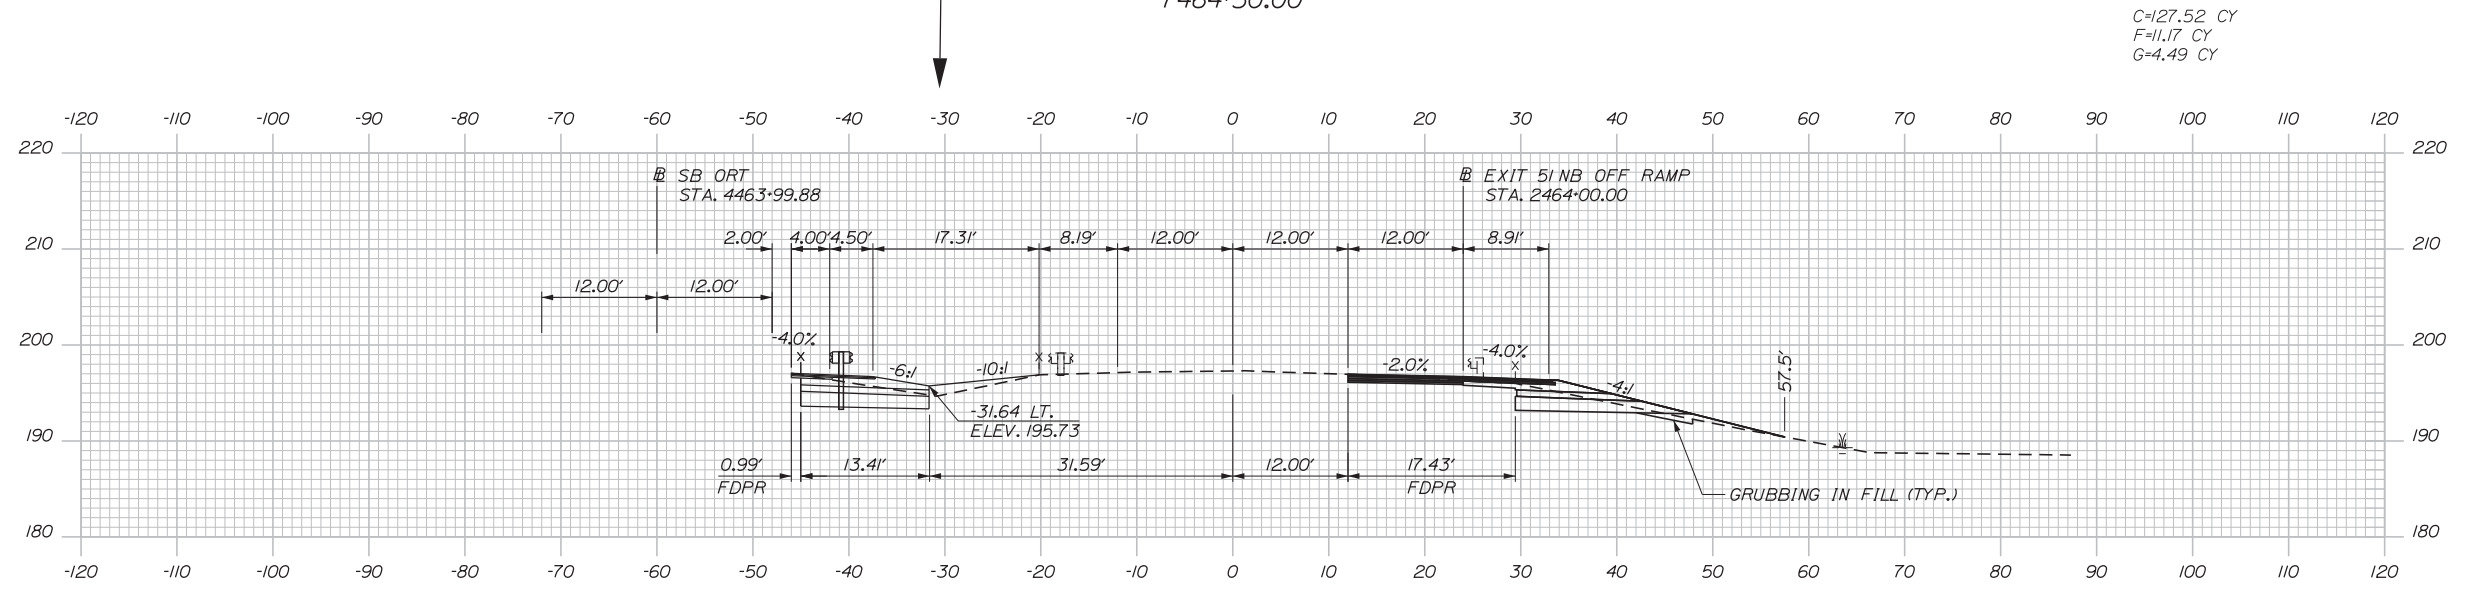

7464+00.00

 

Designed by:


**Stantec**

CONSULTANT PROJECT MANAGER: LAUREN MEEK, PE

No.	Revision	By	Date

	By	Date		By	Date
Designed	PLP	3\20\19	Checked	LEM	3\20\19
Drawn	EJB	3\20\19	In Charge of	GAE	3\20\19

STANTEC CONSULTING SERVICES INC.  
 482 PAYNE ROAD  
 SCARBOROUGH, ME 04074  
 TEL (207) 887-3448  
 FAX (207) 883-3376

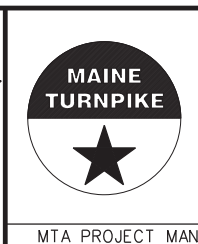

**THE GOLD STAR  
 MEMORIAL HIGHWAY**


INTERCHANGE 103  
 ORT CONVERSION  
 NB ORT  
 STA. 7464+00.00 TO STA. 7464+50.00

SHEET NUMBER: XS-10  
 CONTRACT: 2019.04  
 244 OF 503




Date: 3/20/2019


Filename: ...:\00\HIGHWAY\MSTA\\_xsect.dgn

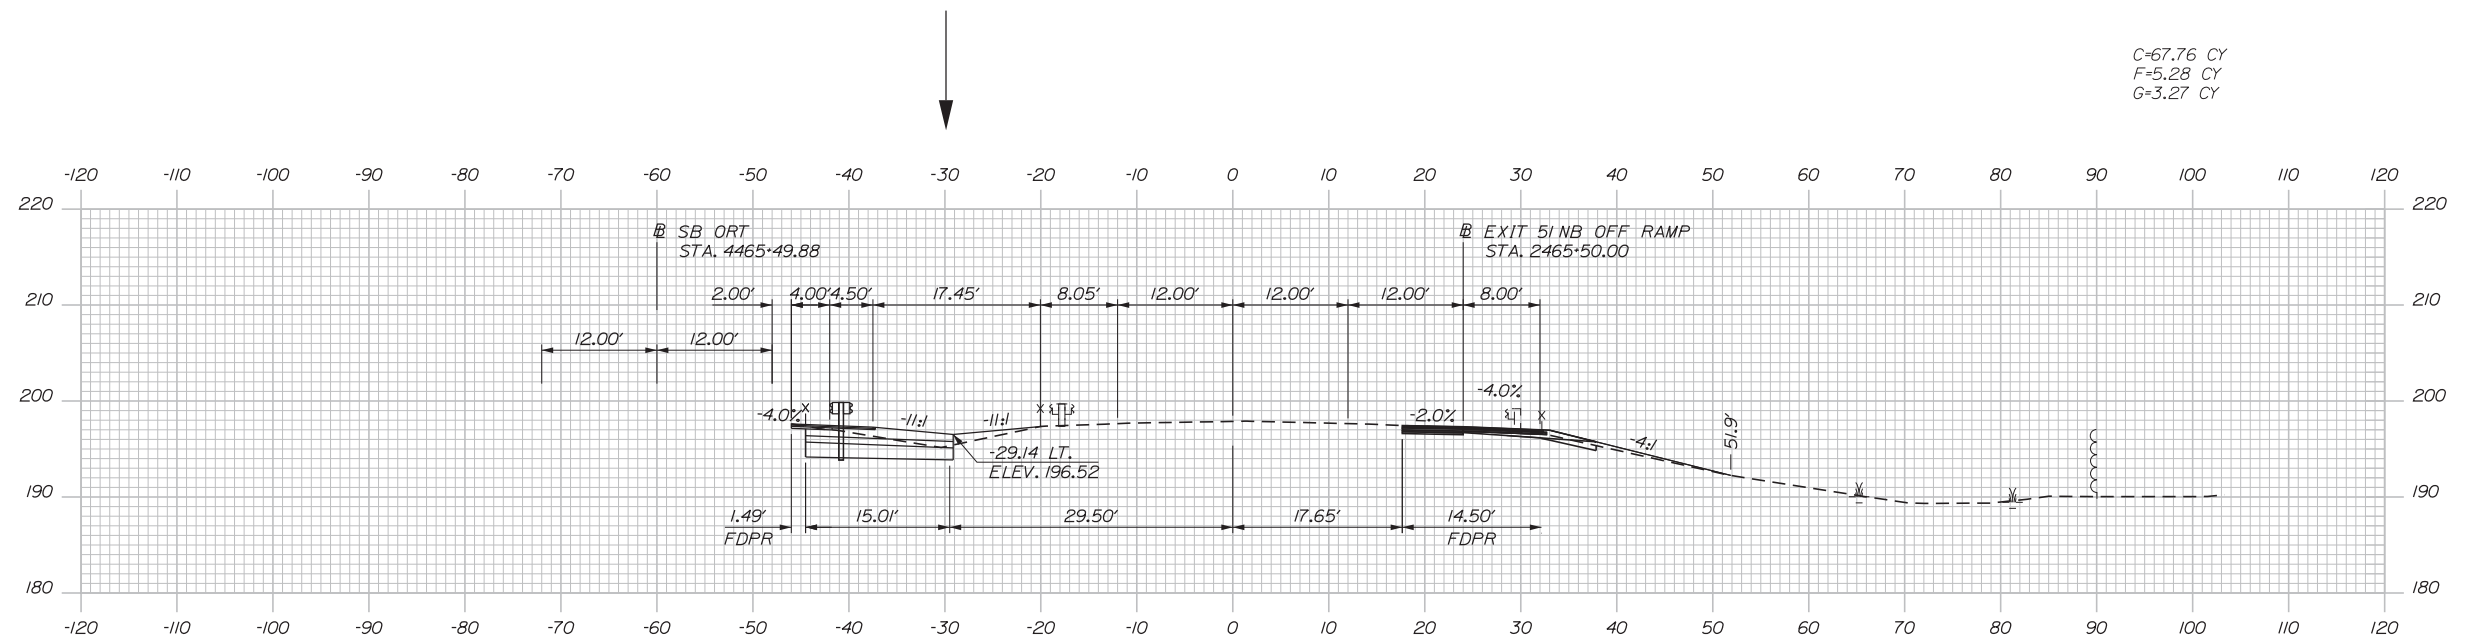

7465+50.00

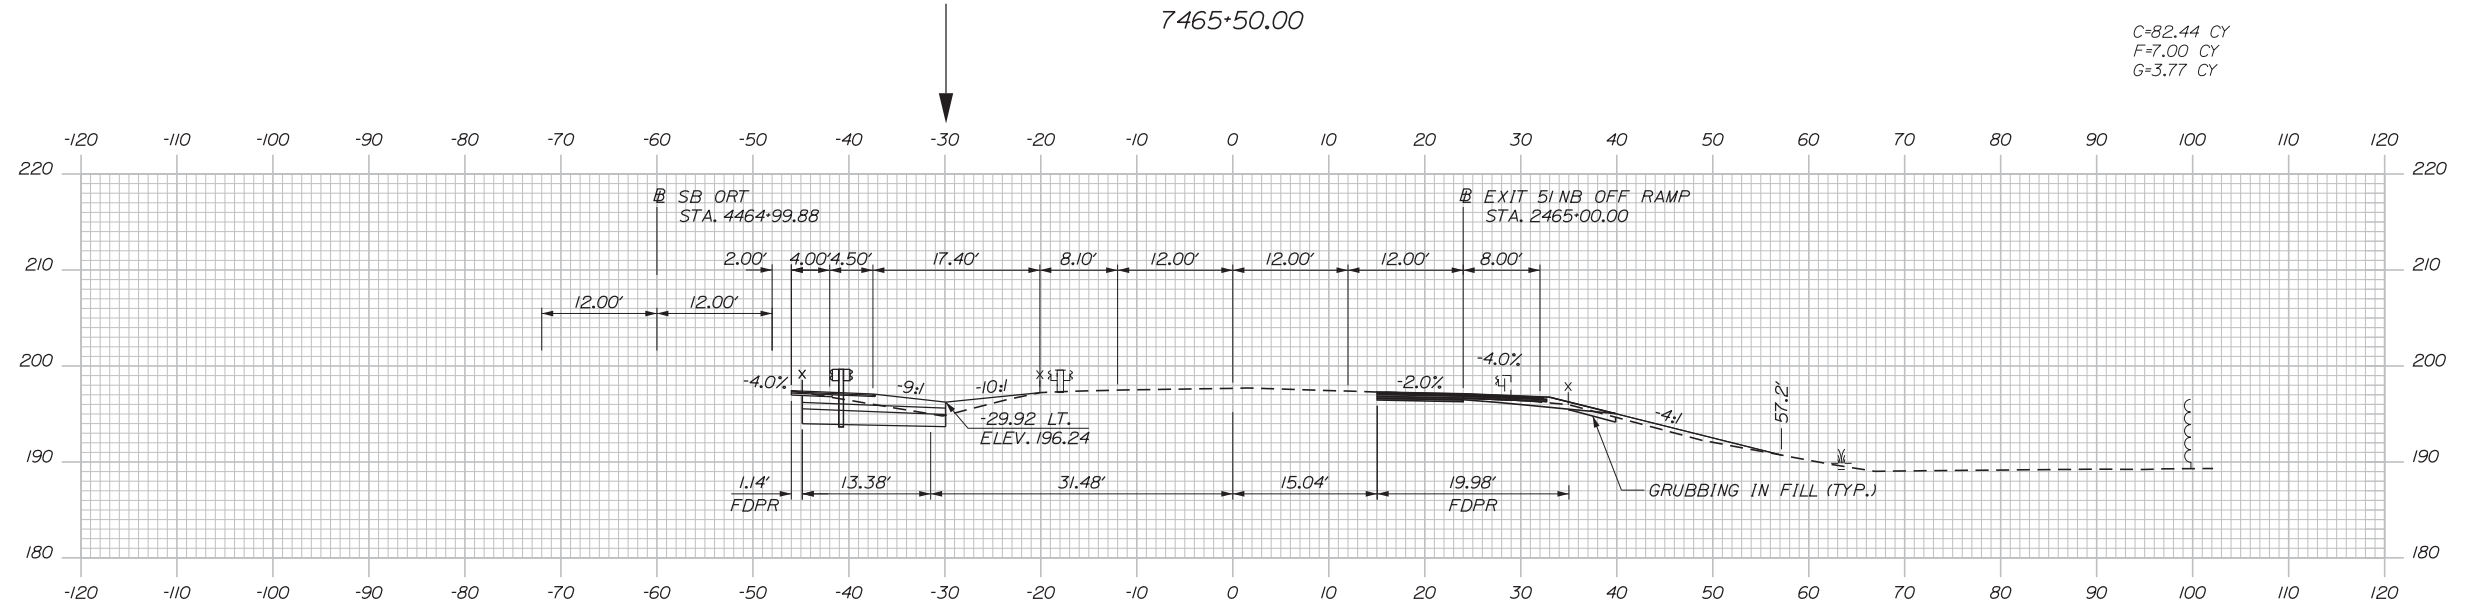

7465+00.00

 

Designed by:



STANTEC CONSULTING SERVICES INC.  
482 PAYNE ROAD  
SCARBOROUGH, ME 04074  
TEL (207) 887-3448  
FAX (207) 883-3376



THE GOLD STAR  
MEMORIAL HIGHWAY

INTERCHANGE 103  
ORT CONVERSION  
NB ORT  
STA. 7465+00.00 TO STA. 7465+50.00

No.	Revision	By	Date

CONSULTANT PROJECT MANAGER: LAUREN MEEK, PE			
	By	Date	
Designed	PLP	3\20\19	Checked LEM 3\20\19
Drawn	EJB	3\20\19	In Charge of GAE 3\20\19

MTA PROJECT MANAGER: RALPH NORWOOD, IV, PE, PTOE

 

CONTRACT: 2019.04

SHEET NUMBER: XS-11

245 OF 503

Date: 3/20/2019

Filename: ...00\HIGHWAY\MSTA\\_xsect.dgn

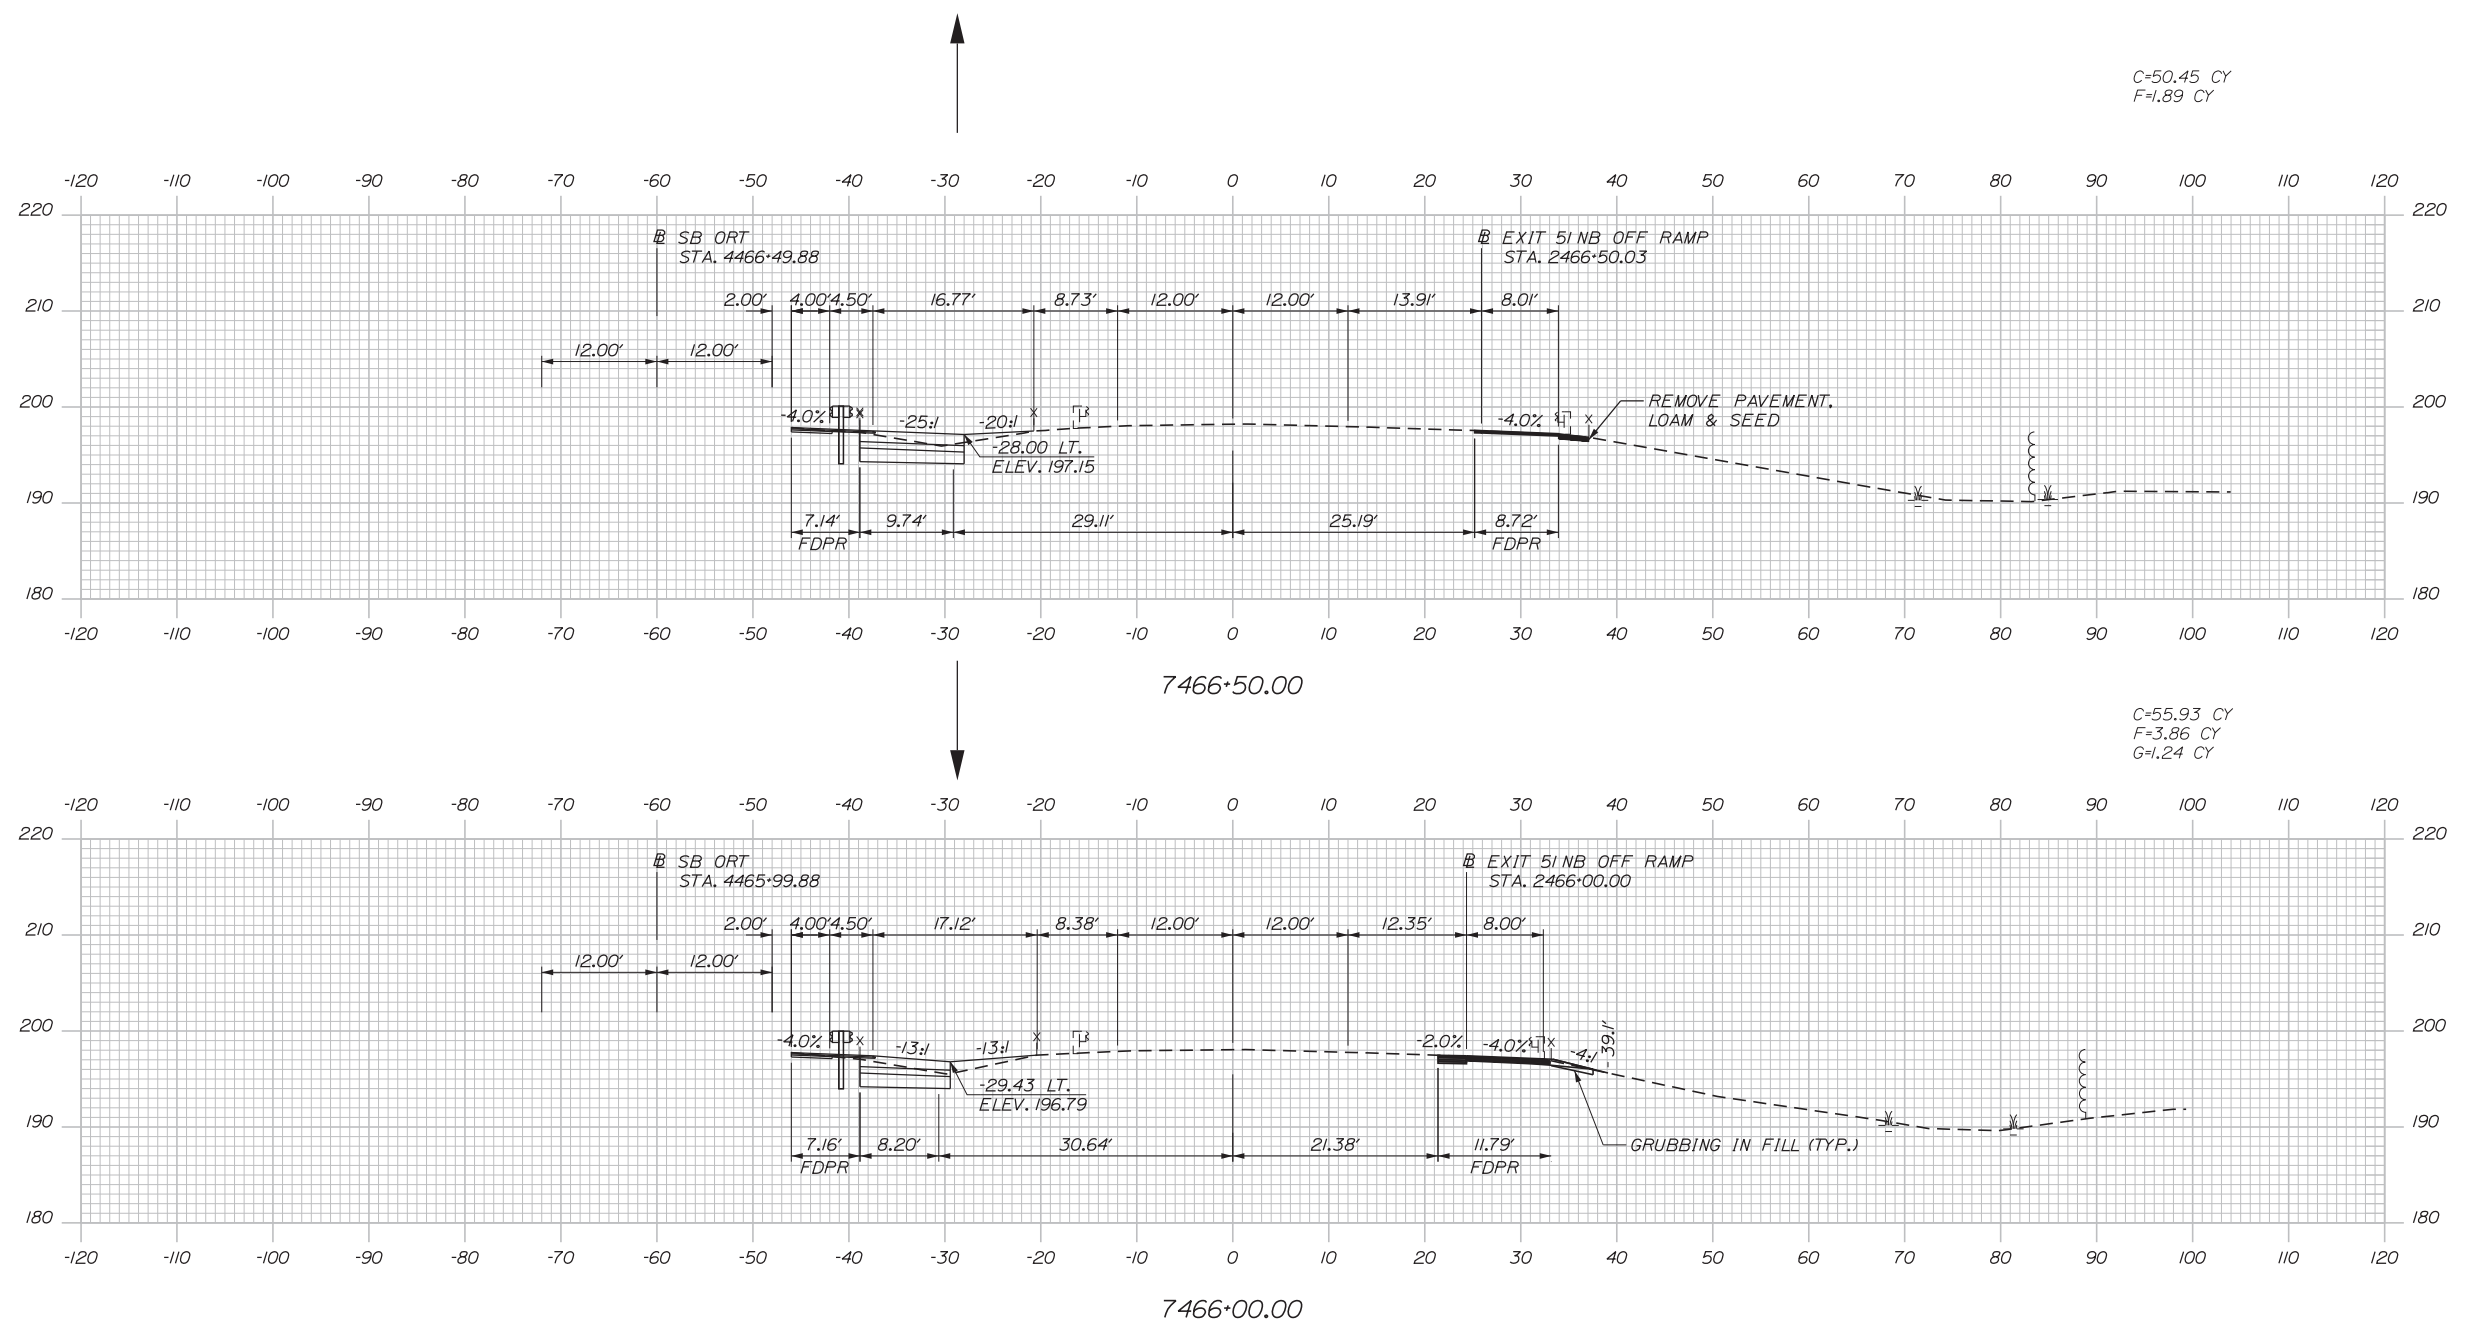

Designed by:

**Stantec**

CONSULTANT PROJECT MANAGER: LAUREN MEEK, PE

No.	Revision	By	Date

	By	Date		By	Date
Designed	PLP	3\20\19	Checked	LEM	3\20\19
Drawn	EJB	3\20\19	In Charge of	GAE	3\20\19

STANTEC CONSULTING SERVICES INC.  
482 PAYNE ROAD  
SCARBOROUGH, ME 04074  
TEL (207) 887-3448  
FAX (207) 883-3376

**MAINE TURNPIKE**

**THE GOLD STAR MEMORIAL HIGHWAY**




MTA PROJECT MANAGER: RALPH NORWOOD, IV, PE, PTOE

INTERCHANGE 103  
ORT CONVERSION  
NB ORT  
STA. 7466+00.00 TO STA. 7466+50.00

SHEET NUMBER: XS-12  
CONTRACT: 2019.04  
246 OF 503

Date: 3/20/2019

 Filename: ... \00\HIGHWAY\MSTA\\_xsect.dgn

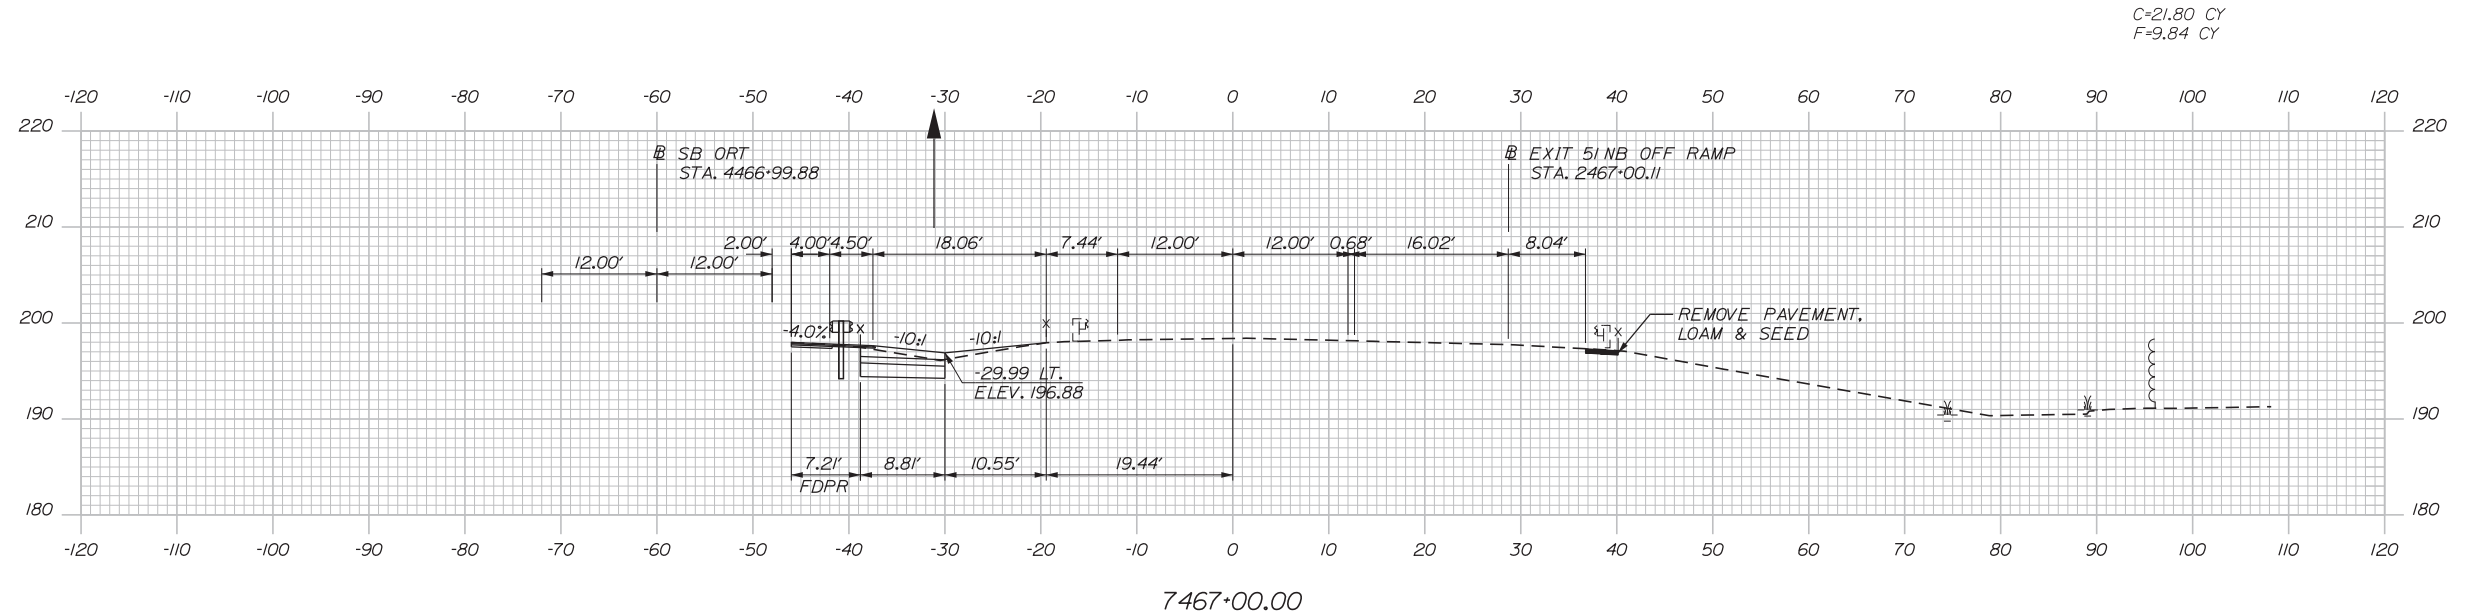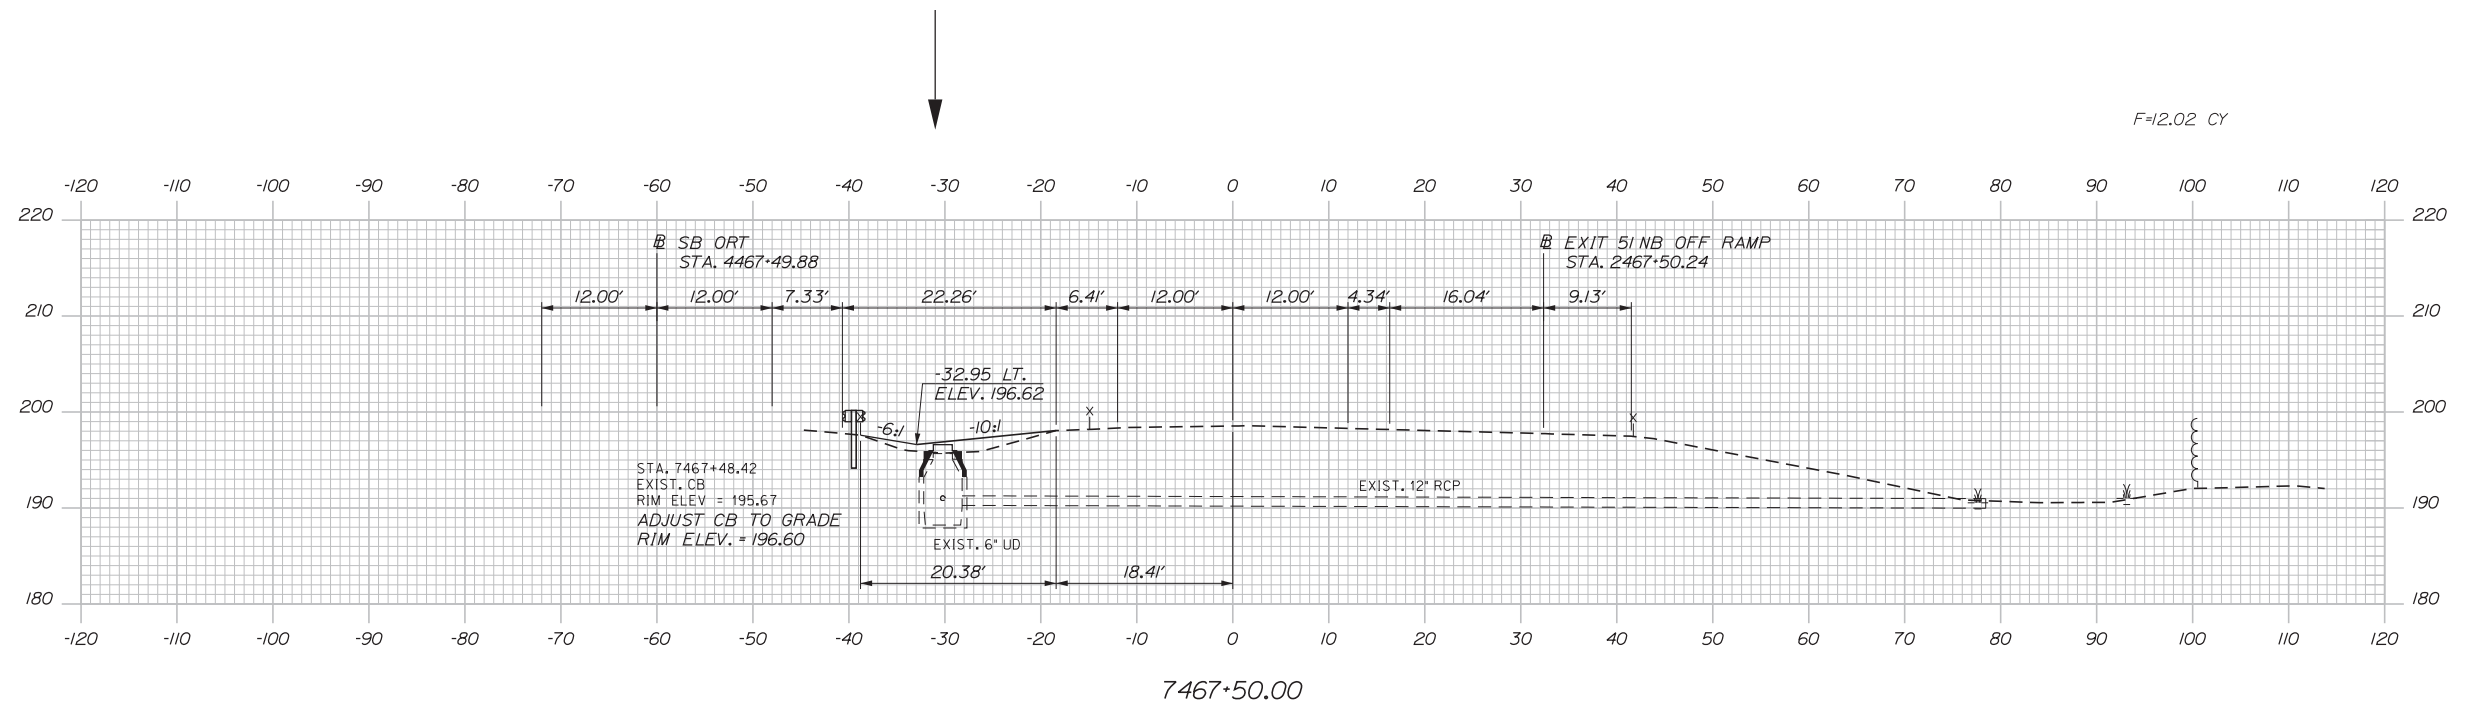

Designed by:


**Stantec**

CONSULTANT PROJECT MANAGER: LAUREN MEEK, PE

No.	Revision	By	Date

	By	Date		By	Date
Designed	PLP	3\20\19	Checked	LEM	3\20\19
Drawn	EJB	3\20\19	In Charge of	GAE	3\20\19

STANTEC CONSULTING SERVICES INC.  
 482 PAYNE ROAD  
 SCARBOROUGH, ME 04074  
 TEL (207) 887-3448  
 FAX (207) 883-3376

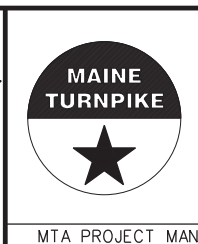

**THE GOLD STAR  
 MEMORIAL HIGHWAY**


MTA PROJECT MANAGER: RALPH NORWOOD, IV, PE, PTOE

INTERCHANGE 103  
 ORT CONVERSION  
 NB ORT  
 STA. 7467+00.00 TO STA. 7467+50.00

SHEET NUMBER: XS-13  
 CONTRACT: 2019.04  
 247 OF 503

Date: 3/20/2019

Filename: ...\\00\HIGHWAY\MSTA\\_xsect.dgn

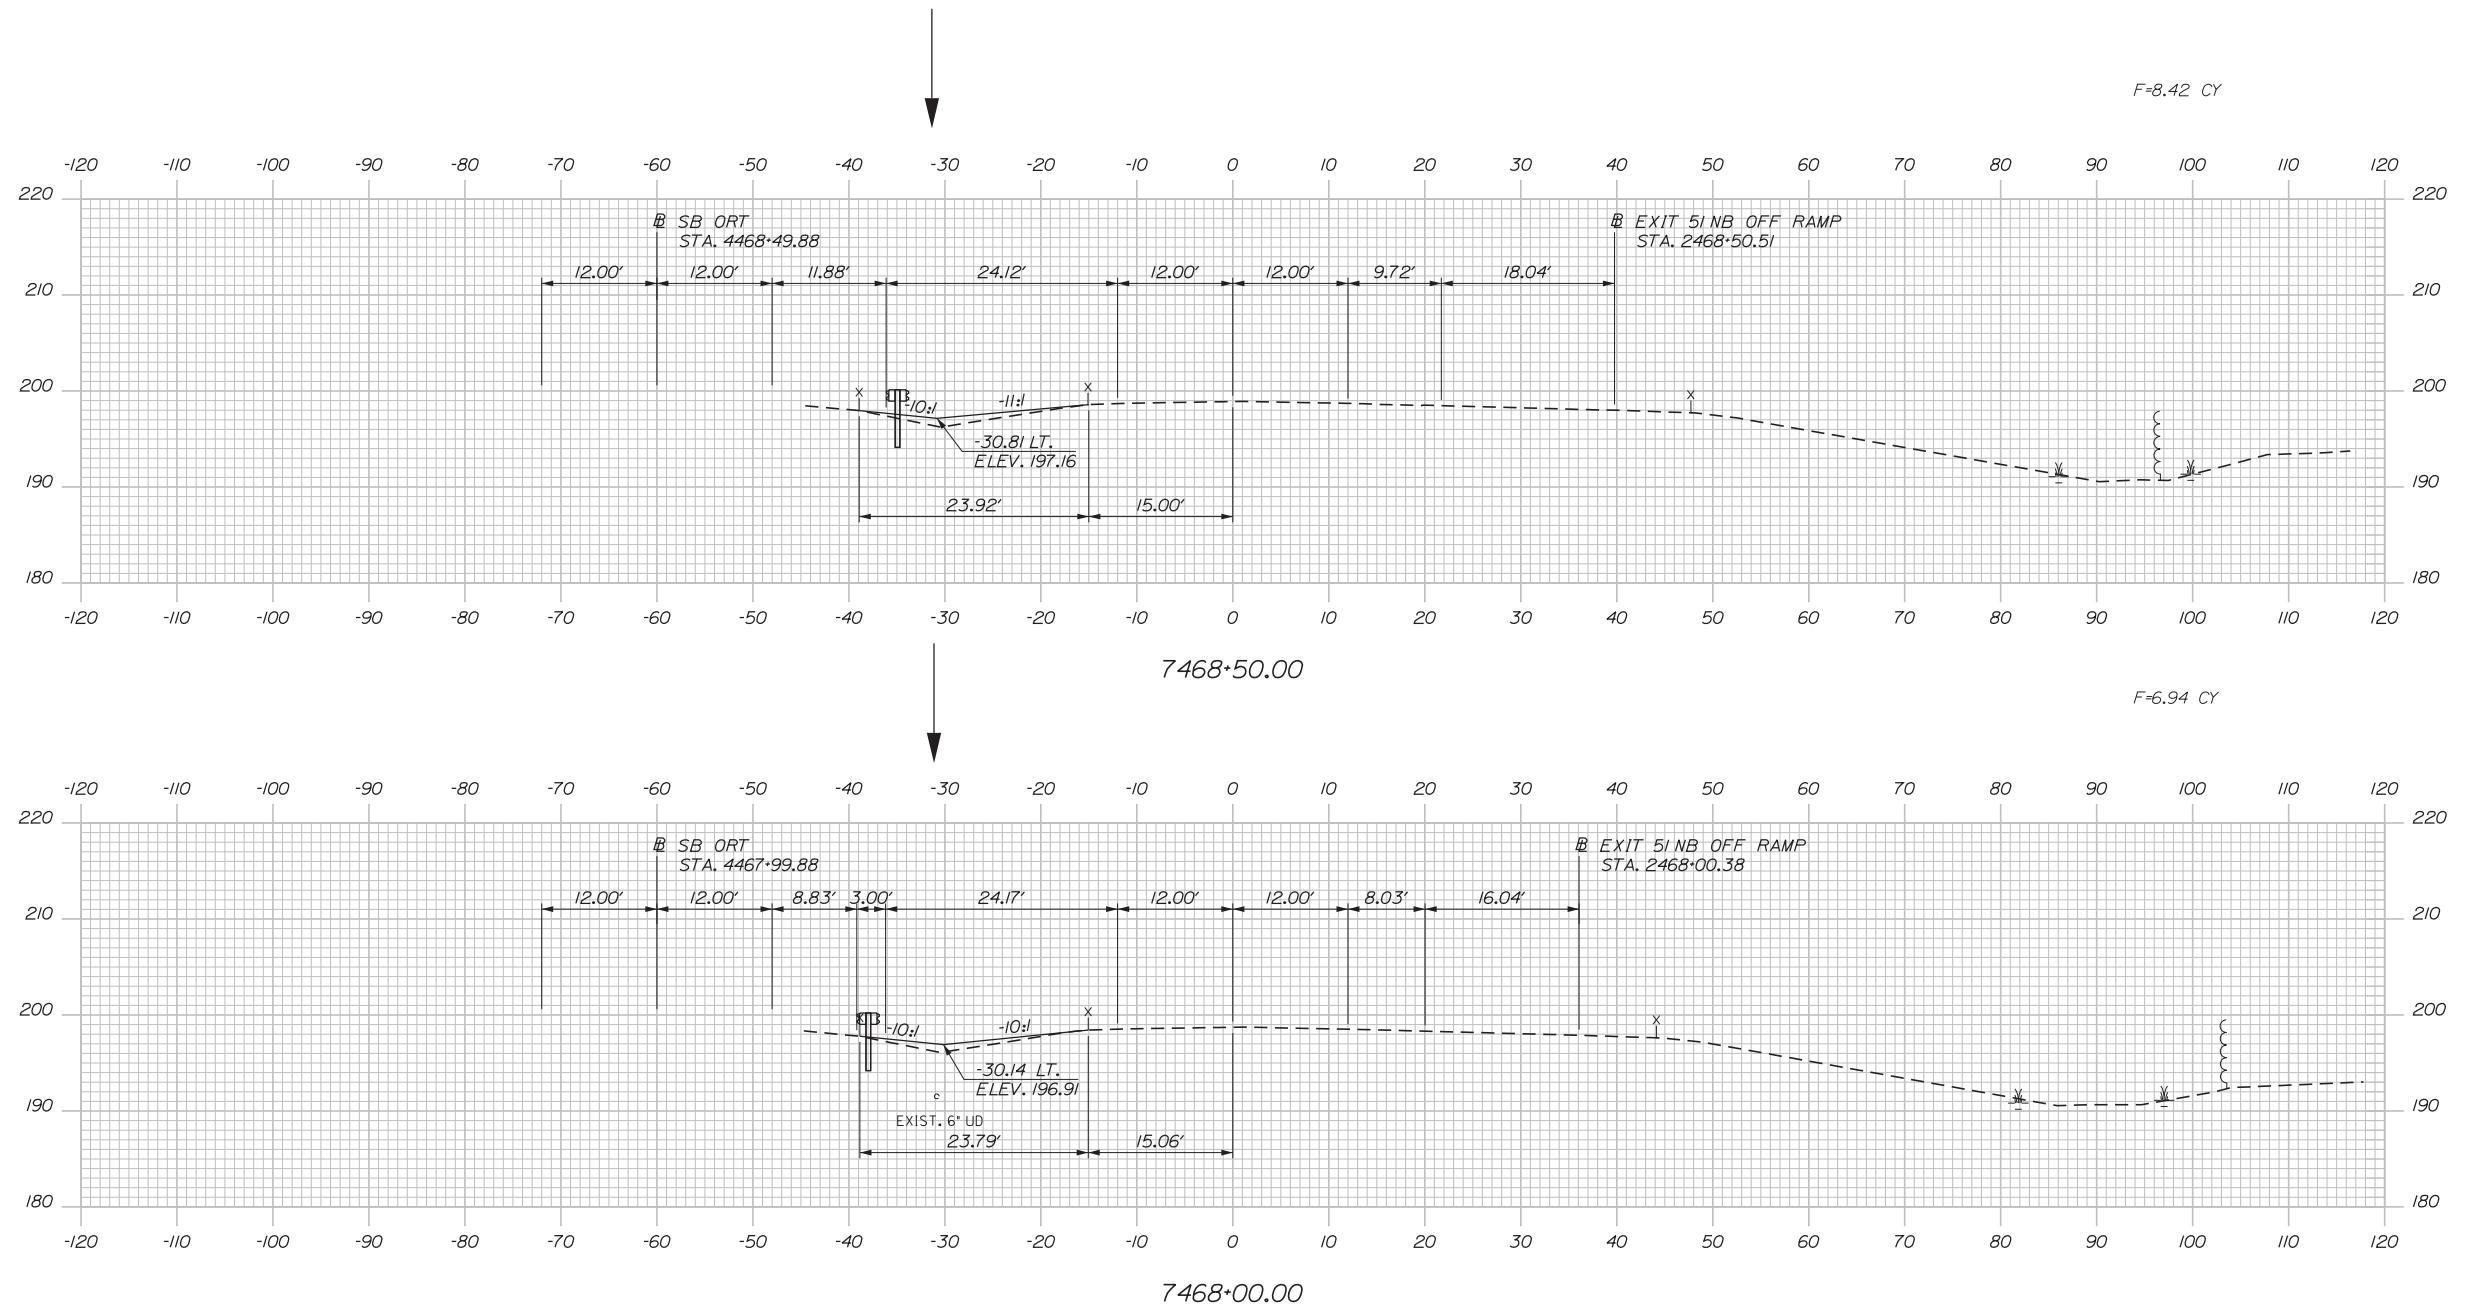

Designed by:



STANTEC CONSULTING SERVICES INC.  
482 PAYNE ROAD  
SCARBOROUGH, ME 04074  
TEL (207) 887-3448  
FAX (207) 883-3376



THE GOLD STAR  
MEMORIAL HIGHWAY

INTERCHANGE 103  
ORT CONVERSION  
NB ORT  
STA. 7468+00.00 TO STA. 7468+50.00

No.	Revision	By	Date

CONSULTANT PROJECT MANAGER: LAUREN MEEK, PE			
	By	Date	
Designed	PLP	3\20\19	Checked LEM 3\20\19
Drawn	EJB	3\20\19	In Charge of GAE 3\20\19

MTA PROJECT MANAGER: RALPH NORWOOD, IV, PE, PTOE

 

CONTRACT: 2019.04

SHEET NUMBER: XS-14

248 OF 503

Date: 3/20/2019

Filename: ... \00\HIGHWAY\MSTA\\_xsect.dgn

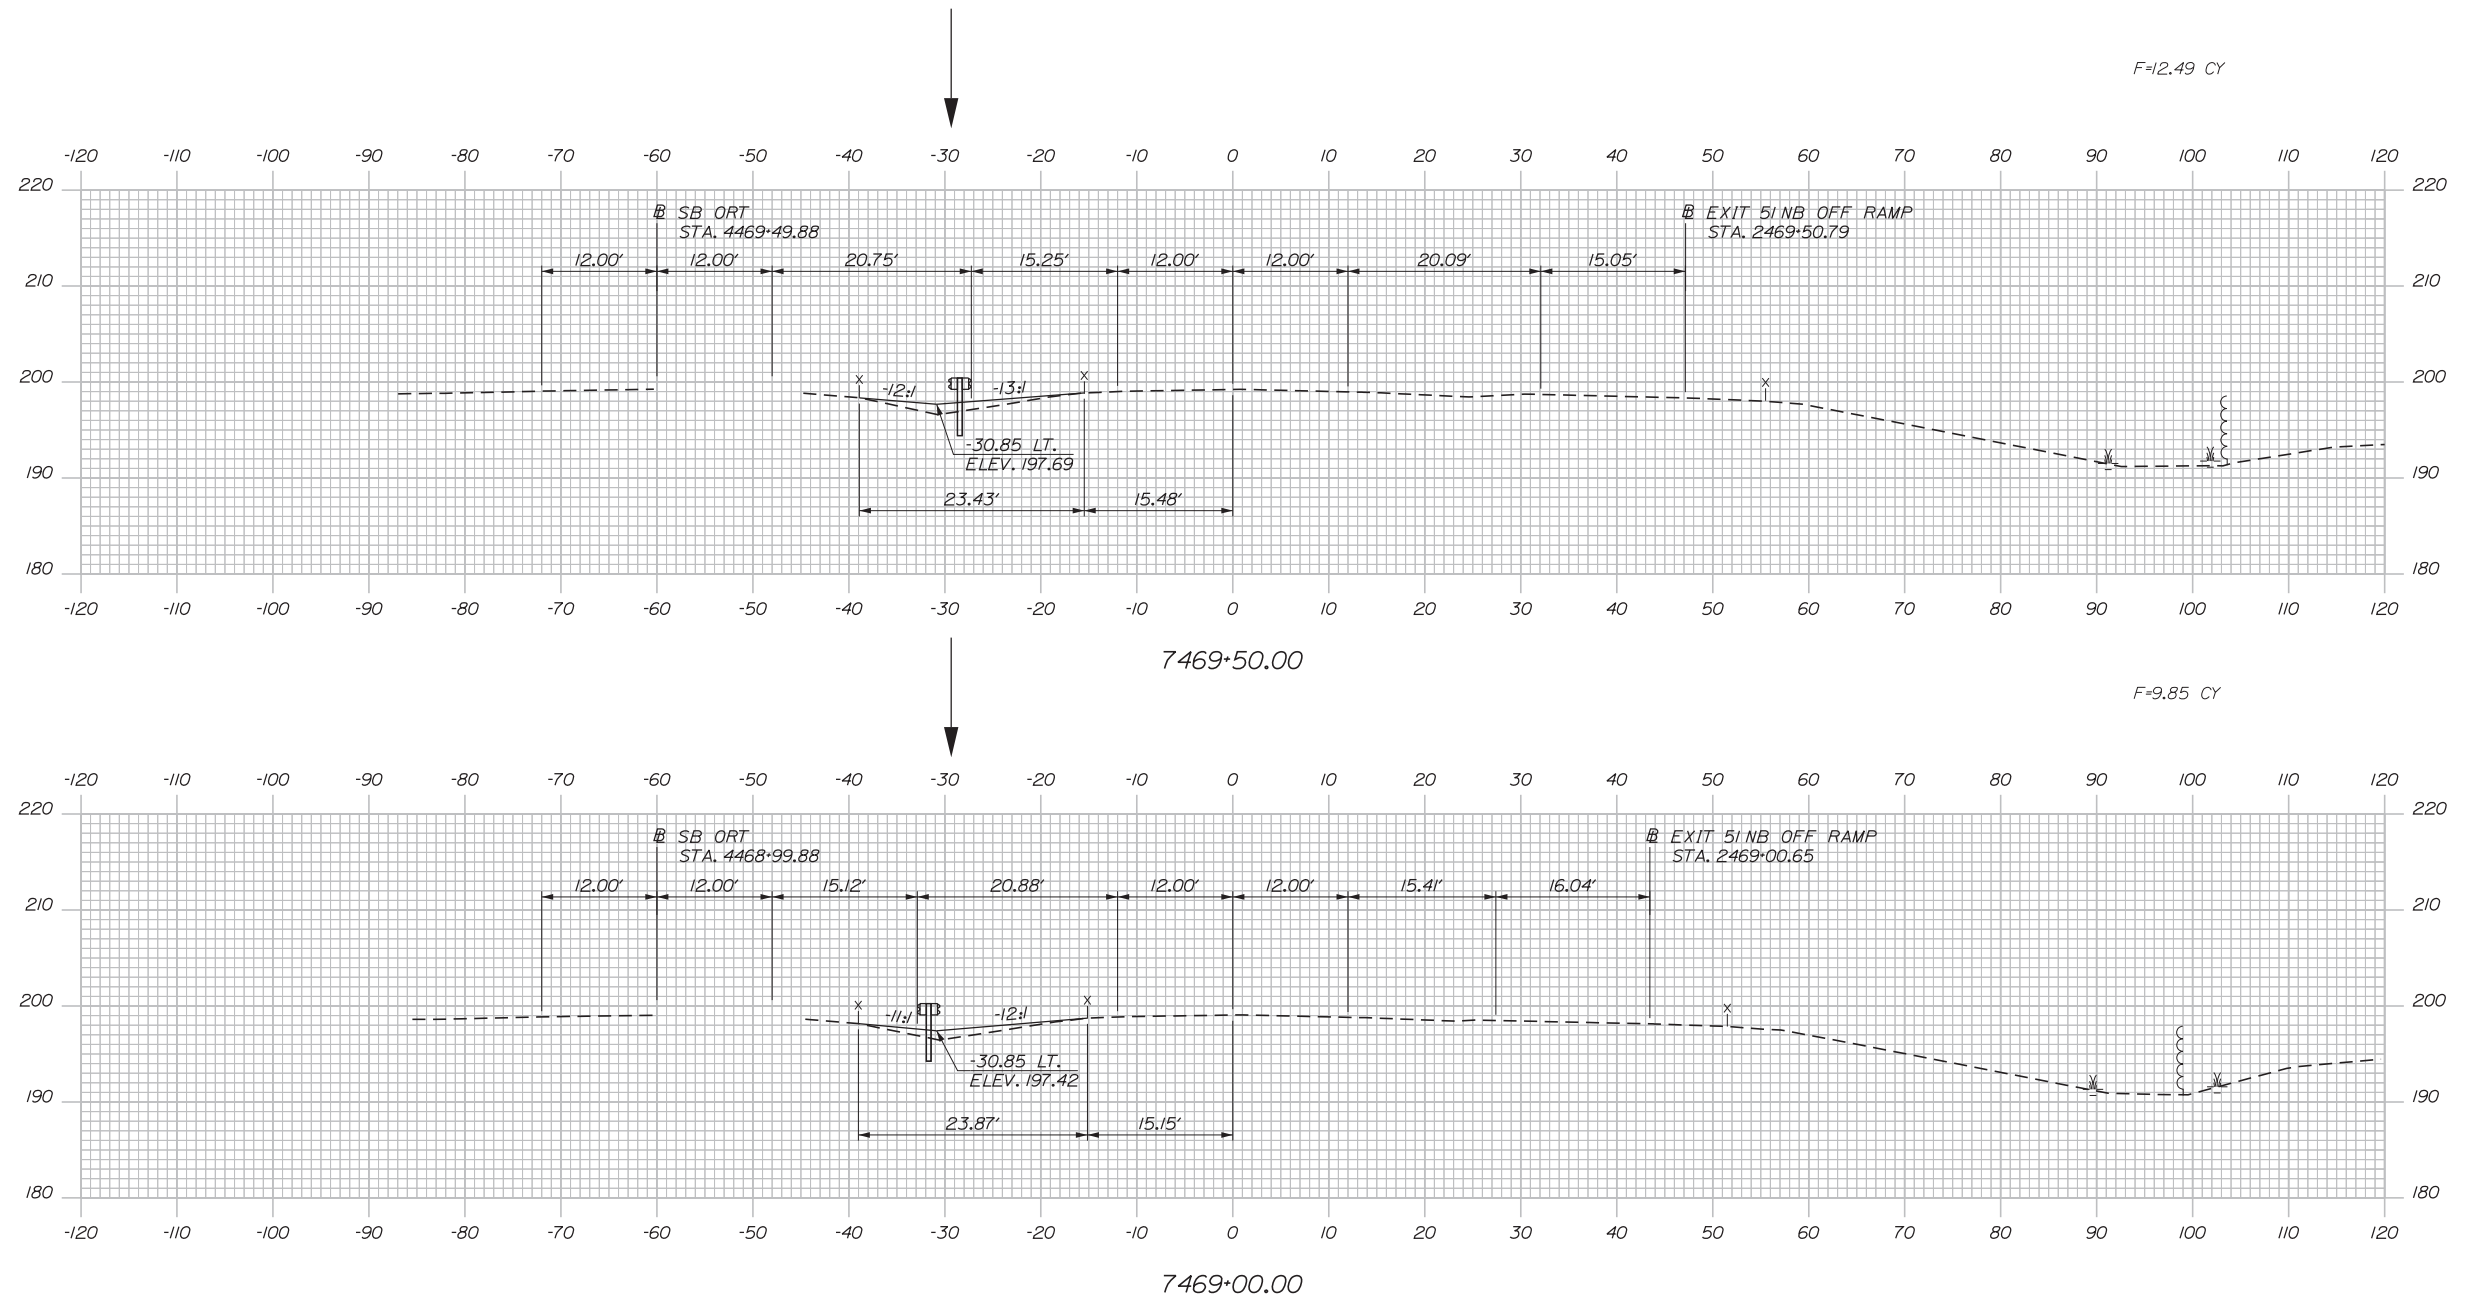

Designed by:



STANTEC CONSULTING SERVICES INC.  
 482 PAYNE ROAD  
 SCARBOROUGH, ME 04074  
 TEL (207) 887-3448  
 FAX (207) 883-3376



THE GOLD STAR  
 MEMORIAL HIGHWAY

INTERCHANGE 103  
 ORT CONVERSION  
 NB ORT  
 STA. 7469+00.00 TO STA. 7469+50.00

No.	Revision	By	Date

CONSULTANT PROJECT MANAGER: LAUREN MEEK, PE			
Designed	By	Date	Checked
	PLP	3\20\19	LEM
Drawn	By	Date	In Charge of
	EJB	3\20\19	GAE

MTA PROJECT MANAGER: RALPH NORWOOD, IV, PE, PTOE

 

CONTRACT: 2019.04

SHEET NUMBER: XS-15

249 OF 503

Date: 3/20/2019

Filename: ... \00\HIGHWAY\MSTA\\_xsect.dgn

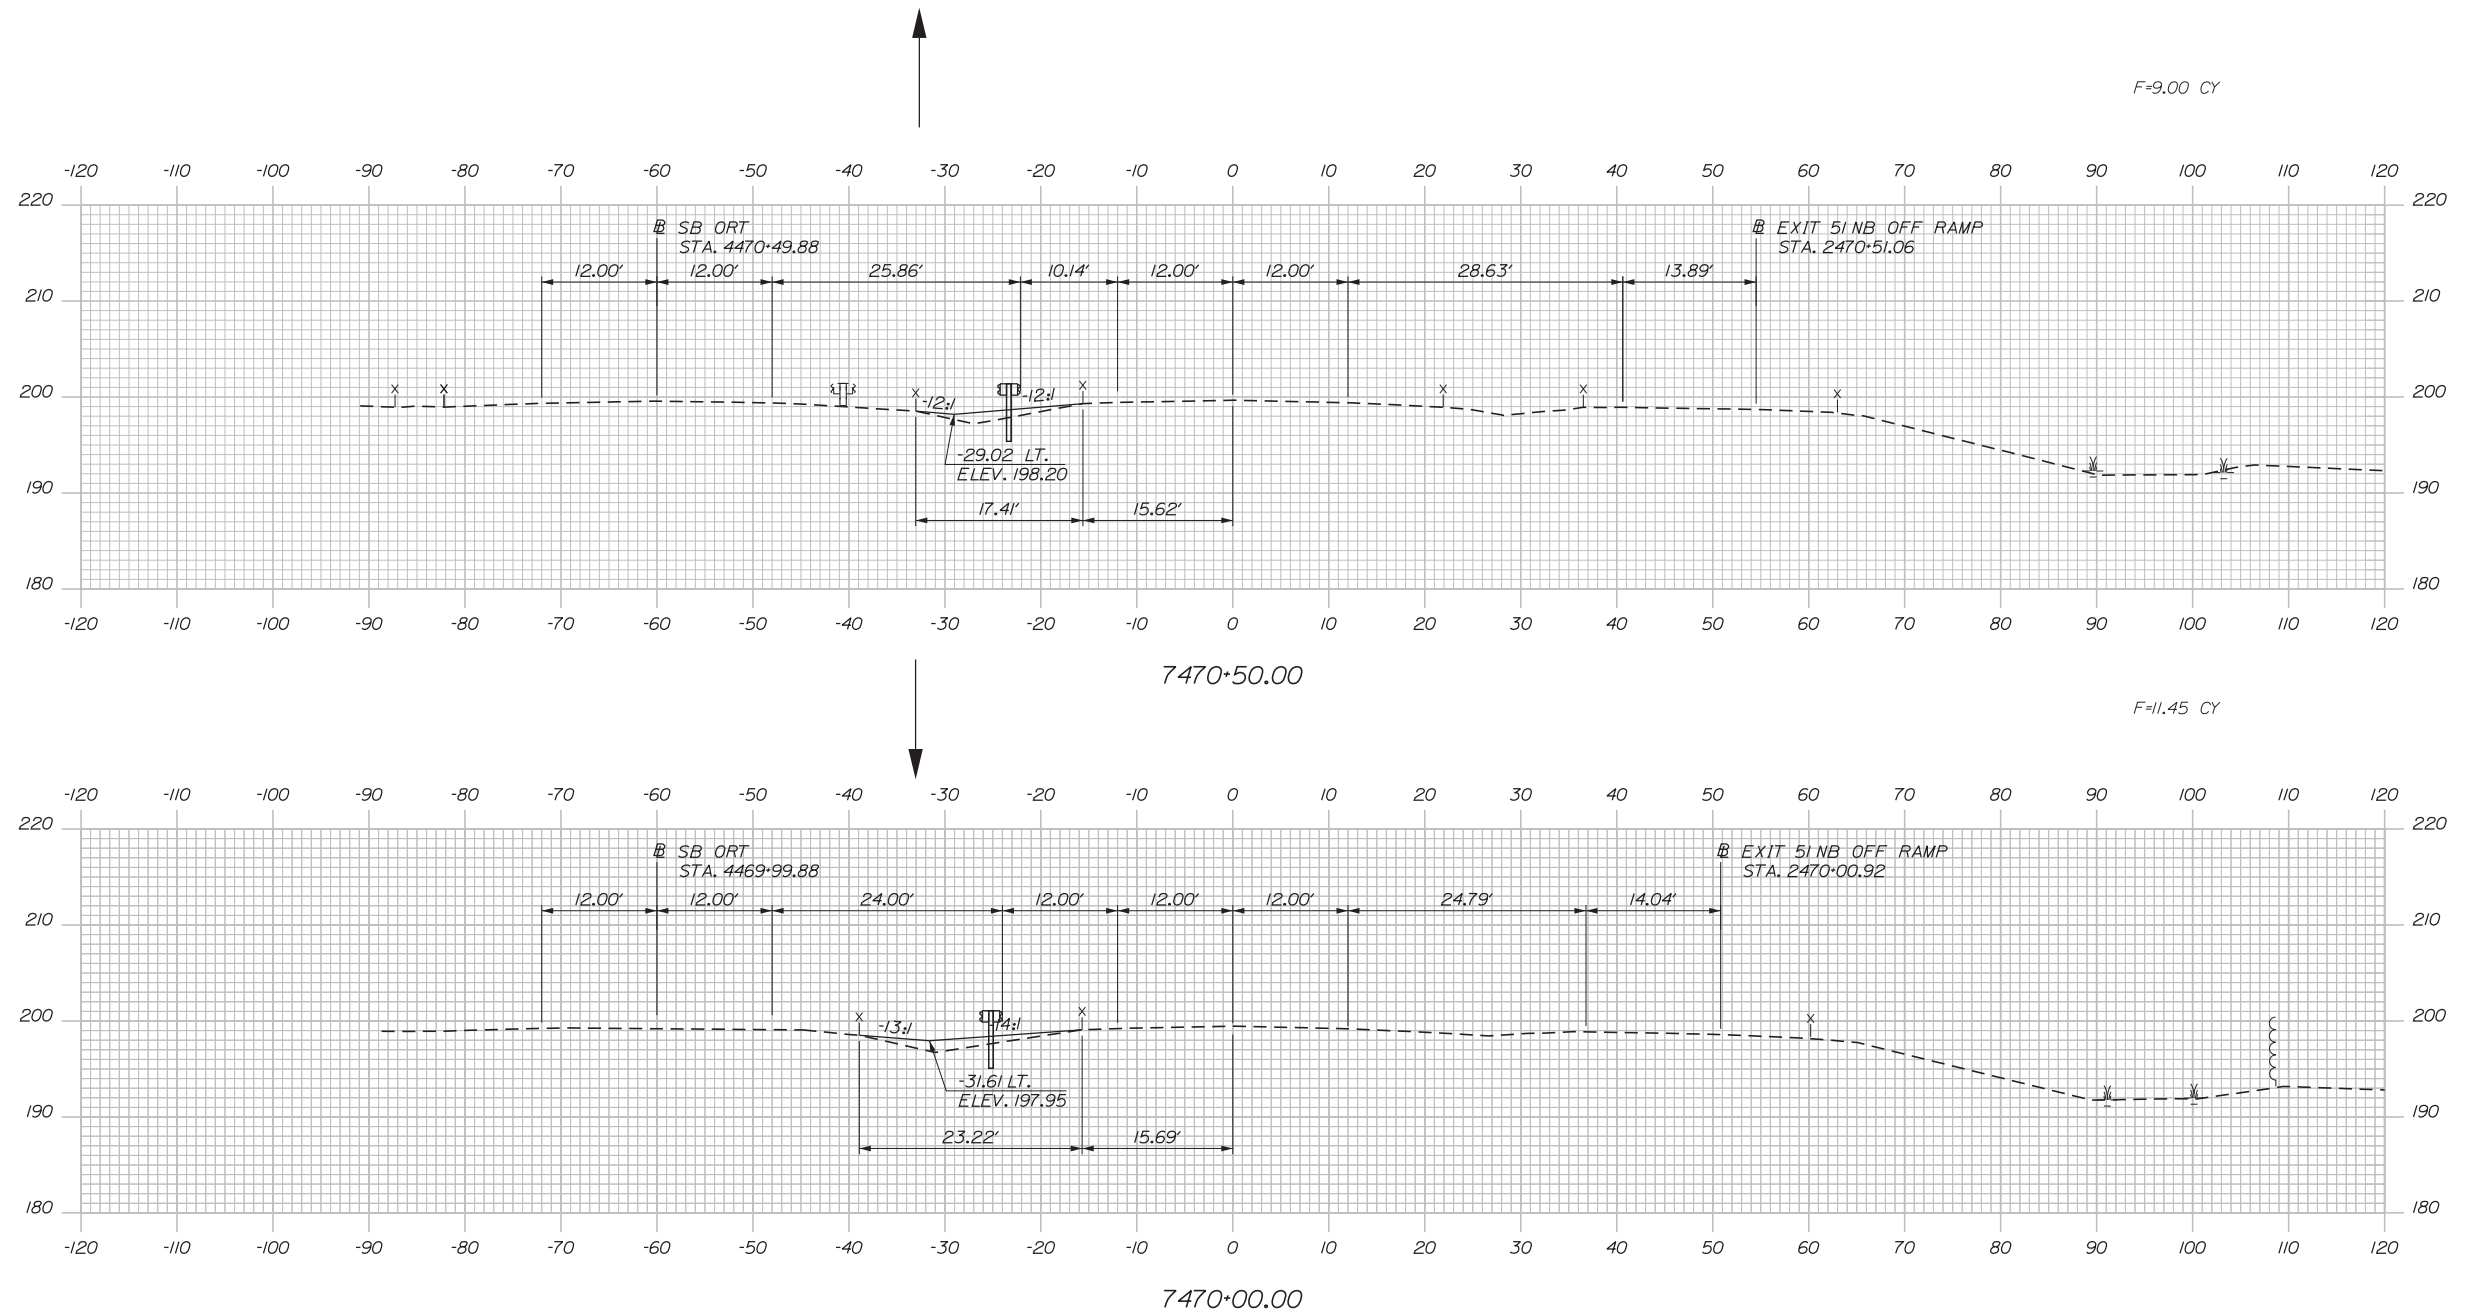

Designed by:

**Stantec**

CONSULTANT PROJECT MANAGER: LAUREN MEEK, PE

No.	Revision	By	Date

	By	Date		By	Date
Designed	PLP	3\20\19	Checked	LEM	3\20\19
Drawn	EJB	3\20\19	In Charge of	GAE	3\20\19

STANTEC CONSULTING SERVICES INC.  
 482 PAYNE ROAD  
 SCARBOROUGH, ME 04074  
 TEL (207) 887-3448  
 FAX (207) 883-3376

**MAINE TURNPIKE**

**THE GOLD STAR MEMORIAL HIGHWAY**

MTA PROJECT MANAGER: RALPH NORWOOD, IV, PE, PTOE




INTERCHANGE 103  
 ORT CONVERSION  
 NB ORT  
 STA. 7470+00.00 TO STA. 7470+50.00

SHEET NUMBER: XS-16  
 250 OF 503

CONTRACT: 2019.04

Date: 3/20/2019

 Filename: ...00\HIGHWAY\MSTA\\_xsect.dgn

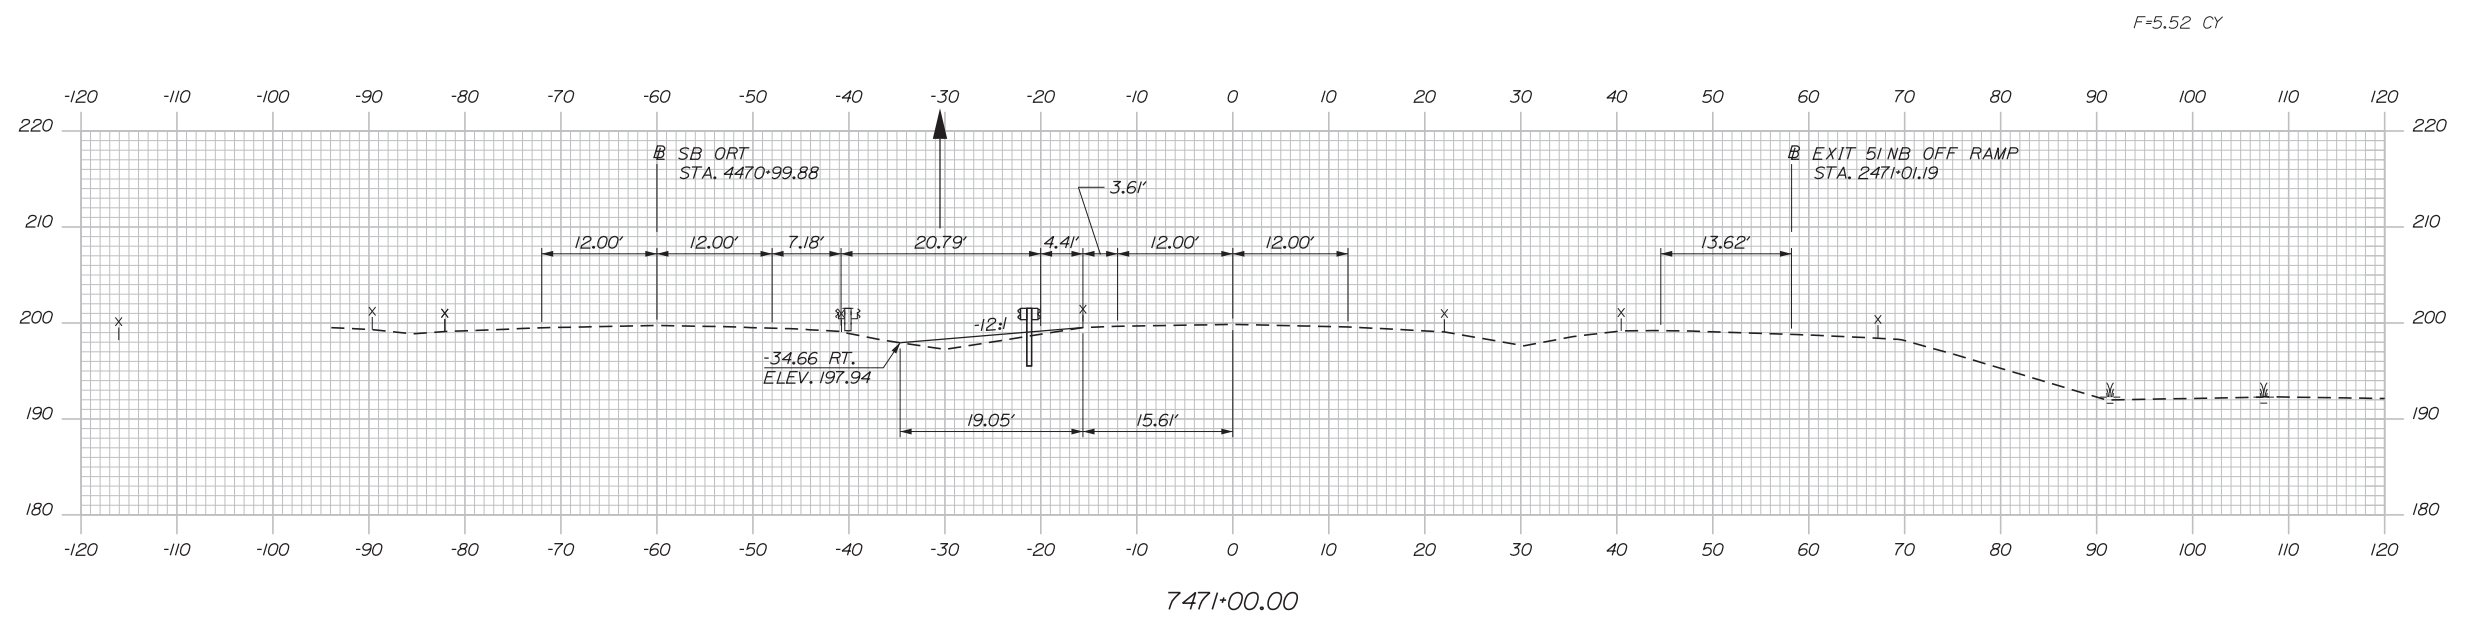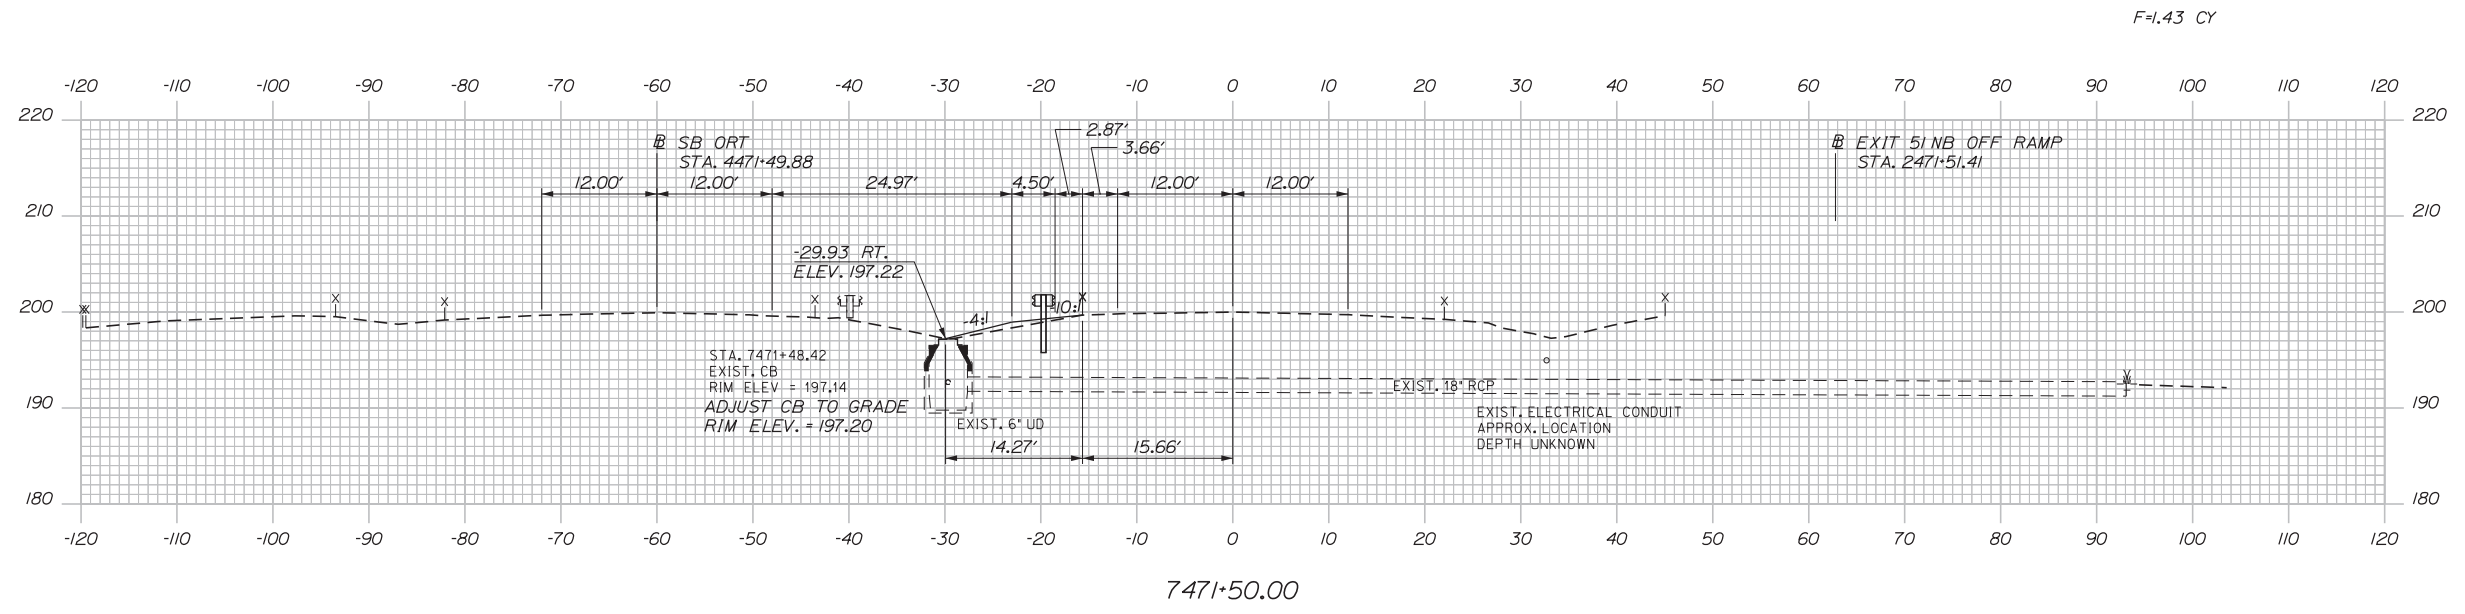

Designed by:


**Stantec**

CONSULTANT PROJECT MANAGER: LAUREN MEEK, PE

No.	Revision	By	Date

	By	Date		By	Date
Designed	PLP	3\20\19	Checked	LEM	3\20\19
Drawn	EJB	3\20\19	In Charge of	GAE	3\20\19

STANTEC CONSULTING SERVICES INC.  
 482 PAYNE ROAD  
 SCARBOROUGH, ME 04074  
 TEL (207) 887-3448  
 FAX (207) 883-3376

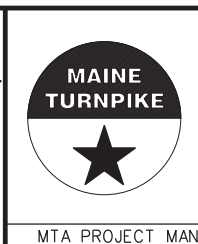

**THE GOLD STAR  
 MEMORIAL HIGHWAY**





INTERCHANGE 103  
 ORT CONVERSION  
 NB ORT  
 STA. 7471+00.00 TO STA. 7471+50.00

SHEET NUMBER: XS-17  
 CONTRACT: 2019.04  
 251 OF 503



Date: 3/20/2019

Filename: ...00\HIGHWAY\MSTA\...xsect.dgn

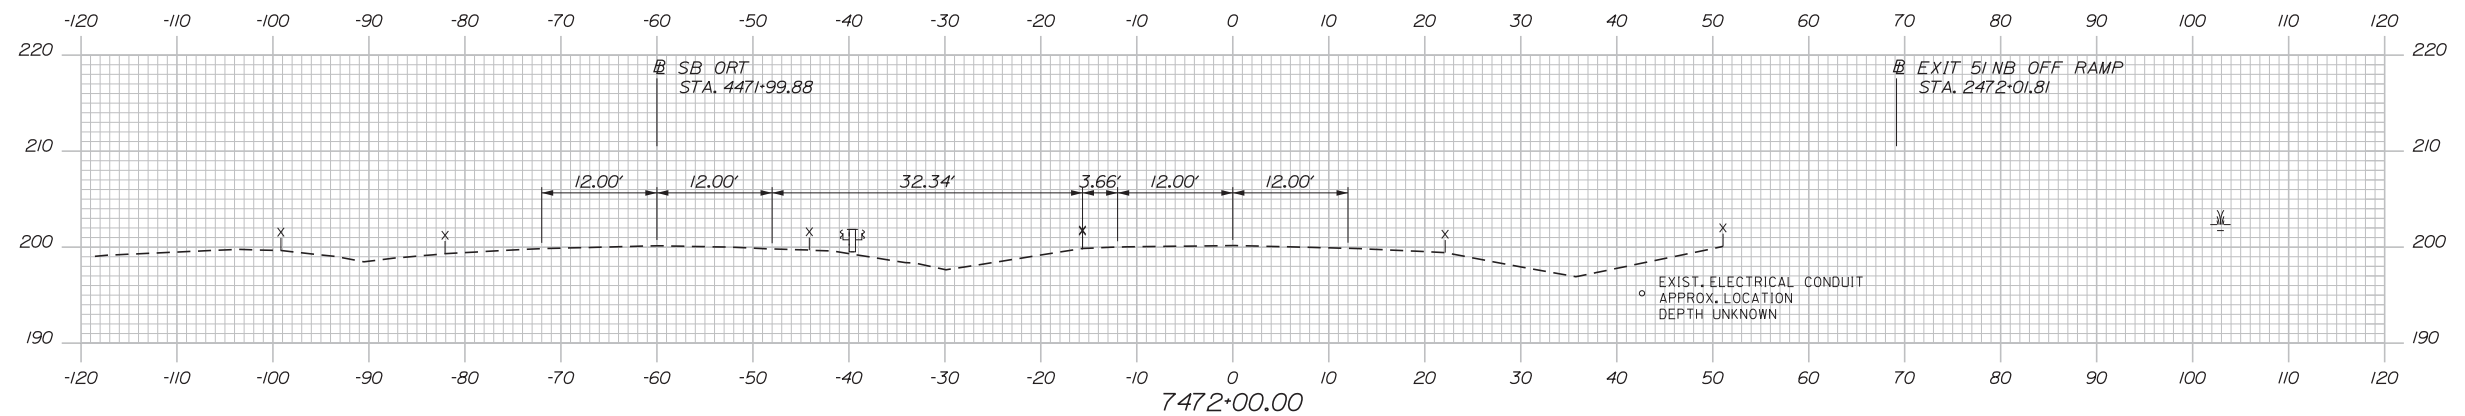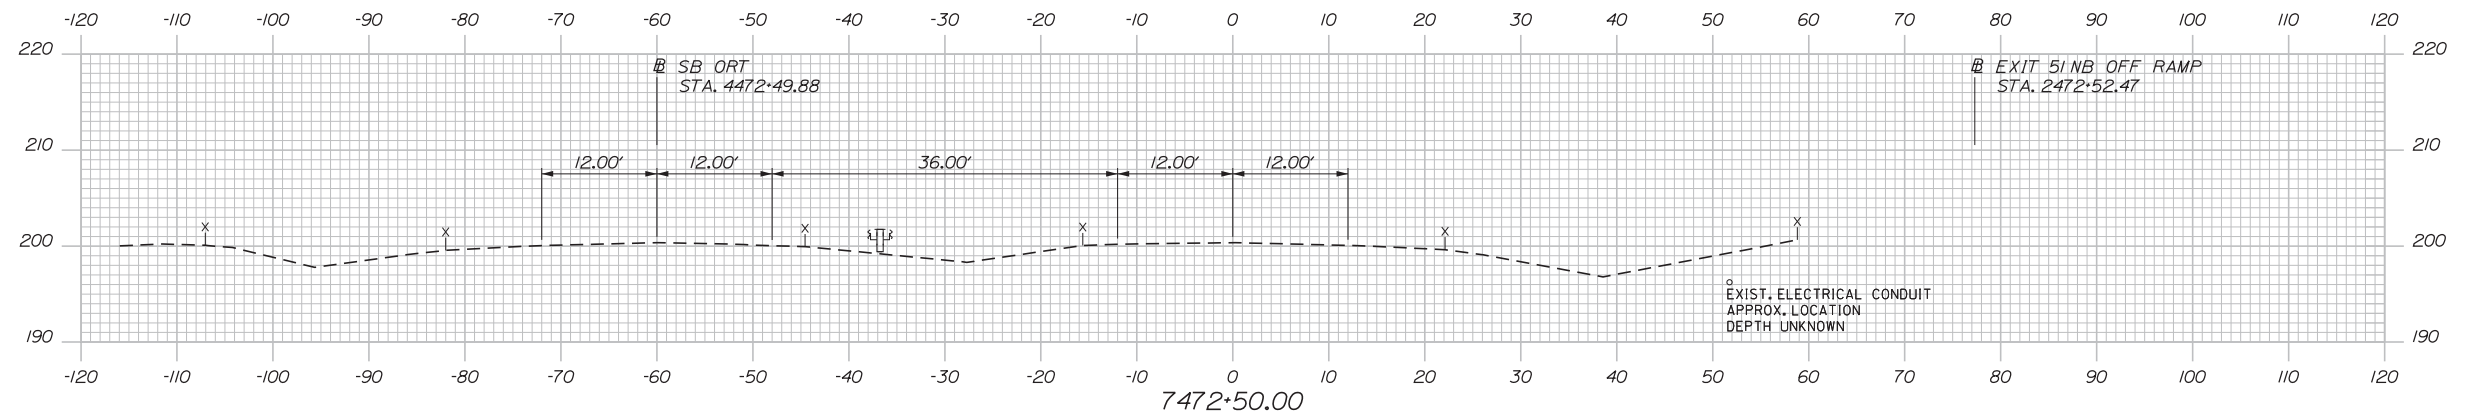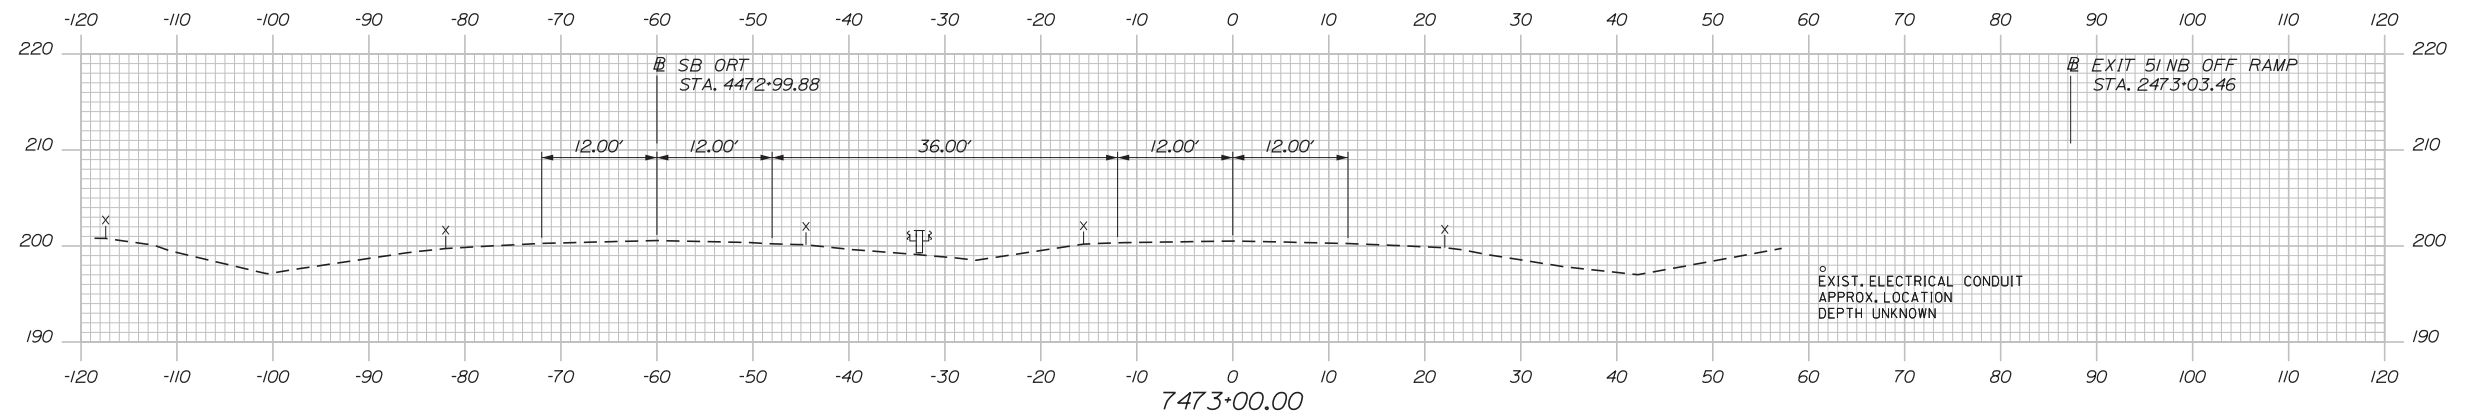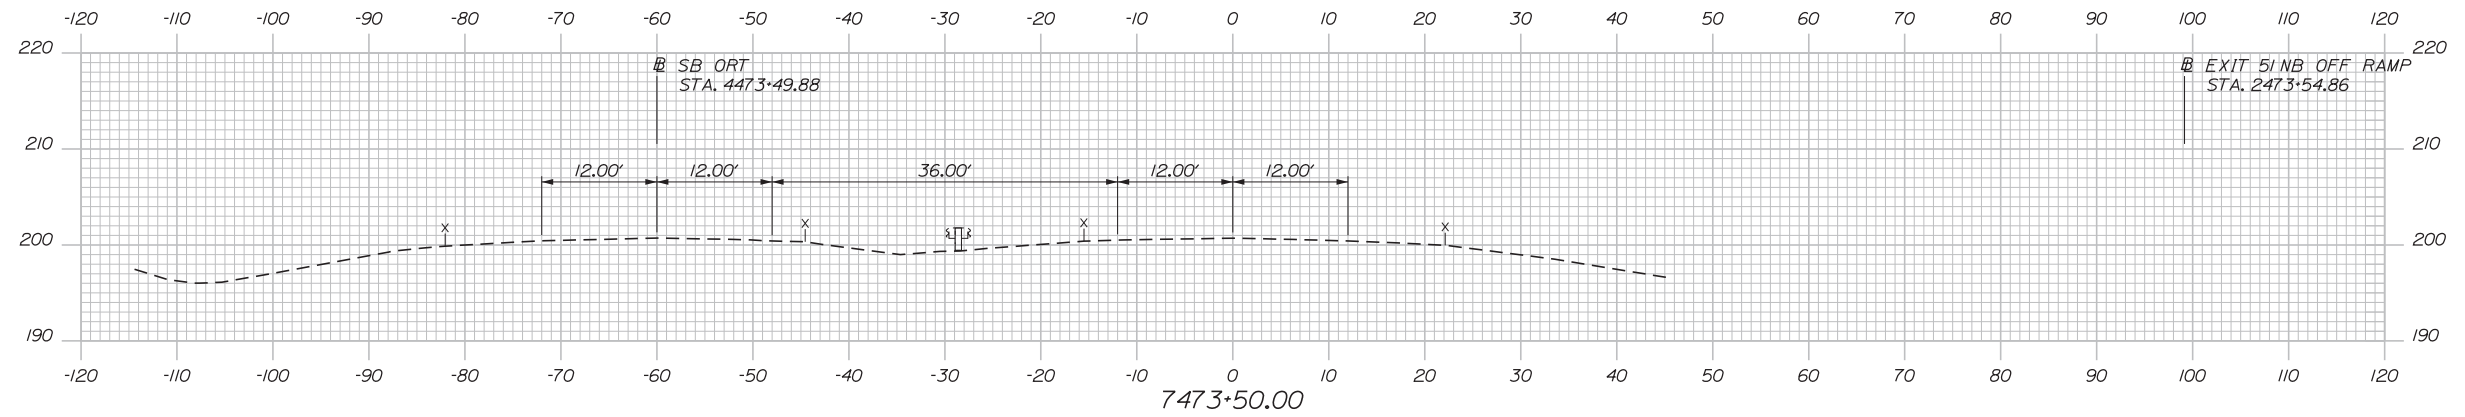

Designed by:



STANTEC CONSULTING SERVICES INC.  
 482 PAYNE ROAD  
 SCARBOROUGH, ME 04074  
 TEL (207) 887-3448  
 FAX (207) 883-3376



**THE GOLD STAR  
 MEMORIAL HIGHWAY**

INTERCHANGE 103  
 ORT CONVERSION  
 NB ORT  
 STA. 7472+00.00 TO STA. 7473+00.00

No.	Revision	By	Date

CONSULTANT PROJECT MANAGER: LAUREN MEEK, PE			
Designed	By	Date	Checked
	PLP	3\20\19	LEM
Drawn	By	Date	In Charge of
	EJB	3\20\19	GAE

 


MTA PROJECT MANAGER: RALPH NORWOOD, IV, PE, PTOE

CONTRACT: 2019.04

SHEET NUMBER: XS-18

252 OF 503

Date: 3/20/2019

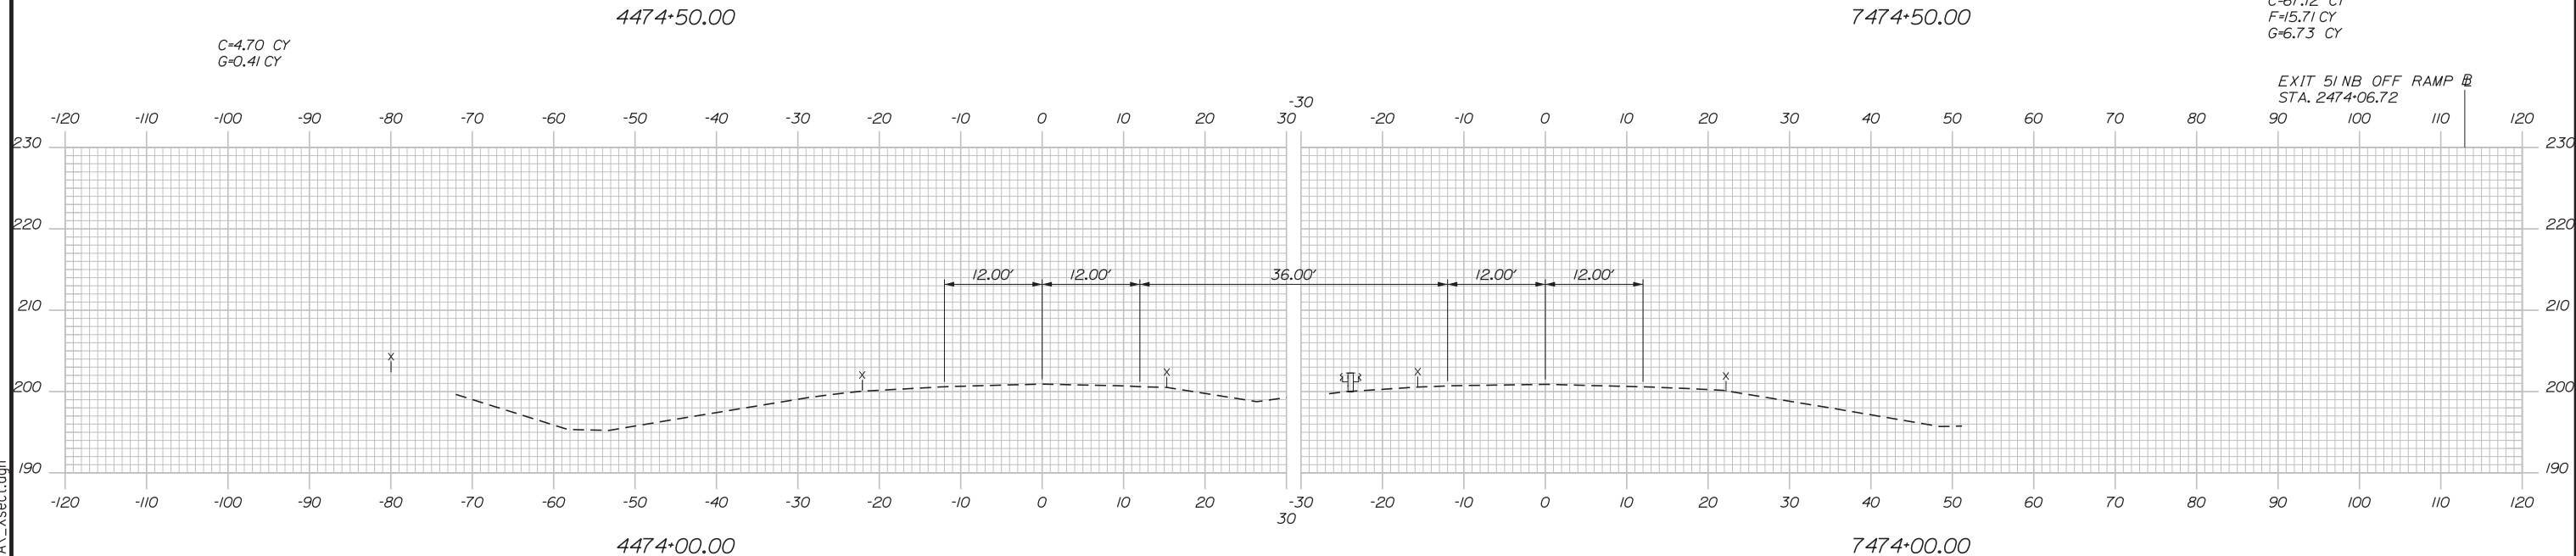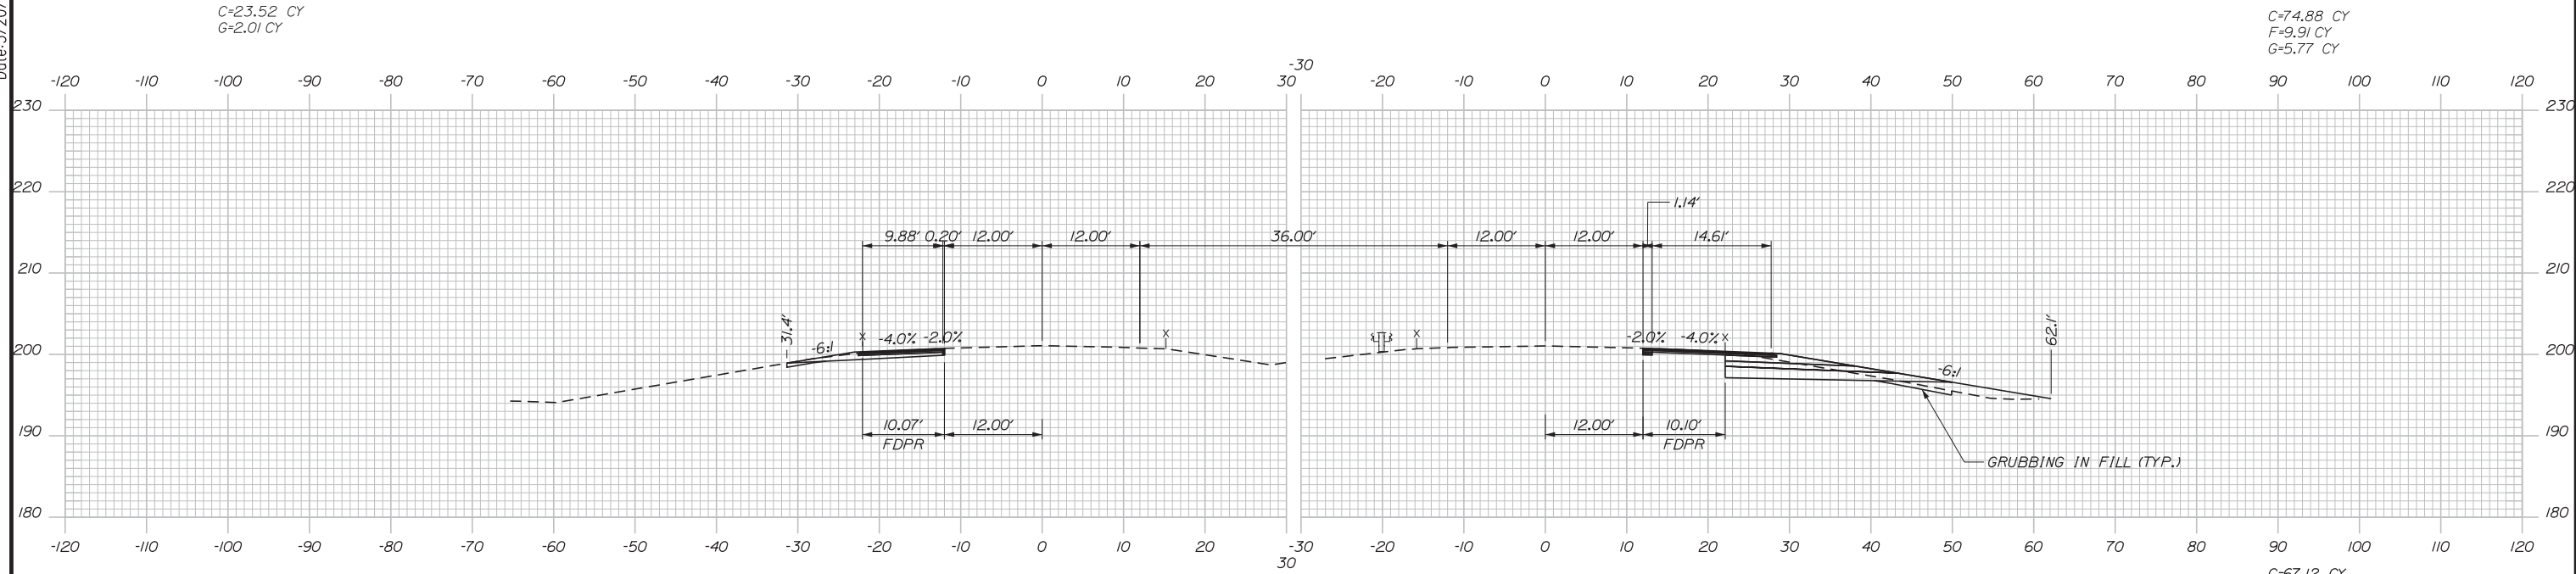

Designed by:

**Stantec**

No.	Revision	By	Date

CONSULTANT PROJECT MANAGER: LAUREN MEEK, PE			
Designed	By	Date	Checked
	PLP	3\20\19	LEM
Drawn	By	Date	In Charge of
	EJB	3\20\19	GAE

STANTEC CONSULTING SERVICES INC.  
 482 PAYNE ROAD  
 SCARBOROUGH, ME 04074  
 TEL (207) 887-3448  
 FAX (207) 883-3376

**MAINE TURNPIKE**

**THE GOLD STAR MEMORIAL HIGHWAY**




MTA PROJECT MANAGER: RALPH NORWOOD, IV, PE, PTOE

INTERCHANGE 103  
 ORT CONVERSION  
 NB/SB ORT  
 STA. 4474+00/7474+00 TO STA. 4474+50/7474+50

SHEET NUMBER: XS-19  
 CONTRACT: 2019.04  
 253 OF 503

Filename: ... \00\HIGHWAY\STA\\_xsect.dgn

 Date: 3/20/2019

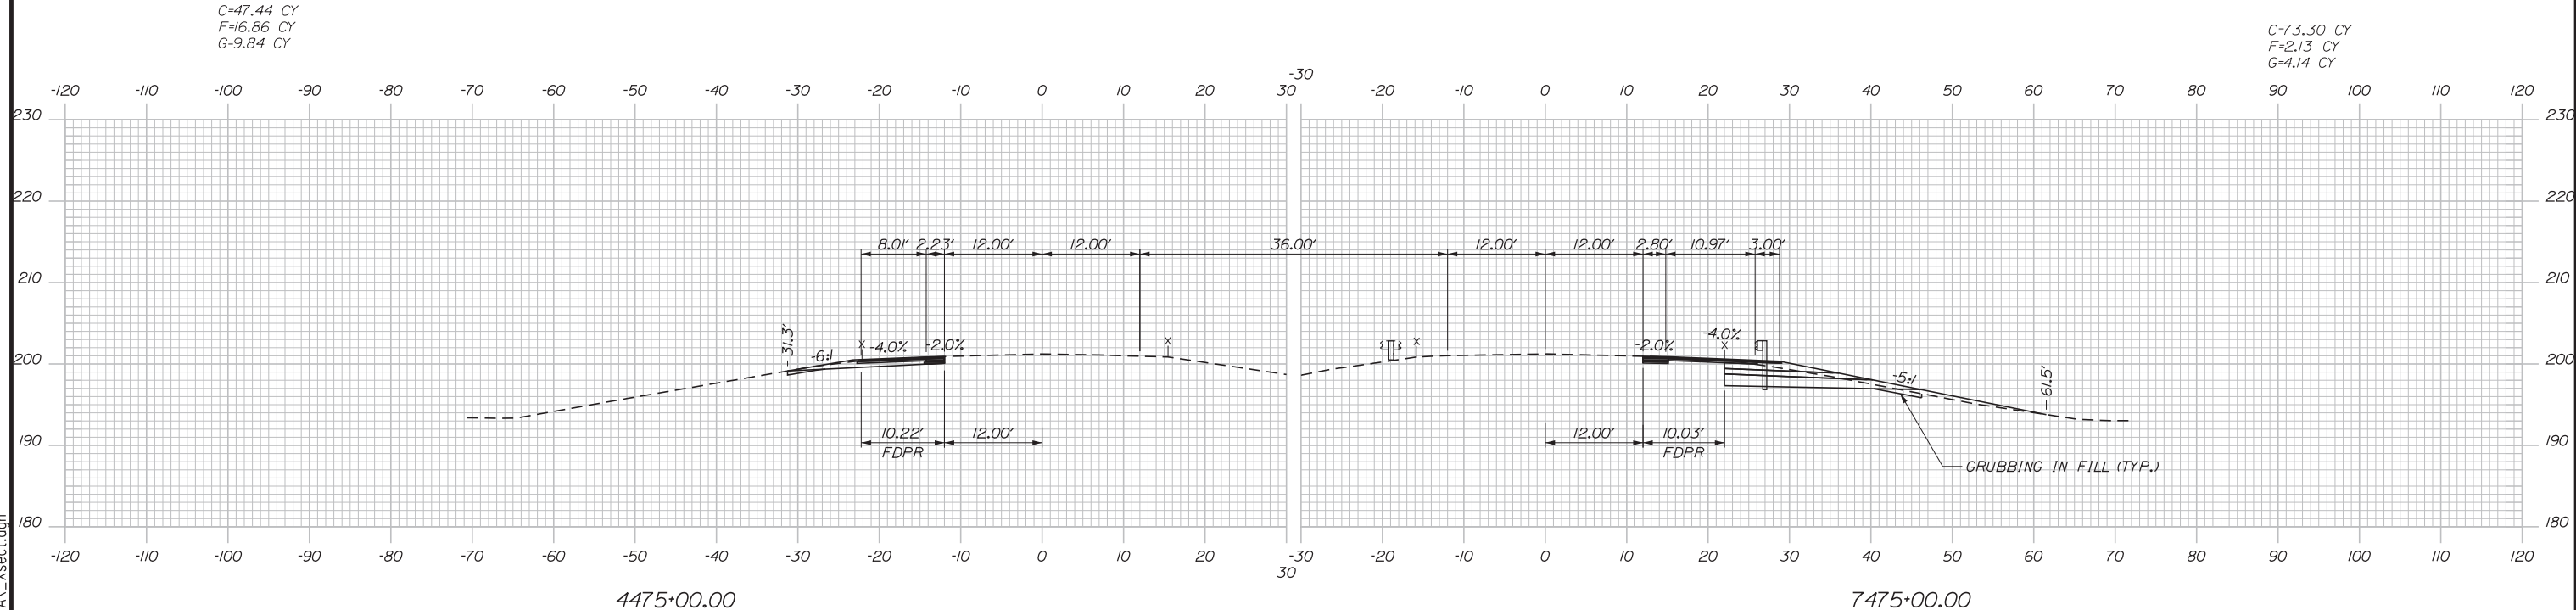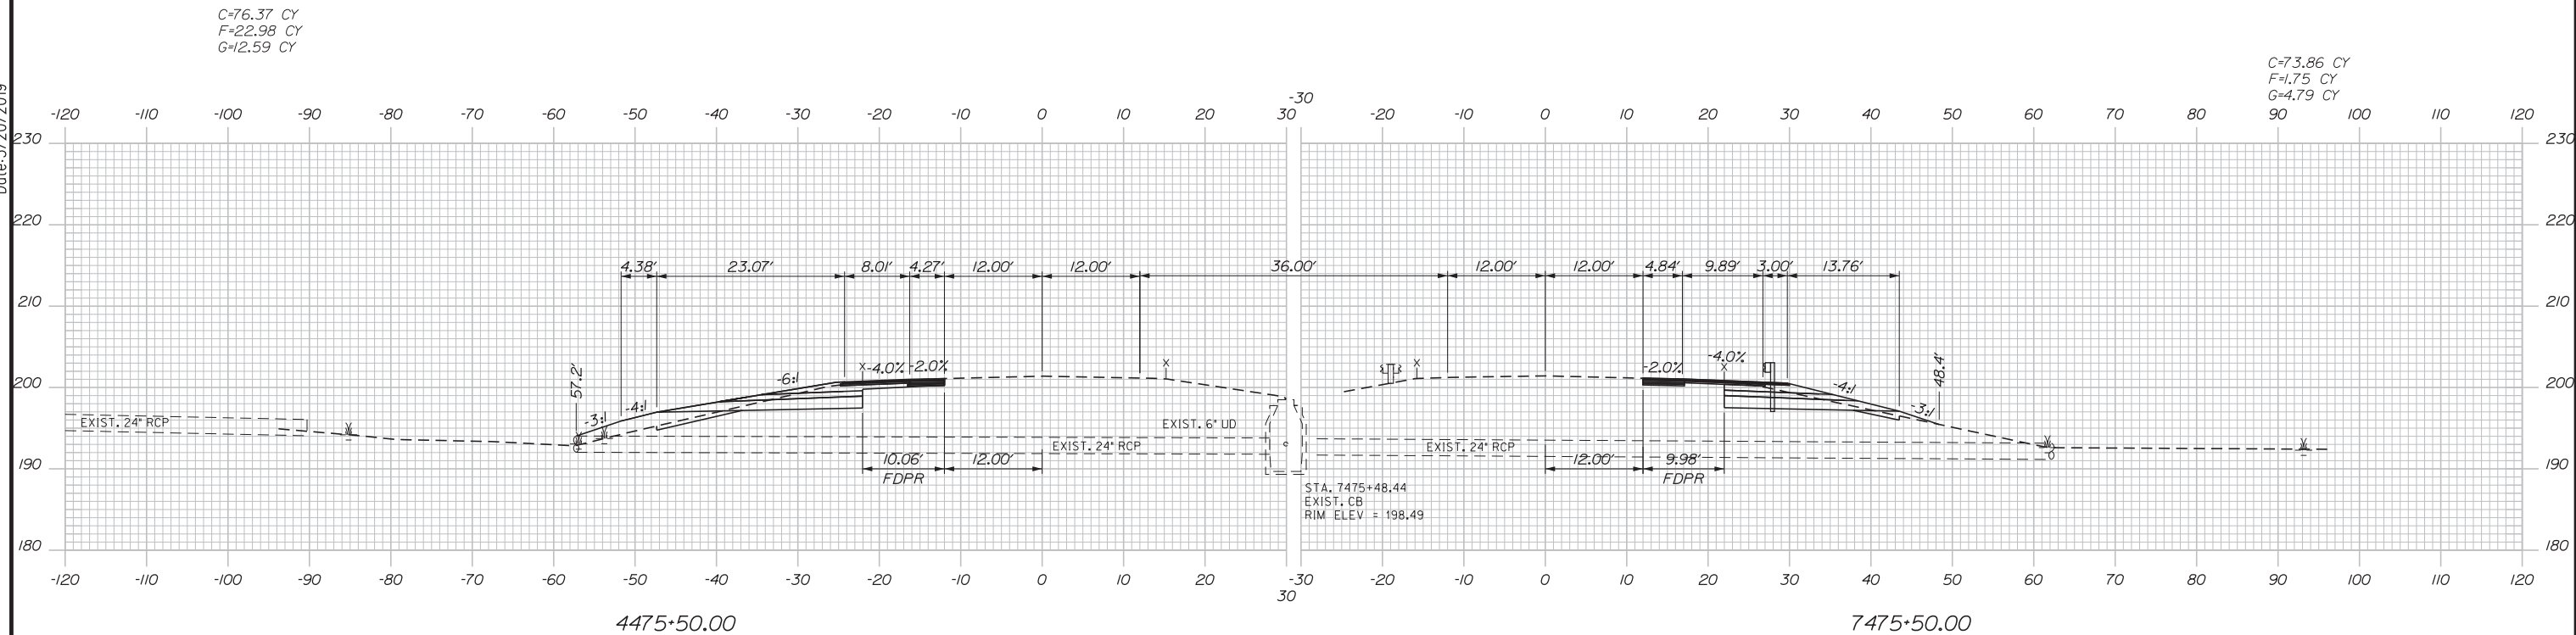


Designed by:

**Stantec**

CONSULTANT PROJECT MANAGER: LAUREN MEEK, PE			
By	Date	By	Date
Designed	PLP 3\20\19	Checked	LEM 3\20\19
Drawn	EJB 3\20\19	In Charge of	GAE 3\20\19

STANTEC CONSULTING SERVICES INC.  
482 PAYNE ROAD  
SCARBOROUGH, ME 04074  
TEL (207) 887-3448  
FAX (207) 883-3376

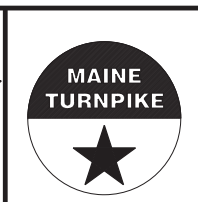


**THE GOLD STAR  
MEMORIAL HIGHWAY**

INTERCHANGE 103  
ORT CONVERSION  
NB/SB ORT  
STA. 4475+00/7475+00 TO STA. 4475+50/7475+50


Filename: ...00.HIGHWAY\MSTA\\_xsect.dgn

Date: 3/20/2019

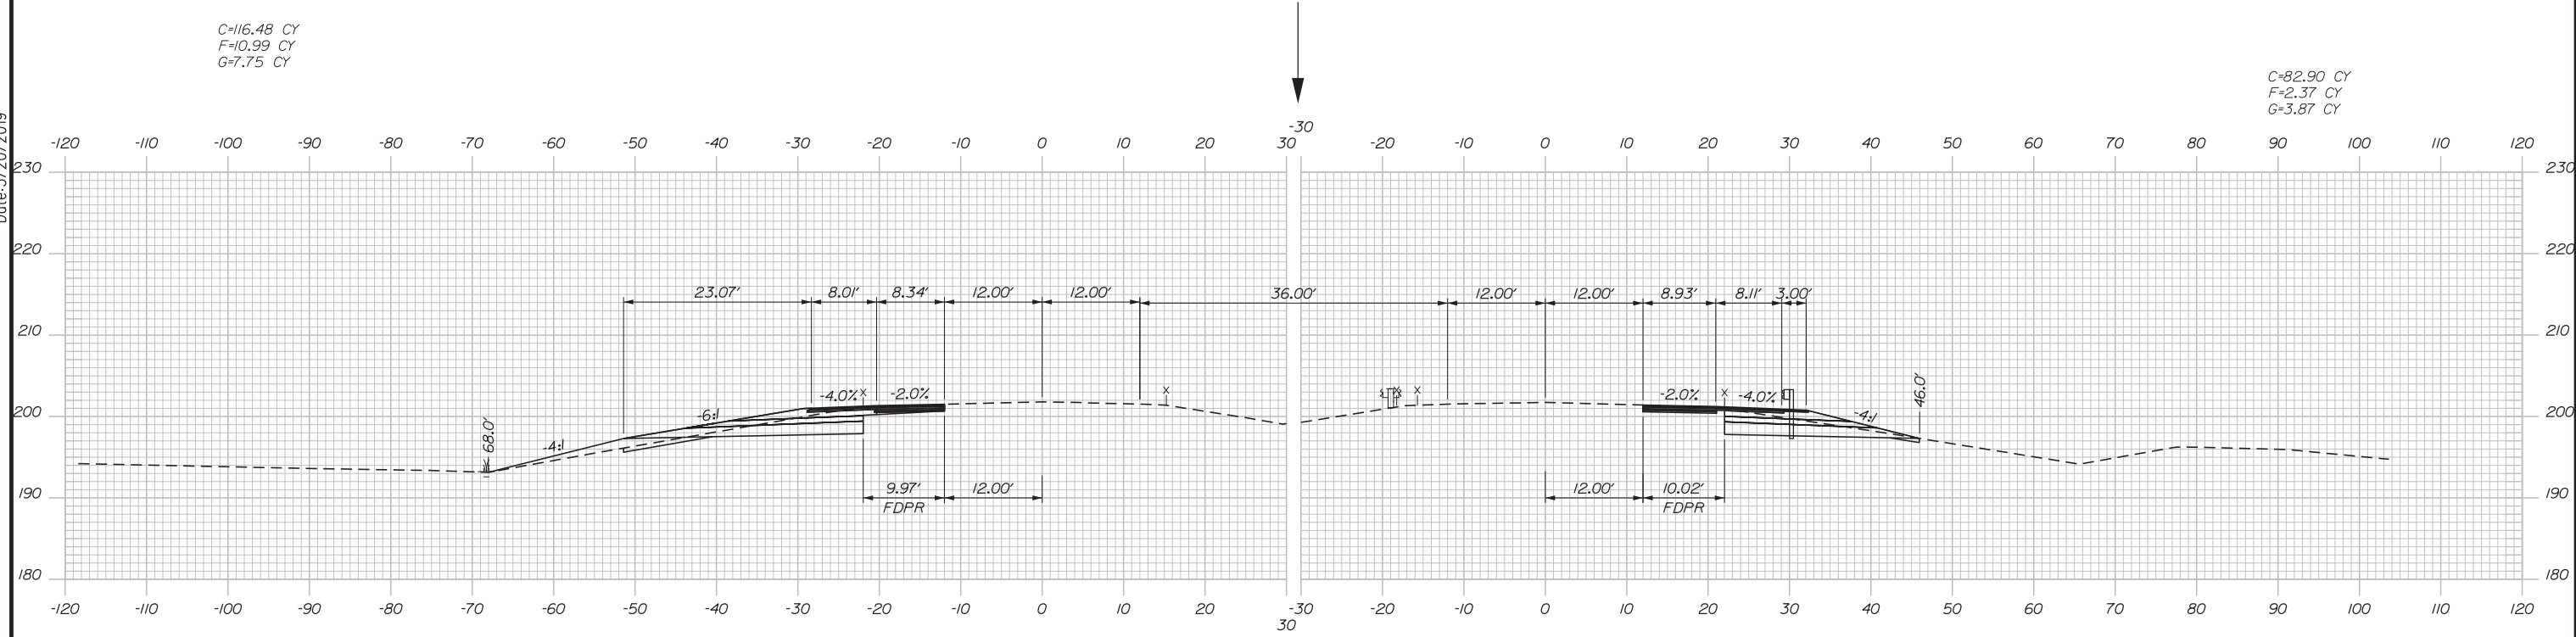


4476+50.00

7476+50.00

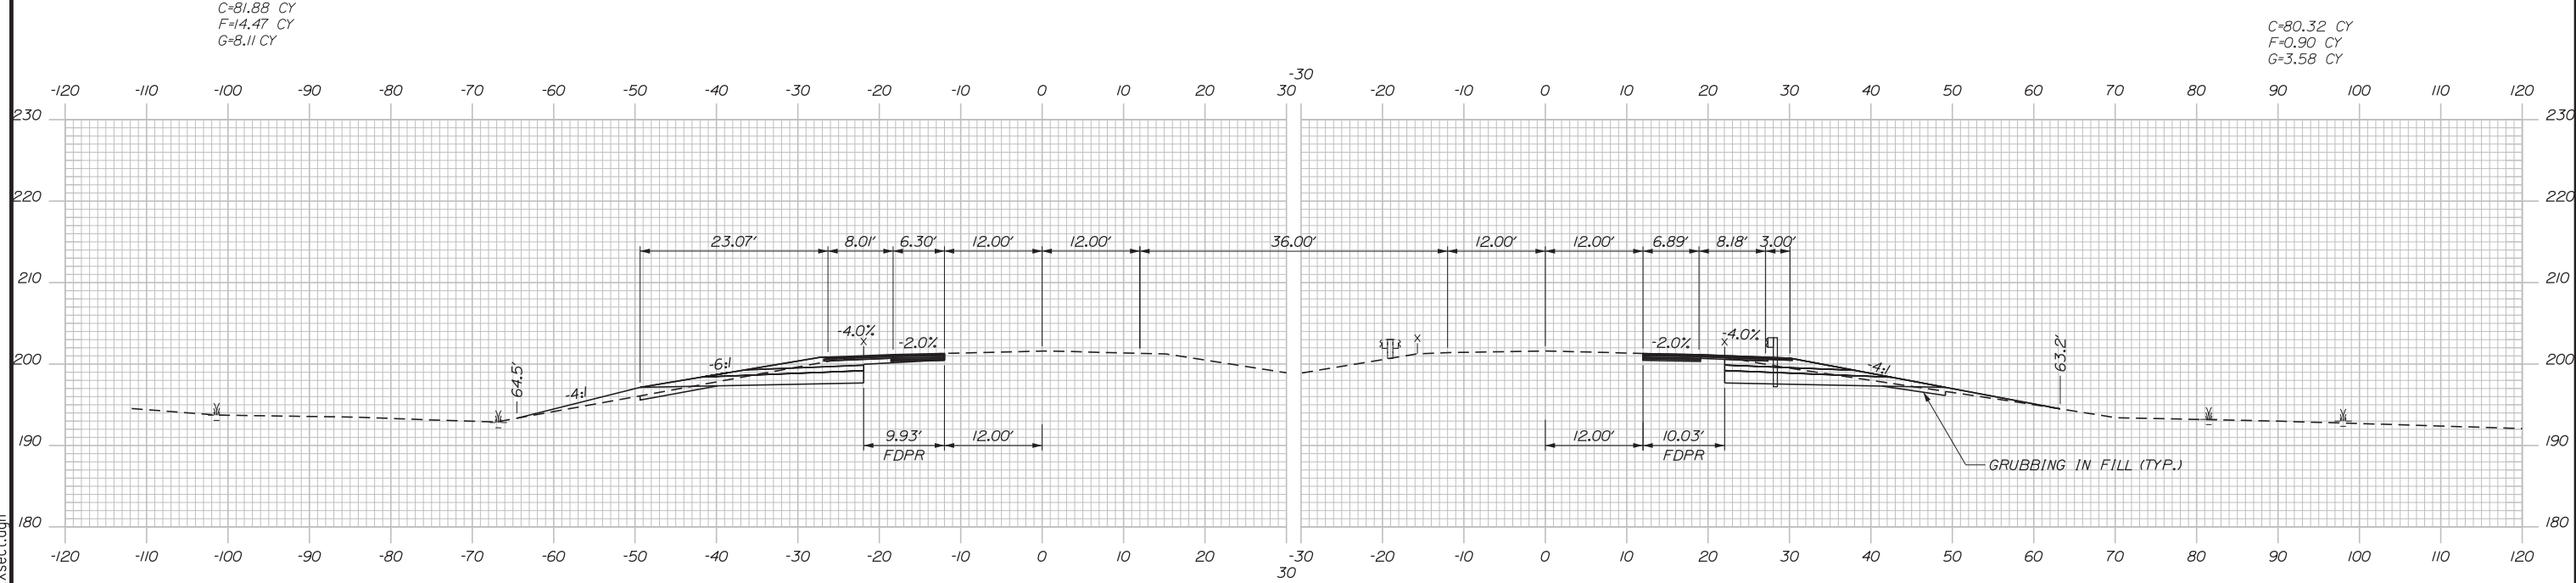

4476+00.00

 7476+00.00



Designed by:

**Stantec**

No.	Revision	By	Date

CONSULTANT PROJECT MANAGER: LAUREN MEEK, PE

	By	Date		By	Date
Designed	PLP	3\20\19	Checked	LEM	3\20\19
Drawn	EJB	3\20\19	In Charge of	GAE	3\20\19

STANTEC CONSULTING SERVICES INC.  
 482 PAYNE ROAD  
 SCARBOROUGH, ME 04074  
 TEL (207) 887-3448  
 FAX (207) 883-3376

**MAINE TURNPIKE**

**THE GOLD STAR MEMORIAL HIGHWAY**




MTA PROJECT MANAGER: RALPH NORWOOD, IV, PE, PTOE

INTERCHANGE 103  
 ORT CONVERSION  
 NB/SB ORT  
 STA. 4476+00/7476+00 TO STA. 4476+50/7476+50

SHEET NUMBER: XS-21  
 CONTRACT: 2019.04  
 255 OF 503

Filename: ...00\HIGHWAY\MSTA\\_xsect.dgn

 Date: 3/20/2019

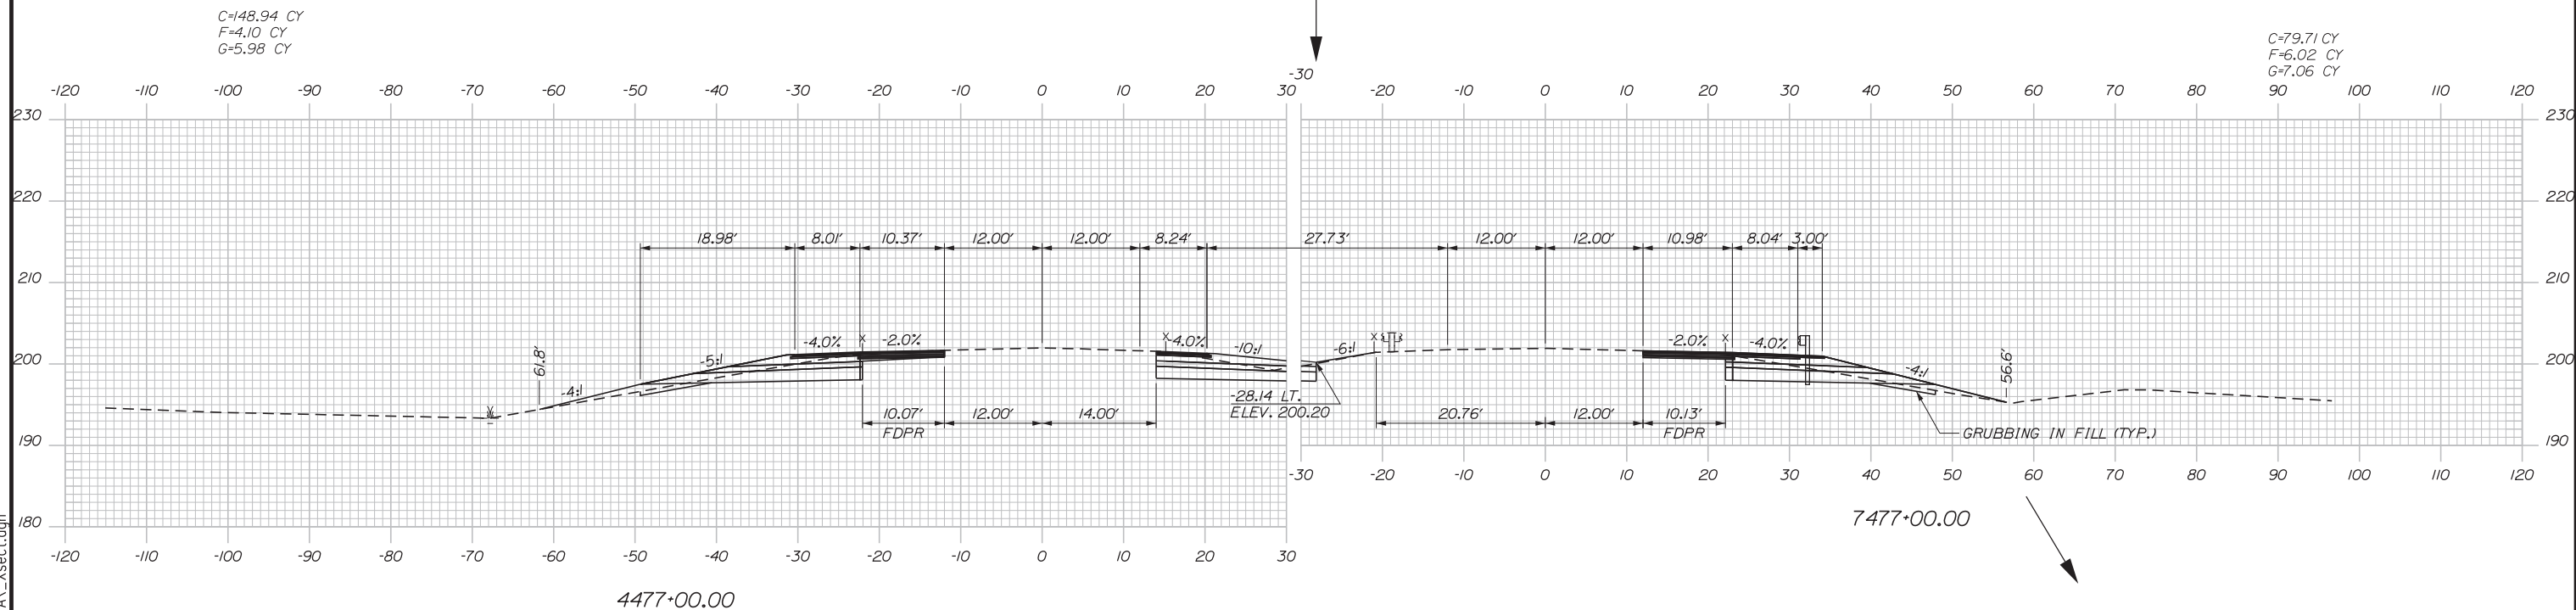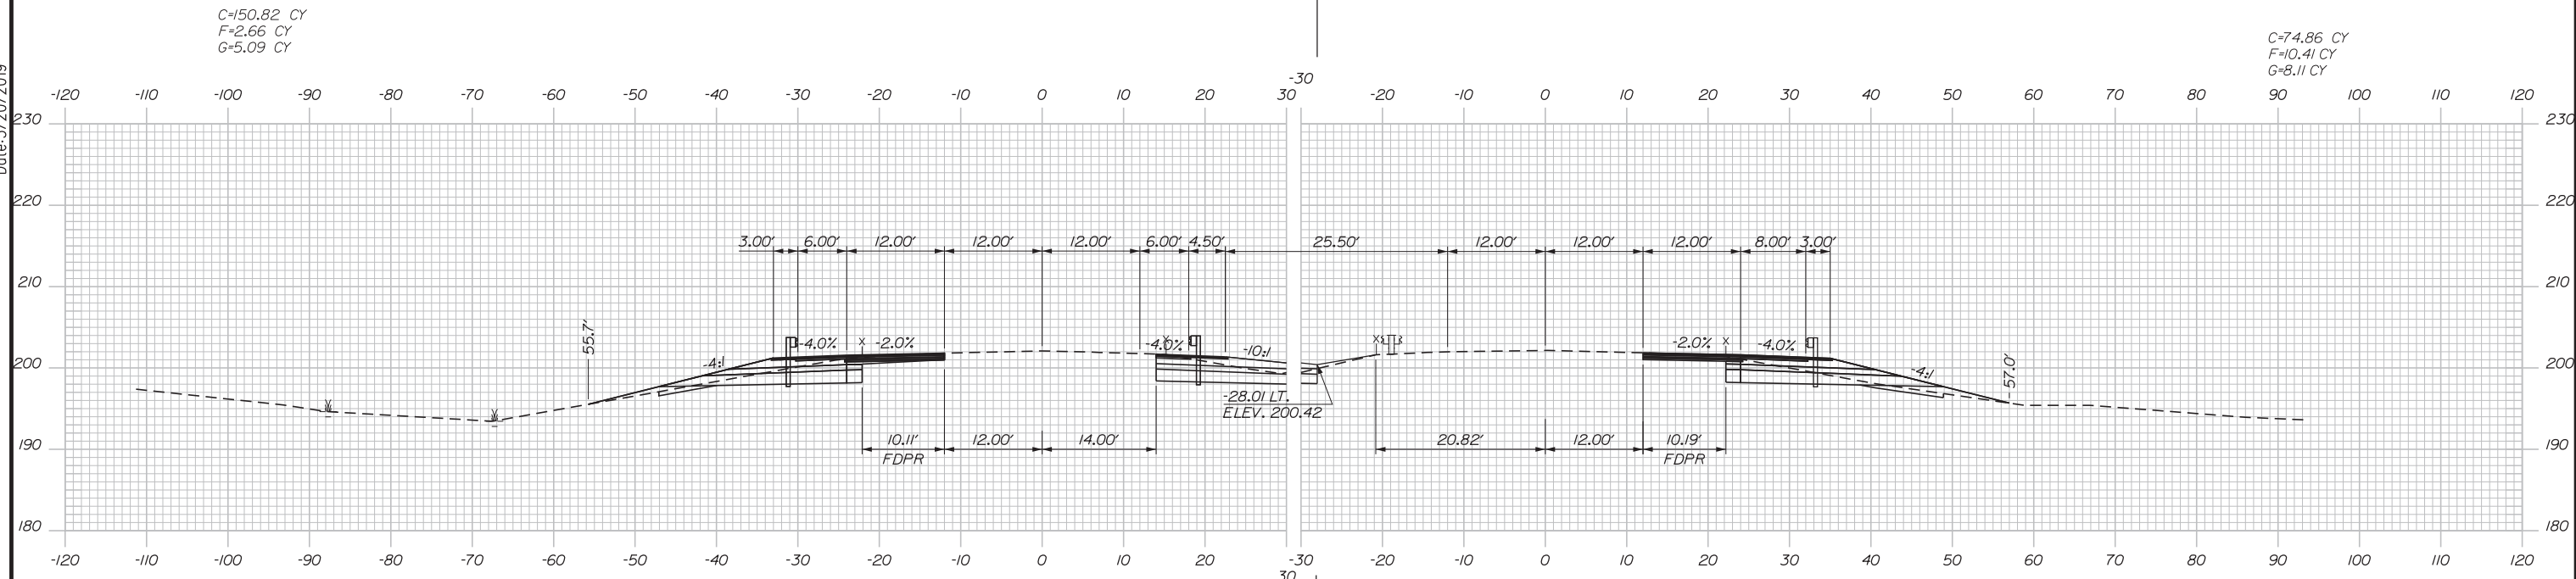

Designed by:

**Stantec**

CONSULTANT PROJECT MANAGER: LAUREN MEEK, PE					
	By	Date	By	Date	
Designed	PLP	3\20\19	Checked	LEM	3\20\19
Drawn	EJB	3\20\19	In Charge of	GAE	3\20\19

STANTEC CONSULTING SERVICES INC.  
 482 PAYNE ROAD  
 SCARBOROUGH, ME 04074  
 TEL (207) 887-3448  
 FAX (207) 883-3376

**MAINE TURNPIKE**

**THE GOLD STAR MEMORIAL HIGHWAY**



MTA PROJECT MANAGER: RALPH NORWOOD, IV, PE, PTOE

INTERCHANGE 103  
 ORT CONVERSION  
 NB/SB ORT  
 STA. 4477+00/7477+00 TO STA. 4477+50/7477+50

SHEET NUMBER: XS-22  
 CONTRACT: 2019.04  
 256 OF 503

Filename: ...00\HIGHWAY\MSTA\\_xsect.dgn

Date: 3/20/2019

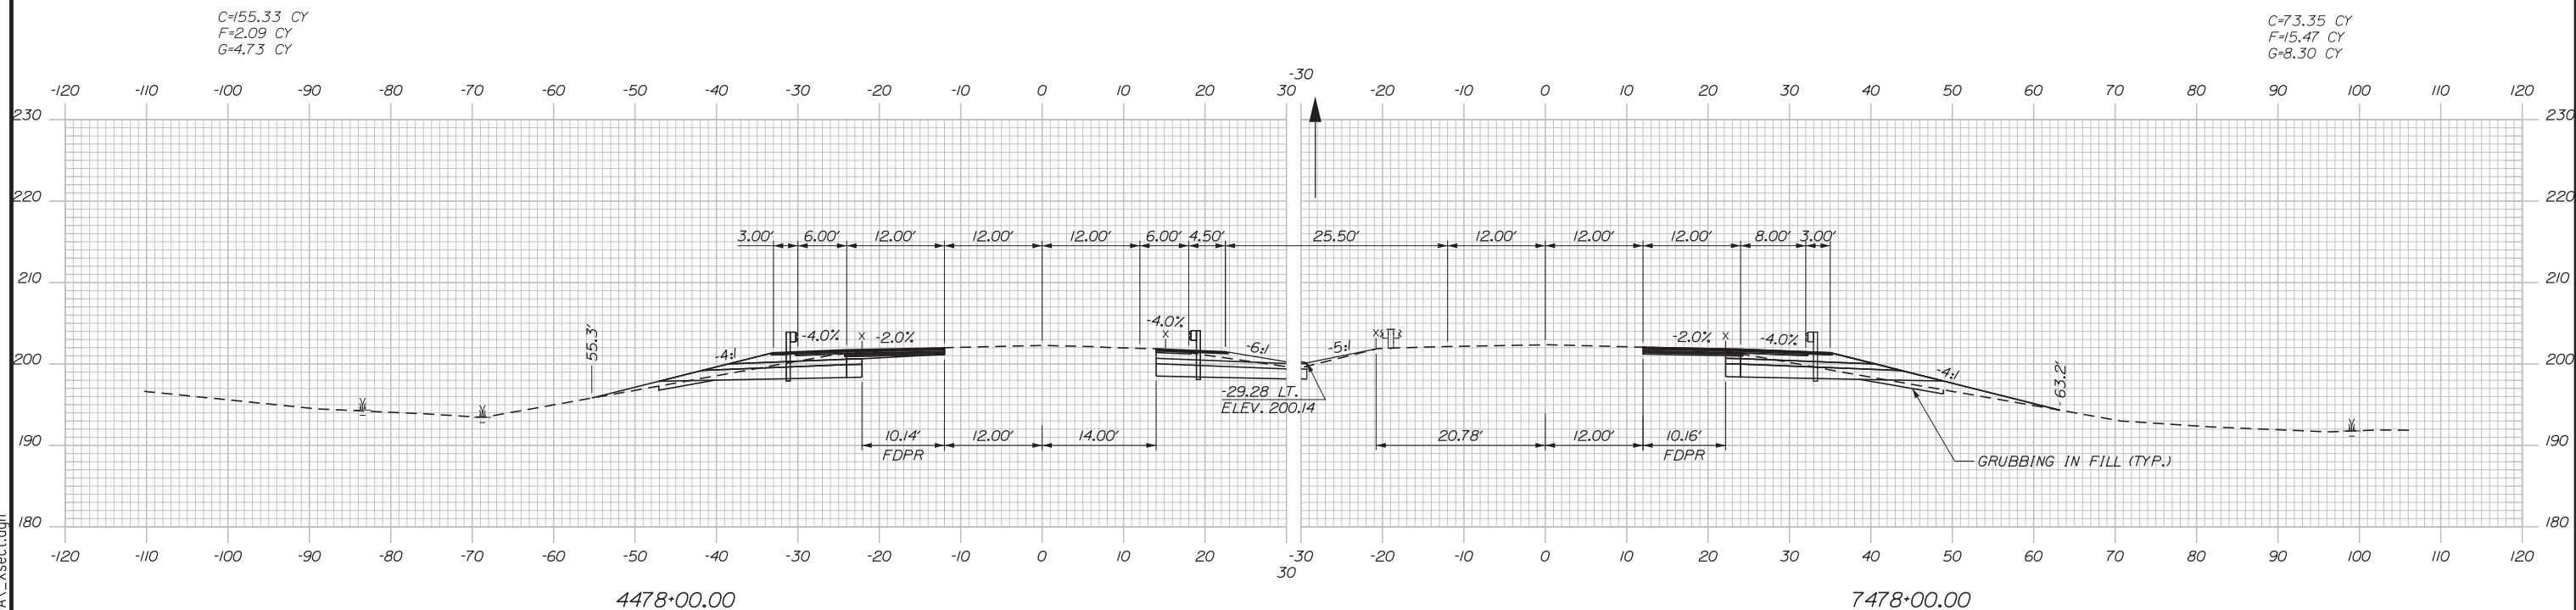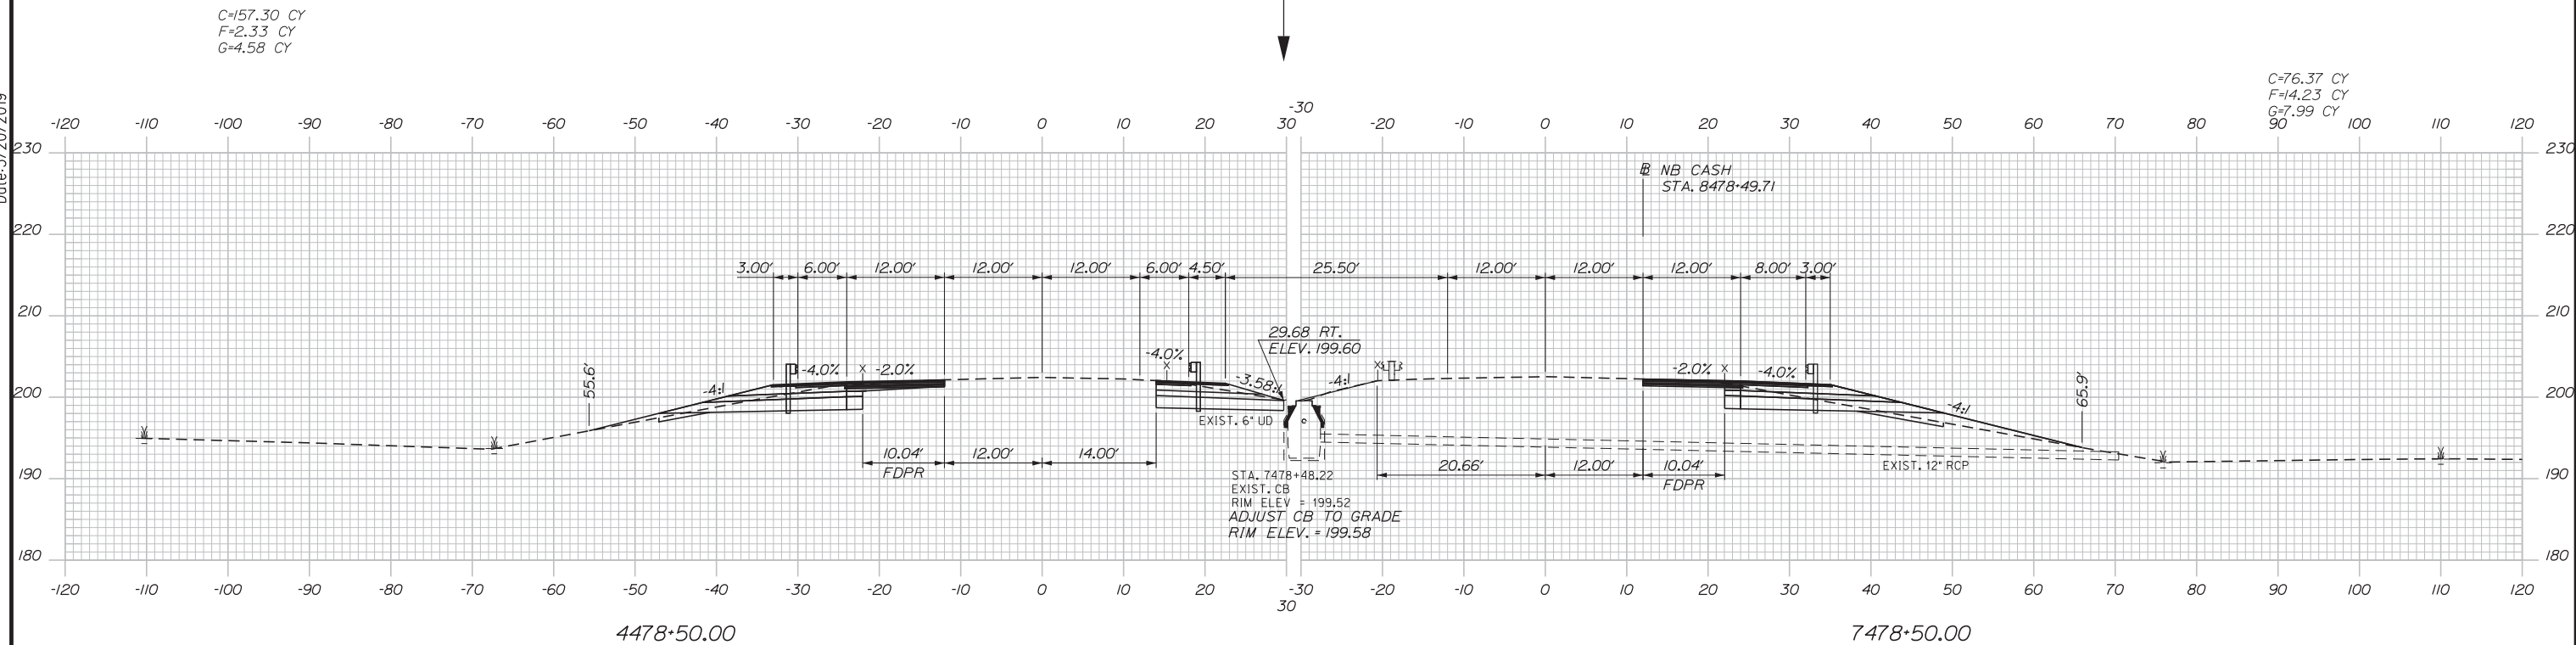

Designed by:

**Stantec**

CONSULTANT PROJECT MANAGER: LAUREN MEEK, PE

No.	Revision	By	Date

	By	Date		By	Date
Designed	PLP	3\20\19	Checked	LEM	3\20\19
Drawn	EJB	3\20\19	In Charge of	GAE	3\20\19

STANTEC CONSULTING SERVICES INC.  
 482 PAYNE ROAD  
 SCARBOROUGH, ME 04074  
 TEL (207) 887-3448  
 FAX (207) 883-3376

**MAINE TURNPIKE**

**THE GOLD STAR MEMORIAL HIGHWAY**

MTA PROJECT MANAGER: RALPH NORWOOD, IV, PE, PTOE

INTERCHANGE 103  
 ORT CONVERSION  
 NB/SB ORT  
 STA. 4478+00/7478+00 TO STA. 4478+50/7478+50

 


SHEET NUMBER: XS-23  
 257 OF 503

CONTRACT: 2019.04

Filename: ...000.HIGHWAY\MSTA\\_xsect.dgn



Date: 3/20/2019

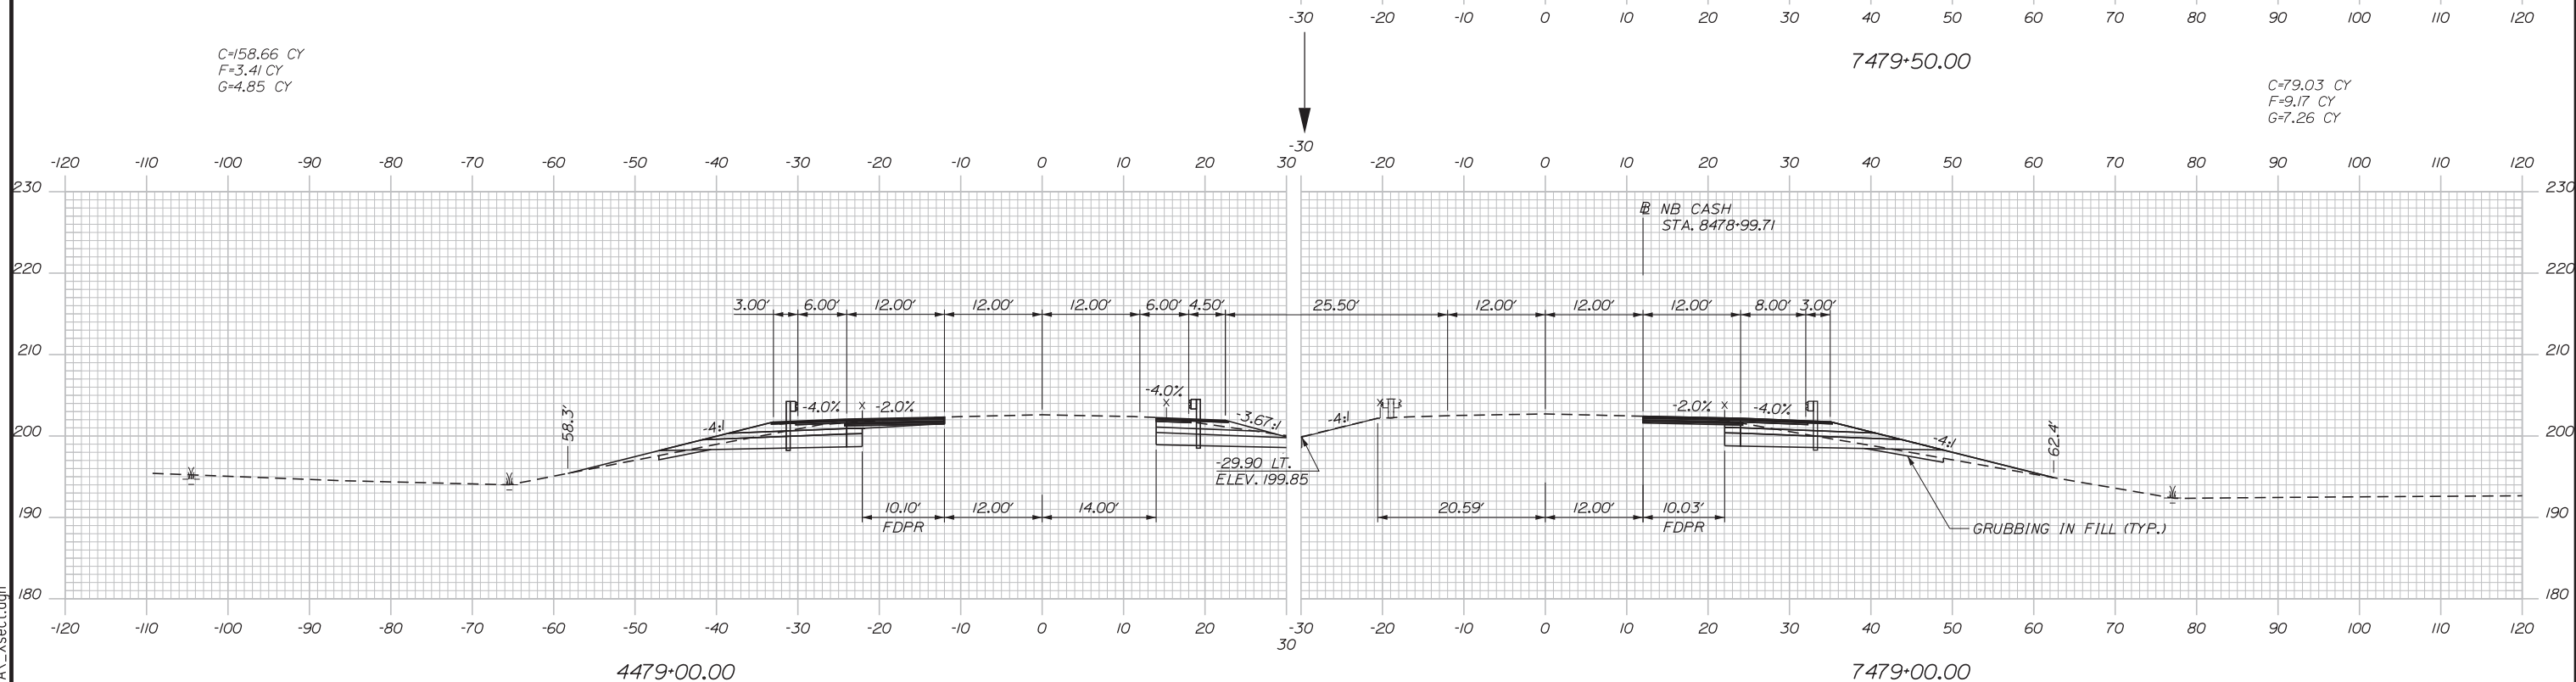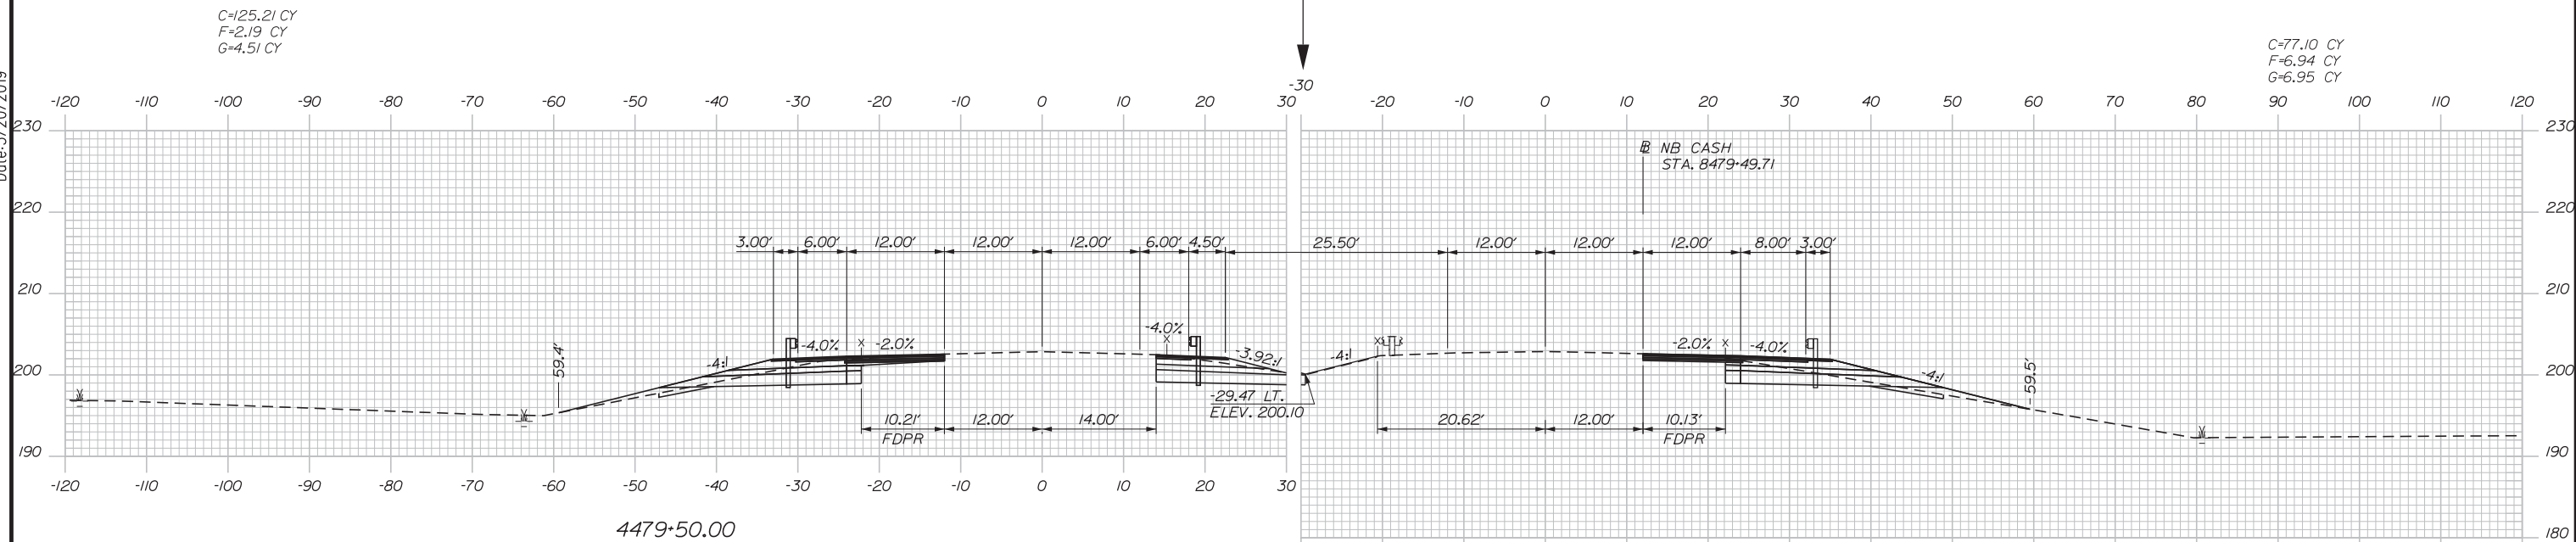

Designed by:


**Stantec**

No.	Revision	By	Date

CONSULTANT PROJECT MANAGER: LAUREN MEEK, PE

	By	Date		By	Date
Designed	PLP	3\20\19	Checked	LEM	3\20\19
Drawn	EJB	3\20\19	In Charge of	GAE	3\20\19

STANTEC CONSULTING SERVICES INC.  
482 PAYNE ROAD  
SCARBOROUGH, ME 04074  
TEL (207) 887-3448  
FAX (207) 883-3376

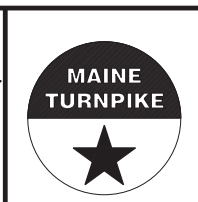

**THE GOLD STAR  
MEMORIAL HIGHWAY**

INTERCHANGE 103  
ORT CONVERSION  
NB/SB ORT  
STA. 4479+00/7479+00 TO STA. 4479+50/7479+50

 




Filename: ...00\HIGHWAY\MSTA\\_xsect.dgn

MTA PROJECT MANAGER: RALPH NORWOOD, IV, PE, PTOE



Date: 3/20/2019

File: ...00\HIGHWAY\MSTA\...xsect.dgn

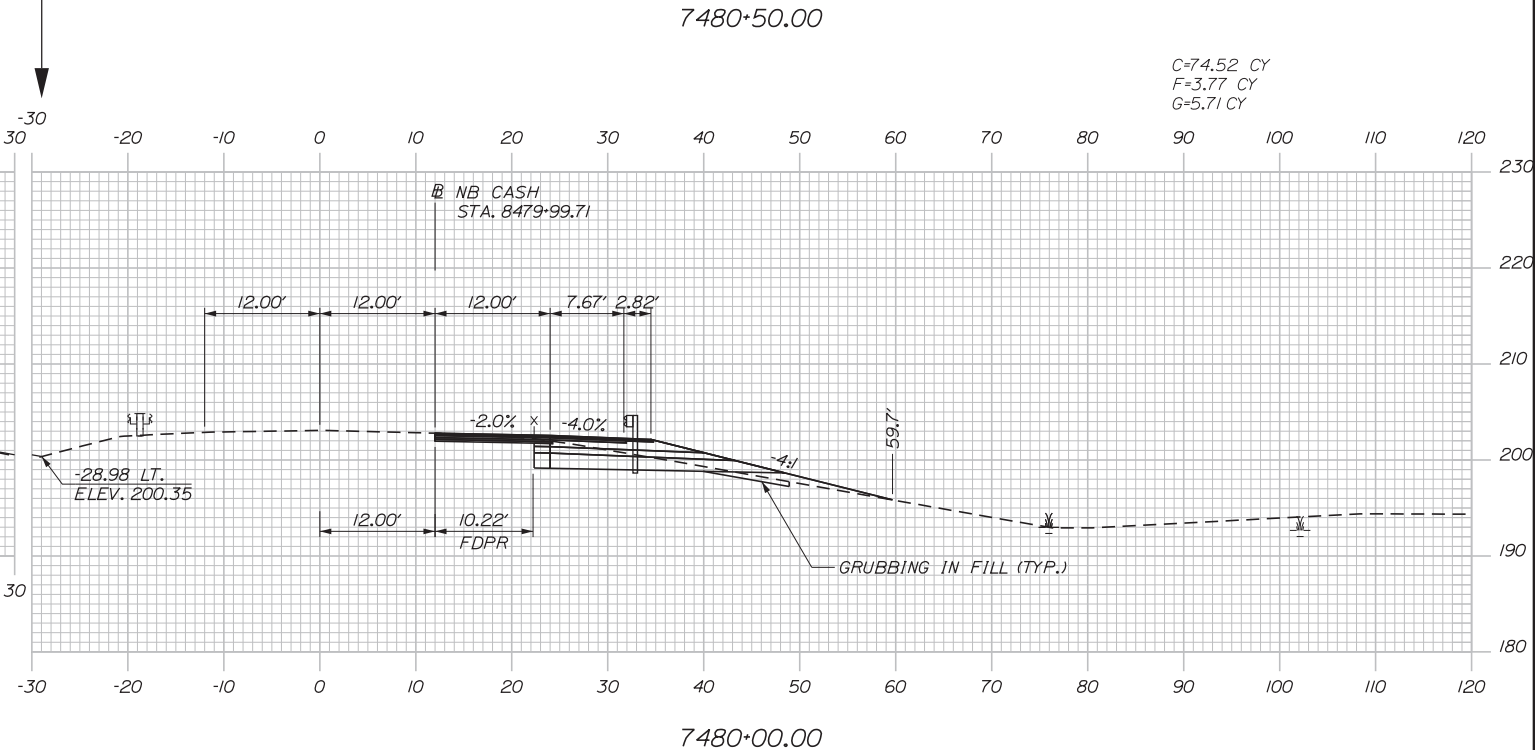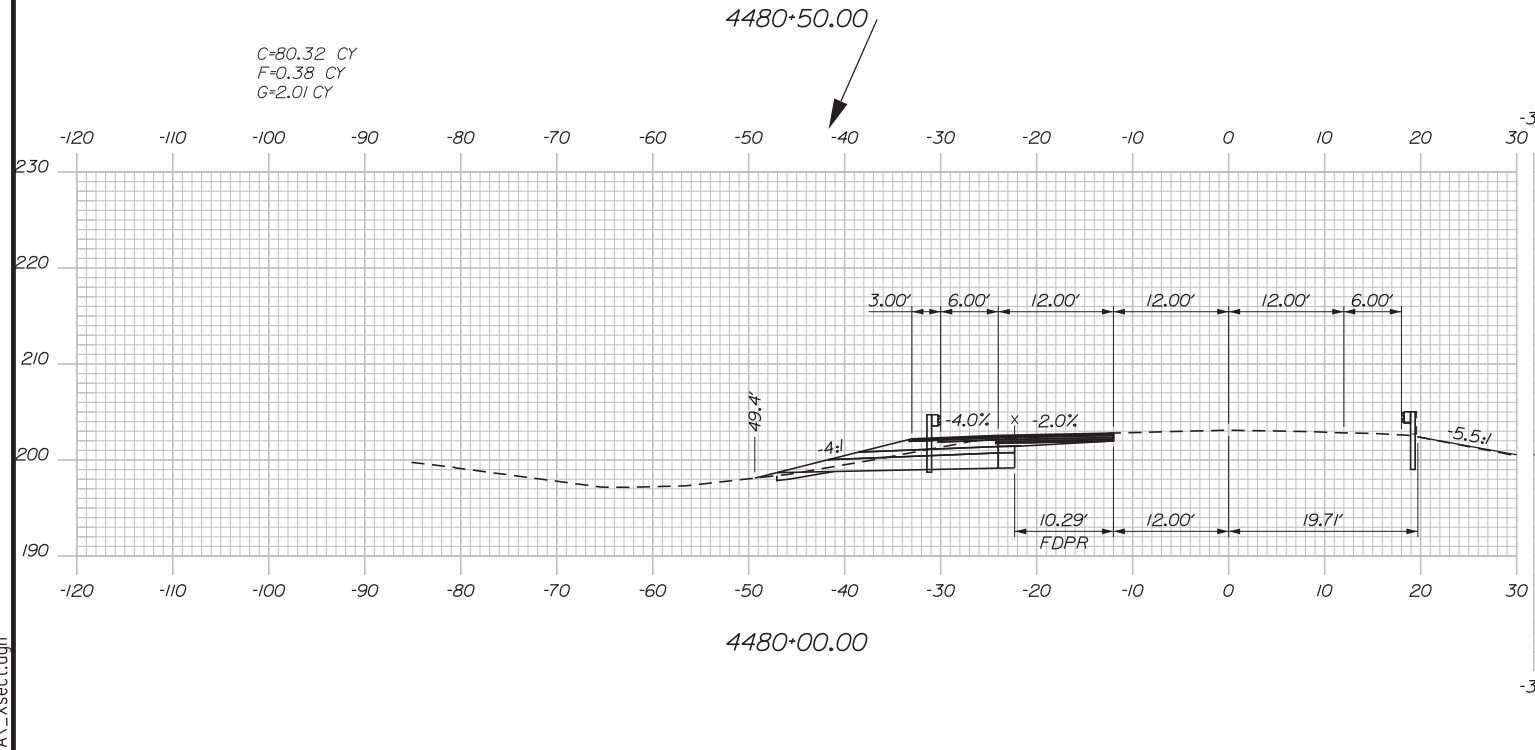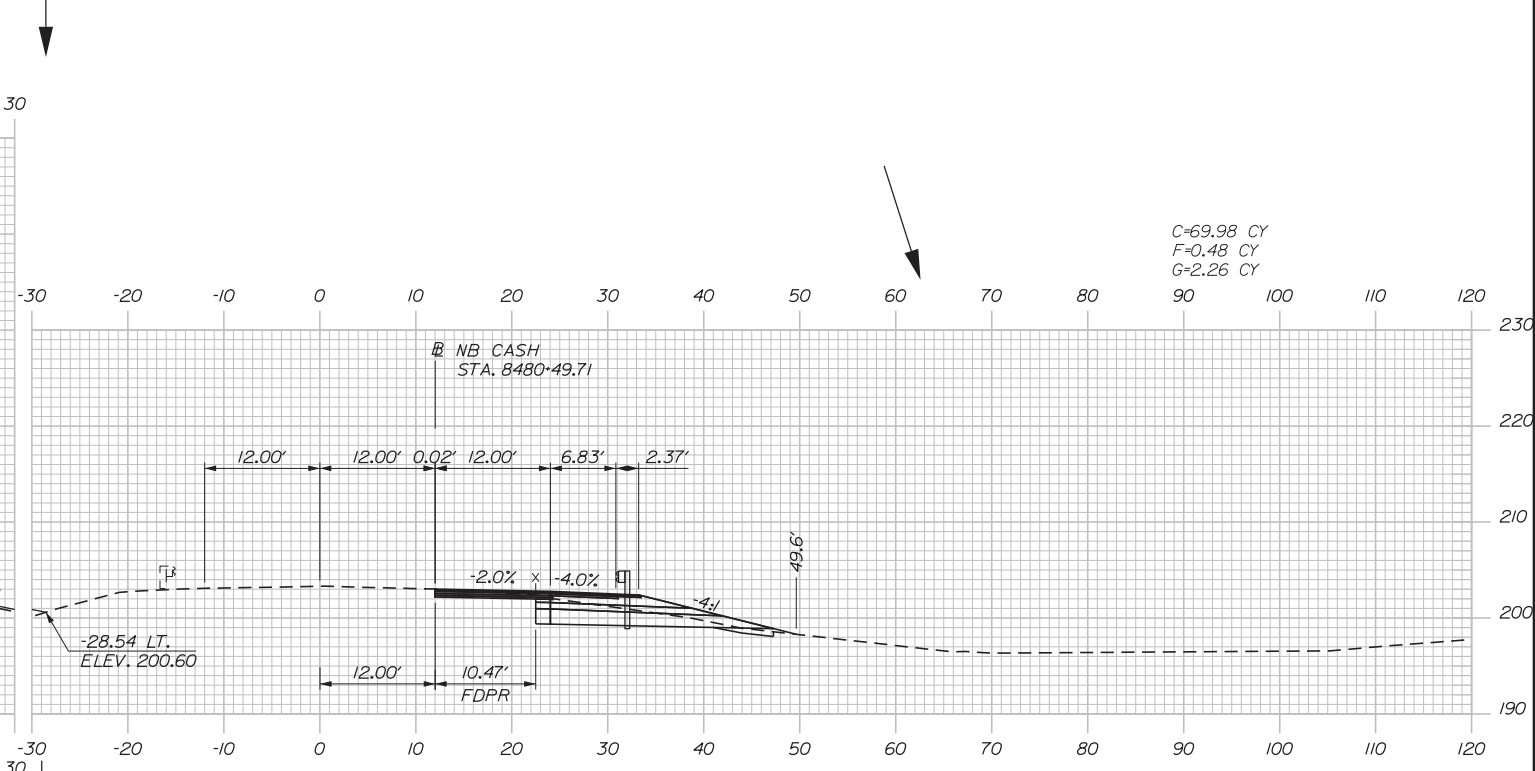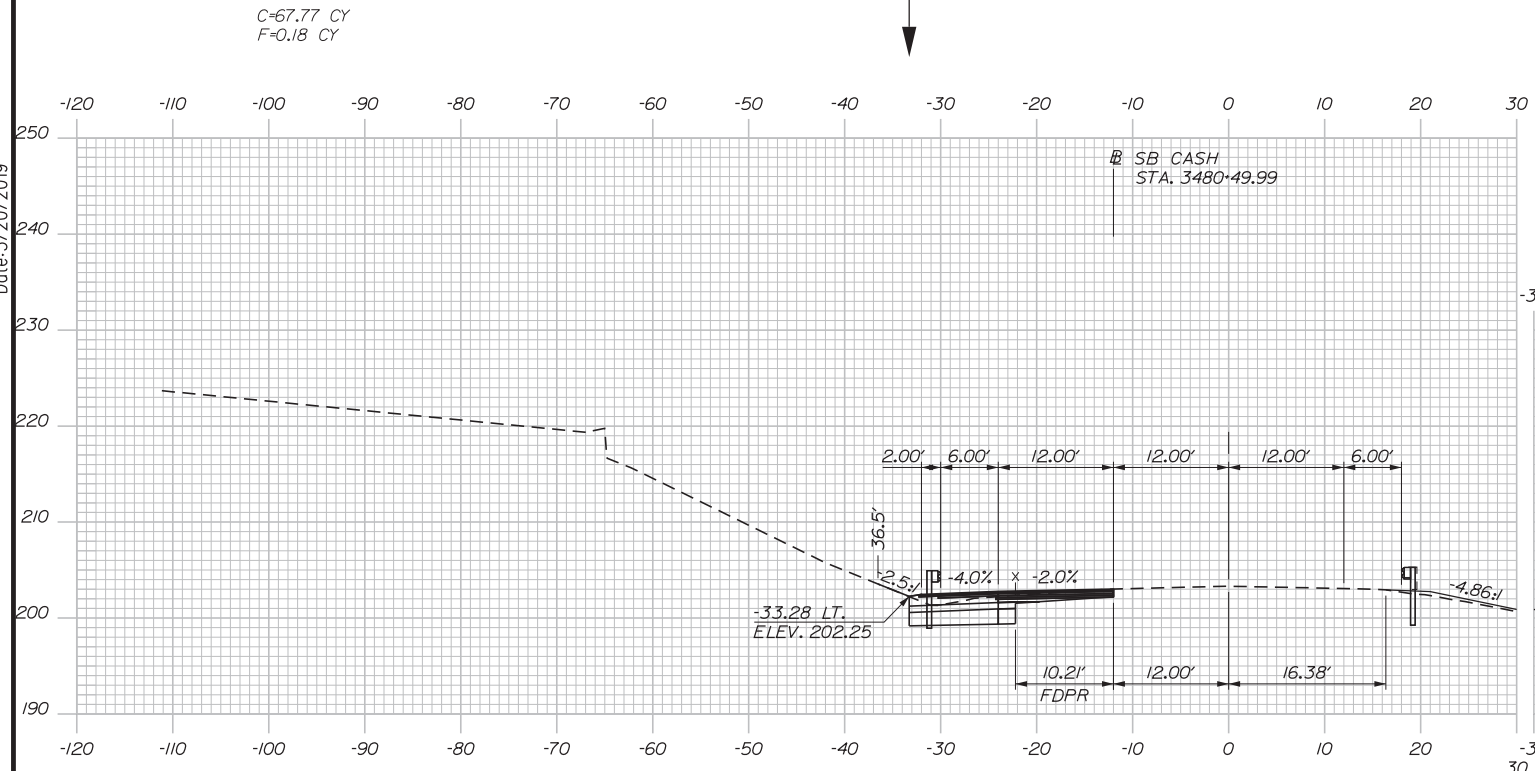

Designed by: **Stantec**

No.	Revision	By	Date

CONSULTANT PROJECT MANAGER: LAUREN MEEK, PE			
Designed	By	Date	Checked
	PLP	3\20\19	LEM
Drawn	By	Date	In Charge of
	EJB	3\20\19	GAE

STANTEC CONSULTING SERVICES INC.  
 482 PAYNE ROAD  
 SCARBOROUGH, ME 04074  
 TEL (207) 887-3448  
 FAX (207) 883-3376

**THE GOLD STAR MEMORIAL HIGHWAY**




MTA PROJECT MANAGER: RALPH NORWOOD, IV, PE, PTOE

INTERCHANGE 103  
 ORT CONVERSION  
 NB/SB ORT  
 STA. 4480+00/7480+00 TO STA. 4480+50/7480+50

SHEET NUMBER: XS-25  
 259 OF 503

CONTRACT: 2019.04

 Date: 3/20/2019

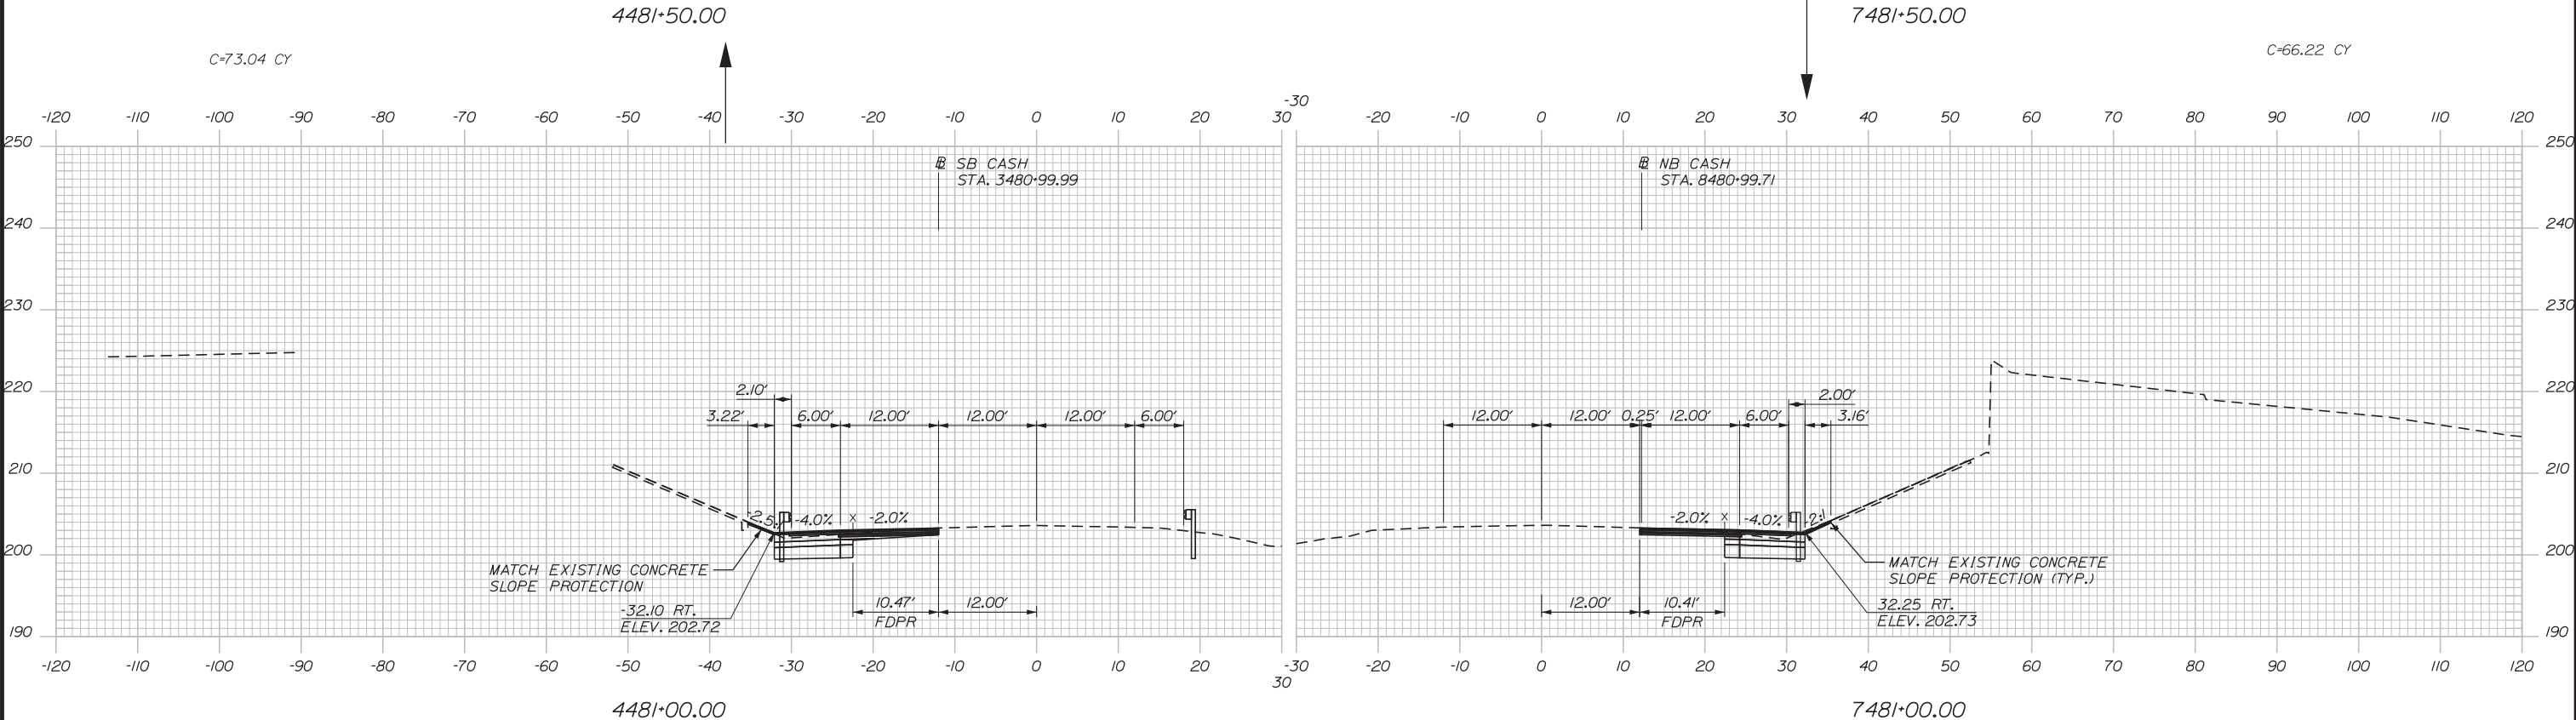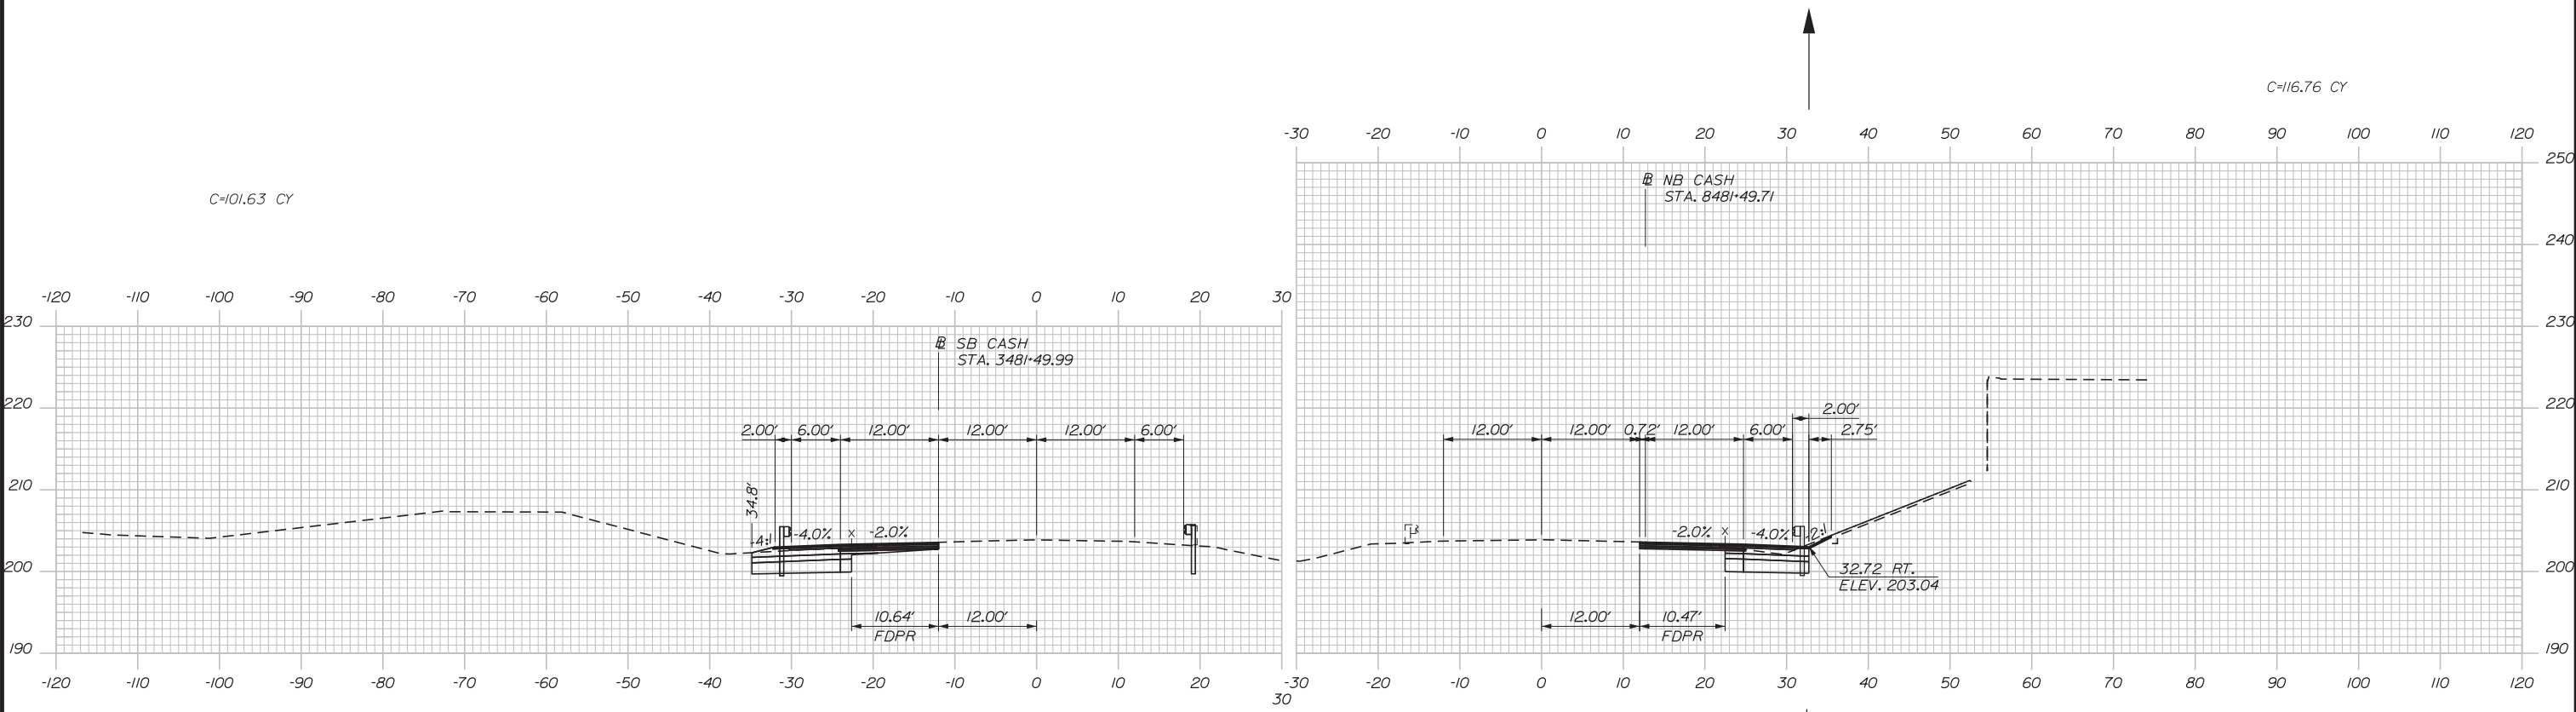

Designed by:


**Stantec**

CONSULTANT PROJECT MANAGER: LAUREN MEEK, PE

No.	Revision	By	Date

	By	Date		By	Date
Designed	PLP	3\20\19	Checked	LEM	3\20\19
Drawn	EJB	3\20\19	In Charge of	GAE	3\20\19

STANTEC CONSULTING SERVICES INC.  
 482 PAYNE ROAD  
 SCARBOROUGH, ME 04074  
 TEL (207) 887-3448  
 FAX (207) 883-3376




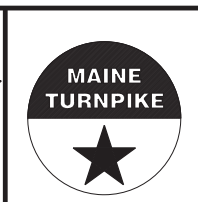


**THE GOLD STAR  
 MEMORIAL HIGHWAY**

INTERCHANGE 103  
 ORT CONVERSION  
 NB/SB ORT  
 STA. 4481+00/7481+00 TO STA. 4481+50/7481+50

Filename: ...00\HIGHWAY\MSTA\\_xsect.dgn

 Date: 3/20/2019

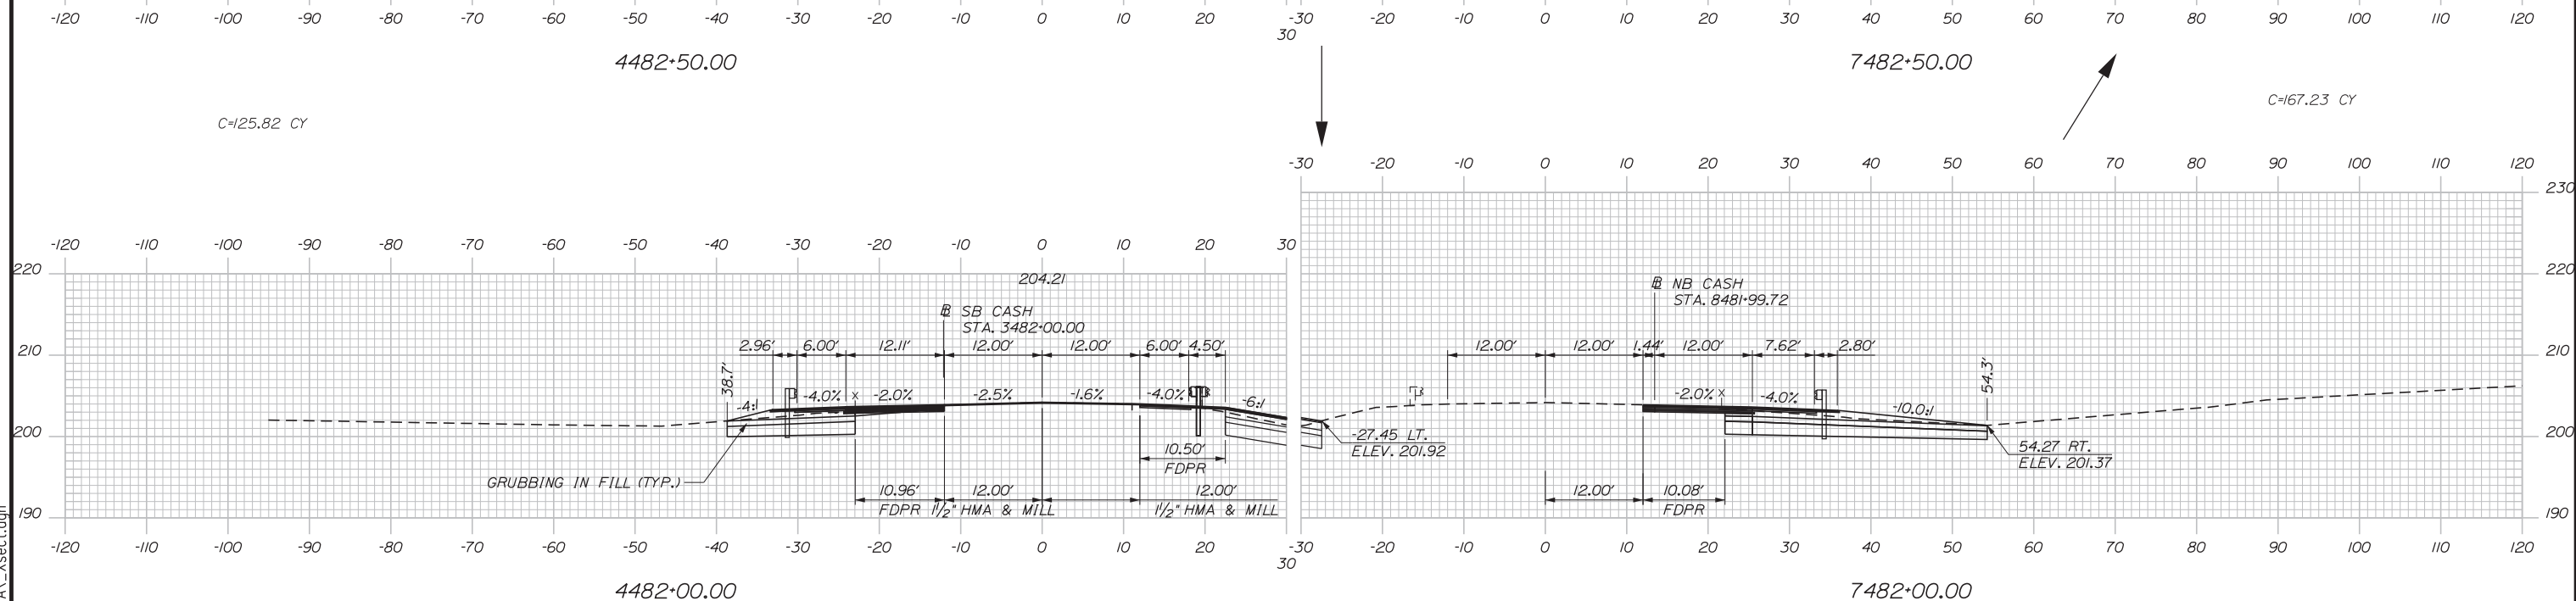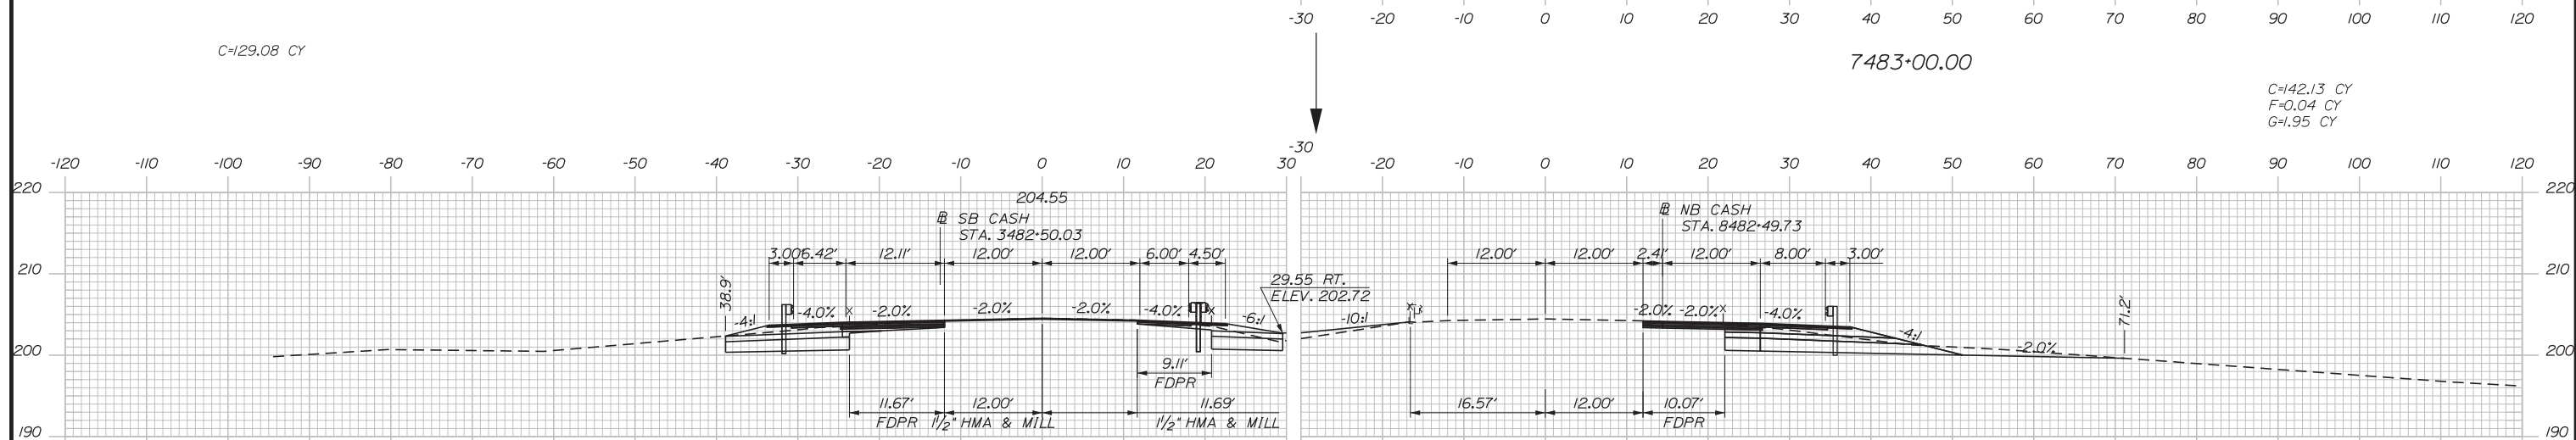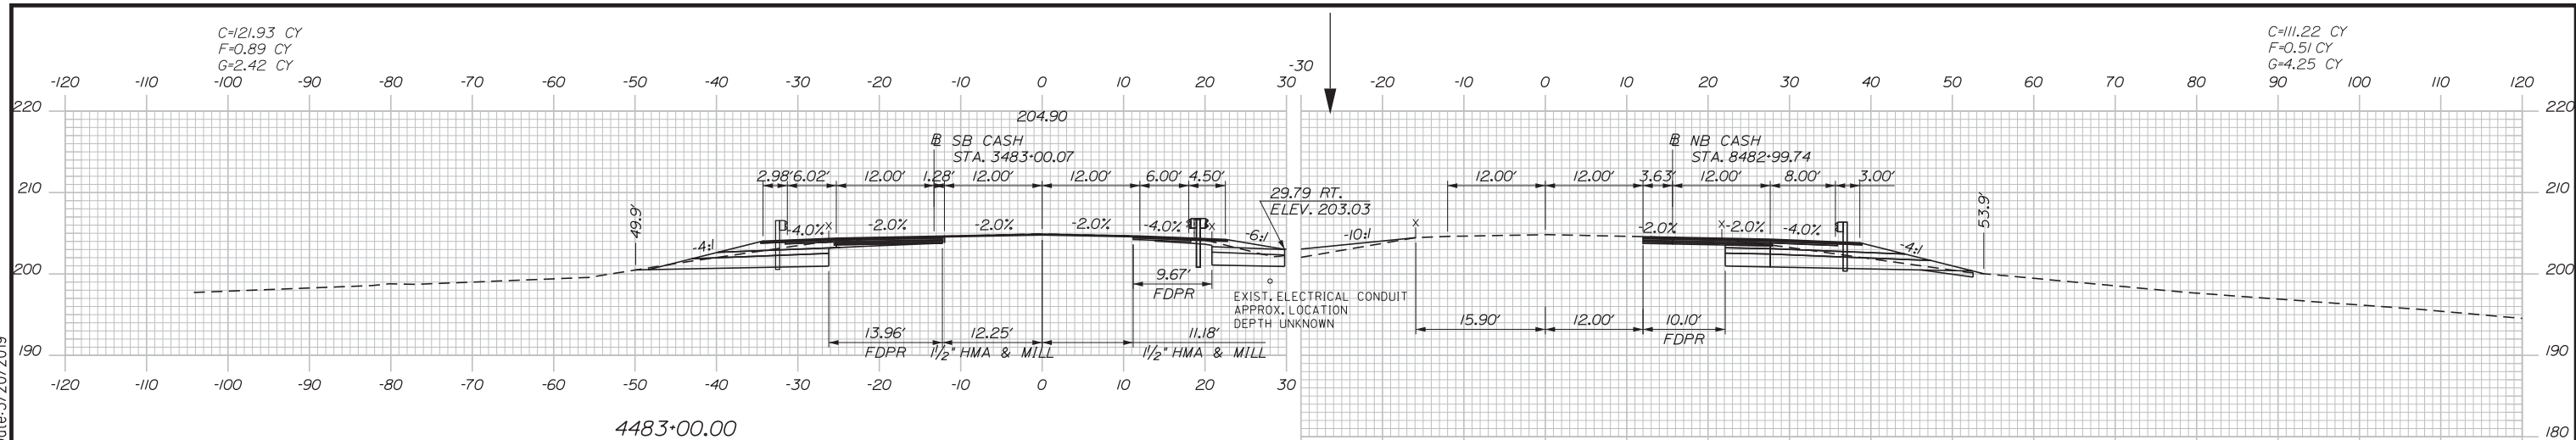

Designed by:


**Stantec**

No.	Revision	By	Date

CONSULTANT PROJECT MANAGER: LAUREN MEEK, PE

	By	Date		By	Date
Designed	PLP	3\20\19	Checked	LEM	3\20\19
Drawn	EJB	3\20\19	In Charge of	GAE	3\20\19

STANTEC CONSULTING SERVICES INC.  
 482 PAYNE ROAD  
 SCARBOROUGH, ME 04074  
 TEL (207) 887-3448  
 FAX (207) 883-3376

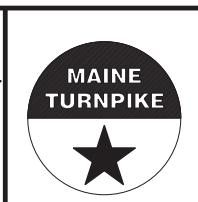


**THE GOLD STAR  
 MEMORIAL HIGHWAY**


INTERCHANGE 103  
 ORT CONVERSION  
 NB/SB ORT  
 STA. 4482+00/7482+00 TO STA. 4483+00/7483+00

Filename: ...100\HIGHWAY\MSTA\\_xsect.dgn

Date: 3/20/2019

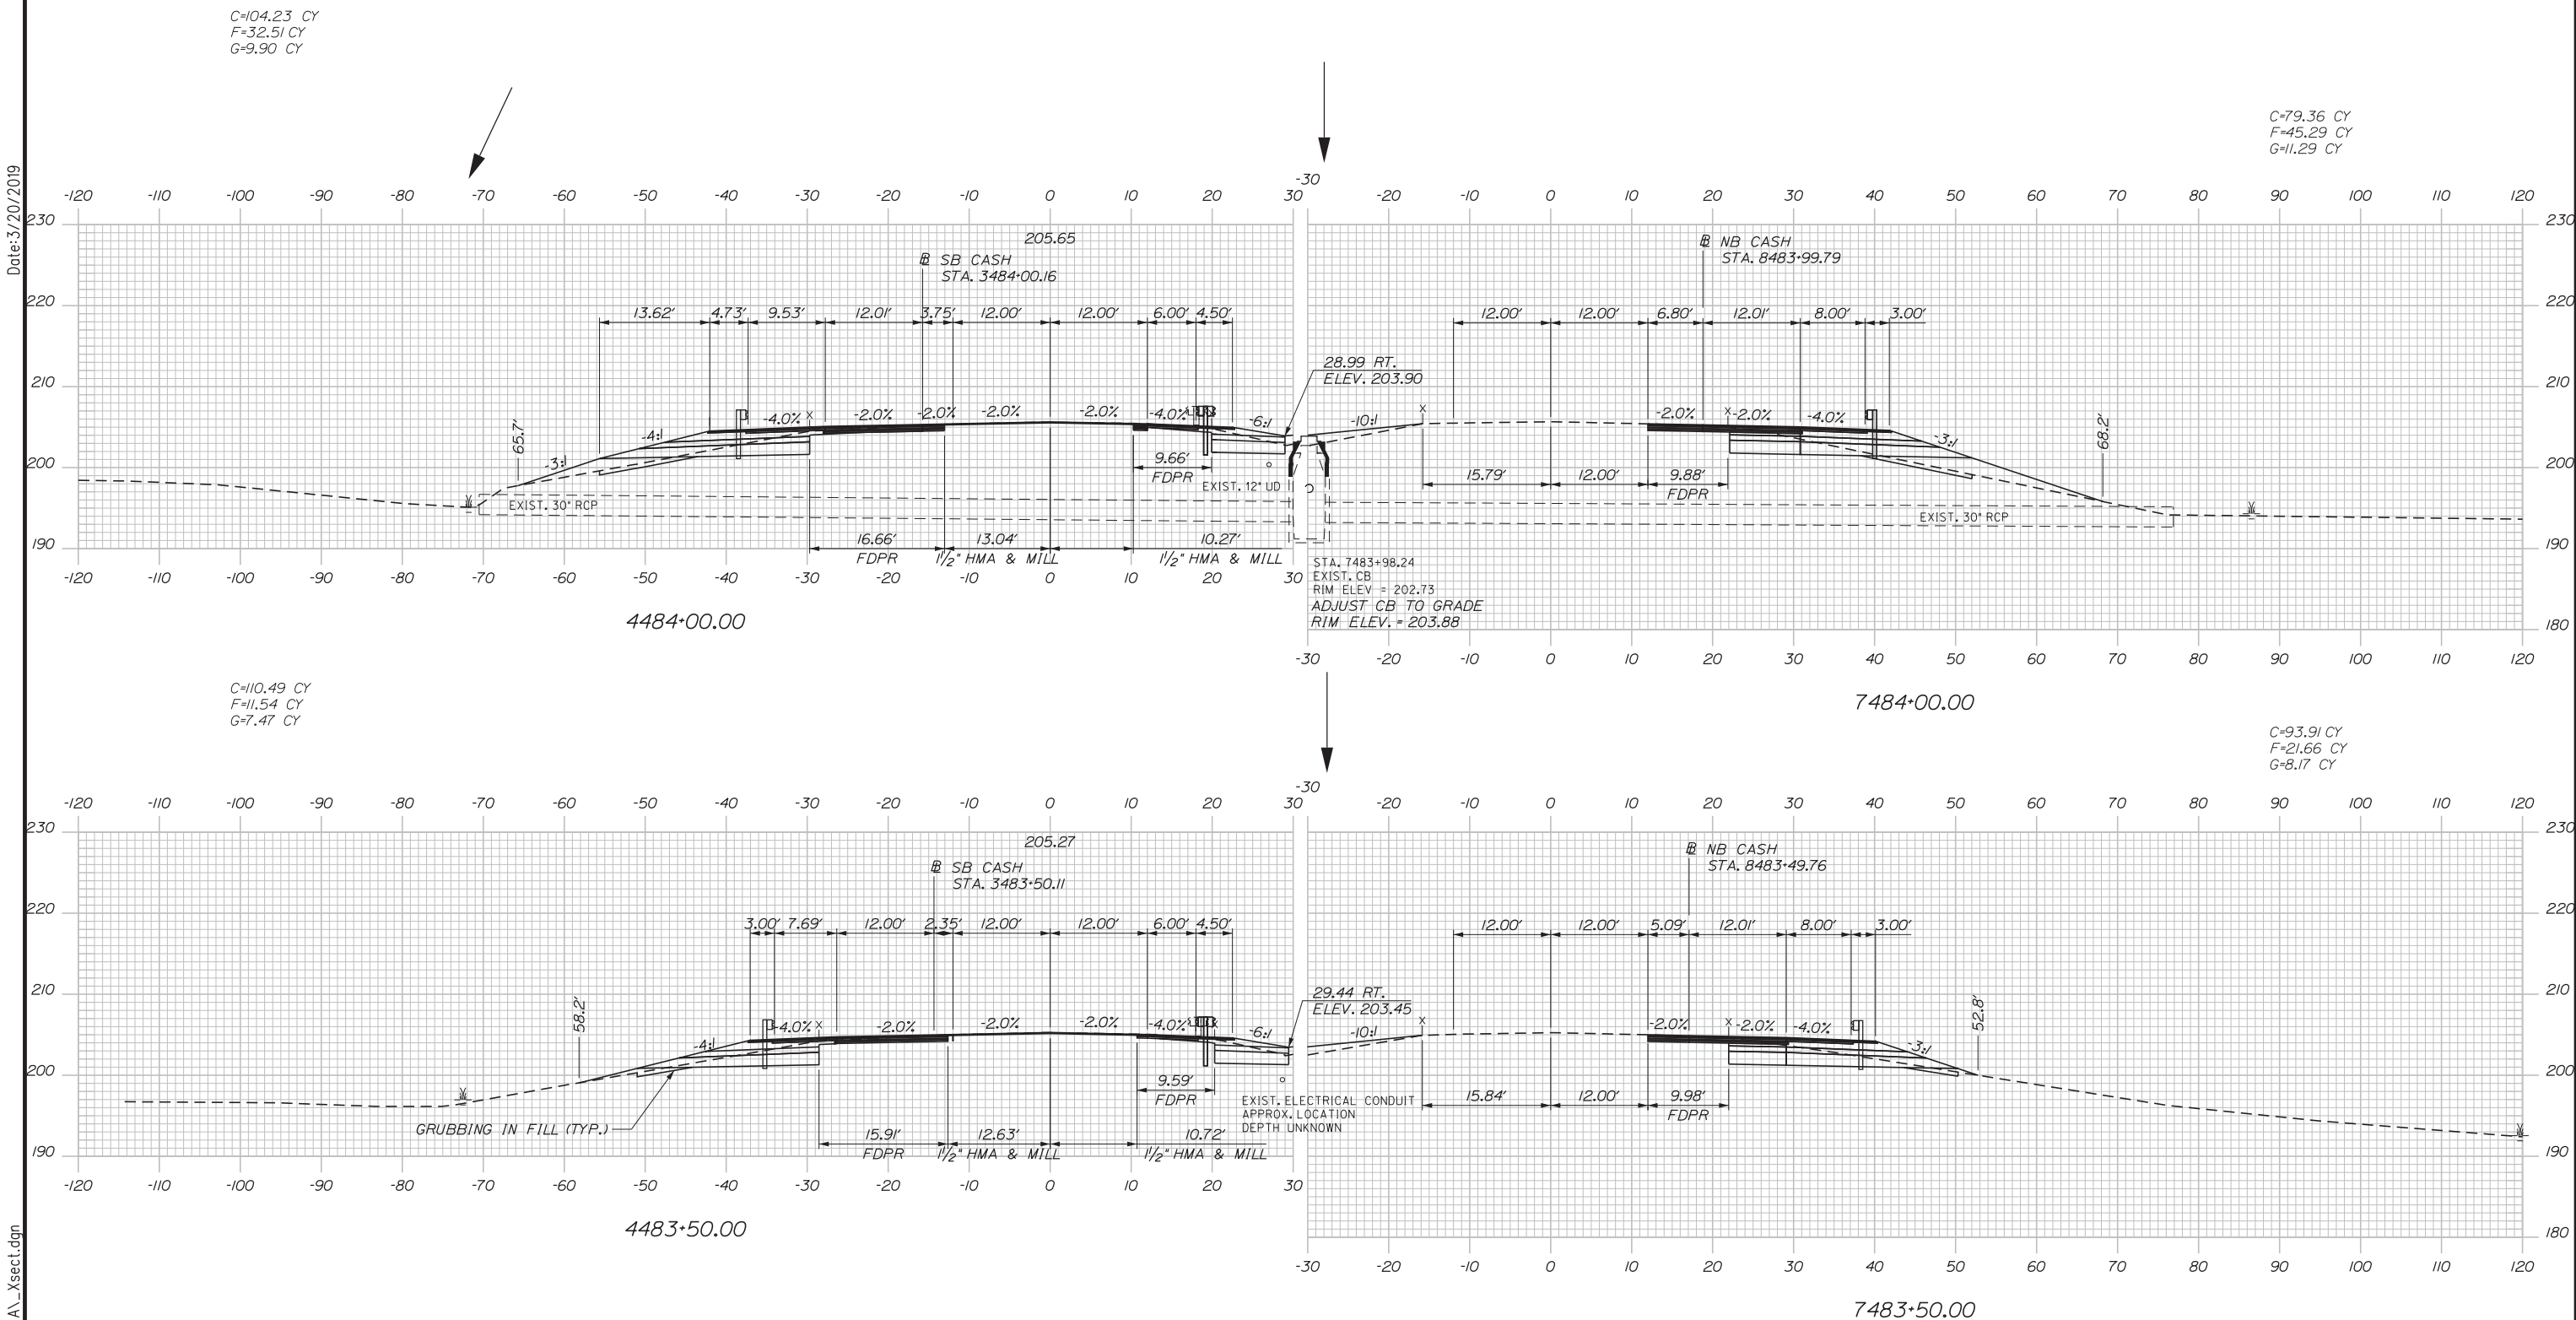

 Filename: ...00.HIGHWAY\MSTA\\_xsect.dgn



Designed by:


**Stantec**

No.	Revision	By	Date

CONSULTANT PROJECT MANAGER: LAUREN MEEK, PE

	By	Date		By	Date
Designed	PLP	3\20\19	Checked	LEM	3\20\19
Drawn	EJB	3\20\19	In Charge of	GAE	3\20\19

STANTEC CONSULTING SERVICES INC.  
482 PAYNE ROAD  
SCARBOROUGH, ME 04074  
TEL (207) 887-3448  
FAX (207) 883-3376


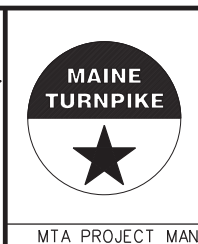


**THE GOLD STAR  
MEMORIAL HIGHWAY**

INTERCHANGE 103  
ORT CONVERSION  
NB/SB ORT  
STA. 4483+50/7483+50 TO STA. 4484+00/7484+00

SHEET NUMBER: XS-28  
CONTRACT: 2019.04  
262 OF 503

 Date: 3/20/2019

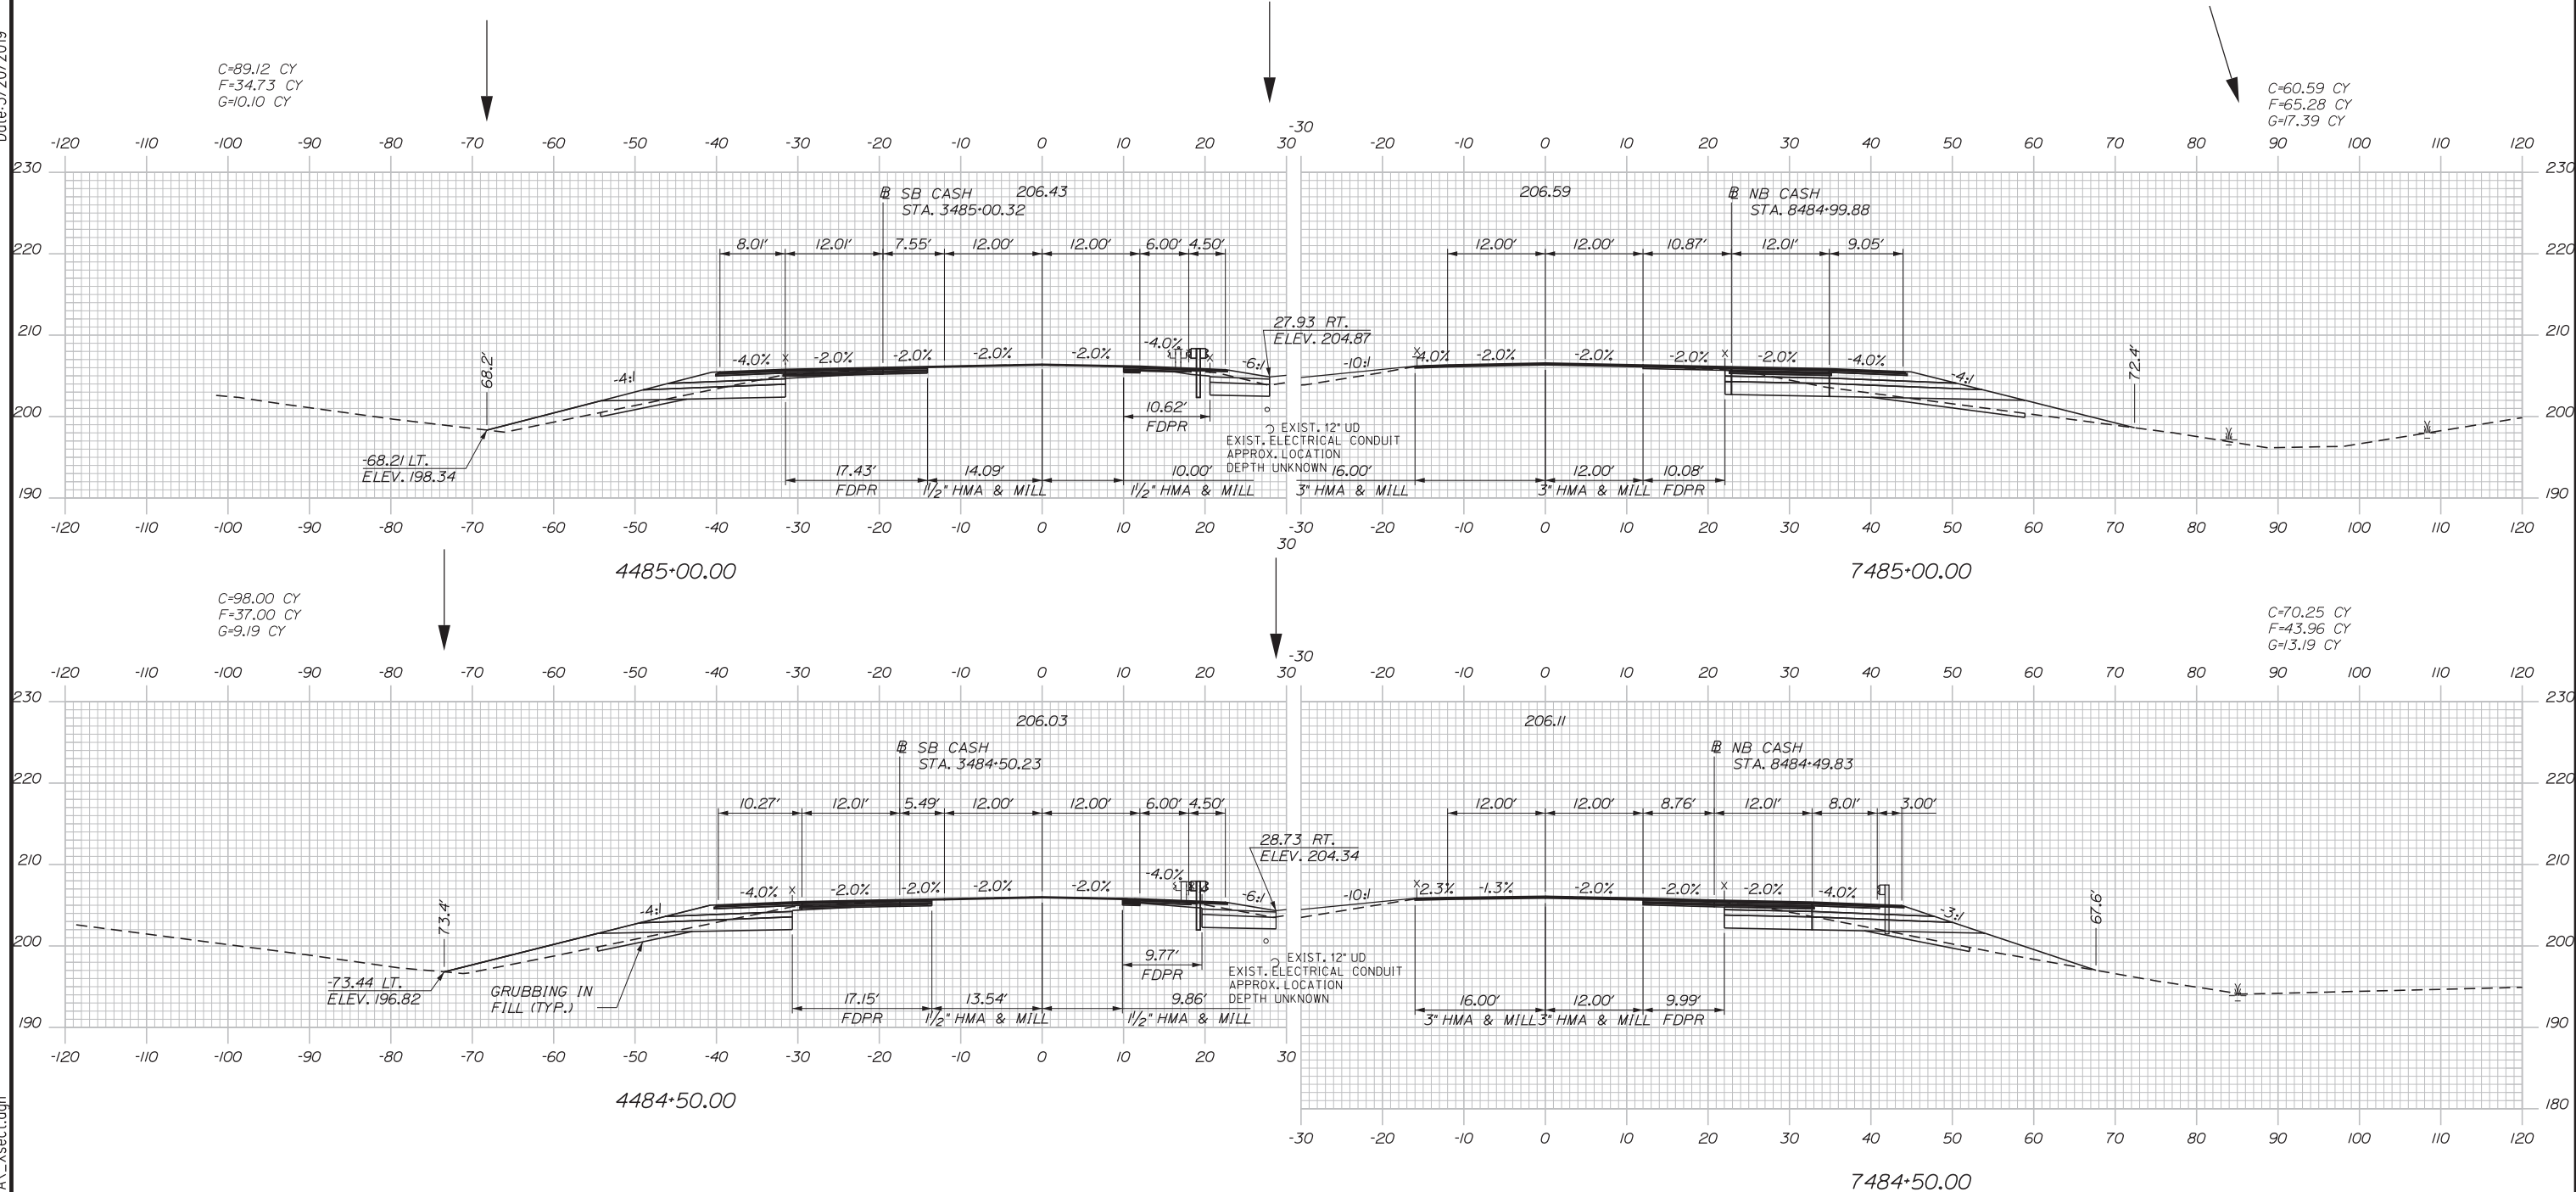

Designed by:


**Stantec**

No.	Revision	By	Date

CONSULTANT PROJECT MANAGER: LAUREN MEEK, PE

	By	Date		By	Date
Designed	PLP	3\20\19	Checked	LEM	3\20\19
Drawn	EJB	3\20\19	In Charge of	GAE	3\20\19

STANTEC CONSULTING SERVICES INC.  
482 PAYNE ROAD  
SCARBOROUGH, ME 04074  
TEL (207) 887-3448  
FAX (207) 883-3376

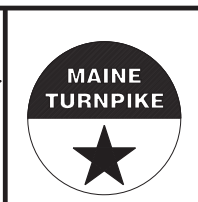




**THE GOLD STAR  
MEMORIAL HIGHWAY**

INTERCHANGE 103  
ORT CONVERSION  
NB/SB ORT  
STA. 4484+50/7484+50 TO STA. 4485+00/7485+00

Filename: ...00.HIGHWAY\MSTA\\_xsect.dgn



 Date: 3/20/2019

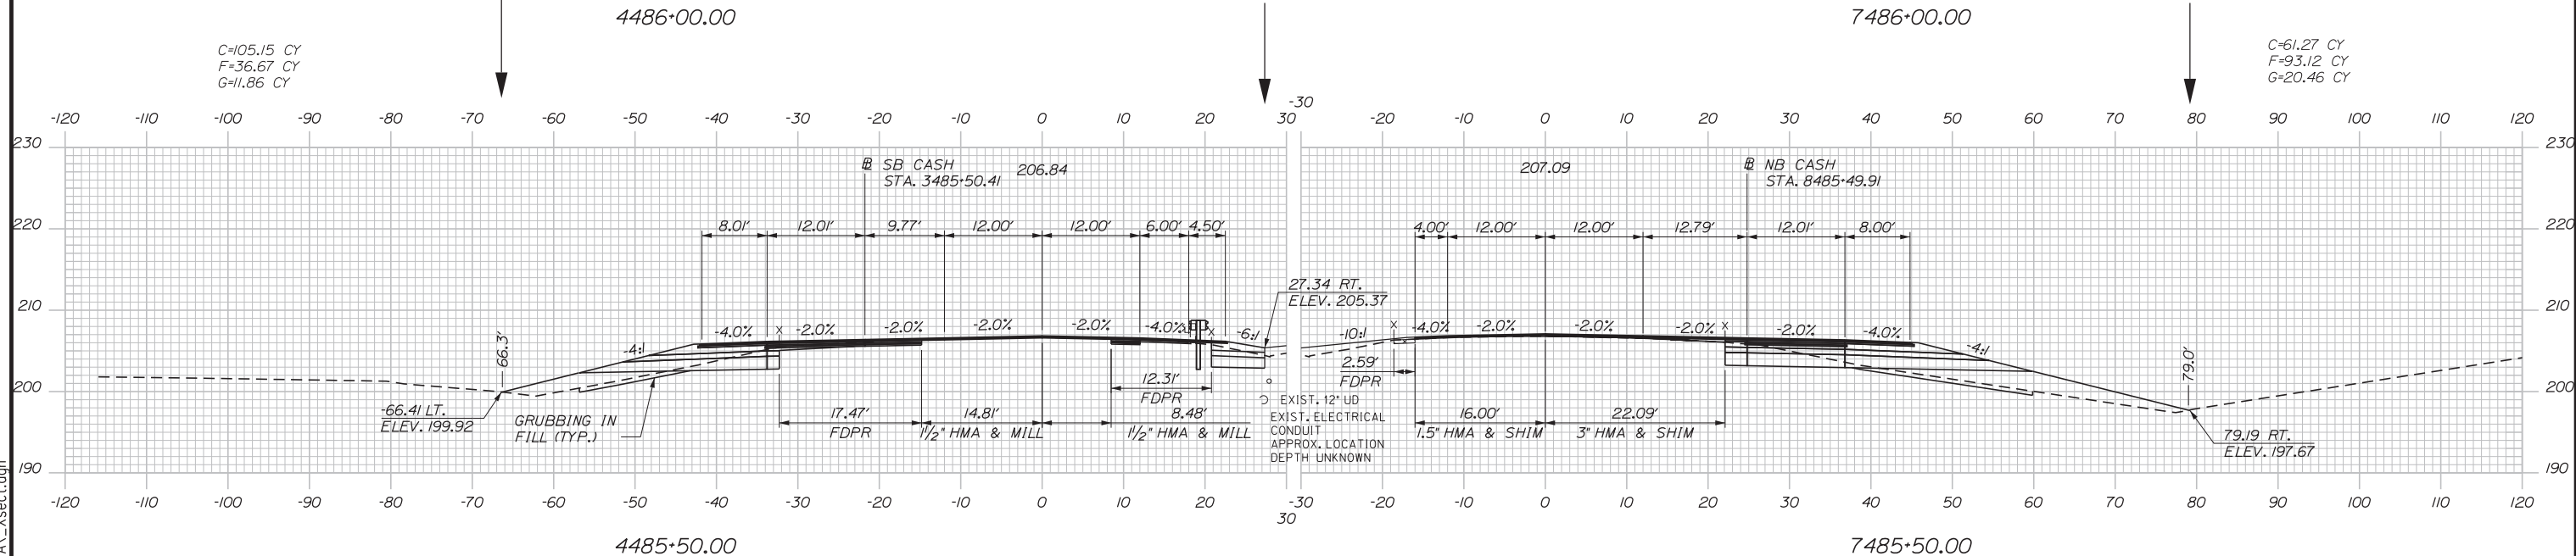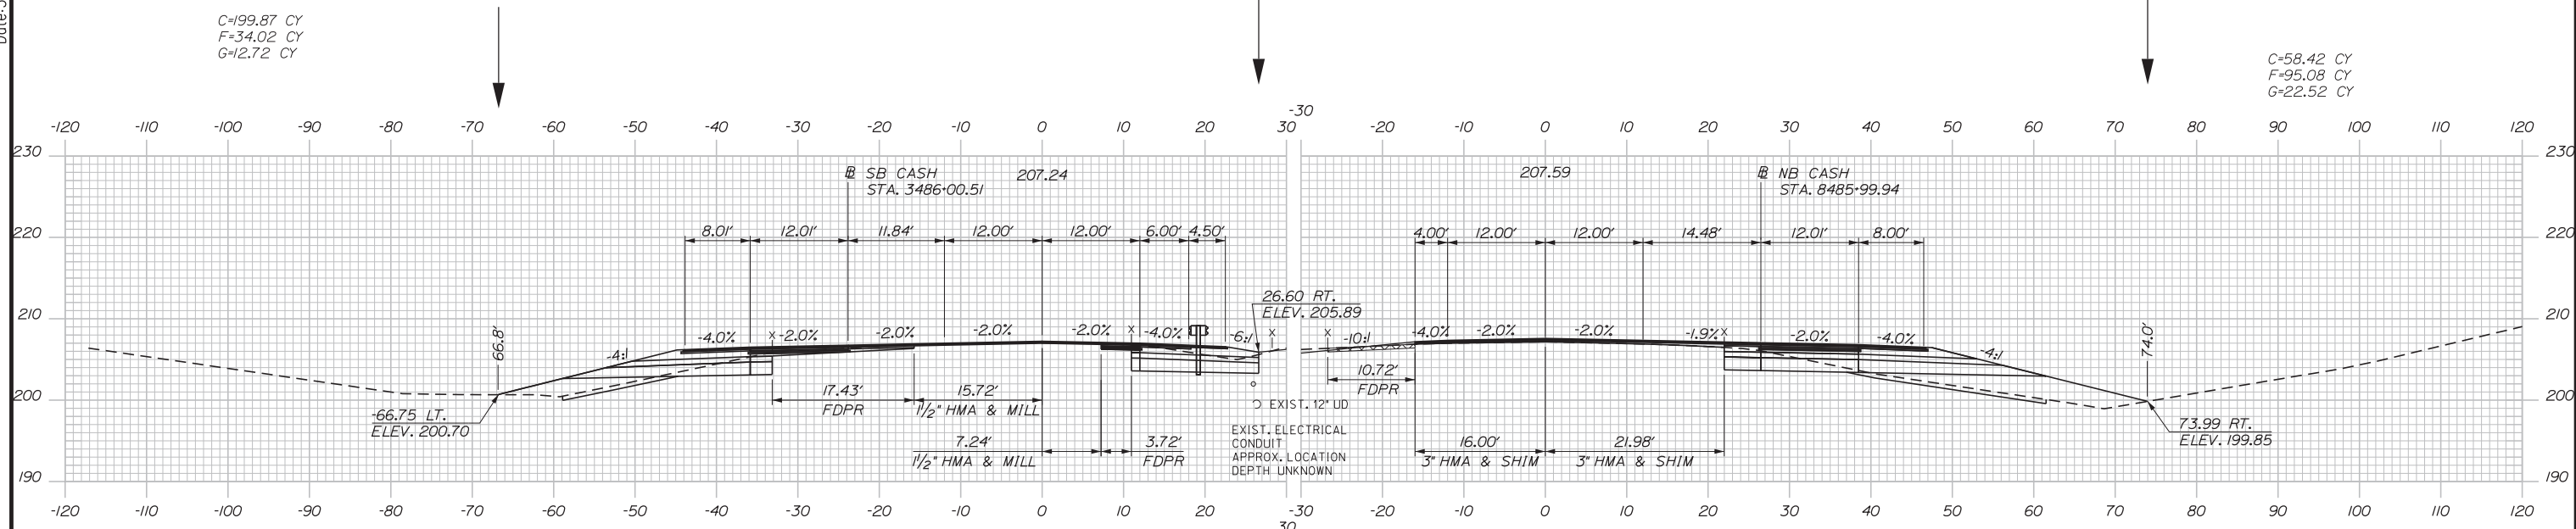

Designed by:


**Stantec**

No.	Revision	By	Date

CONSULTANT PROJECT MANAGER: LAUREN MEEK, PE

	By	Date		By	Date
Designed	PLP	3\20\19	Checked	LEM	3\20\19
Drawn	EJB	3\20\19	In Charge of	GAE	3\20\19

STANTEC CONSULTING SERVICES INC.  
 482 PAYNE ROAD  
 SCARBOROUGH, ME 04074  
 TEL (207) 887-3448  
 FAX (207) 883-3376

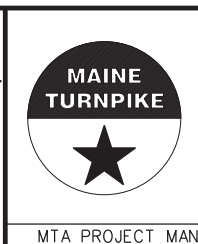

**THE GOLD STAR  
 MEMORIAL HIGHWAY**



INTERCHANGE 103  
 ORT CONVERSION  
 NB/SB ORT  
 STA. 4485+50/7485+50 TO STA. 4486+00/7486+00

SHEET NUMBER: XS-30  
 264 OF 503

CONTRACT: 2019.04

Filename: ...000.HIGHWAY\MSTA\\_xsect.dgn

 Date: 3/20/2019

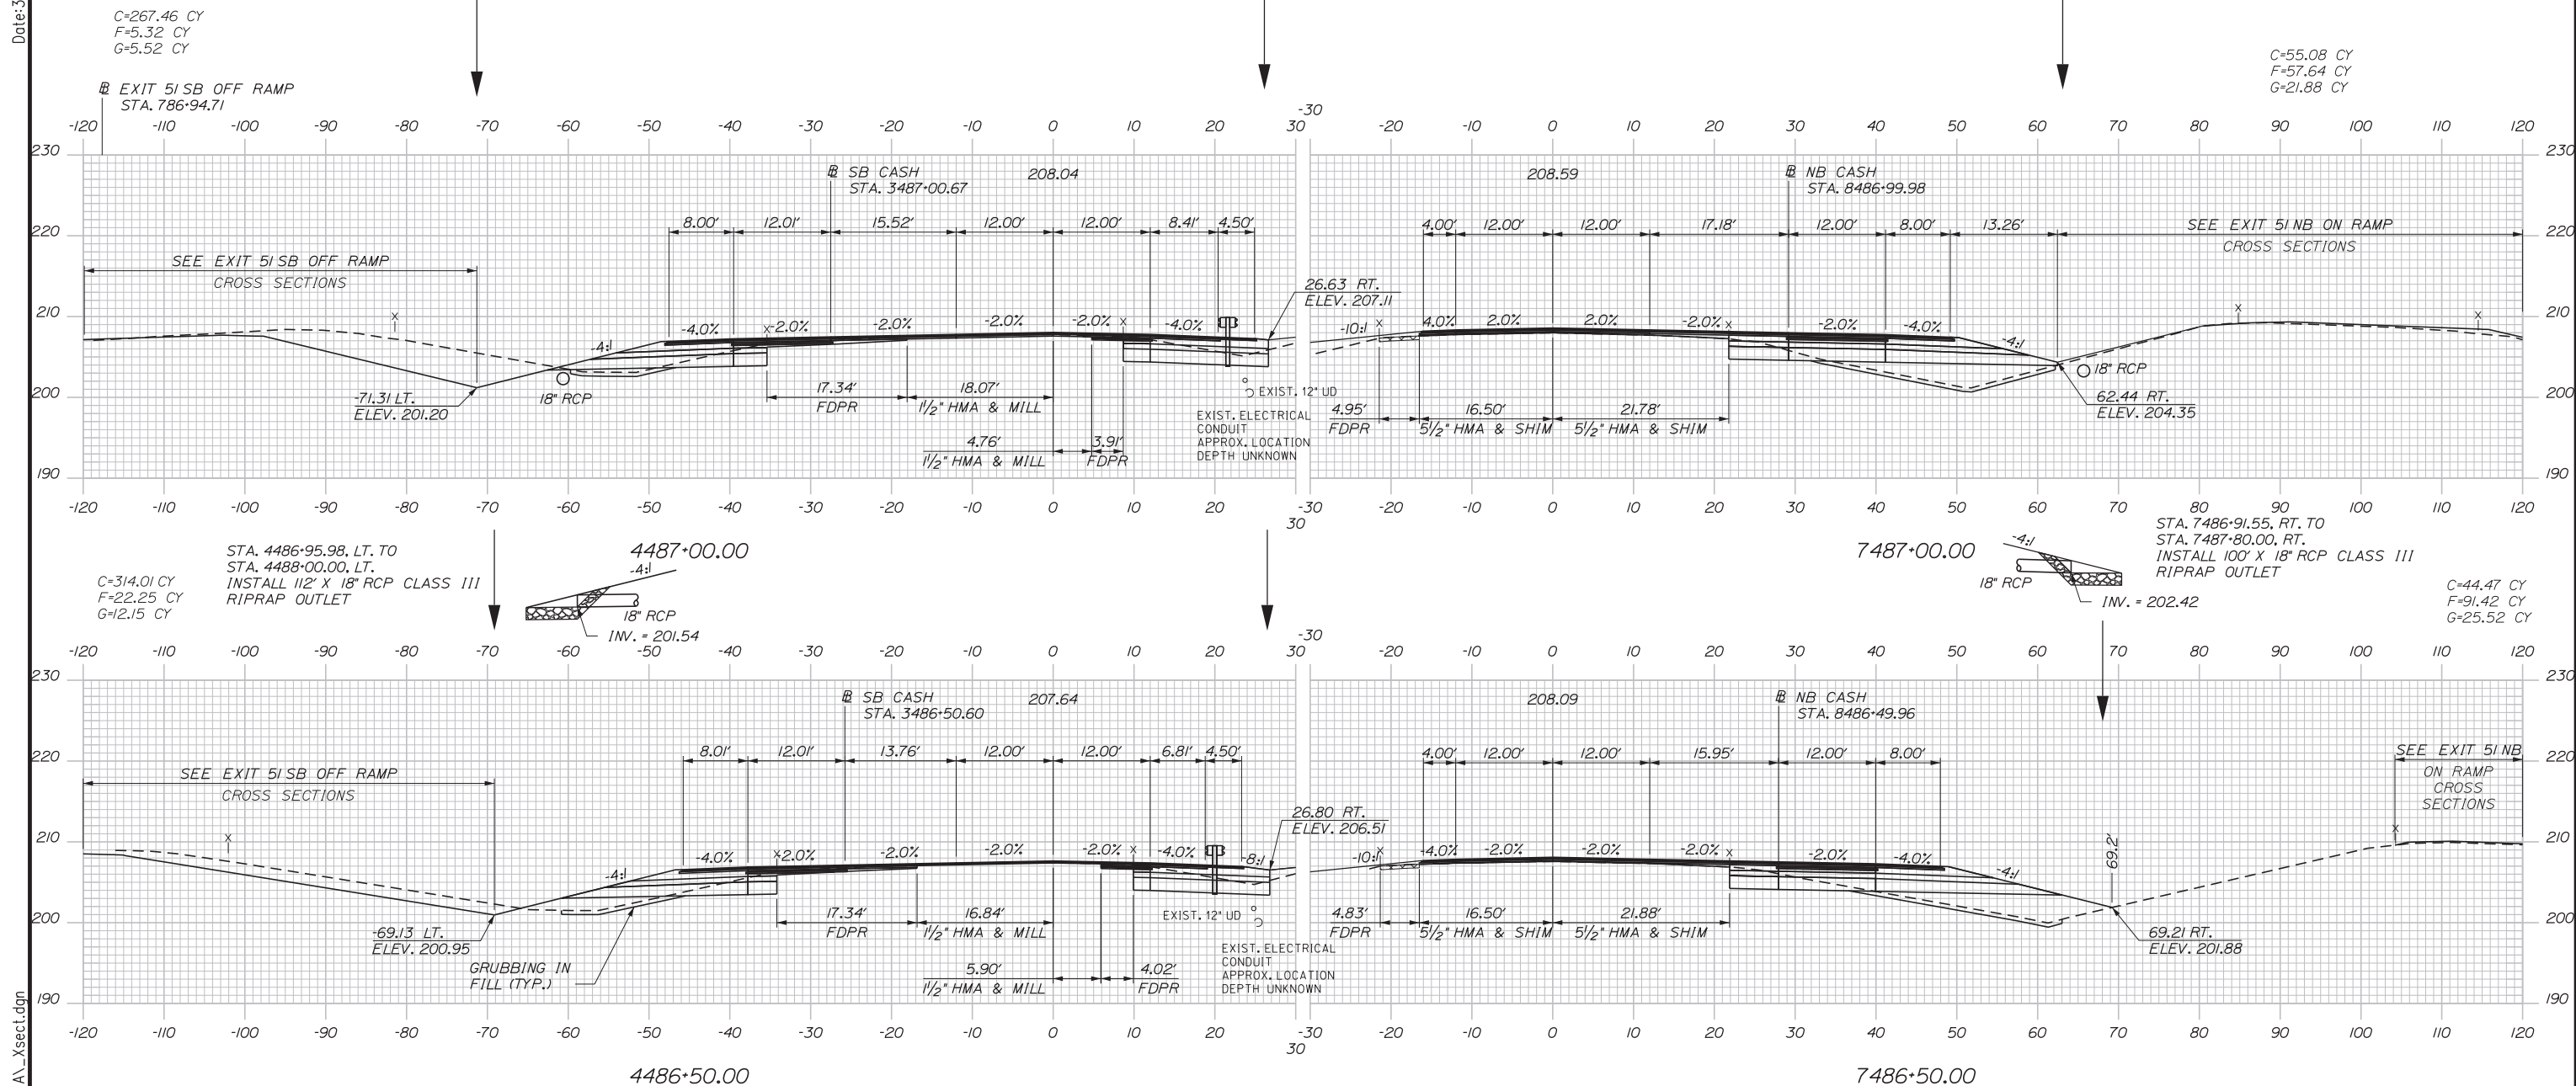

Designed by:


**Stantec**

CONSULTANT PROJECT MANAGER: LAUREN MEEK, PE

No.	Revision	By	Date

	By	Date		By	Date
Designed	PLP	3\20\19	Checked	LEM	3\20\19
Drawn	EJB	3\20\19	In Charge of	GAE	3\20\19

STANTEC CONSULTING SERVICES INC.  
 482 PAYNE ROAD  
 SCARBOROUGH, ME 04074  
 TEL (207) 887-3448  
 FAX (207) 883-3376

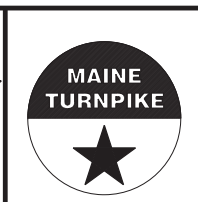


**THE GOLD STAR  
 MEMORIAL HIGHWAY**

INTERCHANGE 103  
 ORT CONVERSION  
 NB/SB ORT  
 STA. 4486+50/7486+50 TO STA. 4487+00/7487+00

Filename: ... \000\HIGHWAY\MSTA\\_xsect.dgn



Date: 3/20/2019

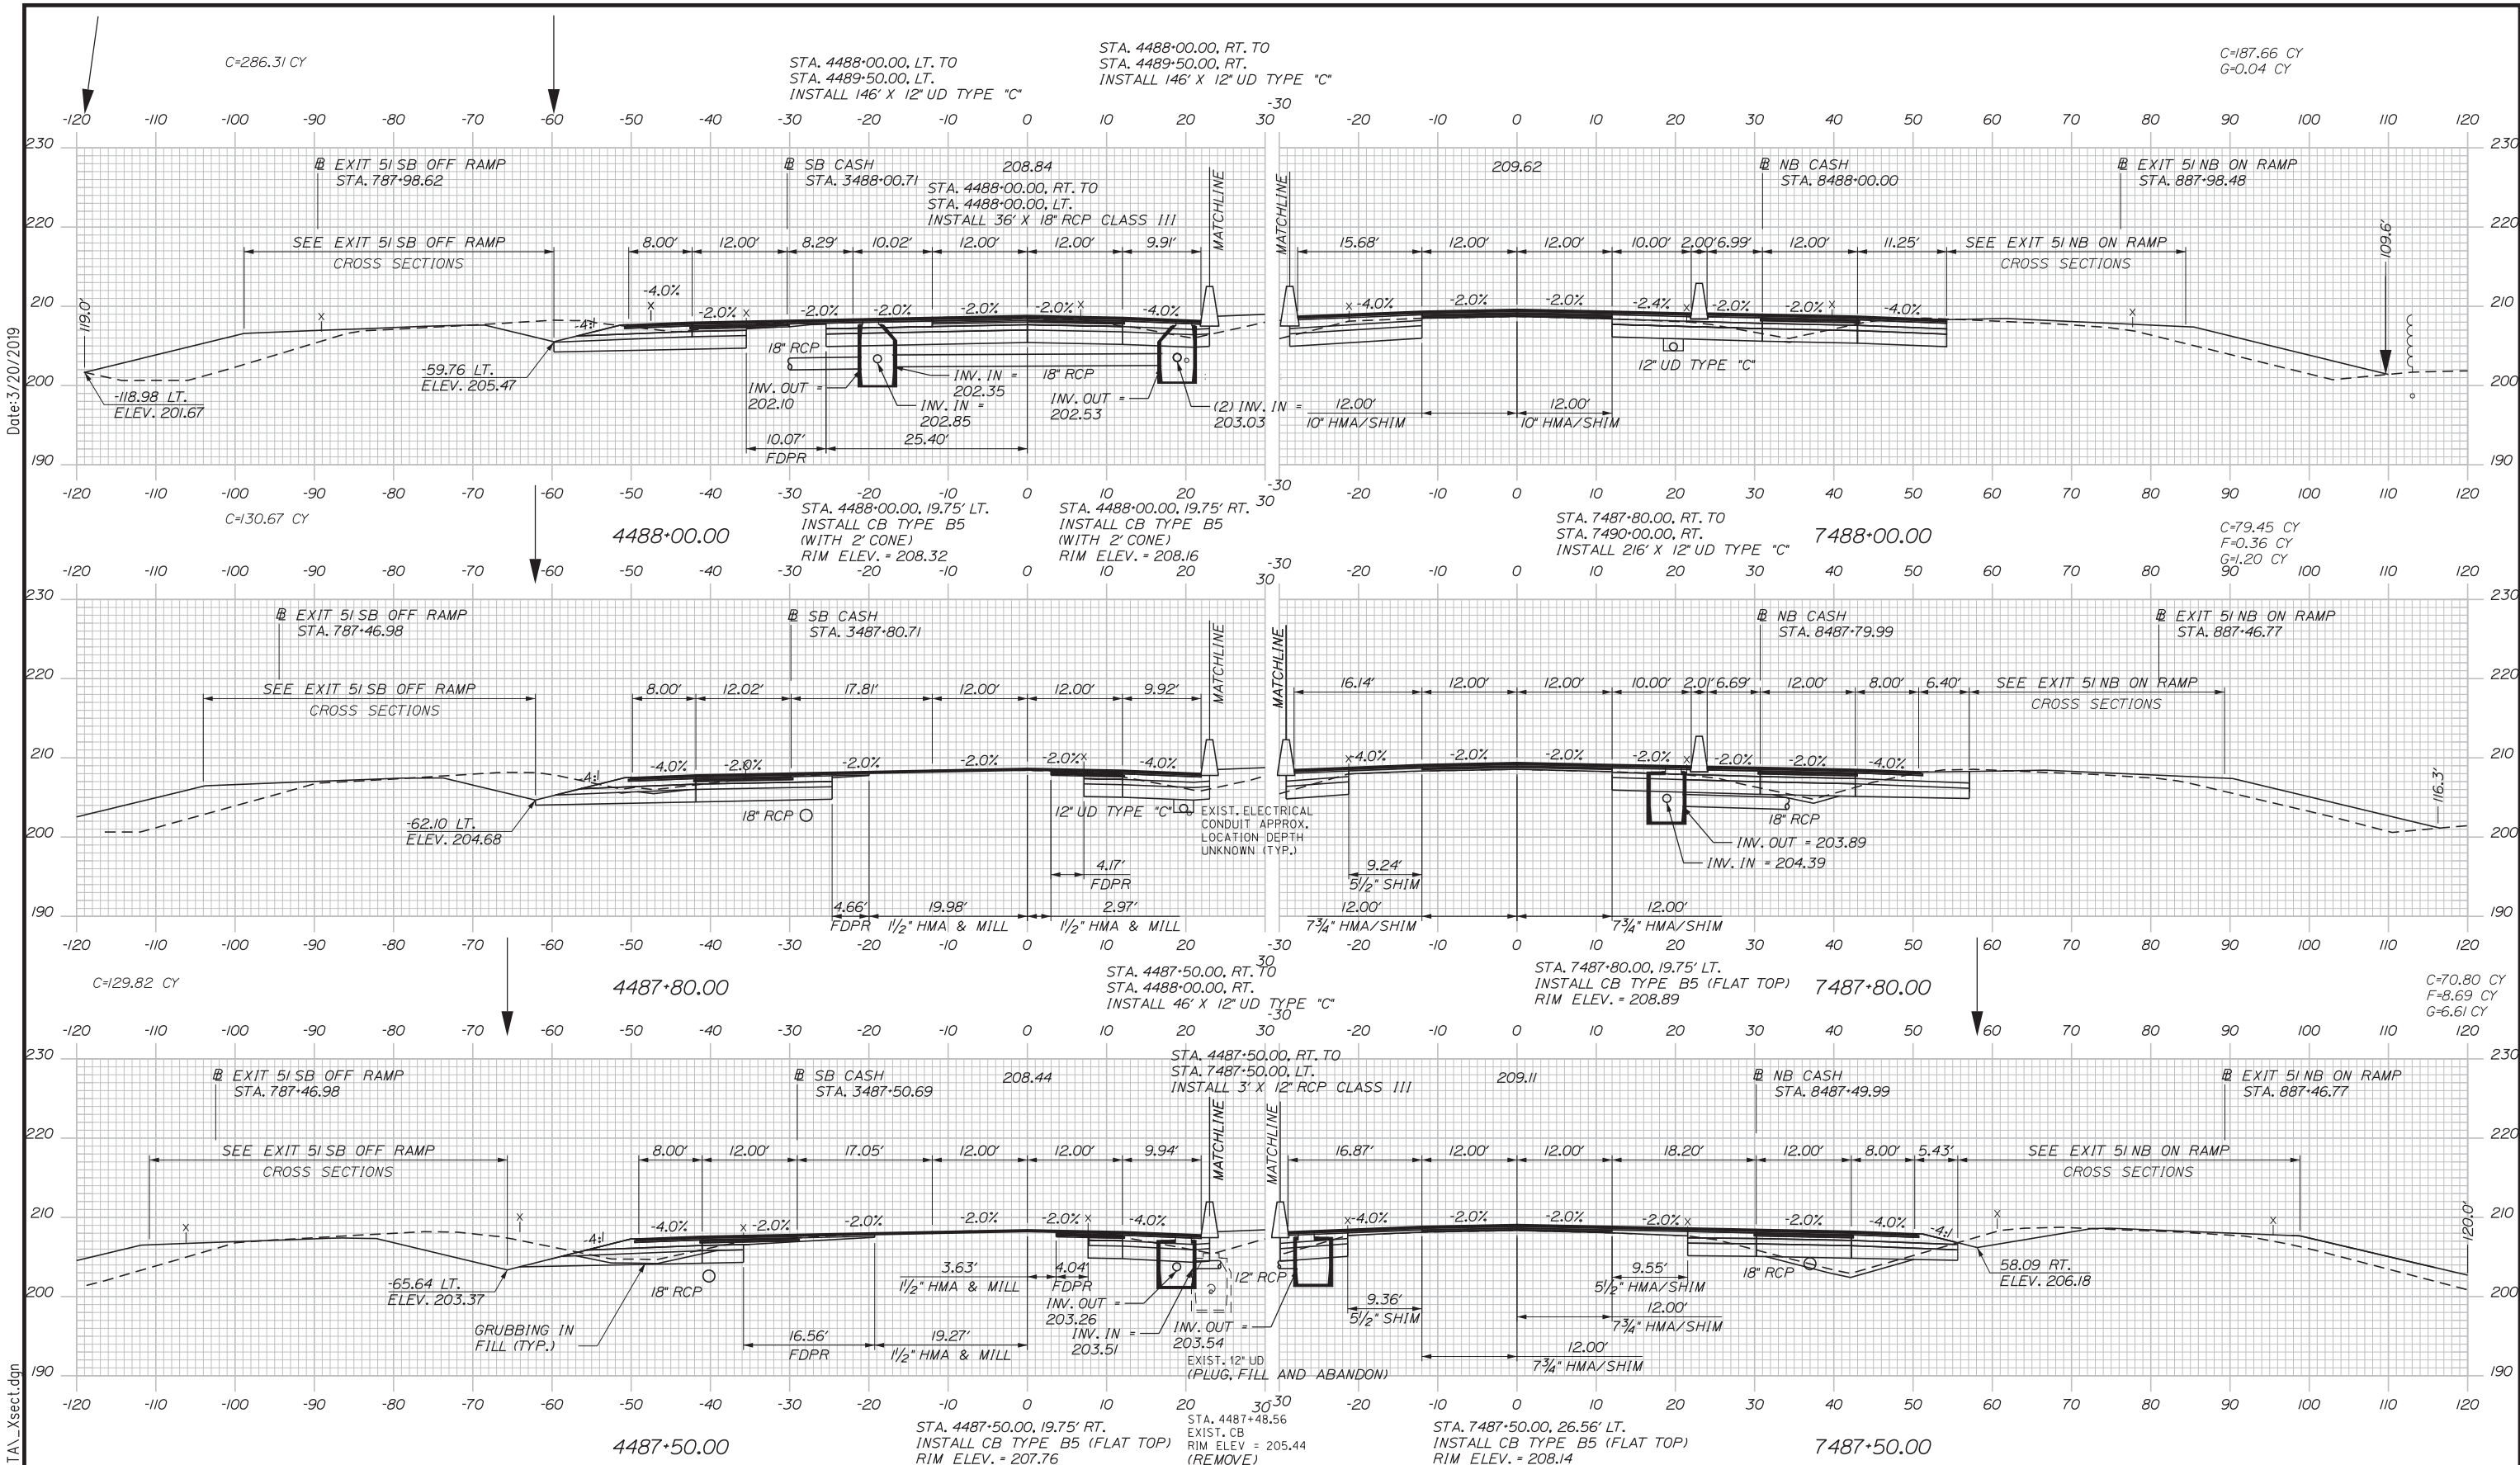

Scale: 1" = 20'

No.	Revision	By	Date

Designed by:

**Stantec**

CONSULTANT PROJECT MANAGER: LAUREN MEEK, PE

	By	Date		By	Date
Designed	PLP	3/20/19	Checked	LEM	3/20/19
Drawn	EJB	3/20/19	In Charge of	GAE	3/20/19

STANTEC CONSULTING SERVICES INC.  
 482 PAYNE ROAD  
 SCARBOROUGH, ME 04074  
 TEL (207) 887-3448  
 FAX (207) 883-3376

**MAINE TURNPIKE**

**THE GOLD STAR MEMORIAL HIGHWAY**

MTA PROJECT MANAGER: RALPH NORWOOD, IV, PE, PTOE

**INTERCHANGE 103  
 ORT CONVERSION  
 NB/SB ORT**

 


STA. 4487+50/7487+50 TO STA. 4488+00/7488+00

SHEET NUMBER: XS-32  
 266 OF 503

CONTRACT: 2019.04

Filename: ...100\HIGHWAY\MSTA\\_xsect.dgn

Date: 3/20/2019

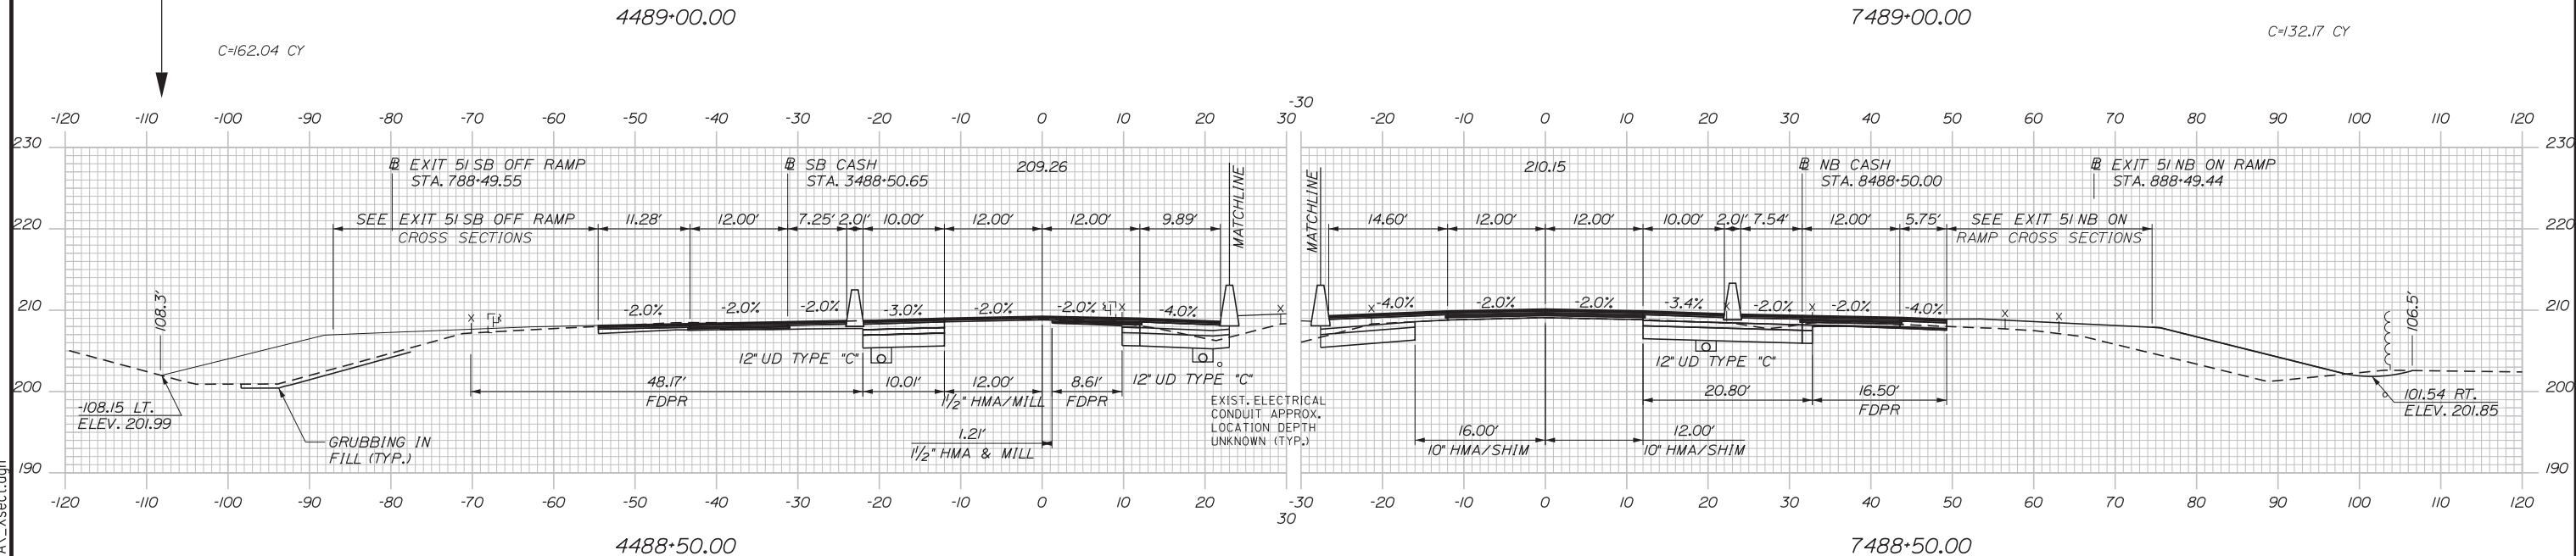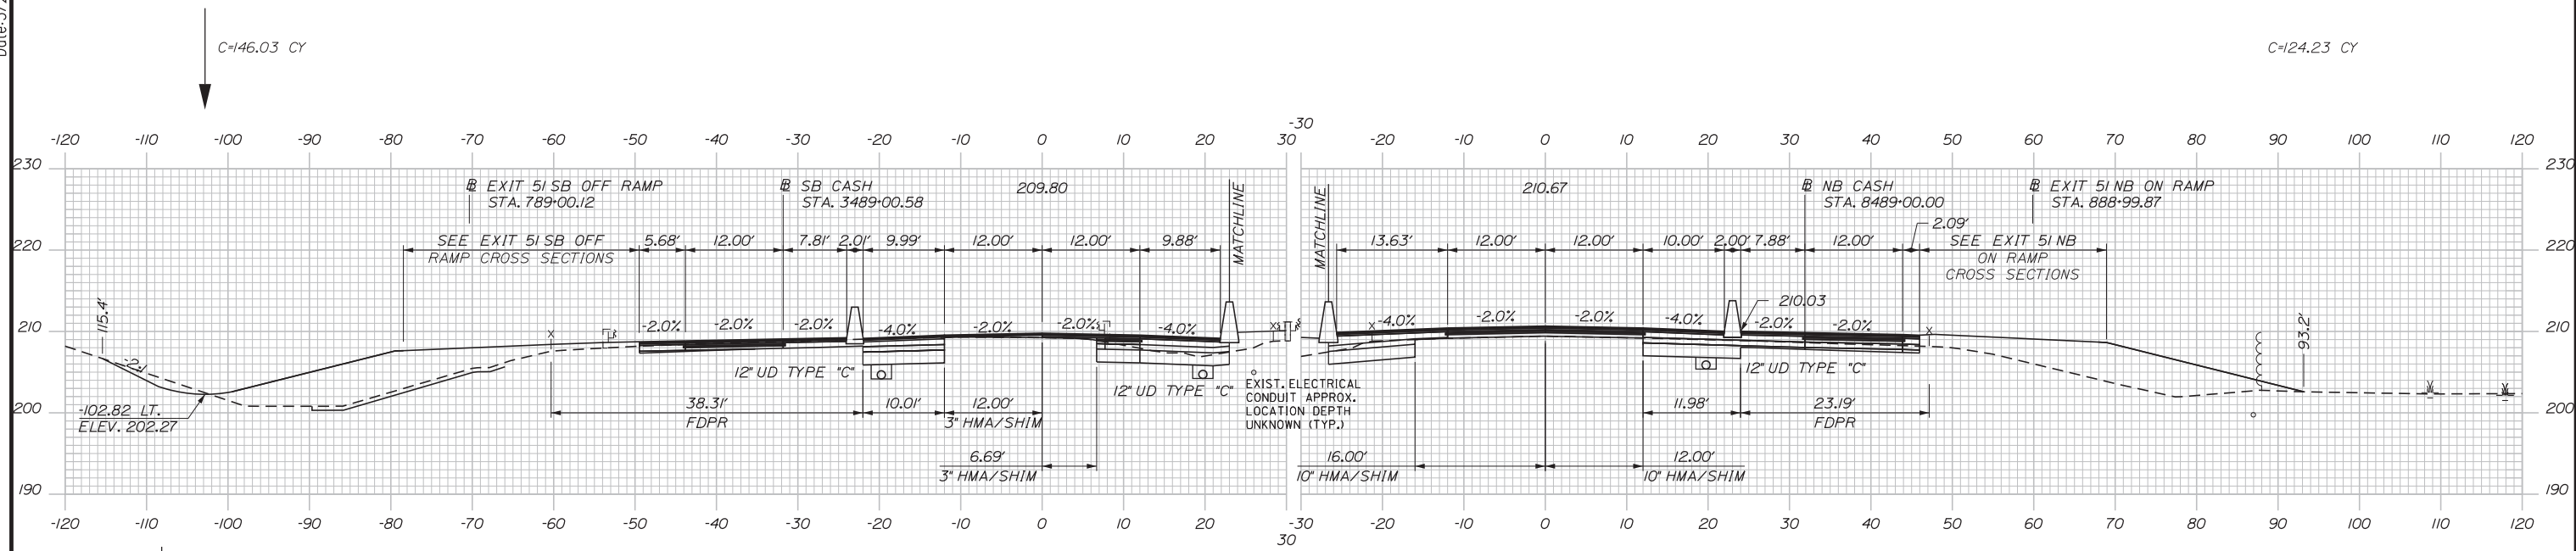

No.	Revision	By	Date


Designed by:

**Stantec**

CONSULTANT PROJECT MANAGER: LAUREN MEEK, PE

	By	Date		By	Date
Designed	PLP	3\20\19	Checked	LEM	3\20\19
Drawn	EJB	3\20\19	In Charge of	GAE	3\20\19

STANTEC CONSULTING SERVICES INC.  
 482 PAYNE ROAD  
 SCARBOROUGH, ME 04074  
 TEL (207) 887-3448  
 FAX (207) 883-3376

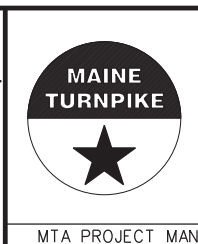

**THE GOLD STAR  
 MEMORIAL HIGHWAY**



INTERCHANGE 103  
 ORT CONVERSION  
 NB/SB ORT  
 STA. 4488+50/7488+50 TO STA. 4489+00/7489+00

SHEET NUMBER: XS-33  
 267 OF 503

CONTRACT: 2019.04

Filename: ...00\HIGHWAY\MSTA\\_xsect.dgn

Date: 3/20/2019

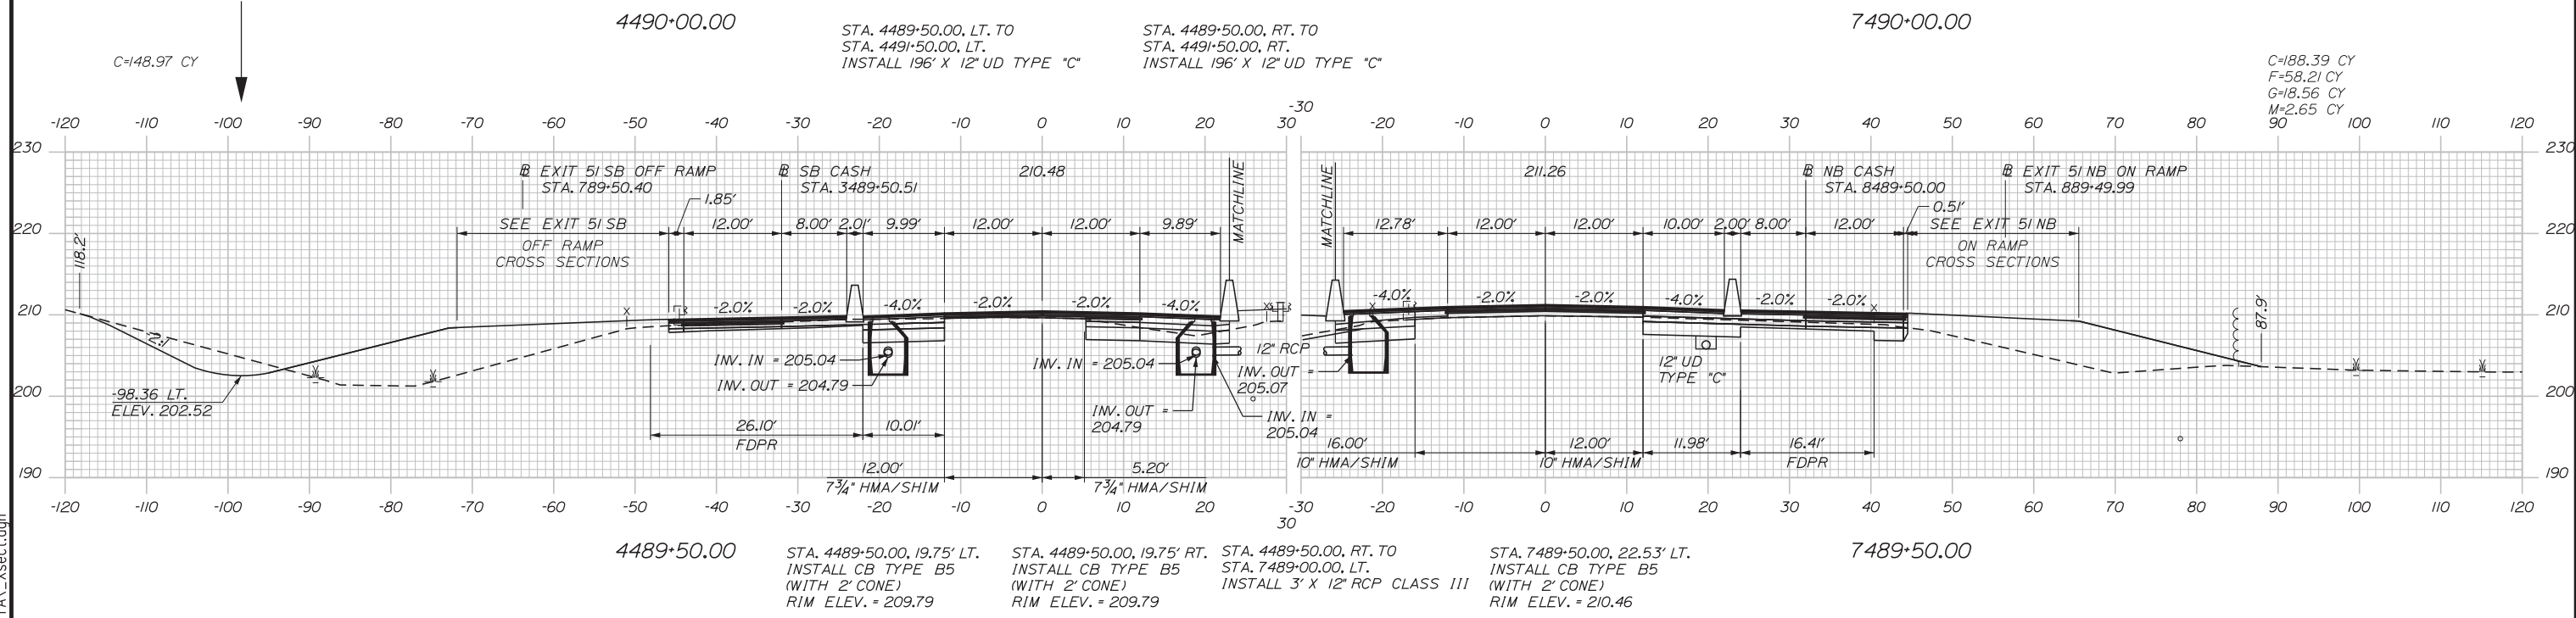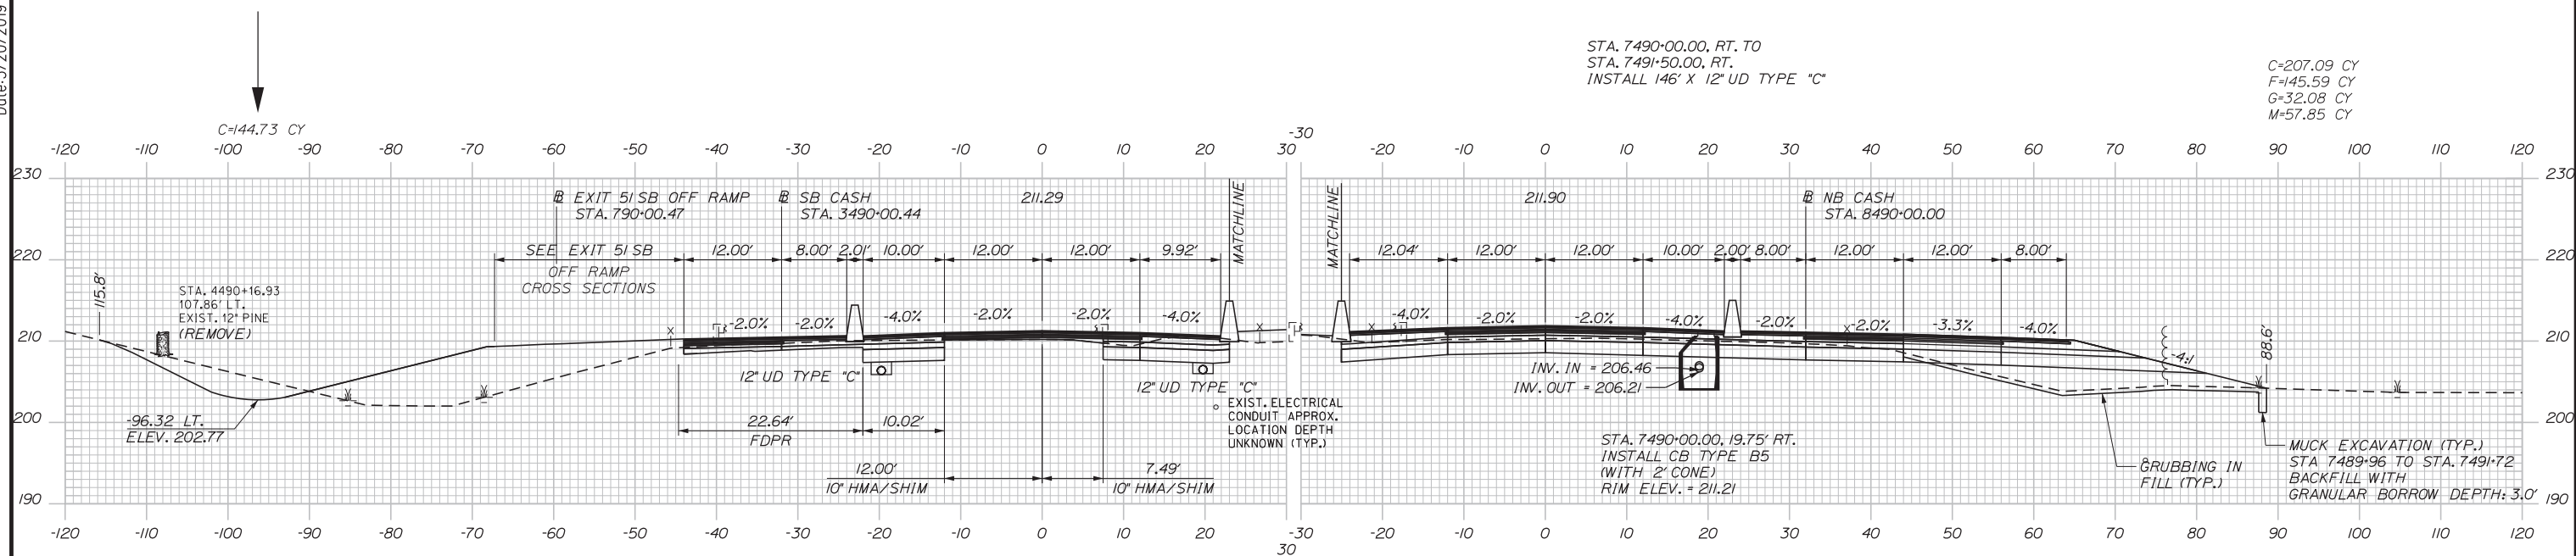

Scale: 10 0 10 20  
 Scale of Feet

No.	Revision	By	Date

Designed by:

**Stantec**

CONSULTANT PROJECT MANAGER: LAUREN MEEK, PE

	By	Date		By	Date
Designed	PLP	3\20\19	Checked	LEM	3\20\19
Drawn	EJB	3\20\19	In Charge of	GAE	3\20\19

STANTEC CONSULTING SERVICES INC.  
 482 PAYNE ROAD  
 SCARBOROUGH, ME 04074  
 TEL (207) 887-3448  
 FAX (207) 883-3376

**MAINE TURNPIKE**

**THE GOLD STAR MEMORIAL HIGHWAY**


MTA PROJECT MANAGER: RALPH NORWOOD, IV, PE, PTOE

INTERCHANGE 103  
 ORT CONVERSION  
 NB/SB ORT  
 STA. 4489+50/7489+50 TO STA. 4490+00/7490+00

SHEET NUMBER: XS-34  
 CONTRACT: 2019.04  
 268 OF 503


Filename: ...000\HIGHWAY\MSTA\\_xsect.dgn

Date: 3/20/2019

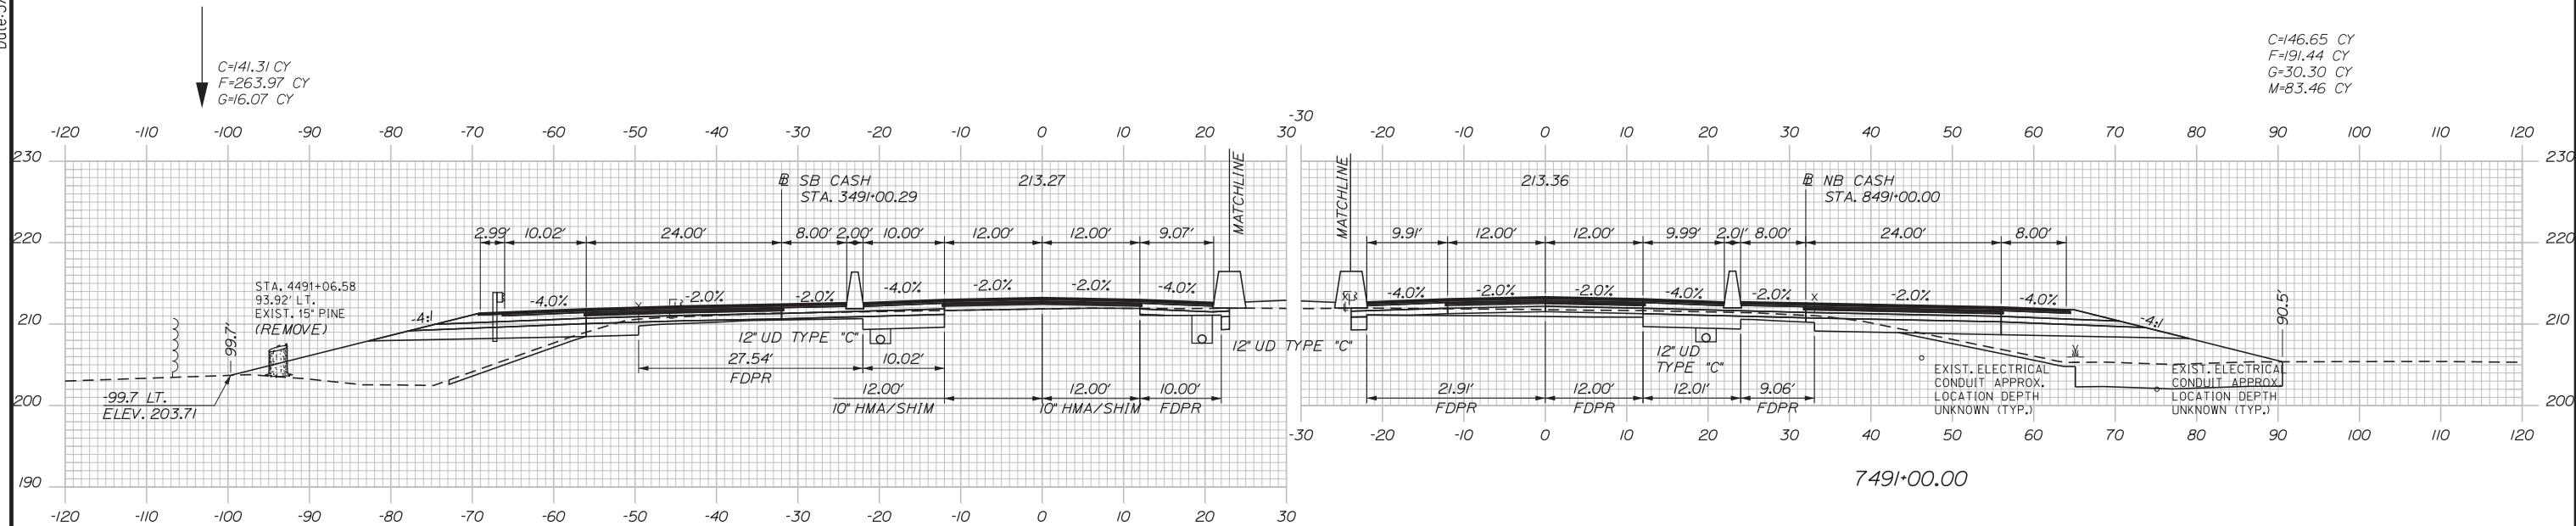


C=141.31 CY  
F=263.97 CY  
G=16.07 CY

C=146.65 CY  
F=191.44 CY  
G=30.30 CY  
M=83.46 CY

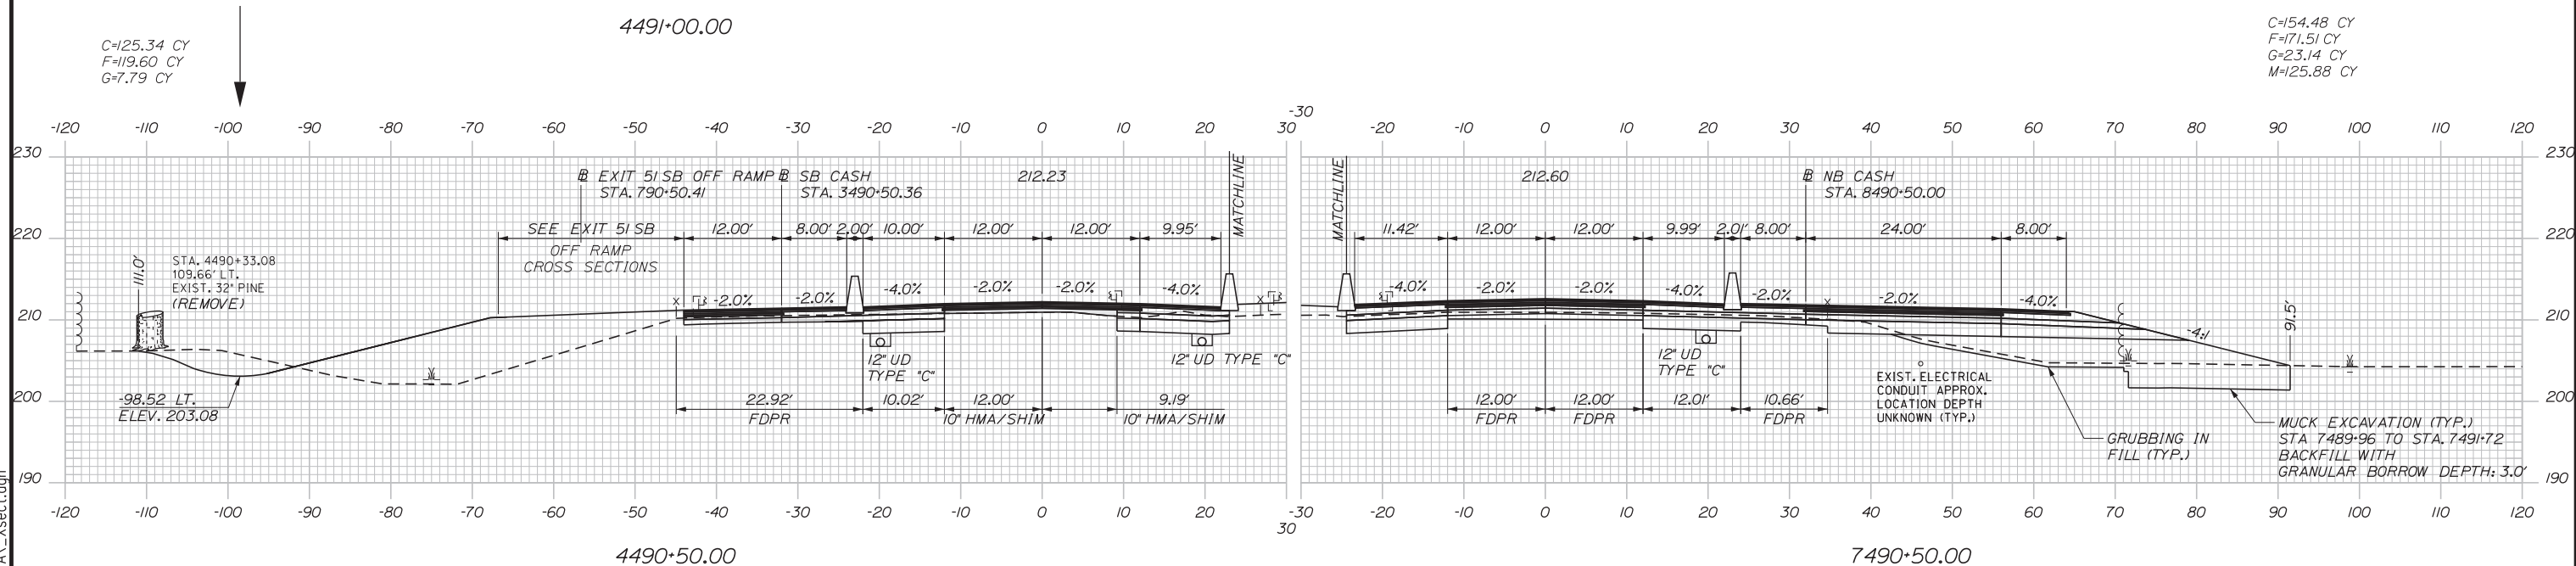

C=125.34 CY  
F=119.60 CY  
G=7.79 CY

 C=154.48 CY  
F=171.51 CY  
G=23.14 CY  
M=125.88 CY



Designed by:



STANTEC CONSULTING SERVICES INC.  
482 PAYNE ROAD  
SCARBOROUGH, ME 04074  
TEL (207) 887-3448  
FAX (207) 883-3376



THE GOLD STAR  
MEMORIAL HIGHWAY

INTERCHANGE 103  
ORT CONVERSION  
NB/SB ORT  
STA. 4490+50/7490+50 TO STA. 4491+00/7491+00

No.	Revision	By	Date

CONSULTANT PROJECT MANAGER: LAUREN MEEK, PE			
	By	Date	
Designed	PLP	3\20\19	Checked LEM 3\20\19
Drawn	EJB	3\20\19	In Charge of GAE 3\20\19

MTA PROJECT MANAGER: RALPH NORWOOD, IV, PE, PTOE

CONTRACT: 2019.04

SHEET NUMBER: XS-35


269 OF 503

Filename: ...00\HIGHWAY\MSTA\\_xsect.dgn



Date: 3/20/2019

Filename: ...000\HIGHWAY\MSTA...xsect.dgn

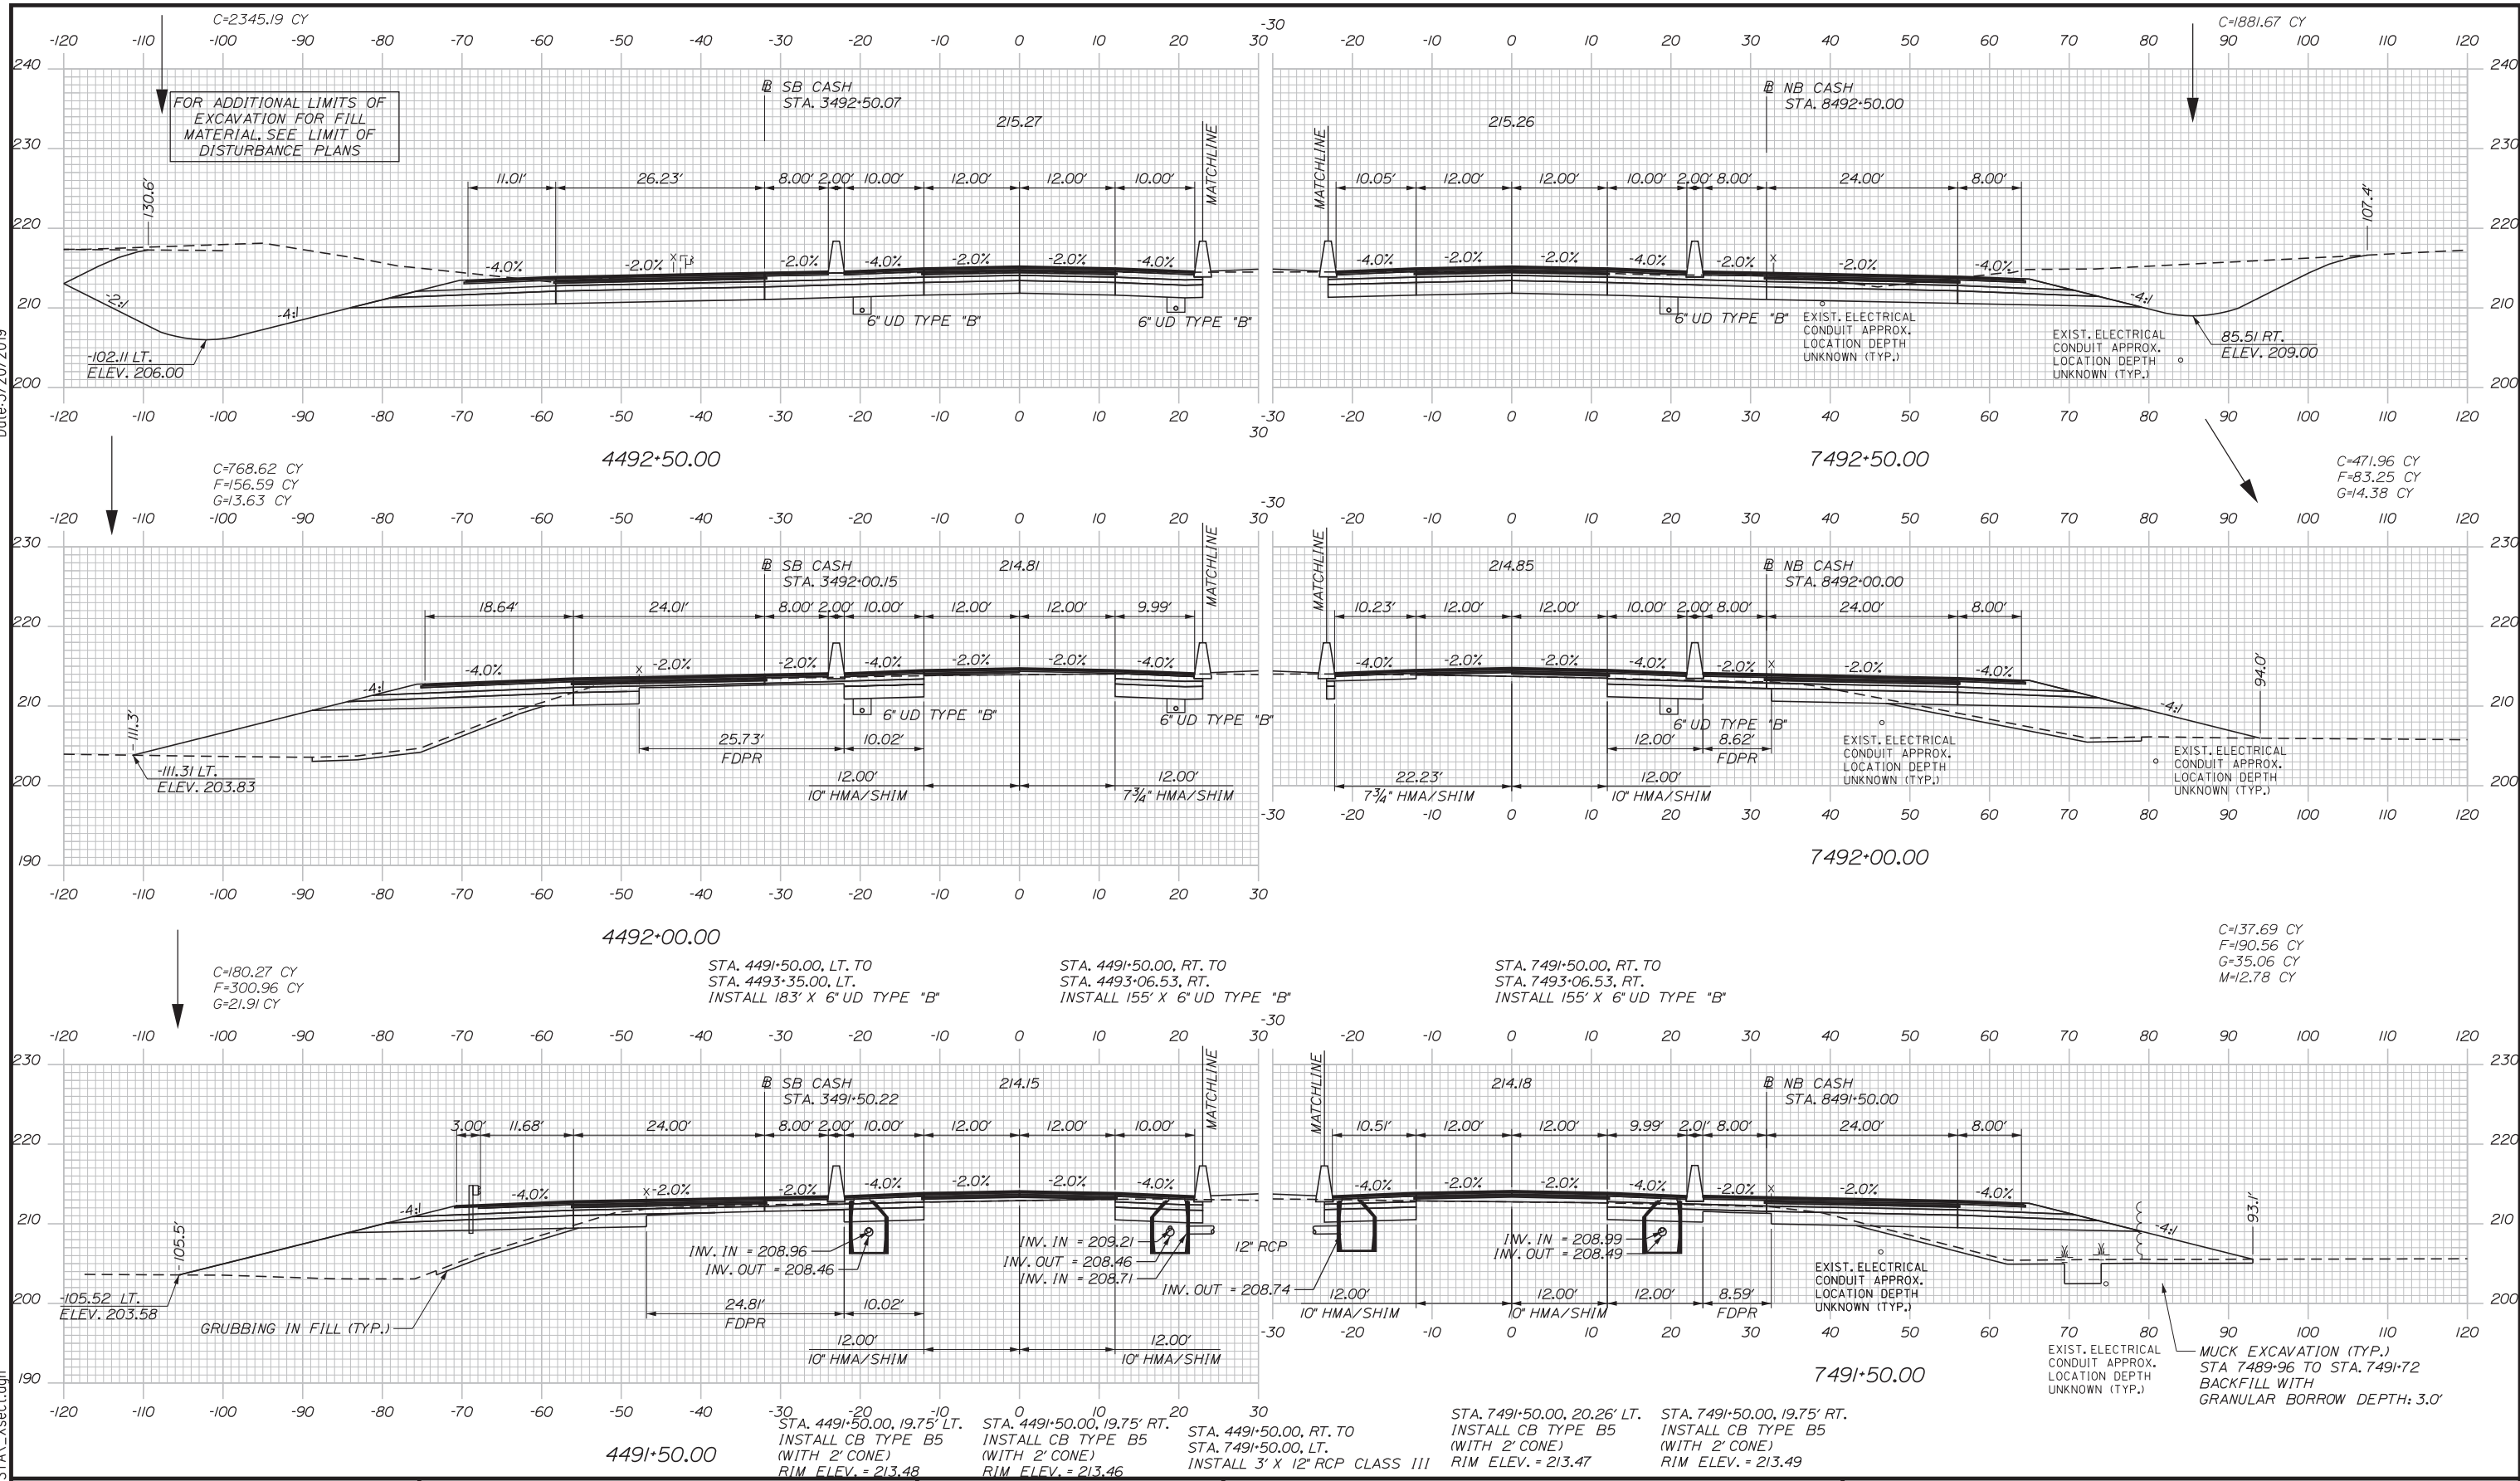

Scale: 10 0 10 20  
Scale of Feet

No.	Revision	By	Date

Designed by:

STANTEC CONSULTING SERVICES INC.  
482 PAYNE ROAD  
SCARBOROUGH, ME 04074  
TEL (207) 887-3448  
FAX (207) 883-3376

CONSULTANT PROJECT MANAGER: LAUREN MEEK, PE			
By	Date	By	Date
Designed	PLP 3\20\19	Checked	LEM 3\20\19
Drawn	EJB 3\20\19	In Charge of	GAE 3\20\19

STA. 4491+50.00, 19.75' LT. INSTALL CB TYPE B5 (WITH 2' CONE) RIM ELEV. = 213.48

STA. 4491+50.00, 19.75' RT. INSTALL CB TYPE B5 (WITH 2' CONE) RIM ELEV. = 213.46

STA. 4491+50.00, RT. TO STA. 4493+35.00, LT. INSTALL 183' X 6" UD TYPE "B"

STA. 4491+50.00, RT. TO STA. 4493+06.53, RT. INSTALL 155' X 6" UD TYPE "B"

STA. 7491+50.00, 20.26' LT. INSTALL CB TYPE B5 (WITH 2' CONE) RIM ELEV. = 213.47

STA. 7491+50.00, 19.75' RT. INSTALL CB TYPE B5 (WITH 2' CONE) RIM ELEV. = 213.49

**THE GOLD STAR MEMORIAL HIGHWAY**

MTA PROJECT MANAGER: RALPH NORWOOD, IV, PE, PTOE



**INTERCHANGE 103  
ORT CONVERSION  
NB/SB ORT**

STA. 4491+50/7491+50 TO STA. 4492+50/7492+50

SHEET NUMBER: XS-36  
270 OF 503

CONTRACT: 2019.04

 Date: 3/20/2019

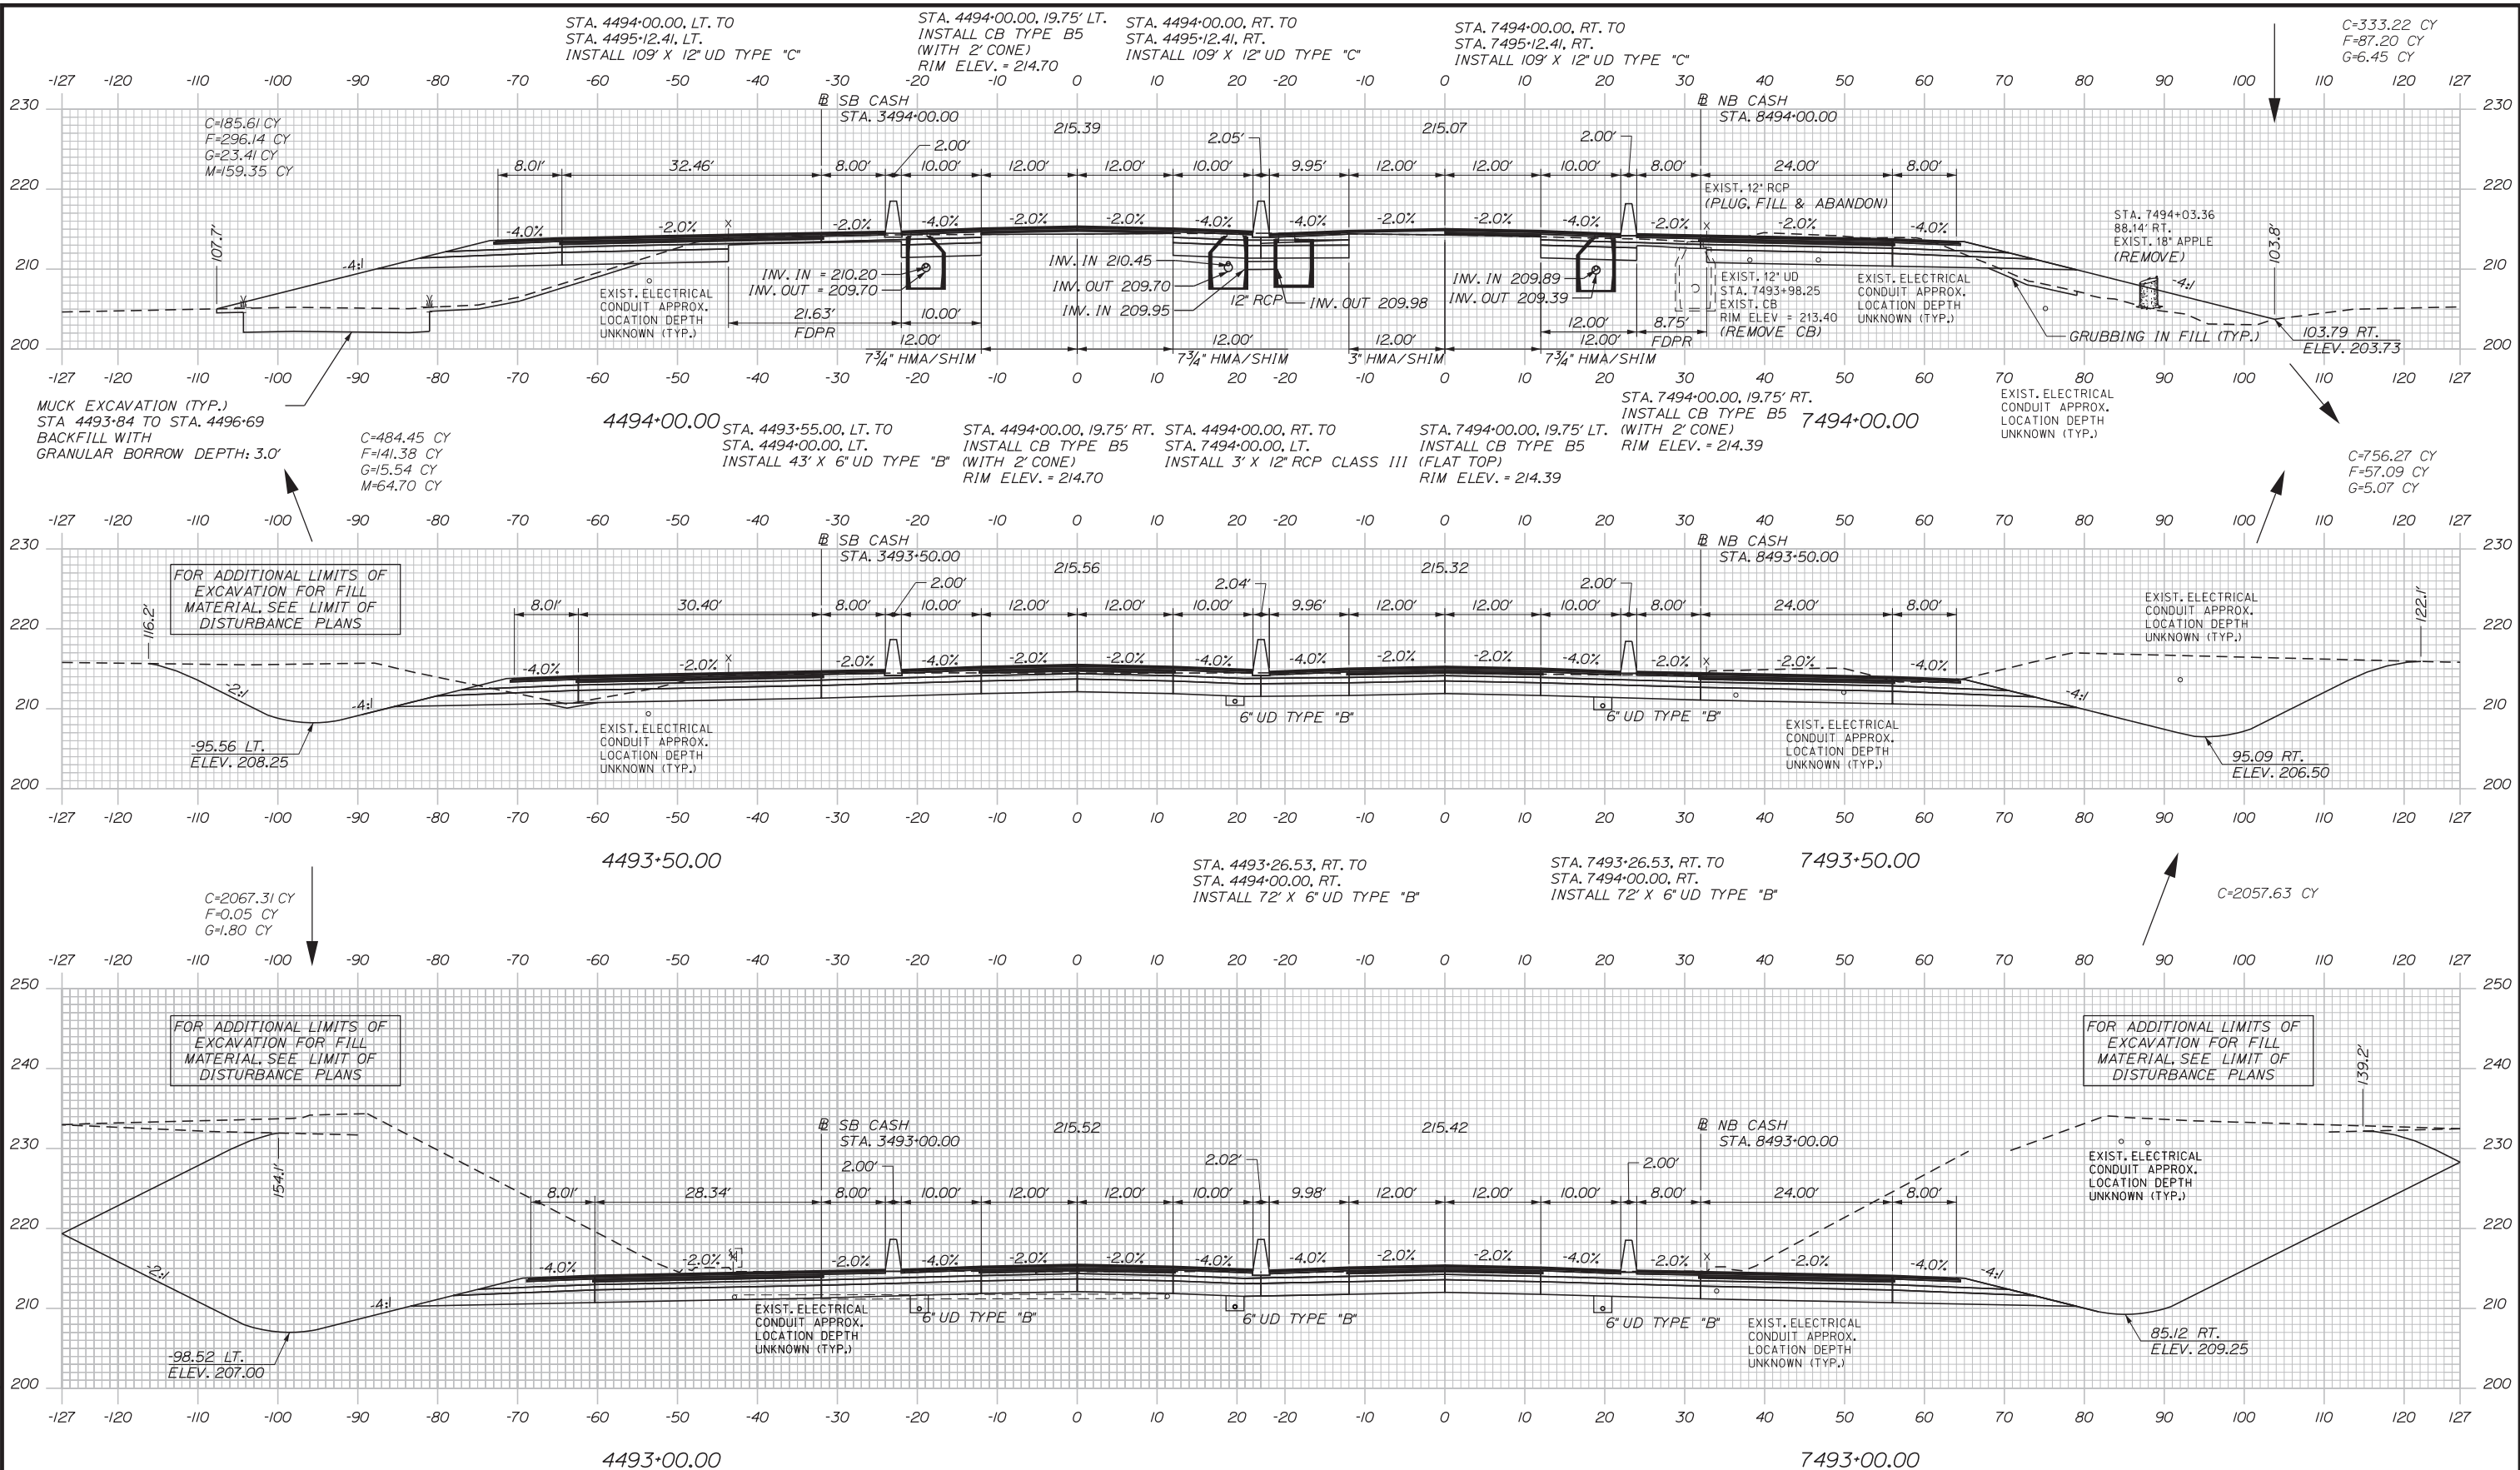

Designed by:



STANTEC CONSULTING SERVICES INC.  
482 PAYNE ROAD  
SCARBOROUGH, ME 04074  
TEL (207) 887-3448  
FAX (207) 883-3376



THE GOLD STAR  
MEMORIAL HIGHWAY

INTERCHANGE 103  
ORT CONVERSION  
NB/SB ORT  
STA. 4493+00/7493+00 TO STA. 4494+00/7494+00

No.	Revision	By	Date

CONSULTANT PROJECT MANAGER: LAUREN MEEK, PE			
	By	Date	
Designed	PLP	3\20\19	Checked
Drawn	EJB	3\20\19	In Charge of

MTA PROJECT MANAGER: RALPH NORWOOD, IV, PE, PTOE

CONTRACT: 2019.04

 

SHEET NUMBER: XS-37

271 OF 503

Filename: ...00\HIGHWAY\MSTA...xsect.dgn



Date: 3/20/2019

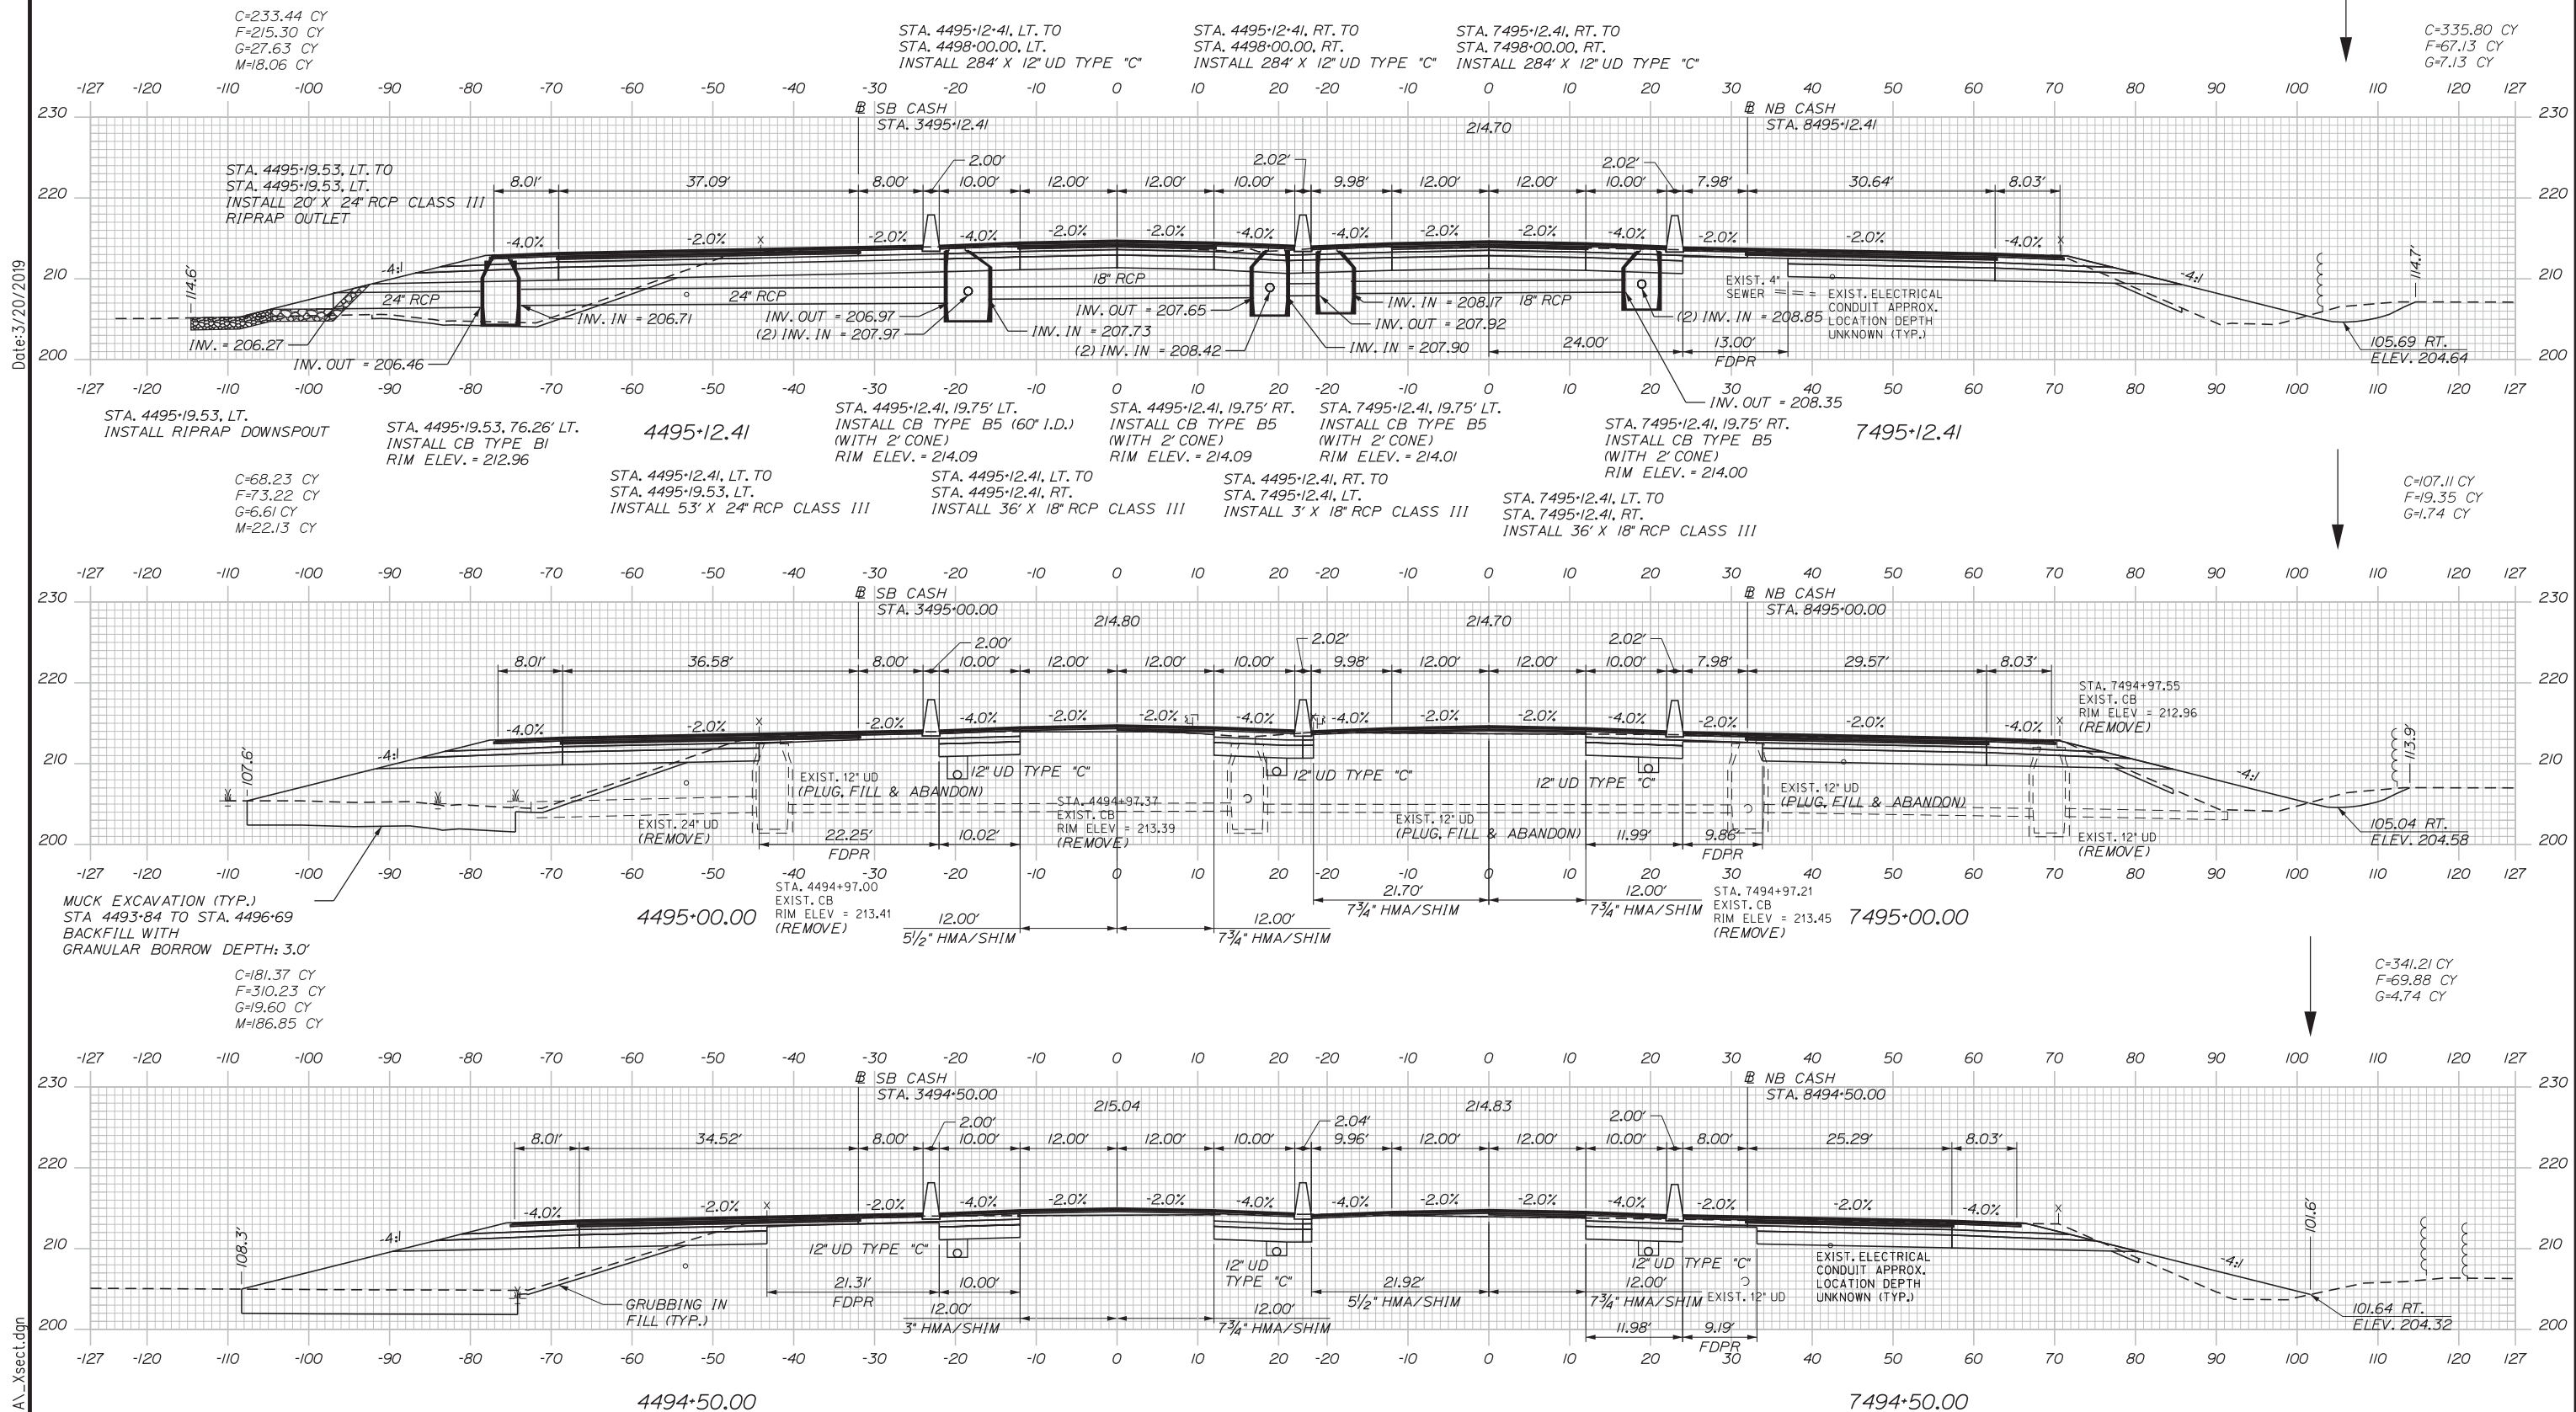

Designed by:


**Stantec**

CONSULTANT PROJECT MANAGER: LAUREN MEEK, PE

No.	Revision	By	Date

	By	Date		By	Date
Designed	PLP	3\20\19	Checked	LEM	3\20\19
Drawn	EJB	3\20\19	In Charge of	GAE	3\20\19

STANTEC CONSULTING SERVICES INC.  
482 PAYNE ROAD  
SCARBOROUGH, ME 04074  
TEL (207) 887-3448  
FAX (207) 883-3376




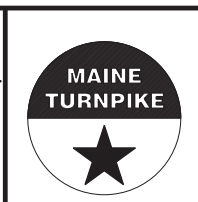


**THE GOLD STAR  
MEMORIAL HIGHWAY**

INTERCHANGE 103  
ORT CONVERSION  
NB/SB ORT  
STA. 4494+50/7494+50 TO STA. 4495+12.41/7495+12.41

Filename: ...100\HIGHWAY\MSTA1...xsect.dgn

 Date: 3/20/2019

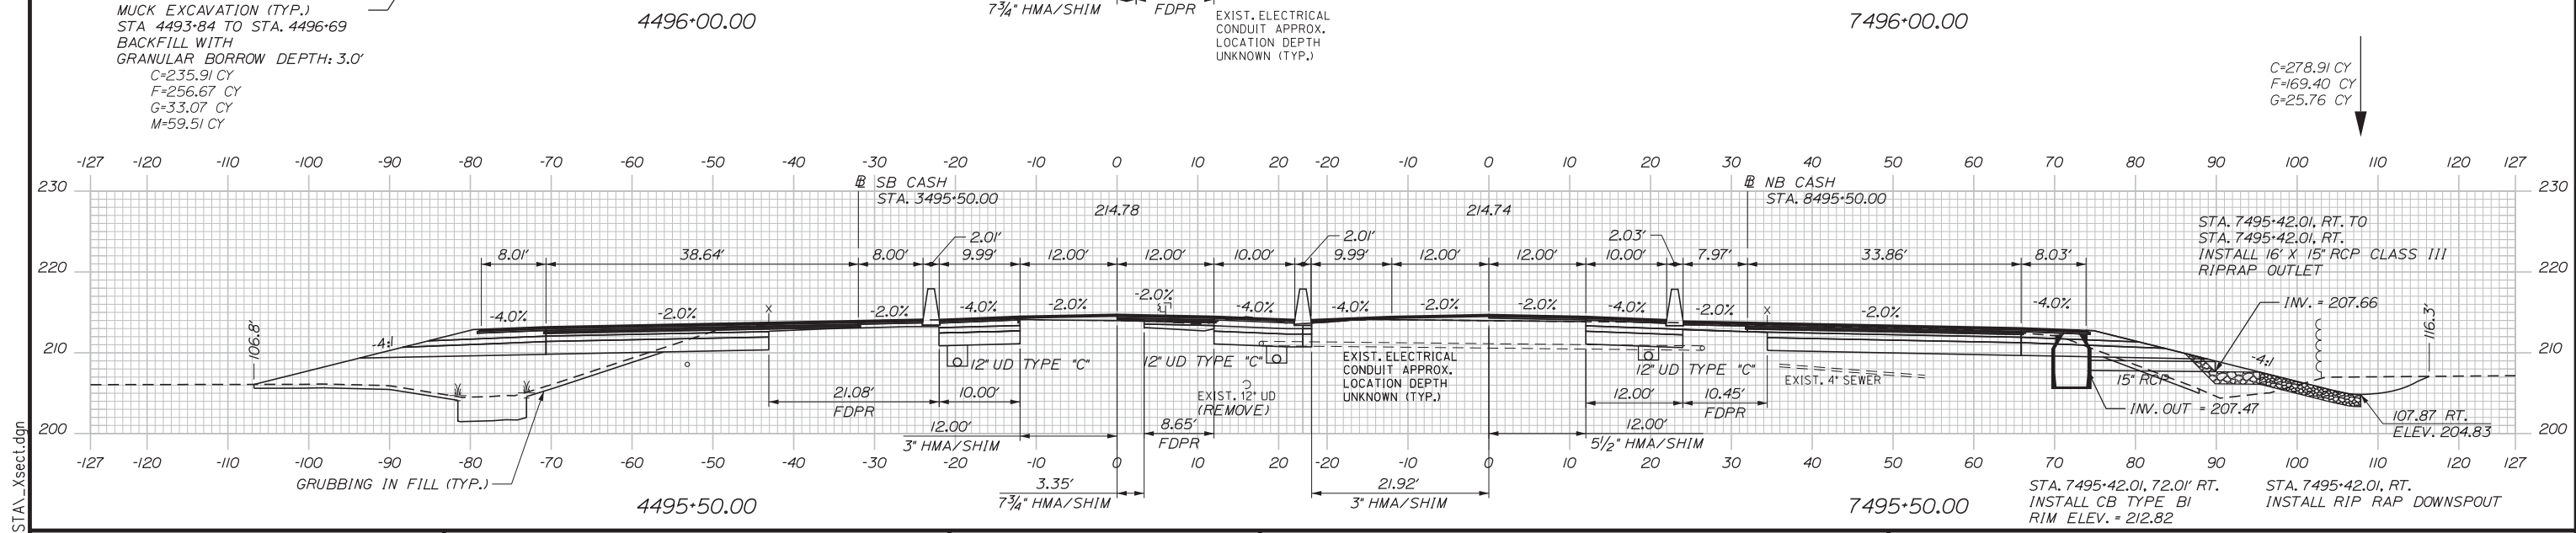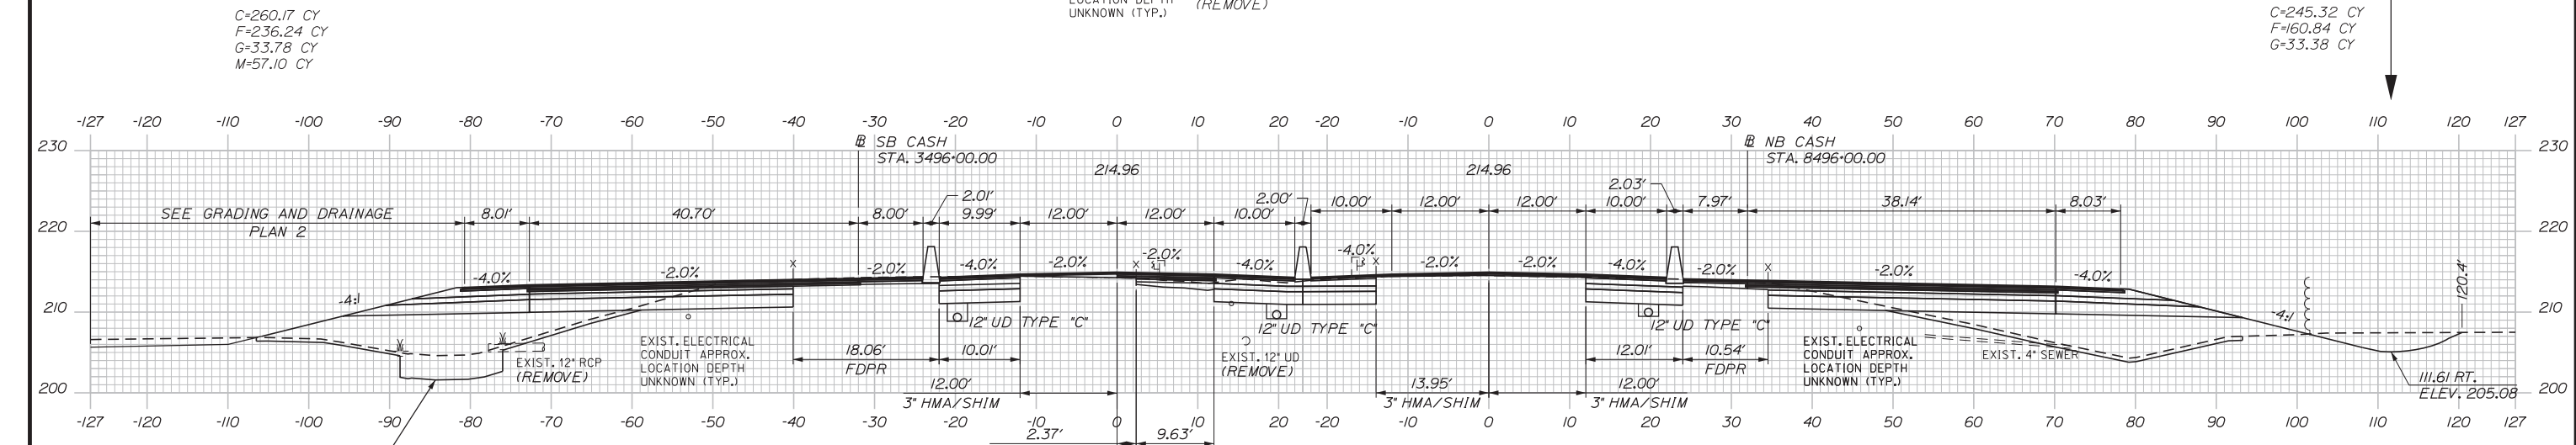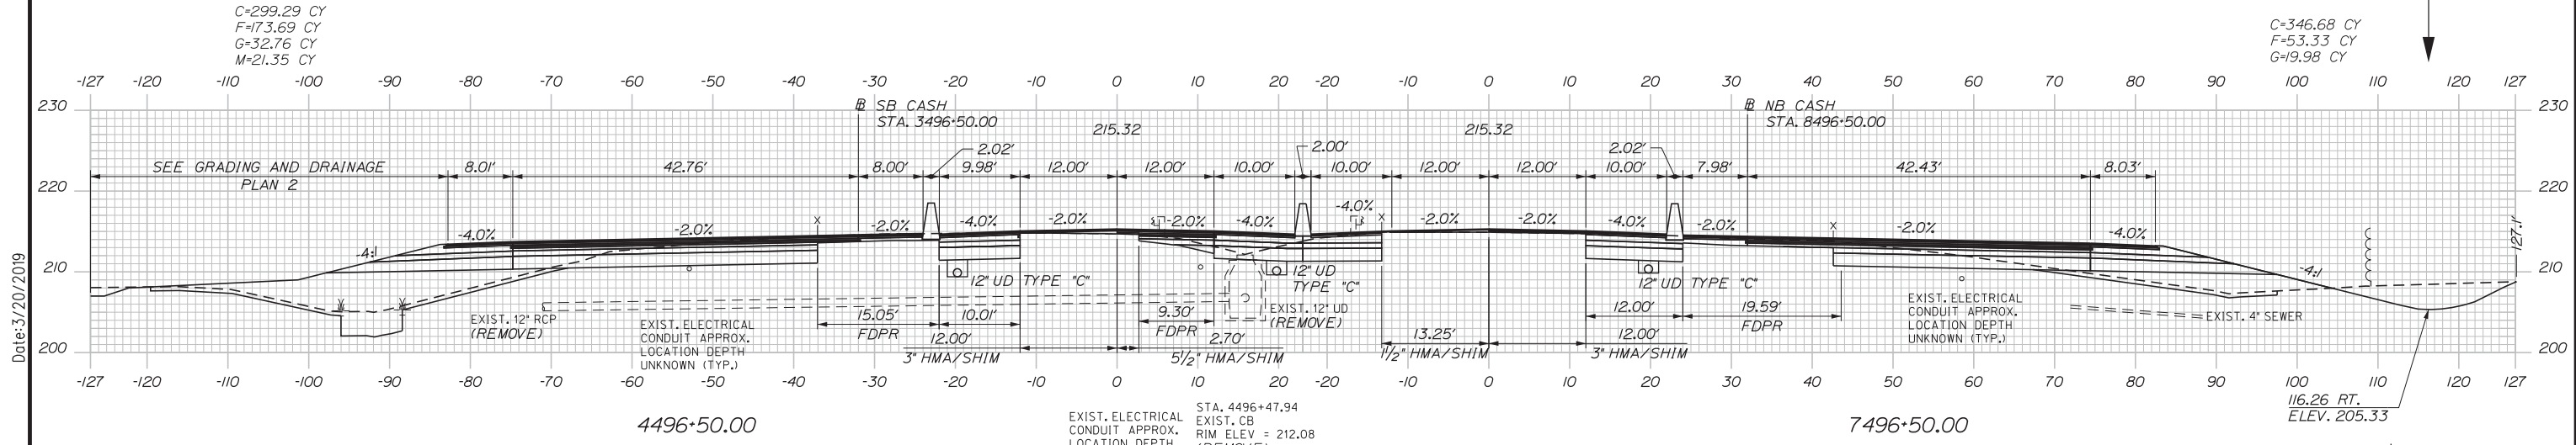

Designed by:


**Stantec**

No.	Revision	By	Date

CONSULTANT PROJECT MANAGER: LAUREN MEEK, PE

	By	Date		By	Date
Designed	PLP	3\20\19	Checked	LEM	3\20\19
Drawn	EJB	3\20\19	In Charge of	GAE	3\20\19

STANTEC CONSULTING SERVICES INC.  
 482 PAYNE ROAD  
 SCARBOROUGH, ME 04074  
 TEL (207) 887-3448  
 FAX (207) 883-3376

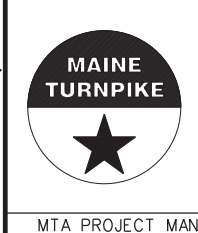

**THE GOLD STAR  
 MEMORIAL HIGHWAY**


**INTERCHANGE 103  
 ORT CONVERSION  
 NB/SB ORT**  
 STA. 4495+50/7495+50 TO STA. 4496+50/7496+50

SHEET NUMBER: XS-39  
 273 OF 503

CONTRACT: 2019.04

Filename: ...100.HIGHWAY\STA...xsect.dgn

Date: 3/20/2019

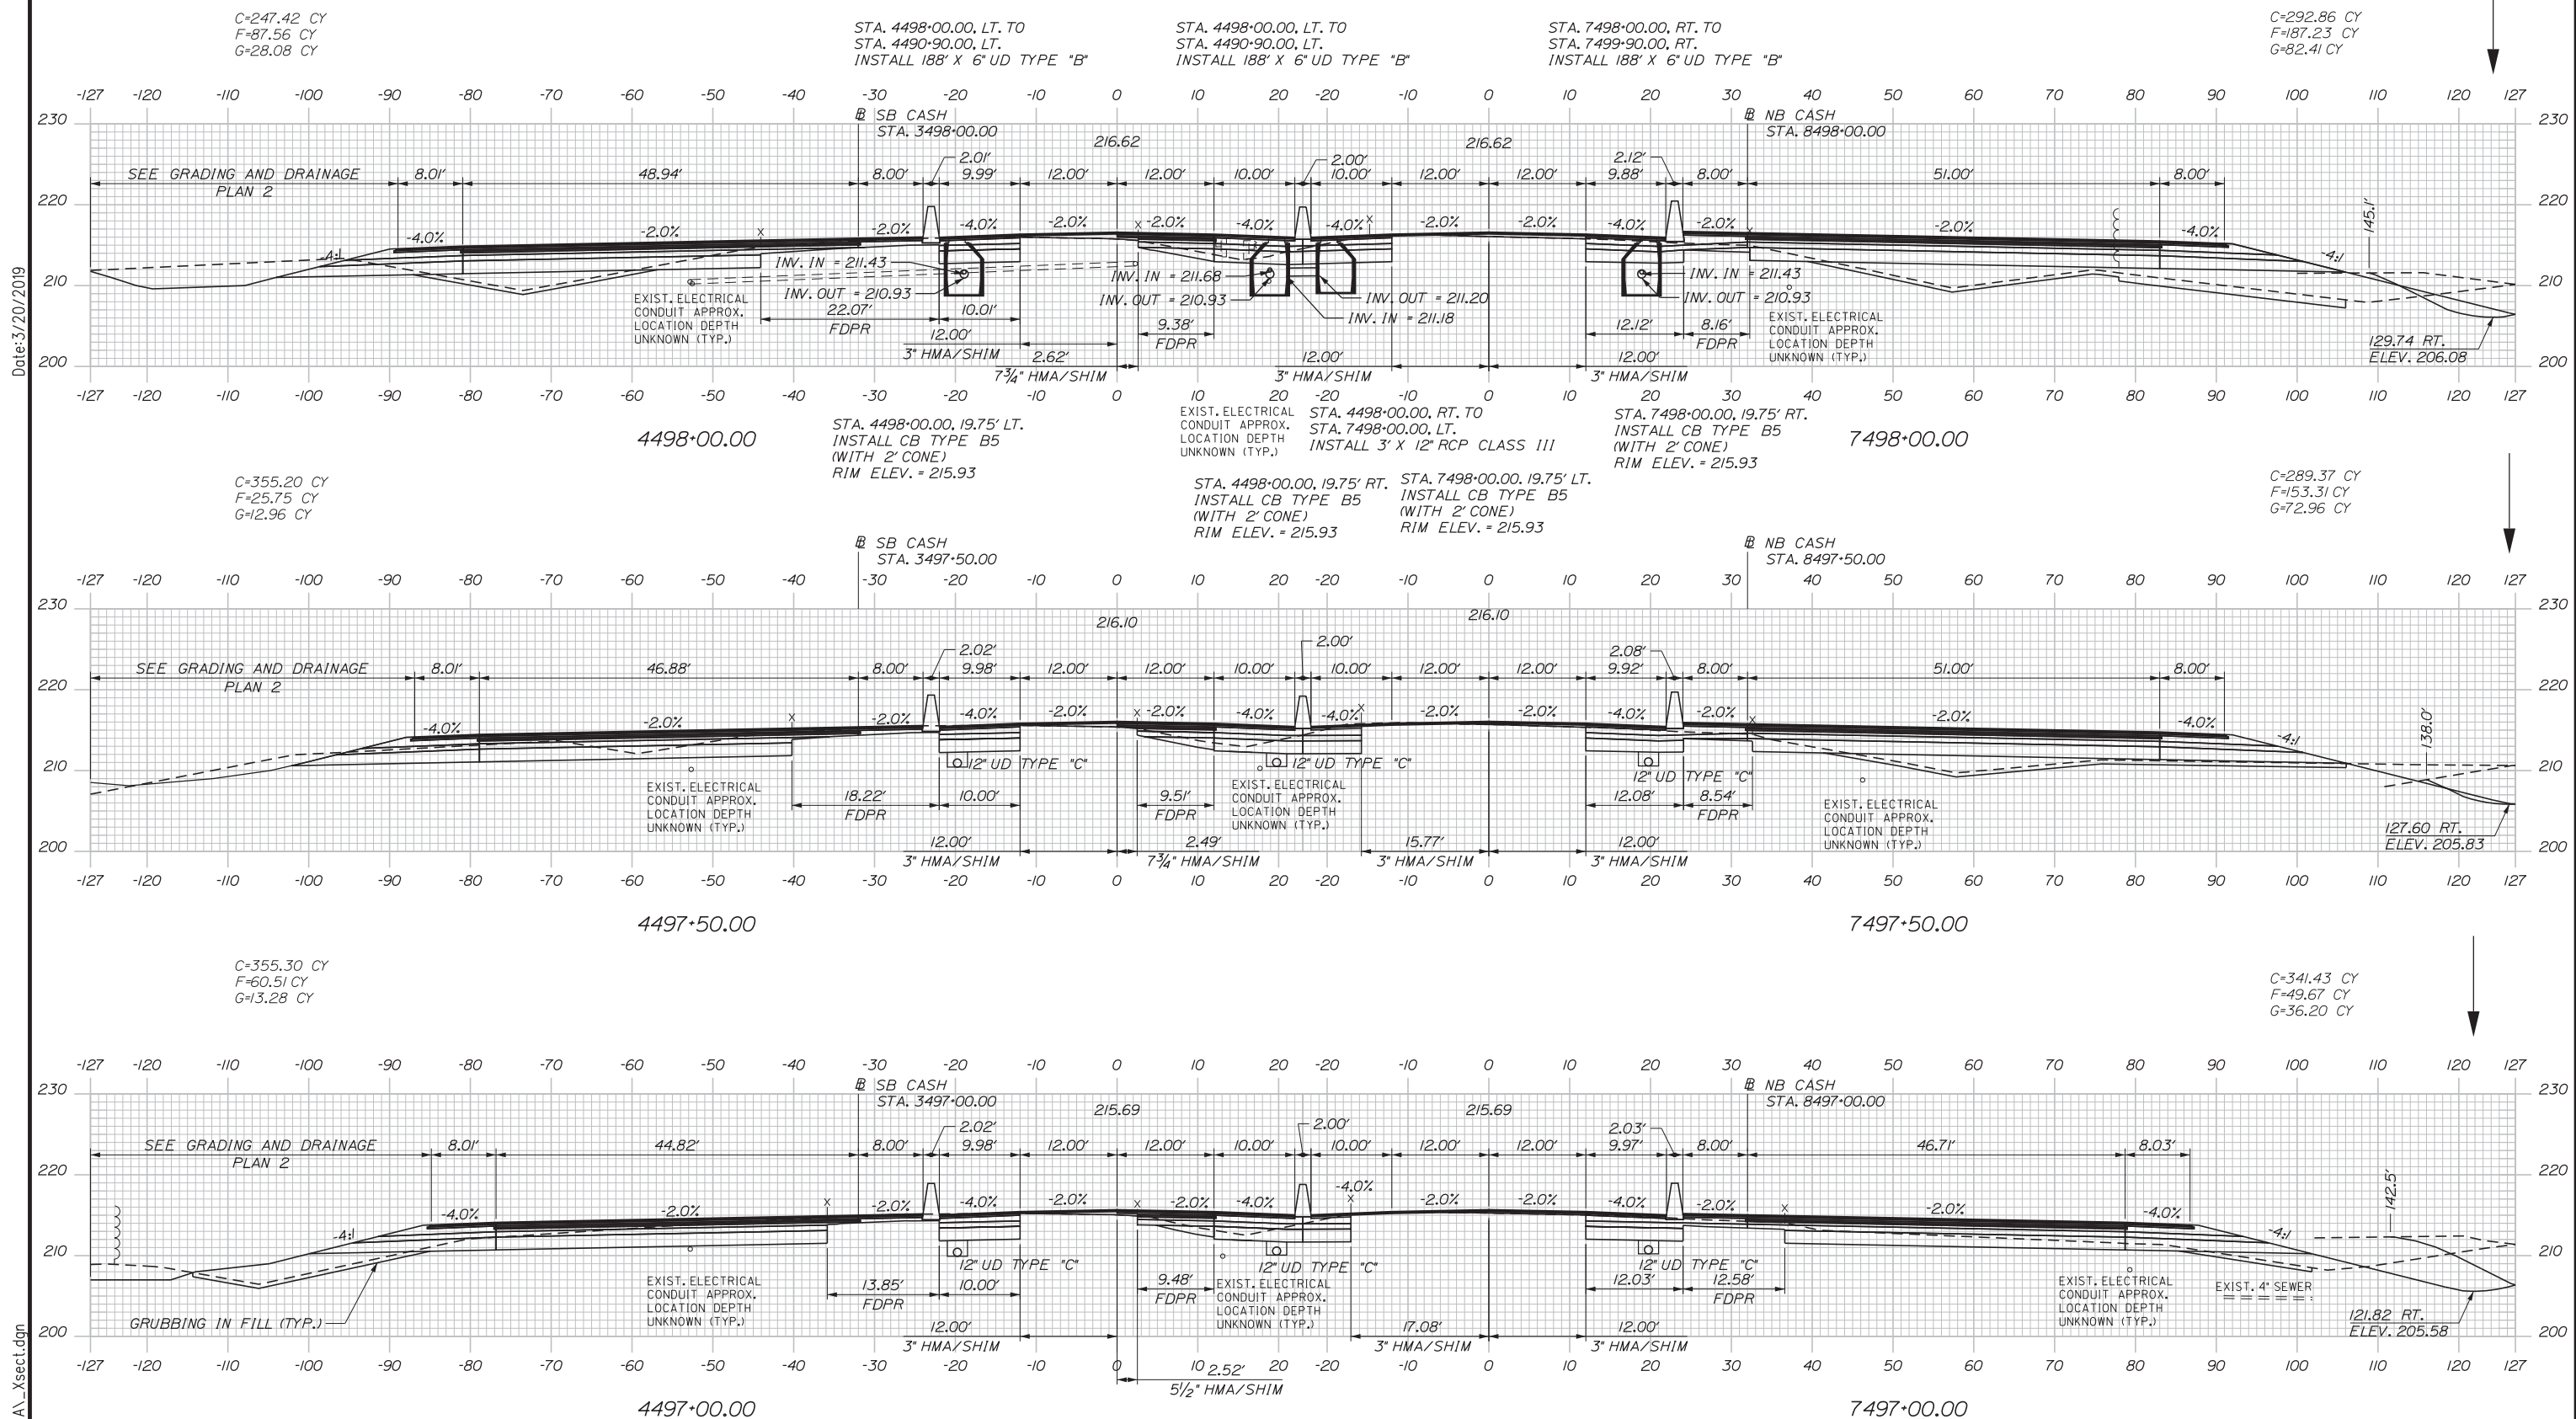

Scale: 10 0 10 20  
Scale of Feet

No.	Revision	By	Date

Designed by:

**Stantec**

CONSULTANT PROJECT MANAGER: LAUREN MEEK, PE

	By	Date		By	Date
Designed	PLP	3\20\19	Checked	LEM	3\20\19
Drawn	EJB	3\20\19	In Charge of	GAE	3\20\19

STANTEC CONSULTING SERVICES INC.  
482 PAYNE ROAD  
SCARBOROUGH, ME 04074  
TEL (207) 887-3448  
FAX (207) 883-3376



**THE GOLD STAR  
MEMORIAL HIGHWAY**


INTERCHANGE 103  
ORT CONVERSION  
NB/SB ORT  
STA. 4497+00/7497+00 TO STA. 4498+00/7498+00

SHEET NUMBER: XS-40  
CONTRACT: 2019.04  
274 OF 503

Filename: ...100\HIGHWAY\MSTA1\...xsect.dgn



Date: 3/20/2019

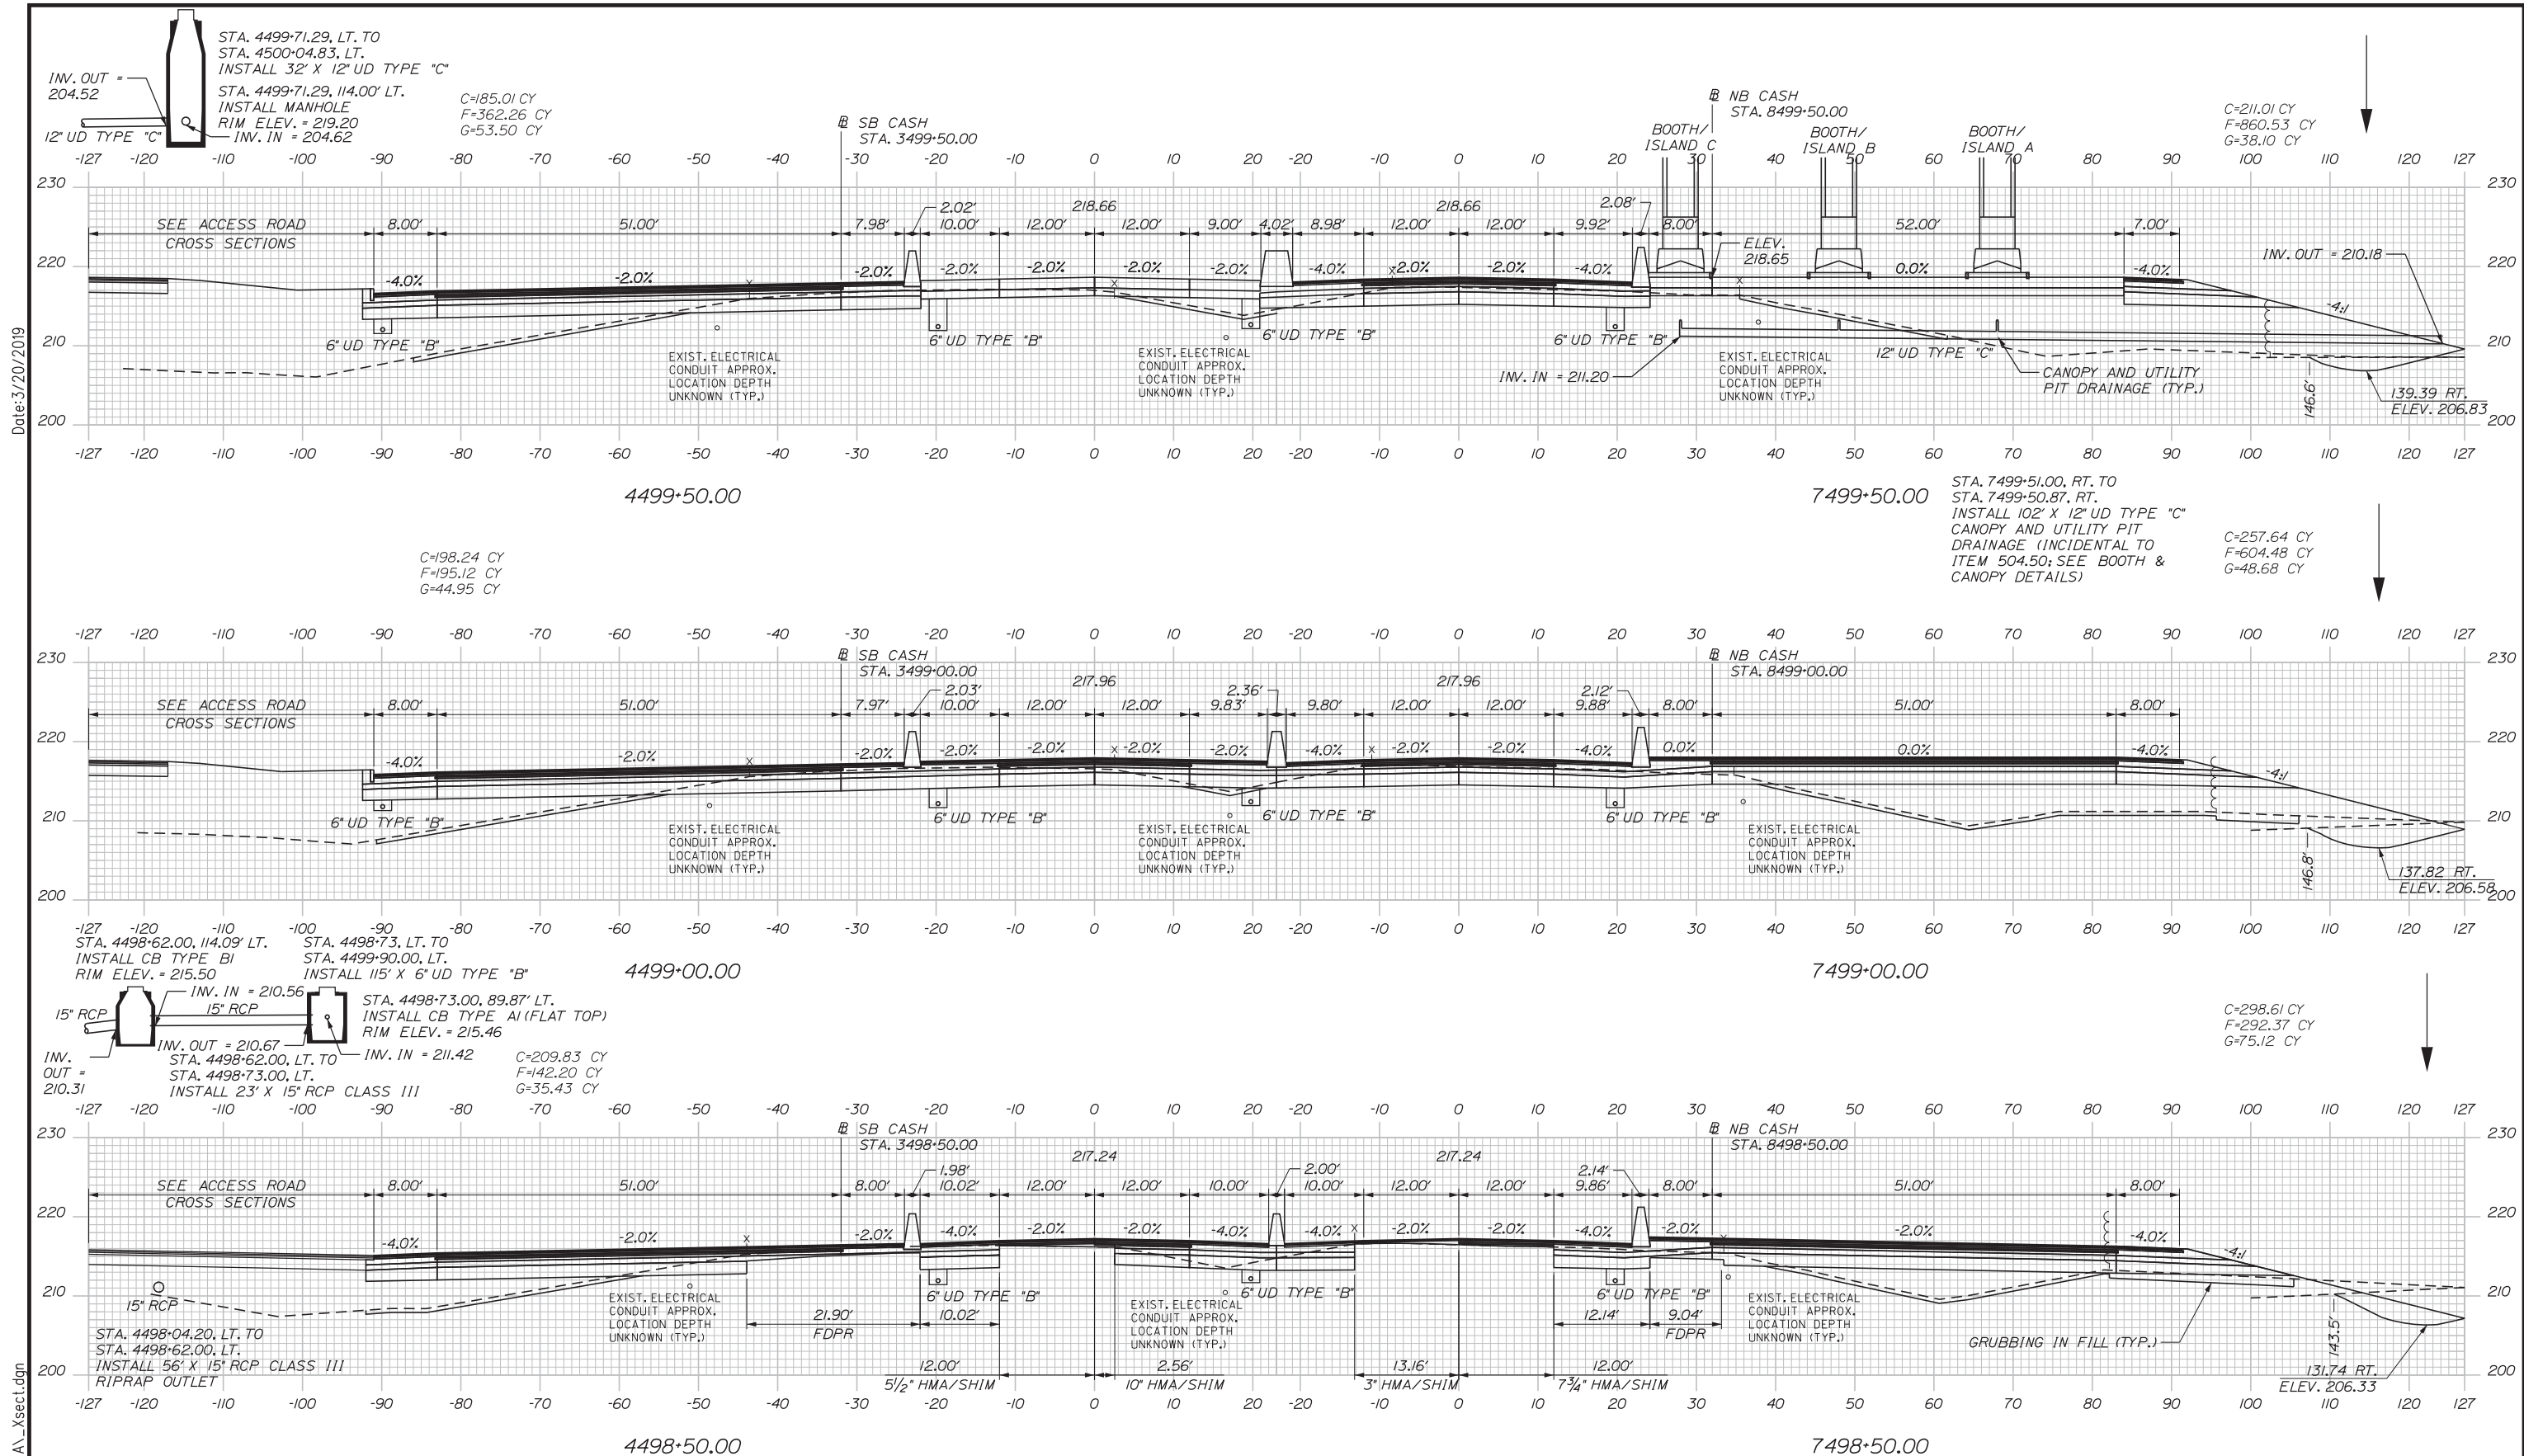

Scale: 10 0 10 20  
Scale of Feet

No.	Revision	By	Date

Designed by: **Stantec**

CONSULTANT PROJECT MANAGER: LAUREN MEEK, PE

	By	Date		By	Date
Designed	PLP	3\20\19	Checked	LEM	3\20\19
Drawn	EJB	3\20\19	In Charge of	GAE	3\20\19

STANTEC CONSULTING SERVICES INC.  
482 PAYNE ROAD  
SCARBOROUGH, ME 04074  
TEL (207) 887-3448  
FAX (207) 883-3376

**MAINE TURNPIKE**

**THE GOLD STAR MEMORIAL HIGHWAY**

MTA PROJECT MANAGER: RALPH NORWOOD, IV, PE, PTOE




INTERCHANGE 103  
ORT CONVERSION  
NB/SB ORT  
STA. 4498+50/7498+50 TO STA. 4499+50/7499+50

SHEET NUMBER: XS-41  
275 OF 503

CONTRACT: 2019.04

Filename: ...100\HIGHWAY\MSTA1...xsect.dgn

Date: 3/20/2019

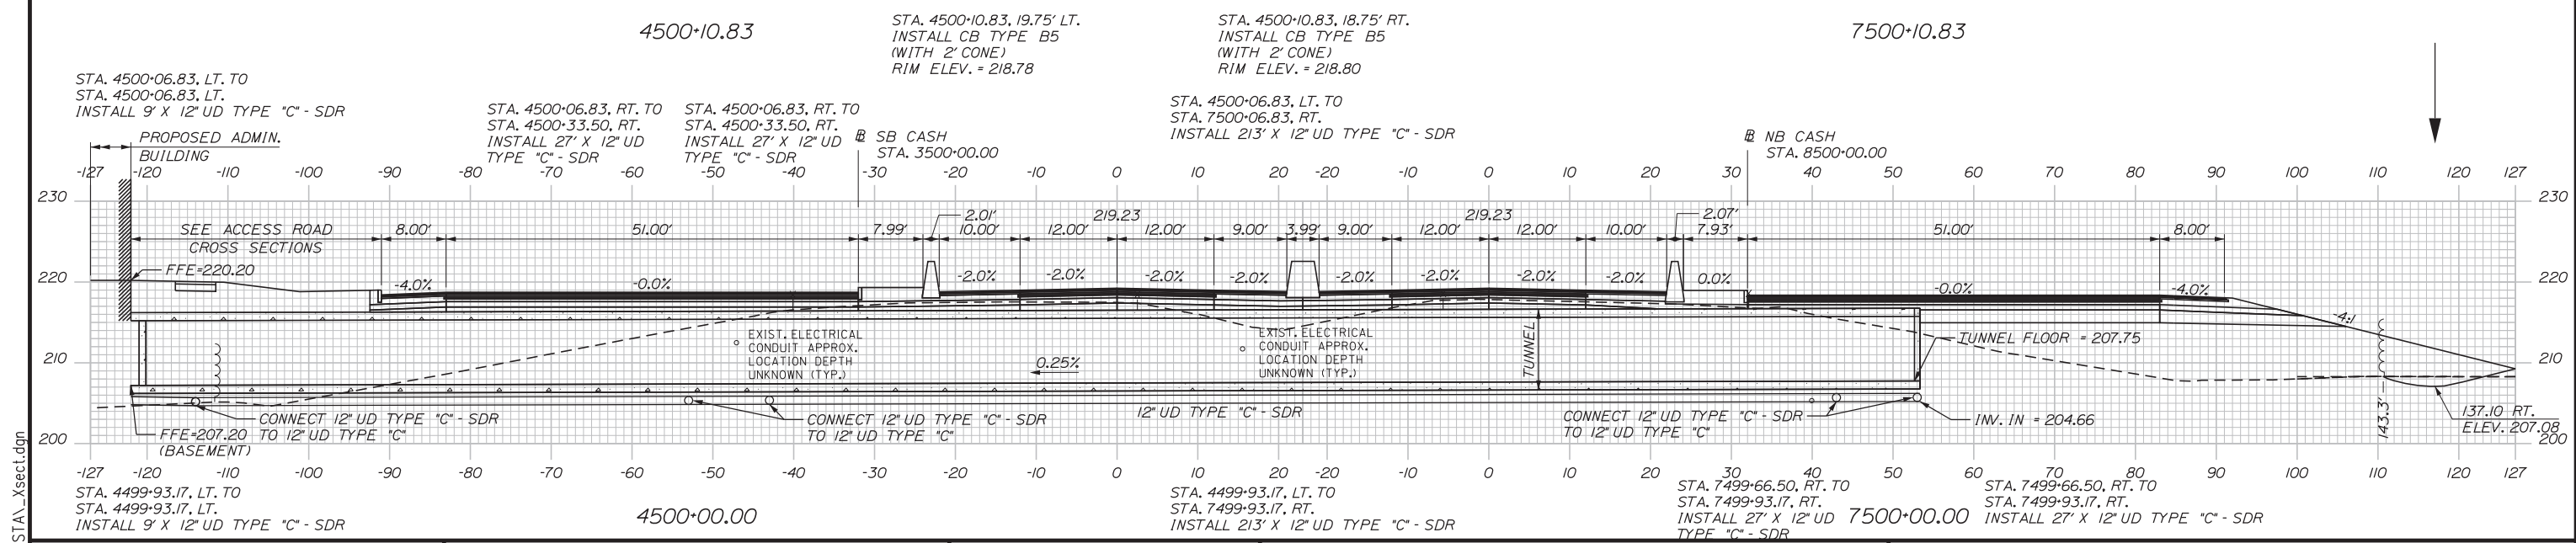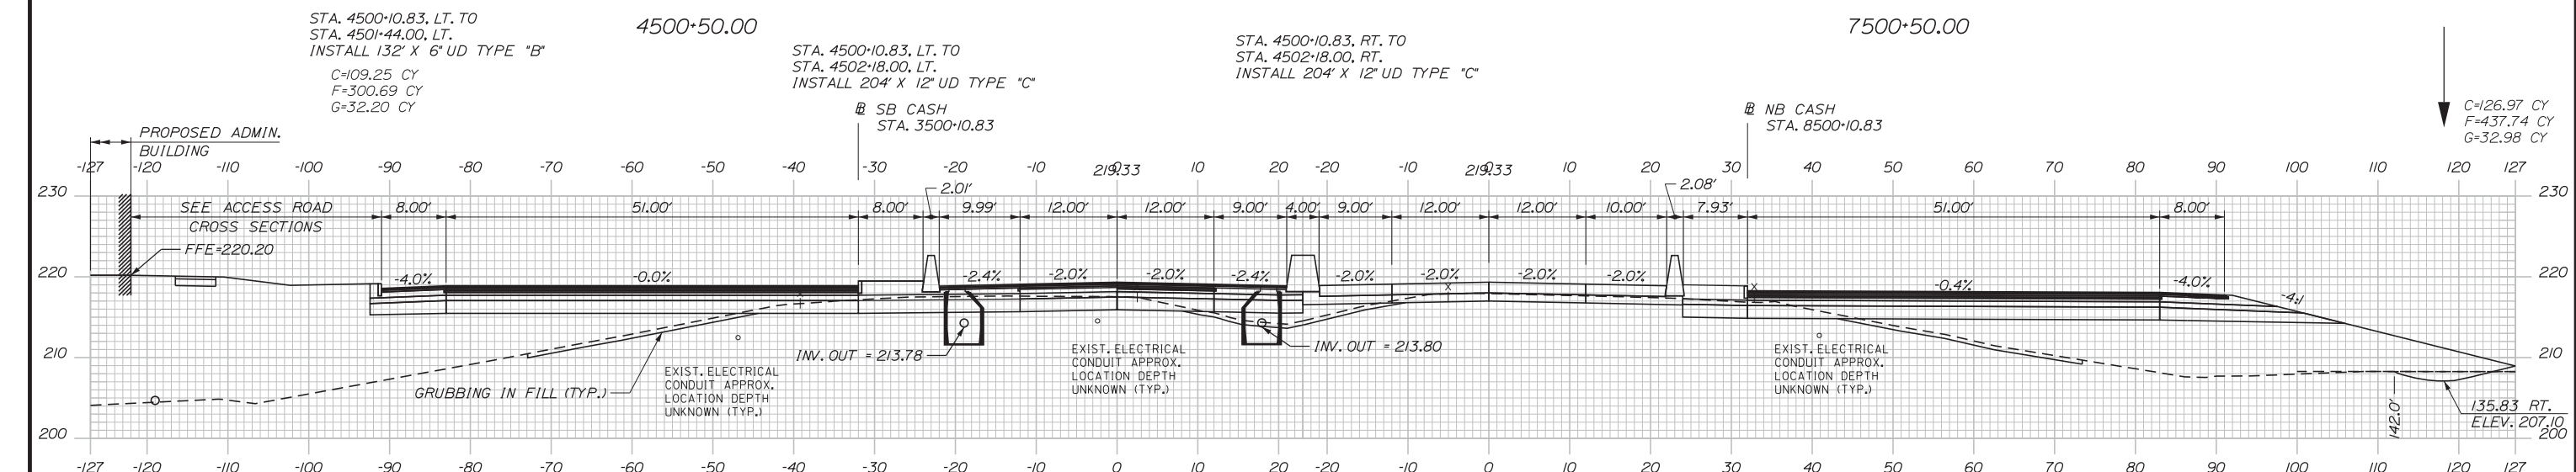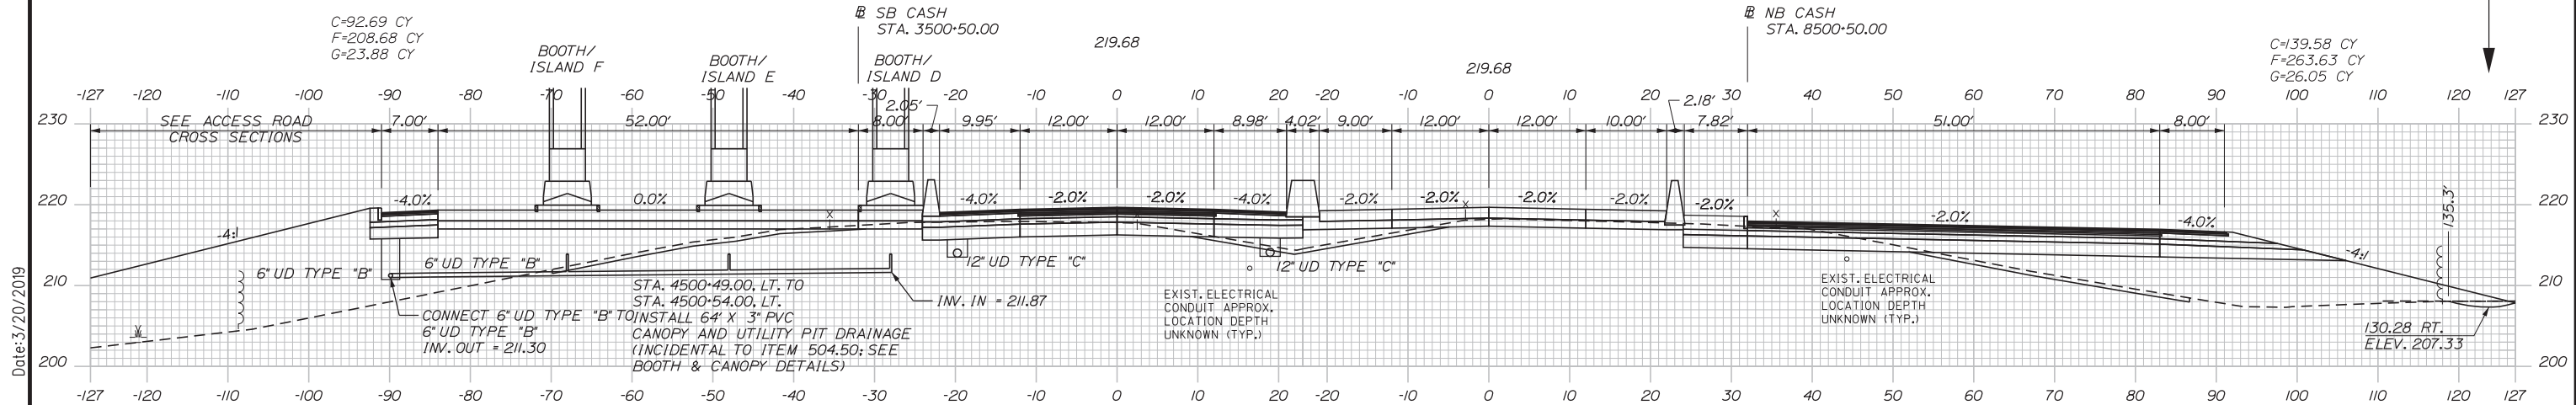

Scale: 10 0 10 20  
Scale of Feet

No.	Revision	By	Date

Designed by:

**Stantec**

CONSULTANT PROJECT MANAGER: LAUREN MEEK, PE

	By	Date		By	Date
Designed	PLP	3\20\19	Checked	LEM	3\20\19
Drawn	EJB	3\20\19	In Charge of	GAE	3\20\19

STANTEC CONSULTING SERVICES INC.  
482 PAYNE ROAD  
SCARBOROUGH, ME 04074  
TEL (207) 887-3448  
FAX (207) 883-3376

**MAINE TURNPIKE**

**THE GOLD STAR MEMORIAL HIGHWAY**

MTA PROJECT MANAGER: RALPH NORWOOD, IV, PE, PTOE


INTERCHANGE 103  
ORT CONVERSION  
NB/SB ORT  
STA. 4500+00/7500+00 TO STA. 4501+00/7501+00

SHEET NUMBER: XS-42  
CONTRACT: 2019.04  
276 OF 503

Filename: ...100.HIGHWAY\MSTA...xsect.dgn

Date: 3/20/2019

Filename: ...100.HIGHWAY\MSTA...xsect.dgn

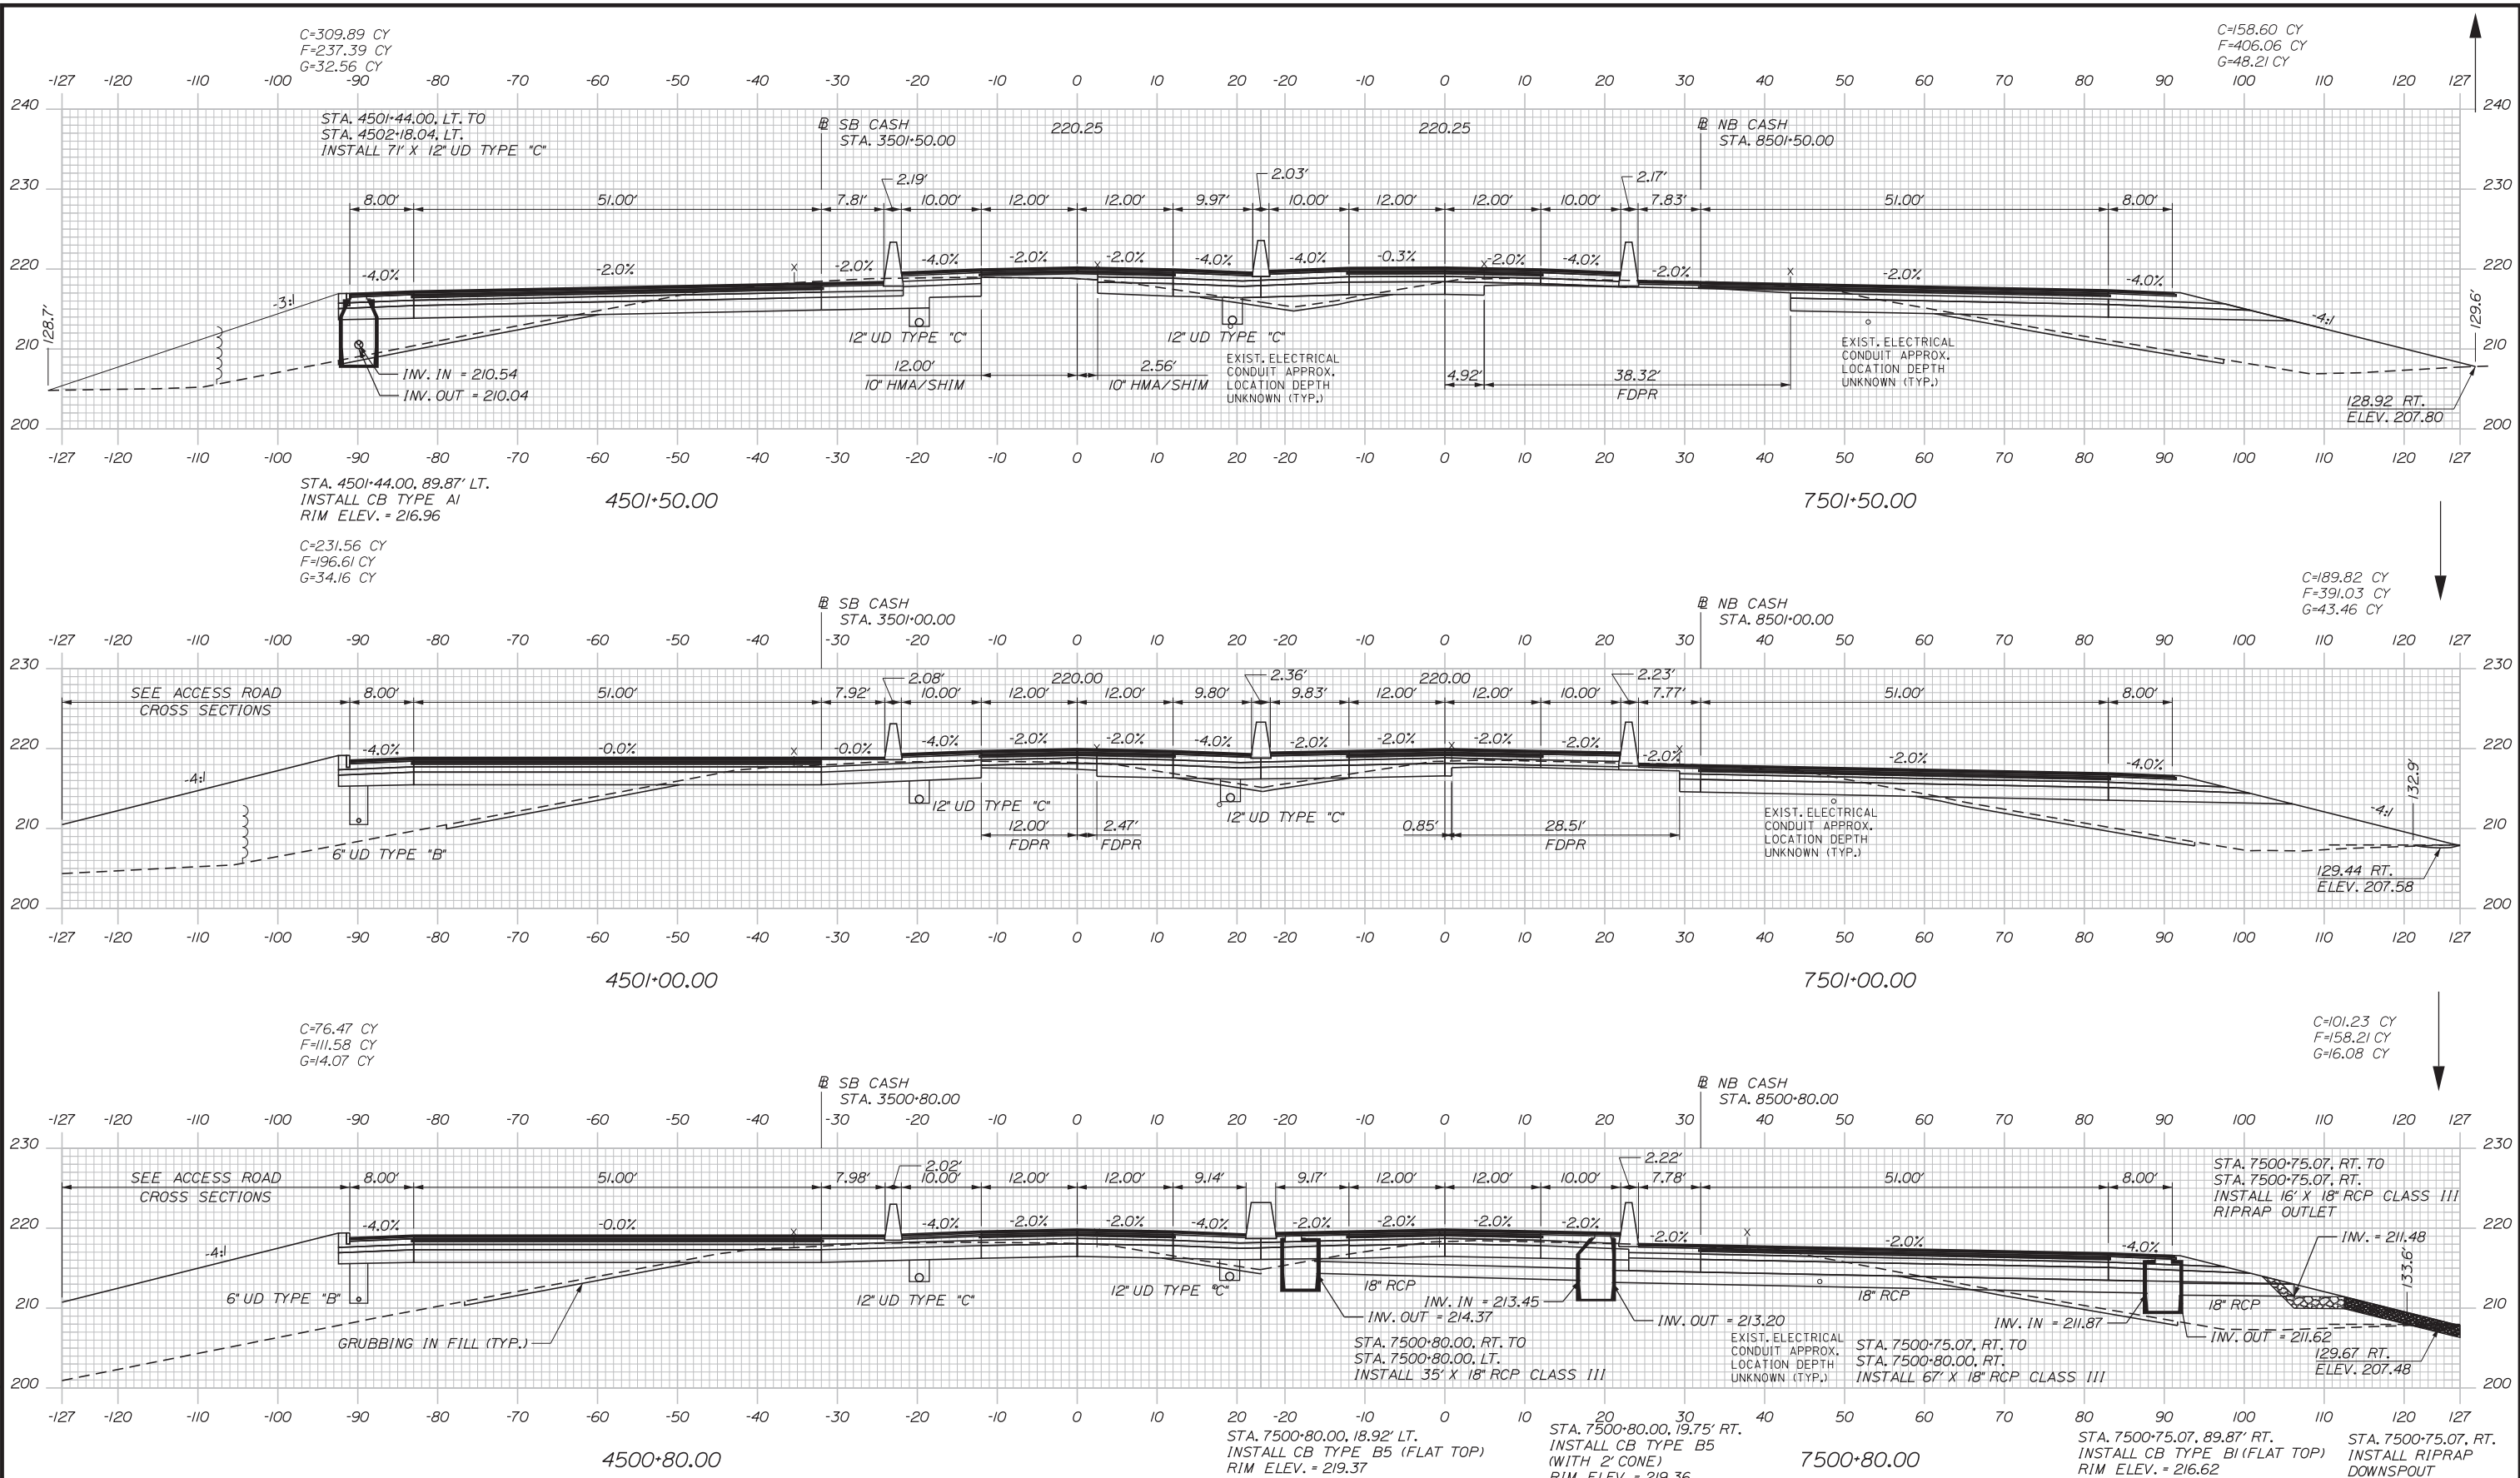

Scale: 10 0 10 20  
Scale of Feet

No.	Revision	By	Date

Designed by:

**Stantec**

CONSULTANT PROJECT MANAGER: LAUREN MEEK, PE

	By	Date		By	Date
Designed	PLP	3\20\19	Checked	LEM	3\20\19
Drawn	EJB	3\20\19	In Charge of	GAE	3\20\19

STANTEC CONSULTING SERVICES INC.  
482 PAYNE ROAD  
SCARBOROUGH, ME 04074  
TEL (207) 887-3448  
FAX (207) 883-3376

**MAINE TURNPIKE**

**THE GOLD STAR MEMORIAL HIGHWAY**

MTA PROJECT MANAGER: RALPH NORWOOD, IV, PE, PTOE

**INTERCHANGE 103  
ORT CONVERSION  
NB/SB ORT**

STA. 4500+80/7500+80 TO STA. 4501+50/7501+50


SHEET NUMBER: XS-43  
277 OF 503

CONTRACT: 2019.04



Date: 3/20/2019

Filename: ...00\HIGHWAY\STA...xsect.dgn

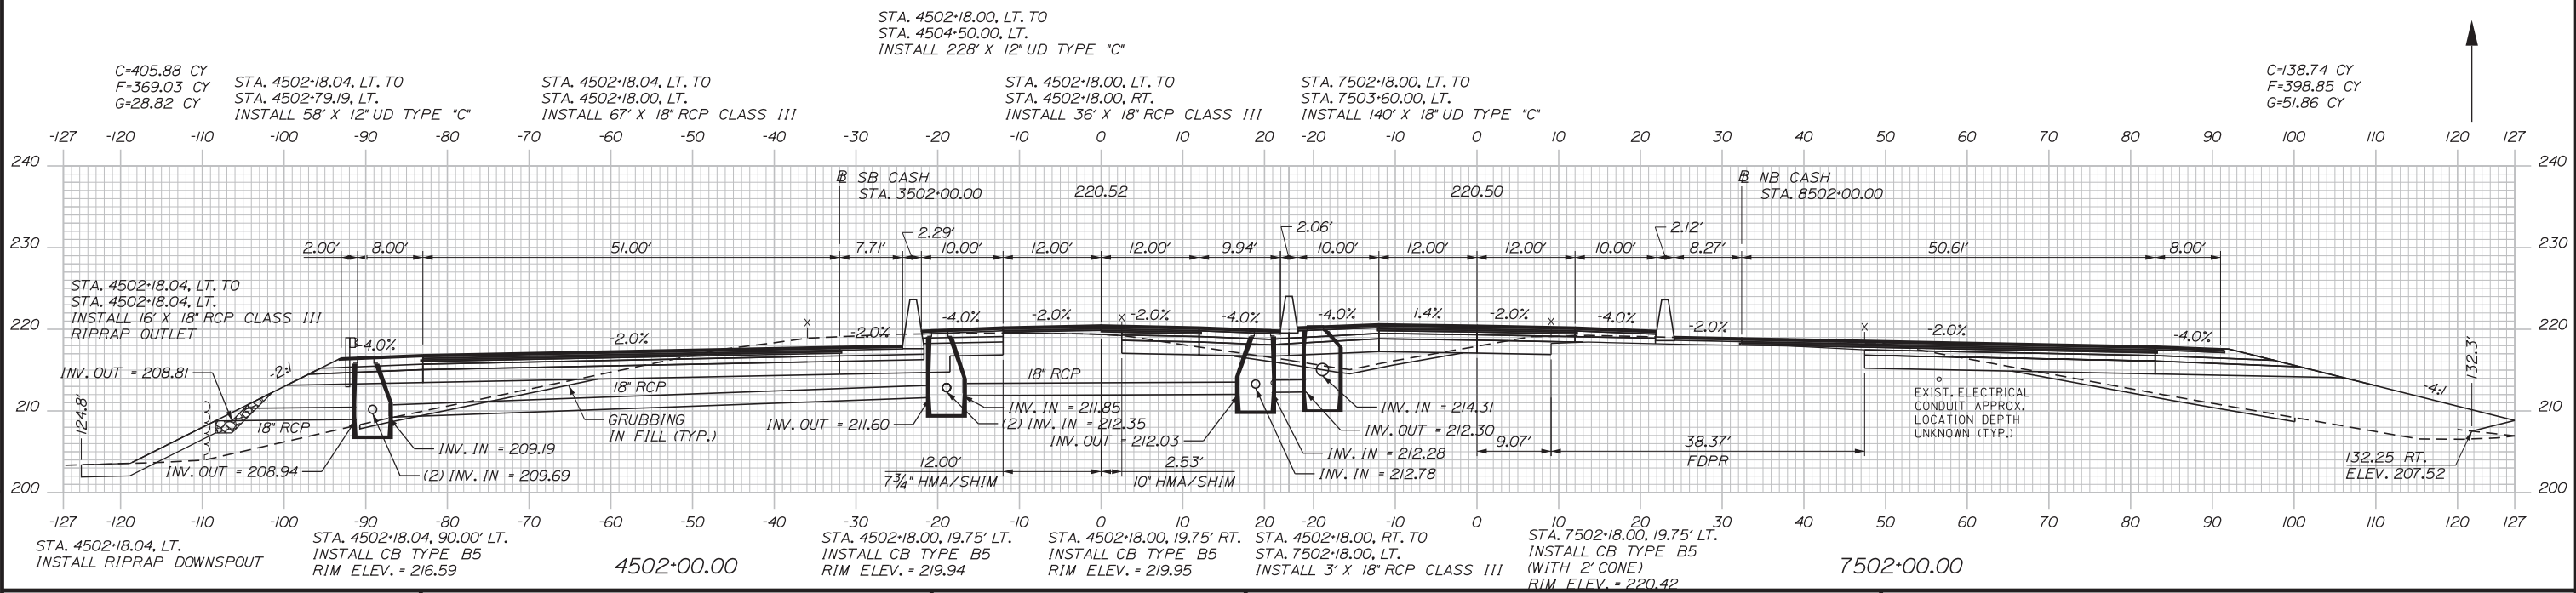

Scale: 10 0 10 20  
Scale of Feet

No.	Revision	By	Date

Designed by:

CONSULTANT PROJECT MANAGER: LAUREN MEEK, PE

	By	Date		By	Date
Designed	PLP	3\20\19	Checked	LEM	3\20\19
Drawn	EJB	3\20\19	In Charge of	GAE	3\20\19

STANTEC CONSULTING SERVICES INC.  
482 PAYNE ROAD  
SCARBOROUGH, ME 04074  
TEL (207) 887-3448  
FAX (207) 883-3376

**THE GOLD STAR MEMORIAL HIGHWAY**


MTA PROJECT MANAGER: RALPH NORWOOD, IV, PE, PTOE

**INTERCHANGE 103  
ORT CONVERSION  
NB/SB ORT**  
STA. 4502+00/7502+00 TO STA. 4502+00/7502+00



SHEET NUMBER: XS-44  
CONTRACT: 2019.04  
278 OF 503

Date: 3/20/2019

C=369.65 CY  
 F=622.58 CY  
 G=23.05 CY  
 M=82.23 CY

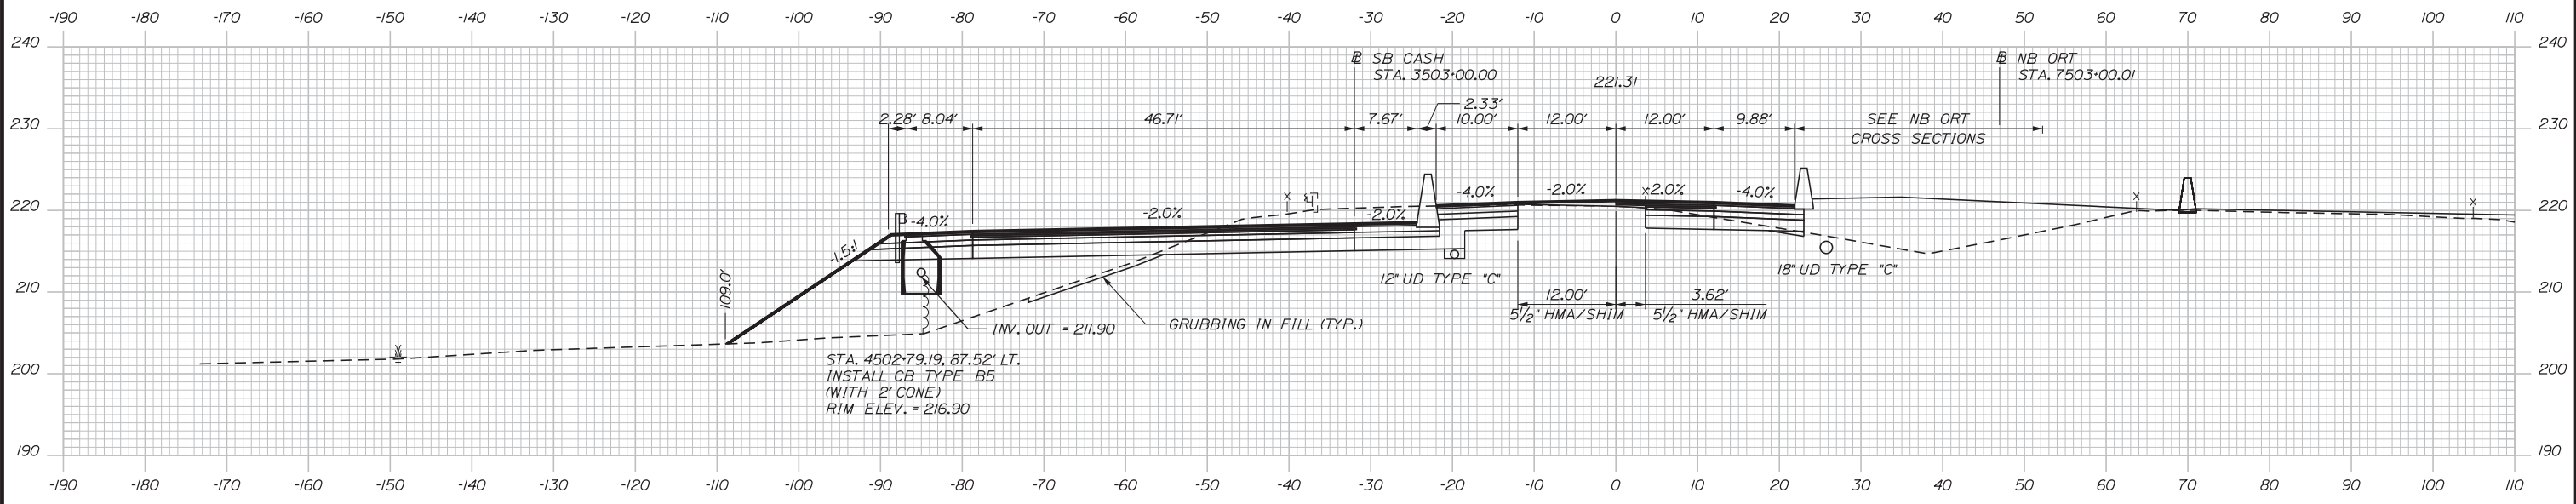

 C=420.45 CY  
 F=453.35 CY  
 G=22.15 CY

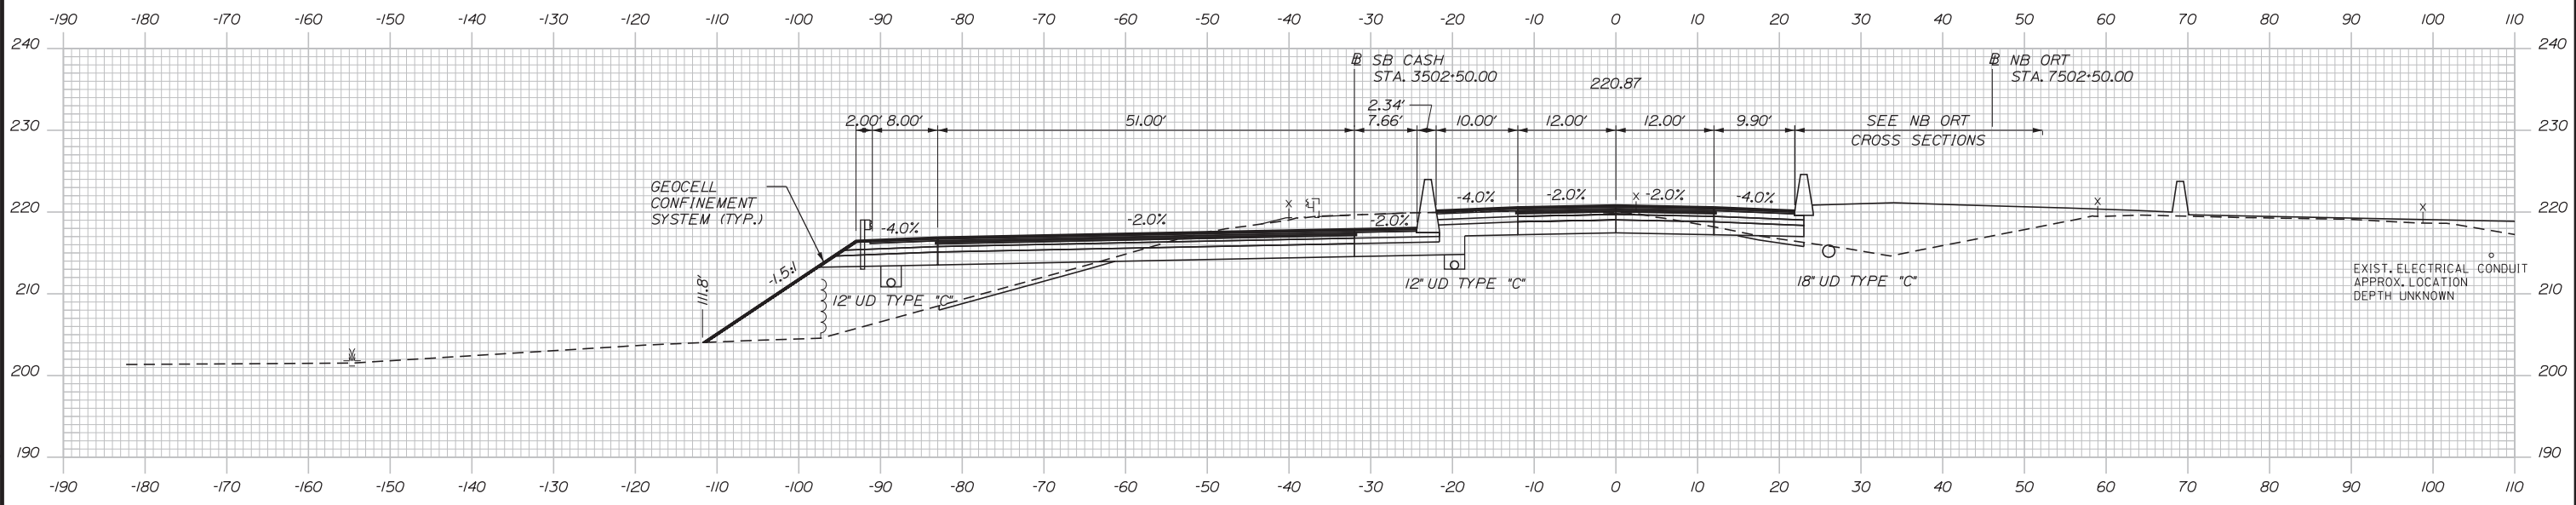

Designed by:

**Stantec**

CONSULTANT PROJECT MANAGER: LAUREN MEEK, PE

No.	Revision	By	Date

By	Date	By	Date
Designed	PLP 3\20\19	Checked	LEM 3\20\19
Drawn	EJB 3\20\19	In Charge of	GAE 3\20\19

STANTEC CONSULTING SERVICES INC.  
 482 PAYNE ROAD  
 SCARBOROUGH, ME 04074  
 TEL (207) 887-3448  
 FAX (207) 883-3376

**MAINE TURNPIKE**

**THE GOLD STAR MEMORIAL HIGHWAY**

MTA PROJECT MANAGER: RALPH NORWOOD, IV, PE, PTOE


INTERCHANGE 103  
 ORT CONVERSION  
 SB ORT  
 STA. 4502+50.00 TO STA. 4503+00.00

SHEET NUMBER: XS-45  
 279 OF 503

CONTRACT: 2019.04


Filename: ...00\HIGHWAY\MSTA\\_xsect.dgn

Date: 3/20/2019

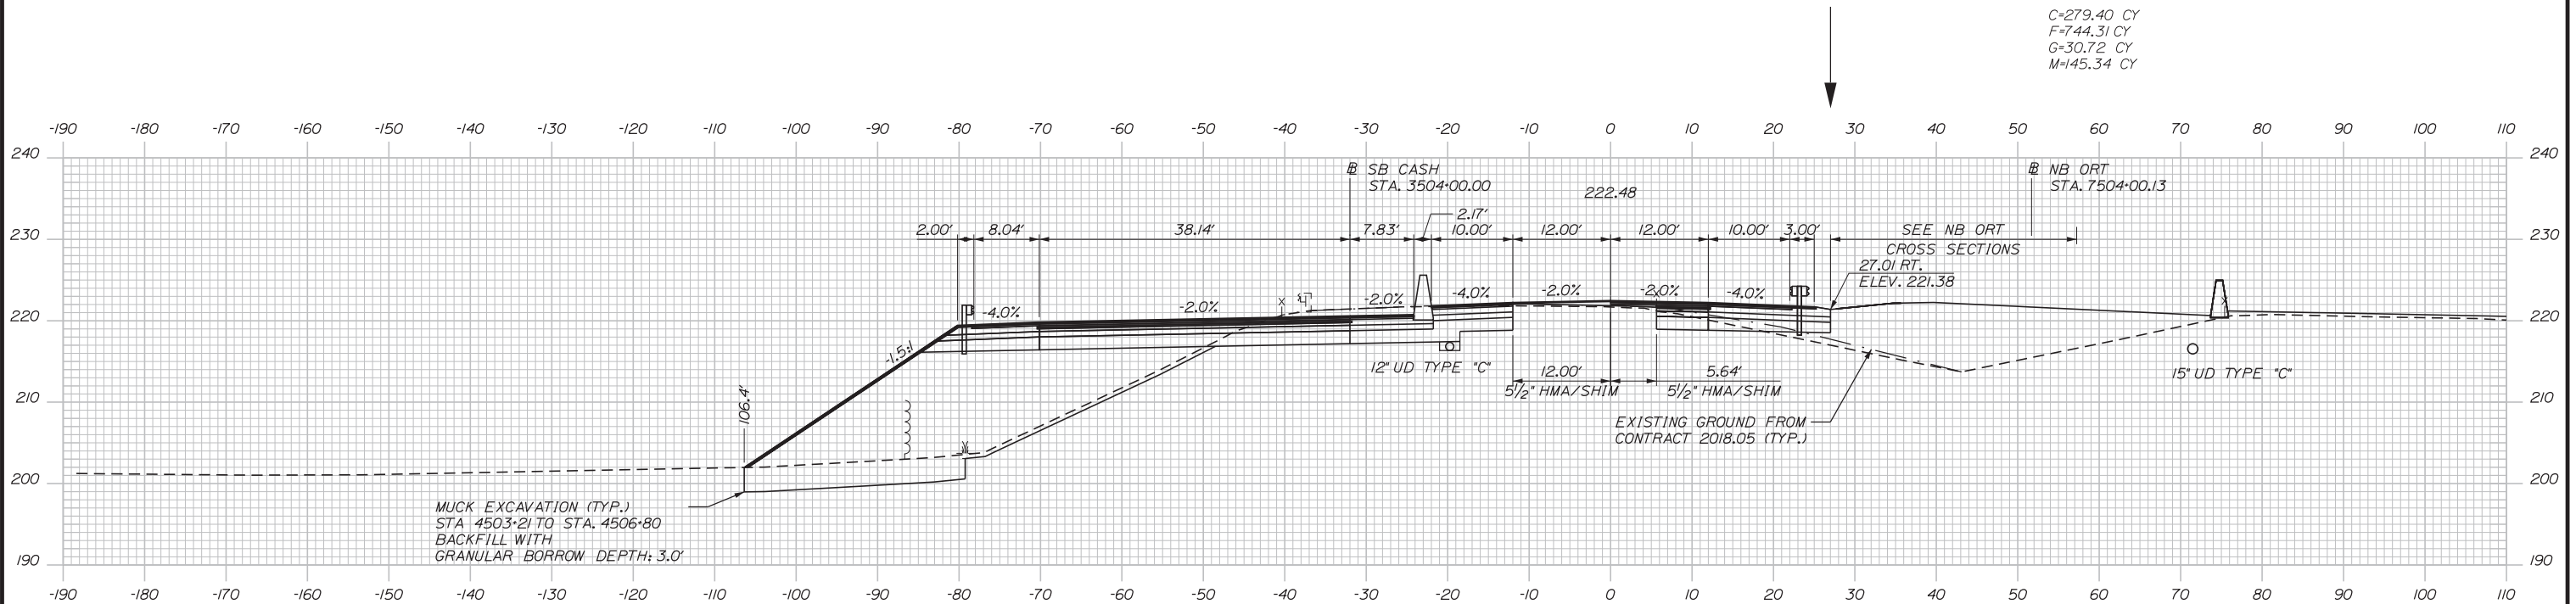


C=279.40 CY  
 F=744.31 CY  
 G=30.72 CY  
 M=145.34 CY

4504+00.00

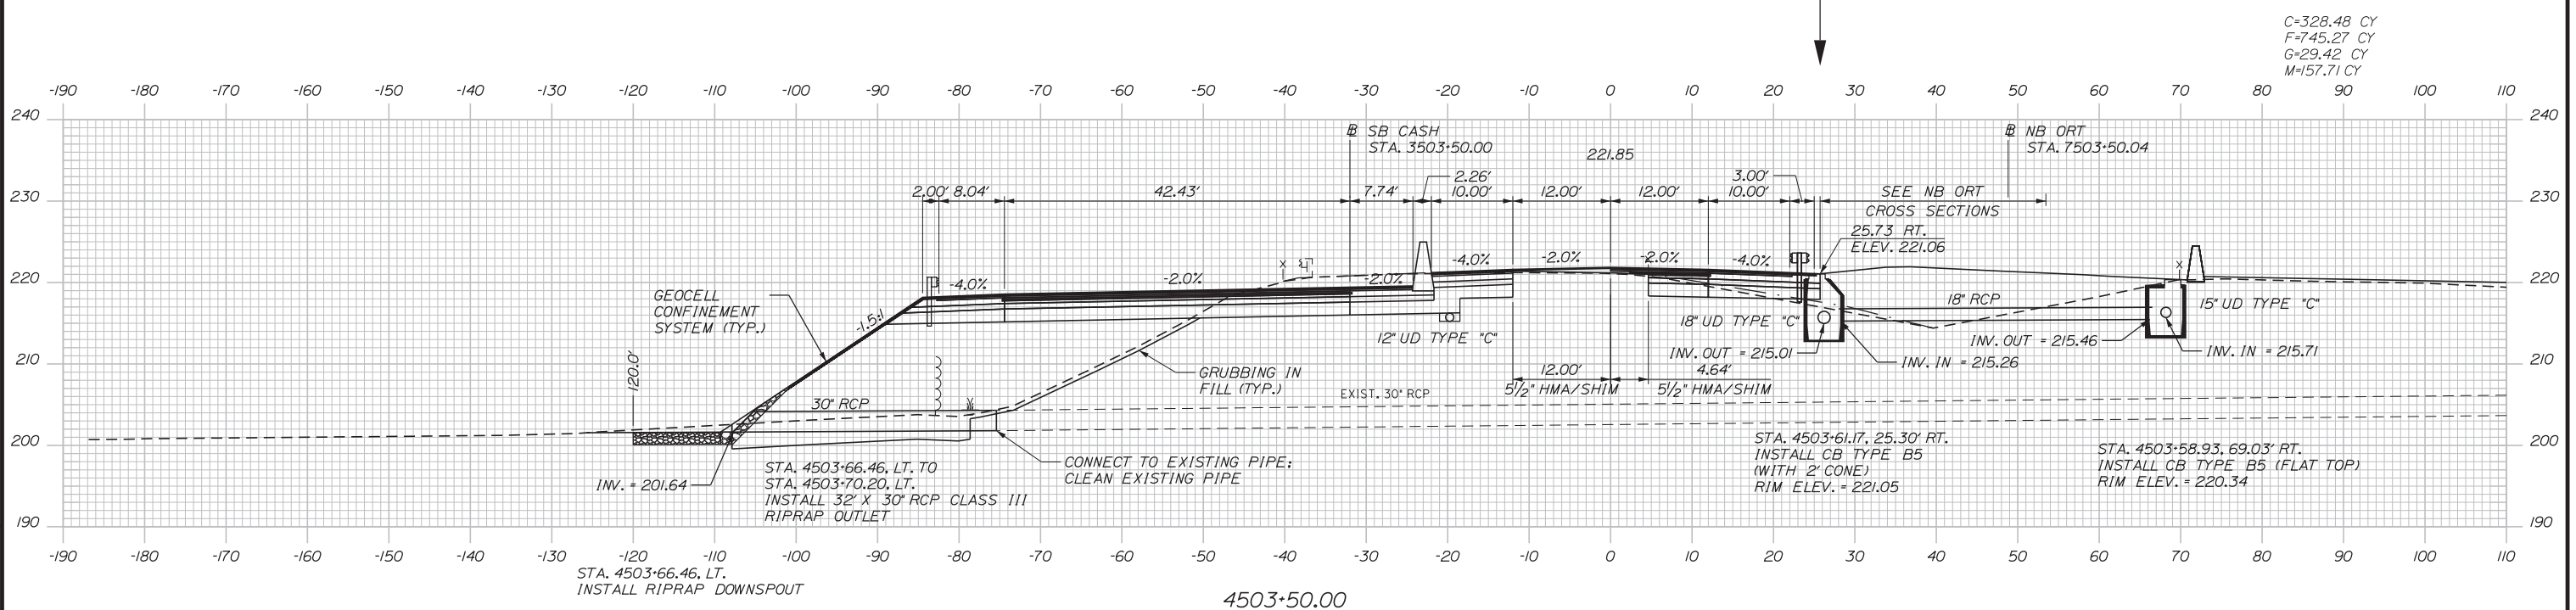

C=328.48 CY  
 F=745.27 CY  
 G=29.42 CY  
 M=157.71 CY

 4503+50.00



Designed by:

**Stantec**

CONSULTANT PROJECT MANAGER: LAUREN MEEK, PE

No.	Revision	By	Date

	By	Date		By	Date
Designed	PLP	3\20\19	Checked	LEM	3\20\19
Drawn	EJB	3\20\19	In Charge of	GAE	3\20\19

STANTEC CONSULTING SERVICES INC.  
 482 PAYNE ROAD  
 SCARBOROUGH, ME 04074  
 TEL (207) 887-3448  
 FAX (207) 883-3376




**THE GOLD STAR  
 MEMORIAL HIGHWAY**

INTERCHANGE 103  
 ORT CONVERSION  
 SB ORT  
 STA. 4503+50.00 TO STA. 4504+00.00


SHEET NUMBER: XS-46  
 CONTRACT: 2019.04  
 280 OF 503

Filename: ...00\HIGHWAY\MSTA\\_xsect.dgn


Date: 3/20/2019

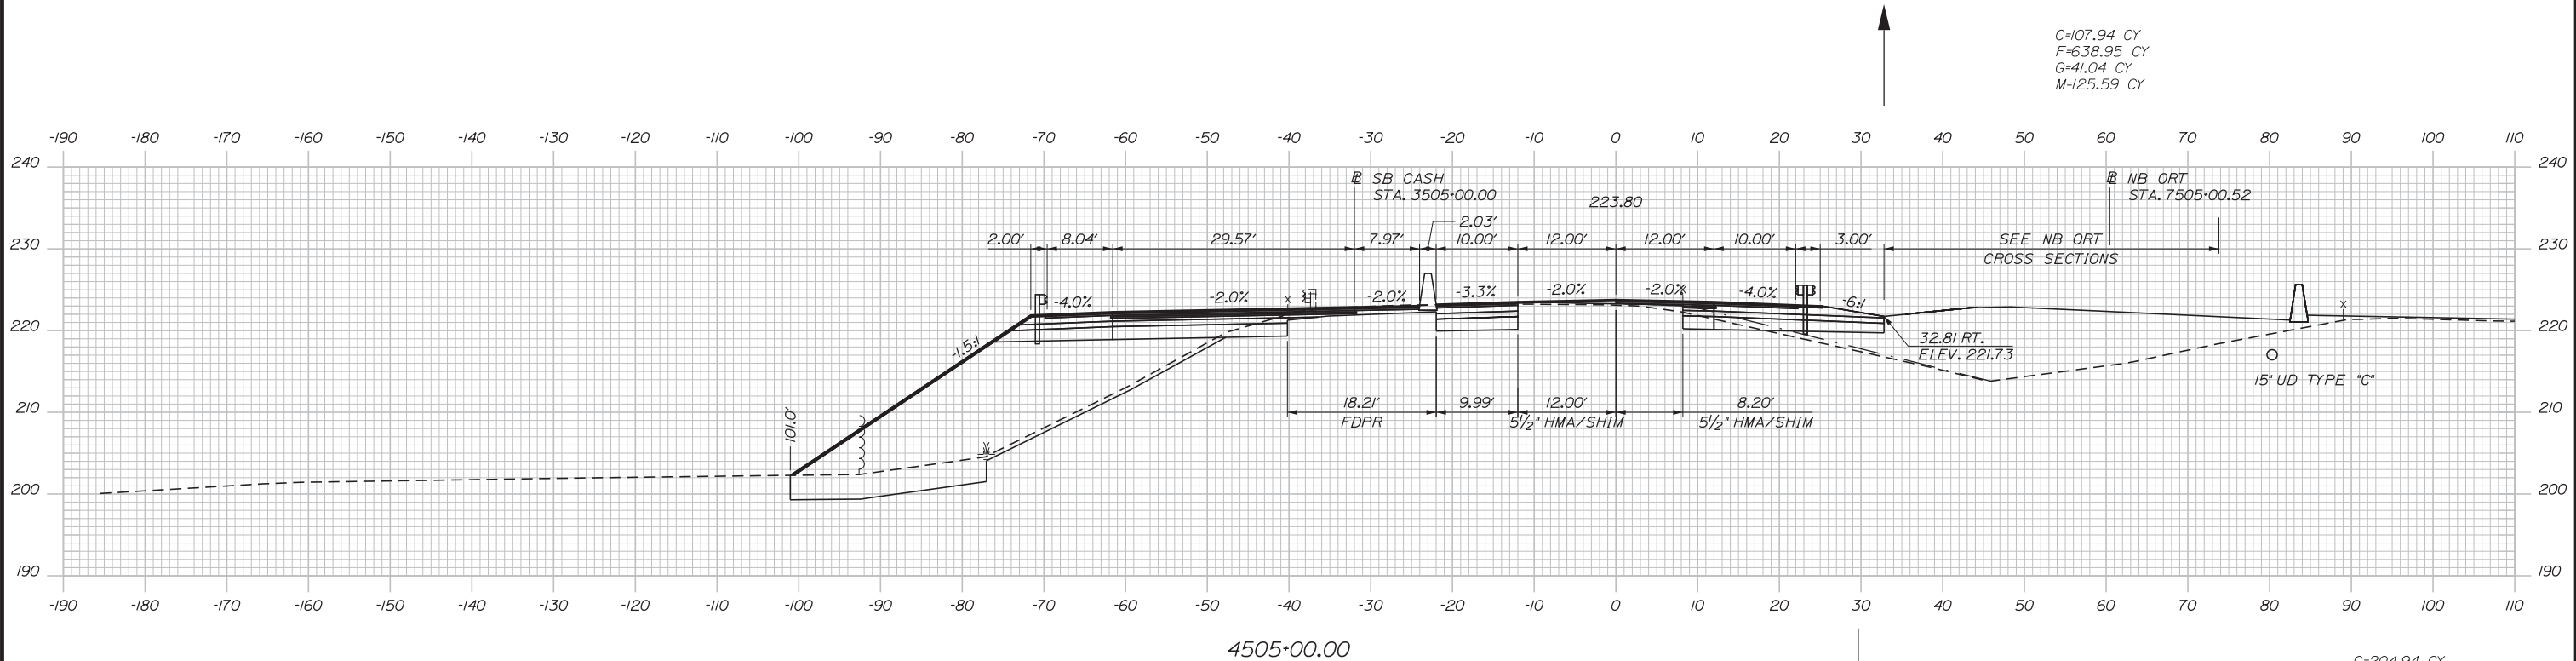

C=107.94 CY  
F=638.95 CY  
G=41.04 CY  
M=125.59 CY

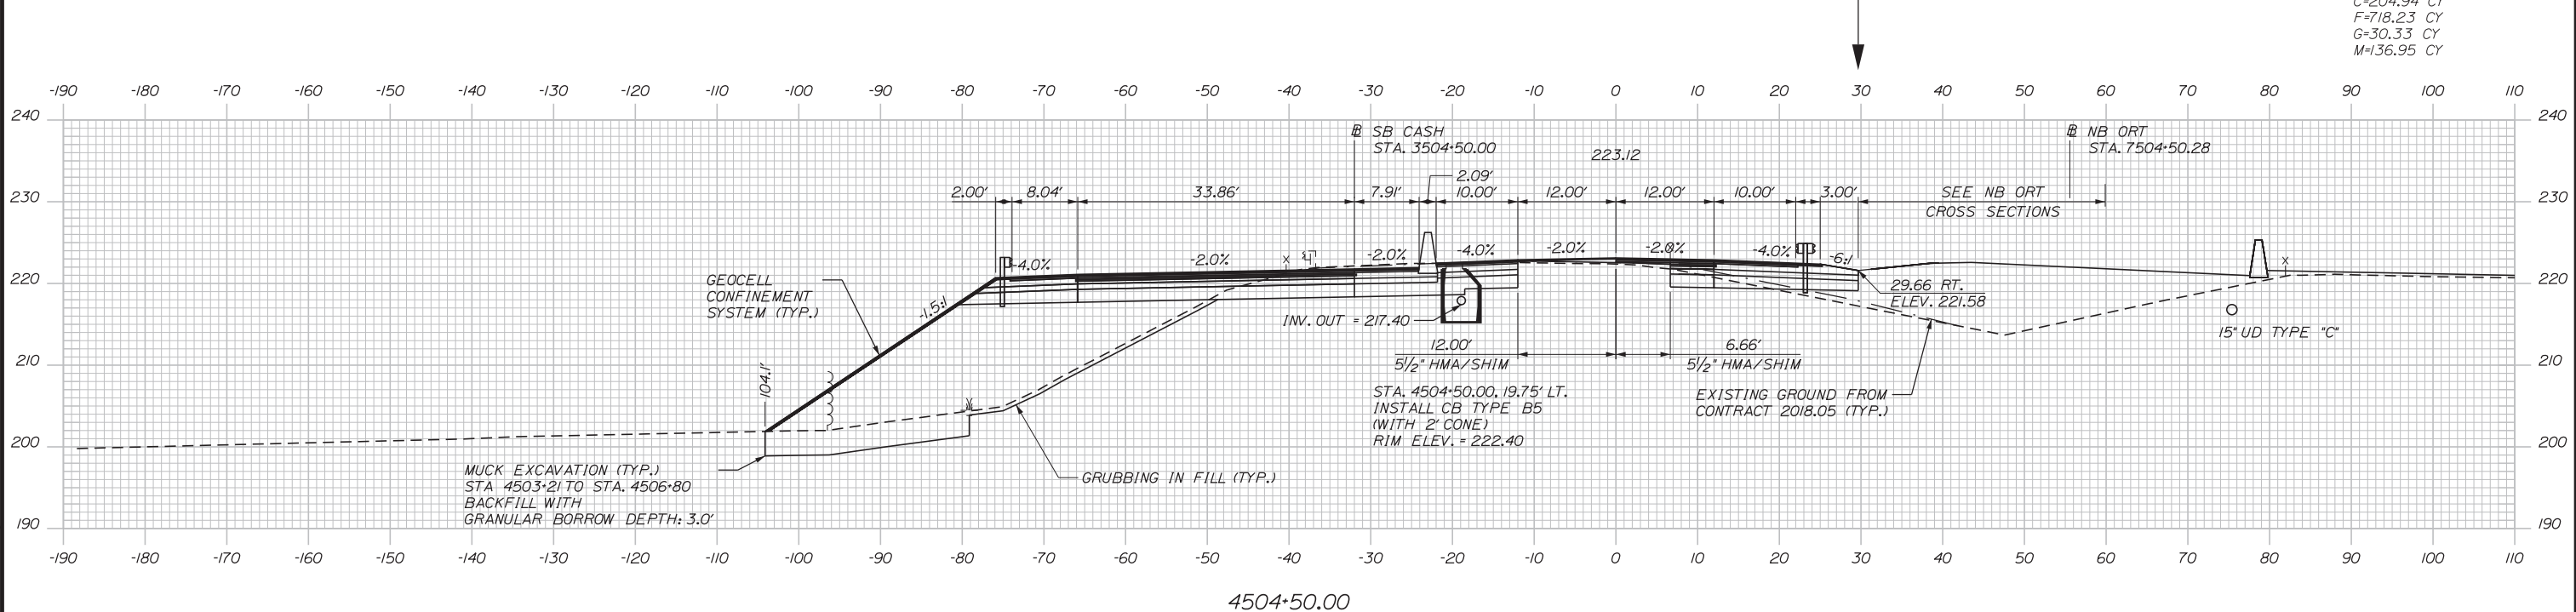

 C=204.94 CY  
F=718.23 CY  
G=30.33 CY  
M=136.95 CY



Designed by:


**Stantec**

CONSULTANT PROJECT MANAGER: LAUREN MEEK, PE

No.	Revision	By	Date

	By	Date		By	Date
Designed	PLP	3\20\19	Checked	LEM	3\20\19
Drawn	EJB	3\20\19	In Charge of	GAE	3\20\19

STANTEC CONSULTING SERVICES INC.  
482 PAYNE ROAD  
SCARBOROUGH, ME 04074  
TEL (207) 887-3448  
FAX (207) 883-3376

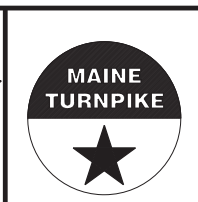


**THE GOLD STAR  
MEMORIAL HIGHWAY**

INTERCHANGE 103  
ORT CONVERSION  
SB ORT  
STA. 4504+50.00 TO STA. 4505+00.00


Filename: ...00.HIGHWAY\MSTA\\_xsect.dgn

Date: 3/20/2019

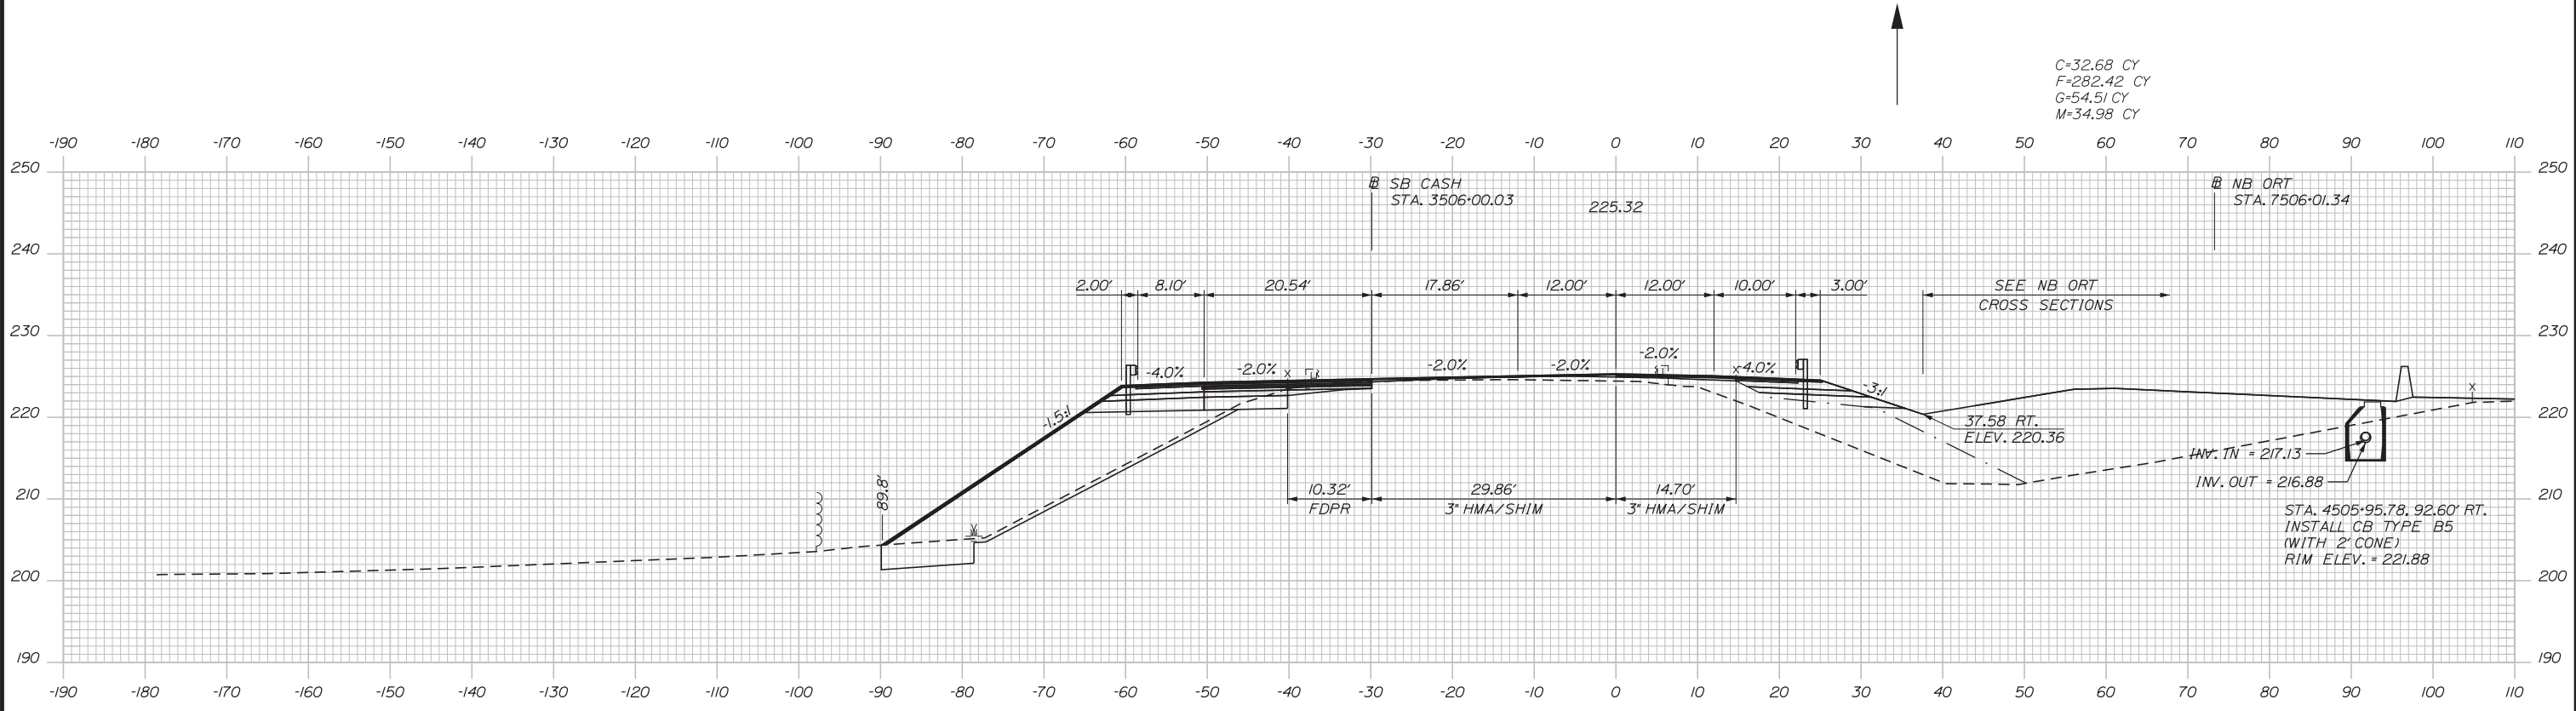


C=32.68 CY  
F=282.42 CY  
G=54.51 CY  
M=34.98 CY

4506+00.00

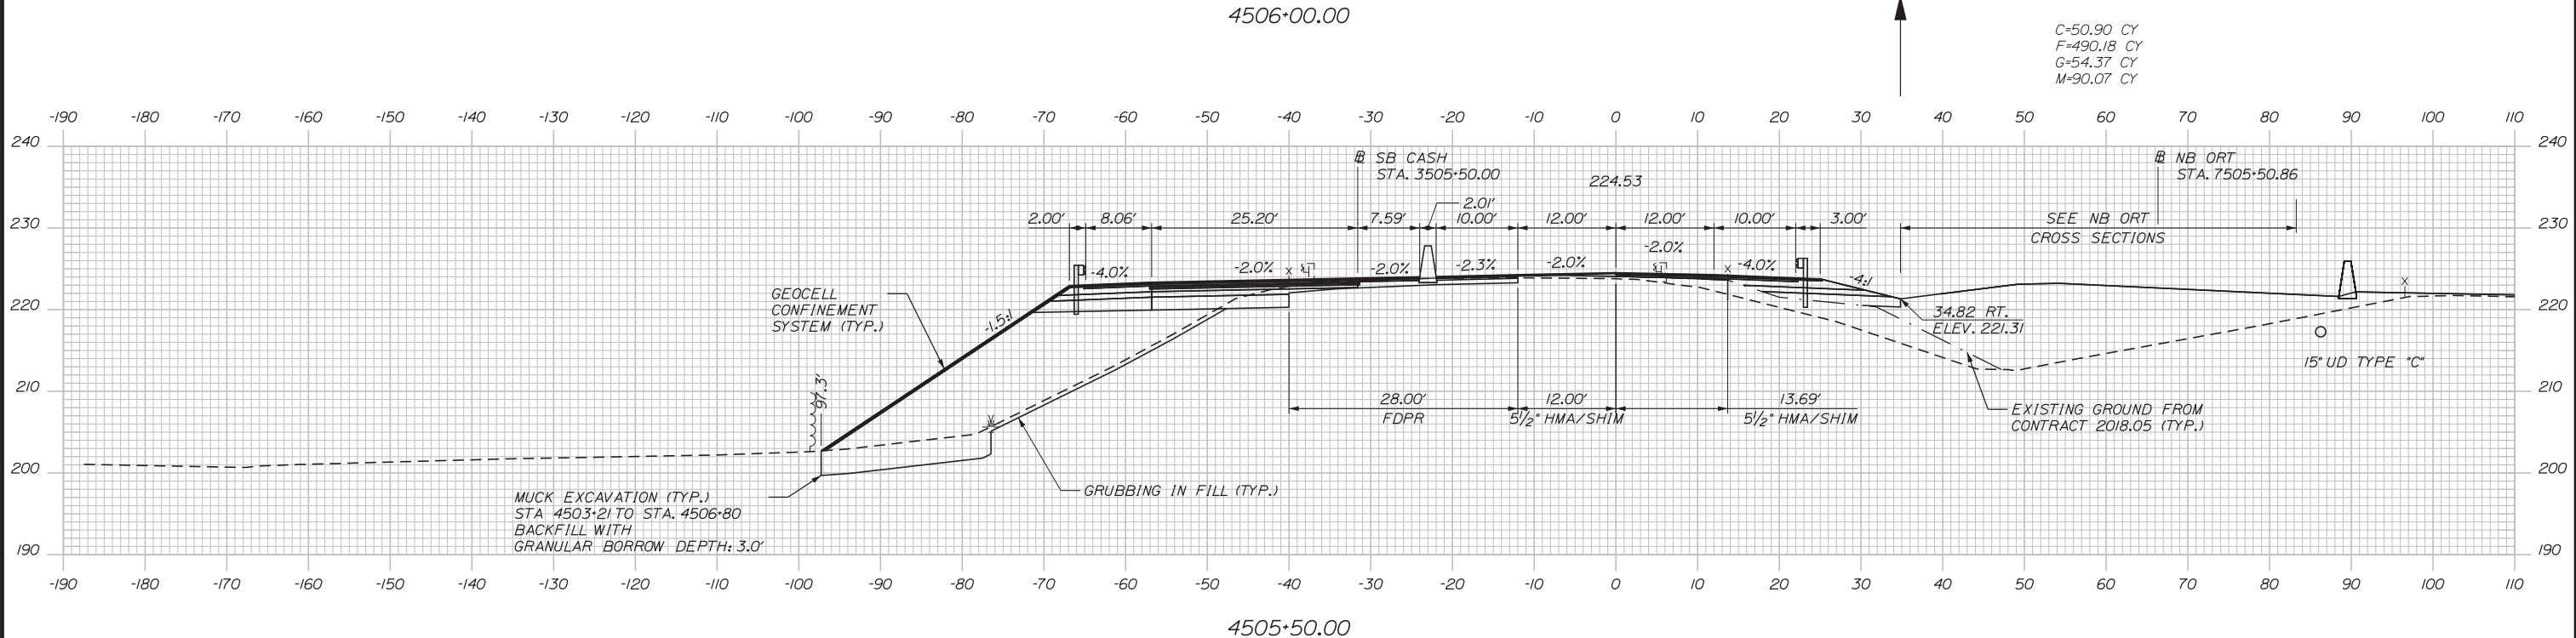

C=50.90 CY  
F=490.18 CY  
G=54.37 CY  
M=90.07 CY

 4505+50.00



Designed by:


**Stantec**

CONSULTANT PROJECT MANAGER: LAUREN MEEK, PE

No.	Revision	By	Date

	By	Date		By	Date
Designed	PLP	3\20\19	Checked	LEM	3\20\19
Drawn	EJB	3\20\19	In Charge of	GAE	3\20\19

STANTEC CONSULTING SERVICES INC.  
482 PAYNE ROAD  
SCARBOROUGH, ME 04074  
TEL (207) 887-3448  
FAX (207) 883-3376

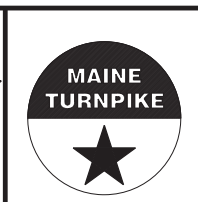

**THE GOLD STAR  
MEMORIAL HIGHWAY**




INTERCHANGE 103  
ORT CONVERSION  
SB ORT  
STA. 4505+50.00 TO STA. 4506+00.00

SHEET NUMBER: XS-48  
CONTRACT: 2019.04  
282 OF 503

Filename: ...00.HIGHWAY\MSTA\\_xsect.dgn



 Date: 3/20/2019

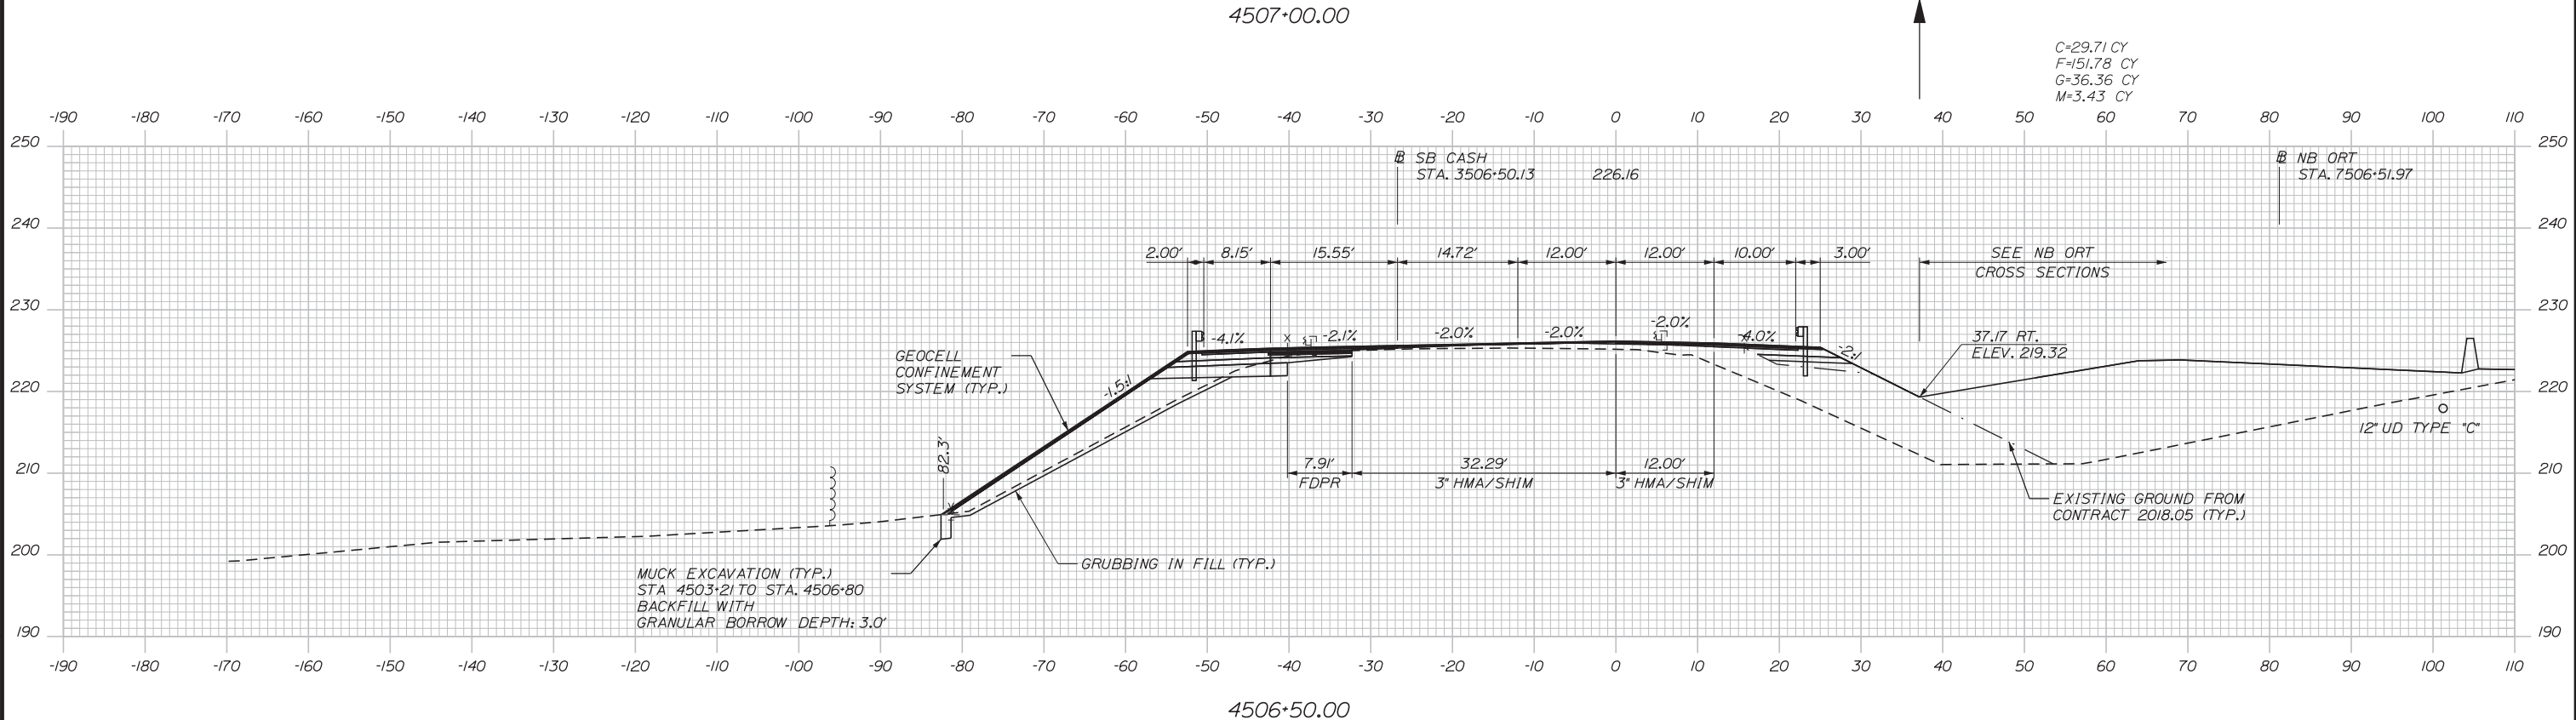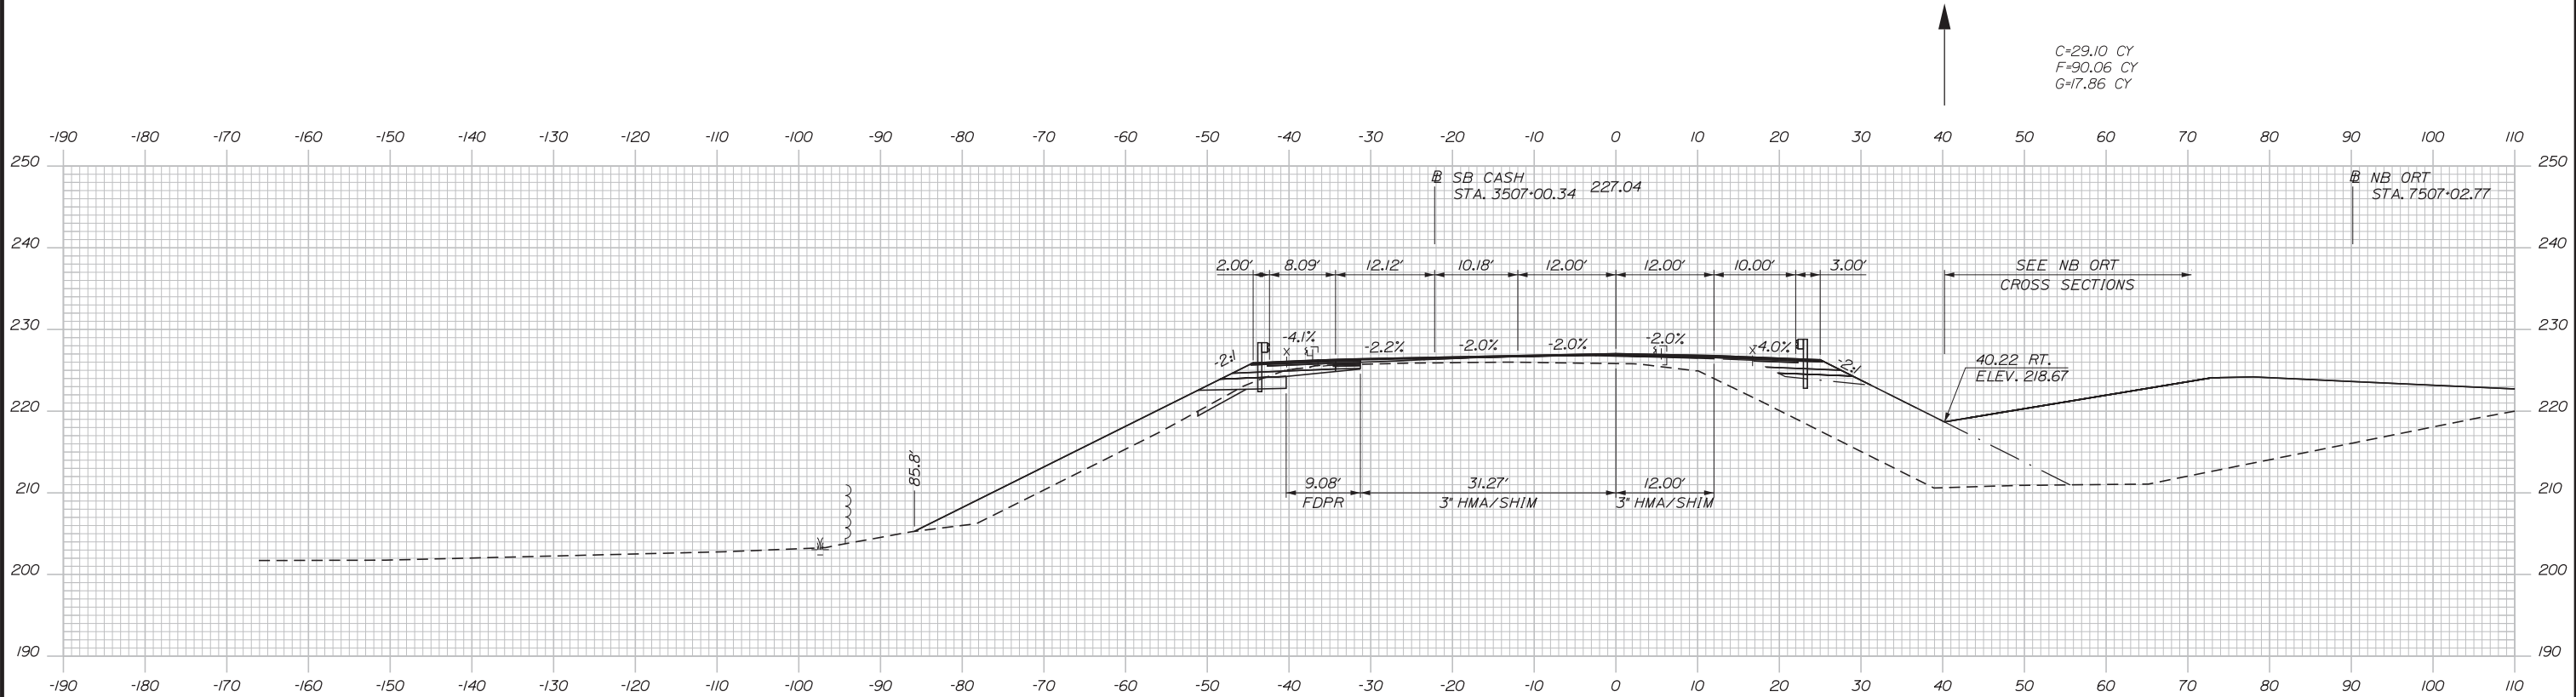

Designed by:

**Stantec**

CONSULTANT PROJECT MANAGER: LAUREN MEEK, PE

No.	Revision	By	Date

	By	Date		By	Date
Designed	PLP	3\20\19	Checked	LEM	3\20\19
Drawn	EJB	3\20\19	In Charge of	GAE	3\20\19

STANTEC CONSULTING SERVICES INC.  
482 PAYNE ROAD  
SCARBOROUGH, ME 04074  
TEL (207) 887-3448  
FAX (207) 883-3376

**MAINE TURNPIKE**

**THE GOLD STAR MEMORIAL HIGHWAY**

MTA PROJECT MANAGER: RALPH NORWOOD, IV, PE, PTOE

INTERCHANGE 103  
ORT CONVERSION  
SB ORT  
STA. 4506+50.00 TO STA. 4507+00.00


SHEET NUMBER: XS-49  
283 OF 503

CONTRACT: 2019.04


Filename: ...100\HIGHWAY\MSTA\\_xsect.dgn




Date: 3/20/2019

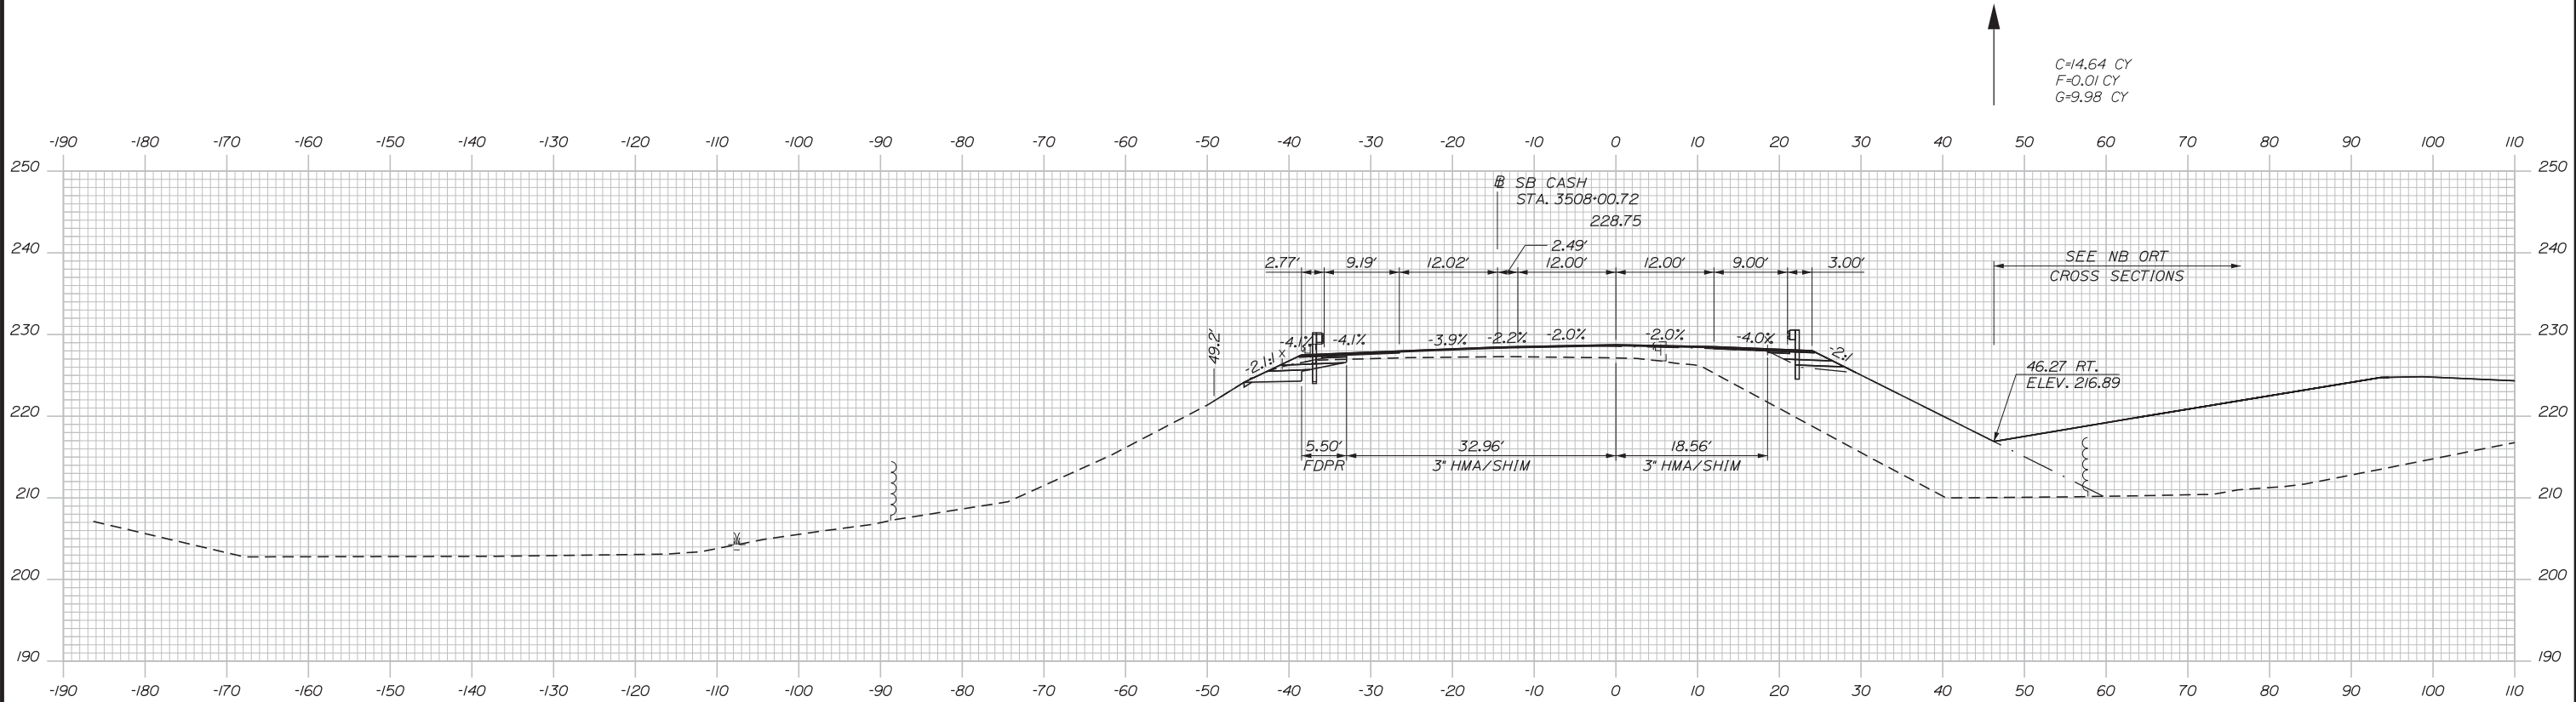

4508+00.00

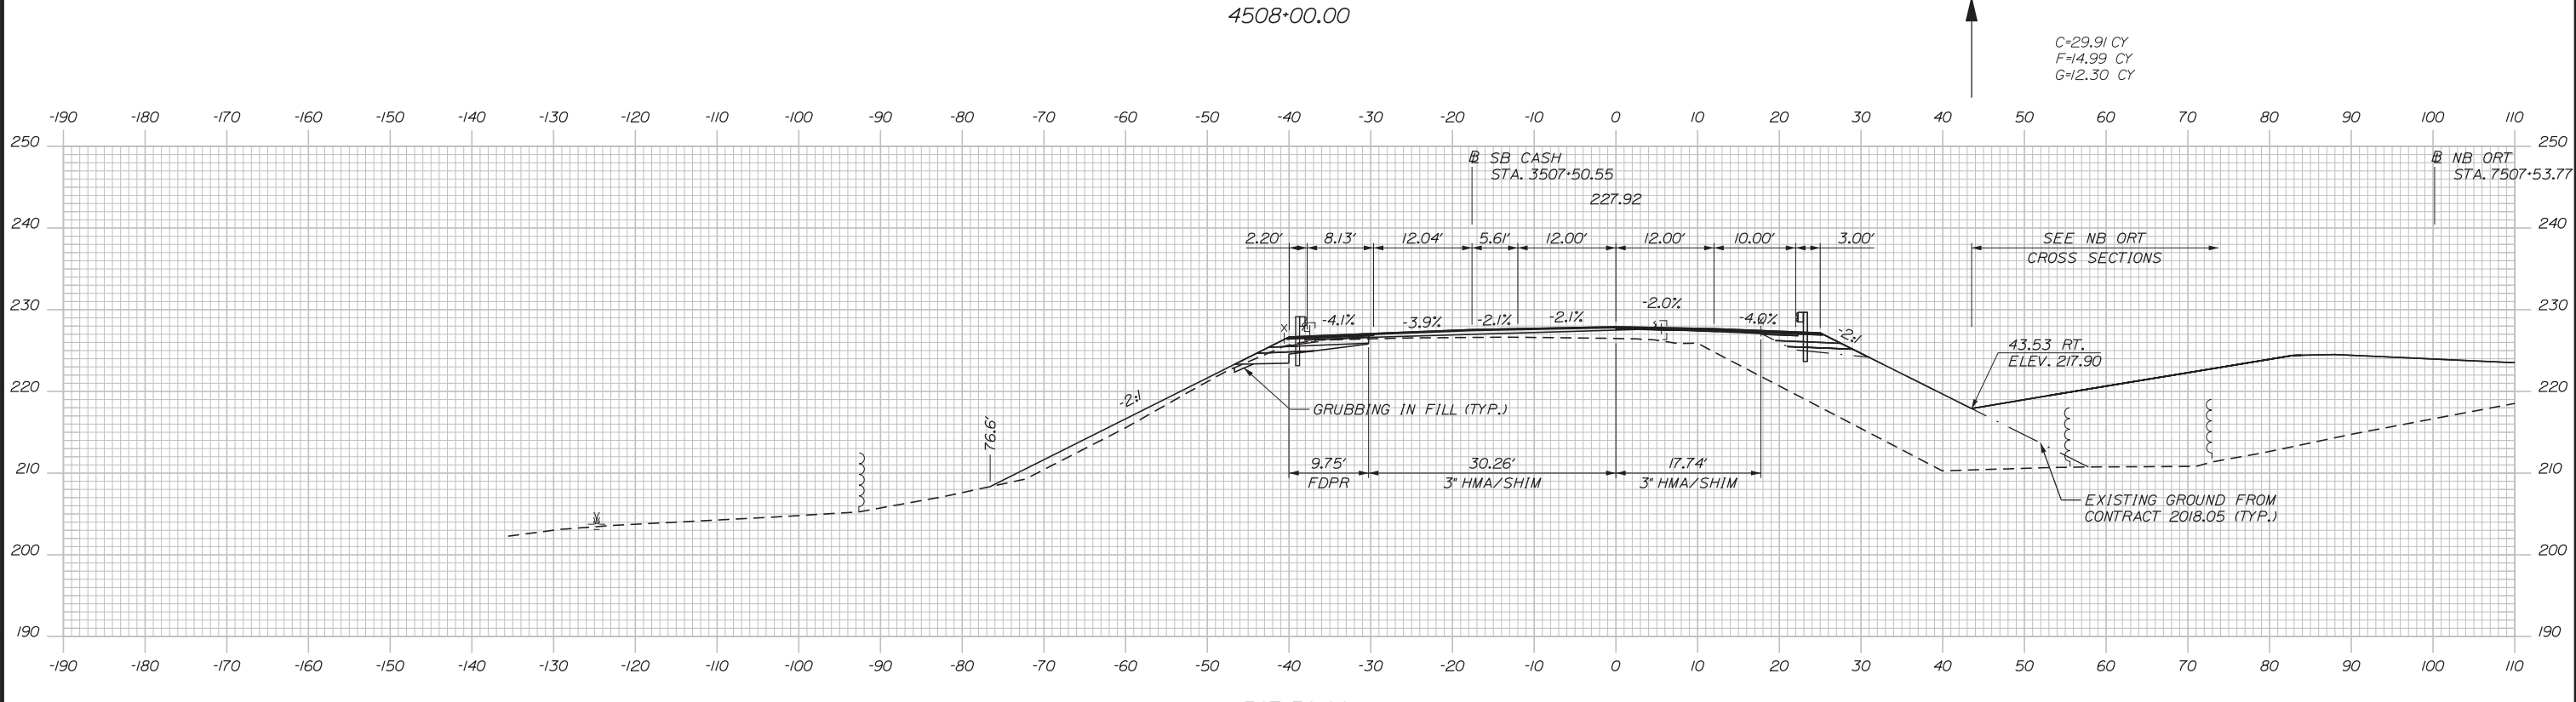

4507+50.00

 

Designed by:


**Stantec**

CONSULTANT PROJECT MANAGER: LAUREN MEEK, PE

No.	Revision	By	Date

	By	Date		By	Date
Designed	PLP	3\20\19	Checked	LEM	3\20\19
Drawn	EJB	3\20\19	In Charge of	GAE	3\20\19

STANTEC CONSULTING SERVICES INC.  
 482 PAYNE ROAD  
 SCARBOROUGH, ME 04074  
 TEL (207) 887-3448  
 FAX (207) 883-3376

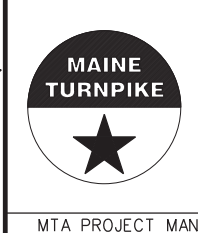

**THE GOLD STAR  
 MEMORIAL HIGHWAY**


INTERCHANGE 103  
 ORT CONVERSION  
 SB ORT  
 STA. 4507+50.00 TO STA. 4508+00.00

SHEET NUMBER: XS-50  
 284 OF 503


CONTRACT: 2019.04

Filename: ...100\HIGHWAY\MSTA\\_xsect.dgn


Date: 3/20/2019

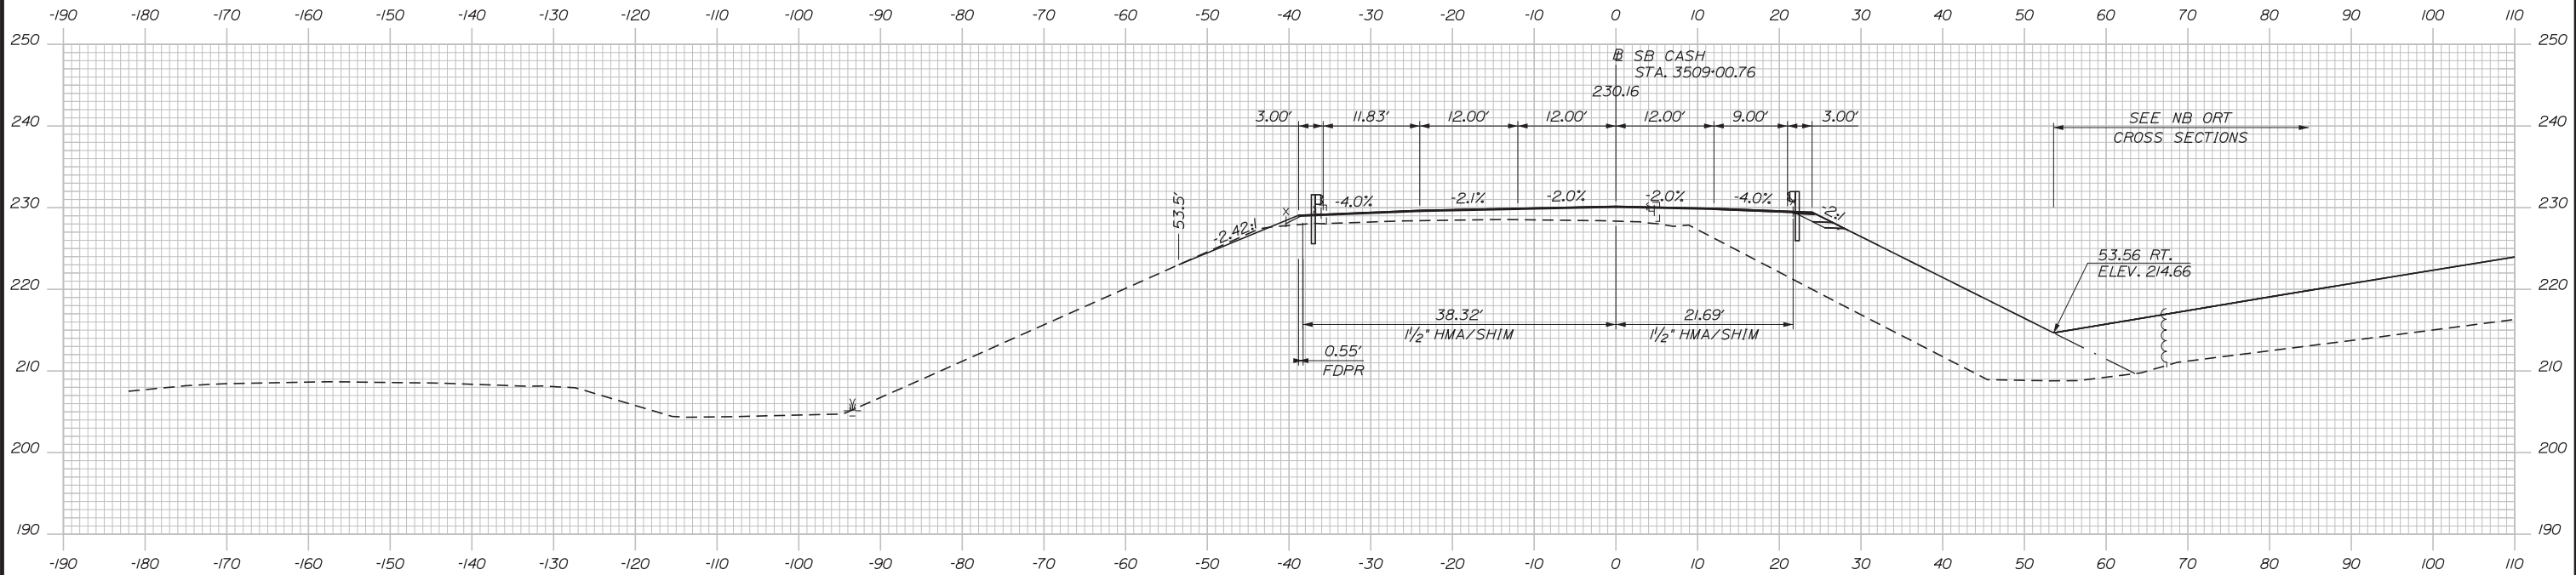

4509+00.00

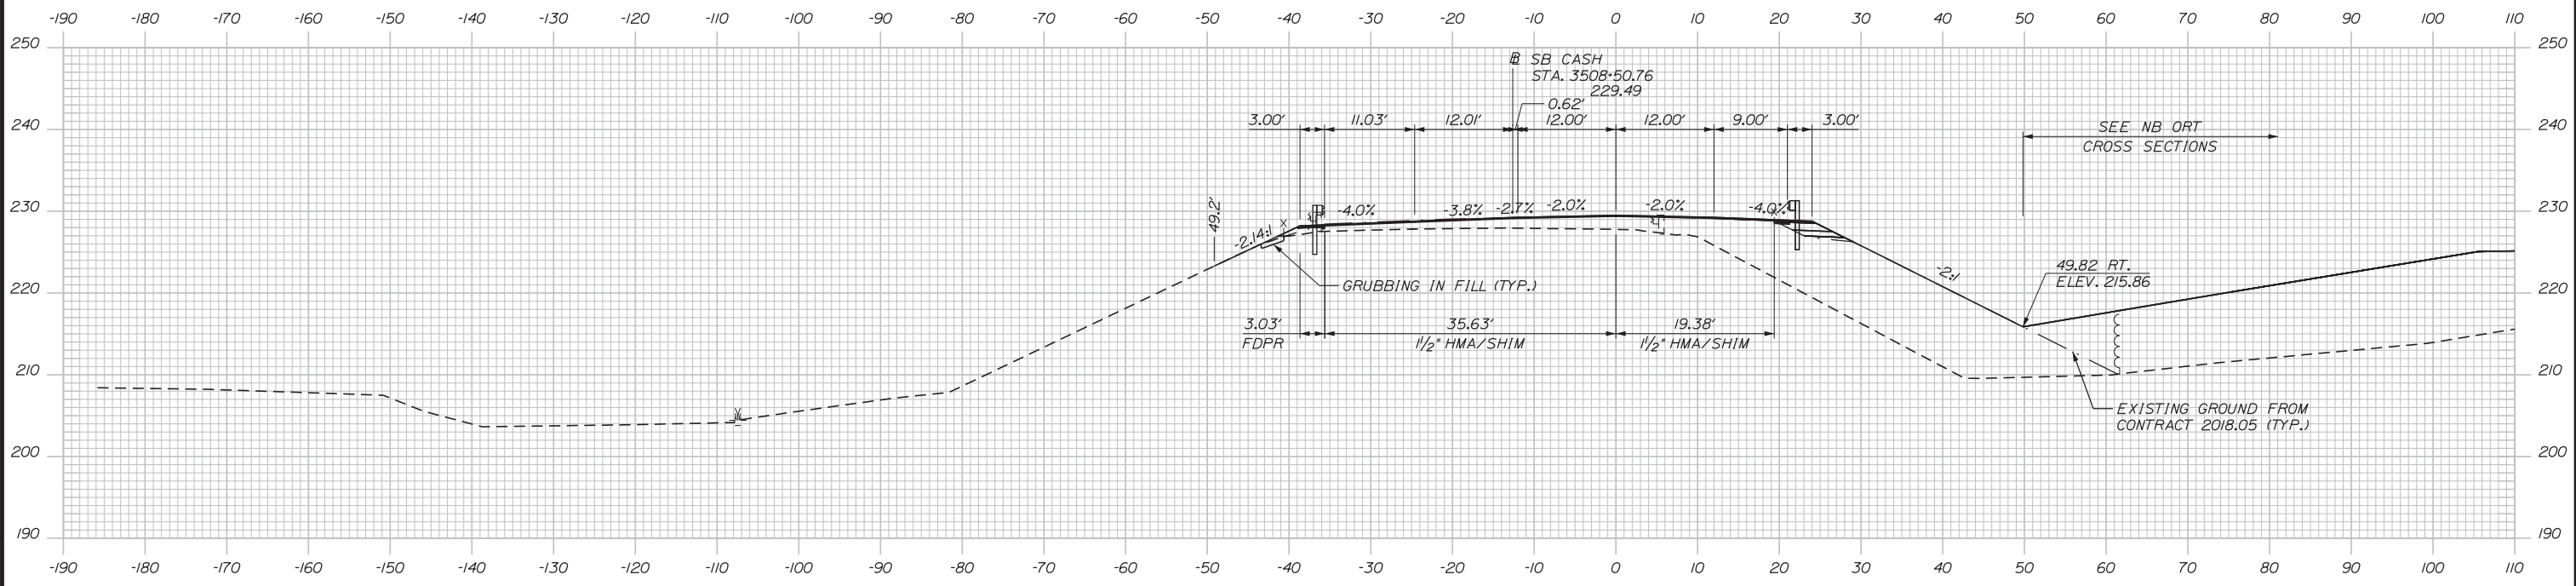

4508+50.00

 

Designed by:


**Stantec**

CONSULTANT PROJECT MANAGER: LAUREN MEEK, PE

No.	Revision	By	Date

By	Date	By	Date
Designed	PLP 3\20\19	Checked	LEM 3\20\19
Drawn	EJB 3\20\19	In Charge of	GAE 3\20\19

STANTEC CONSULTING SERVICES INC.  
482 PAYNE ROAD  
SCARBOROUGH, ME 04074  
TEL (207) 887-3448  
FAX (207) 883-3376

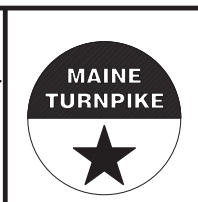

**THE GOLD STAR  
MEMORIAL HIGHWAY**


INTERCHANGE 103  
ORT CONVERSION  
SB ORT  
STA. 4508+50.00 TO STA. 4509+00.00

SHEET NUMBER: XS-51  
285 OF 503


CONTRACT: 2019.04

Filename: ...100\HIGHWAY\MSTA\\_xsect.dgn

Date: 3/20/2019

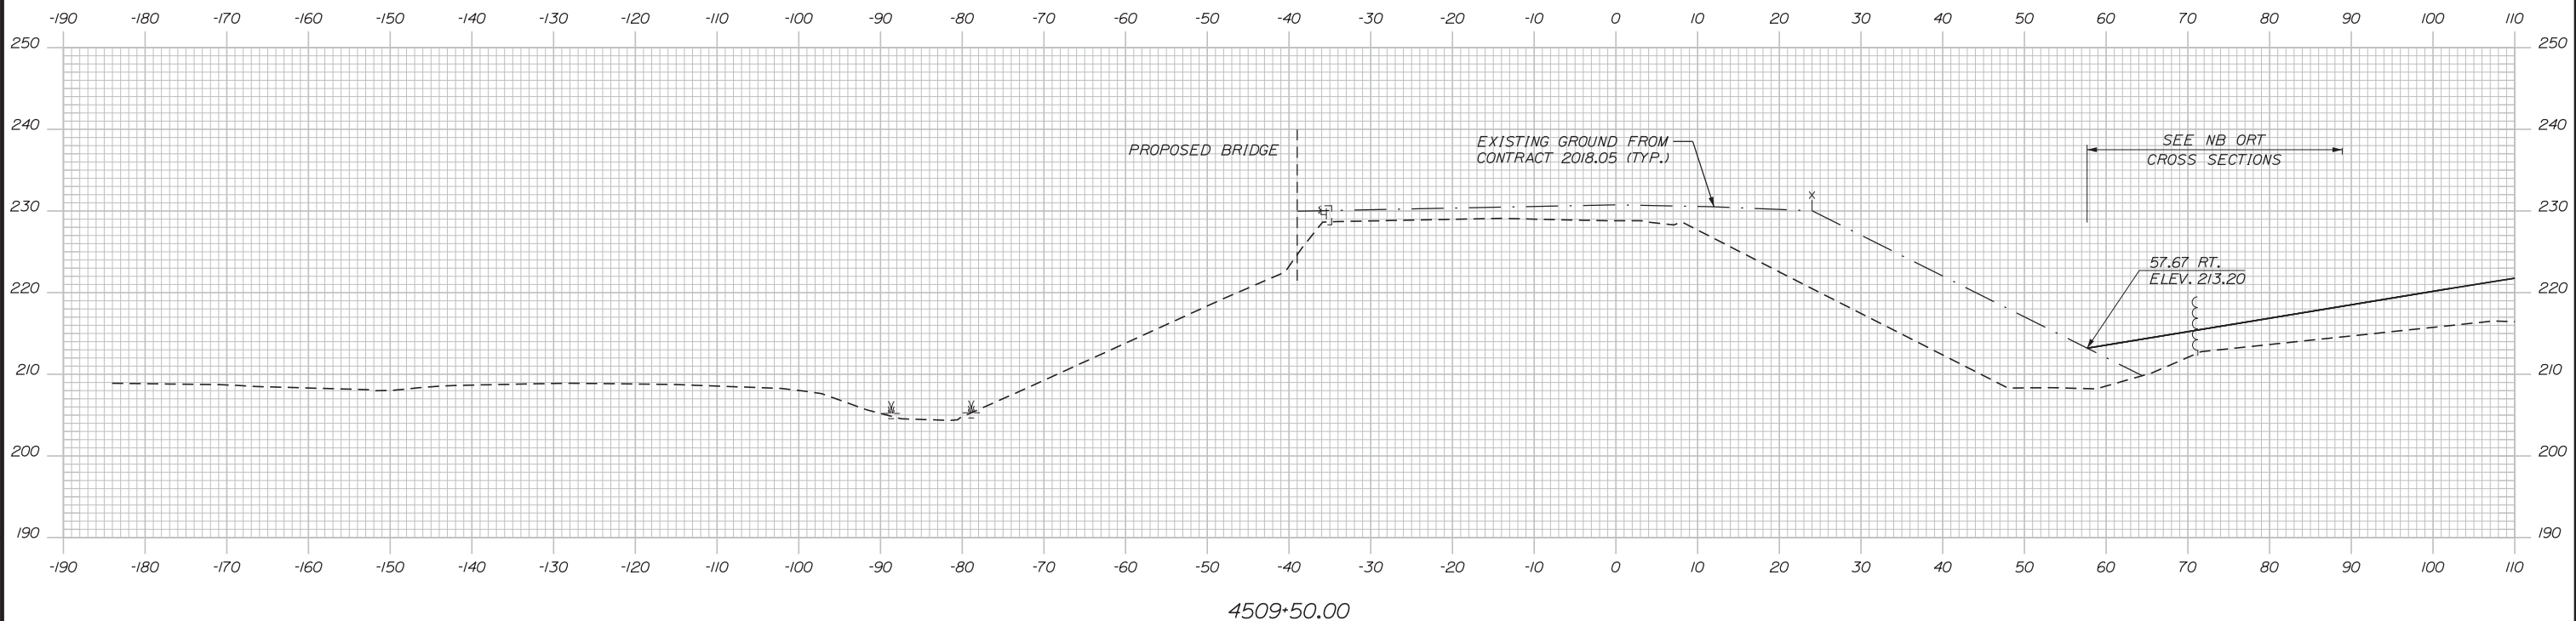

 Filename: ... \00\HIGHWAY\MSTA\\_xsect.dgn



Designed by:

**Stantec**

No.	Revision	By	Date

CONSULTANT PROJECT MANAGER: LAUREN MEEK, PE

	By	Date		By	Date
Designed	PLP	3\20\19	Checked	LEM	3\20\19
Drawn	EJB	3\20\19	In Charge of	GAE	3\20\19

STANTEC CONSULTING SERVICES INC.  
482 PAYNE ROAD  
SCARBOROUGH, ME 04074  
TEL (207) 887-3448  
FAX (207) 883-3376

**MAINE TURNPIKE**

**THE GOLD STAR MEMORIAL HIGHWAY**


MTA PROJECT MANAGER: RALPH NORWOOD, IV, PE, PTOE

INTERCHANGE 103  
ORT CONVERSION  
SB ORT  
STA. 4509+50.00 TO STA. 4509+50.00


SHEET NUMBER: XS-52  
286 OF 503

CONTRACT: 2019.04

Date: 3/20/2019

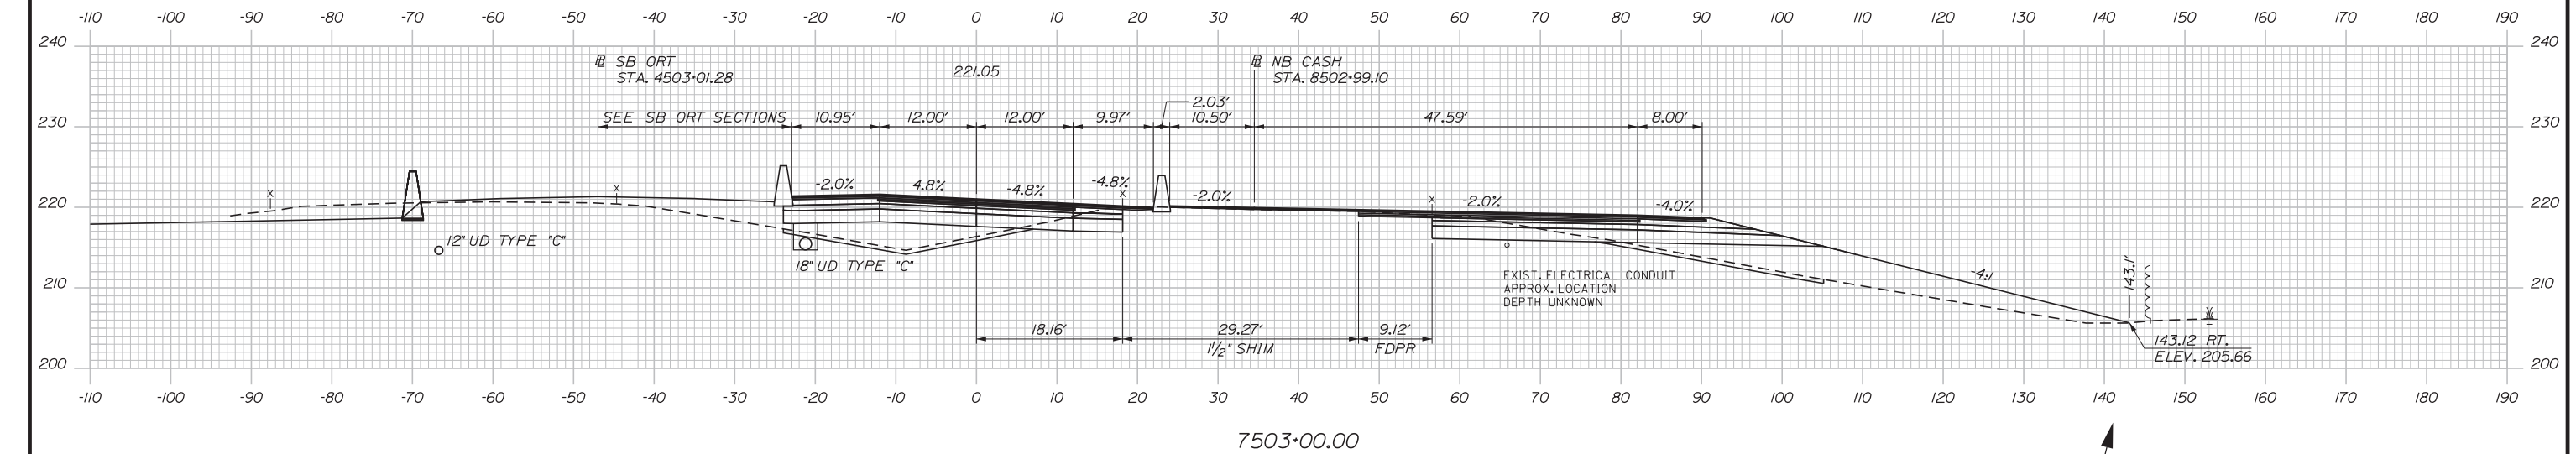

C=125.27 CY  
 F=407.97 CY  
 G=53.14 CY

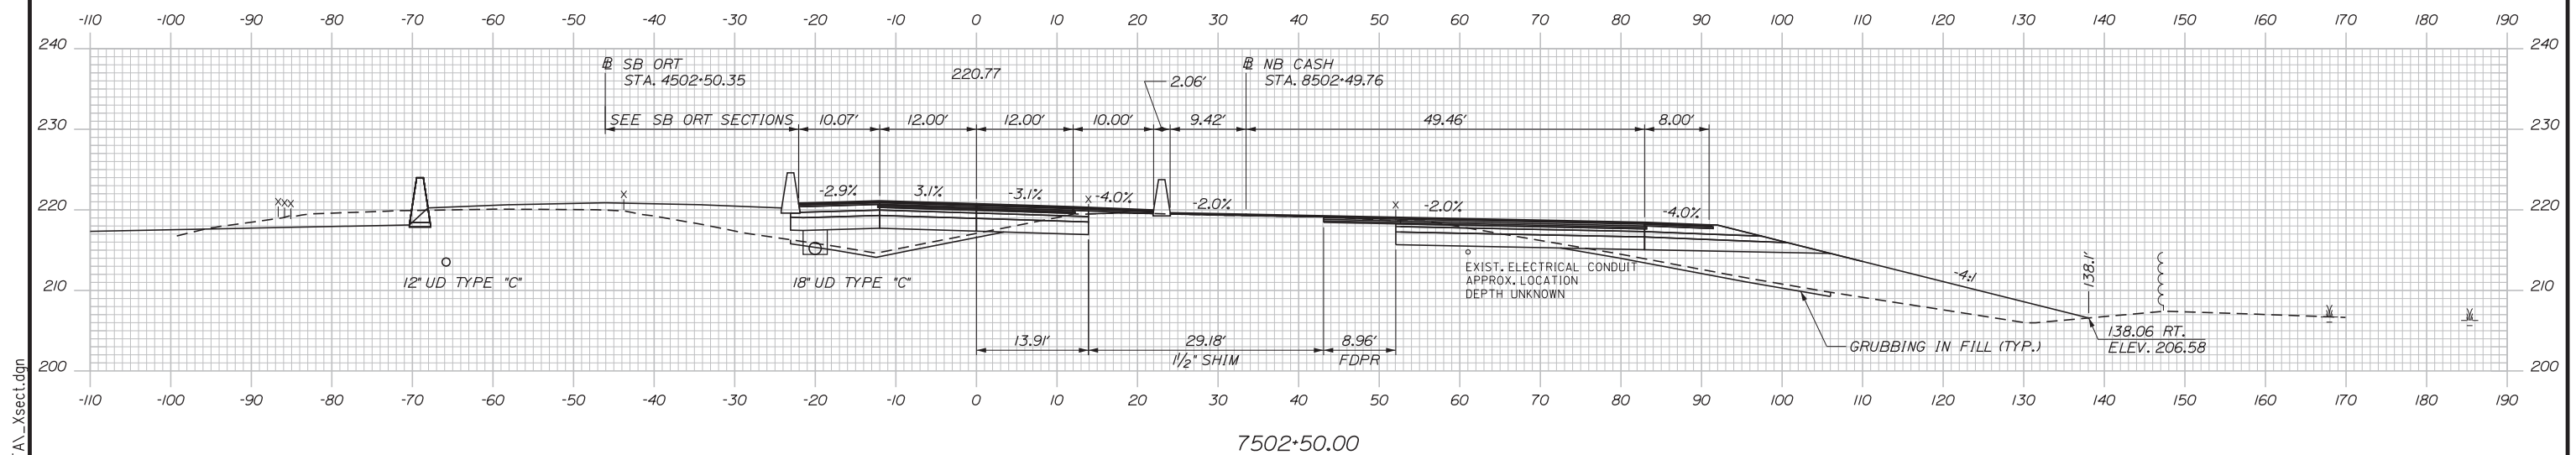

C=123.10 CY  
 F=364.60 CY  
 G=53.59 CY



Designed by:

**Stantec**

CONSULTANT PROJECT MANAGER: LAUREN MEEK, PE

No.	Revision	By	Date

	By	Date		By	Date
Designed	PLP	3\20\19	Checked	LEM	3\20\19
Drawn	EJB	3\20\19	In Charge of	GAE	3\20\19

STANTEC CONSULTING SERVICES INC.  
 482 PAYNE ROAD  
 SCARBOROUGH, ME 04074  
 TEL (207) 887-3448  
 FAX (207) 883-3376






**THE GOLD STAR  
 MEMORIAL HIGHWAY**

INTERCHANGE 103  
 ORT CONVERSION  
 NB ORT  
 STA. 7502+50.00 TO STA. 7503+00.00

SHEET NUMBER: XS-53  
 CONTRACT: 2019.04  
 287 OF 503

Filename: ...:\00\HIGHWAY\MSTA\\_xsect.dgn

 Date: 3/20/2019

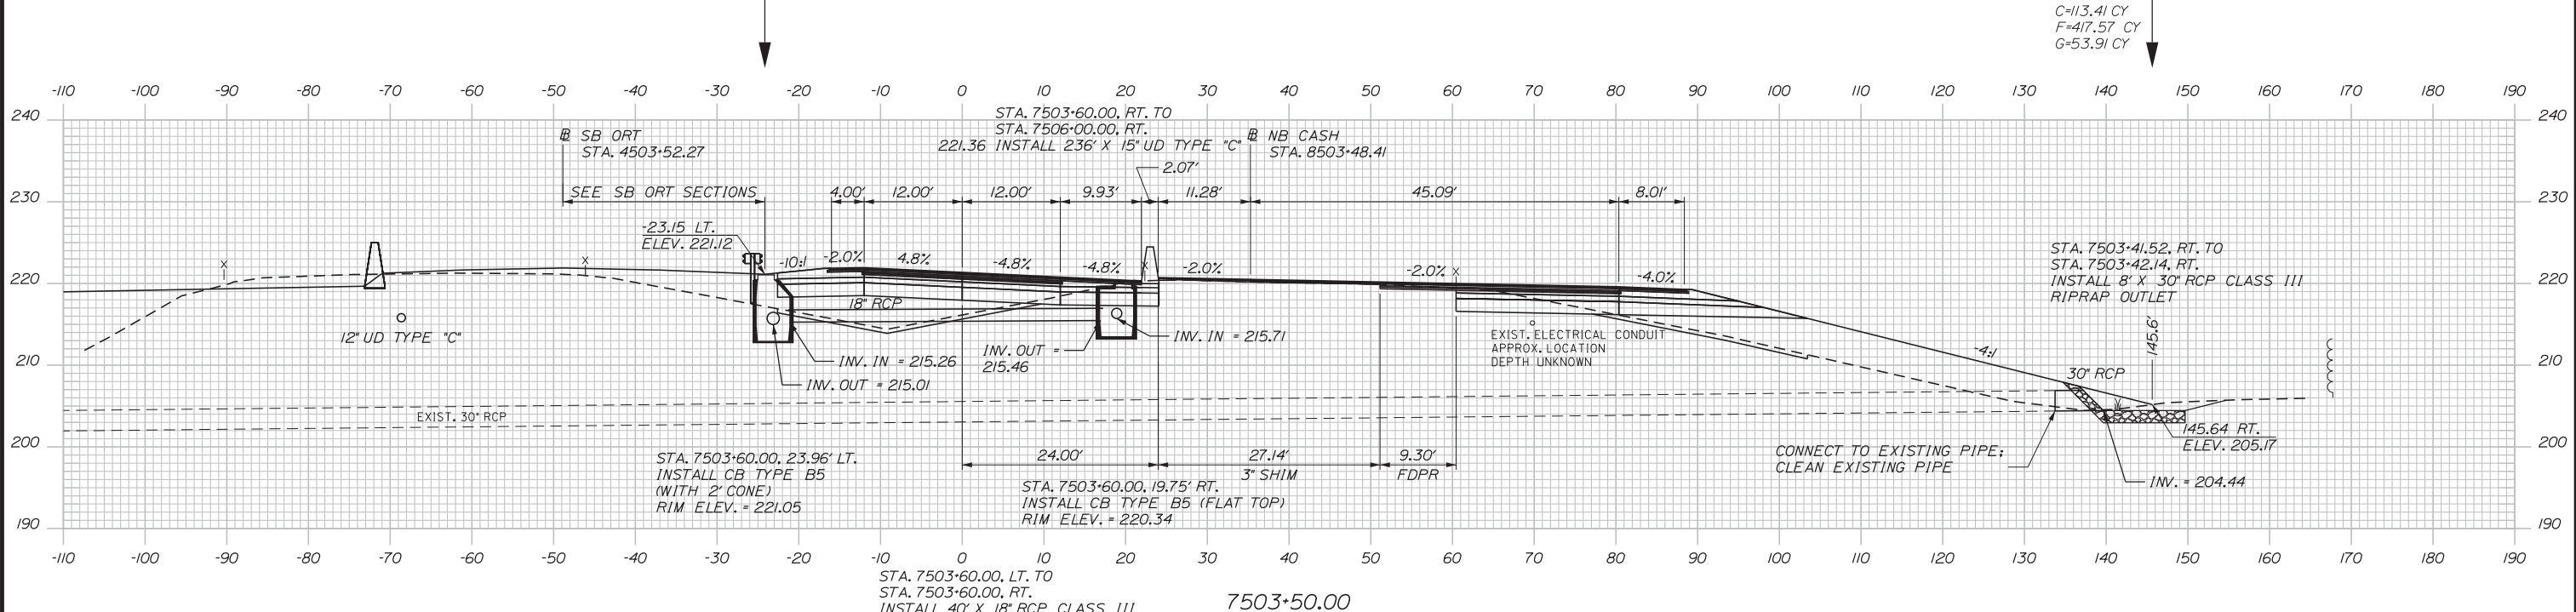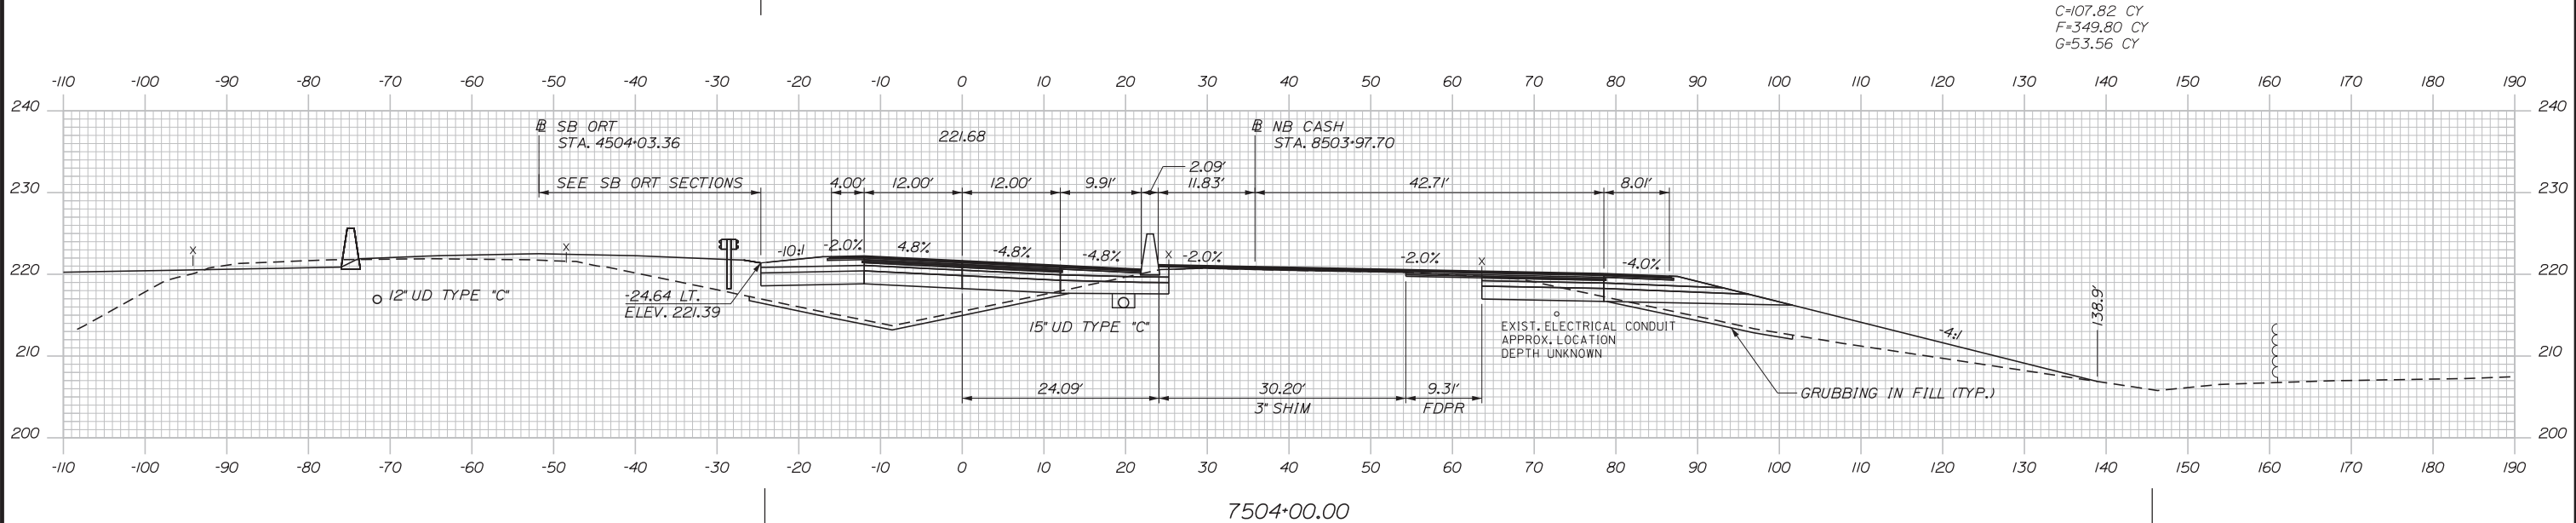

Designed by: **Stantec**

No.	Revision	By	Date

By	Date	By	Date
PLP	3\20\19	LEM	3\20\19
EJB	3\20\19	GAE	3\20\19

CONSULTANT PROJECT MANAGER: LAUREN MEEK, PE

STANTEC CONSULTING SERVICES INC.  
482 PAYNE ROAD  
SCARBOROUGH, ME 04074  
TEL (207) 887-3448  
FAX (207) 883-3376

**MAINE TURNPIKE**

**THE GOLD STAR MEMORIAL HIGHWAY**

MTA PROJECT MANAGER: RALPH NORWOOD, IV, PE, PTOE


INTERCHANGE 103  
ORT CONVERSION  
NB ORT  
STA. 7503+50.00 TO STA. 7504+00.00

SHEET NUMBER: XS-54  
288 OF 503


CONTRACT: 2019.04

Filename: ...:\00\HIGHWAY\MSTA\\_xsect.dgn


Date: 3/20/2019

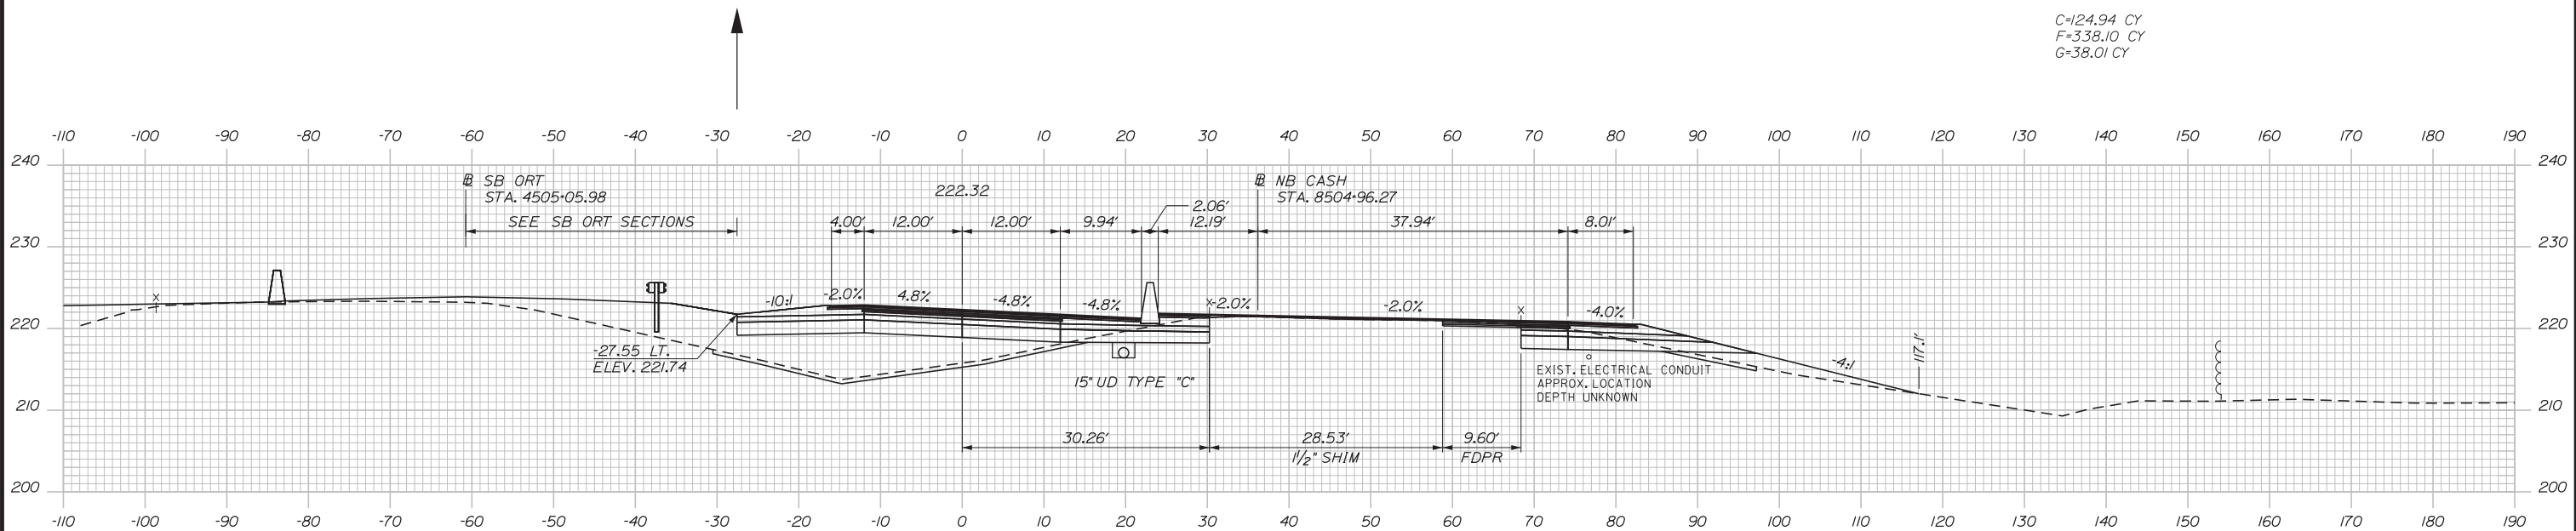

C=124.94 CY  
F=338.10 CY  
G=38.01 CY

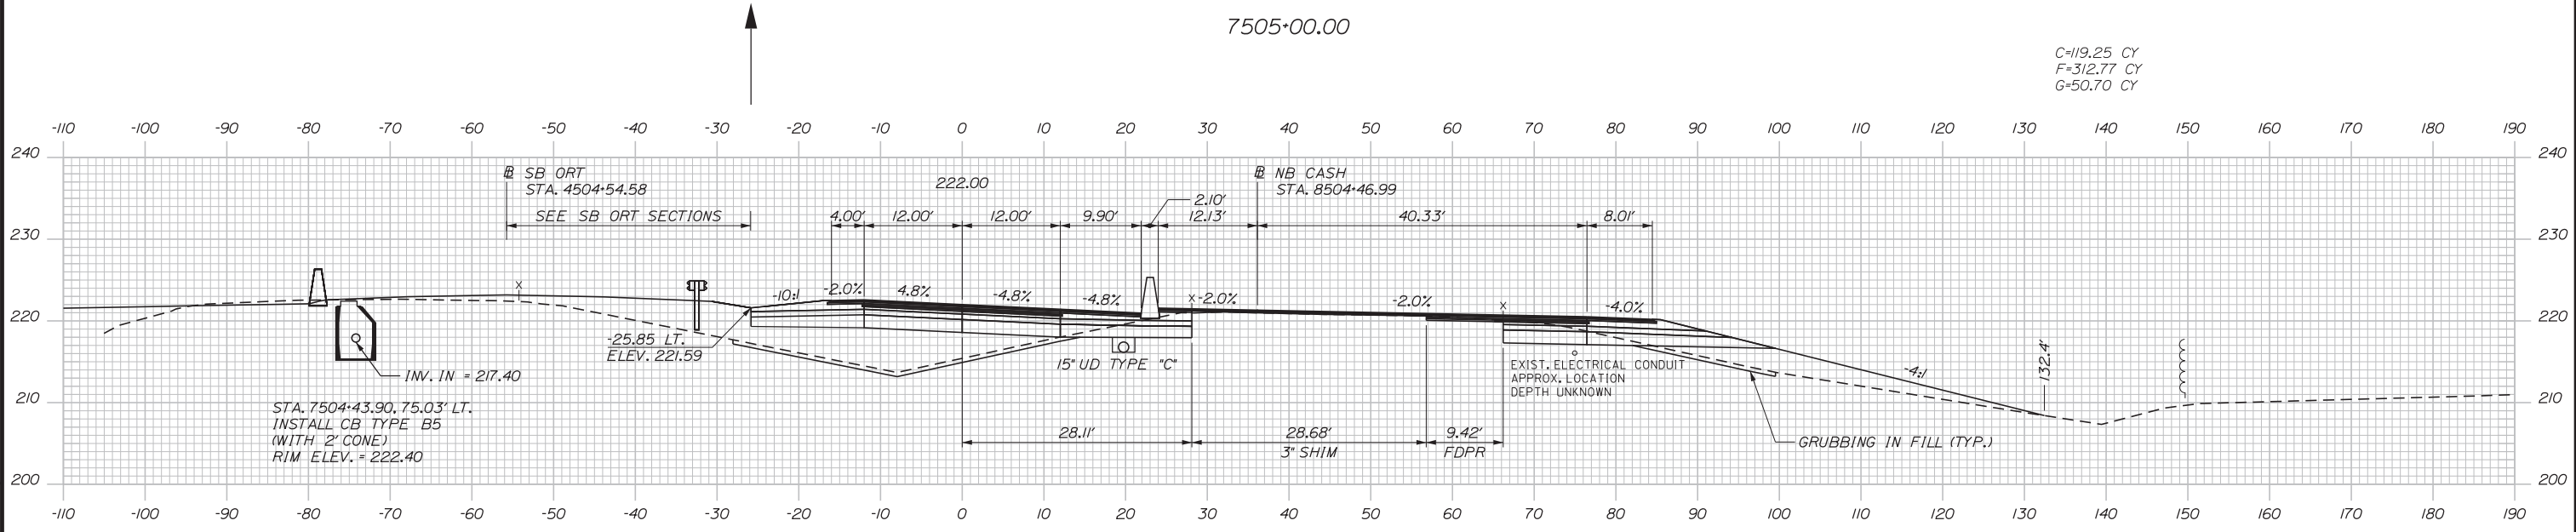

C=119.25 CY  
F=312.77 CY  
G=50.70 CY

 

Designed by:


**Stantec**

No.	Revision	By	Date

CONSULTANT PROJECT MANAGER: LAUREN MEEK, PE

	By	Date		By	Date
Designed	PLP	3\20\19	Checked	LEM	3\20\19
Drawn	EJB	3\20\19	In Charge of	GAE	3\20\19

STANTEC CONSULTING SERVICES INC.  
482 PAYNE ROAD  
SCARBOROUGH, ME 04074  
TEL (207) 887-3448  
FAX (207) 883-3376

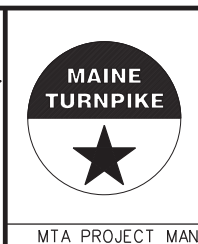

**THE GOLD STAR  
MEMORIAL HIGHWAY**




INTERCHANGE 103  
ORT CONVERSION  
NB ORT  
STA. 7504+50.00 TO STA. 7505+00.00

SHEET NUMBER: XS-55  
CONTRACT: 2019.04  
289 OF 503

Filename: ...00.HIGHWAY\MSTA\\_xsect.dgn



 Date: 3/20/2019

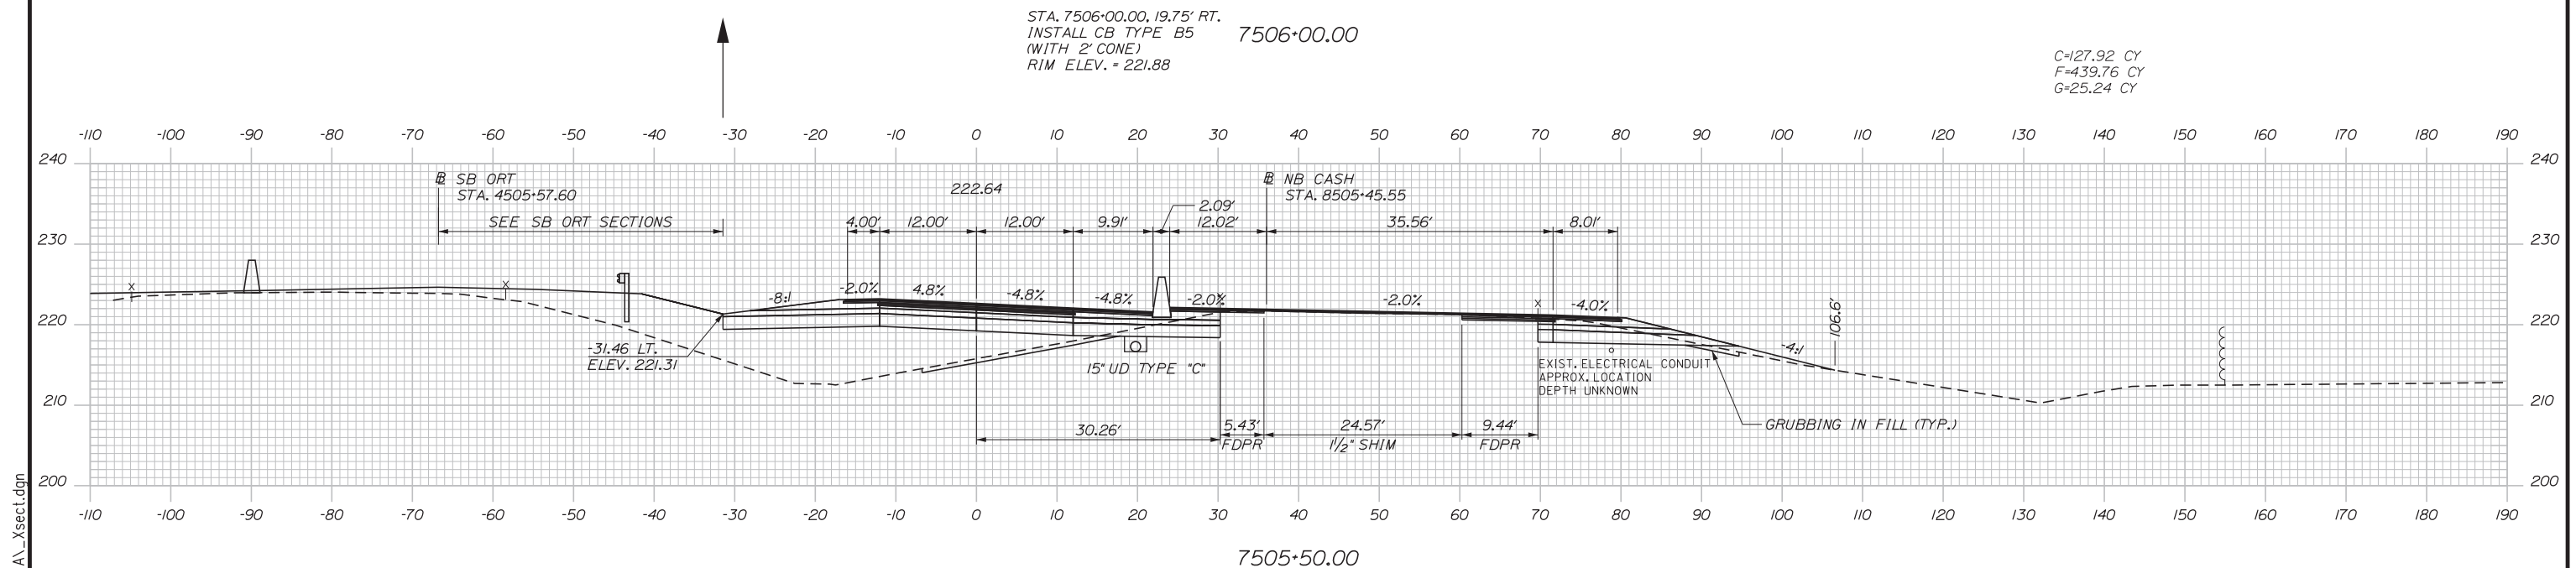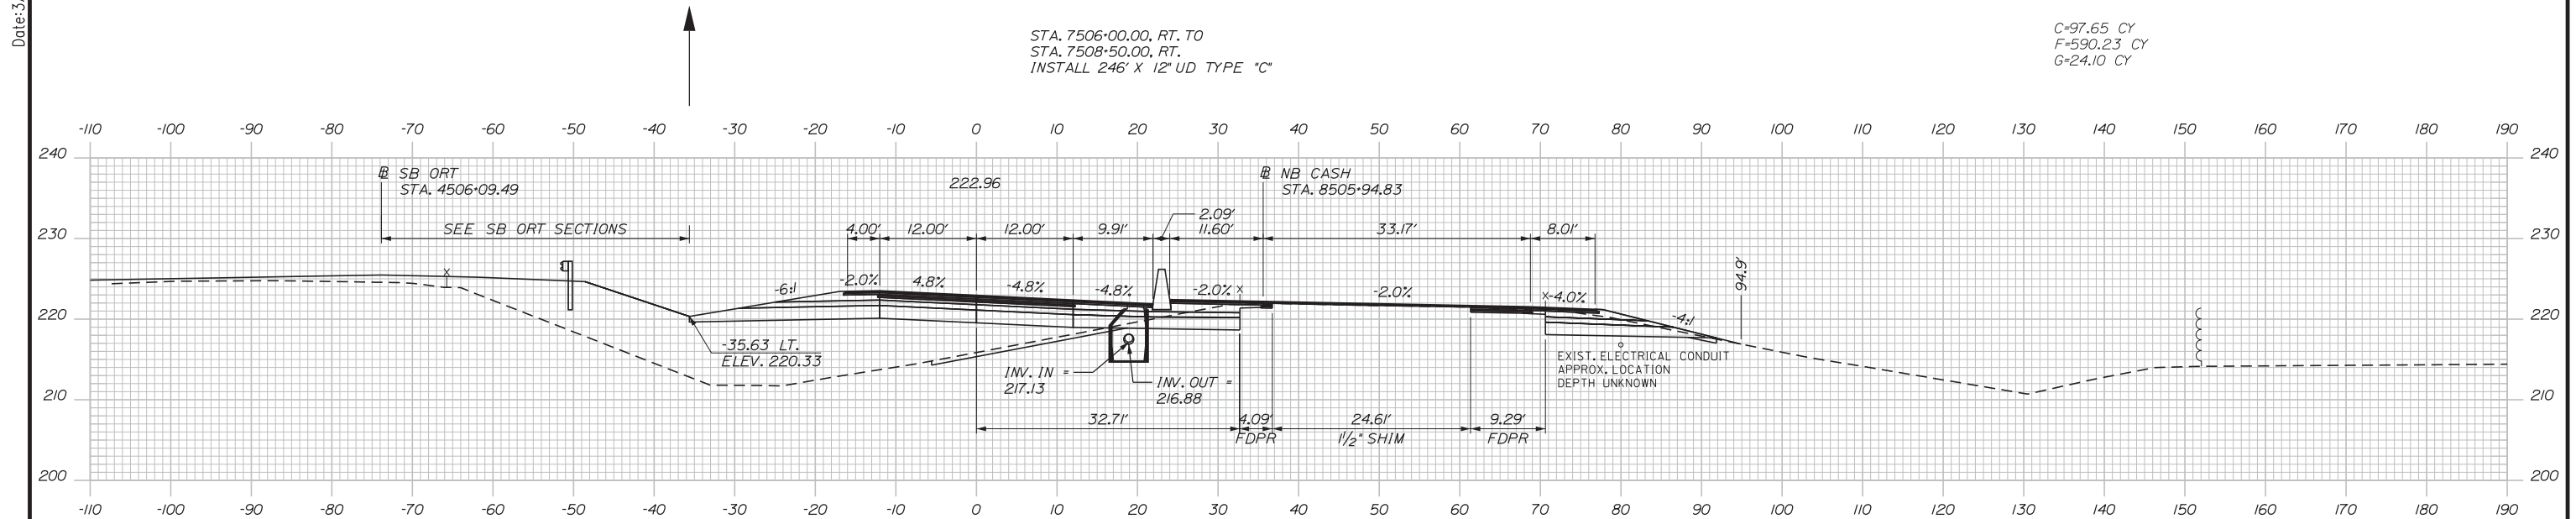

Designed by:

**Stantec**

No.	Revision	By	Date

CONSULTANT PROJECT MANAGER: LAUREN MEEK, PE

	By	Date		By	Date
Designed	PLP	3\20\19	Checked	LEM	3\20\19
Drawn	EJB	3\20\19	In Charge of	GAE	3\20\19

STANTEC CONSULTING SERVICES INC.  
482 PAYNE ROAD  
SCARBOROUGH, ME 04074  
TEL (207) 887-3448  
FAX (207) 883-3376

**MAINE TURNPIKE**

**THE GOLD STAR MEMORIAL HIGHWAY**


MTA PROJECT MANAGER: RALPH NORWOOD, IV, PE, PTOE

INTERCHANGE 103  
ORT CONVERSION  
NB ORT  
STA. 7505+50.00 TO STA. 7506+00.00


SHEET NUMBER: XS-56  
CONTRACT: 2019.04  
290 OF 503

Filename: ...00\HIGHWAY\MSTA\\_xsect.dgn


Date: 3/20/2019

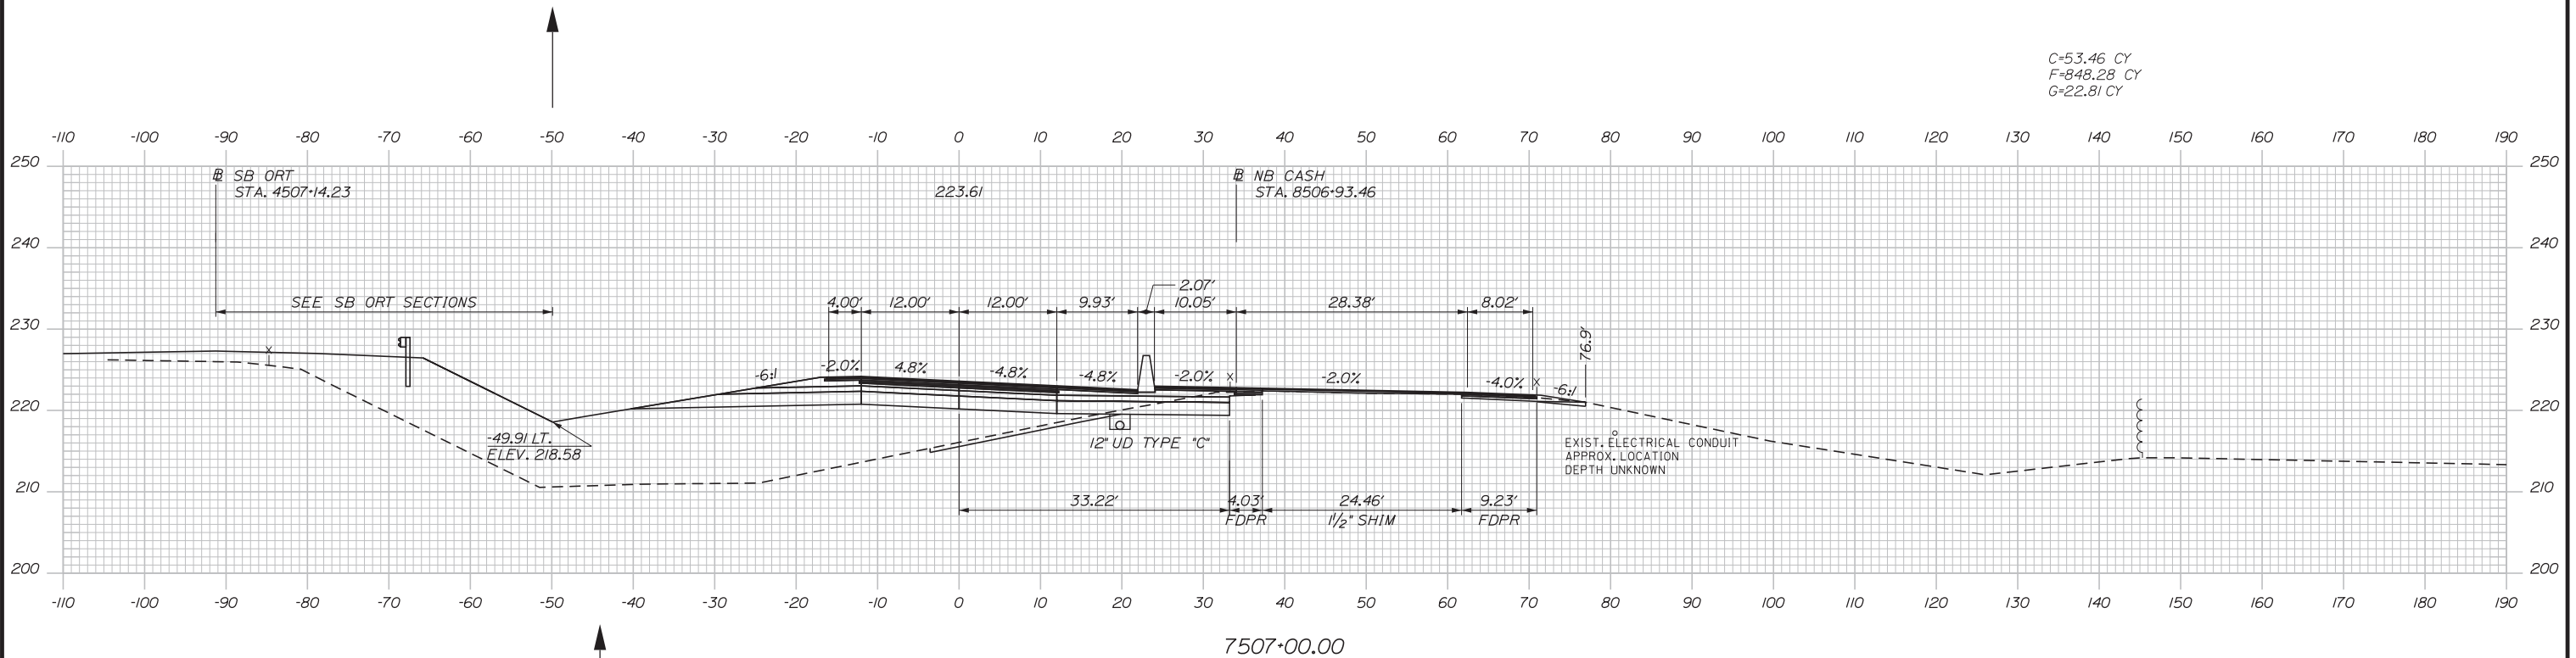

C=53.46 CY  
F=848.28 CY  
G=22.81 CY

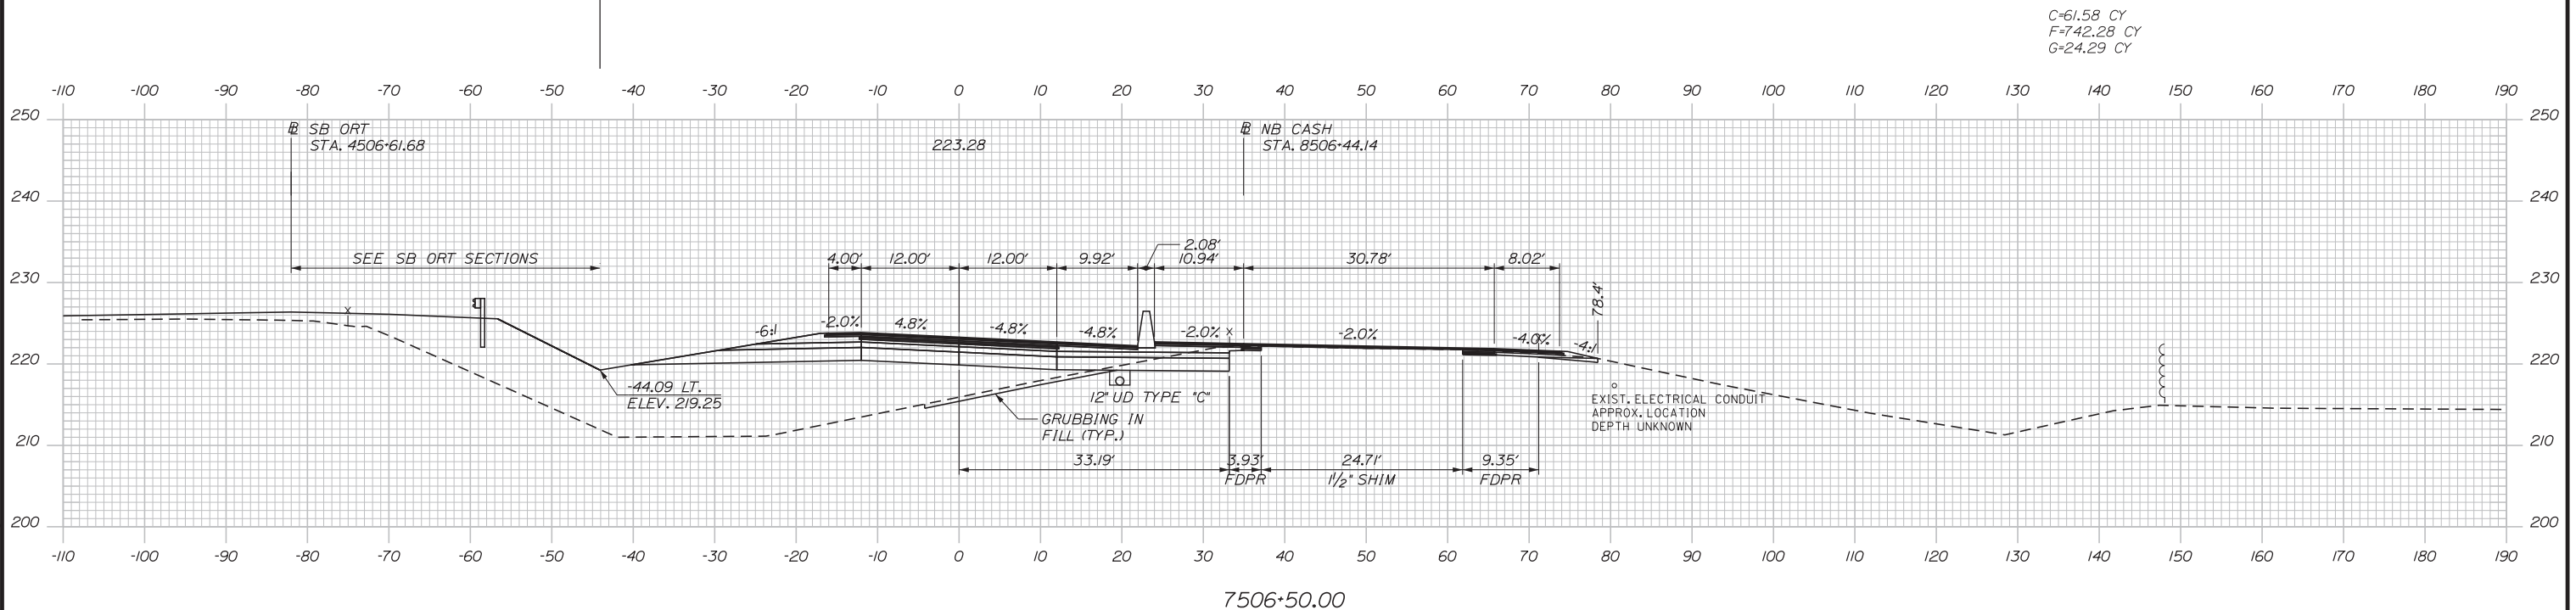

C=61.58 CY  
F=742.28 CY  
G=24.29 CY

 

Designed by:


**Stantec**

CONSULTANT PROJECT MANAGER: LAUREN MEEK, PE

No.	Revision	By	Date

	By	Date		By	Date
Designed	PLP	3\20\19	Checked	LEM	3\20\19
Drawn	EJB	3\20\19	In Charge of	GAE	3\20\19

STANTEC CONSULTING SERVICES INC.  
482 PAYNE ROAD  
SCARBOROUGH, ME 04074  
TEL (207) 887-3448  
FAX (207) 883-3376

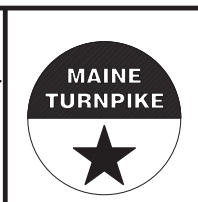


**THE GOLD STAR  
MEMORIAL HIGHWAY**


INTERCHANGE 103  
ORT CONVERSION  
NB ORT  
STA. 7506+50.00 TO STA. 7507+00.00

Filename: ... \00\HIGHWAY\MSTA\\_xsect.dgn


Date: 3/20/2019

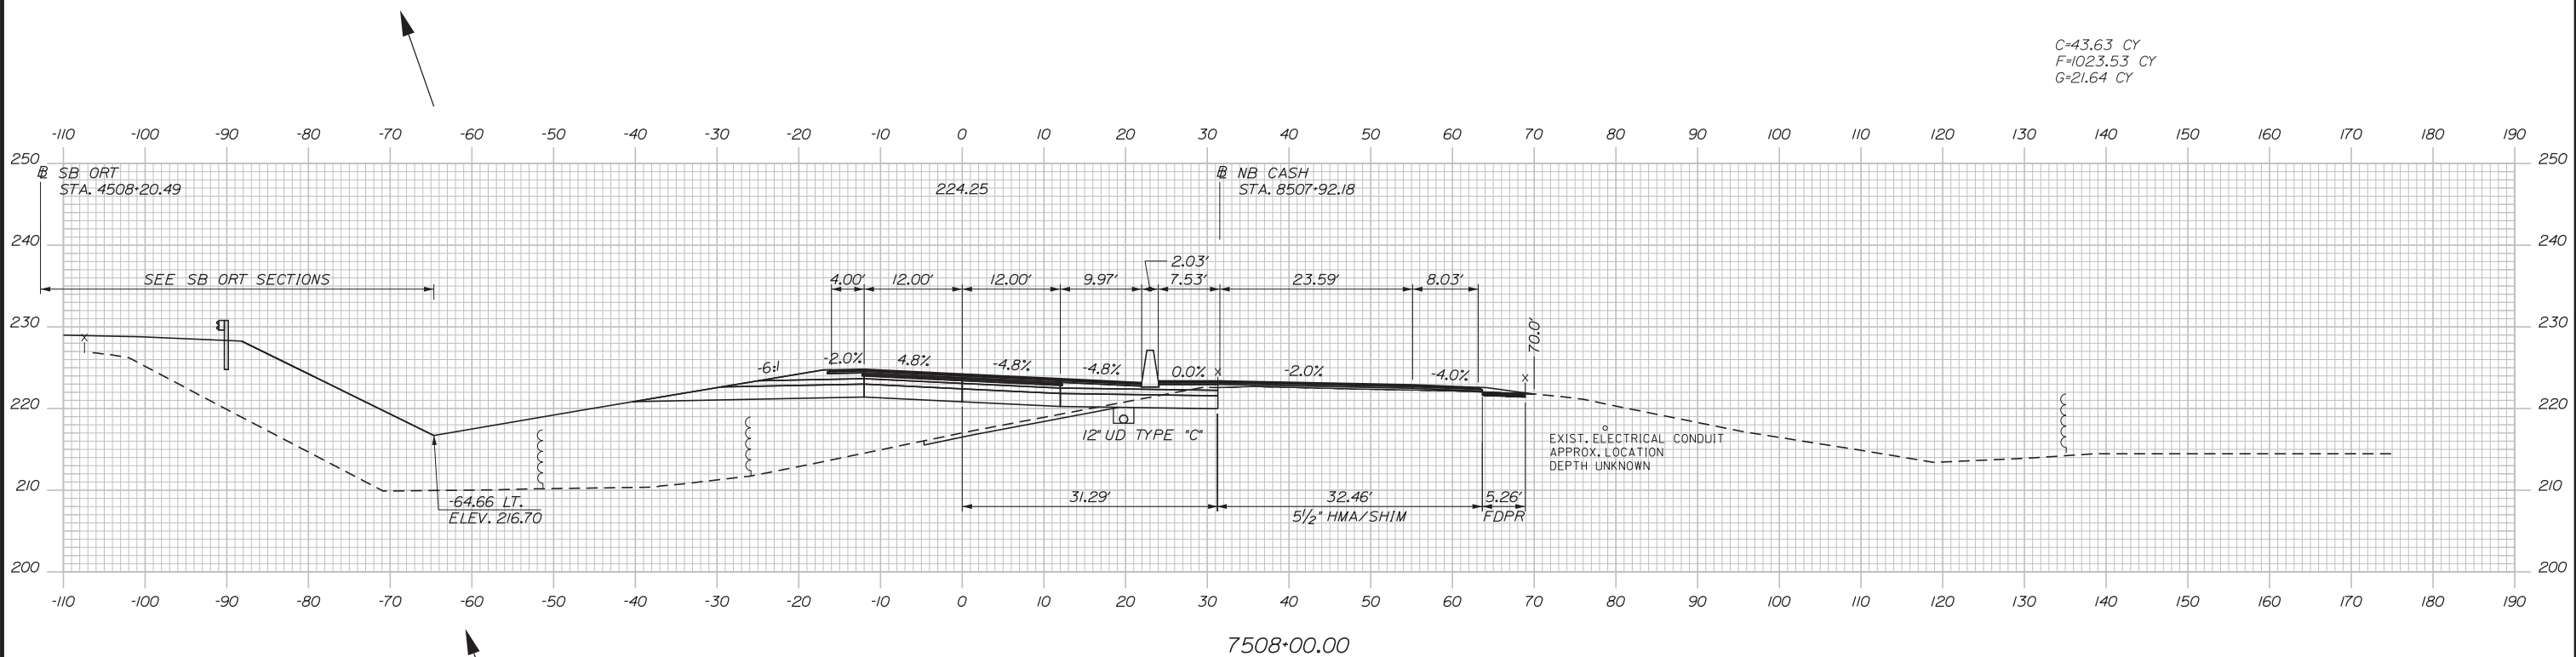

C=43.63 CY  
F=1023.53 CY  
G=21.64 CY

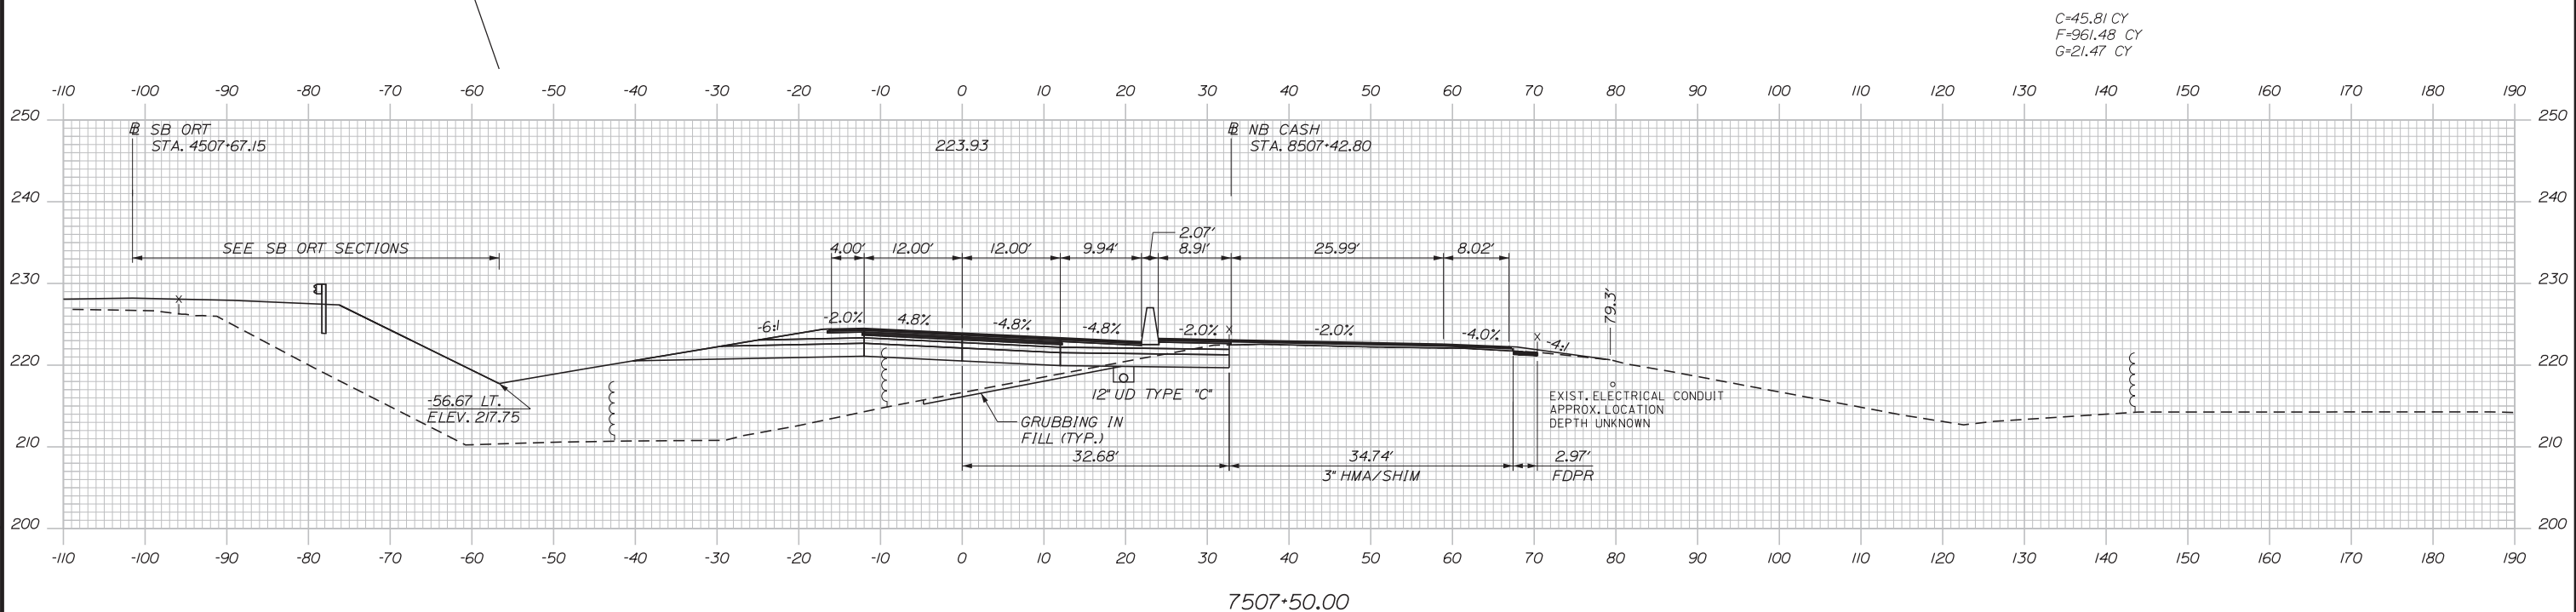

C=45.81 CY  
F=961.48 CY  
G=21.47 CY

 

Designed by:


**Stantec**

CONSULTANT PROJECT MANAGER: LAUREN MEEK, PE

No.	Revision	By	Date

	By	Date		By	Date
Designed	PLP	3\20\19	Checked	LEM	3\20\19
Drawn	EJB	3\20\19	In Charge of	GAE	3\20\19

STANTEC CONSULTING SERVICES INC.  
482 PAYNE ROAD  
SCARBOROUGH, ME 04074  
TEL (207) 887-3448  
FAX (207) 883-3376

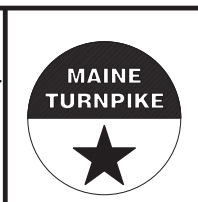


**THE GOLD STAR  
MEMORIAL HIGHWAY**

INTERCHANGE 103  
ORT CONVERSION  
NB ORT  
STA. 7507+50.00 TO STA. 7508+00.00


Filename: ...000.HIGHWAY\MSTA\\_xsect.dgn

Date: 3/20/2019

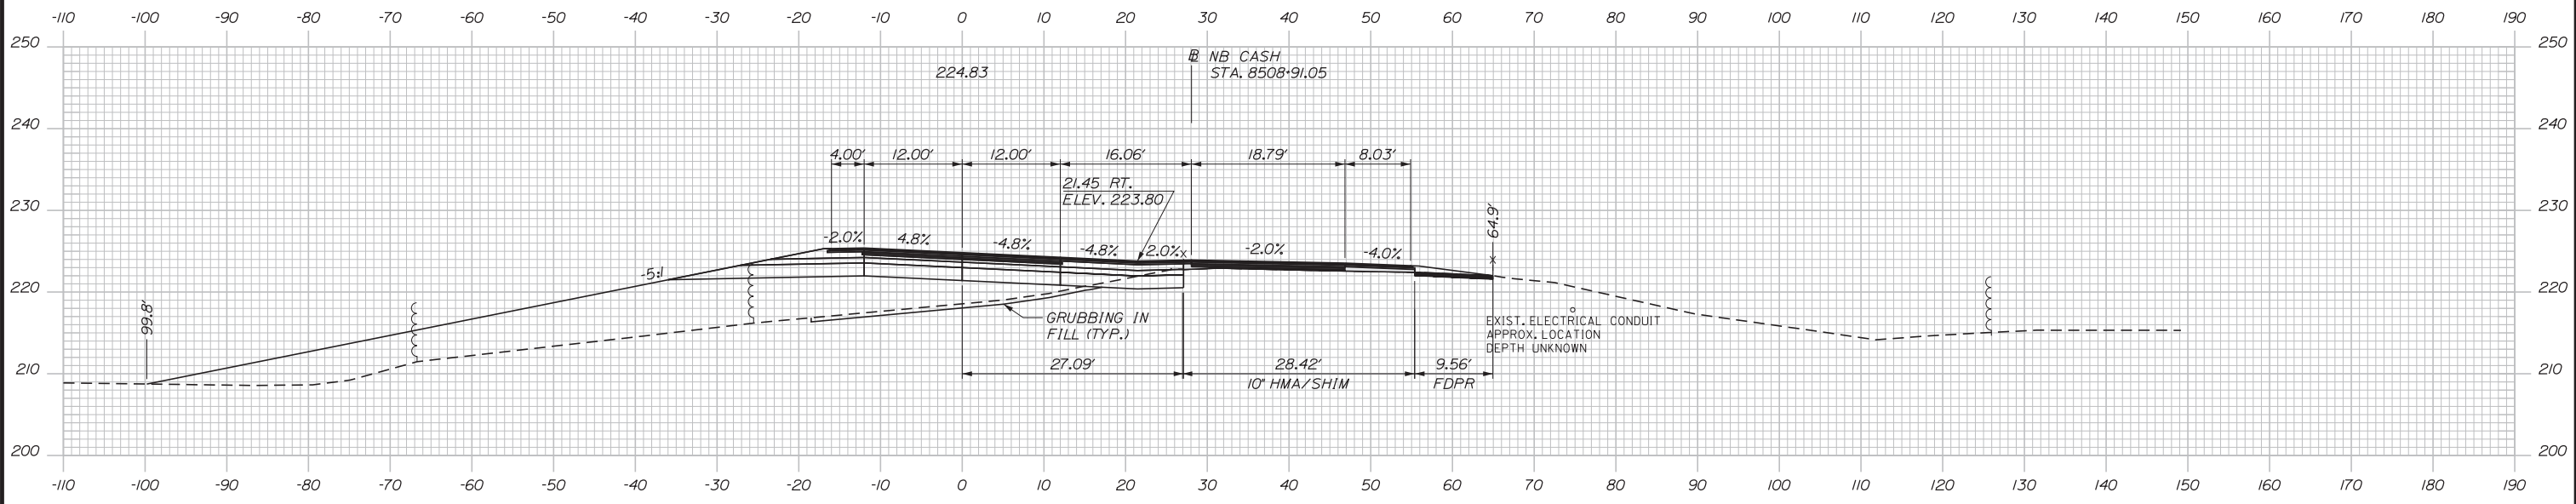


C=38.31 CY  
F=635.92 CY  
G=33.60 CY

7509+00.00

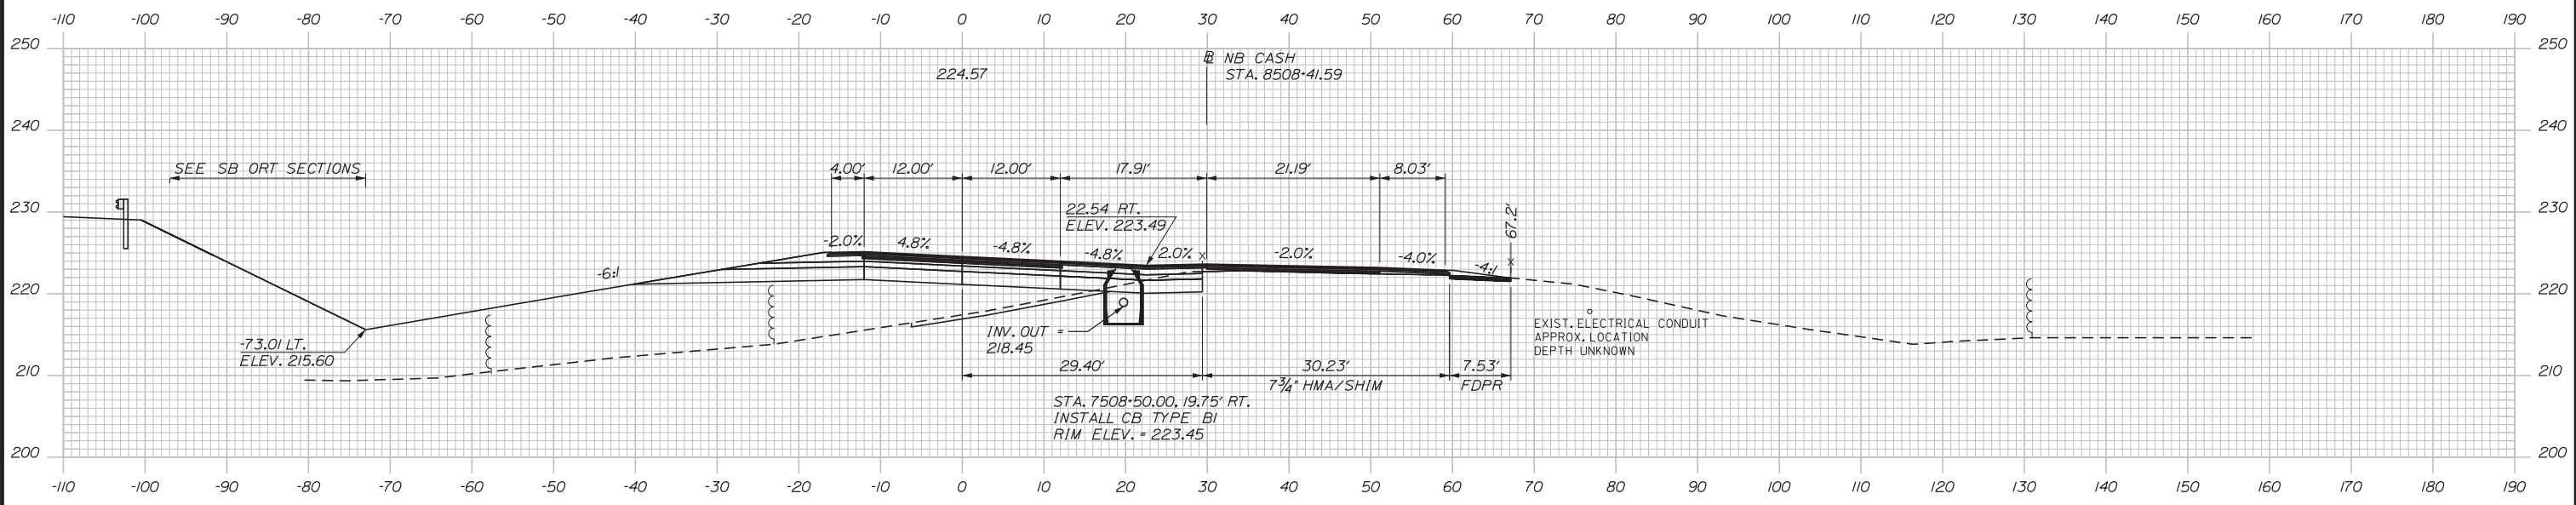

C=40.74 CY  
F=912.99 CY  
G=27.10 CY

 7508+50.00



Designed by:


**Stantec**

CONSULTANT PROJECT MANAGER: LAUREN MEEK, PE

No.	Revision	By	Date

	By	Date		By	Date
Designed	PLP	3\20\19	Checked	LEM	3\20\19
Drawn	EJB	3\20\19	In Charge of	GAE	3\20\19

STANTEC CONSULTING SERVICES INC.  
482 PAYNE ROAD  
SCARBOROUGH, ME 04074  
TEL (207) 887-3448  
FAX (207) 883-3376

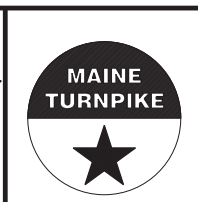


**THE GOLD STAR  
MEMORIAL HIGHWAY**

INTERCHANGE 103  
ORT CONVERSION  
NB ORT  
STA. 7508+50.00 TO STA. 7509+00.00



Filename: ...100\HIGHWAY\MSTA\\_xsect.dgn

Date: 3/20/2019

C=43.50 CY  
F=702.53 CY  
G=23.59 CY

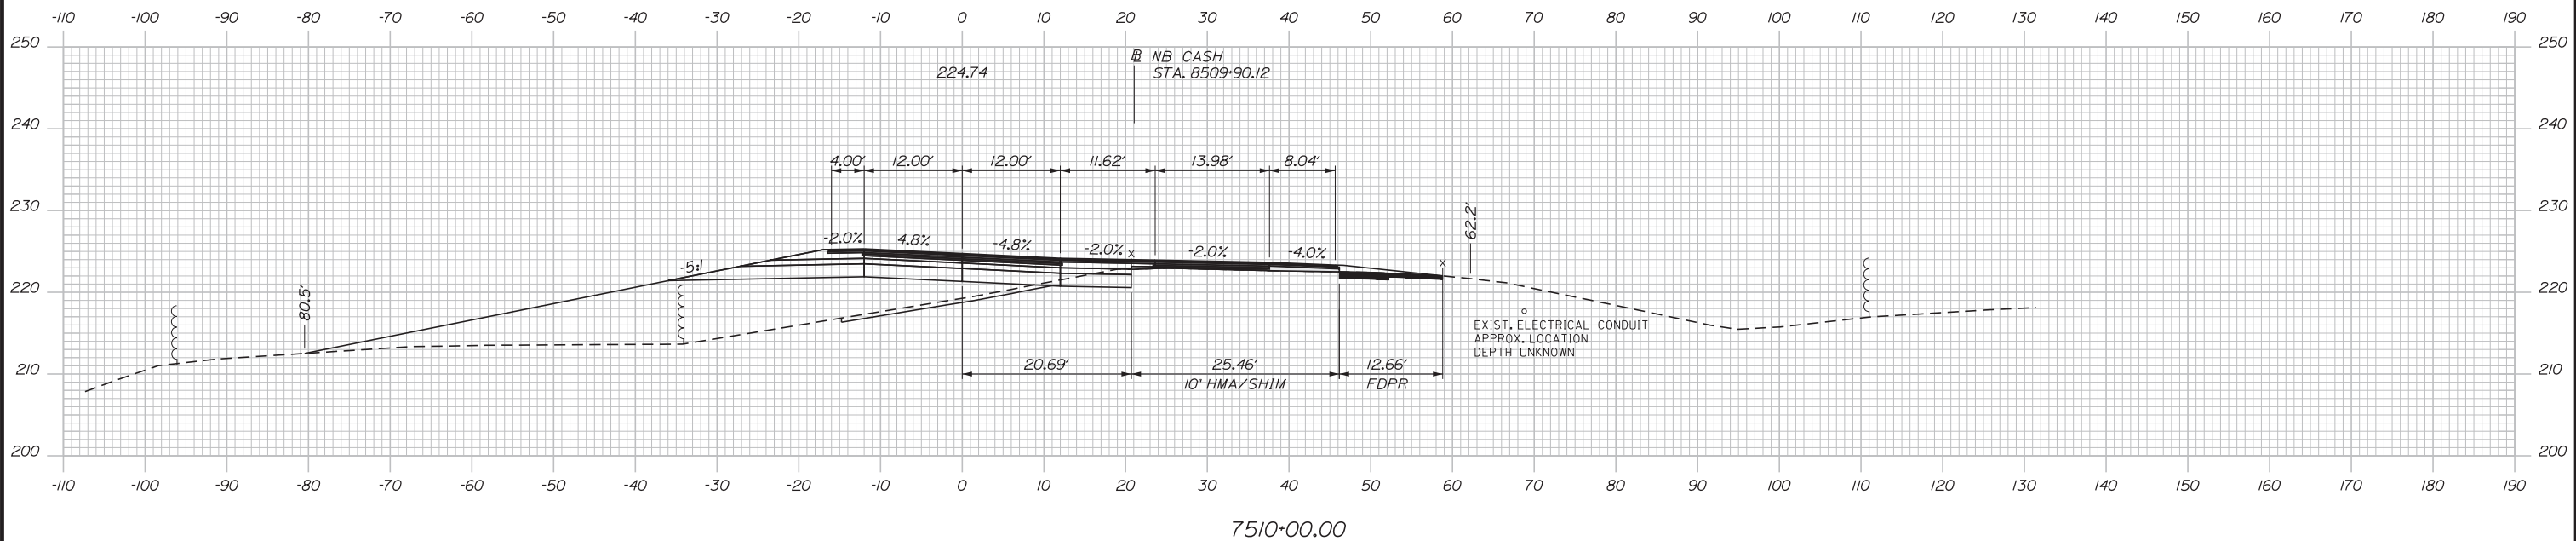

C=40.89 CY  
F=553.95 CY  
G=29.06 CY

 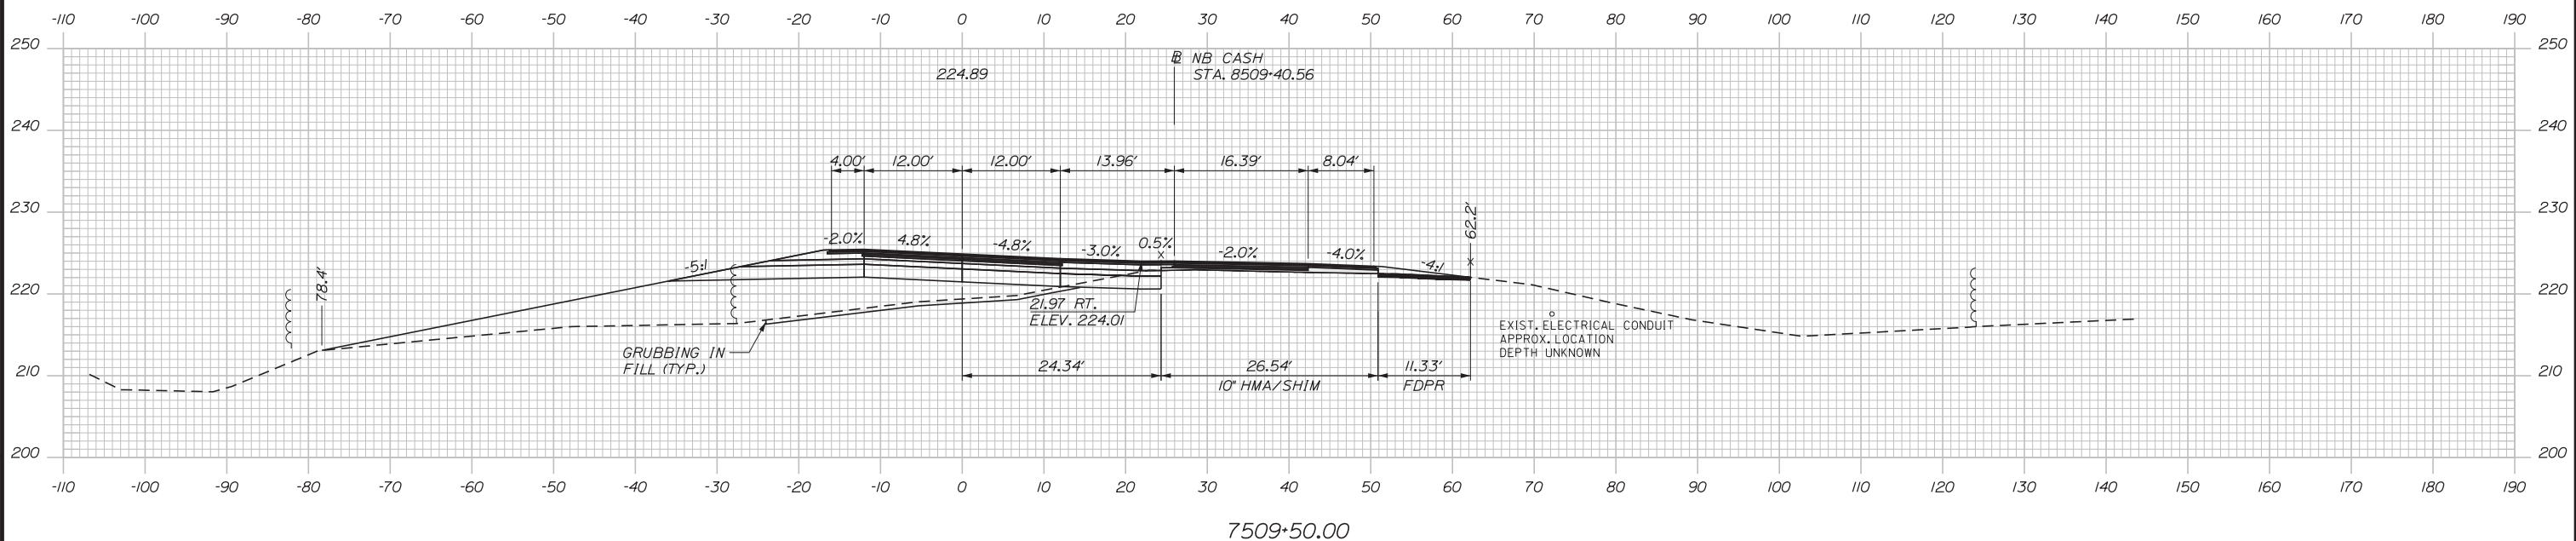

Designed by:


**Stantec**

CONSULTANT PROJECT MANAGER: LAUREN MEEK, PE

No.	Revision	By	Date

	By	Date		By	Date
Designed	PLP	3\20\19	Checked	LEM	3\20\19
Drawn	EJB	3\20\19	In Charge of	GAE	3\20\19

STANTEC CONSULTING SERVICES INC.  
482 PAYNE ROAD  
SCARBOROUGH, ME 04074  
TEL (207) 887-3448  
FAX (207) 883-3376

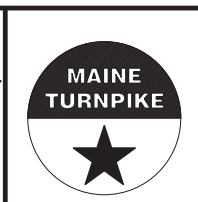

**THE GOLD STAR  
MEMORIAL HIGHWAY**

INTERCHANGE 103  
ORT CONVERSION  
NB ORT  
STA. 7509+50.00 TO STA. 7510+00.00


Filename: ...00.HIGHWAY\MSTA\\_xsect.dgn

MTA PROJECT MANAGER: RALPH NORWOOD, IV, PE, PTOE





Date: 3/20/2019

C=46.08 CY  
F=569.47 CY  
G=26.11 CY

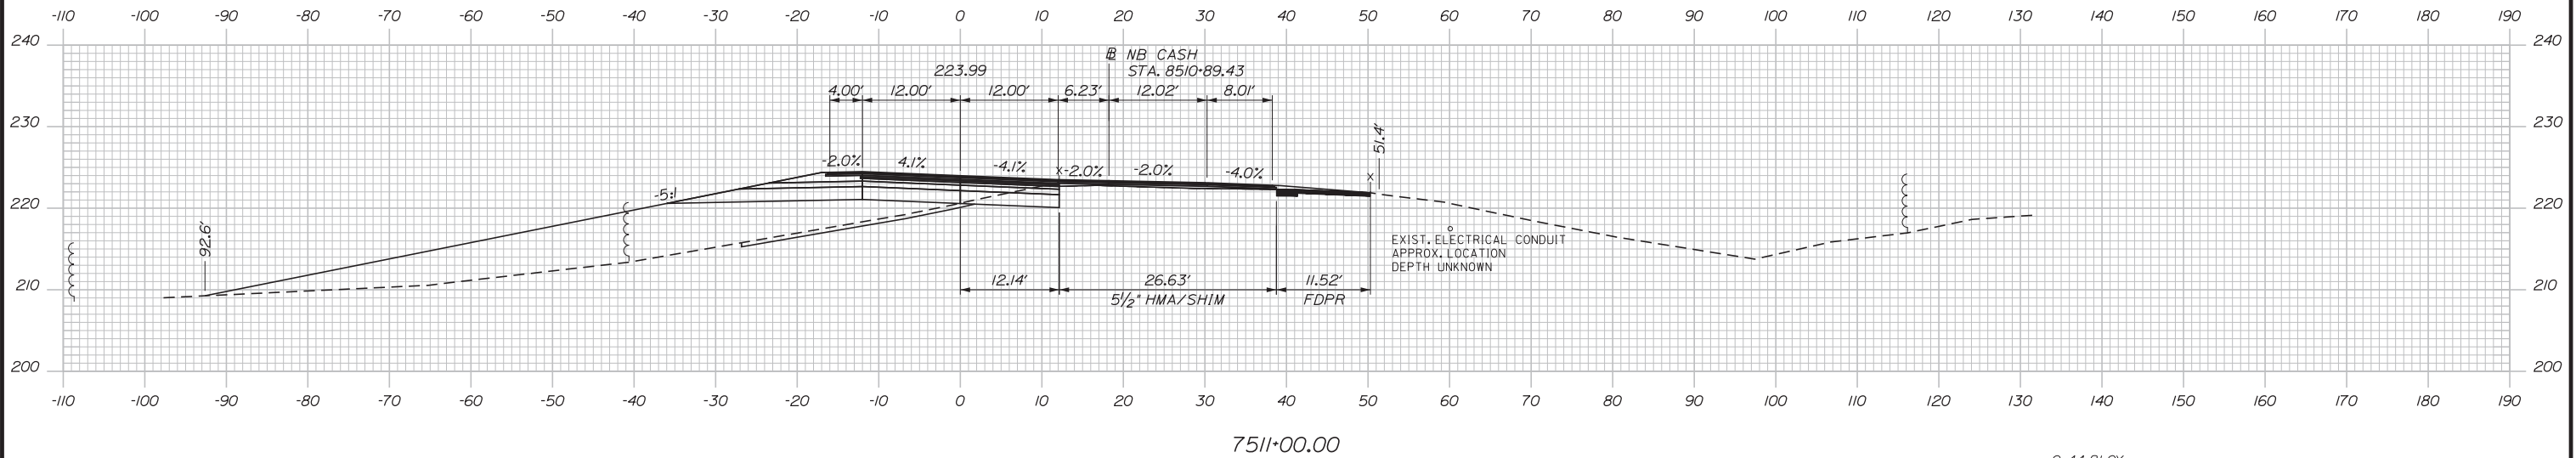

C=44.81 CY  
F=680.54 CY  
G=25.01 CY

 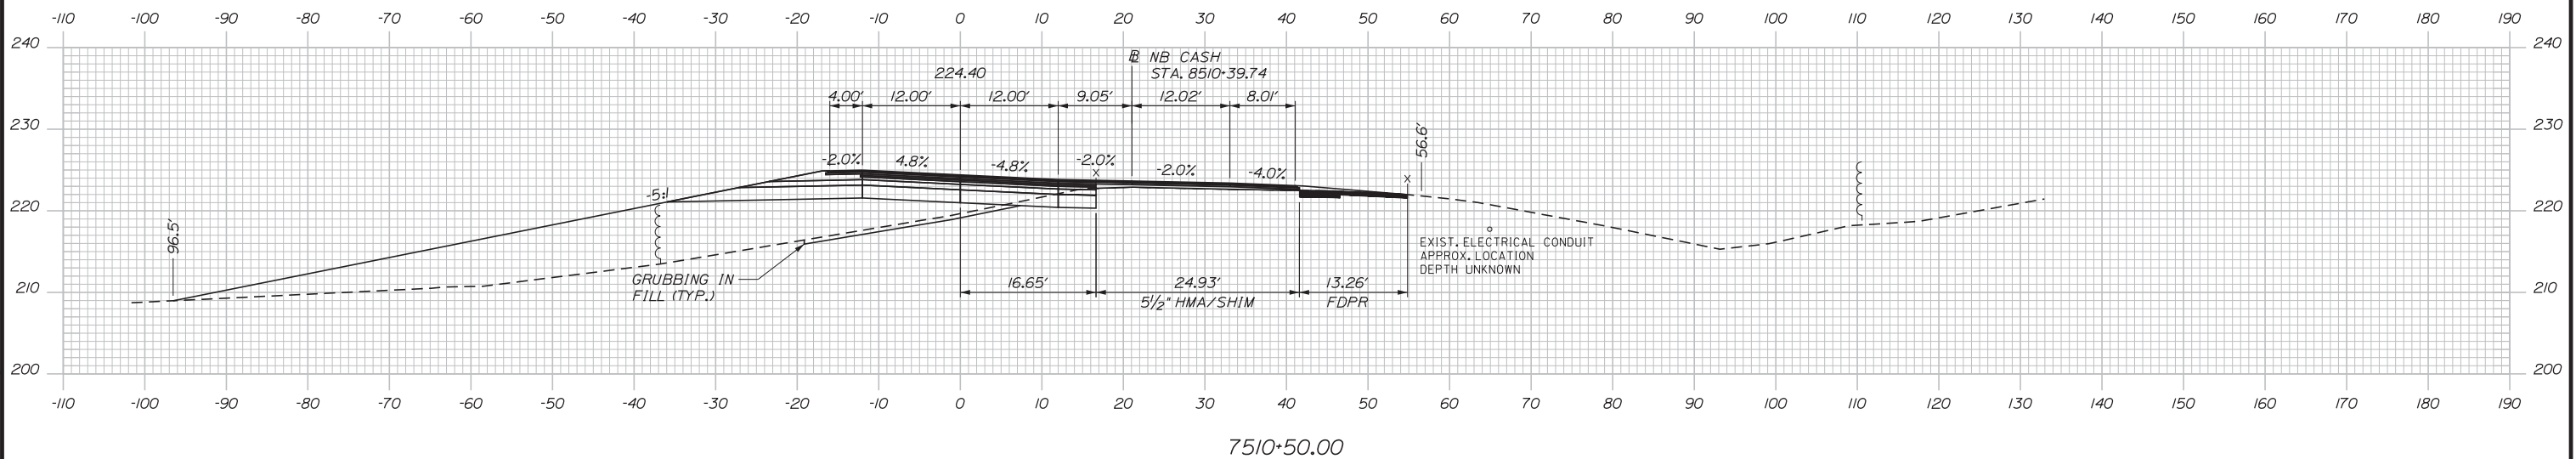

Designed by:

**Stantec**

CONSULTANT PROJECT MANAGER: LAUREN MEEK, PE

No.	Revision	By	Date

	By	Date		By	Date
Designed	PLP	3\20\19	Checked	LEM	3\20\19
Drawn	EJB	3\20\19	In Charge of	GAE	3\20\19

STANTEC CONSULTING SERVICES INC.  
482 PAYNE ROAD  
SCARBOROUGH, ME 04074  
TEL (207) 887-3448  
FAX (207) 883-3376

**MAINE TURNPIKE**

**THE GOLD STAR MEMORIAL HIGHWAY**

MTA PROJECT MANAGER: RALPH NORWOOD, IV, PE, PTOE


INTERCHANGE 103  
ORT CONVERSION  
NB ORT  
STA. 7510+50.00 TO STA. 7511+00.00

SHEET NUMBER: XS-61  
CONTRACT: 2019.04  
295 OF 503



Filename: ...000\HIGHWAY\MSTA\\_xsect.dgn

Date: 3/20/2019

C=41.34 CY  
F=233.68 CY  
G=20.06 CY

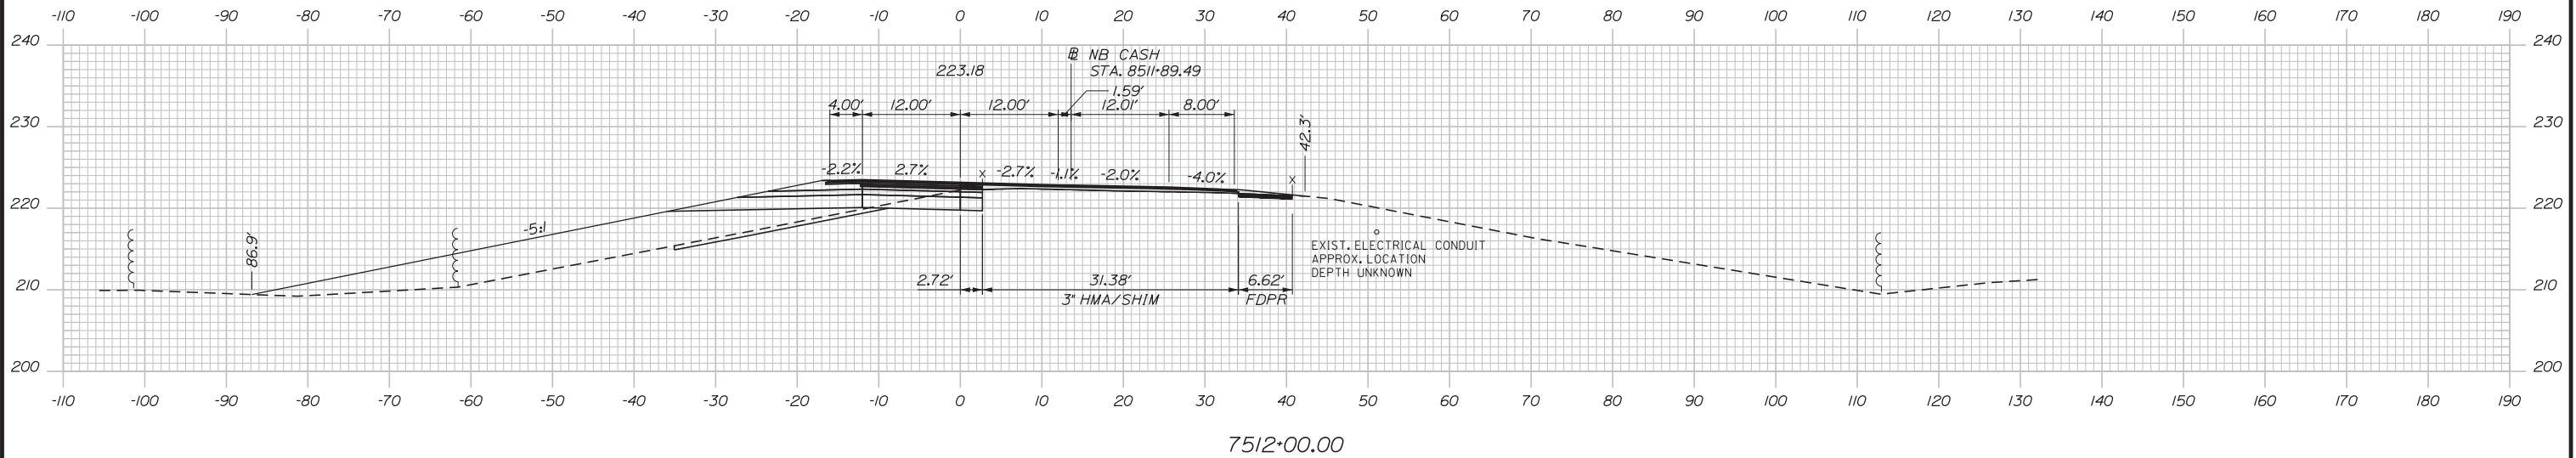

C=45.11 CY  
F=460.40 CY  
G=24.96 CY

 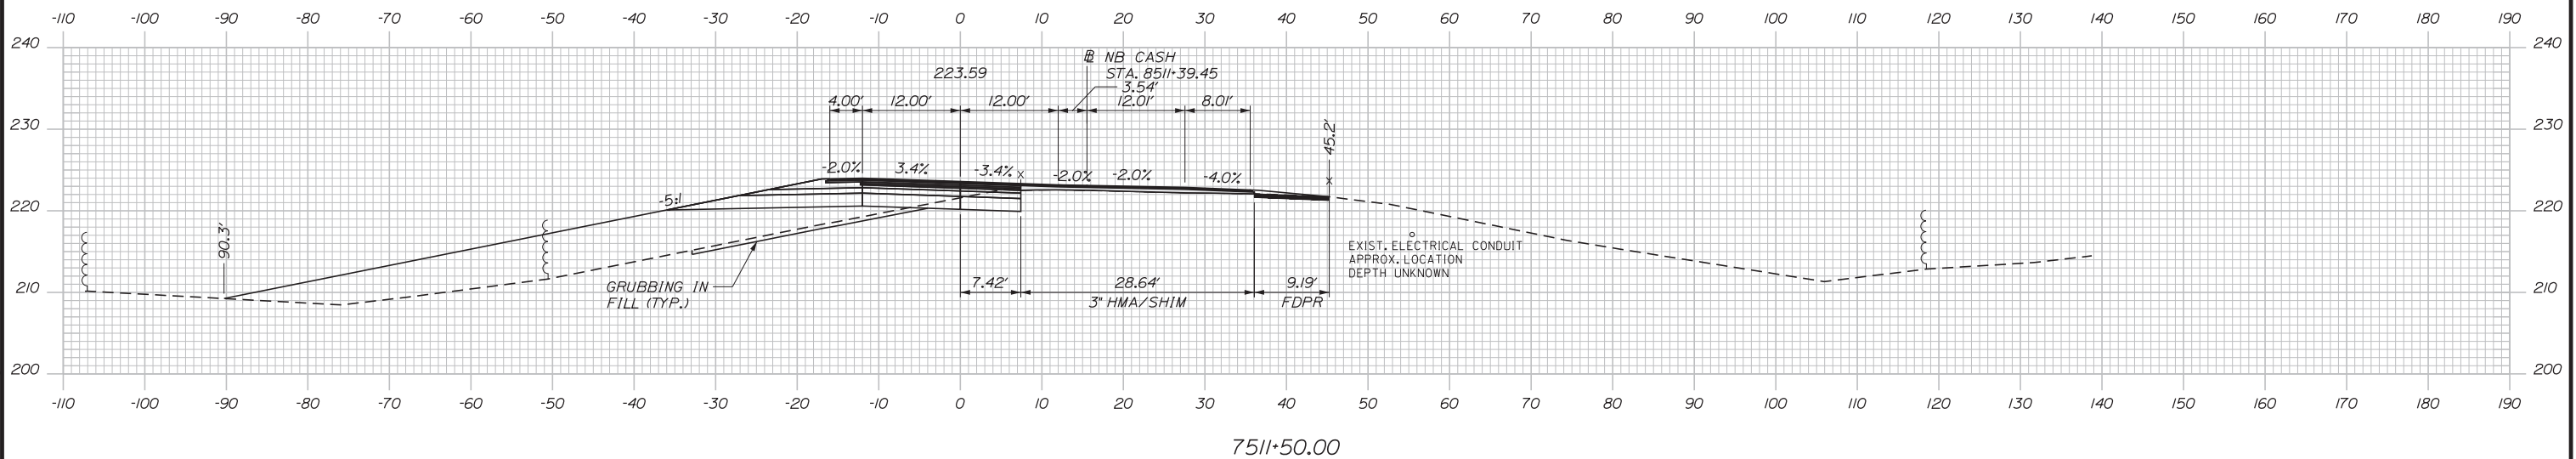

Designed by:



STANTEC CONSULTING SERVICES INC.  
482 PAYNE ROAD  
SCARBOROUGH, ME 04074  
TEL (207) 887-3448  
FAX (207) 883-3376



THE GOLD STAR  
MEMORIAL HIGHWAY

INTERCHANGE 103  
ORT CONVERSION  
NB ORT  
STA. 7511+50.00 TO STA. 7512+00.00

No.	Revision	By	Date

CONSULTANT PROJECT MANAGER: LAUREN MEEK, PE			
Designed	By	Date	Checked
	PLP	3\20\19	LEM
Drawn	By	Date	In Charge of
	EJB	3\20\19	GAE

MTA PROJECT MANAGER: RALPH NORWOOD, IV, PE, PTOE

CONTRACT: 2019.04


SHEET NUMBER: XS-62

296 OF 503



Filename: ... \00.HIGHWAY\MSTA\\_xsect.dgn

Date: 3/20/2019

C=69.89 CY  
F=31.15 CY  
G=8.22 CY

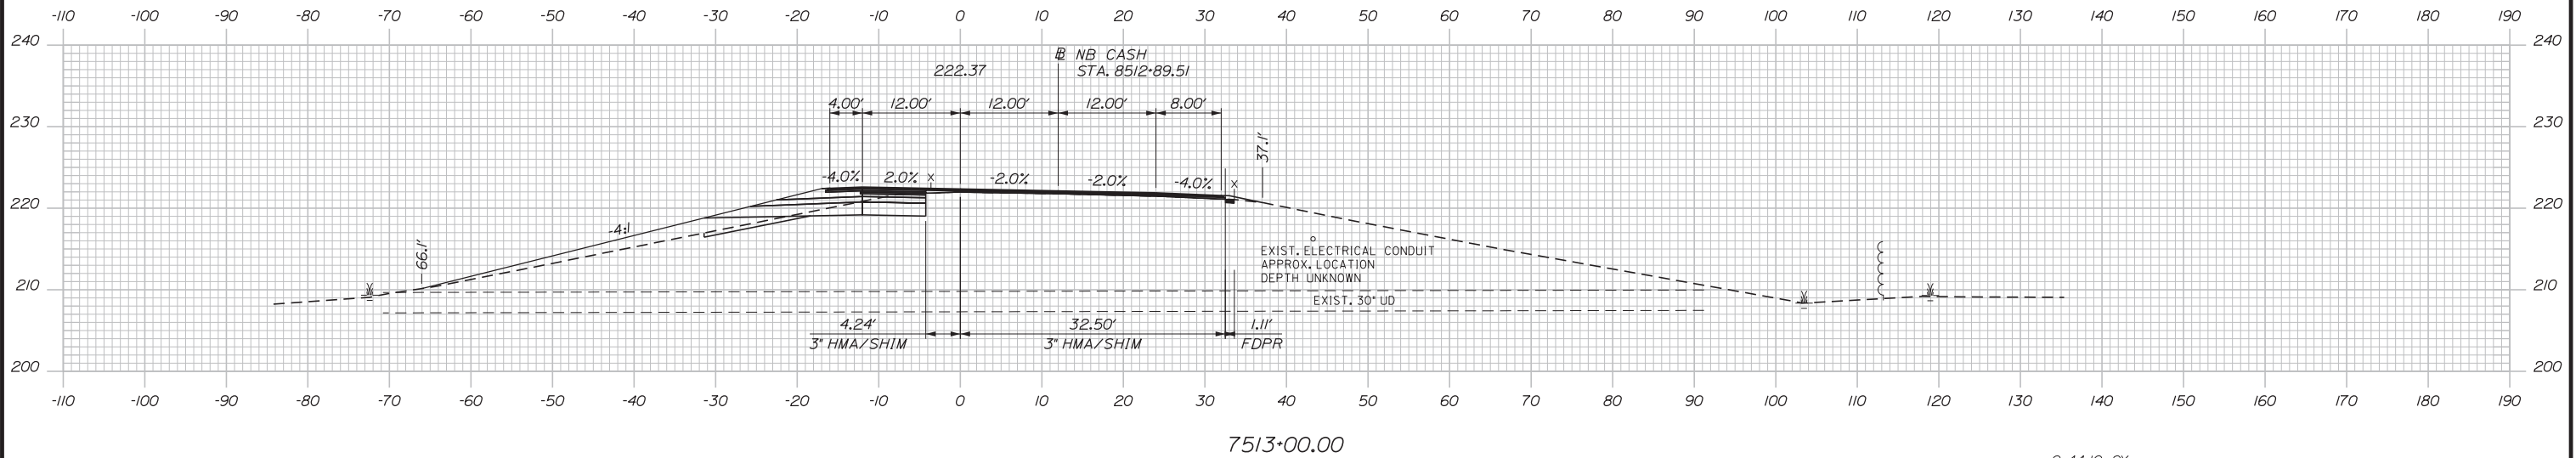

C=44.10 CY  
F=73.19 CY  
G=13.71 CY

 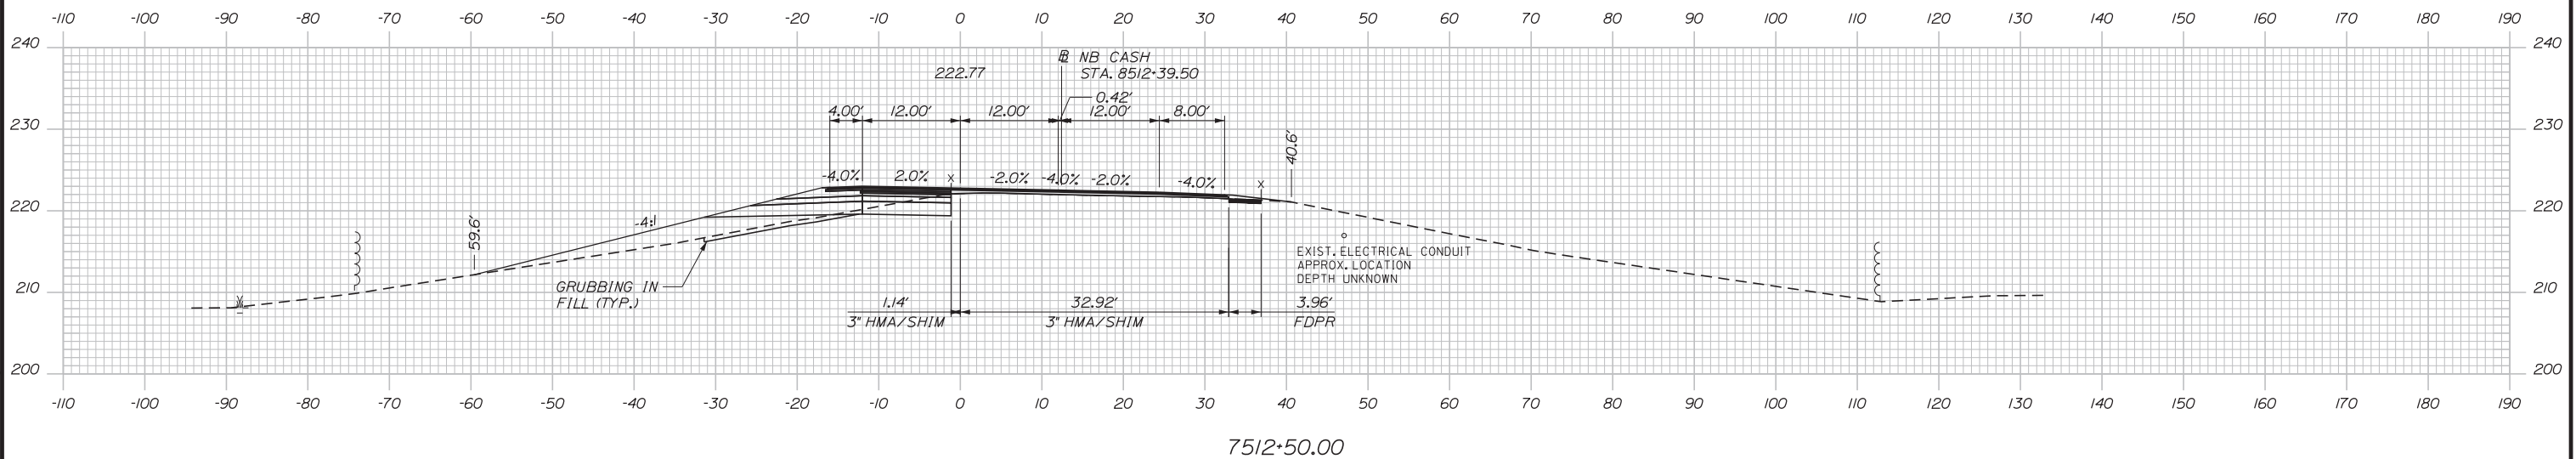

Designed by:



STANTEC CONSULTING SERVICES INC.  
482 PAYNE ROAD  
SCARBOROUGH, ME 04074  
TEL (207) 887-3448  
FAX (207) 883-3376



THE GOLD STAR  
MEMORIAL HIGHWAY

INTERCHANGE 103  
ORT CONVERSION  
NB ORT  
STA. 7512+50.00 TO STA. 7513+00.00

No.	Revision	By	Date

CONSULTANT PROJECT MANAGER: LAUREN MEEK, PE			
Designed	By	Date	Checked
Drawn	By	Date	In Charge of
	PLP	3\20\19	LEM
	EJB	3\20\19	GAE

MTA PROJECT MANAGER: RALPH NORWOOD, IV, PE, PTOE

CONTRACT: 2019.04


SHEET NUMBER: XS-63

297 OF 503

Filename: ...00.HIGHWAY\MSTA\\_xsect.dgn


Date: 3/20/2019

C=140.10 CY  
F=30.43 CY  
G=7.09 CY

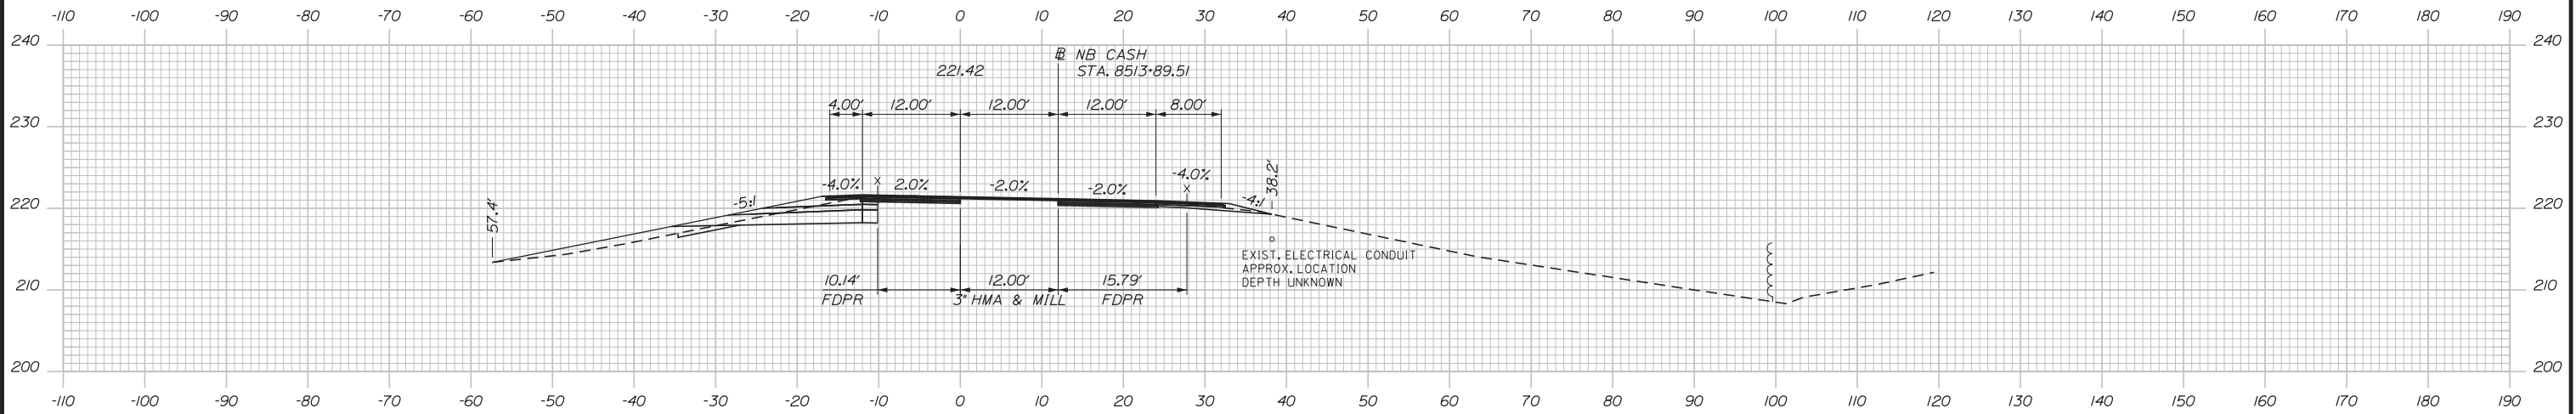


7514+00.00

C=96.25 CY  
F=12.51 CY  
G=5.62 CY

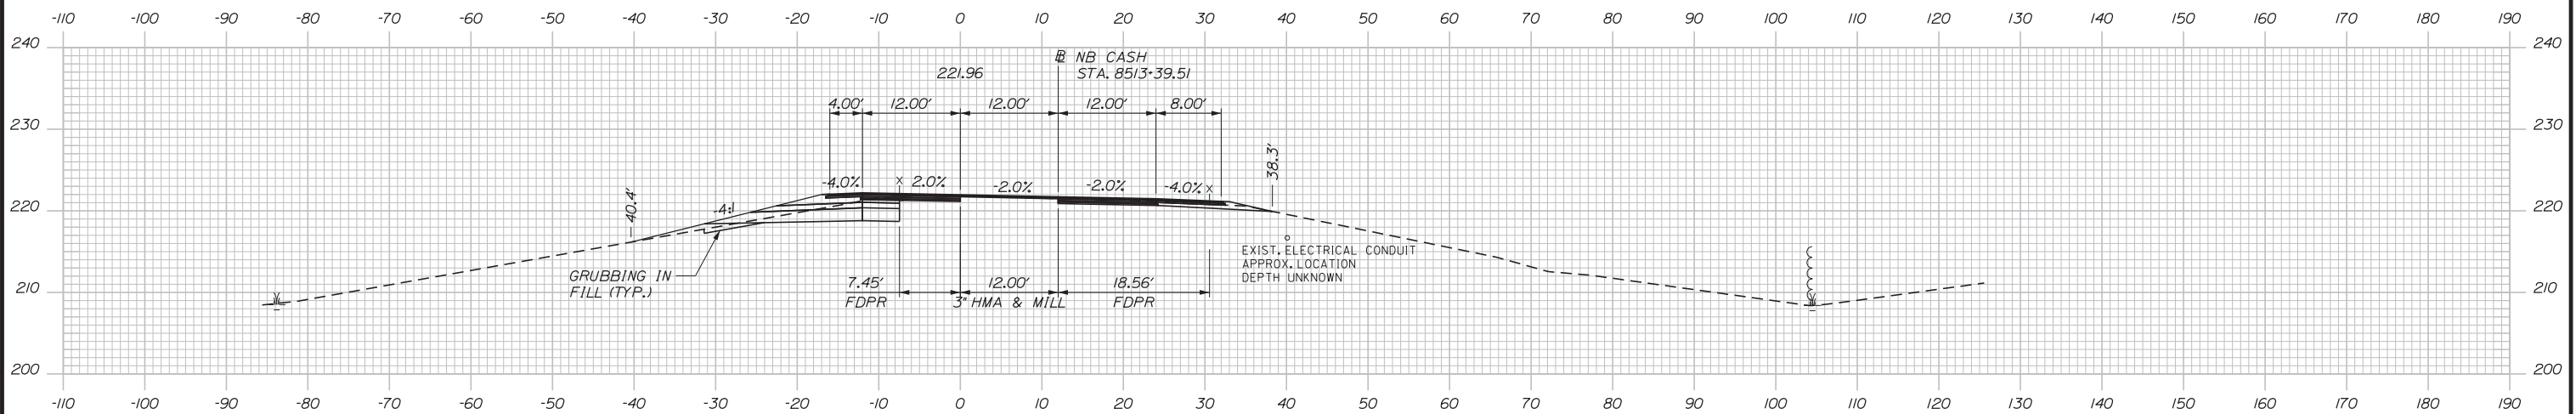

7513+50.00

 

Designed by:



STANTEC CONSULTING SERVICES INC.  
482 PAYNE ROAD  
SCARBOROUGH, ME 04074  
TEL (207) 887-3448  
FAX (207) 883-3376



THE GOLD STAR  
MEMORIAL HIGHWAY

INTERCHANGE 103  
ORT CONVERSION  
NB ORT  
STA. 7513+50.00 TO STA. 7514+00.00

No.	Revision	By	Date

CONSULTANT PROJECT MANAGER: LAUREN MEEK, PE			
Designed	By	Date	Checked
	PLP	3\20\19	LEM
Drawn	By	Date	In Charge of
	EJB	3\20\19	GAE

MTA PROJECT MANAGER: RALPH NORWOOD, IV, PE, PTOE

CONTRACT: 2019.04


SHEET NUMBER: XS-64

298 OF 503



Filename: ...00.HIGHWAY\MSTA\\_xsect.dgn

Date: 3/20/2019

C=173.02 CY  
F=35.02 CY  
G=9.38 CY

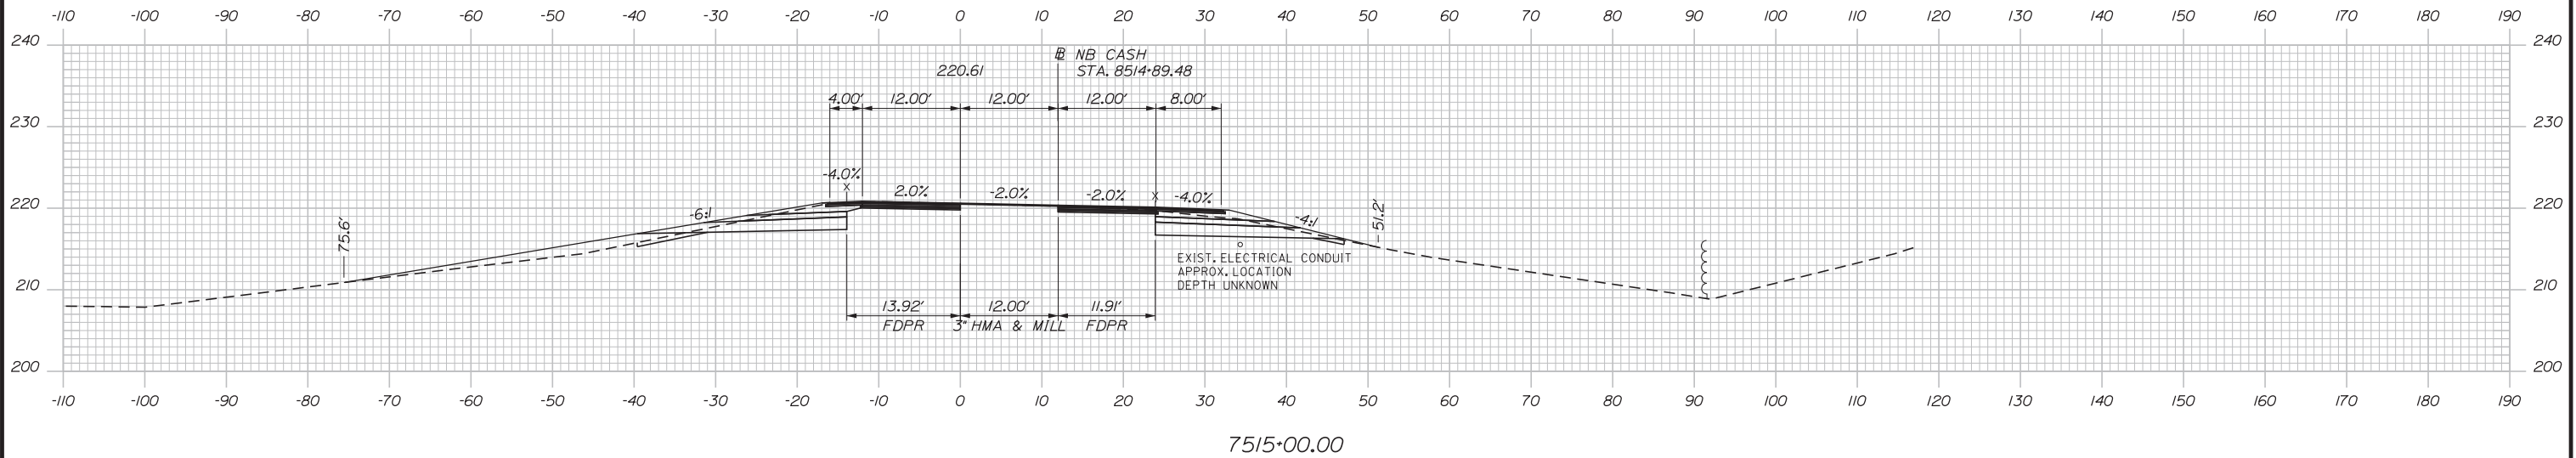

C=174.83 CY  
F=37.61 CY  
G=8.81 CY

 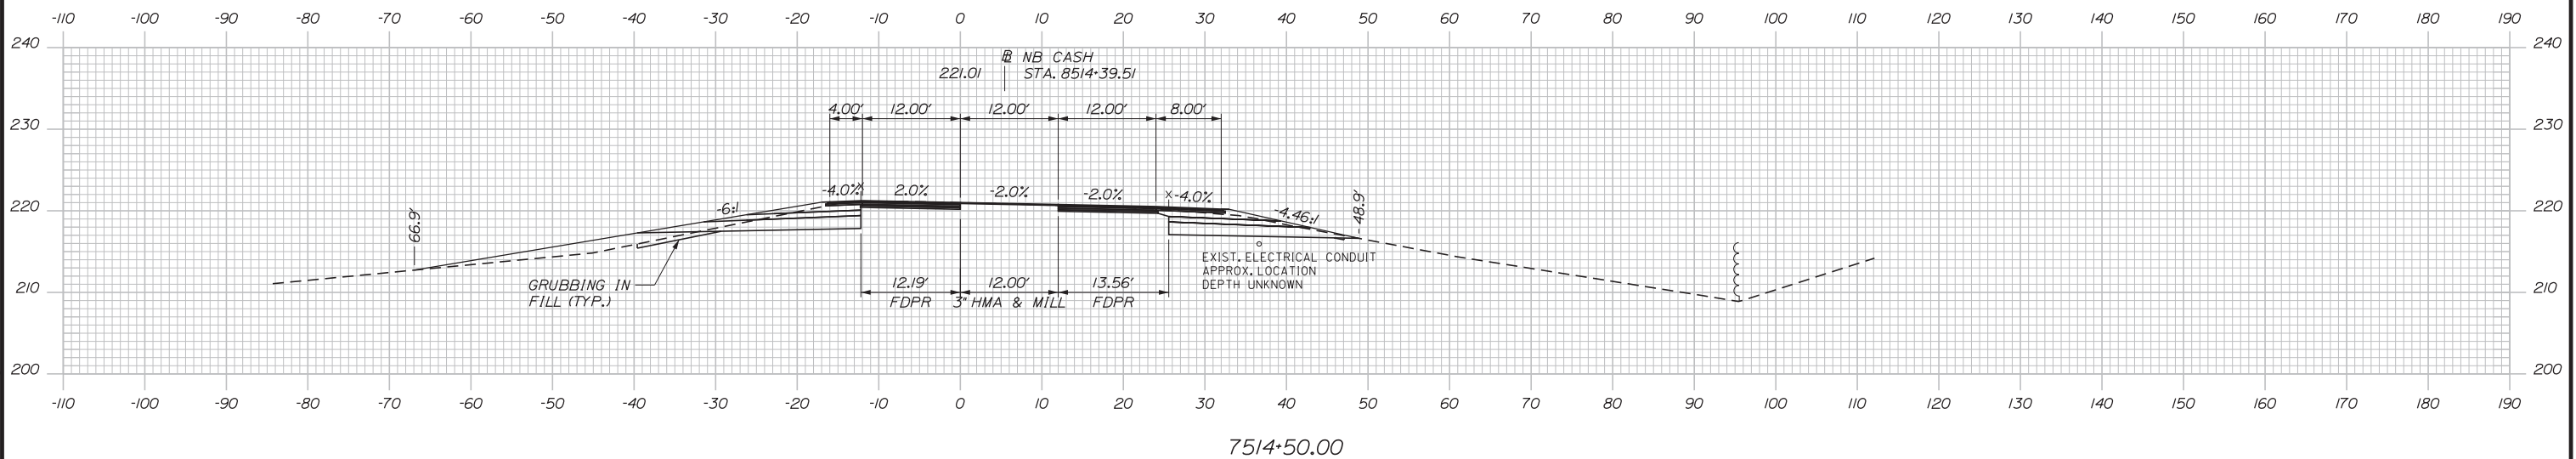

Designed by:



STANTEC CONSULTING SERVICES INC.  
482 PAYNE ROAD  
SCARBOROUGH, ME 04074  
TEL (207) 887-3448  
FAX (207) 883-3376



THE GOLD STAR  
MEMORIAL HIGHWAY

INTERCHANGE 103  
ORT CONVERSION  
NB ORT  
STA. 7514+50.00 TO STA. 7515+00.00

No.	Revision	By	Date

CONSULTANT PROJECT MANAGER: LAUREN MEEK, PE			
Designed	By	Date	Checked
	PLP	3\20\19	LEM
Drawn	By	Date	In Charge of
	EJB	3\20\19	GAE

MTA PROJECT MANAGER: RALPH NORWOOD, IV, PE, PTOE

CONTRACT: 2019.04


SHEET NUMBER: XS-65

299 OF 503


Filename: ...00.HIGHWAY\MSTA\\_xsect.dgn



Date: 3/20/2019

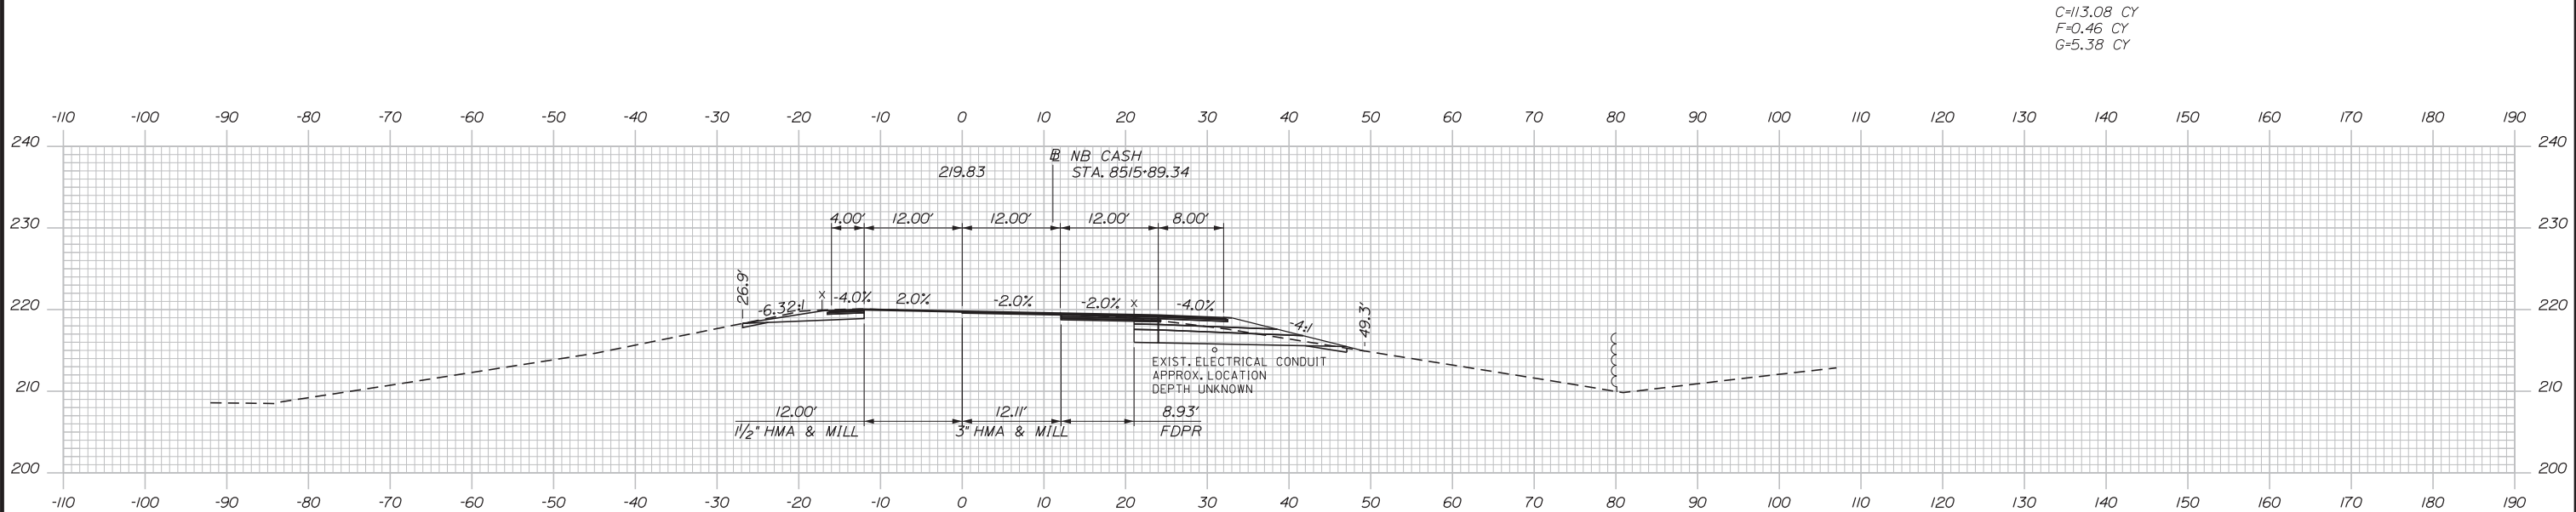


C=113.08 CY  
F=0.46 CY  
G=5.38 CY

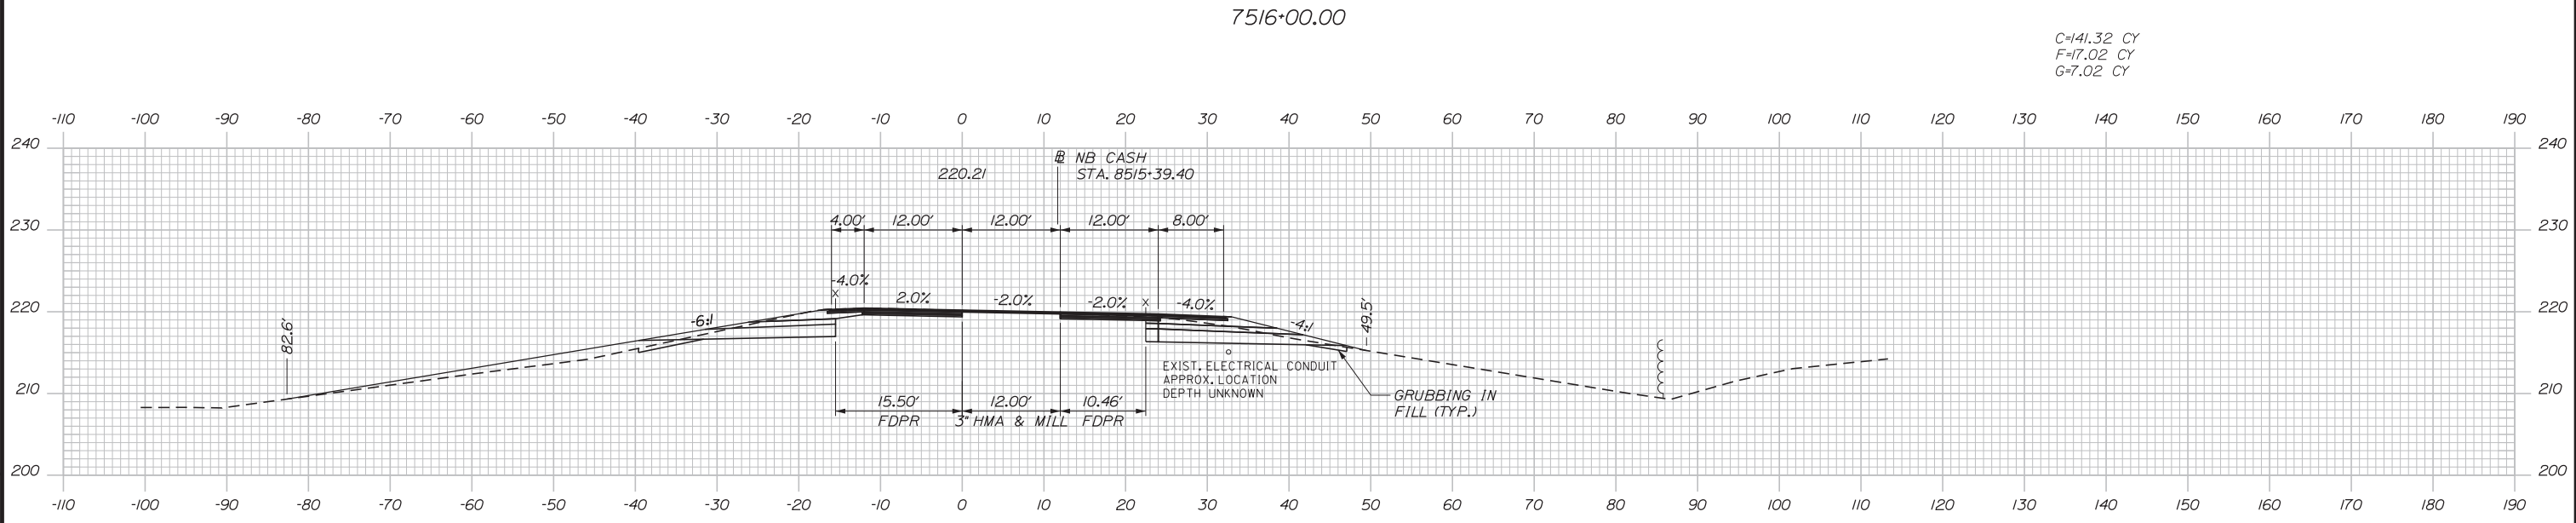

C=141.32 CY  
F=17.02 CY  
G=7.02 CY

 Filename: ...00.HIGHWAY\MSTA\\_xsect.dgn



Designed by:


**Stantec**

CONSULTANT PROJECT MANAGER: LAUREN MEEK, PE

No.	Revision	By	Date

	By	Date		By	Date
Designed	PLP	3\20\19	Checked	LEM	3\20\19
Drawn	EJB	3\20\19	In Charge of	GAE	3\20\19

STANTEC CONSULTING SERVICES INC.  
482 PAYNE ROAD  
SCARBOROUGH, ME 04074  
TEL (207) 887-3448  
FAX (207) 883-3376



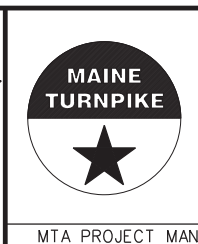


**THE GOLD STAR  
MEMORIAL HIGHWAY**

INTERCHANGE 103  
ORT CONVERSION  
NB ORT  
STA. 7515+50.00 TO STA. 7516+00.00

SHEET NUMBER: XS-66  
CONTRACT: 2019.04  
300 OF 503

 Date: 3/20/2019

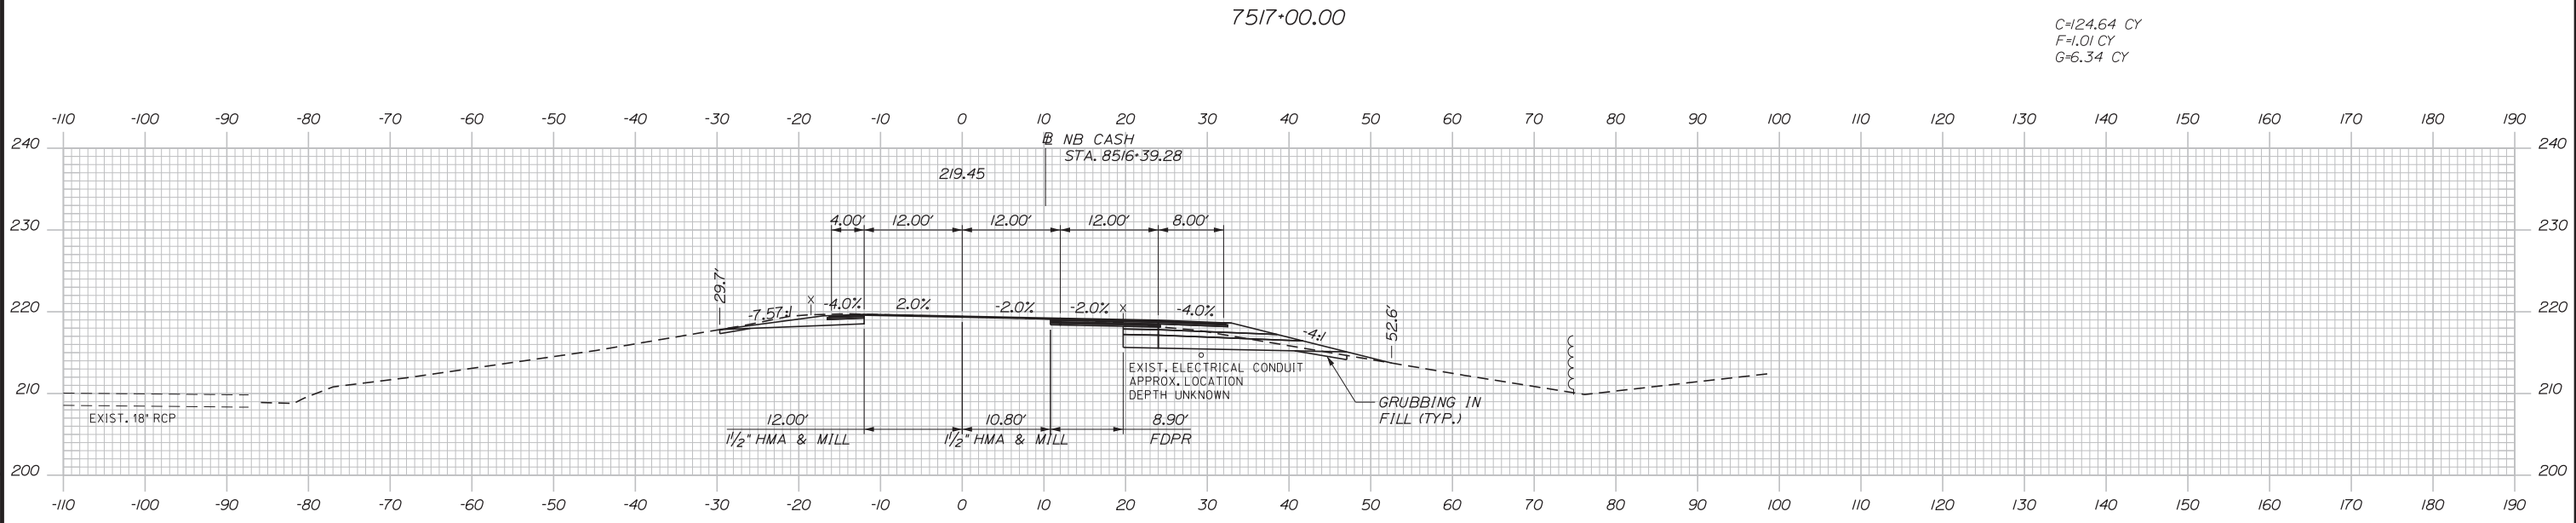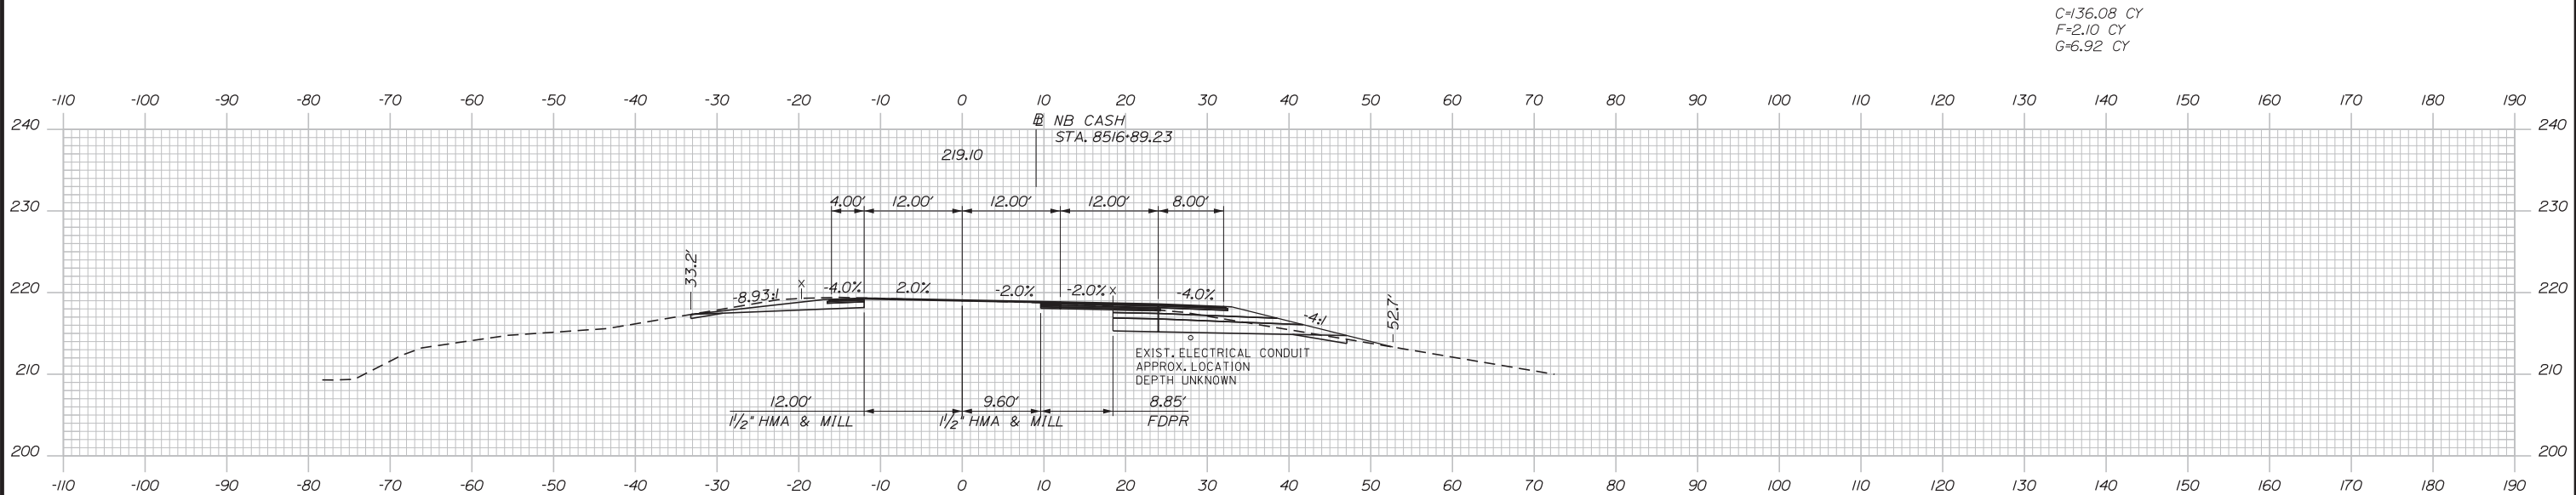

Designed by:


**Stantec**

CONSULTANT PROJECT MANAGER: LAUREN MEEK, PE

No.	Revision	By	Date

	By	Date		By	Date
Designed	PLP	3\20\19	Checked	LEM	3\20\19
Drawn	EJB	3\20\19	In Charge of	GAE	3\20\19

STANTEC CONSULTING SERVICES INC.  
482 PAYNE ROAD  
SCARBOROUGH, ME 04074  
TEL (207) 887-3448  
FAX (207) 883-3376

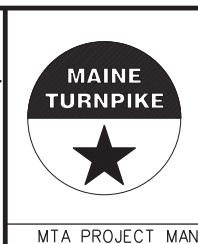


**THE GOLD STAR  
MEMORIAL HIGHWAY**

INTERCHANGE 103  
ORT CONVERSION  
NB ORT  
STA. 7516+50.00 TO STA. 7517+00.00


SHEET NUMBER: XS-67  
CONTRACT: 2019.04  
301 OF 503

Filename: ...00.HIGHWAY\MSTA\\_xsect.dgn


Date: 3/20/2019

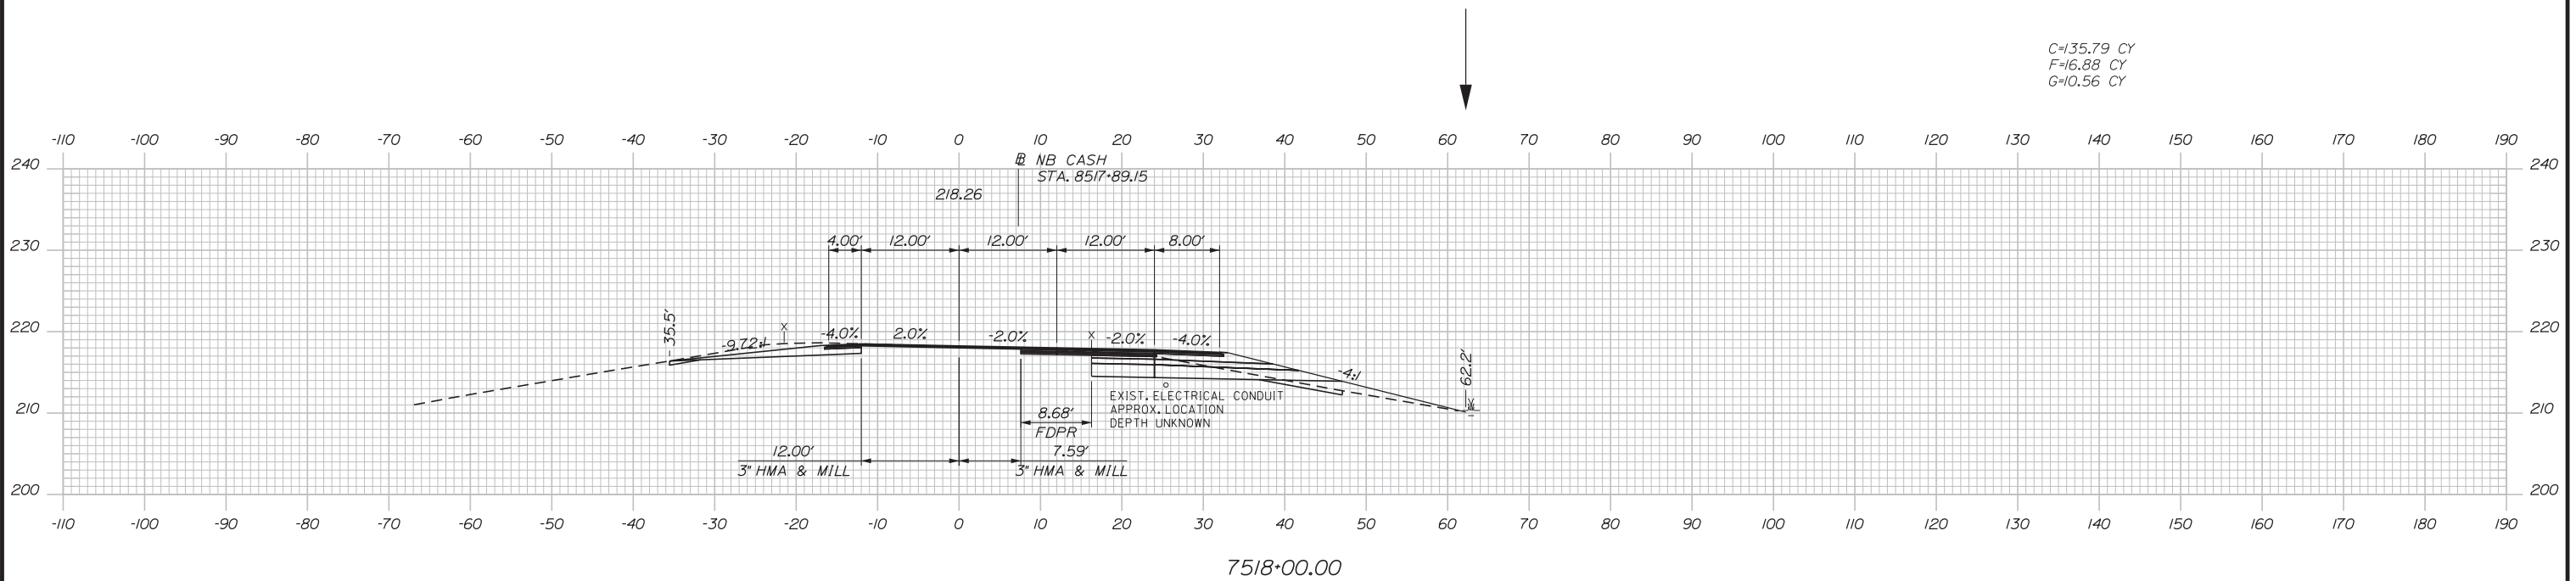

C=135.79 CY  
F=16.88 CY  
G=10.56 CY

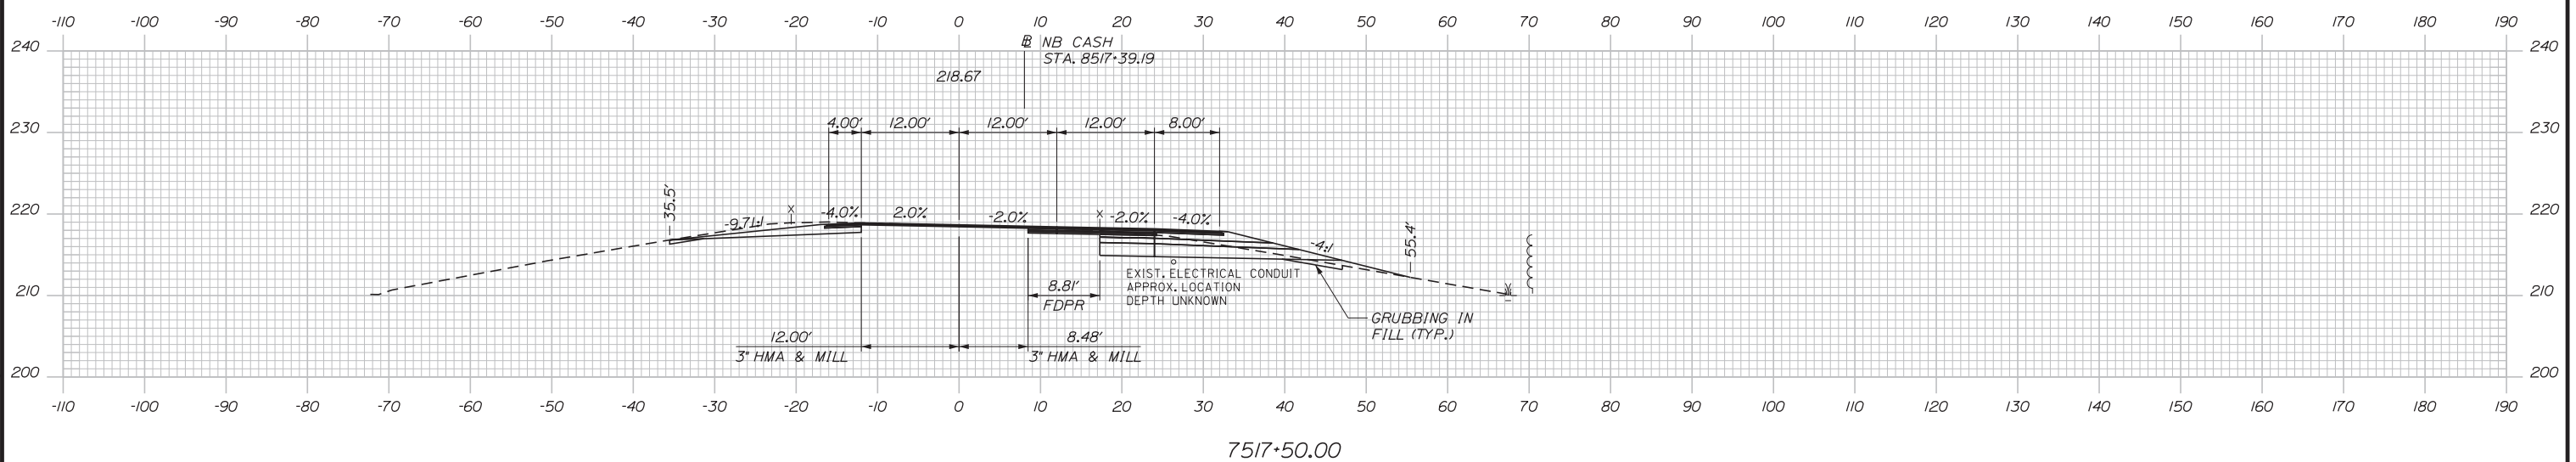

C=138.59 CY  
F=9.25 CY  
G=8.69 CY

 

Designed by:


**Stantec**

CONSULTANT PROJECT MANAGER: LAUREN MEEK, PE

No.	Revision	By	Date

	By	Date		By	Date
Designed	PLP	3\20\19	Checked	LEM	3\20\19
Drawn	EJB	3\20\19	In Charge of	GAE	3\20\19

STANTEC CONSULTING SERVICES INC.  
482 PAYNE ROAD  
SCARBOROUGH, ME 04074  
TEL (207) 887-3448  
FAX (207) 883-3376

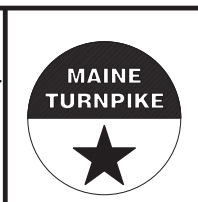



**THE GOLD STAR  
MEMORIAL HIGHWAY**

INTERCHANGE 103  
ORT CONVERSION  
NB ORT  
STA. 7517+50.00 TO STA. 7518+00.00

SHEET NUMBER: XS-68  
CONTRACT: 2019.04  
302 OF 503

Filename: ...00.HIGHWAY\MSTA\\_xsect.dgn

 Date: 3/20/2019

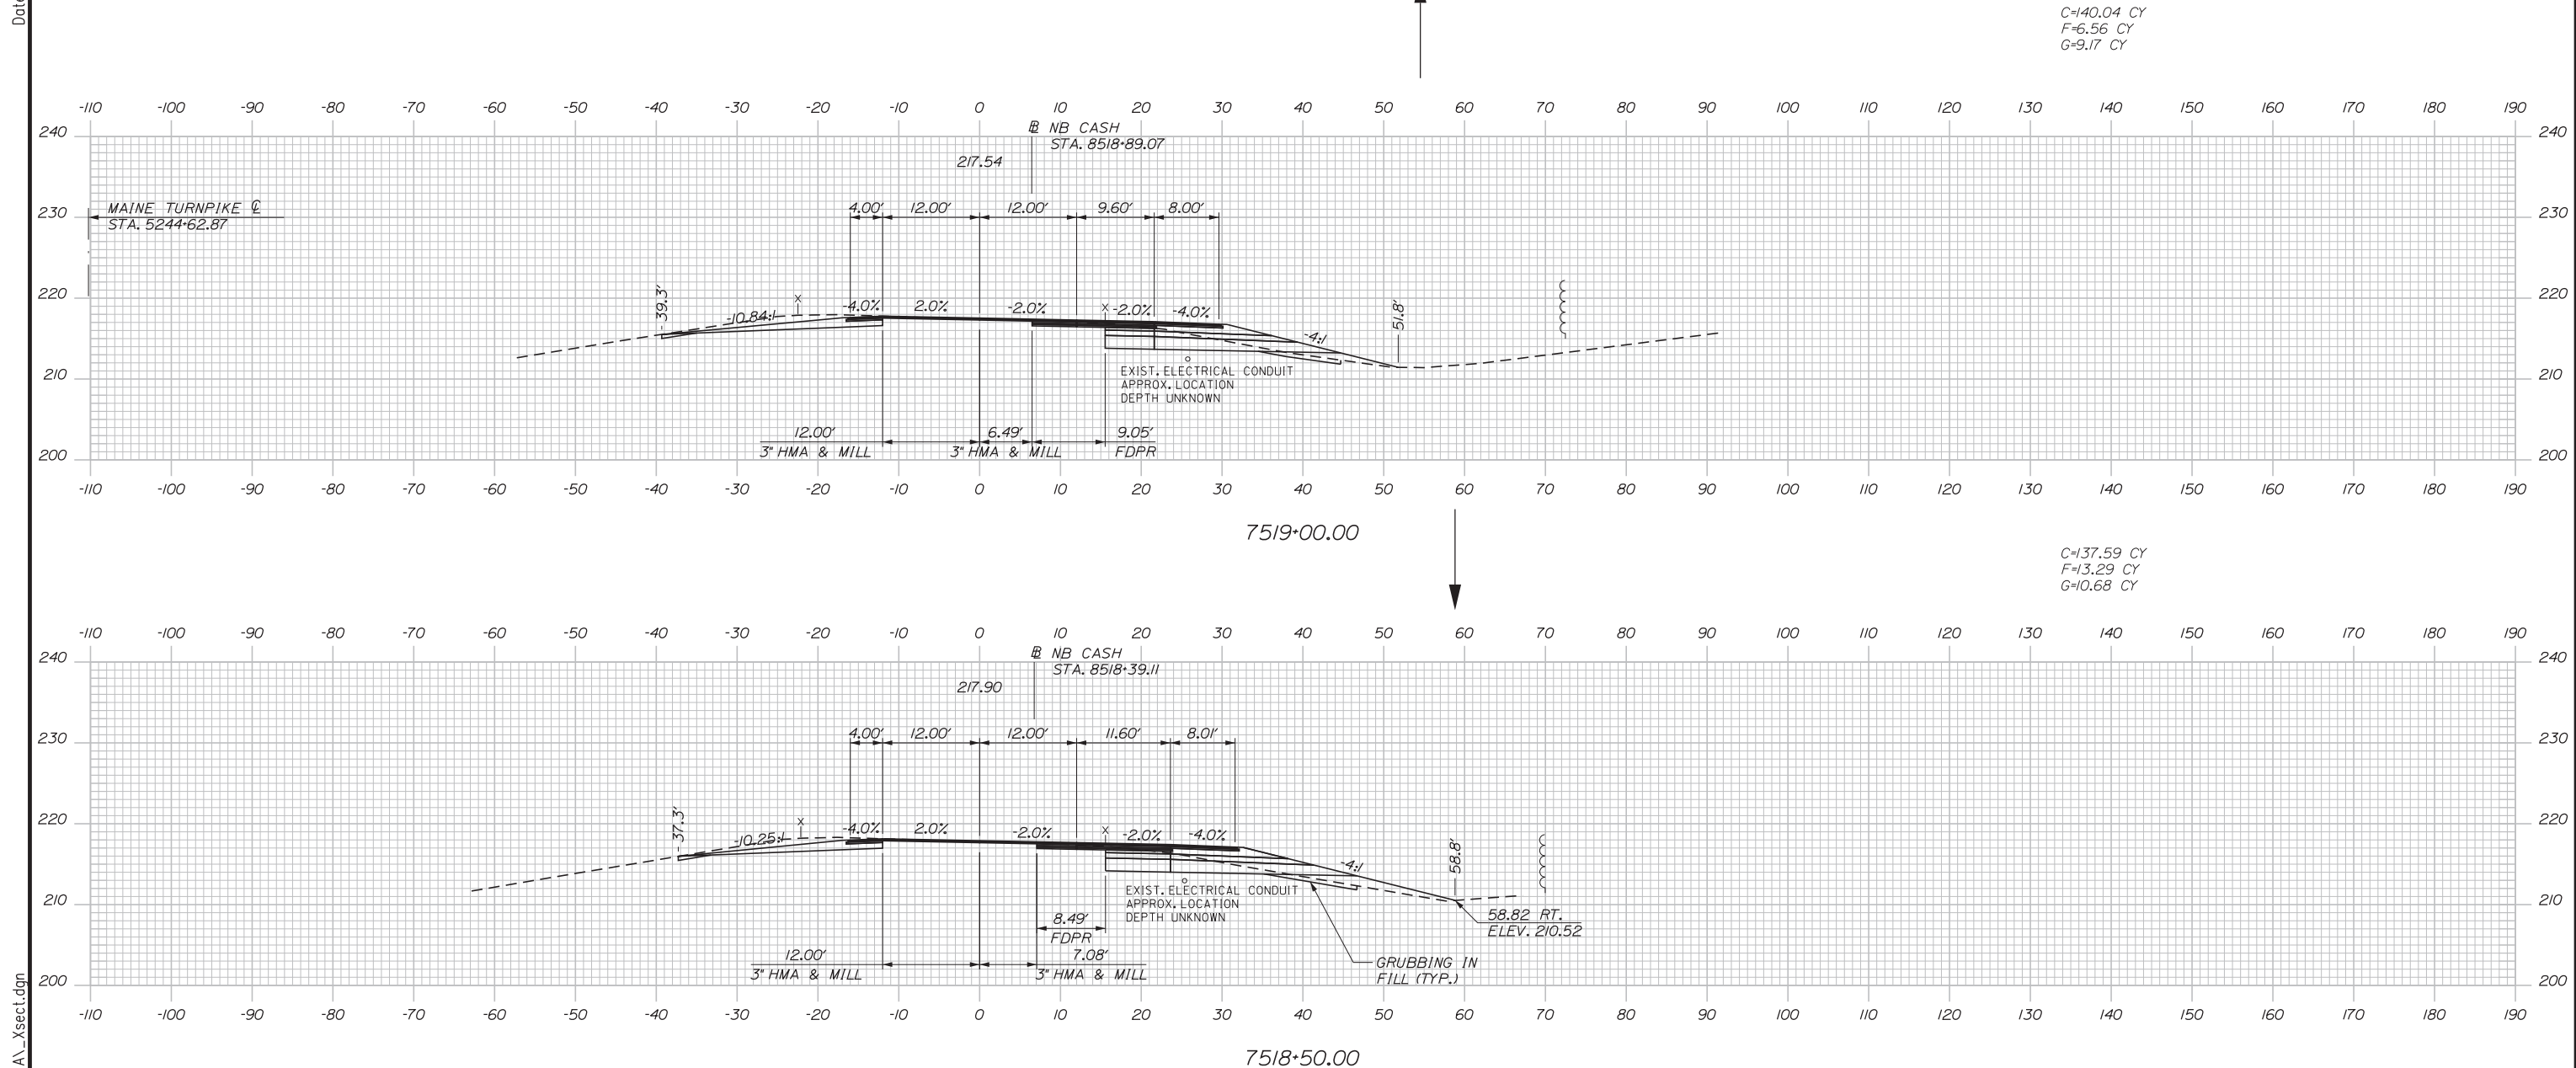

Designed by:

**Stantec**

CONSULTANT PROJECT MANAGER: LAUREN MEEK, PE

No.	Revision	By	Date

	By	Date		By	Date
Designed	PLP	3\20\19	Checked	LEM	3\20\19
Drawn	EJB	3\20\19	In Charge of	GAE	3\20\19

STANTEC CONSULTING SERVICES INC.  
482 PAYNE ROAD  
SCARBOROUGH, ME 04074  
TEL (207) 887-3448  
FAX (207) 883-3376

**MAINE TURNPIKE**


**THE GOLD STAR MEMORIAL HIGHWAY**

MTA PROJECT MANAGER: RALPH NORWOOD, IV, PE, PTOE

INTERCHANGE 103  
ORT CONVERSION  
NB ORT  
STA. 7518+50.00 TO STA. 7519+00.00


SHEET NUMBER: XS-69  
CONTRACT: 2019.04  
303 OF 503

Date: 3/20/2019

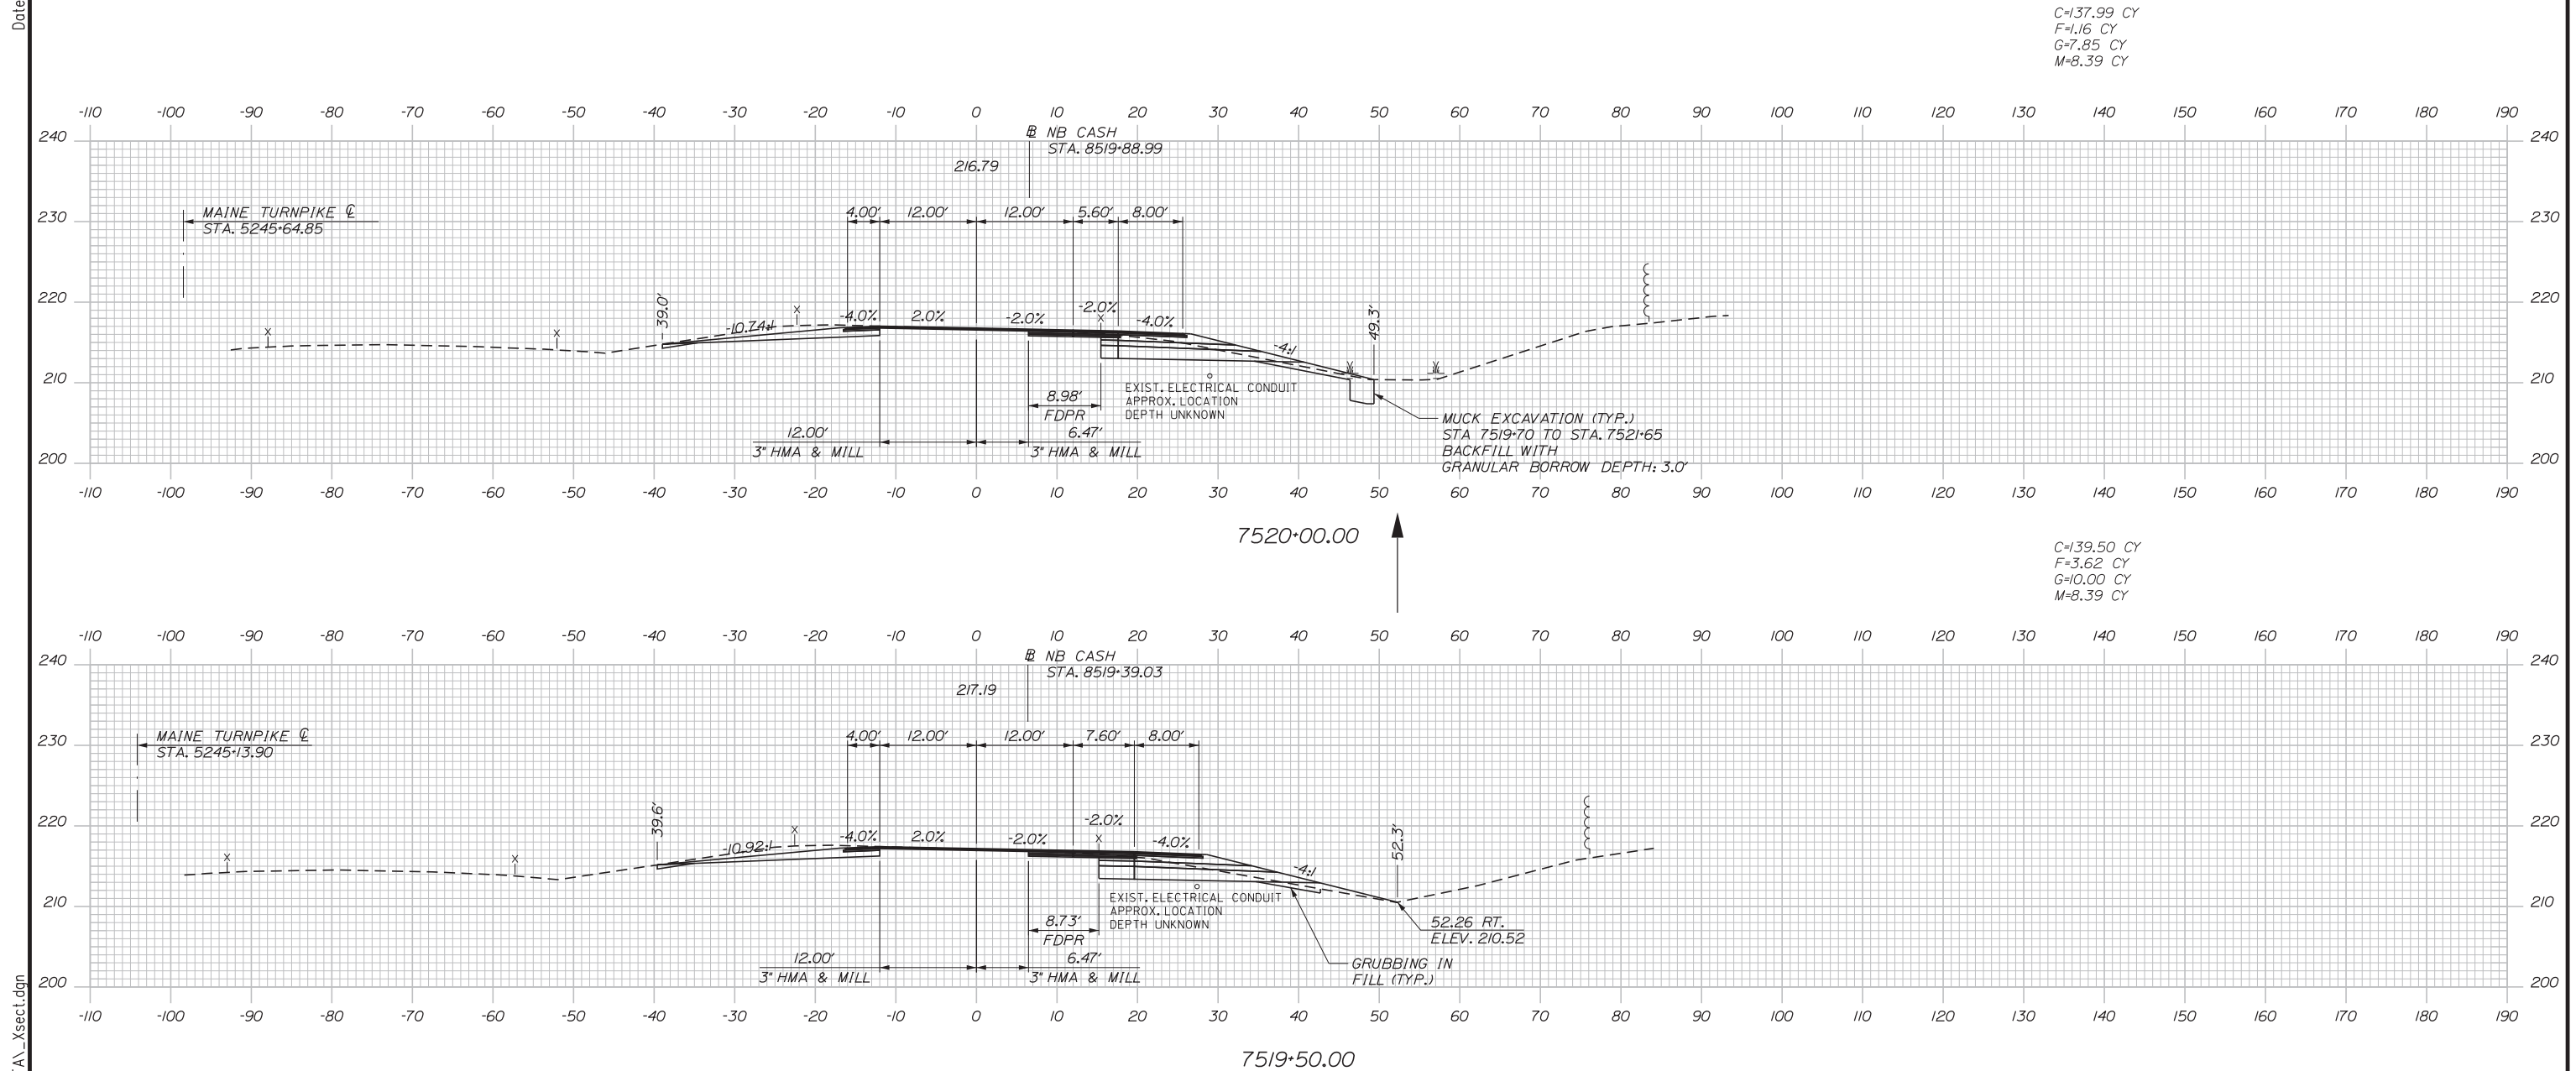

C=137.99 CY  
 F=1.16 CY  
 G=7.85 CY  
 M=8.39 CY

 C=139.50 CY  
 F=3.62 CY  
 G=10.00 CY  
 M=8.39 CY



Designed by:

**Stantec**

CONSULTANT PROJECT MANAGER: LAUREN MEEK, PE

No.	Revision	By	Date

	By	Date		By	Date
Designed	PLP	3\20\19	Checked	LEM	3\20\19
Drawn	EJB	3\20\19	In Charge of	GAE	3\20\19

STANTEC CONSULTING SERVICES INC.  
 482 PAYNE ROAD  
 SCARBOROUGH, ME 04074  
 TEL (207) 887-3448  
 FAX (207) 883-3376

**MAINE TURNPIKE**

**THE GOLD STAR MEMORIAL HIGHWAY**

MTA PROJECT MANAGER: RALPH NORWOOD, IV, PE, PTOE

INTERCHANGE 103  
 ORT CONVERSION  
 NB ORT  
 STA. 7519+50.00 TO STA. 7520+00.00

SHEET NUMBER: XS-70  
 304 OF 503


CONTRACT: 2019.04

Filename: ...000.HIGHWAY\MSTA\\_xsect.dgn





Date: 3/20/2019

C=117.81 CY  
 F=11.02 CY  
 G=10.14 CY  
 M=38.25 CY

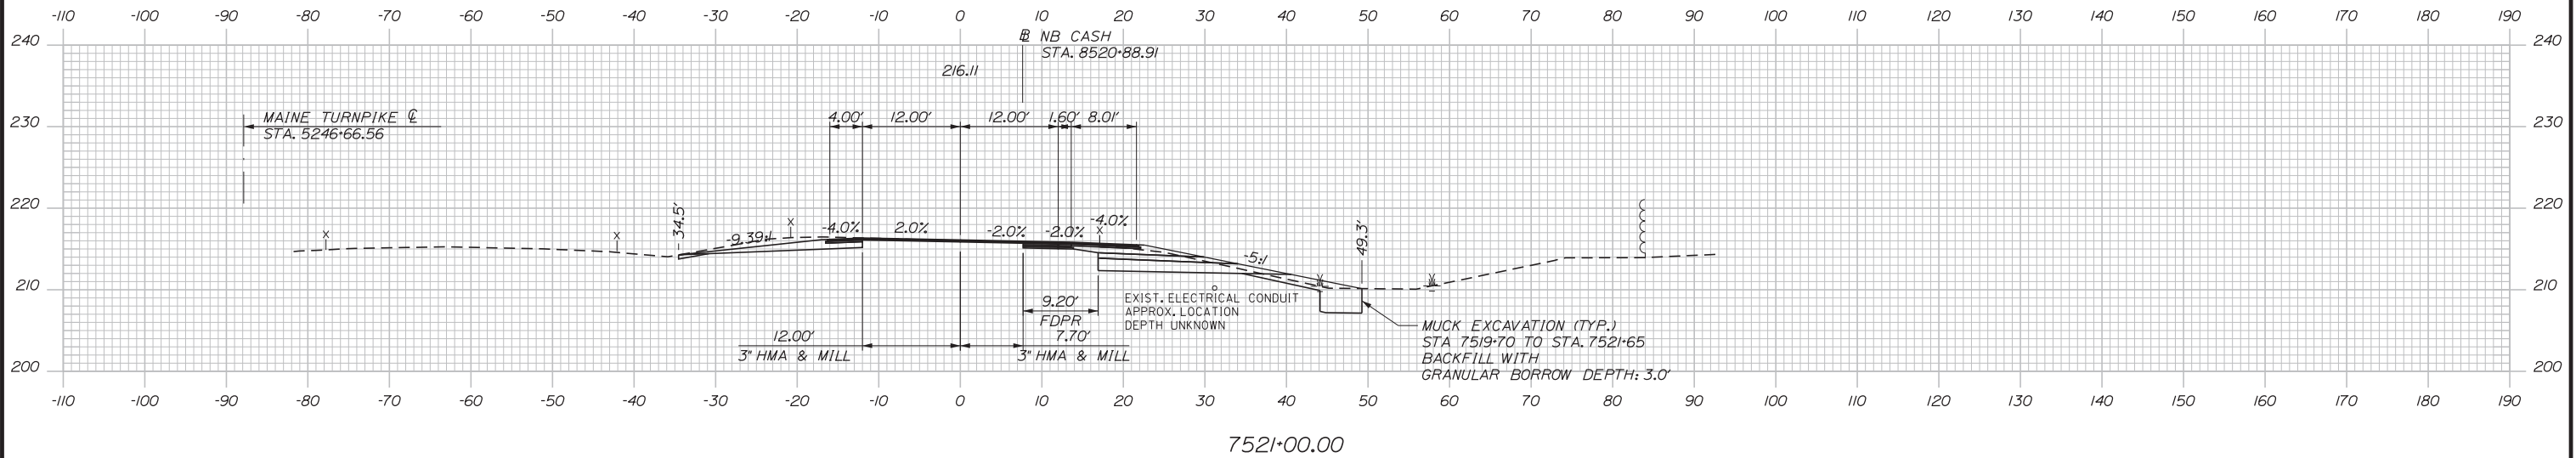

 C=131.91 CY  
 F=3.01 CY  
 G=6.71 CY  
 M=14.34 CY

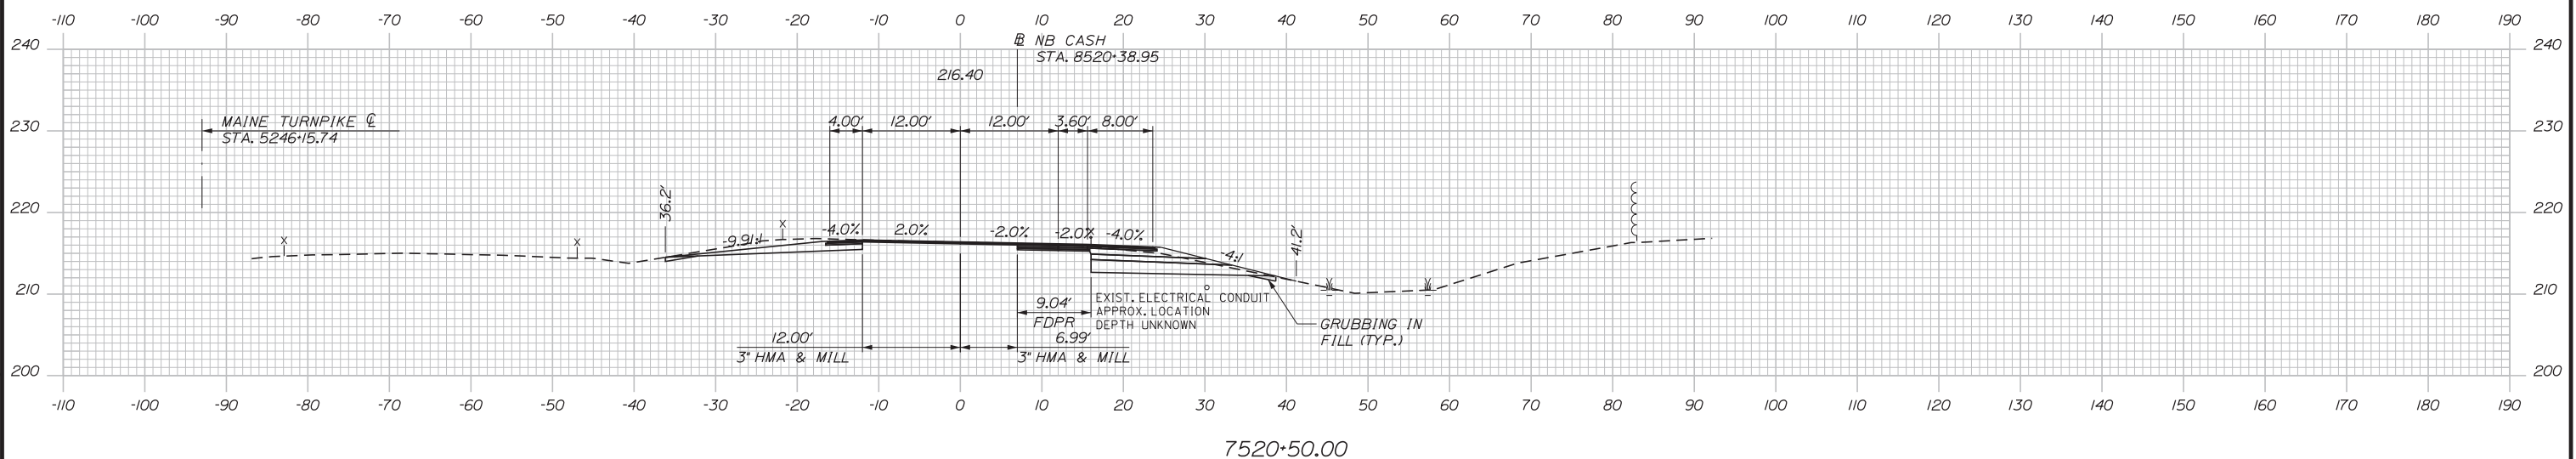

Designed by:

**Stantec**

CONSULTANT PROJECT MANAGER: LAUREN MEEK, PE

No.	Revision	By	Date

	By	Date		By	Date
Designed	PLP	3\20\19	Checked	LEM	3\20\19
Drawn	EJB	3\20\19	In Charge of	GAE	3\20\19

STANTEC CONSULTING SERVICES INC.  
 482 PAYNE ROAD  
 SCARBOROUGH, ME 04074  
 TEL (207) 887-3448  
 FAX (207) 883-3376

**MAINE TURNPIKE**

**THE GOLD STAR MEMORIAL HIGHWAY**

MTA PROJECT MANAGER: RALPH NORWOOD, IV, PE, PTOE

INTERCHANGE 103  
 ORT CONVERSION  
 NB ORT  
 STA. 7520+50.00 TO STA. 7521+00.00


SHEET NUMBER: XS-71  
 305 OF 503

CONTRACT: 2019.04



Filename: ...000.HIGHWAY\MSTA\\_xsect.dgn

Date: 3/20/2019

C=25.30 CY  
G=0.90 CY

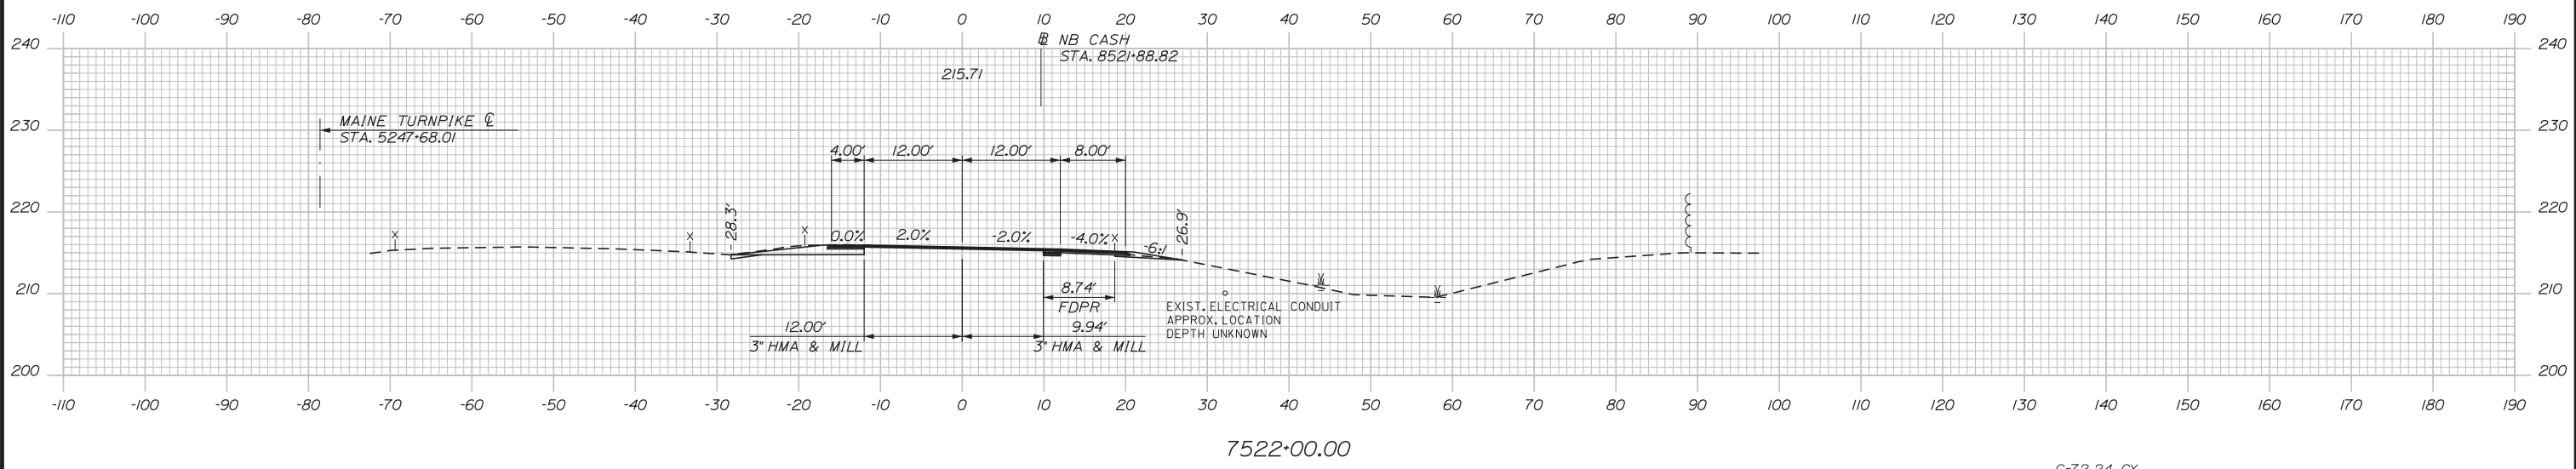

 C=72.24 CY  
F=8.00 CY  
G=6.23 CY  
M=23.91 CY

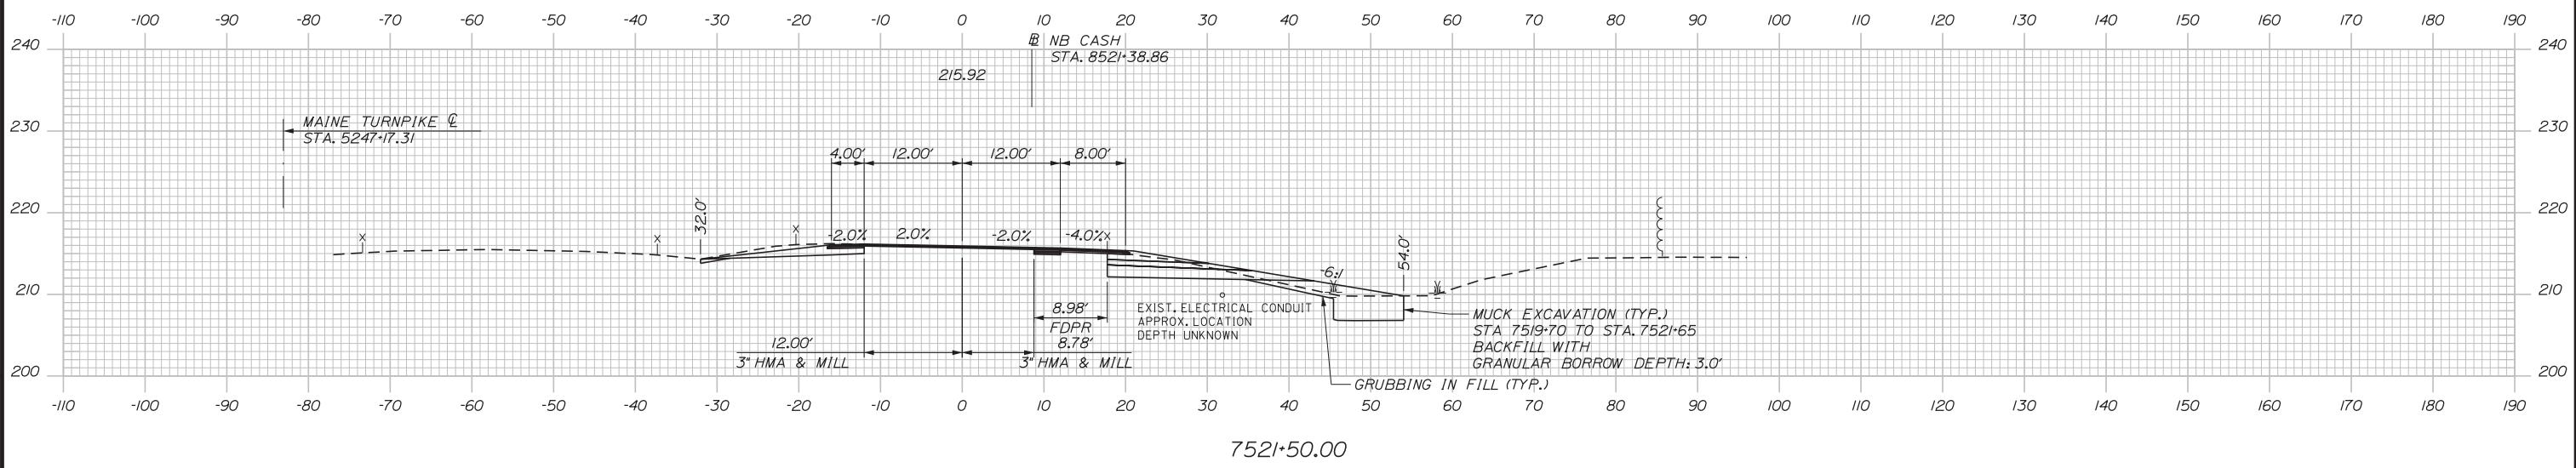

Designed by:

**Stantec**

CONSULTANT PROJECT MANAGER: LAUREN MEEK, PE

No.	Revision	By	Date

	By	Date		By	Date
Designed	PLP	3\20\19	Checked	LEM	3\20\19
Drawn	EJB	3\20\19	In Charge of	GAE	3\20\19

STANTEC CONSULTING SERVICES INC.  
482 PAYNE ROAD  
SCARBOROUGH, ME 04074  
TEL (207) 887-3448  
FAX (207) 883-3376

**MAINE TURNPIKE**

**THE GOLD STAR MEMORIAL HIGHWAY**




MTA PROJECT MANAGER: RALPH NORWOOD, IV, PE, PTOE

INTERCHANGE 103  
ORT CONVERSION  
NB ORT  
STA. 7521+50.00 TO STA. 7522+00.00

SHEET NUMBER: XS-72  
CONTRACT: 2019.04  
306 OF 503

Filename: ...000.HIGHWAY\MSTA\\_xsect.dgn

 Date: 3/20/2019

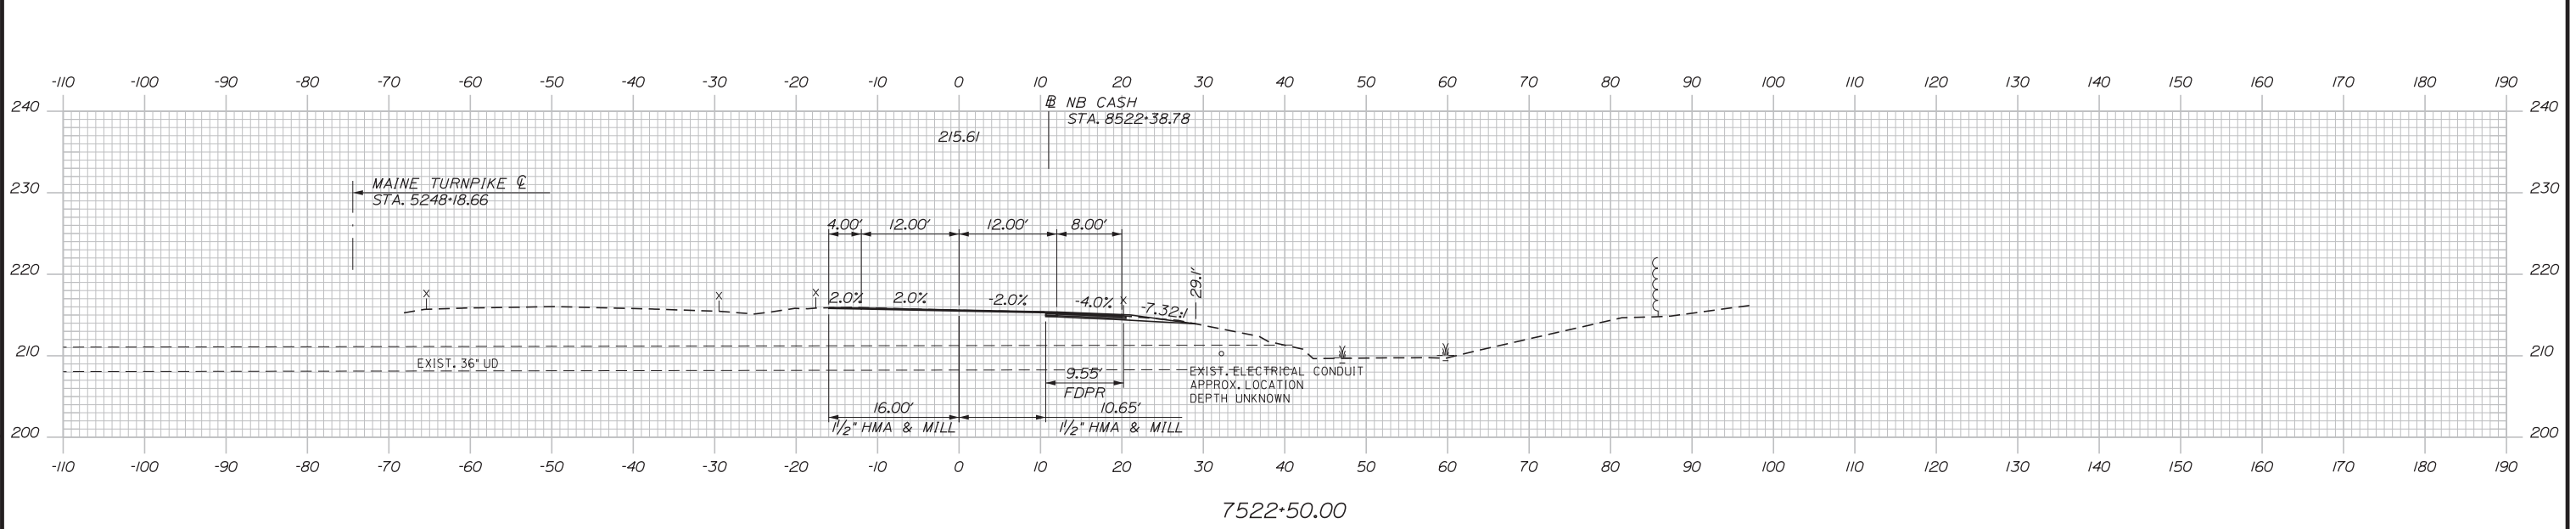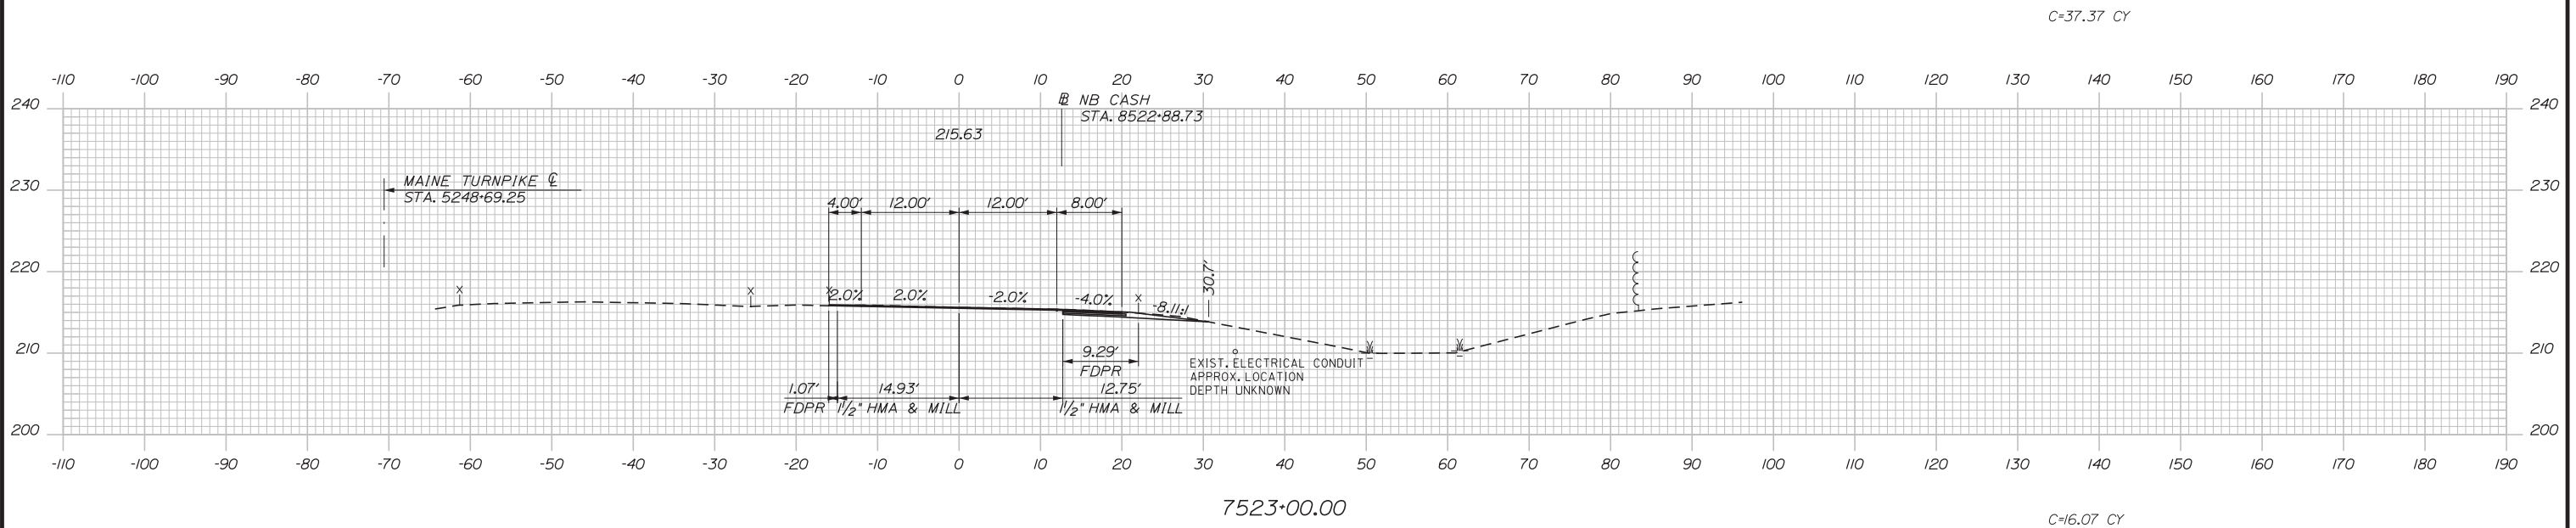

Designed by:

**Stantec**

CONSULTANT PROJECT MANAGER: LAUREN MEEK, PE

No.	Revision	By	Date

	By	Date		By	Date
Designed	PLP	3\20\19	Checked	LEM	3\20\19
Drawn	EJB	3\20\19	In Charge of	GAE	3\20\19

STANTEC CONSULTING SERVICES INC.  
482 PAYNE ROAD  
SCARBOROUGH, ME 04074  
TEL (207) 887-3448  
FAX (207) 883-3376

**MAINE TURNPIKE**

**THE GOLD STAR MEMORIAL HIGHWAY**




MTA PROJECT MANAGER: RALPH NORWOOD, IV, PE, PTOE

INTERCHANGE 103  
ORT CONVERSION  
NB ORT  
STA. 7522+50.00 TO STA. 7523+00.00

SHEET NUMBER: XS-73  
CONTRACT: 2019.04  
307 OF 503

Filename: ...00.HIGHWAY\MSTA\\_xsect.dgn

 Date: 3/20/2019

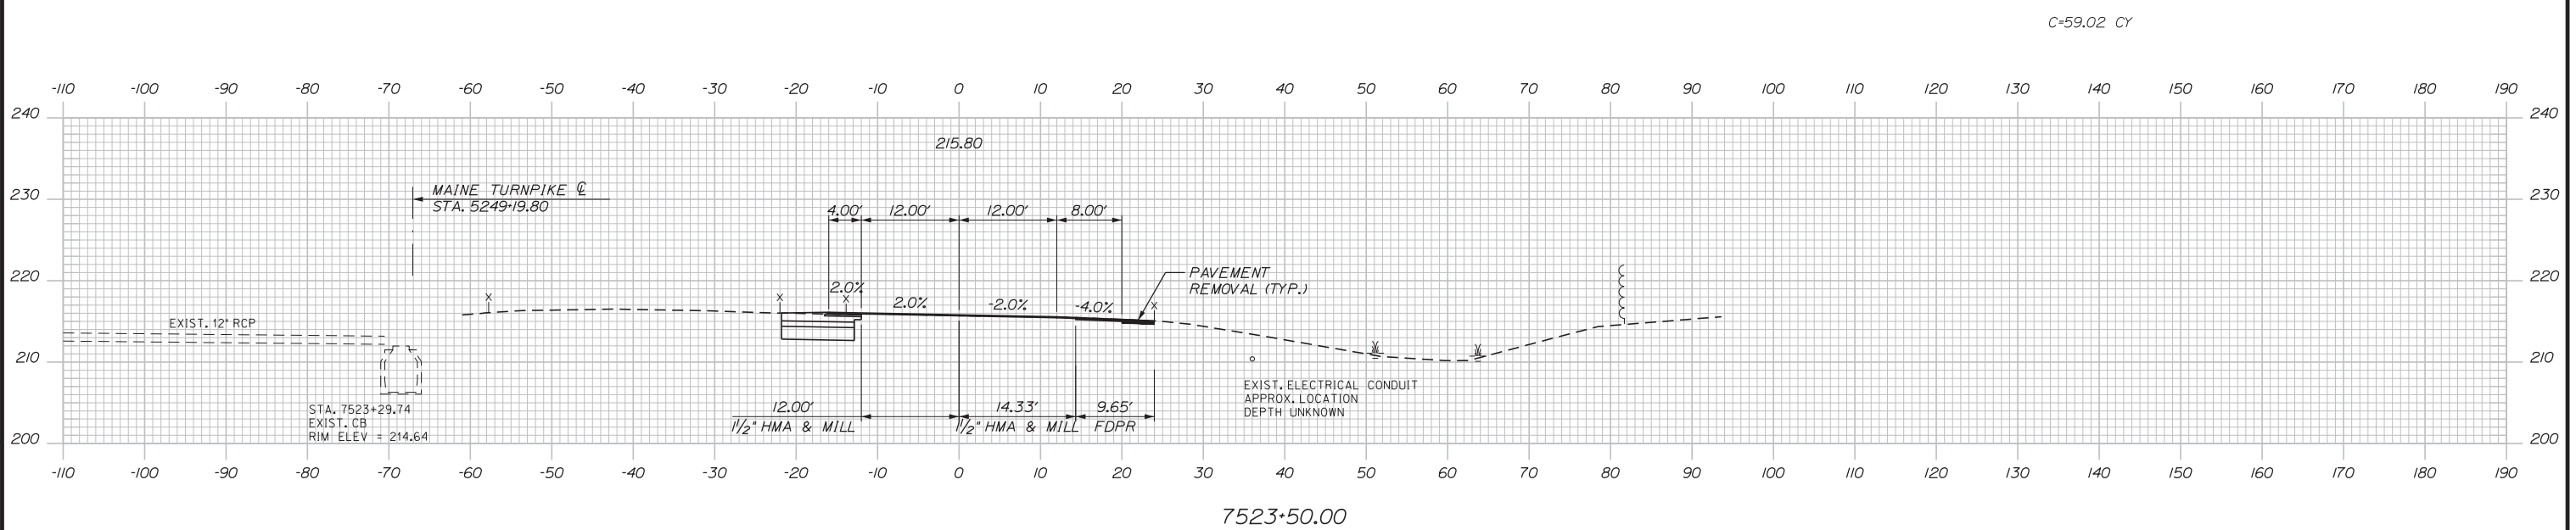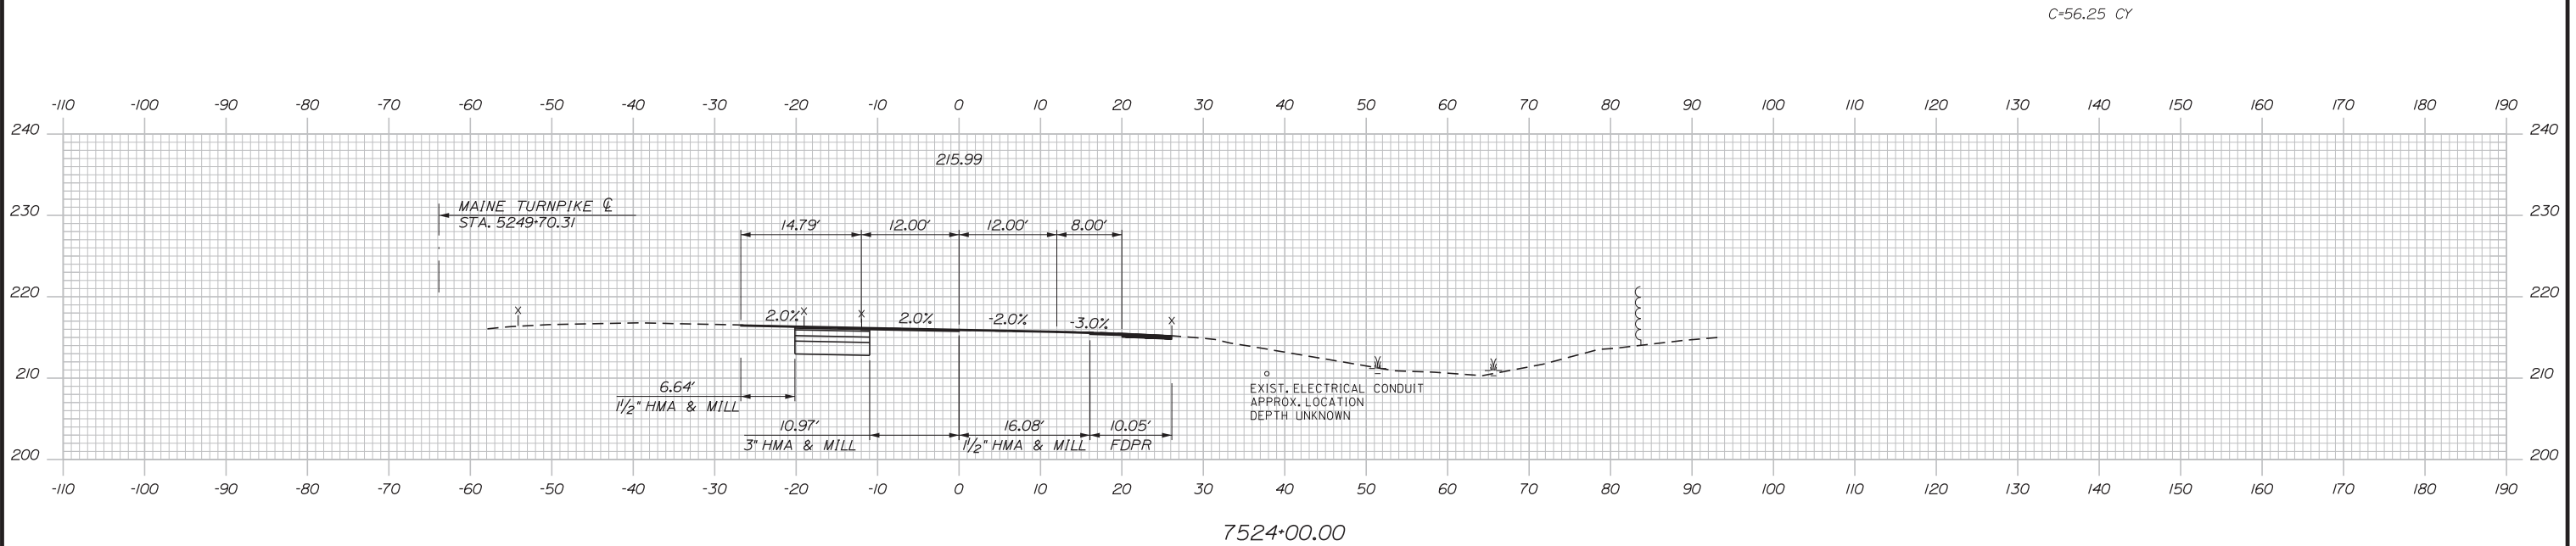

No.	Revision	By	Date


Designed by:

**Stantec**

CONSULTANT PROJECT MANAGER: LAUREN MEEK, PE

	By	Date		By	Date
Designed	PLP	3\20\19	Checked	LEM	3\20\19
Drawn	EJB	3\20\19	In Charge of	GAE	3\20\19

STANTEC CONSULTING SERVICES INC.  
482 PAYNE ROAD  
SCARBOROUGH, ME 04074  
TEL (207) 887-3448  
FAX (207) 883-3376

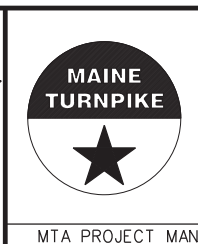

**THE GOLD STAR  
MEMORIAL HIGHWAY**




MTA PROJECT MANAGER: RALPH NORWOOD, IV, PE, PTOE

INTERCHANGE 103  
ORT CONVERSION  
NB ORT  
STA. 7523+50.00 TO STA. 7524+00.00

SHEET NUMBER: XS-74  
CONTRACT: 2019.04  
308 OF 503

Filename: ...00.HIGHWAY\MSTA\\_xsect.dgn

 Date: 3/20/2019

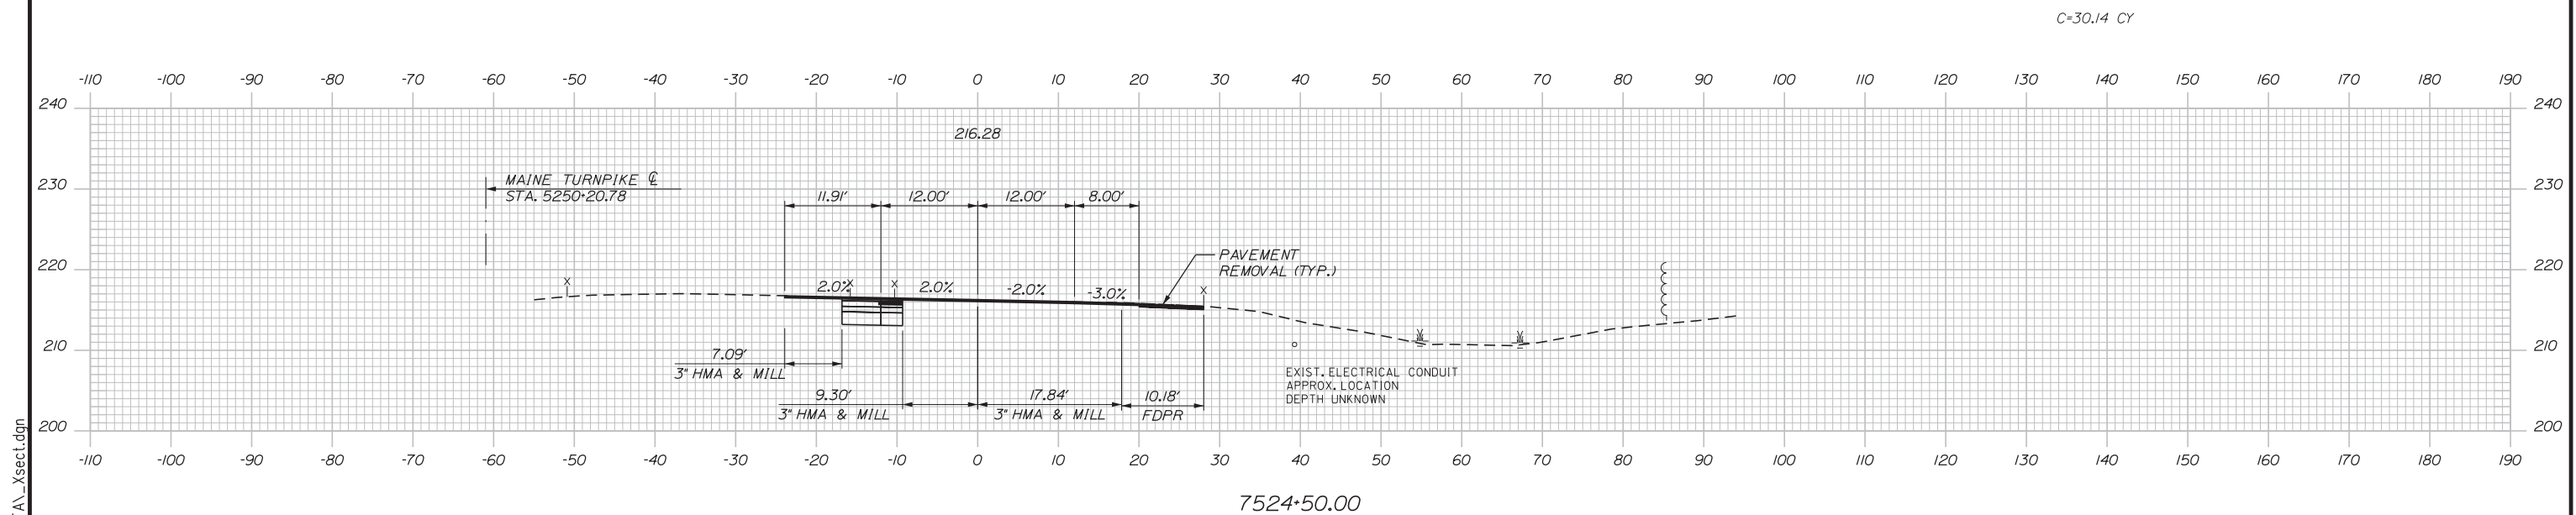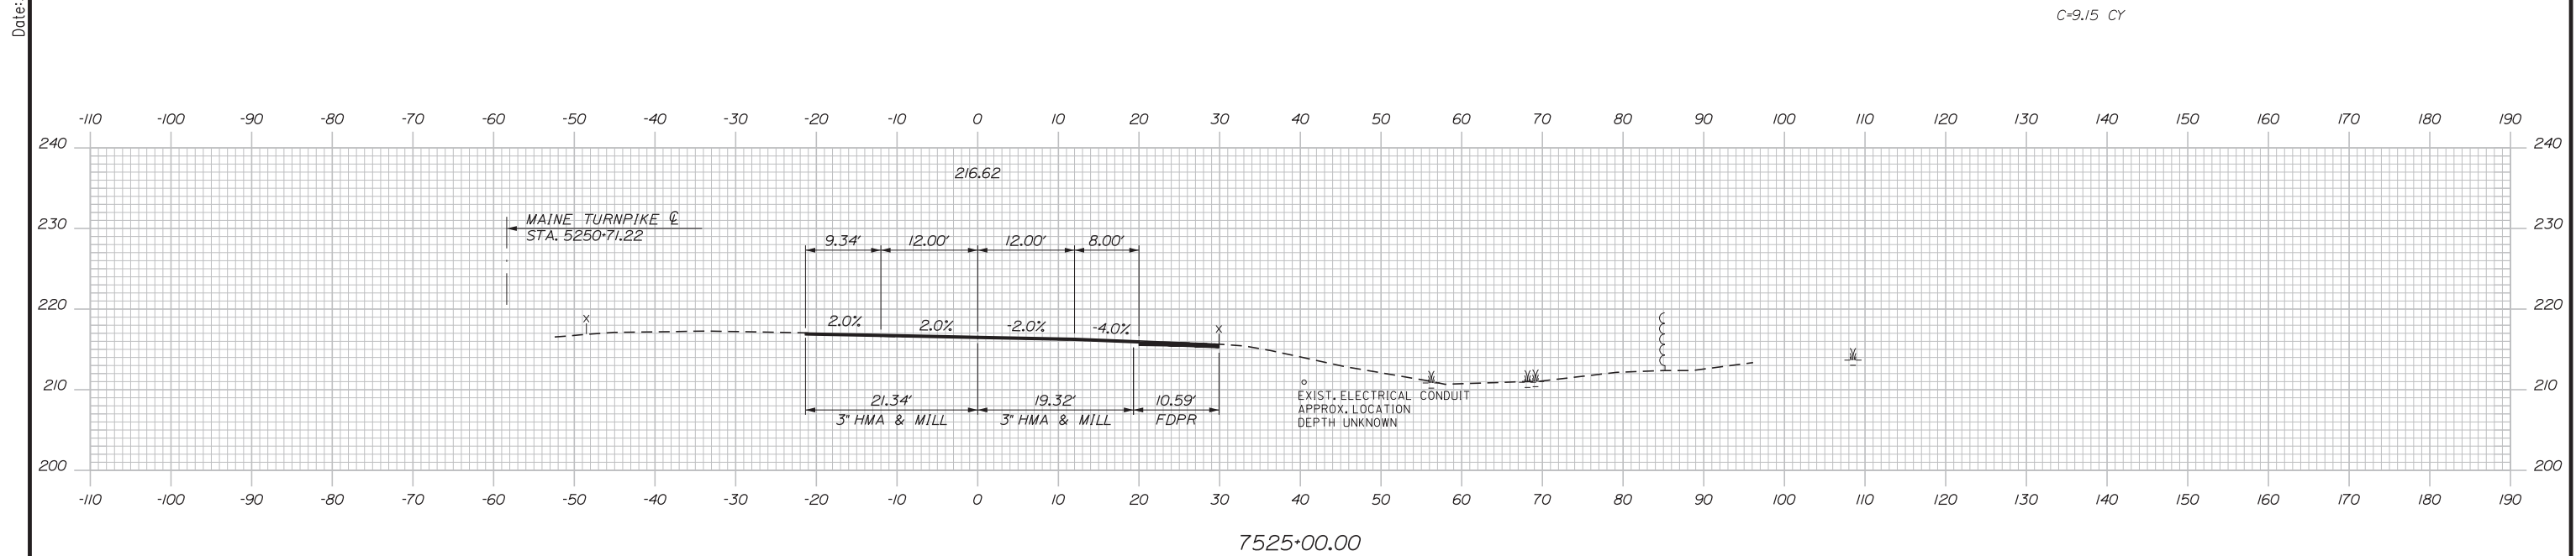

Designed by:

**Stantec**

CONSULTANT PROJECT MANAGER: LAUREN MEEK, PE

No.	Revision	By	Date

	By	Date		By	Date
Designed	PLP	3\20\19	Checked	LEM	3\20\19
Drawn	EJB	3\20\19	In Charge of	GAE	3\20\19

STANTEC CONSULTING SERVICES INC.  
 482 PAYNE ROAD  
 SCARBOROUGH, ME 04074  
 TEL (207) 887-3448  
 FAX (207) 883-3376

**MAINE TURNPIKE**

**THE GOLD STAR MEMORIAL HIGHWAY**

MTA PROJECT MANAGER: RALPH NORWOOD, IV, PE, PTOE

INTERCHANGE 103  
 ORT CONVERSION  
 NB ORT  
 STA. 7524+50.00 TO STA. 7525+00.00


SHEET NUMBER: XS-75  
 309 OF 503

CONTRACT: 2019.04





Date: 3/20/2019

C=12.71 CY

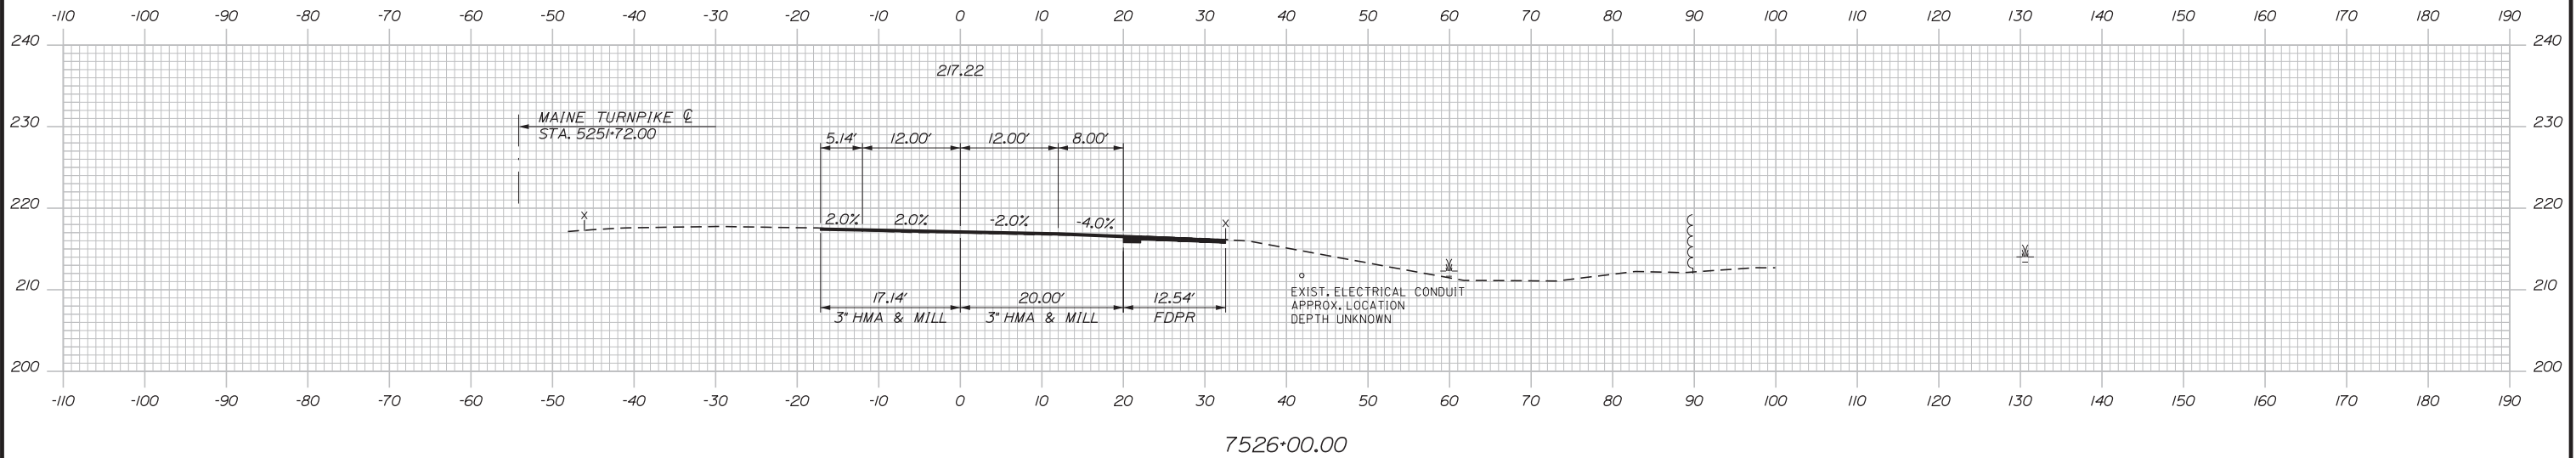

C=10.87 CY

 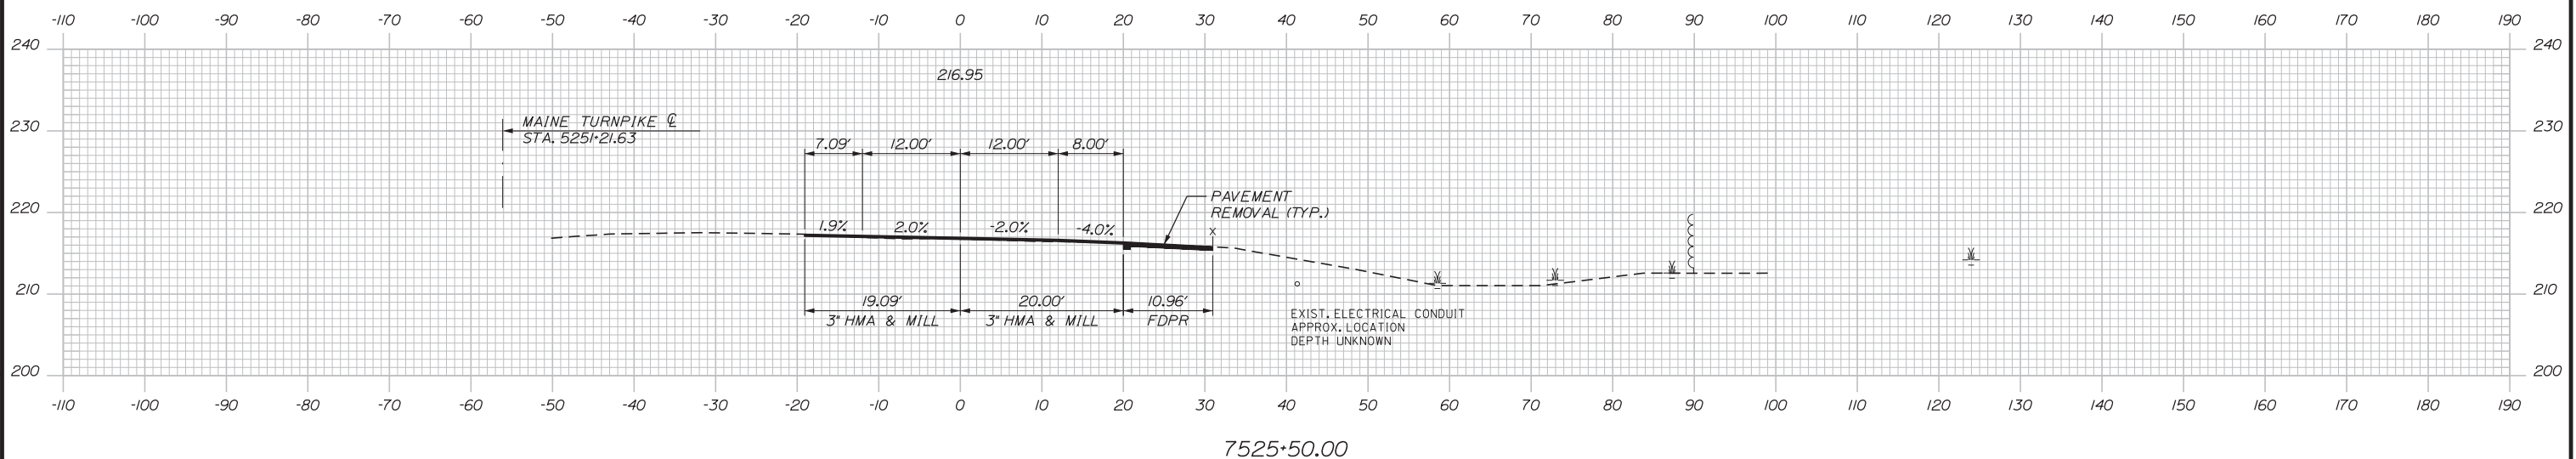

Designed by:

**Stantec**

CONSULTANT PROJECT MANAGER: LAUREN MEEK, PE

No.	Revision	By	Date

	By	Date		By	Date
Designed	PLP	3\20\19	Checked	LEM	3\20\19
Drawn	EJB	3\20\19	In Charge of	GAE	3\20\19

STANTEC CONSULTING SERVICES INC.  
 482 PAYNE ROAD  
 SCARBOROUGH, ME 04074  
 TEL (207) 887-3448  
 FAX (207) 883-3376

**MAINE TURNPIKE**

**THE GOLD STAR MEMORIAL HIGHWAY**

MTA PROJECT MANAGER: RALPH NORWOOD, IV, PE, PTOE

INTERCHANGE 103  
 ORT CONVERSION  
 NB ORT  
 STA. 7525+50.00 TO STA. 7526+00.00

SHEET NUMBER: XS-76


CONTRACT: 2019.04

310 OF 503



Filename: ... \00\HIGHWAY\MSTA\\_xsect.dgn

Date: 3/20/2019

C=14.50 CY

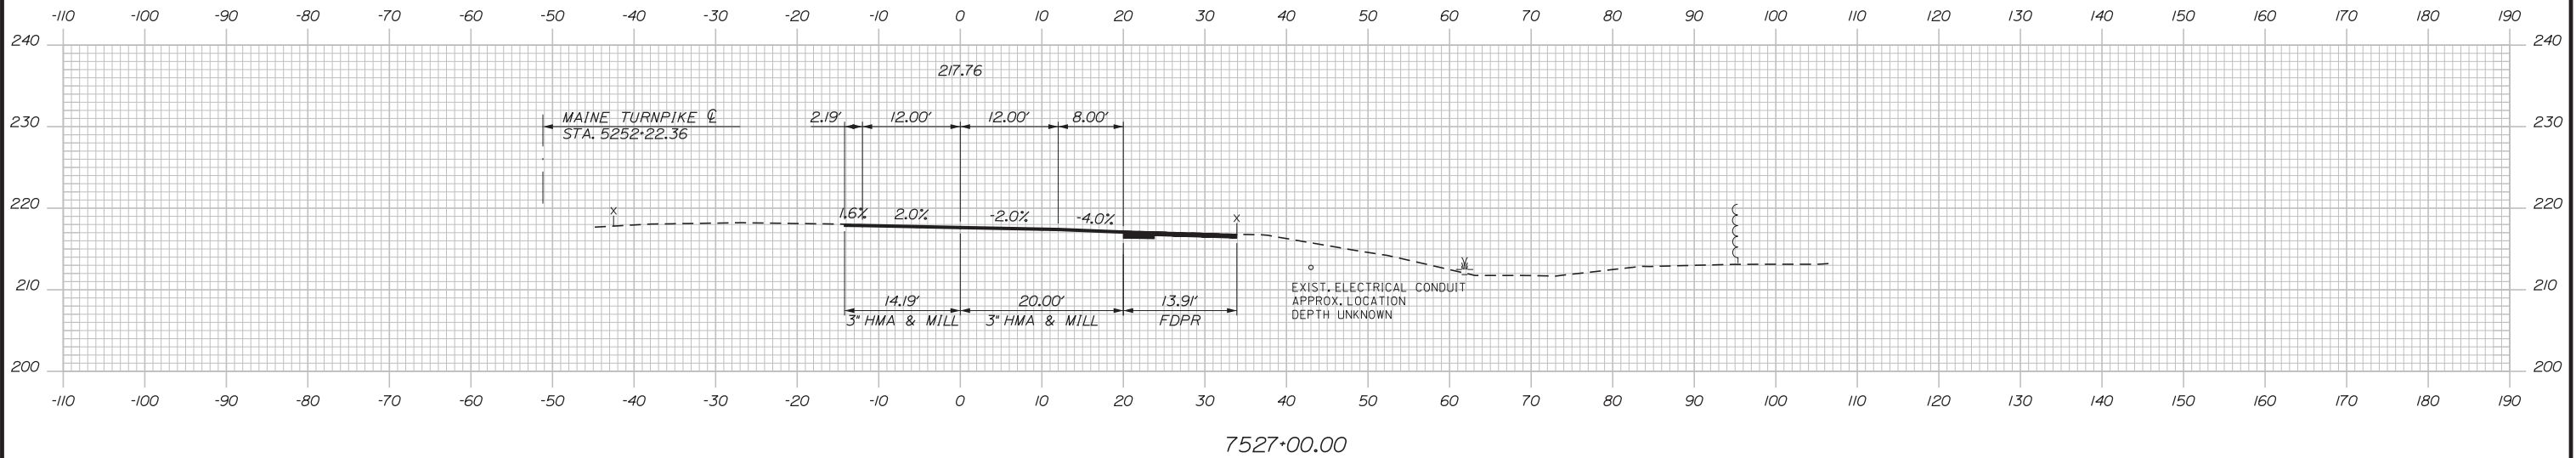

C=14.01 CY

 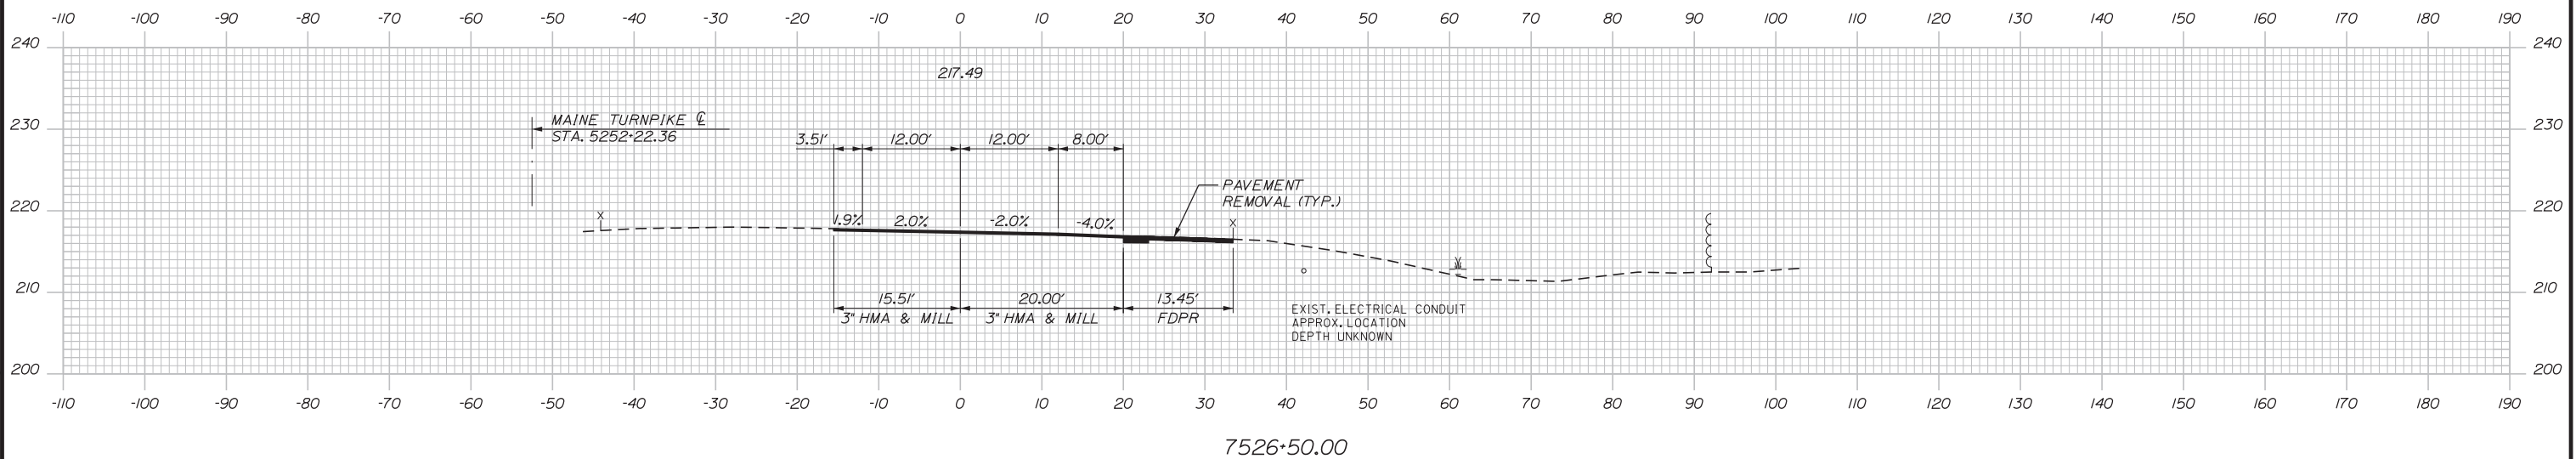

Designed by:



STANTEC CONSULTING SERVICES INC.  
482 PAYNE ROAD  
SCARBOROUGH, ME 04074  
TEL (207) 887-3448  
FAX (207) 883-3376



THE GOLD STAR  
MEMORIAL HIGHWAY

INTERCHANGE 103  
ORT CONVERSION  
NB ORT  
STA. 7526+50.00 TO STA. 7527+00.00

No.	Revision	By	Date

CONSULTANT PROJECT MANAGER: LAUREN MEEK, PE			
Designed	By	Date	Checked
	PLP	3\20\19	LEM
Drawn	By	Date	In Charge of
	EJB	3\20\19	GAE

MTA PROJECT MANAGER: RALPH NORWOOD, IV, PE, PTOE


CONTRACT: 2019.04

SHEET NUMBER: XS-77


311 OF 503

Filename: ... \00\HIGHWAY\MSTA\\_xsect.dgn


Date: 3/20/2019

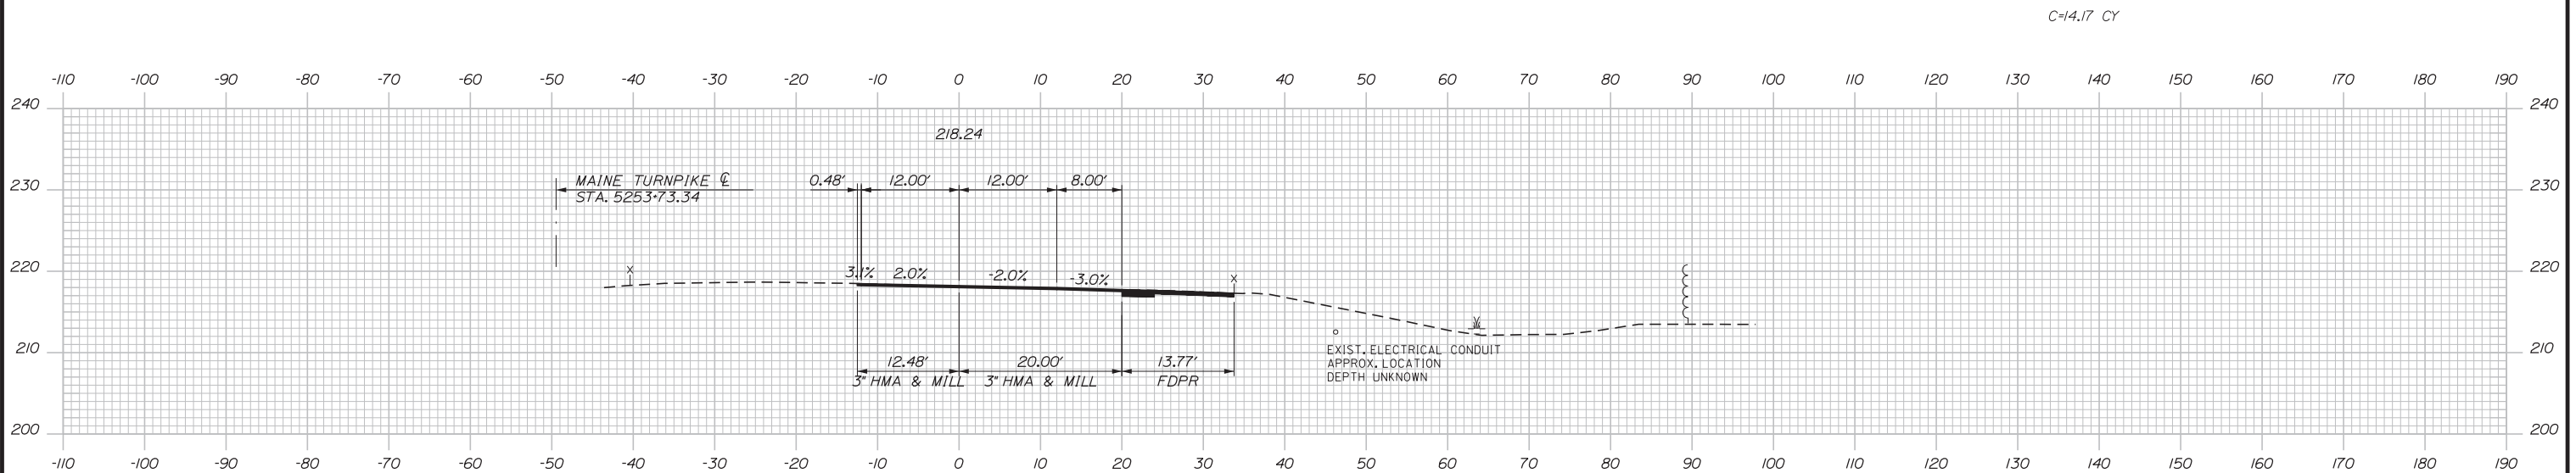

7528+00.00

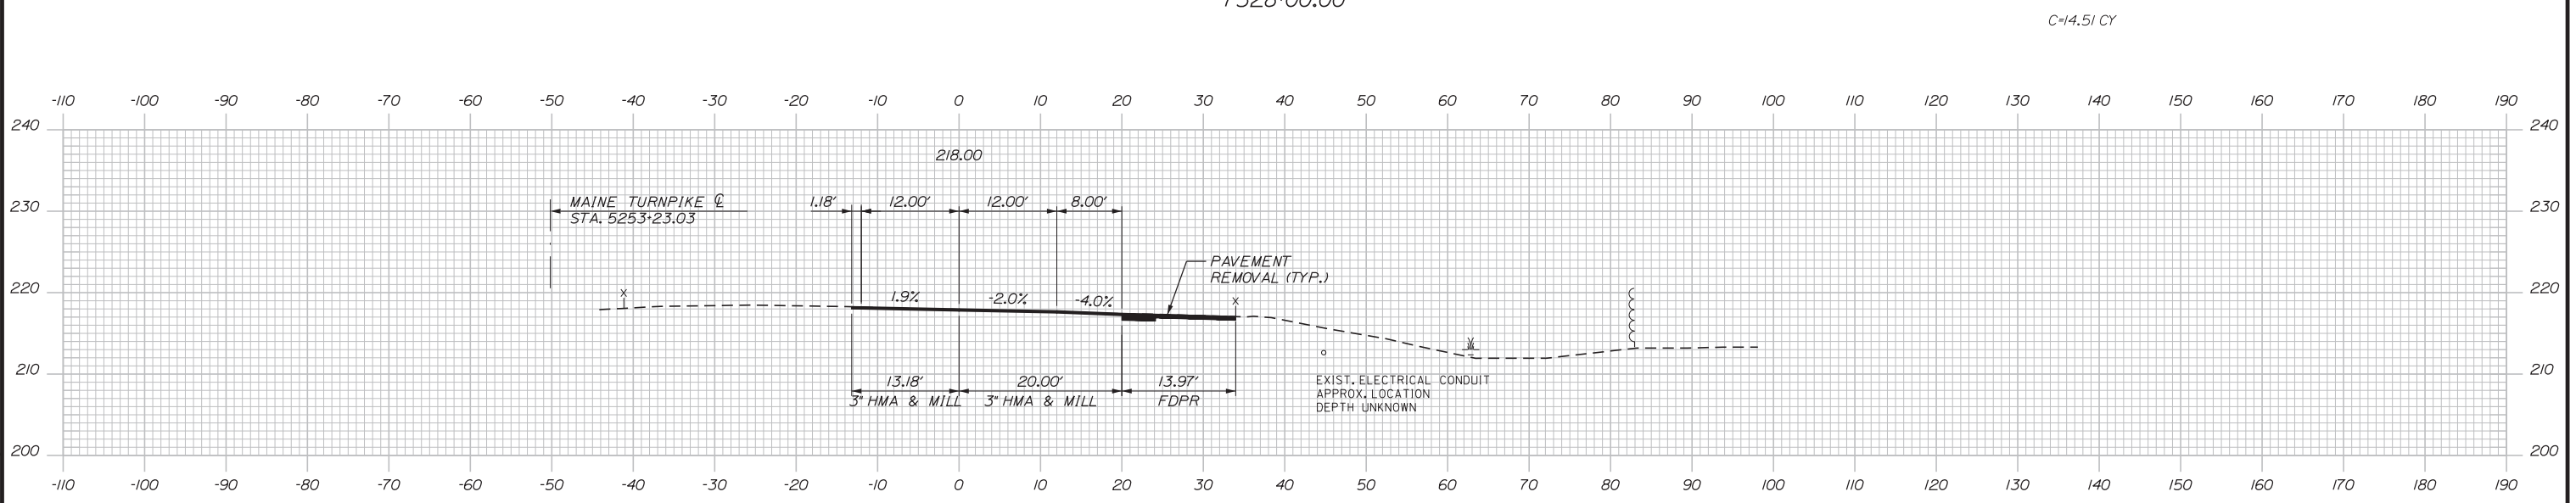

7527+50.00

 

Designed by:


**Stantec**

CONSULTANT PROJECT MANAGER: LAUREN MEEK, PE

No.	Revision	By	Date

	By	Date		By	Date
Designed	PLP	3\20\19	Checked	LEM	3\20\19
Drawn	EJB	3\20\19	In Charge of	GAE	3\20\19

STANTEC CONSULTING SERVICES INC.  
482 PAYNE ROAD  
SCARBOROUGH, ME 04074  
TEL (207) 887-3448  
FAX (207) 883-3376

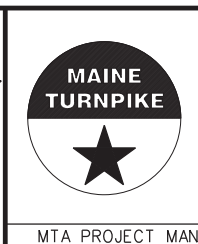

**THE GOLD STAR  
MEMORIAL HIGHWAY**

MTA PROJECT MANAGER: RALPH NORWOOD, IV, PE, PTOE

INTERCHANGE 103  
ORT CONVERSION  
NB ORT  
STA. 7527+50.00 TO STA. 7528+00.00

SHEET NUMBER: XS-78

 

CONTRACT: 2019.04

312 OF 503

Filename: ...00.HIGHWAY\MSTA\\_xsect.dgn

Date: 3/20/2019

Filename: ... \00\HIGHWAY\MTA\\_xsect.dgn

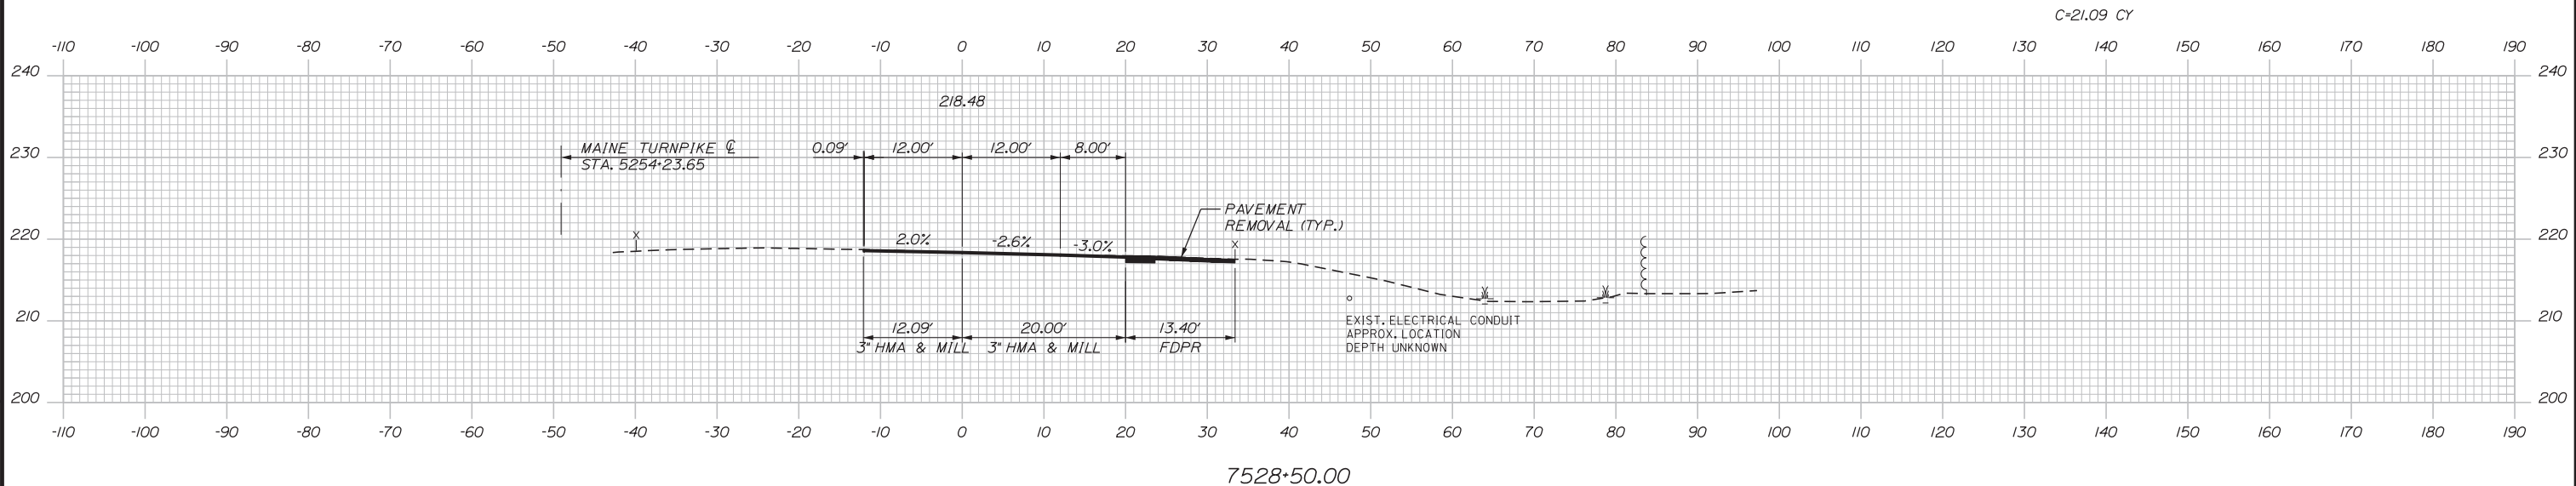

Designed by:

**Stantec**

CONSULTANT PROJECT MANAGER: LAUREN MEEK, PE

No.	Revision	By	Date

	By	Date		By	Date
Designed	PLP	3\20\19	Checked	LEM	3\20\19
Drawn	EJB	3\20\19	In Charge of	GAE	3\20\19

STANTEC CONSULTING SERVICES INC.  
482 PAYNE ROAD  
SCARBOROUGH, ME 04074  
TEL (207) 887-3448  
FAX (207) 883-3376

**THE GOLD STAR MEMORIAL HIGHWAY**

MTA PROJECT MANAGER: RALPH NORWOOD, IV, PE, PTOE




INTERCHANGE 103  
ORT CONVERSION  
NB ORT  
STA. 7528+50.00 TO STA. 7528+50.00

SHEET NUMBER: XS-79

CONTRACT: 2019.04

313 OF 503

 Date: 3/20/2019

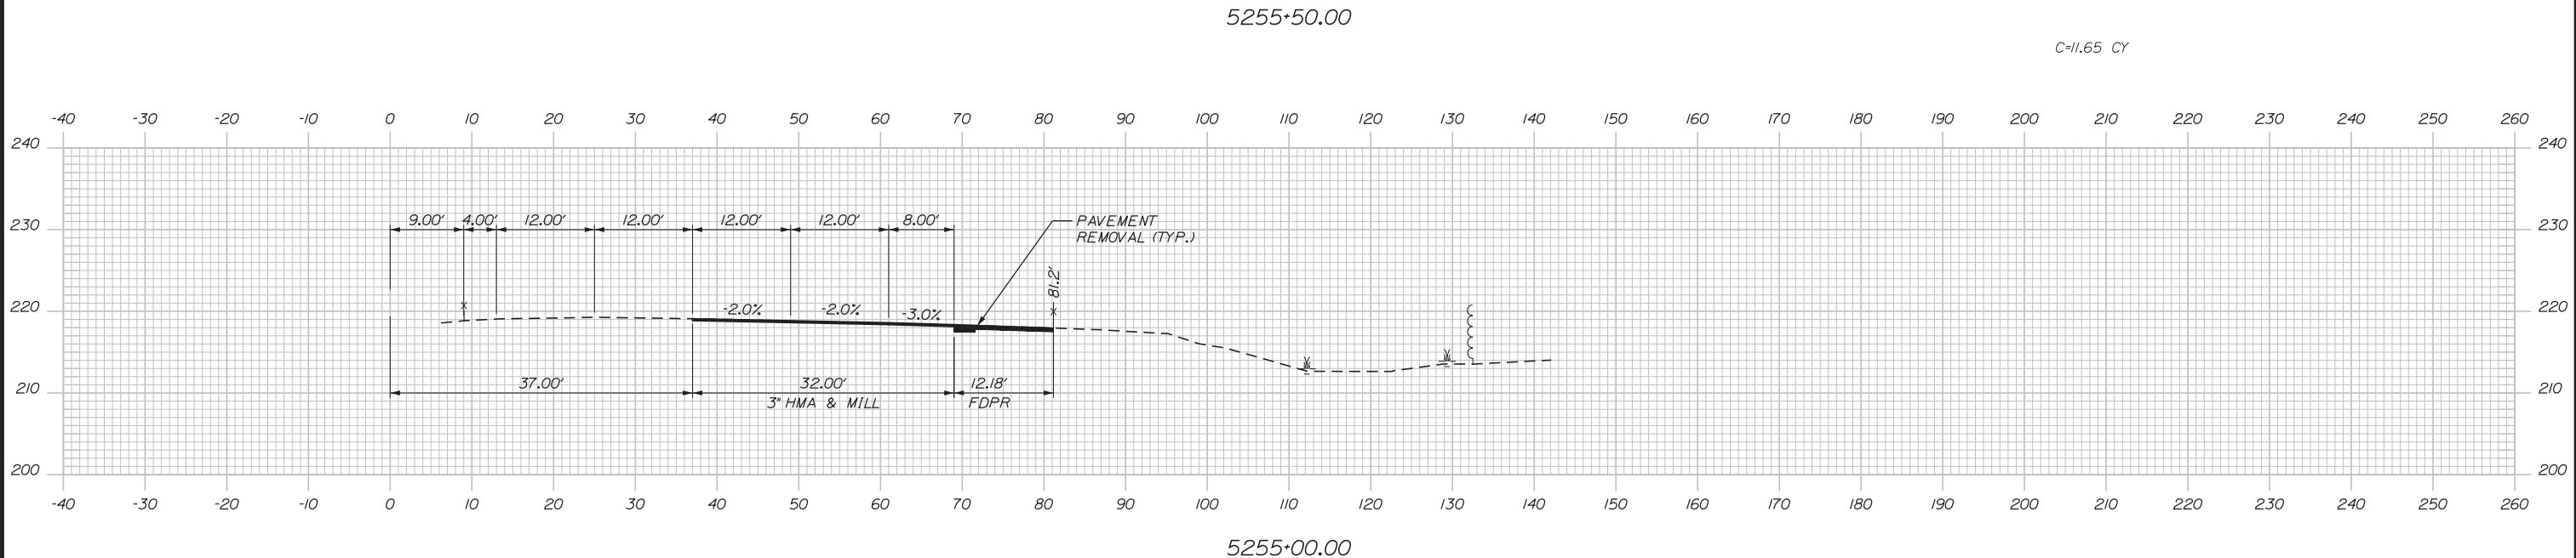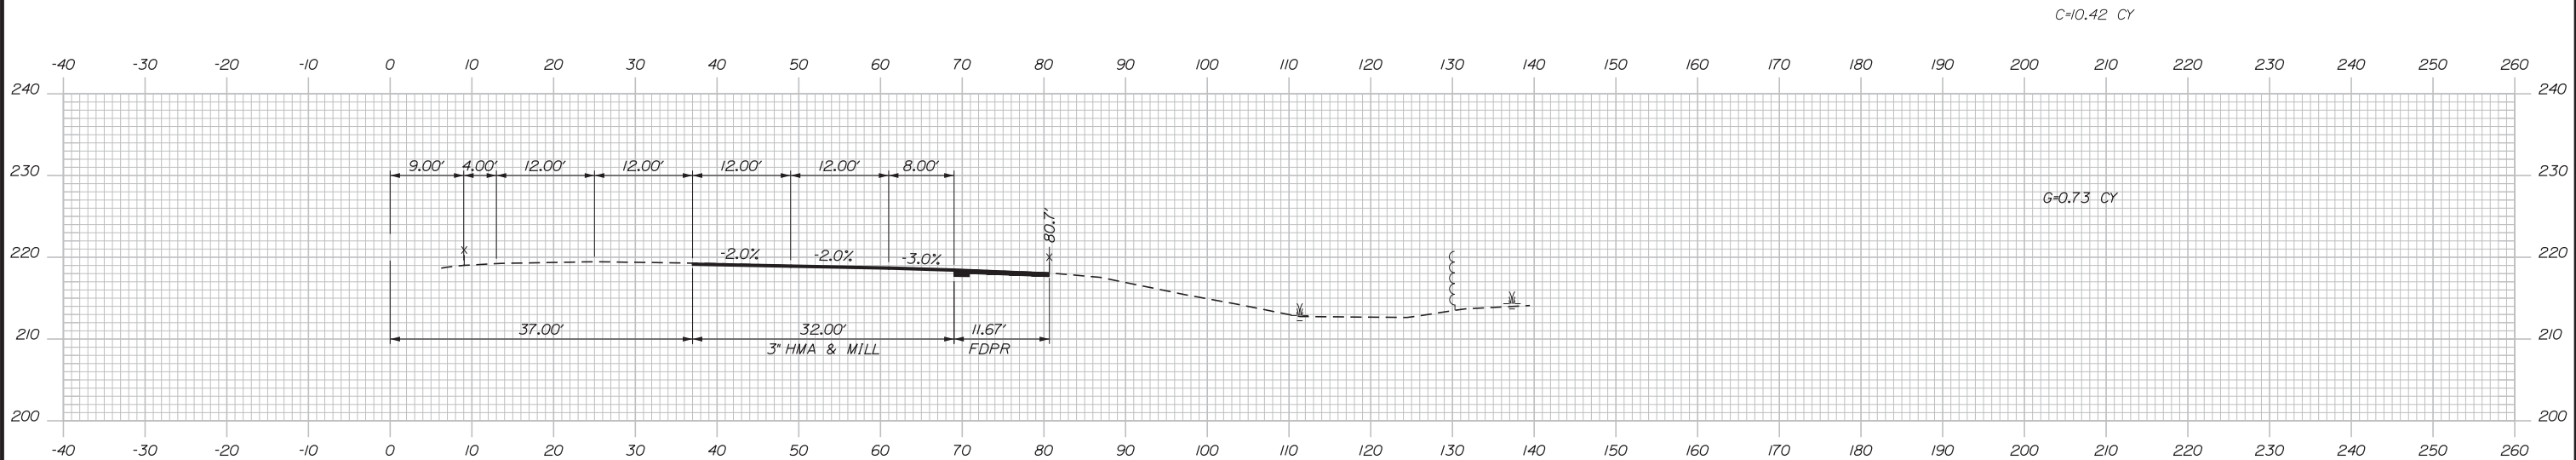

Designed by:

**Stantec**

CONSULTANT PROJECT MANAGER: LAUREN MEEK, PE

No.	Revision	By	Date

	By	Date		By	Date
Designed	PLP	3\20\19	Checked	LEM	3\20\19
Drawn	EJB	3\20\19	In Charge of	GAE	3\20\19

STANTEC CONSULTING SERVICES INC.  
482 PAYNE ROAD  
SCARBOROUGH, ME 04074  
TEL (207) 887-3448  
FAX (207) 883-3376

**MAINE TURNPIKE**

**THE GOLD STAR MEMORIAL HIGHWAY**

MTA PROJECT MANAGER: RALPH NORWOOD, IV, PE, PTOE

INTERCHANGE 103  
ORT CONVERSION  
NB ORT  
STA. 5255+00.00 TO STA. 5255+50.00

SHEET NUMBER: XS-80

 


CONTRACT: 2019.04

314 OF 503

Filename: ...\\00.HIGHWAY\MSTA\\_xsect.dgn



Date: 3/20/2019

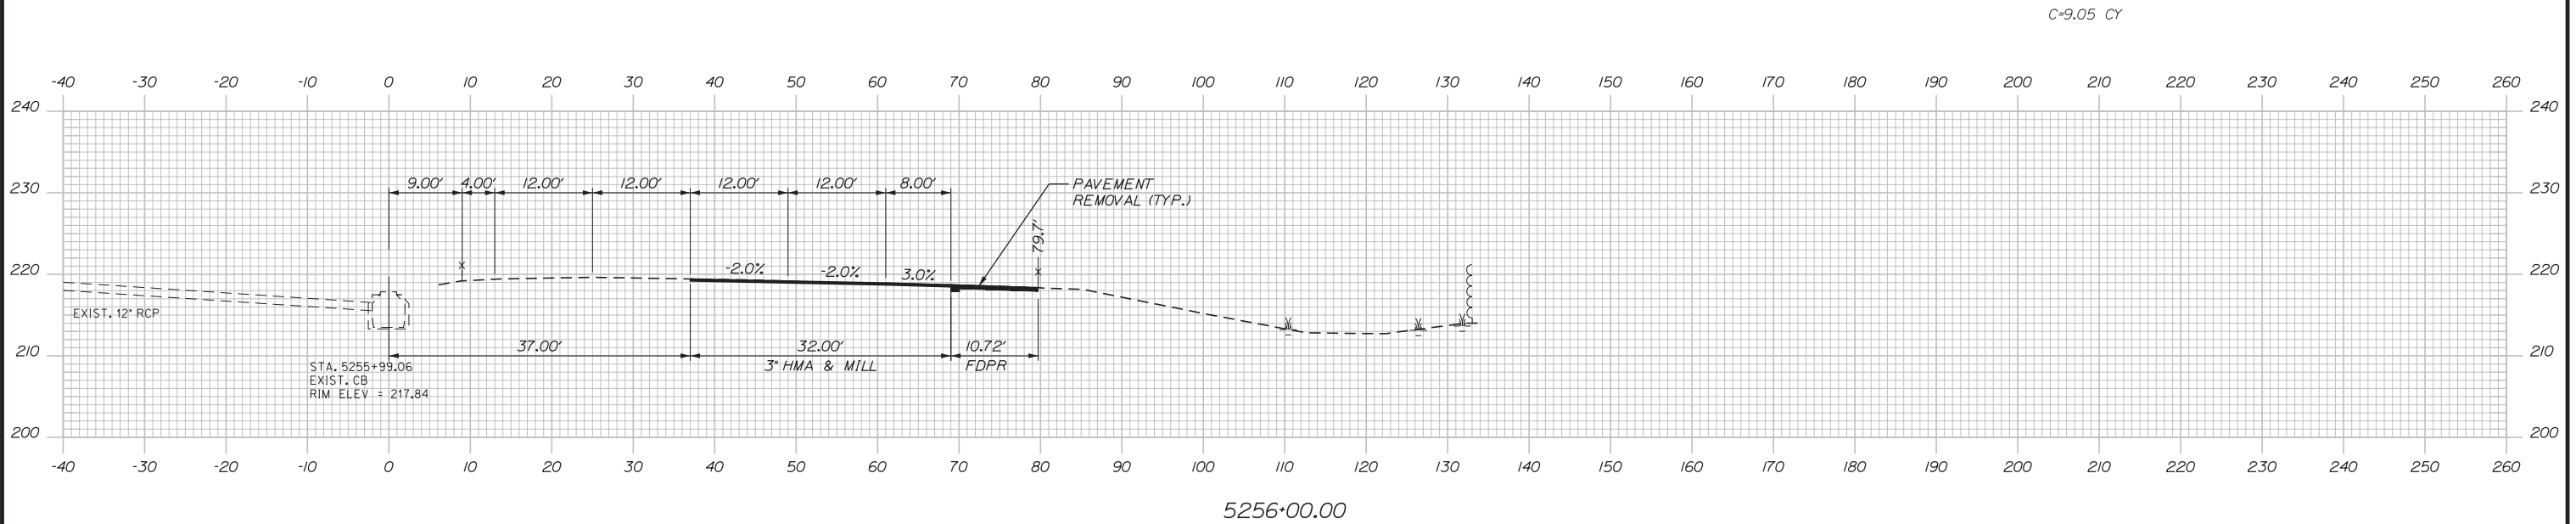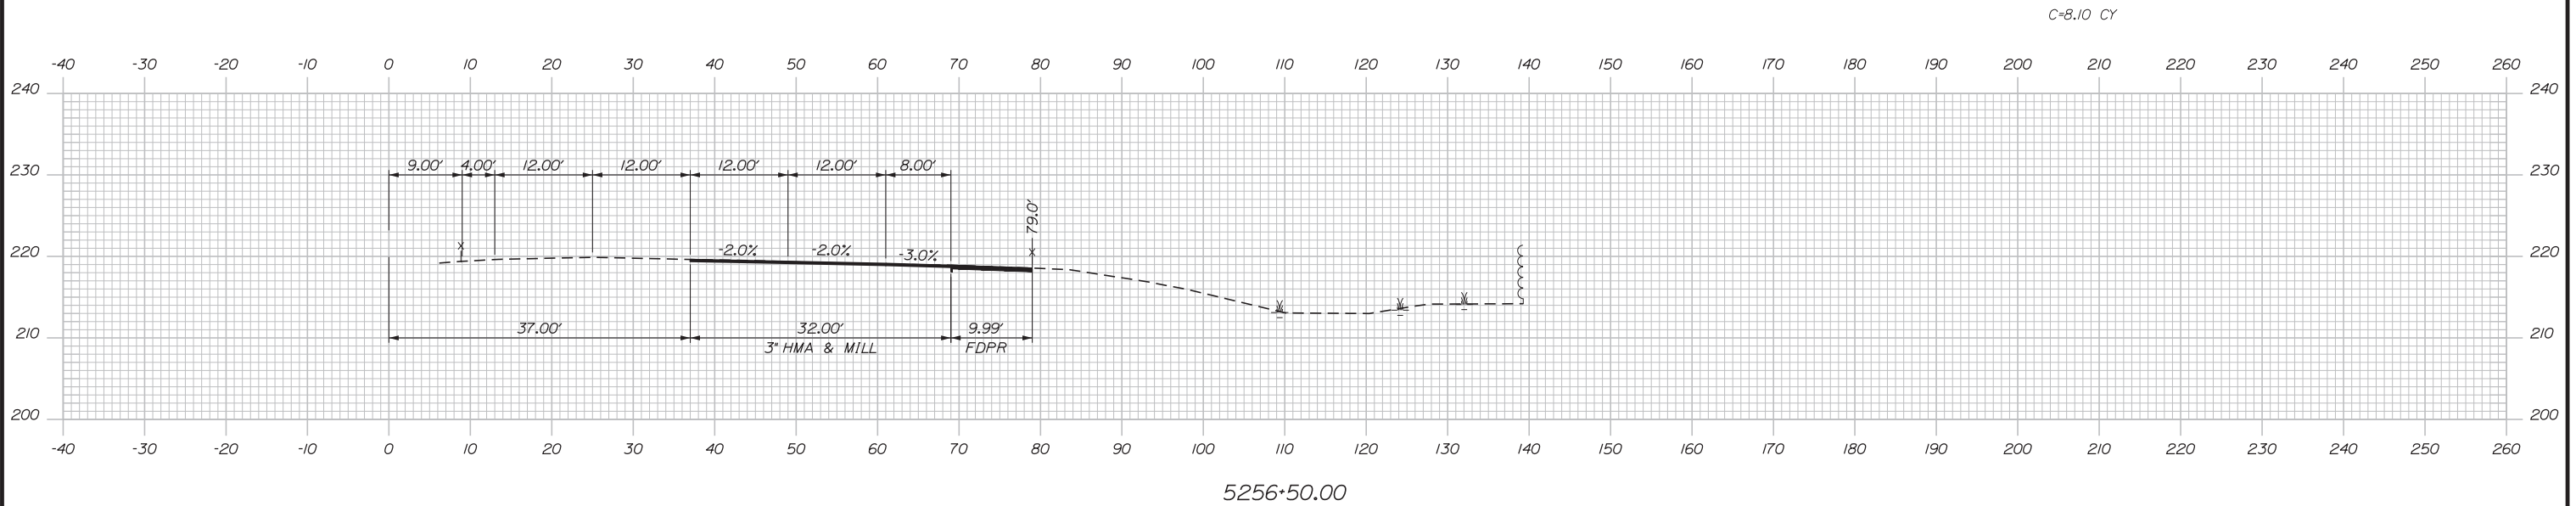

Designed by:

**Stantec**

CONSULTANT PROJECT MANAGER: LAUREN MEEK, PE

No.	Revision	By	Date

	By	Date		By	Date
Designed	PLP	3\20\19	Checked	LEM	3\20\19
Drawn	EJB	3\20\19	In Charge of	GAE	3\20\19

STANTEC CONSULTING SERVICES INC.  
 482 PAYNE ROAD  
 SCARBOROUGH, ME 04074  
 TEL (207) 887-3448  
 FAX (207) 883-3376

**MAINE TURNPIKE**

**THE GOLD STAR MEMORIAL HIGHWAY**

MTA PROJECT MANAGER: RALPH NORWOOD, IV, PE, PTOE

INTERCHANGE 103  
 ORT CONVERSION  
 NB ORT  
 STA. 5256+00.00 TO STA. 5256+50.00


SHEET NUMBER: XS-81

CONTRACT: 2019.04


315 OF 503

Filename: ...00.HIGHWAY\MSTA\\_xsect.dgn


Date: 3/20/2019

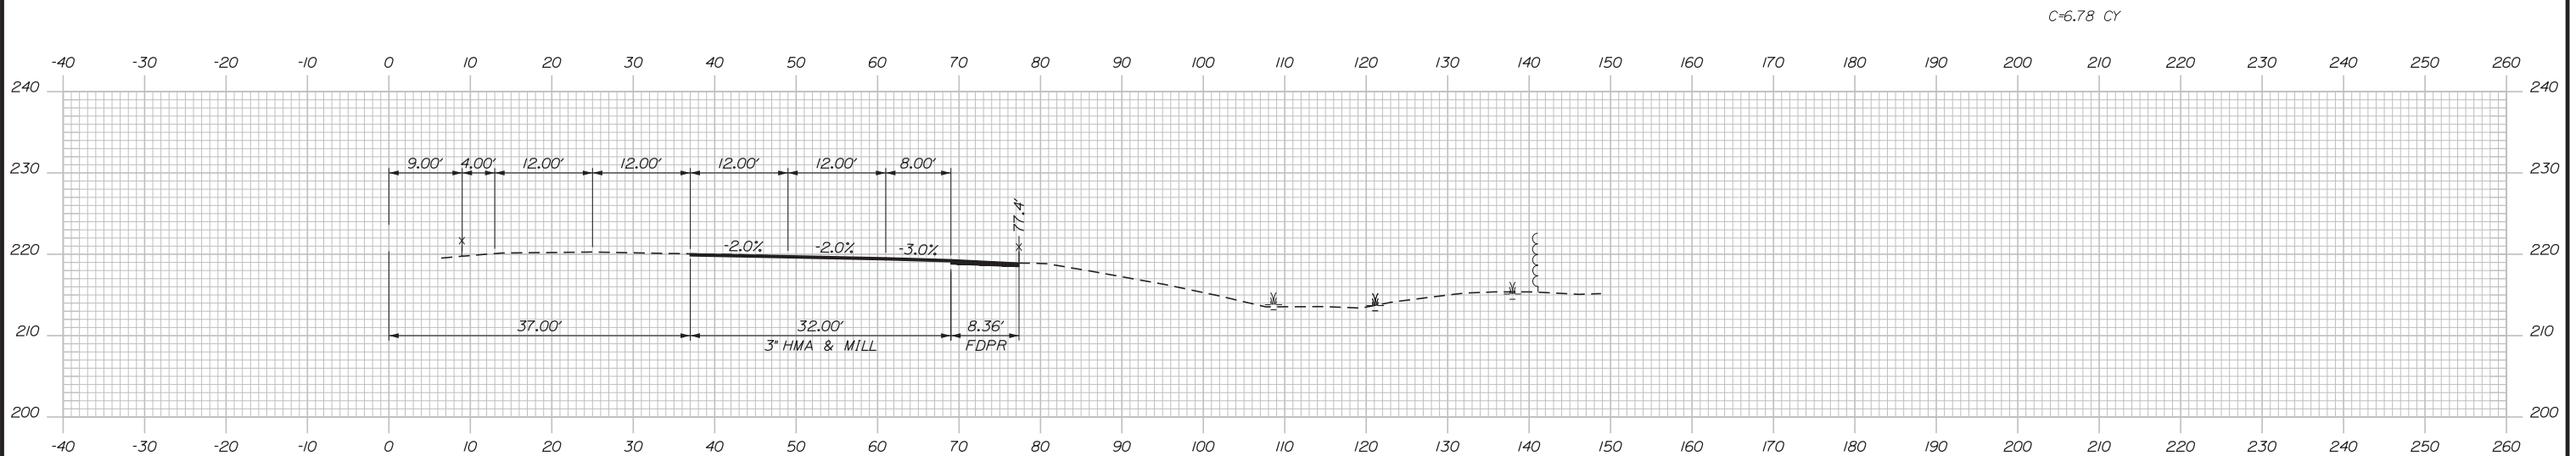

5257+50.00

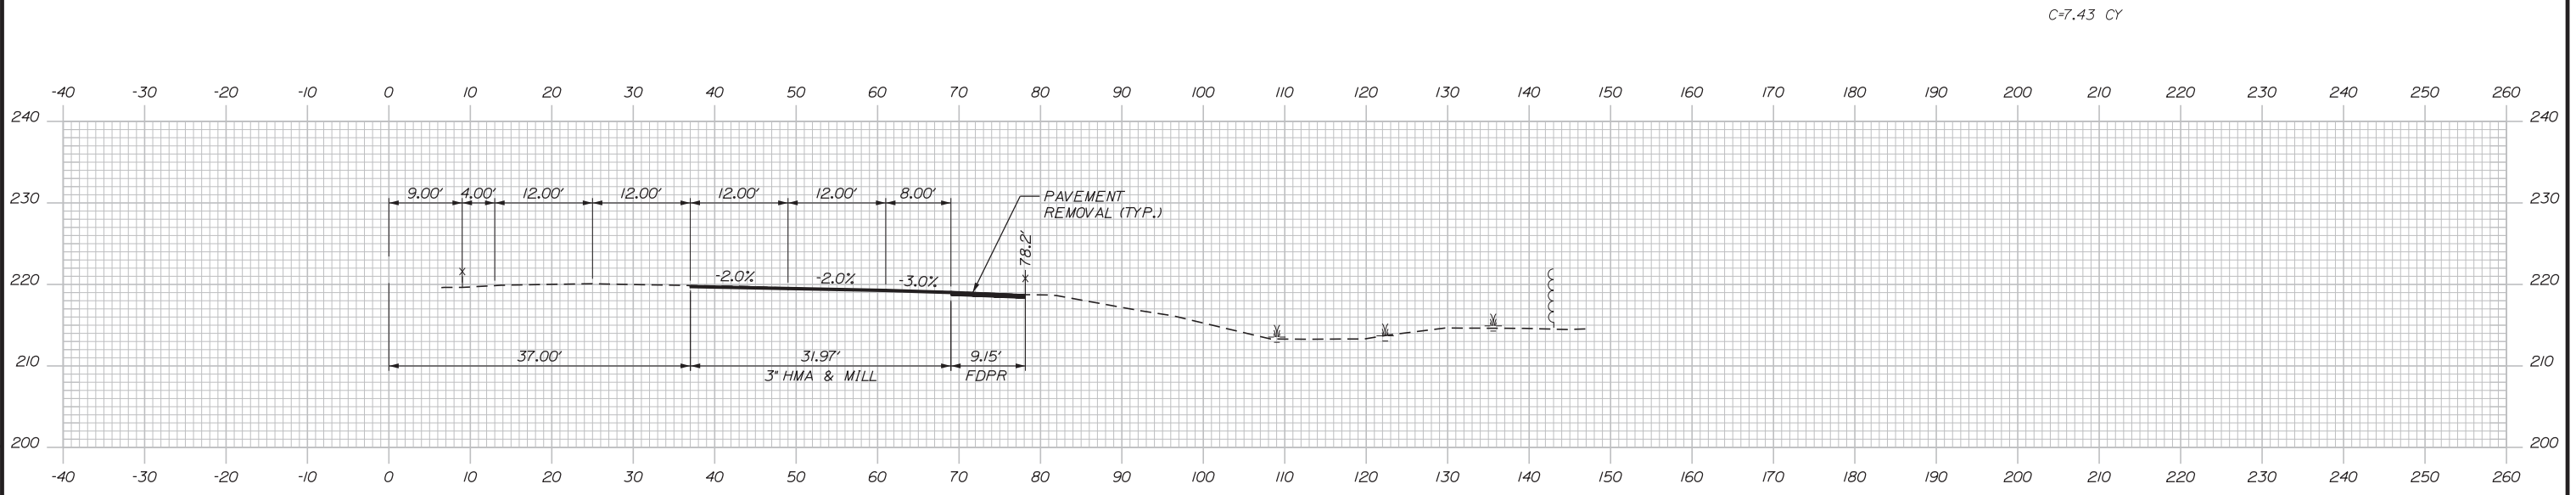

5257+00.00

 

Designed by:

**Stantec**

CONSULTANT PROJECT MANAGER: LAUREN MEEK, PE

No.	Revision	By	Date

	By	Date		By	Date
Designed	PLP	3\20\19	Checked	LEM	3\20\19
Drawn	EJB	3\20\19	In Charge of	GAE	3\20\19

STANTEC CONSULTING SERVICES INC.  
482 PAYNE ROAD  
SCARBOROUGH, ME 04074  
TEL (207) 887-3448  
FAX (207) 883-3376

**MAINE TURNPIKE**

**THE GOLD STAR MEMORIAL HIGHWAY**

MTA PROJECT MANAGER: RALPH NORWOOD, IV, PE, PTOE

INTERCHANGE 103  
ORT CONVERSION  
NB ORT  
STA. 5257+00.00 TO STA. 5257+50.00


SHEET NUMBER: XS-82

Filename: ...\\00\HIGHWAY\MSTA\\_xsect.dgn

Date: 3/20/2019


G=1.22 CY

C=5.24 CY

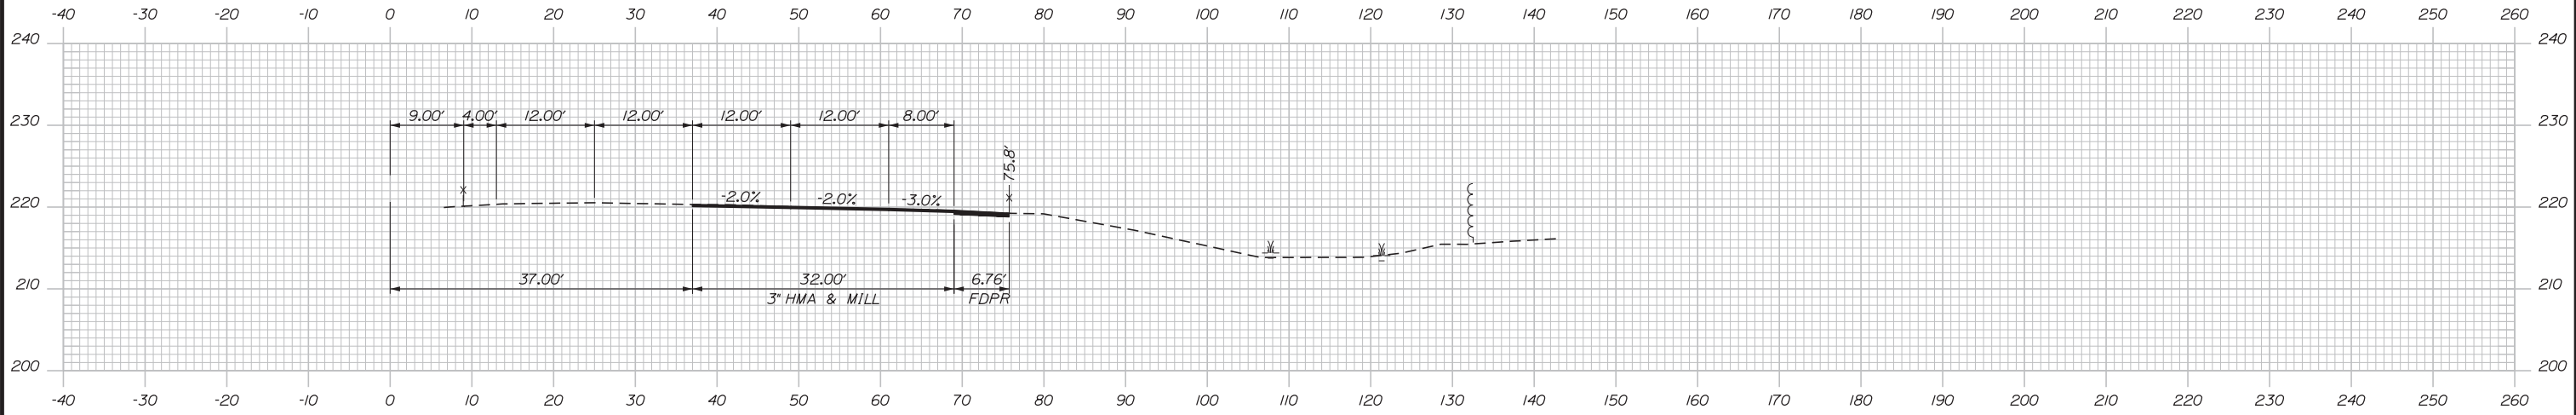


5258+50.00

C=6.10 CY

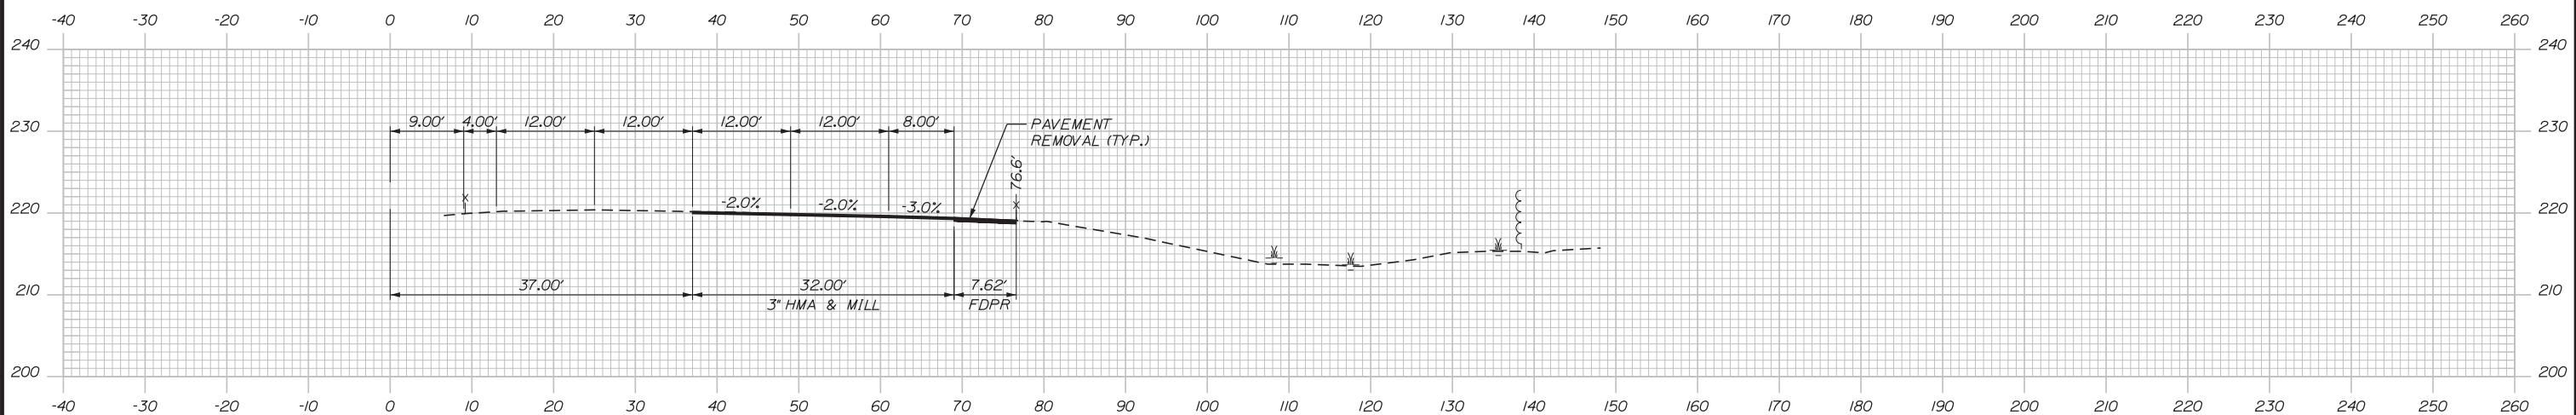

5258+00.00

 

Designed by:

**Stantec**

CONSULTANT PROJECT MANAGER: LAUREN MEEK, PE

No.	Revision	By	Date

	By	Date		By	Date
Designed	PLP	3\20\19	Checked	LEM	3\20\19
Drawn	EJB	3\20\19	In Charge of	GAE	3\20\19

STANTEC CONSULTING SERVICES INC.  
482 PAYNE ROAD  
SCARBOROUGH, ME 04074  
TEL (207) 887-3448  
FAX (207) 883-3376

**MAINE TURNPIKE**

**THE GOLD STAR MEMORIAL HIGHWAY**

MTA PROJECT MANAGER: RALPH NORWOOD, IV, PE, PTOE

INTERCHANGE 103  
ORT CONVERSION  
NB ORT  
STA. 5258+00.00 TO STA. 5258+50.00


SHEET NUMBER: XS-83

CONTRACT: 2019.04


317 OF 503

Filename: ...00\HIGHWAY\MSTA\\_xsect.dgn


Date: 3/20/2019

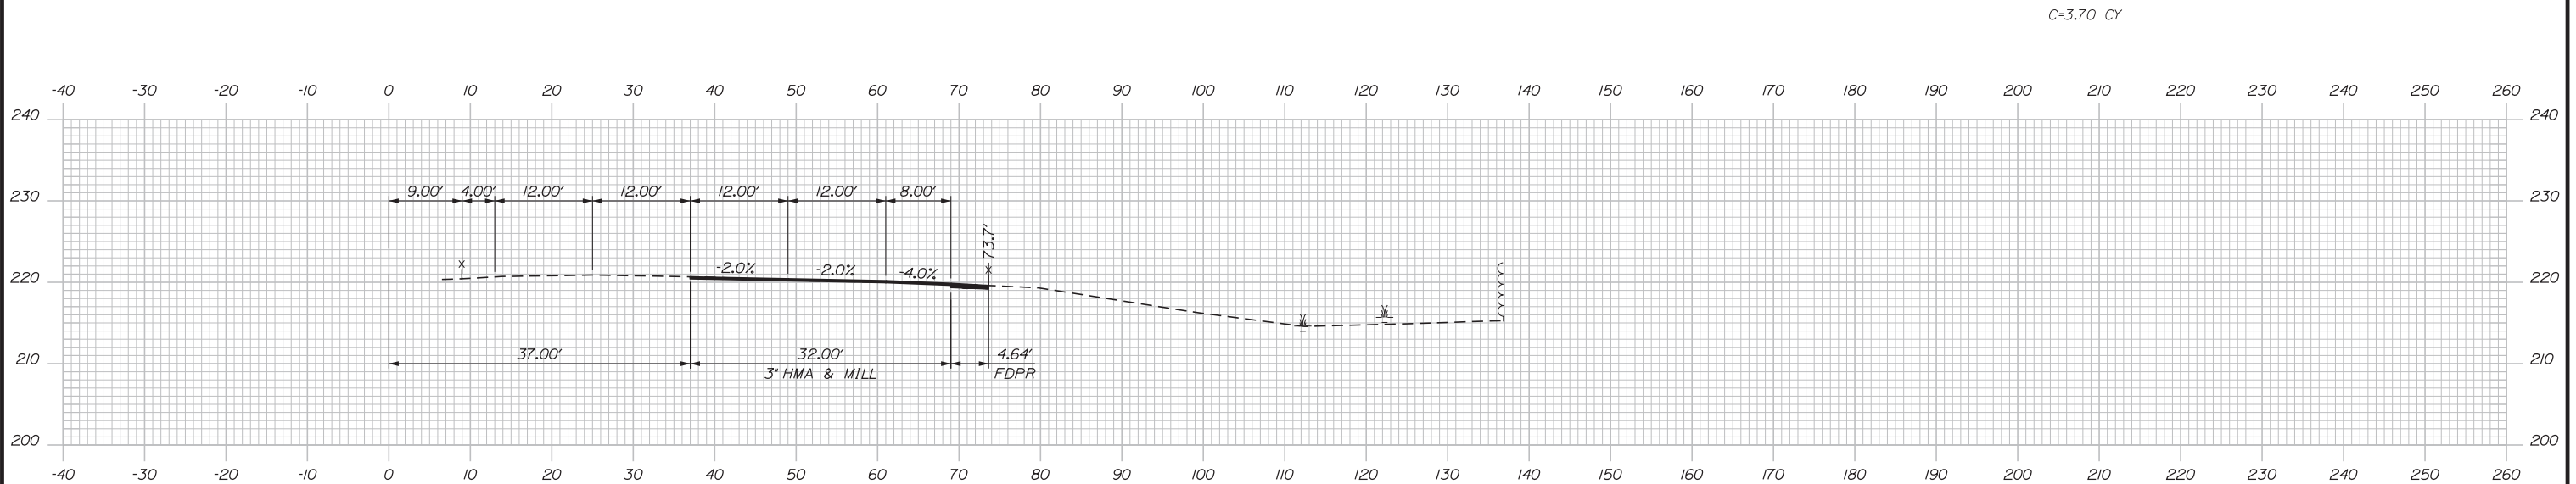

5259+50.00

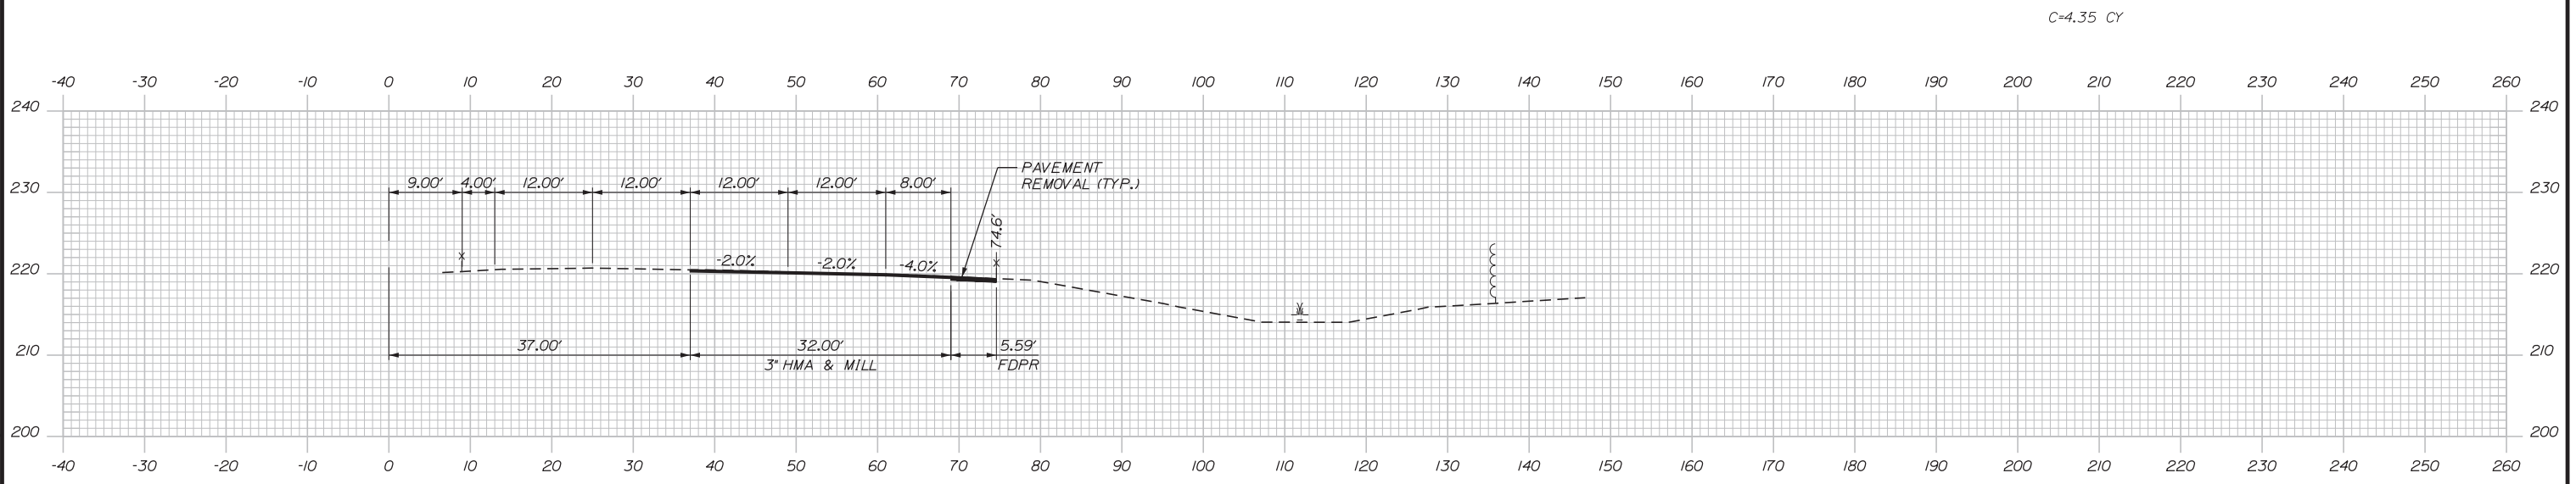

5259+00.00

 

Designed by:

**Stantec**

CONSULTANT PROJECT MANAGER: LAUREN MEEK, PE

No.	Revision	By	Date

	By	Date		By	Date
Designed	PLP	3\20\19	Checked	LEM	3\20\19
Drawn	EJB	3\20\19	In Charge of	GAE	3\20\19

STANTEC CONSULTING SERVICES INC.  
482 PAYNE ROAD  
SCARBOROUGH, ME 04074  
TEL (207) 887-3448  
FAX (207) 883-3376

**THE GOLD STAR  
MEMORIAL HIGHWAY**




MTA PROJECT MANAGER: RALPH NORWOOD, IV, PE, PTOE

INTERCHANGE 103  
ORT CONVERSION  
NB ORT  
STA. 5259+00.00 TO STA. 5259+50.00

SHEET NUMBER: XS-84  
CONTRACT: 2019.04  
318 OF 503

Filename: ...:\00\HIGHWAY\MSTA\\_xsect.dgn

 Date: 3/20/2019

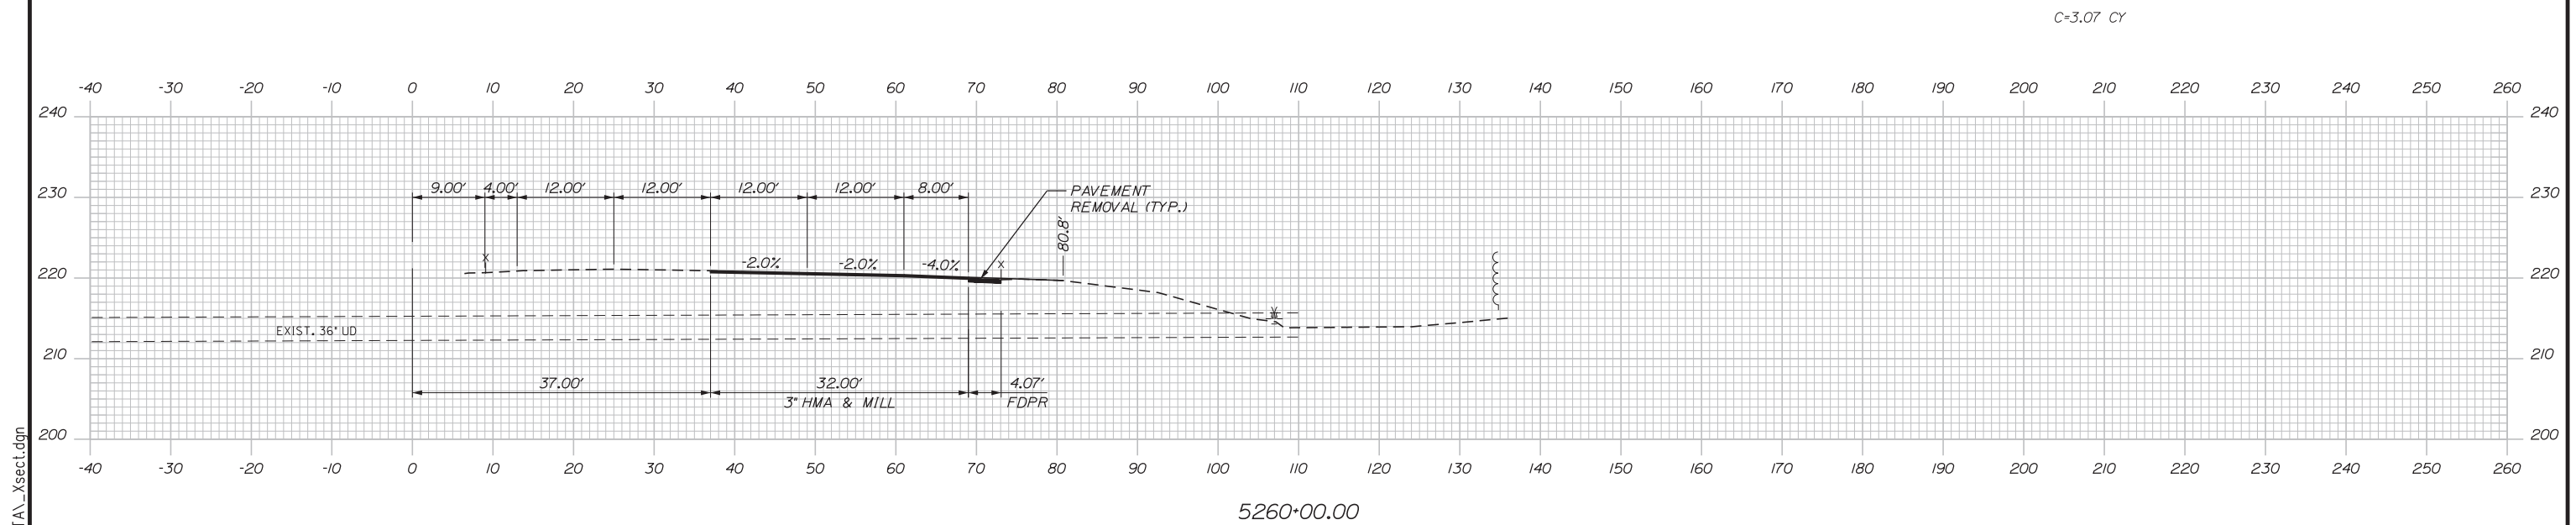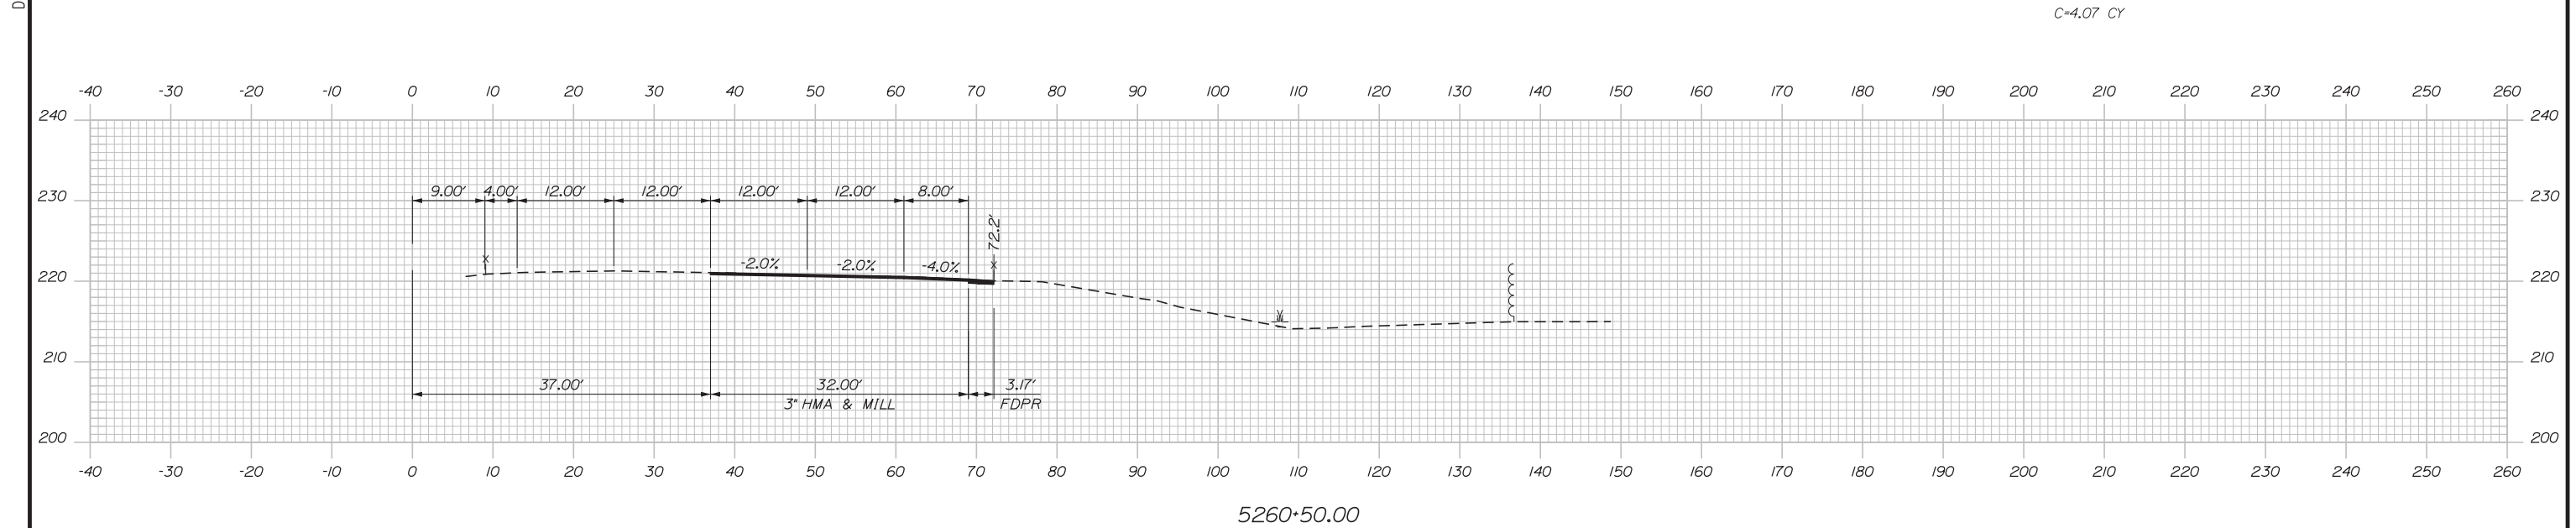

Designed by:

**Stantec**

CONSULTANT PROJECT MANAGER: LAUREN MEEK, PE

No.	Revision	By	Date

	By	Date		By	Date
Designed	PLP	3\20\19	Checked	LEM	3\20\19
Drawn	EJB	3\20\19	In Charge of	GAE	3\20\19

STANTEC CONSULTING SERVICES INC.  
482 PAYNE ROAD  
SCARBOROUGH, ME 04074  
TEL (207) 887-3448  
FAX (207) 883-3376

**MAINE TURNPIKE**

**THE GOLD STAR MEMORIAL HIGHWAY**

MTA PROJECT MANAGER: RALPH NORWOOD, IV, PE, PTOE

INTERCHANGE 103  
ORT CONVERSION  
NB ORT  
STA. 5260+00.00 TO STA. 5260+50.00

SHEET NUMBER: XS-85

CONTRACT: 2019.04


319 OF 503

Filename: ... \00\HIGHWAY\MSTA\\_xsect.dgn




Date: 3/20/2019

Filename: ... \00\HIGHWAY\MSTA\\_xsect.dgn

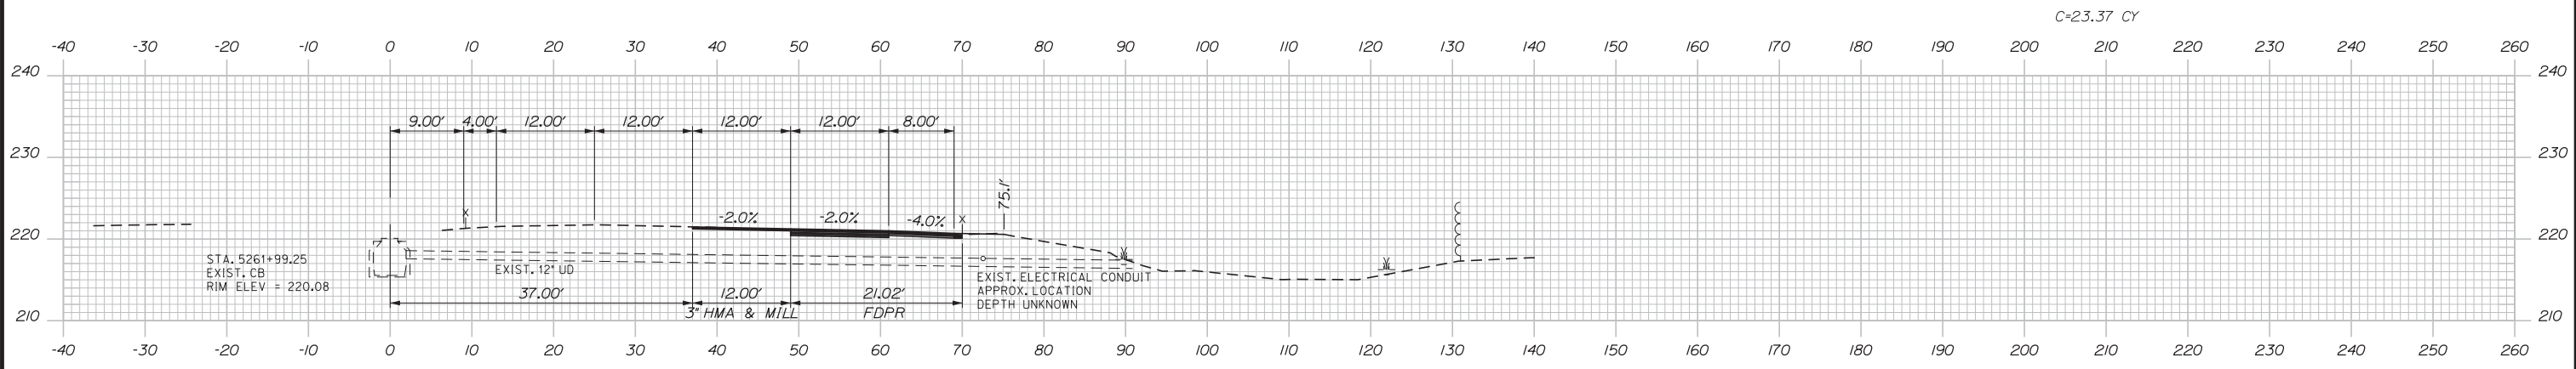


5262+00.00

C=23.37 CY

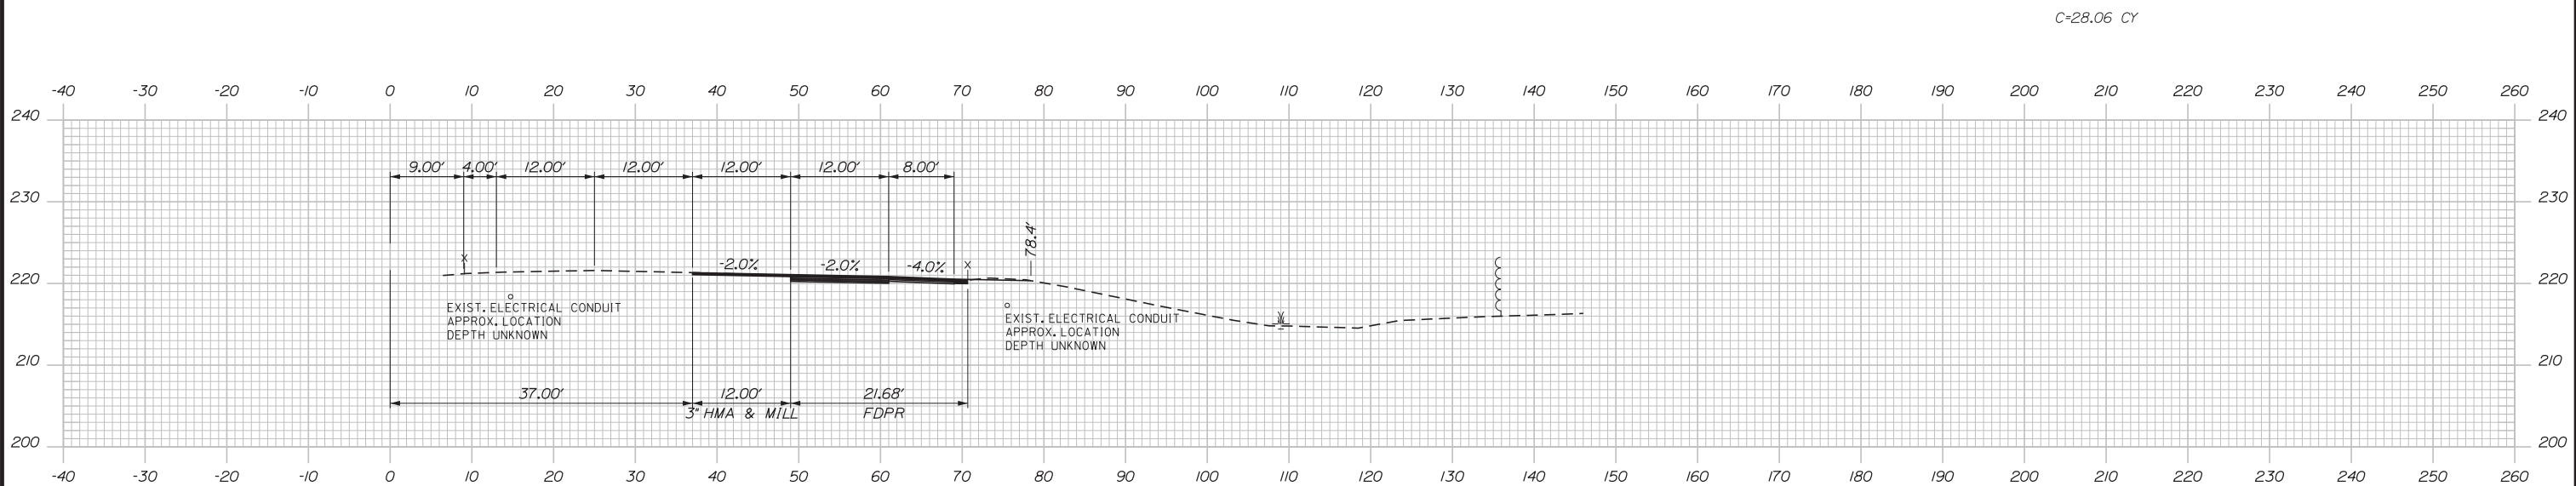


5261+50.00

C=28.06 CY

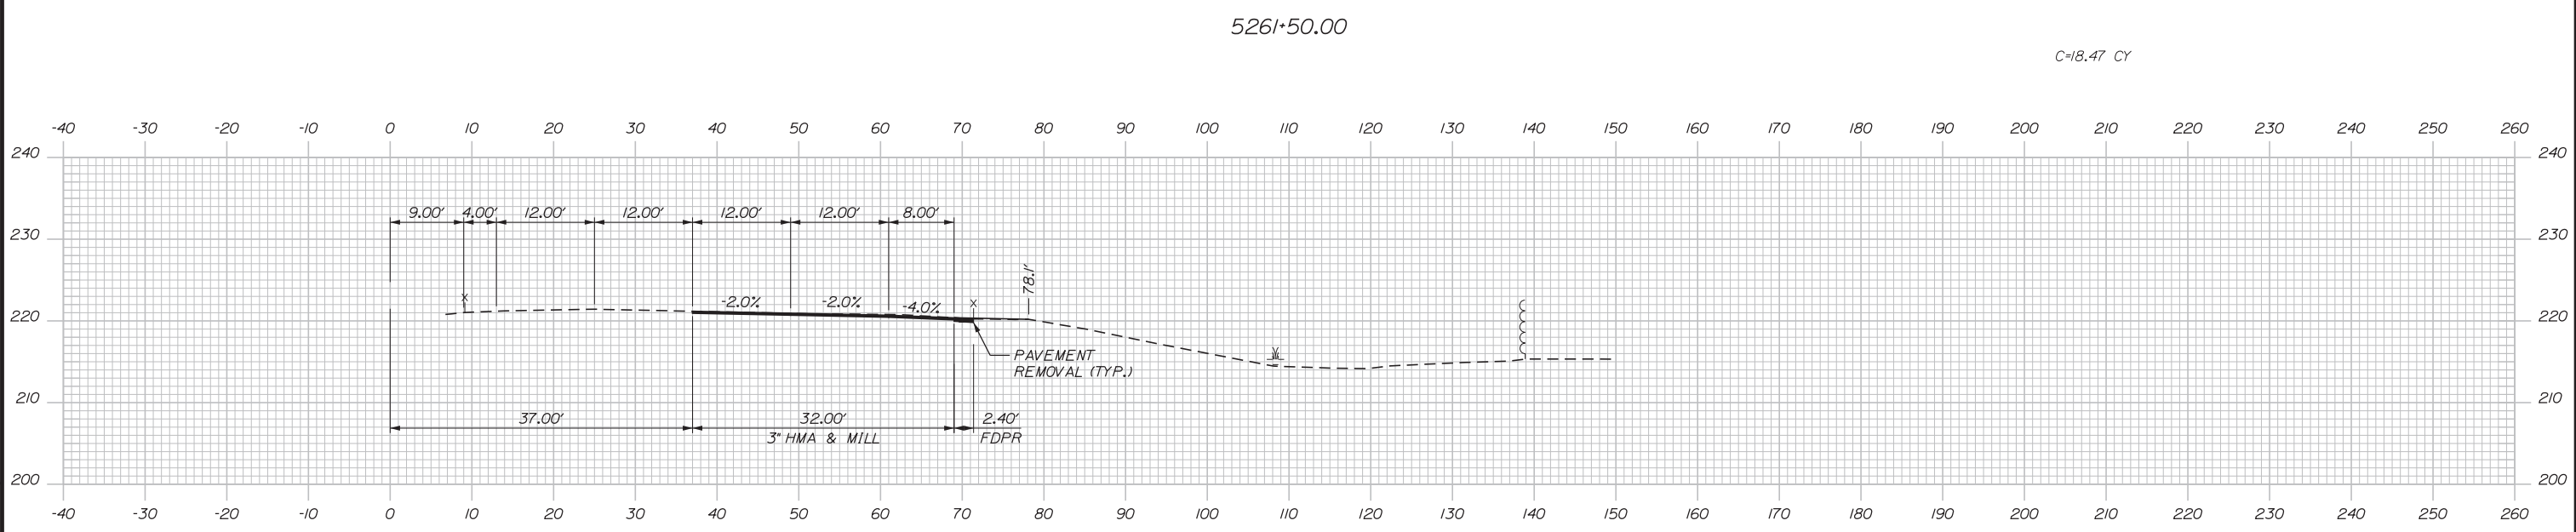

5261+00.00

 C=18.47 CY



No.	Revision	By	Date


Designed by:

**Stantec**

CONSULTANT PROJECT MANAGER: LAUREN MEEK, PE

	By	Date		By	Date
Designed	PLP	3\20\19	Checked	LEM	3\20\19
Drawn	EJB	3\20\19	In Charge of	GAE	3\20\19

STANTEC CONSULTING SERVICES INC.  
 482 PAYNE ROAD  
 SCARBOROUGH, ME 04074  
 TEL (207) 887-3448  
 FAX (207) 883-3376

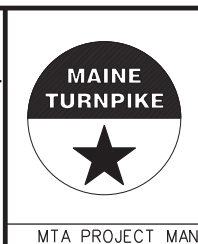


**THE GOLD STAR  
 MEMORIAL HIGHWAY**

INTERCHANGE 103  
 ORT CONVERSION  
 NB ORT  
 STA. 5261+00.00 TO STA. 5262+00.00


SHEET NUMBER: XS-86  
 CONTRACT: 2019.04  
 320 OF 503

Date: 3/20/2019


Filename: ...00\HIGHWAY\MSTA\\_xsect.dgn

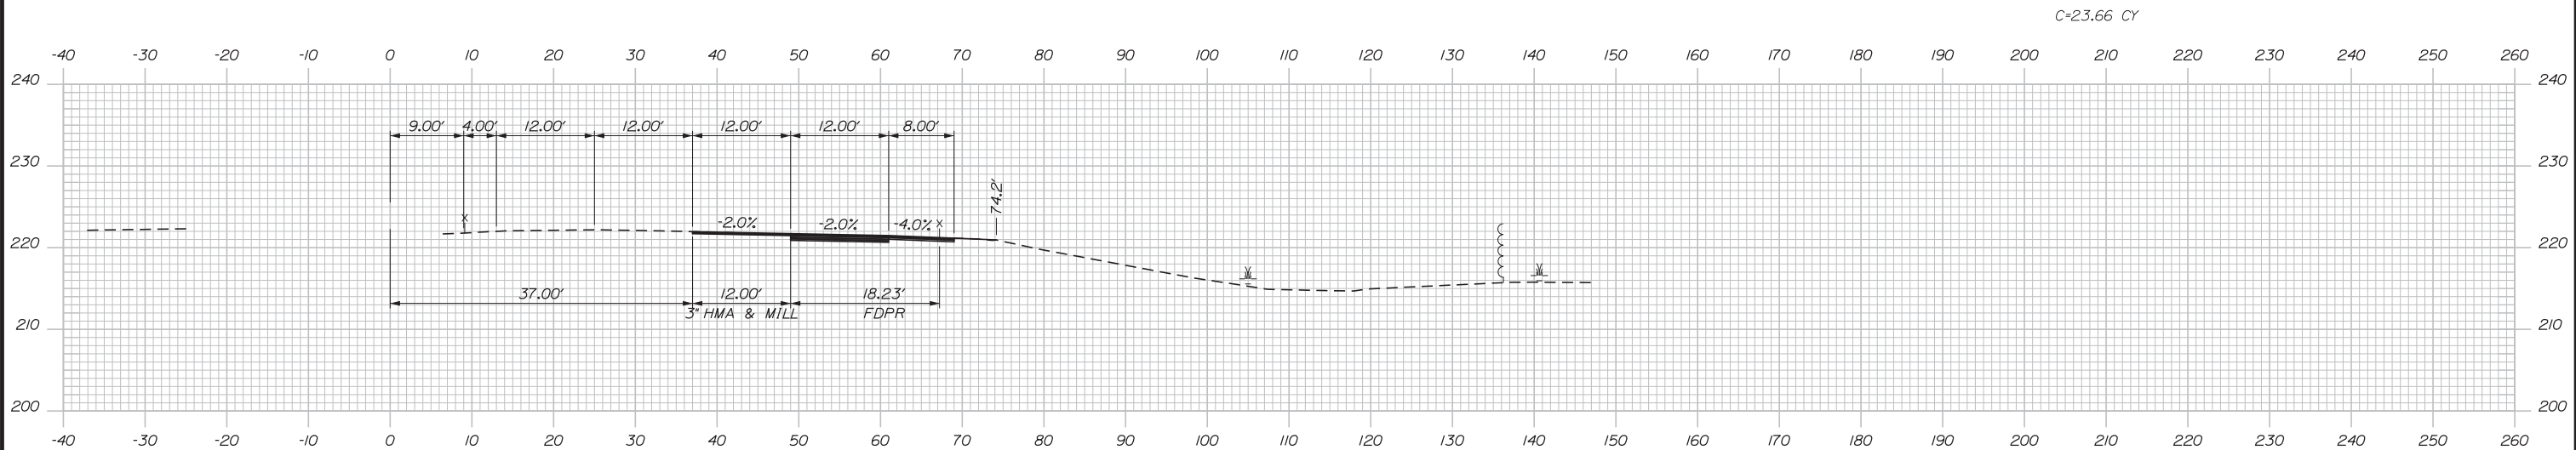


5263+50.00

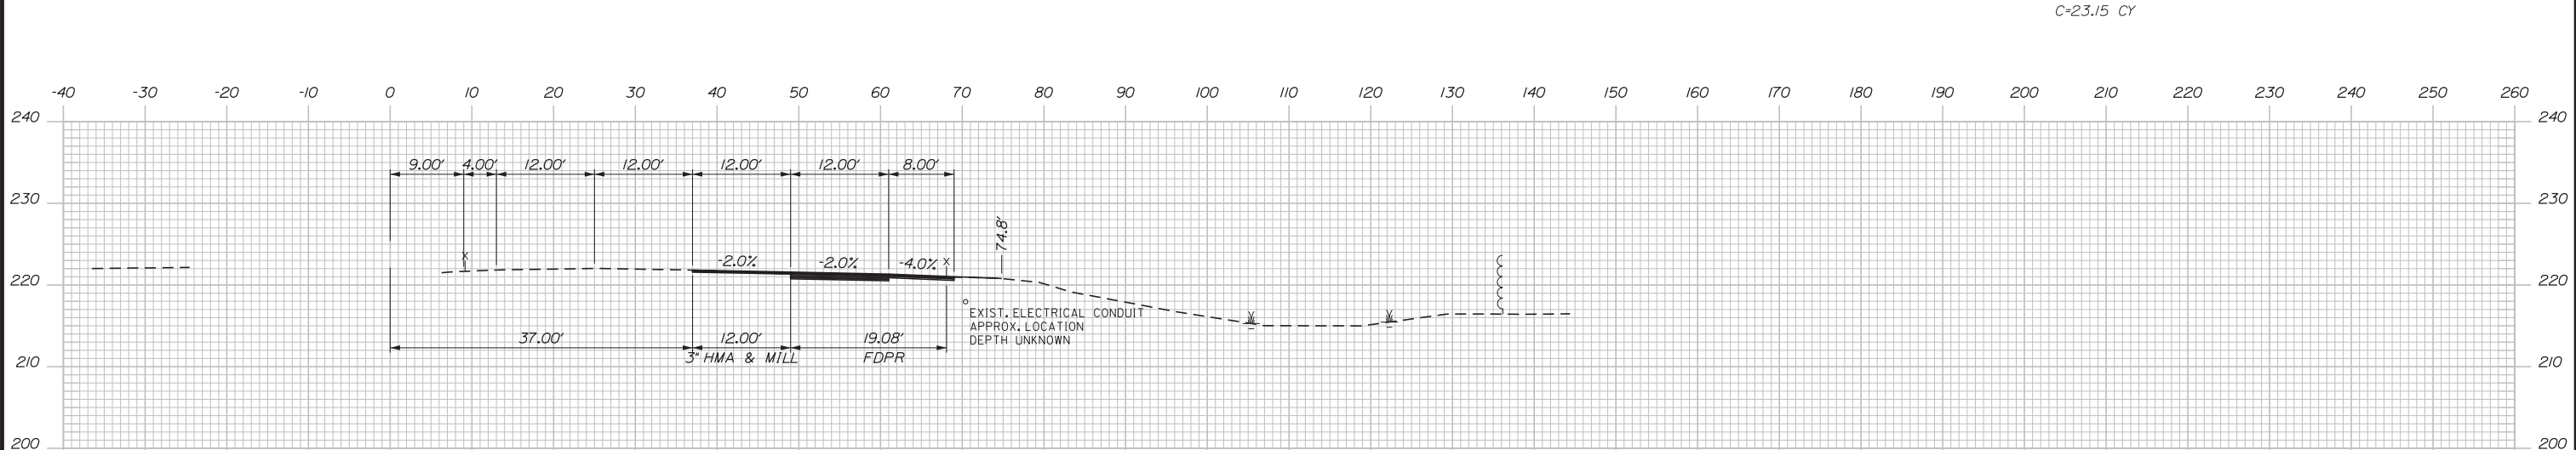

5263+00.00

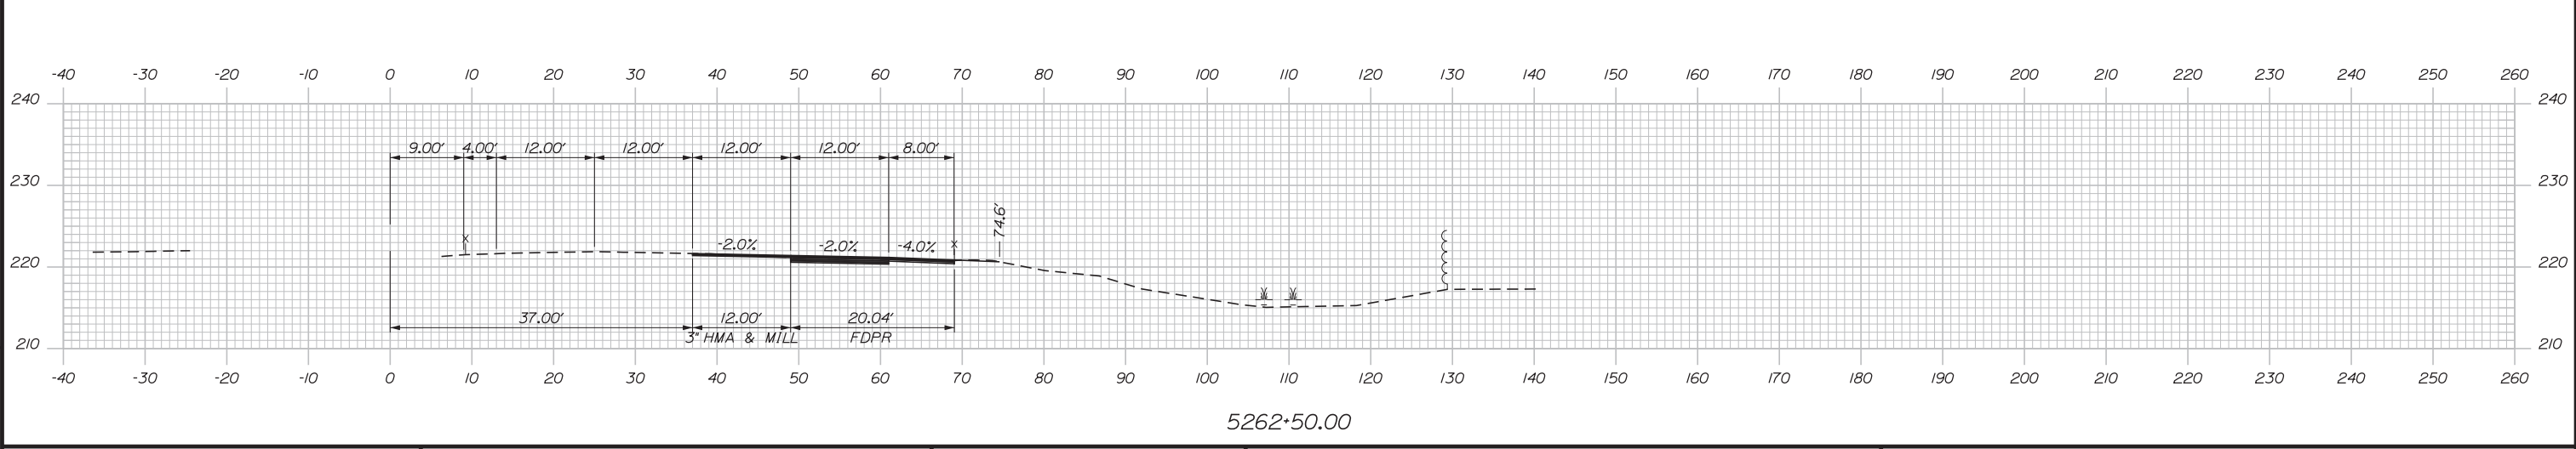

5262+50.00

 

No.	Revision	By	Date


Designed by:

**Stantec**

CONSULTANT PROJECT MANAGER: LAUREN MEEK, PE

	By	Date		By	Date
Designed	PLP	3\20\19	Checked	LEM	3\20\19
Drawn	EJB	3\20\19	In Charge of	GAE	3\20\19

STANTEC CONSULTING SERVICES INC.  
 482 PAYNE ROAD  
 SCARBOROUGH, ME 04074  
 TEL (207) 887-3448  
 FAX (207) 883-3376

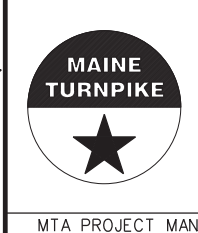

**THE GOLD STAR  
 MEMORIAL HIGHWAY**

MTA PROJECT MANAGER: RALPH NORWOOD, IV, PE, PTOE


INTERCHANGE 103  
 ORT CONVERSION  
 NB ORT  
 STA. 5262+50.00 TO STA. 5263+50.00

SHEET NUMBER: XS-87  
 321 OF 503

CONTRACT: 2019.04


Date: 3/20/2019

Filename: ...00\HIGHWAY\MSTA\\_xsect.dgn

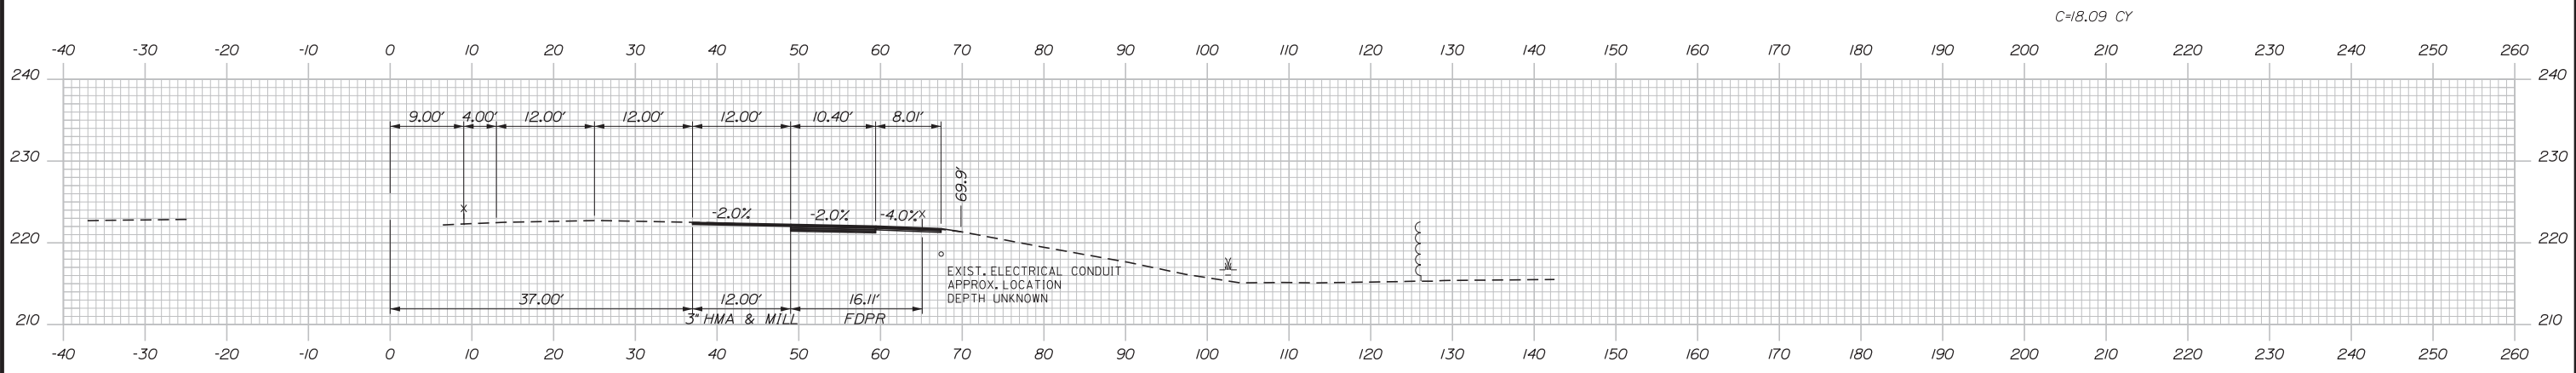


5265+00.00

C=18.09 CY

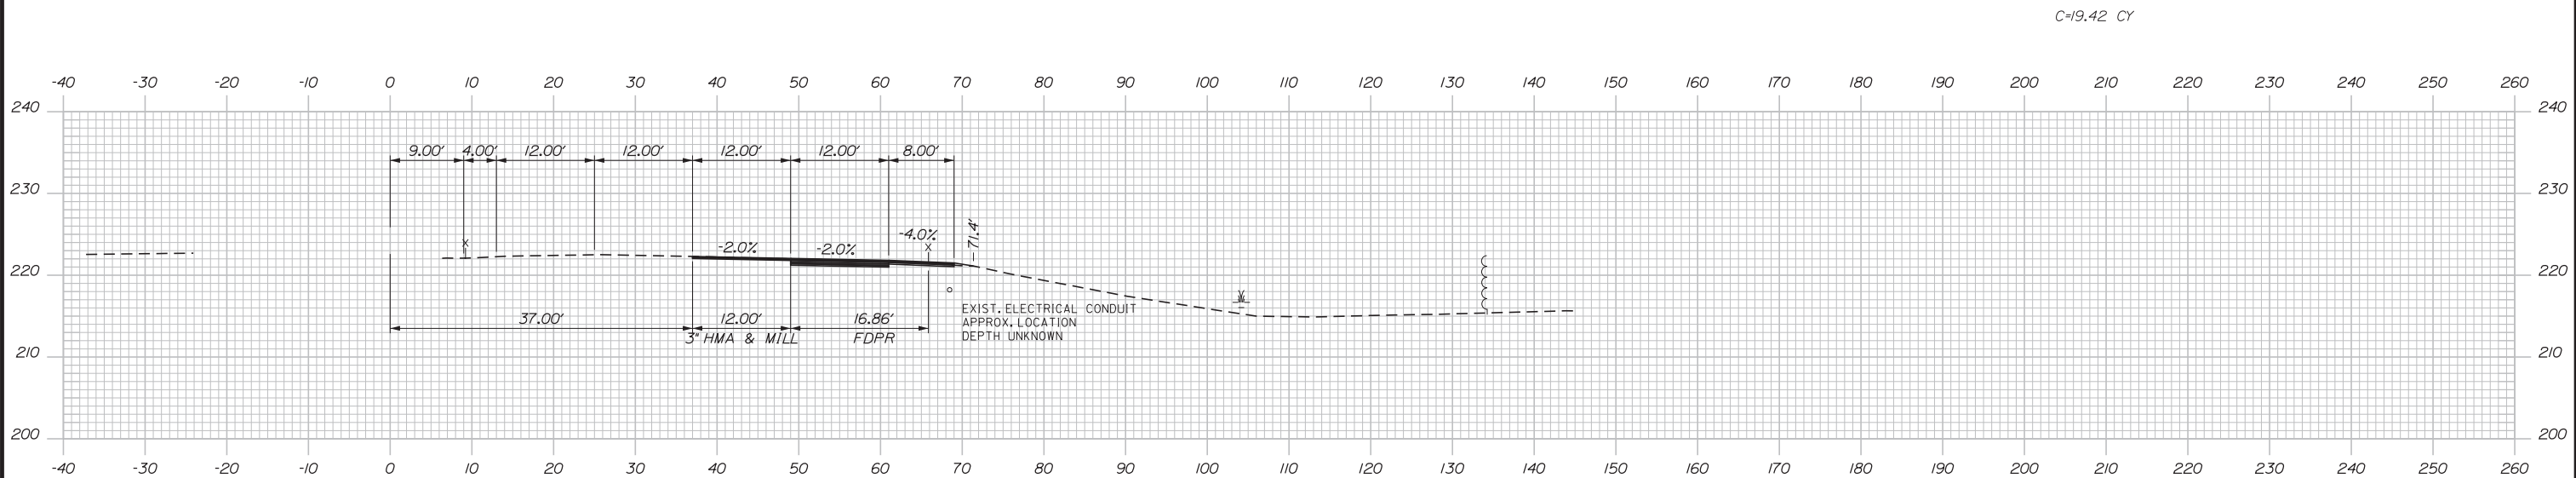


5264+50.00

C=19.42 CY

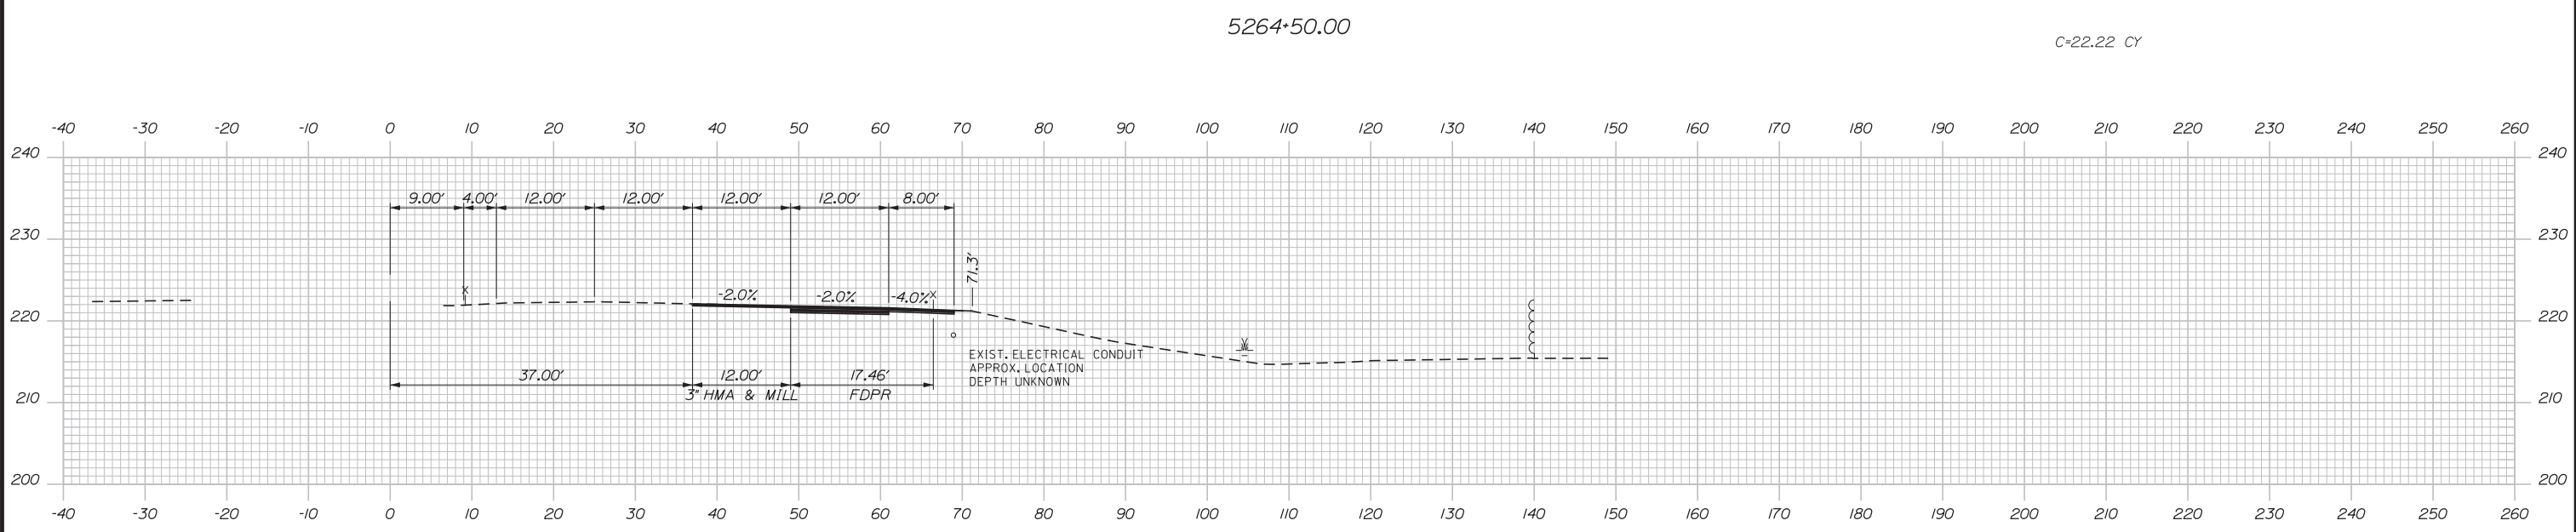

5264+00.00

 C=22.22 CY



Designed by:


**Stantec**

CONSULTANT PROJECT MANAGER: LAUREN MEEK, PE

No.	Revision	By	Date

	By	Date		By	Date
Designed	PLP	3\20\19	Checked	LEM	3\20\19
Drawn	EJB	3\20\19	In Charge of	GAE	3\20\19

STANTEC CONSULTING SERVICES INC.  
482 PAYNE ROAD  
SCARBOROUGH, ME 04074  
TEL (207) 887-3448  
FAX (207) 883-3376

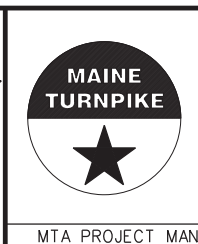


**THE GOLD STAR  
MEMORIAL HIGHWAY**

MTA PROJECT MANAGER: RALPH NORWOOD, IV, PE, PTOE


INTERCHANGE 103  
ORT CONVERSION  
NB ORT  
STA. 5264+00.00 TO STA. 5265+00.00

SHEET NUMBER: XS-88  
CONTRACT: 2019.04  
322 OF 503


Date: 3/20/2019

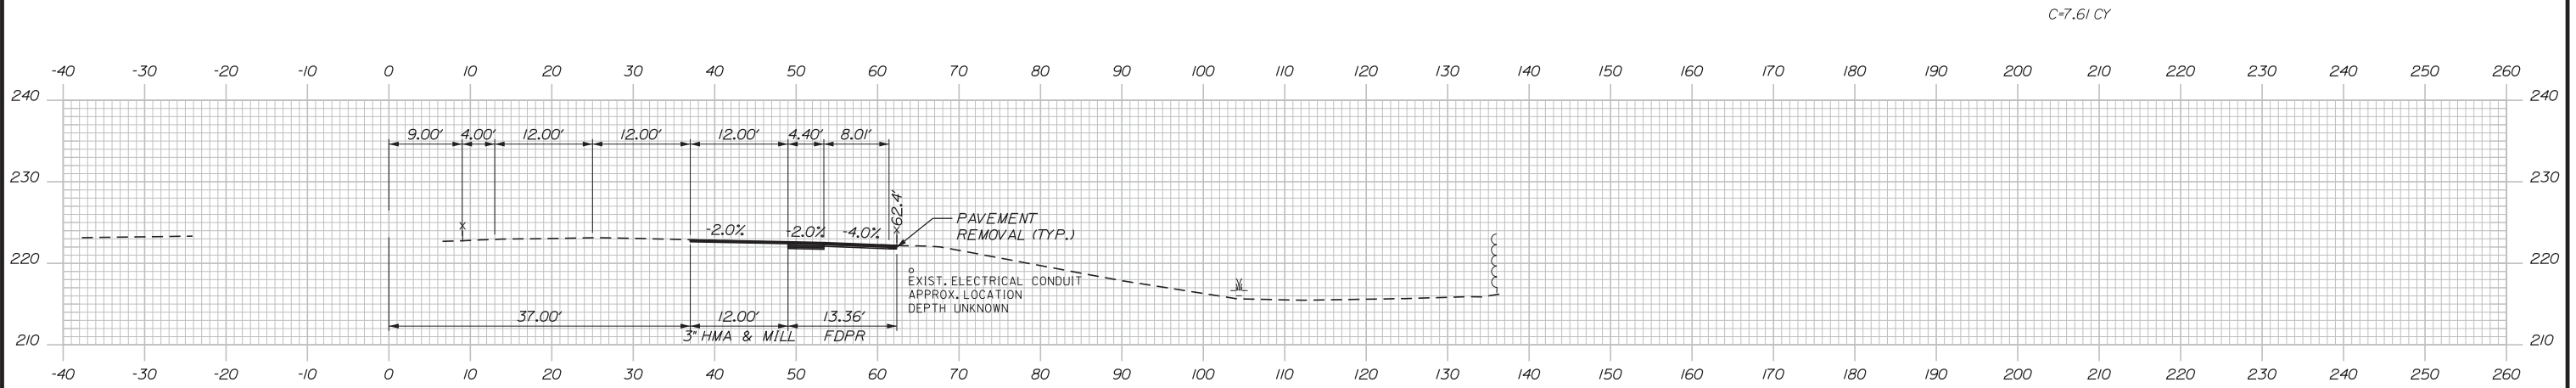


5266+50.00

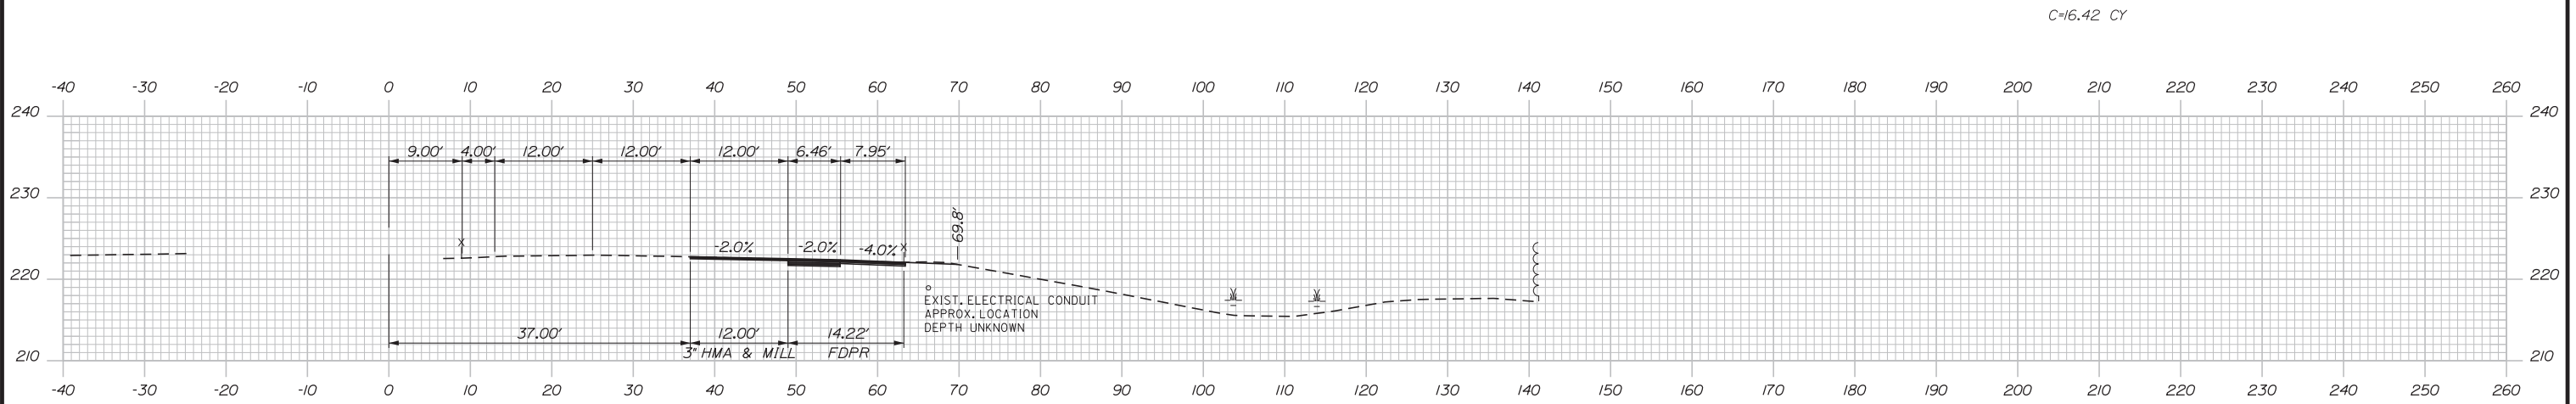

5266+00.00

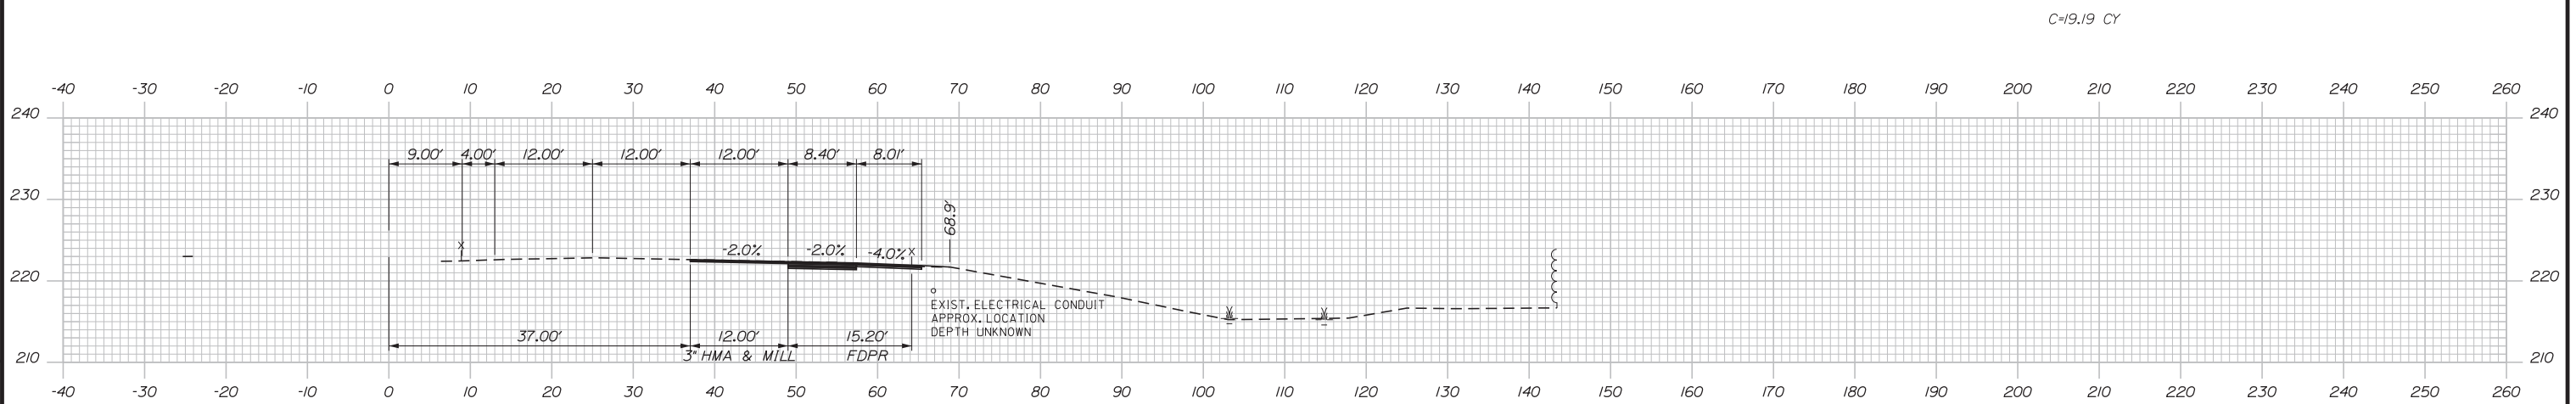

5265+50.00

 

Designed by:


**Stantec**

CONSULTANT PROJECT MANAGER: LAUREN MEEK, PE

No.	Revision	By	Date

	By	Date		By	Date
Designed	PLP	3\20\19	Checked	LEM	3\20\19
Drawn	EJB	3\20\19	In Charge of	GAE	3\20\19

STANTEC CONSULTING SERVICES INC.  
482 PAYNE ROAD  
SCARBOROUGH, ME 04074  
TEL (207) 887-3448  
FAX (207) 883-3376

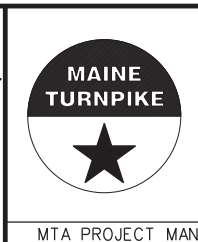





**THE GOLD STAR  
MEMORIAL HIGHWAY**

INTERCHANGE 103  
ORT CONVERSION  
NB ORT  
STA. 5265+50.00 TO STA. 5266+50.00

SHEET NUMBER: XS-89  
CONTRACT: 2019.04  
323 OF 503

Filename: ...00.HIGHWAY\MSTA\\_xsect.dgn

 Date: 3/20/2019

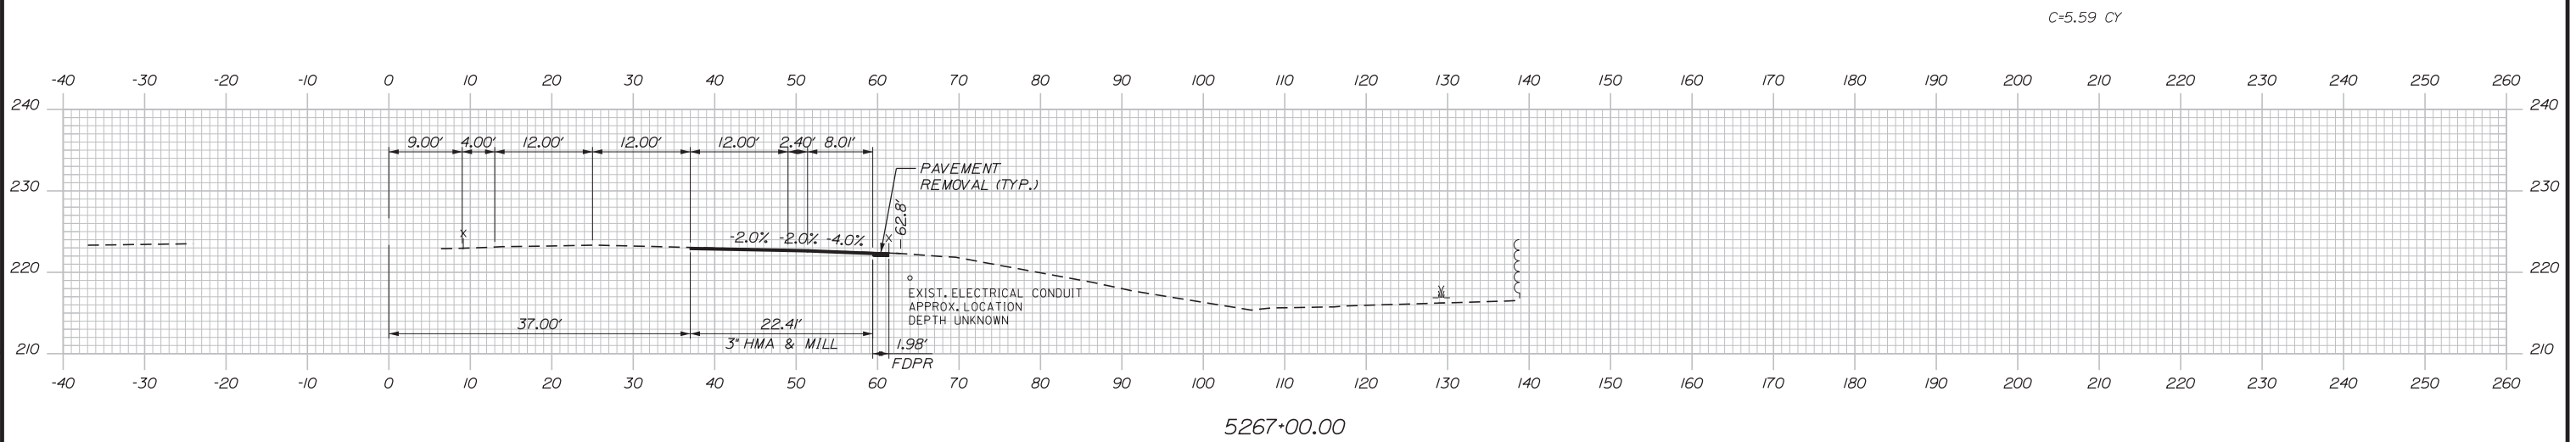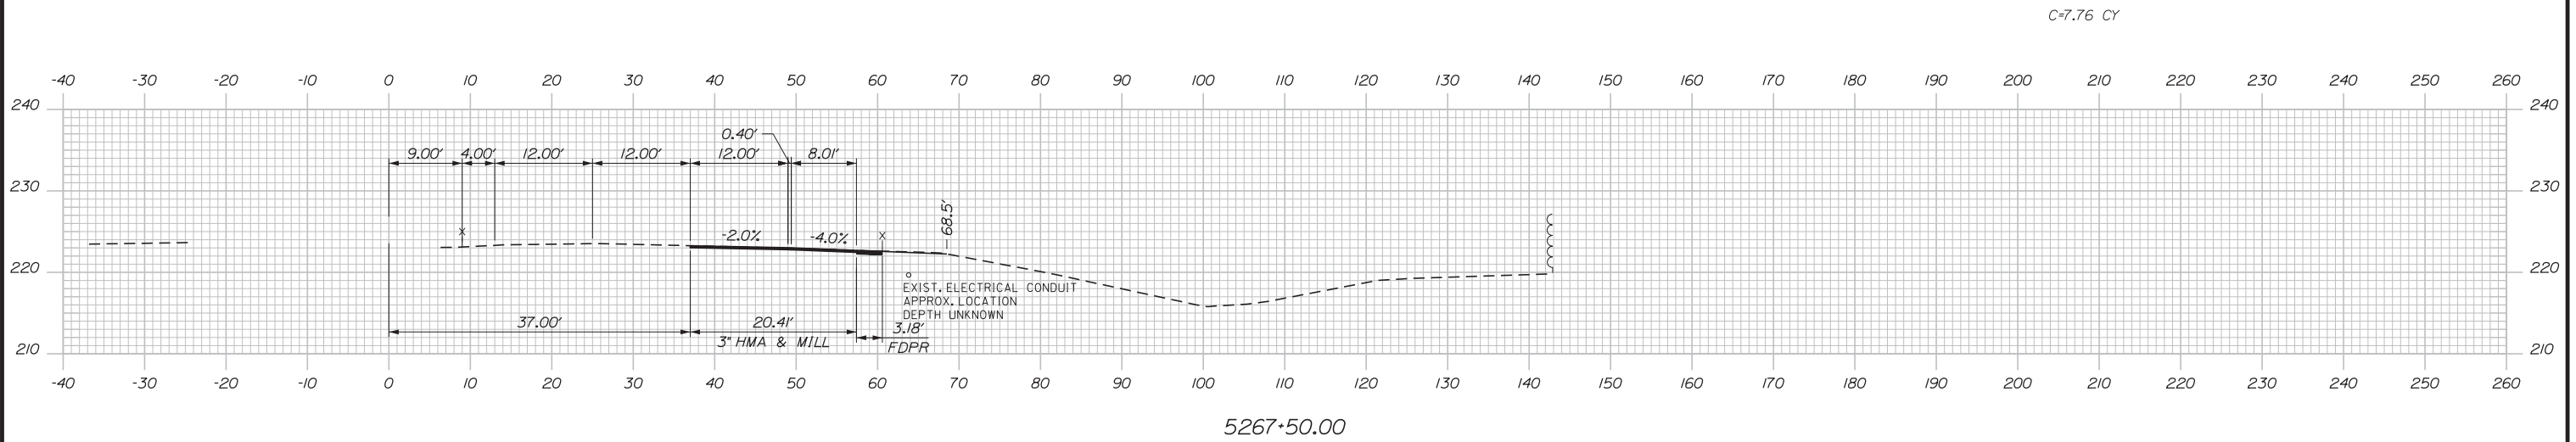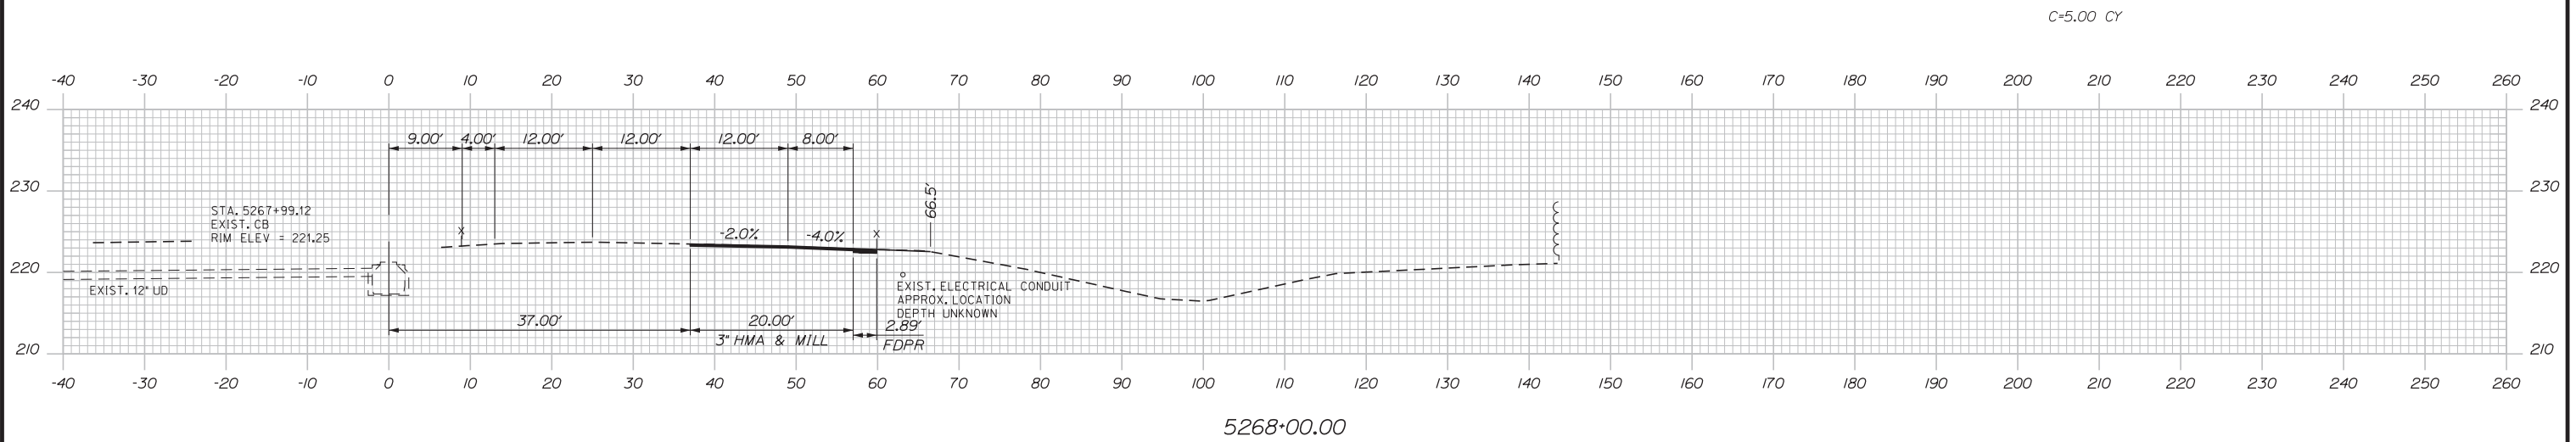

Designed by:

**Stantec**

CONSULTANT PROJECT MANAGER: LAUREN MEEK, PE

No.	Revision	By	Date

	By	Date		By	Date
Designed	PLP	3\20\19	Checked	LEM	3\20\19
Drawn	EJB	3\20\19	In Charge of	GAE	3\20\19

STANTEC CONSULTING SERVICES INC.  
 482 PAYNE ROAD  
 SCARBOROUGH, ME 04074  
 TEL (207) 887-3448  
 FAX (207) 883-3376

**MAINE TURNPIKE**

**THE GOLD STAR MEMORIAL HIGHWAY**

MTA PROJECT MANAGER: RALPH NORWOOD, IV, PE, PTOE


INTERCHANGE 103  
 ORT CONVERSION  
 NB ORT  
 STA. 5267+00.00 TO STA. 5268+00.00

SHEET NUMBER: XS-90  
 CONTRACT: 2019.04  
 324 OF 503


Filename: ...00\HIGHWAY\MSTA\\_xsect.dgn




Date: 3/20/2019

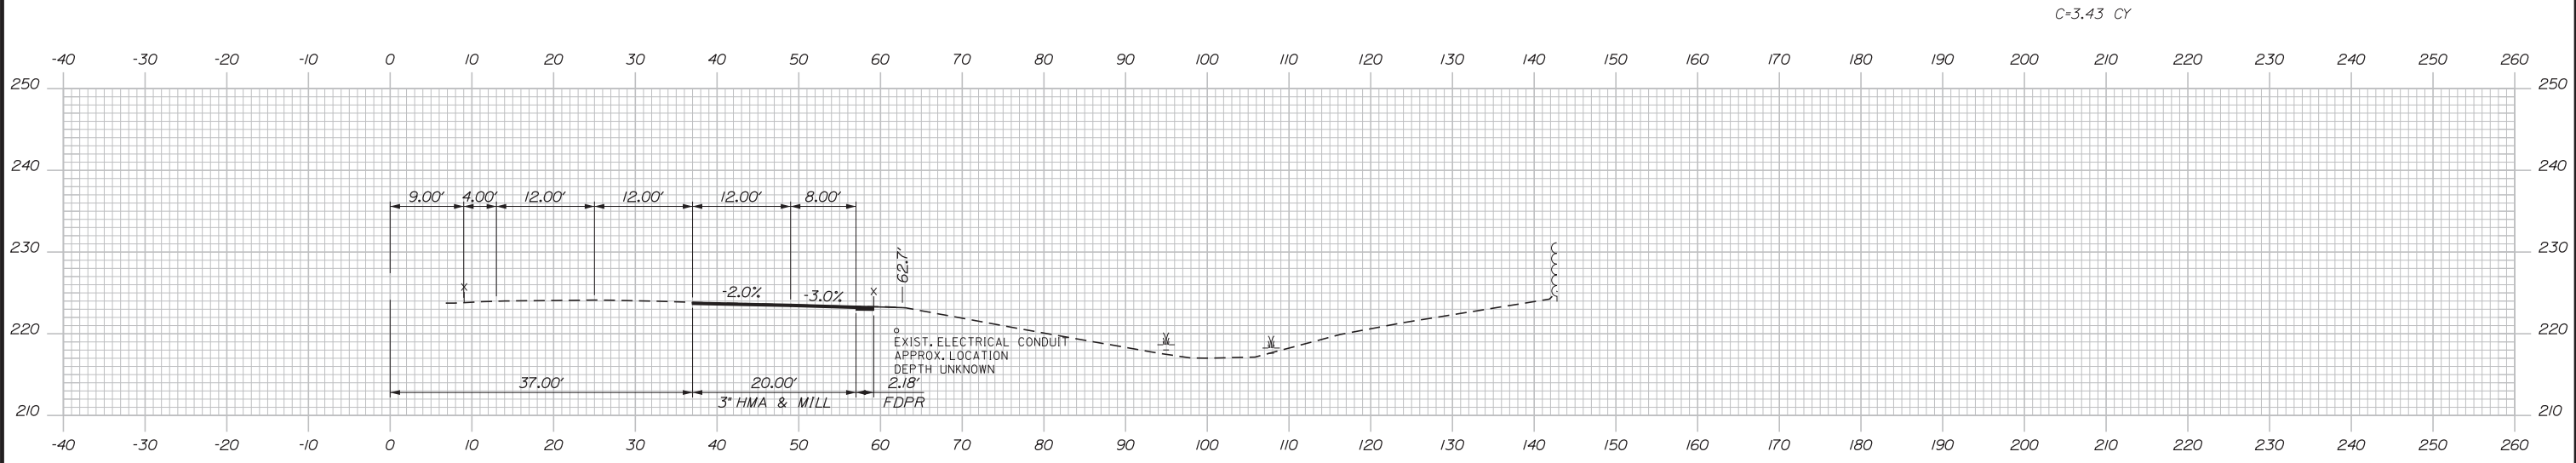


5269+50.00

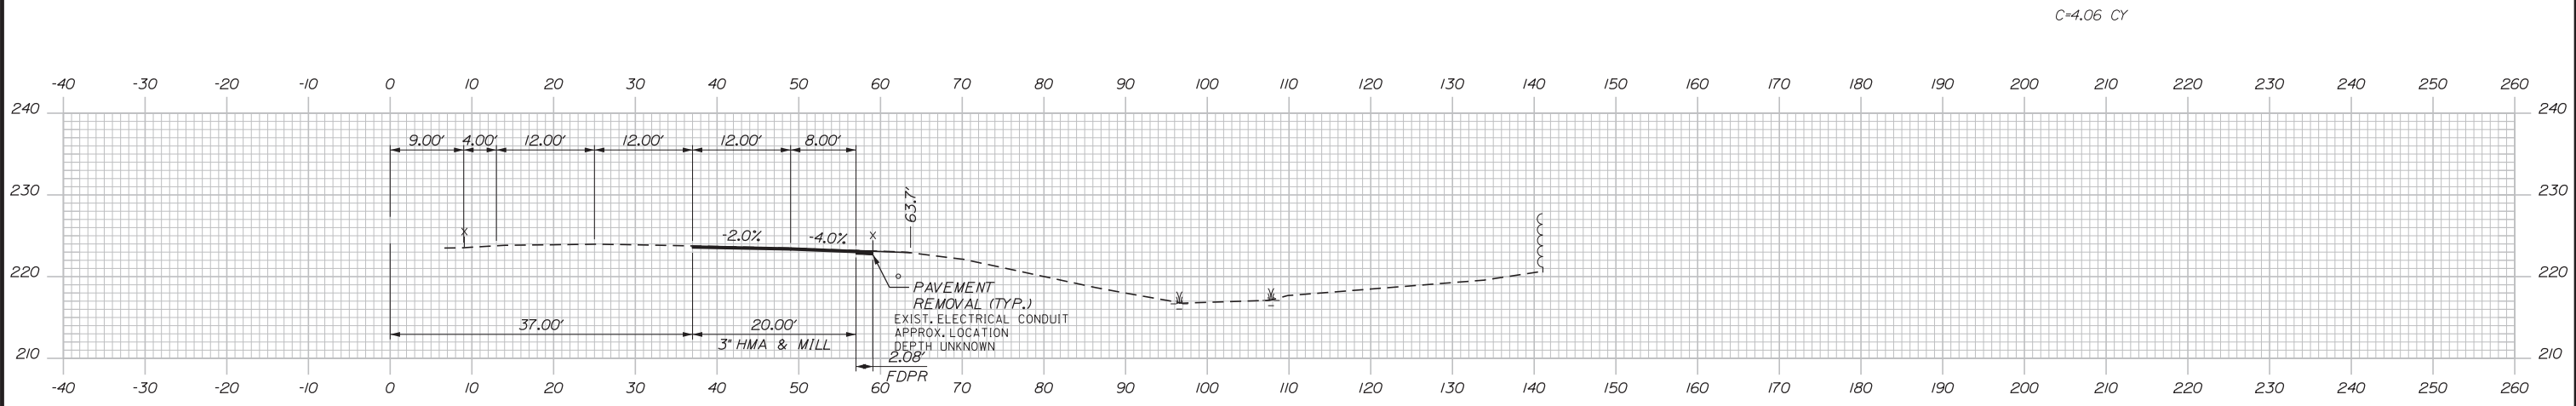

5269+00.00

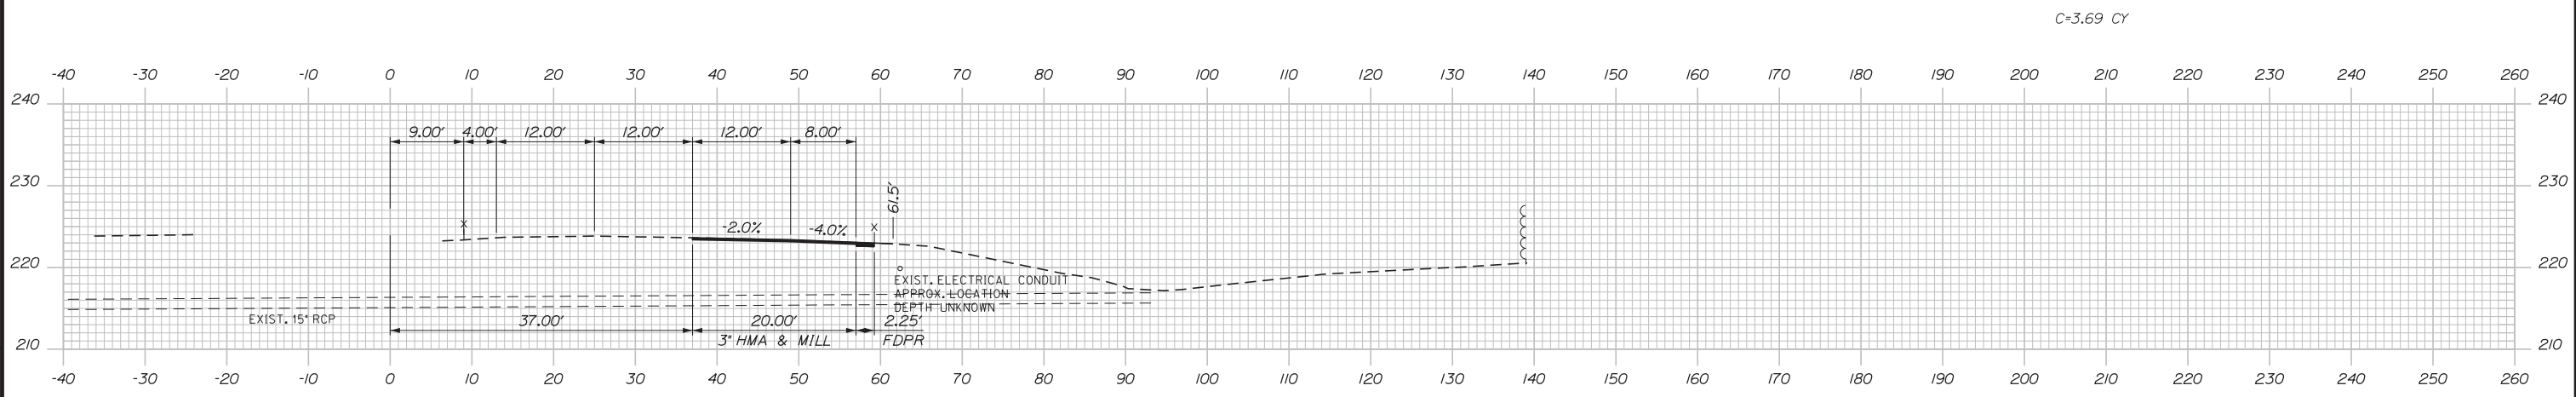

5268+50.00

 

No.	Revision	By	Date


Designed by:

**Stantec**

CONSULTANT PROJECT MANAGER: LAUREN MEEK, PE

	By	Date		By	Date
Designed	PLP	3\20\19	Checked	LEM	3\20\19
Drawn	EJB	3\20\19	In Charge of	GAE	3\20\19

STANTEC CONSULTING SERVICES INC.  
 482 PAYNE ROAD  
 SCARBOROUGH, ME 04074  
 TEL (207) 887-3448  
 FAX (207) 883-3376

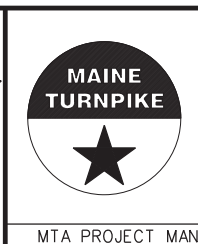

**THE GOLD STAR  
 MEMORIAL HIGHWAY**





INTERCHANGE 103  
 ORT CONVERSION  
 NB ORT  
 STA. 5268+50.00 TO STA. 5269+50.00

SHEET NUMBER: XS-91  
 325 OF 503

CONTRACT: 2019.04

Filename: ...00.HIGHWAY\MSTA\\_xsect.dgn

 Date: 3/20/2019

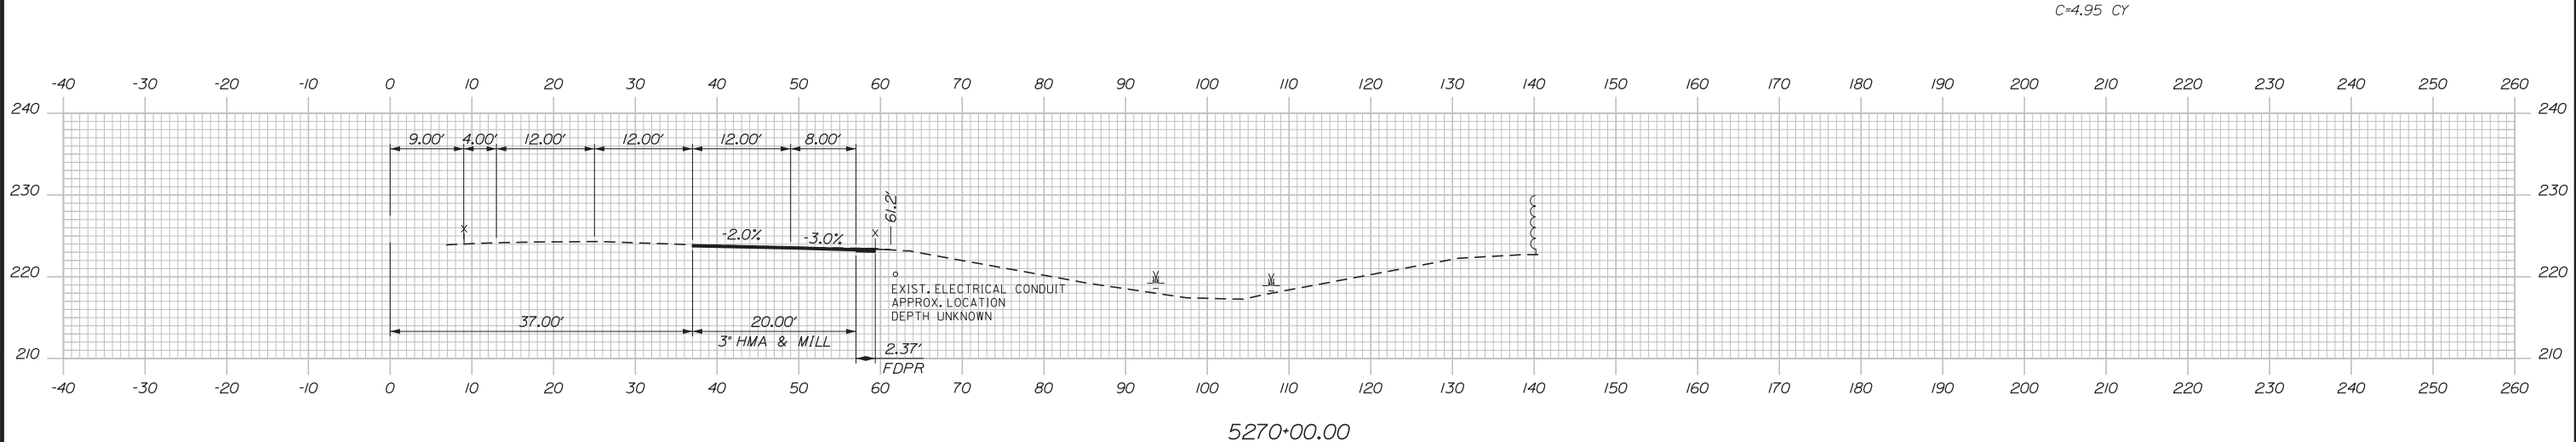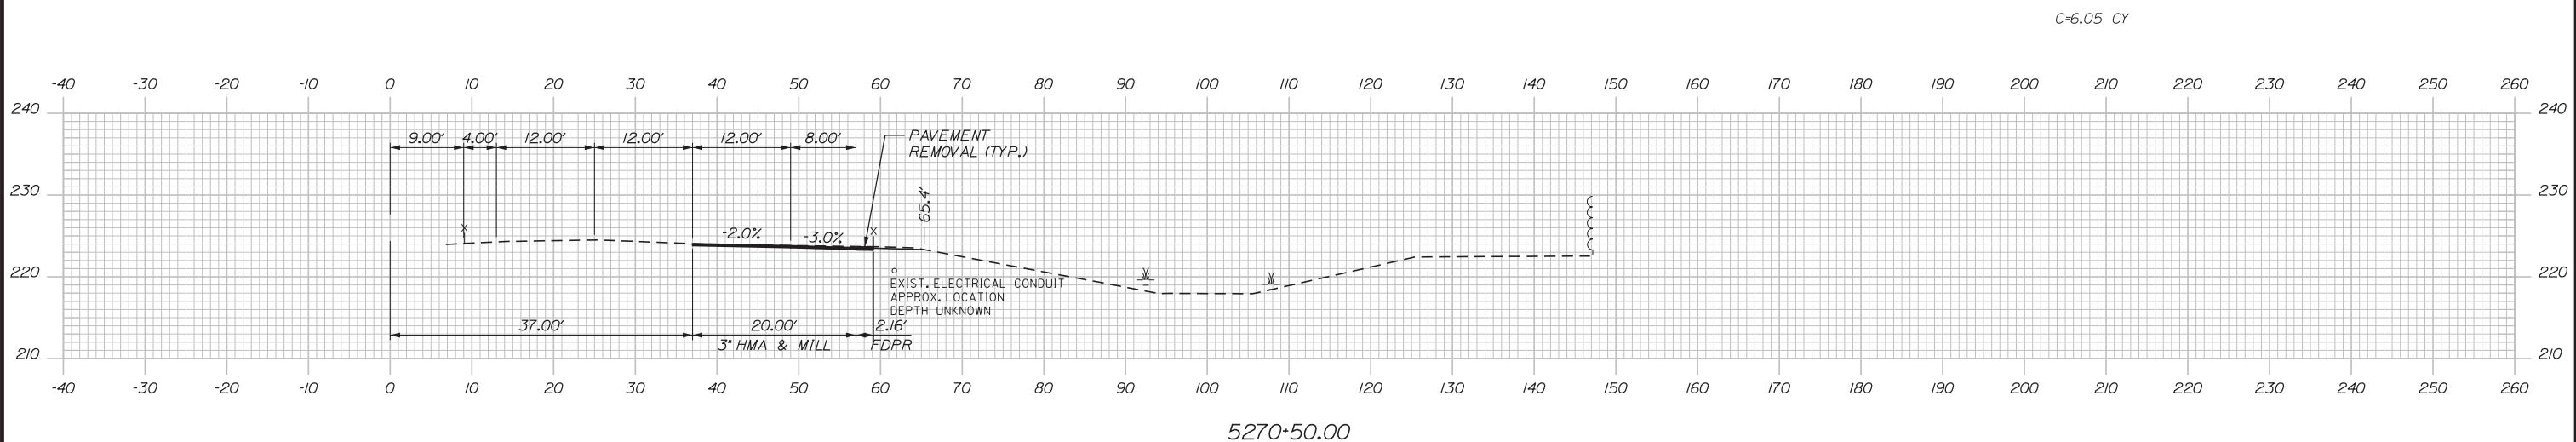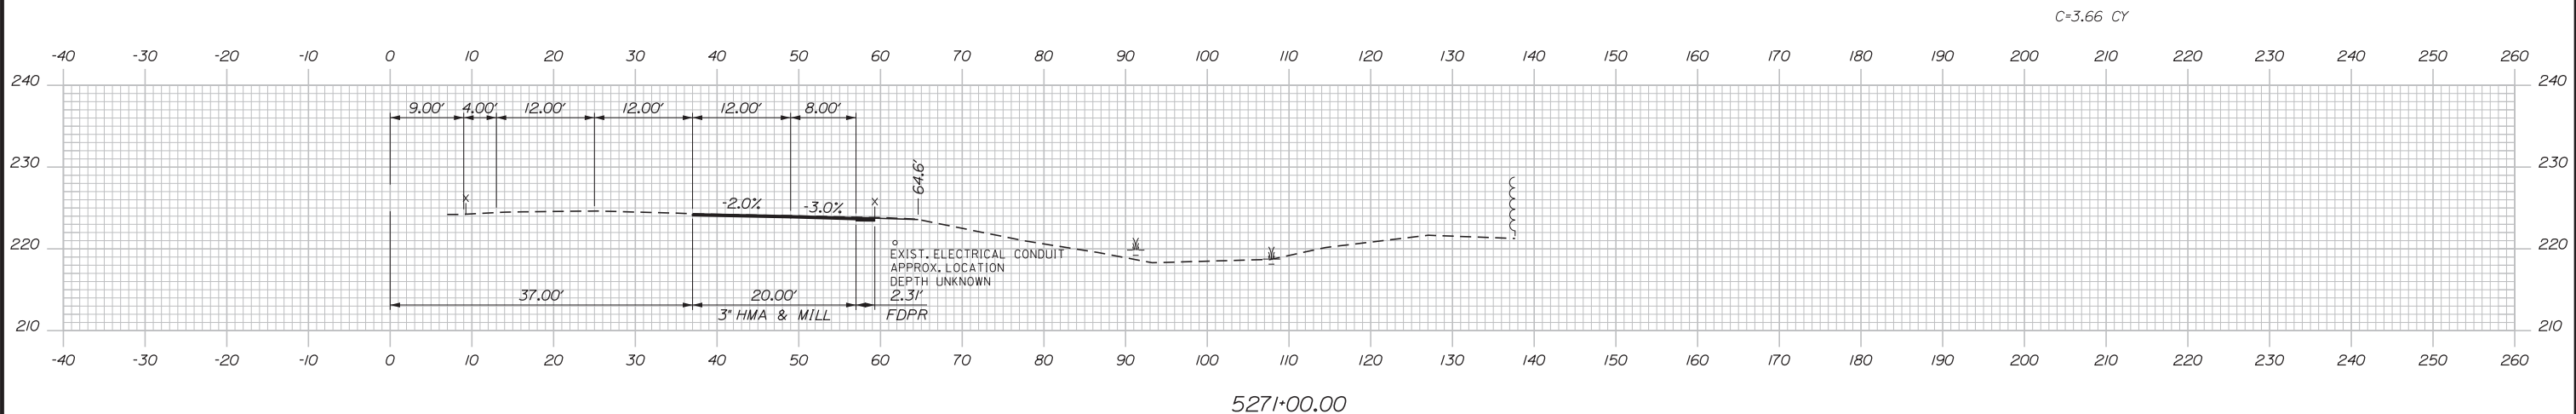

Designed by:

**Stantec**

CONSULTANT PROJECT MANAGER: LAUREN MEEK, PE

No.	Revision	By	Date

	By	Date		By	Date
Designed	PLP	3\20\19	Checked	LEM	3\20\19
Drawn	EJB	3\20\19	In Charge of	GAE	3\20\19

STANTEC CONSULTING SERVICES INC.  
 482 PAYNE ROAD  
 SCARBOROUGH, ME 04074  
 TEL (207) 887-3448  
 FAX (207) 883-3376

**MAINE TURNPIKE**

**THE GOLD STAR MEMORIAL HIGHWAY**

MTA PROJECT MANAGER: RALPH NORWOOD, IV, PE, PTOE


INTERCHANGE 103  
 ORT CONVERSION  
 NB ORT  
 STA. 5270+00.00 TO STA. 5271+00.00

SHEET NUMBER: XS-92  
 326 OF 503


CONTRACT: 2019.04

Filename: ...00.HIGHWAY\MSTA\\_xsect.dgn


Date: 3/20/2019

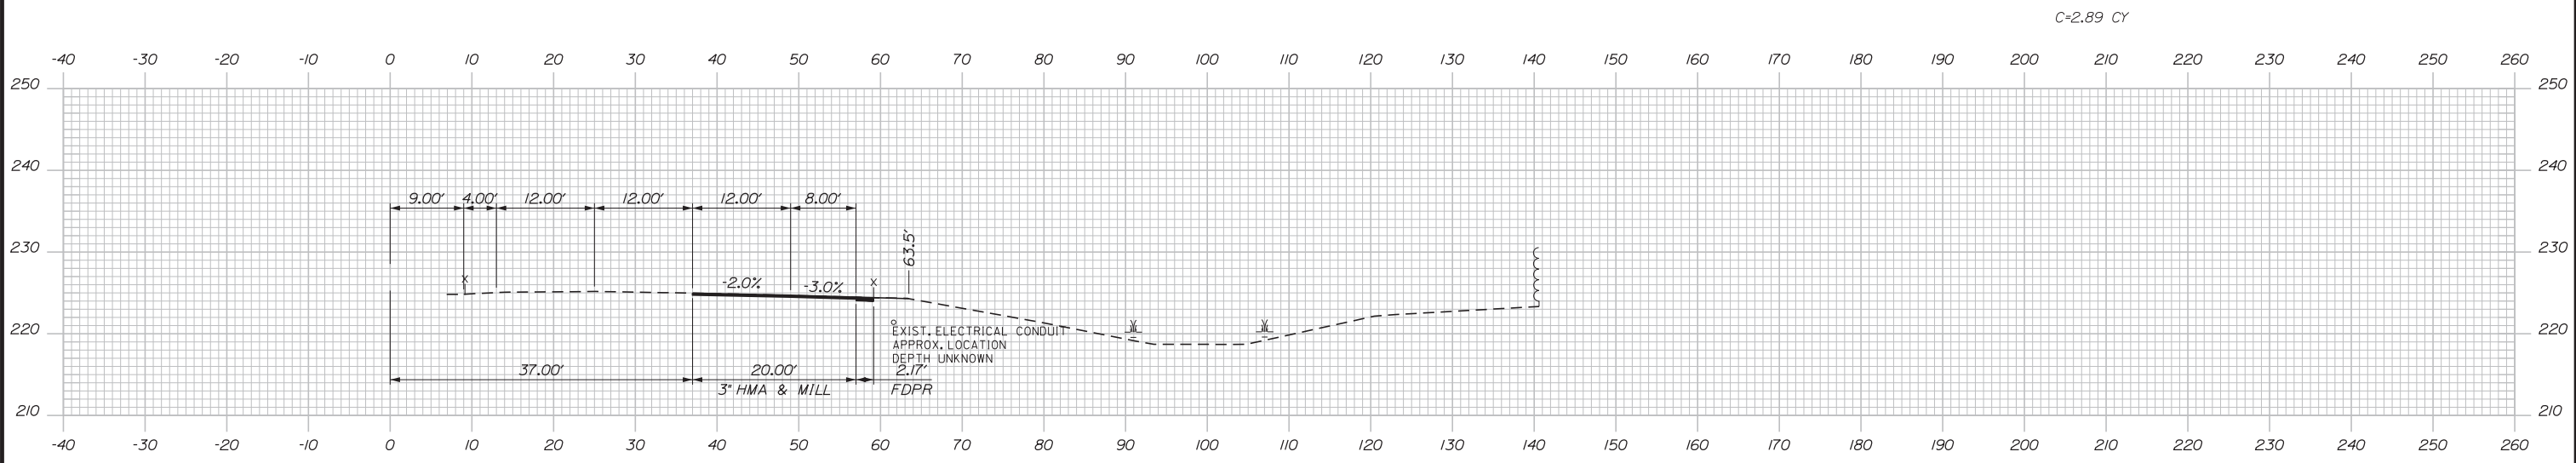


5272+50.00

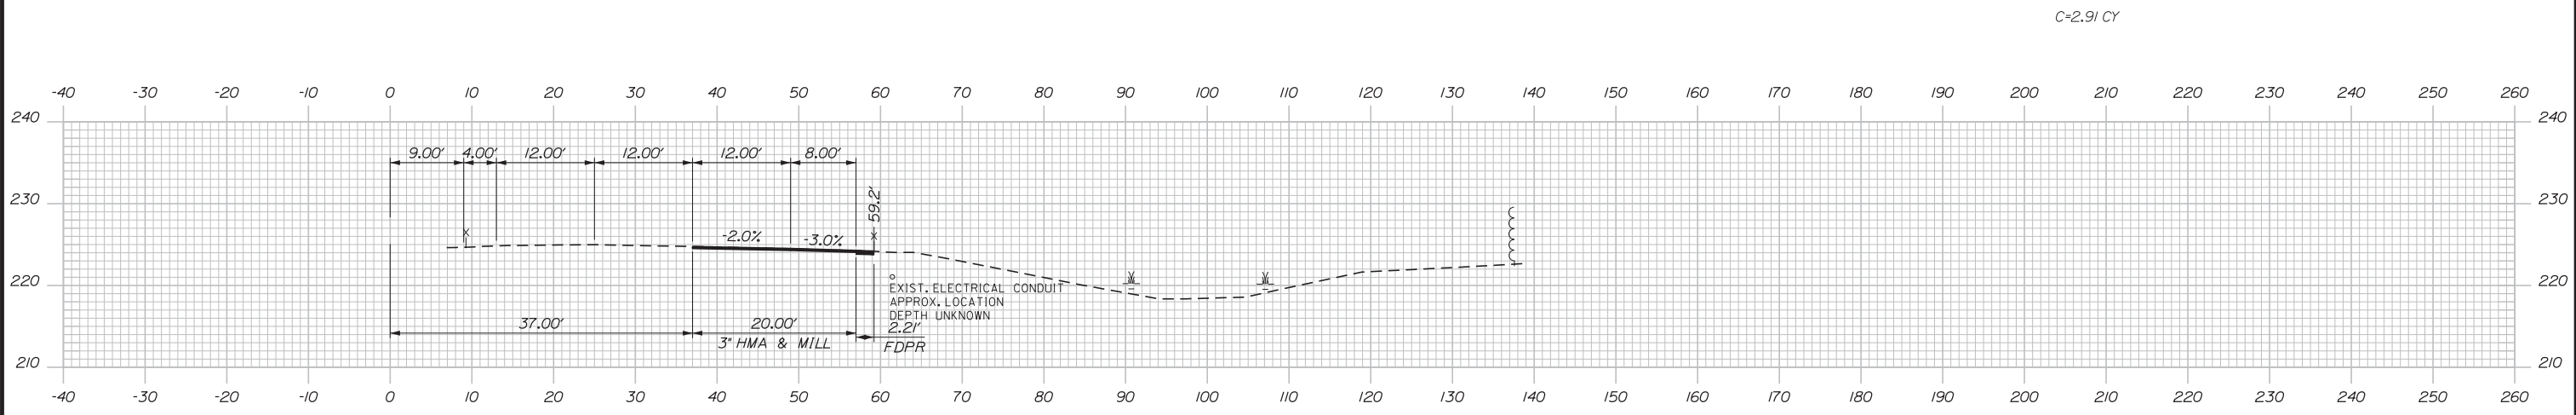

5272+00.00

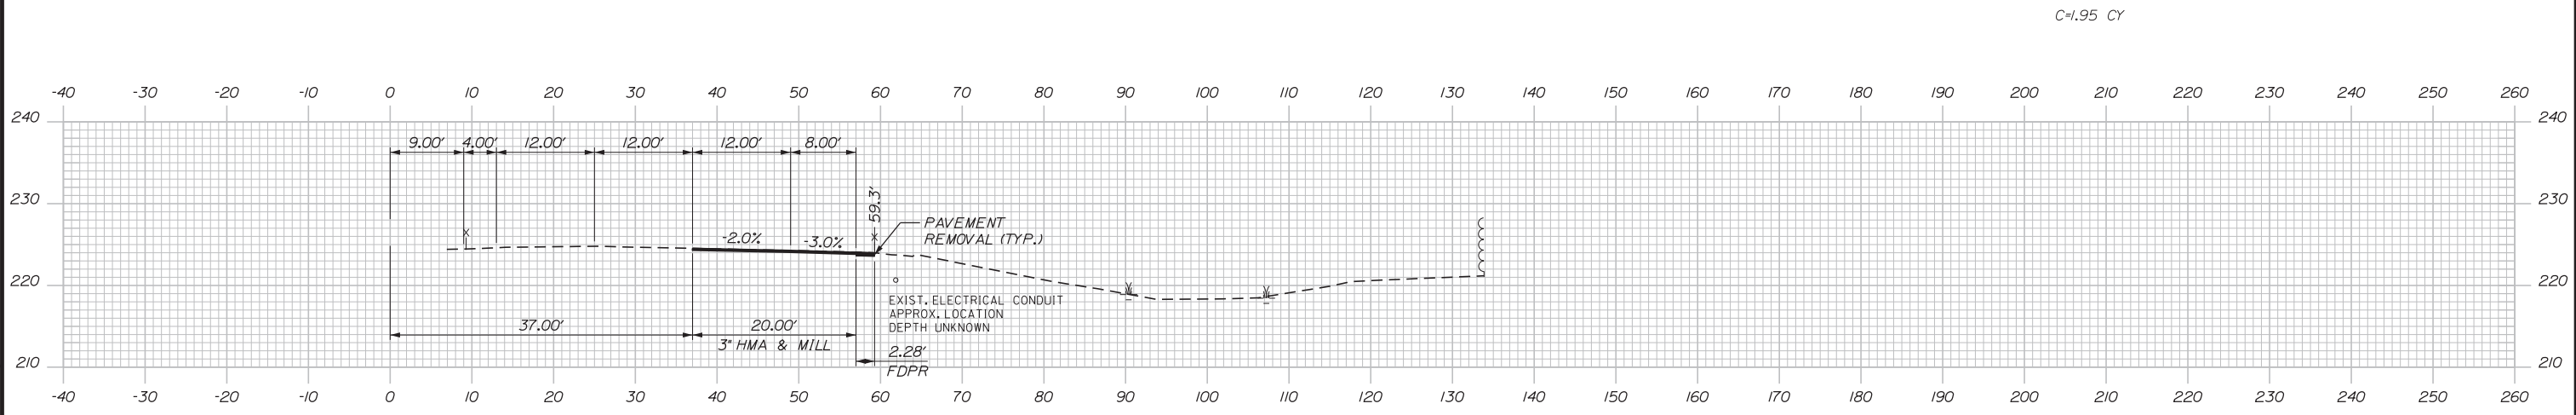

5271+50.00

 

Designed by:


**Stantec**

CONSULTANT PROJECT MANAGER: LAUREN MEEK, PE

No.	Revision	By	Date

	By	Date		By	Date
Designed	PLP	3\20\19	Checked	LEM	3\20\19
Drawn	EJB	3\20\19	In Charge of	GAE	3\20\19

STANTEC CONSULTING SERVICES INC.  
482 PAYNE ROAD  
SCARBOROUGH, ME 04074  
TEL (207) 887-3448  
FAX (207) 883-3376



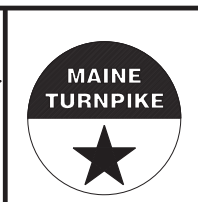


**THE GOLD STAR  
MEMORIAL HIGHWAY**

INTERCHANGE 103  
ORT CONVERSION  
NB ORT  
STA. 5271+50.00 TO STA. 5272+50.00

Filename: ...00.HIGHWAY\MSTA\\_xsect.dgn

 Date: 3/20/2019

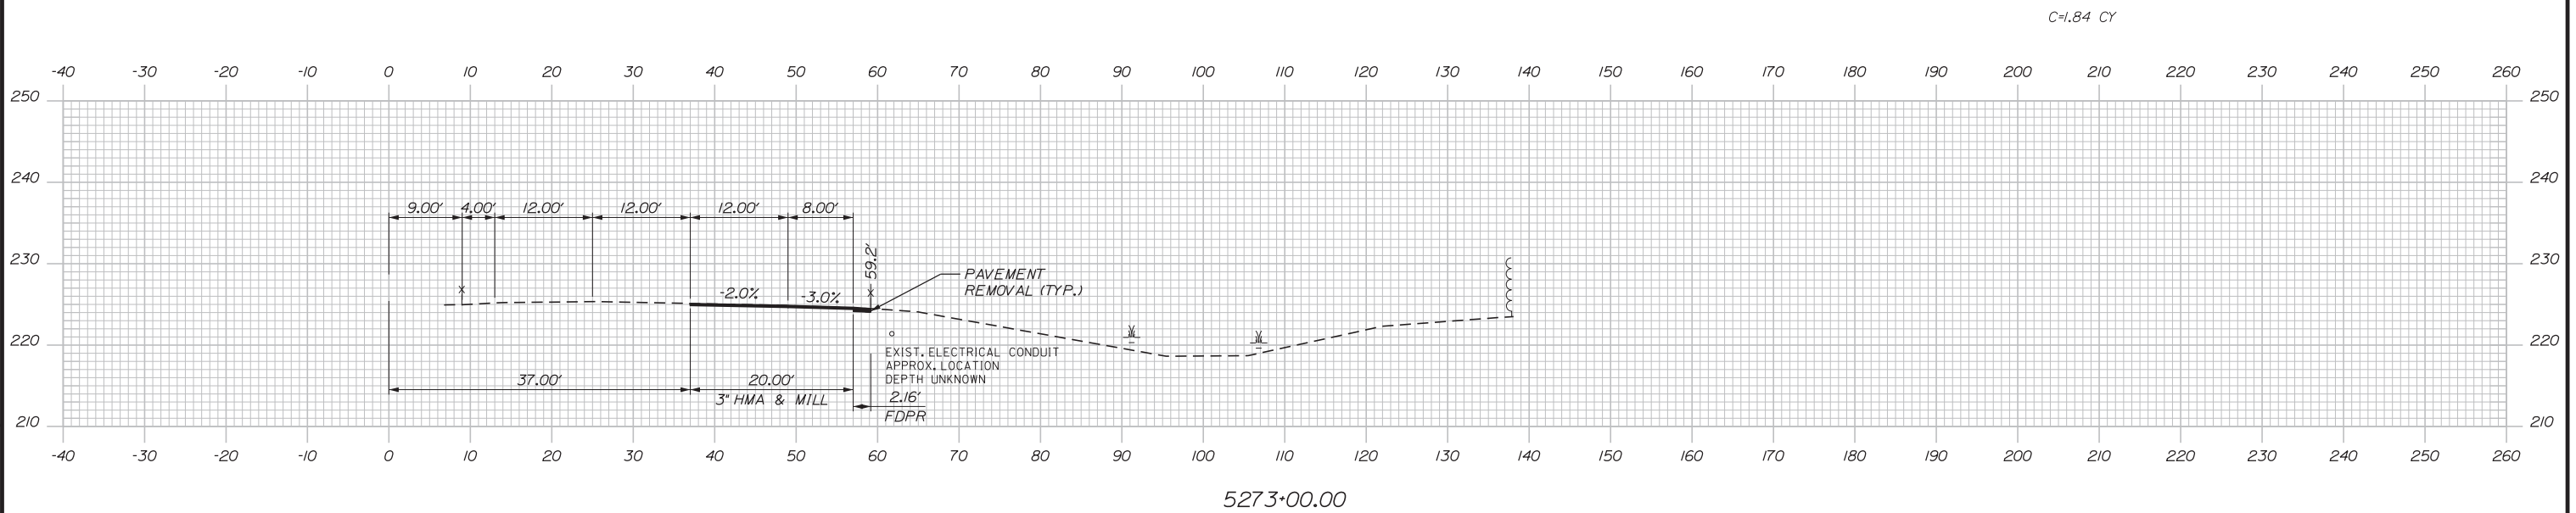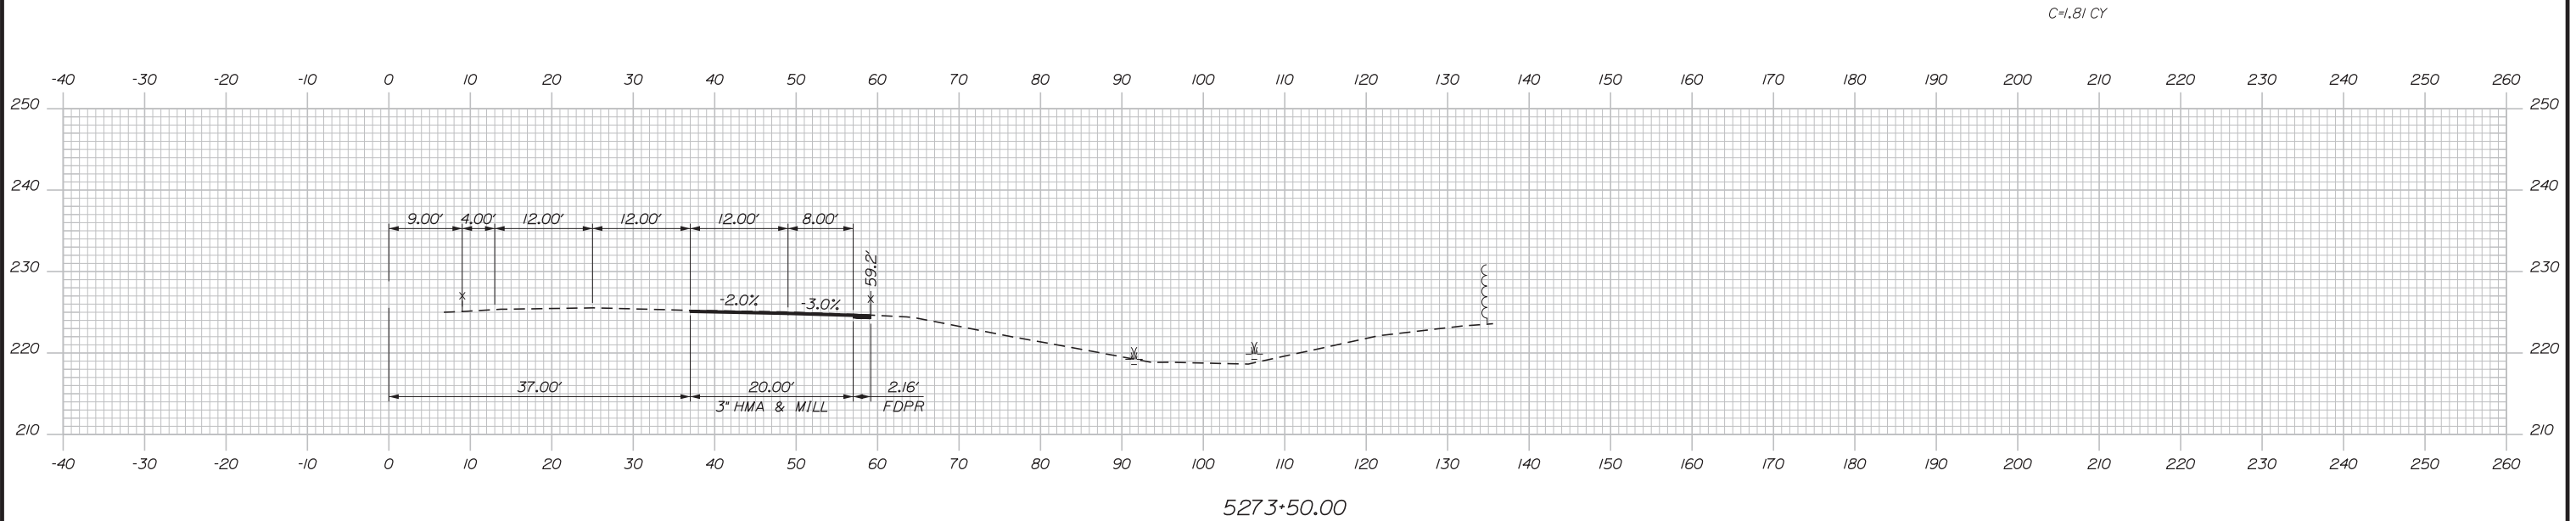

Designed by:

**Stantec**

CONSULTANT PROJECT MANAGER: LAUREN MEEK, PE

No.	Revision	By	Date

	By	Date		By	Date
Designed	PLP	3\20\19	Checked	LEM	3\20\19
Drawn	EJB	3\20\19	In Charge of	GAE	3\20\19

STANTEC CONSULTING SERVICES INC.  
482 PAYNE ROAD  
SCARBOROUGH, ME 04074  
TEL (207) 887-3448  
FAX (207) 883-3376

**MAINE TURNPIKE**

**THE GOLD STAR MEMORIAL HIGHWAY**




MTA PROJECT MANAGER: RALPH NORWOOD, IV, PE, PTOE

INTERCHANGE 103  
ORT CONVERSION  
NB ORT  
STA. 5273+00.00 TO STA. 5273+50.00

SHEET NUMBER: XS-94  
CONTRACT: 2019.04  
328 OF 503

Filename: ...:\00\HIGHWAY\MSTA\\_xsect.dgn

 Date: 3/20/2019

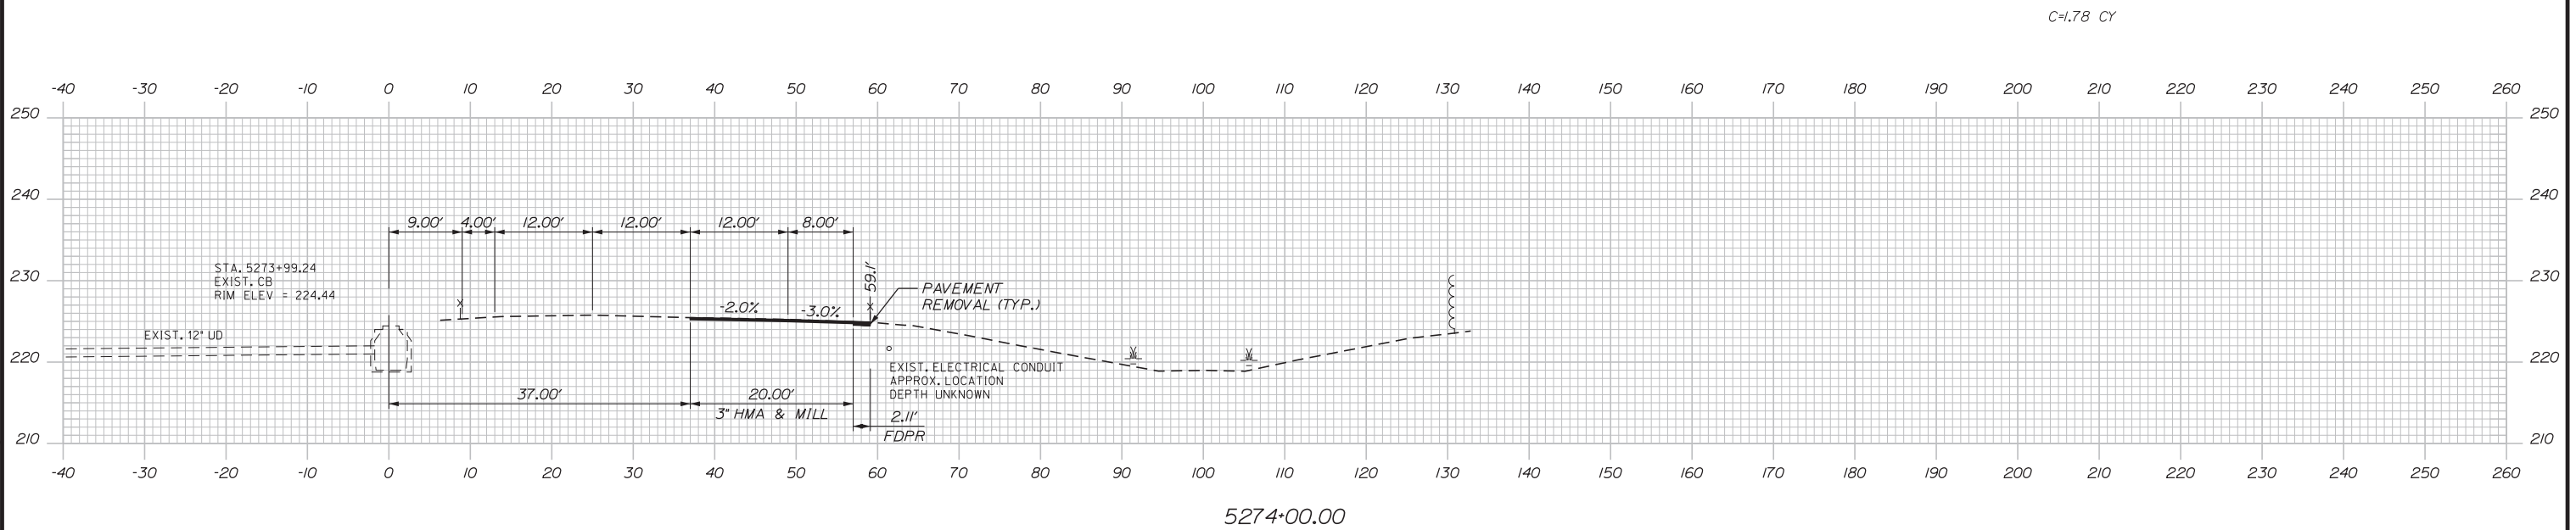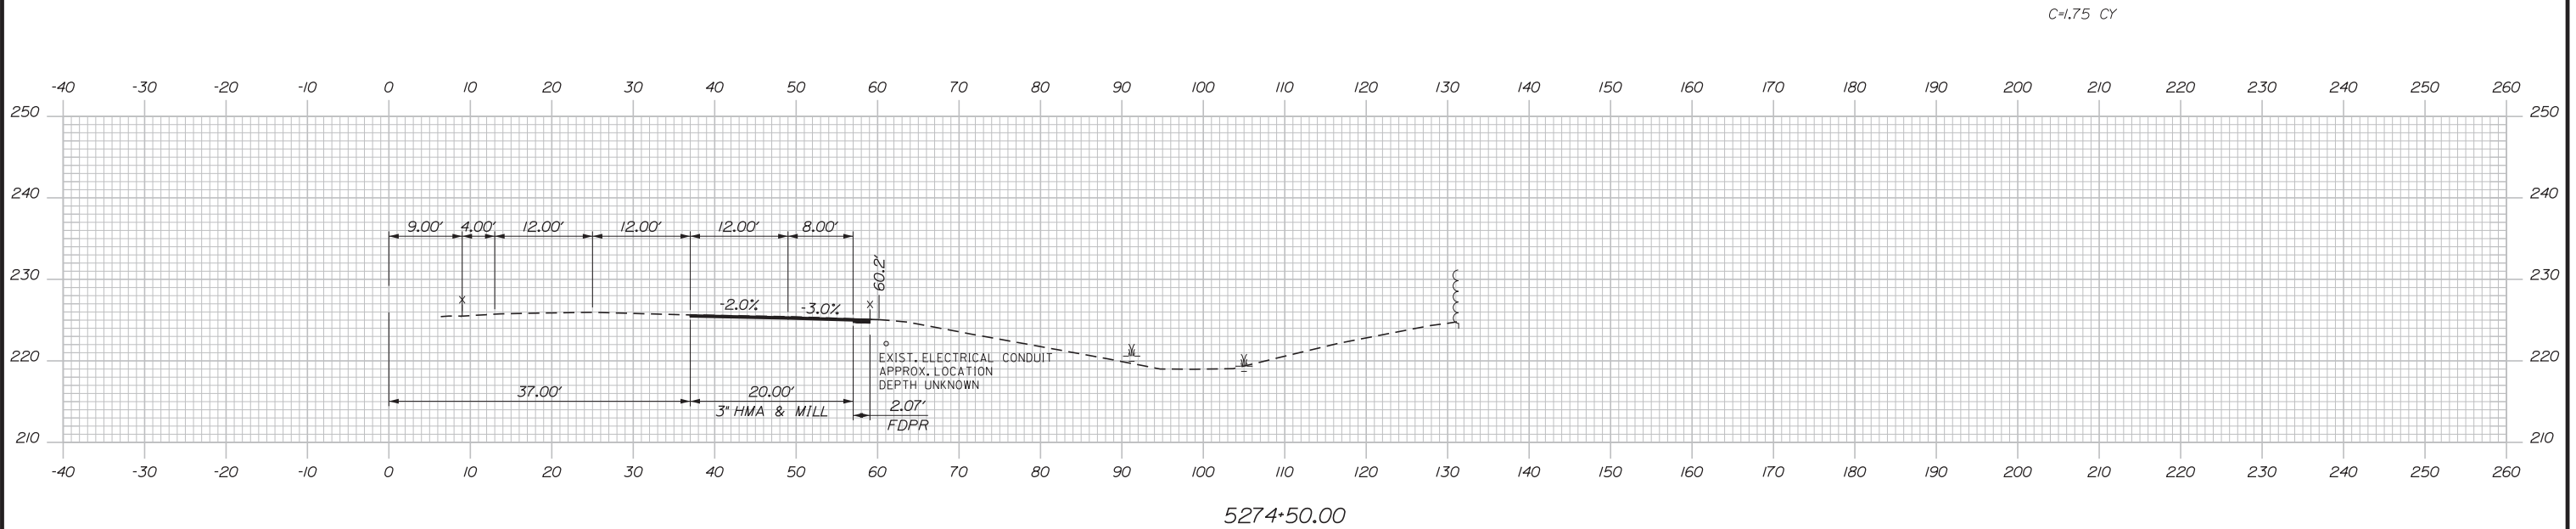

Designed by:

**Stantec**

CONSULTANT PROJECT MANAGER: LAUREN MEEK, PE

No.	Revision	By	Date

	By	Date		By	Date
Designed	PLP	3\20\19	Checked	LEM	3\20\19
Drawn	EJB	3\20\19	In Charge of	GAE	3\20\19

STANTEC CONSULTING SERVICES INC.  
482 PAYNE ROAD  
SCARBOROUGH, ME 04074  
TEL (207) 887-3448  
FAX (207) 883-3376

**MAINE TURNPIKE**

**THE GOLD STAR MEMORIAL HIGHWAY**

MTA PROJECT MANAGER: RALPH NORWOOD, IV, PE, PTOE




INTERCHANGE 103  
ORT CONVERSION  
NB ORT  
STA. 5274+00.00 TO STA. 5274+50.00

SHEET NUMBER: XS-95  
CONTRACT: 2019.04  
329 OF 503

Filename: ...00\HIGHWAY\STA\\_xsect.dgn



 Date: 3/20/2019

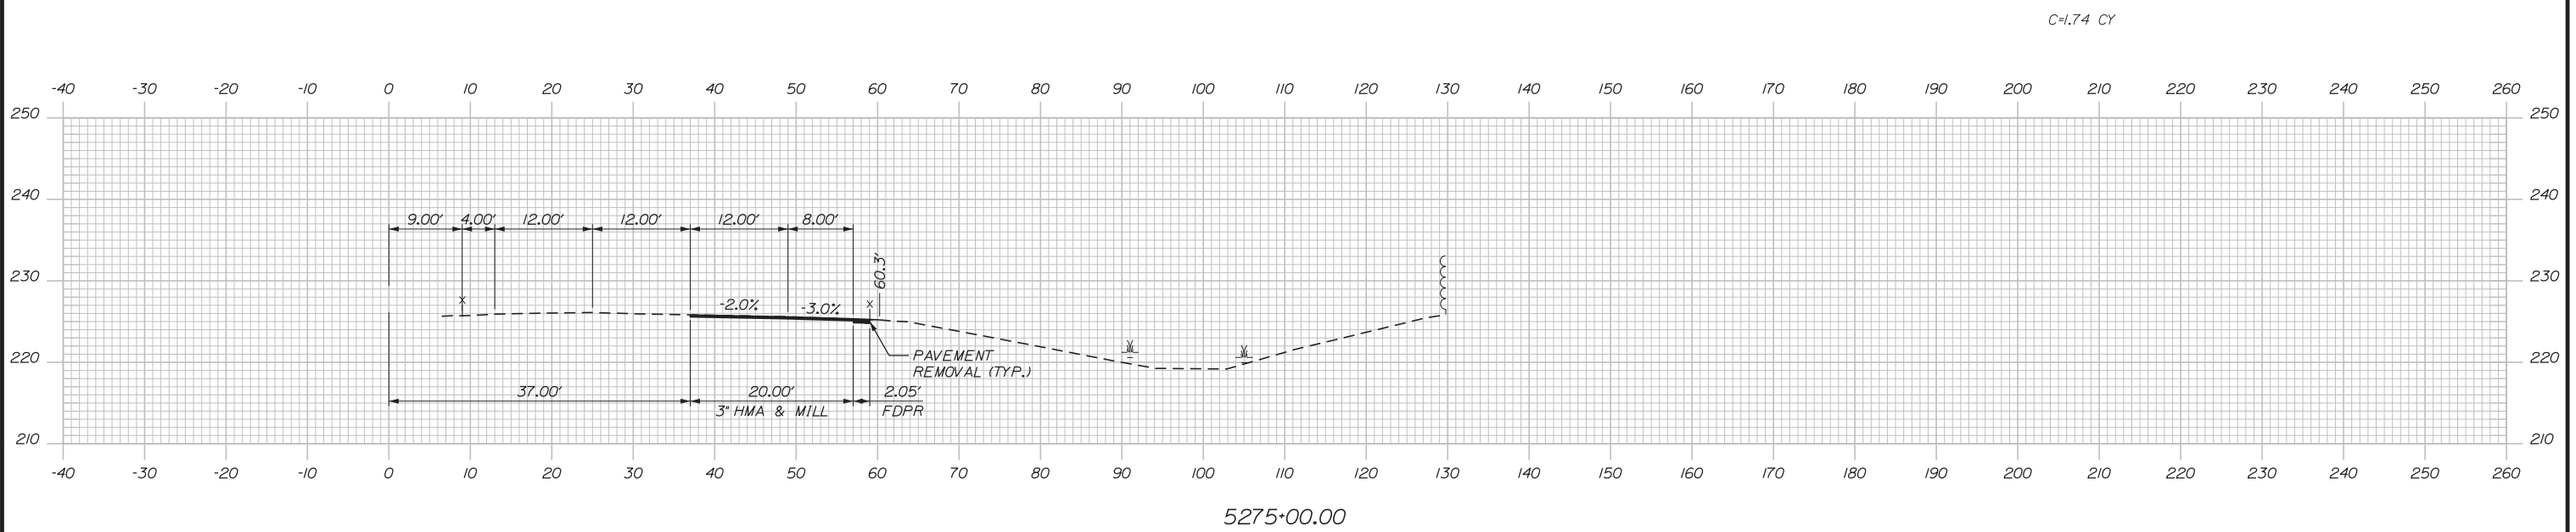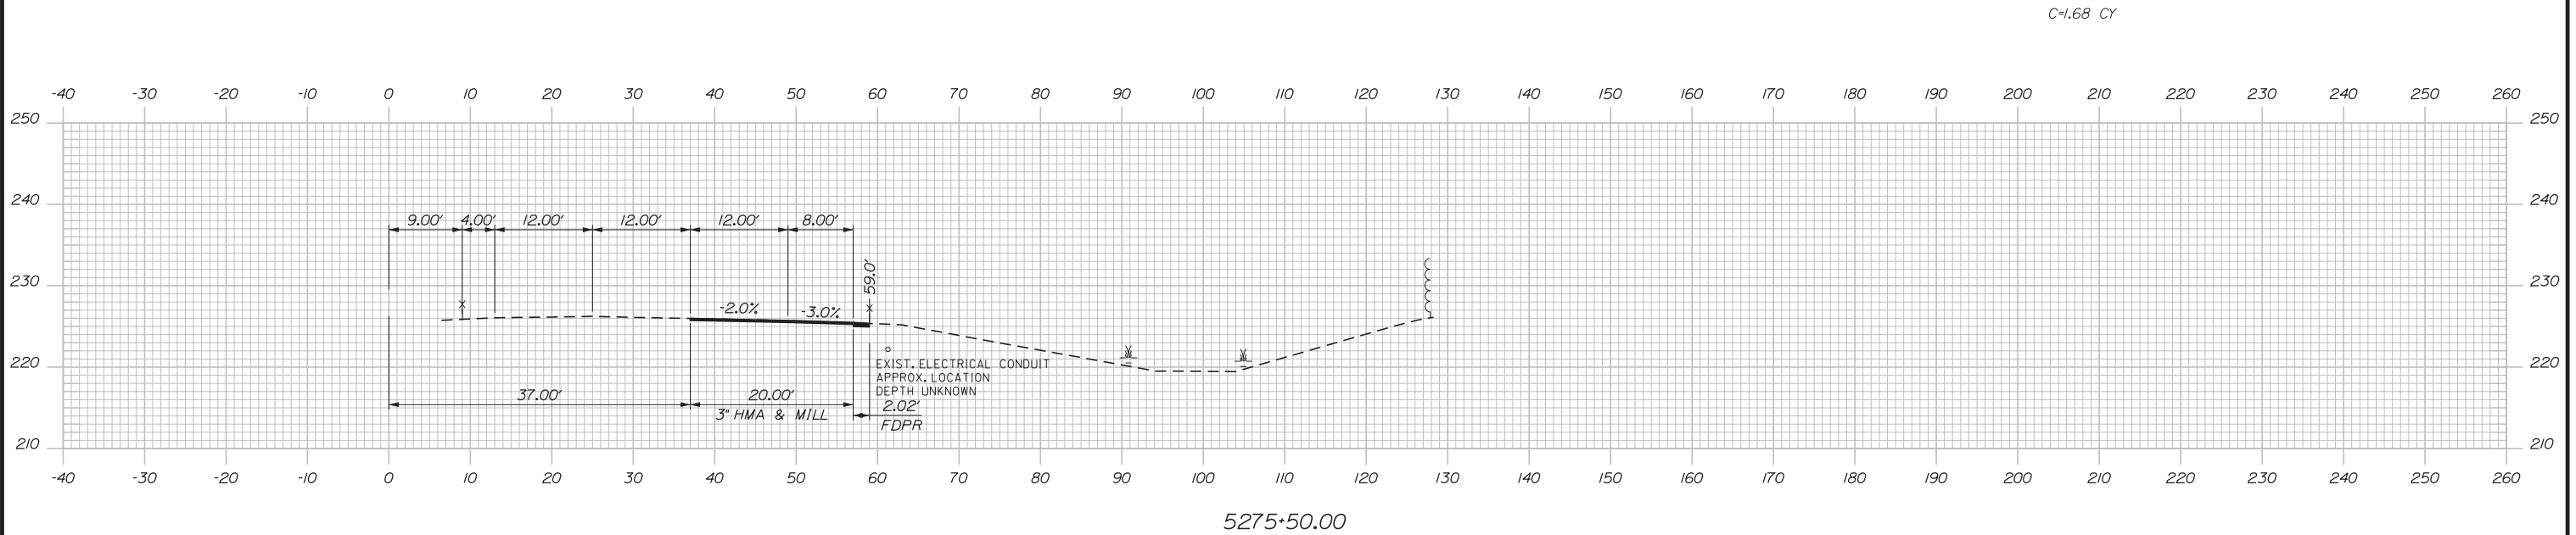

Designed by:

**Stantec**

CONSULTANT PROJECT MANAGER: LAUREN MEEK, PE

No.	Revision	By	Date

	By	Date		By	Date
Designed	PLP	3\20\19	Checked	LEM	3\20\19
Drawn	EJB	3\20\19	In Charge of	GAE	3\20\19

STANTEC CONSULTING SERVICES INC.  
482 PAYNE ROAD  
SCARBOROUGH, ME 04074  
TEL (207) 887-3448  
FAX (207) 883-3376

**MAINE TURNPIKE**

**THE GOLD STAR MEMORIAL HIGHWAY**




MTA PROJECT MANAGER: RALPH NORWOOD, IV, PE, PTOE

INTERCHANGE 103  
ORT CONVERSION  
NB ORT  
STA. 5275+00.00 TO STA. 5275+50.00

SHEET NUMBER: XS-96  
CONTRACT: 2019.04  
330 OF 503

Filename: ...:\00\HIGHWAY\MSTA\\_xsect.dgn

 Date: 3/20/2019

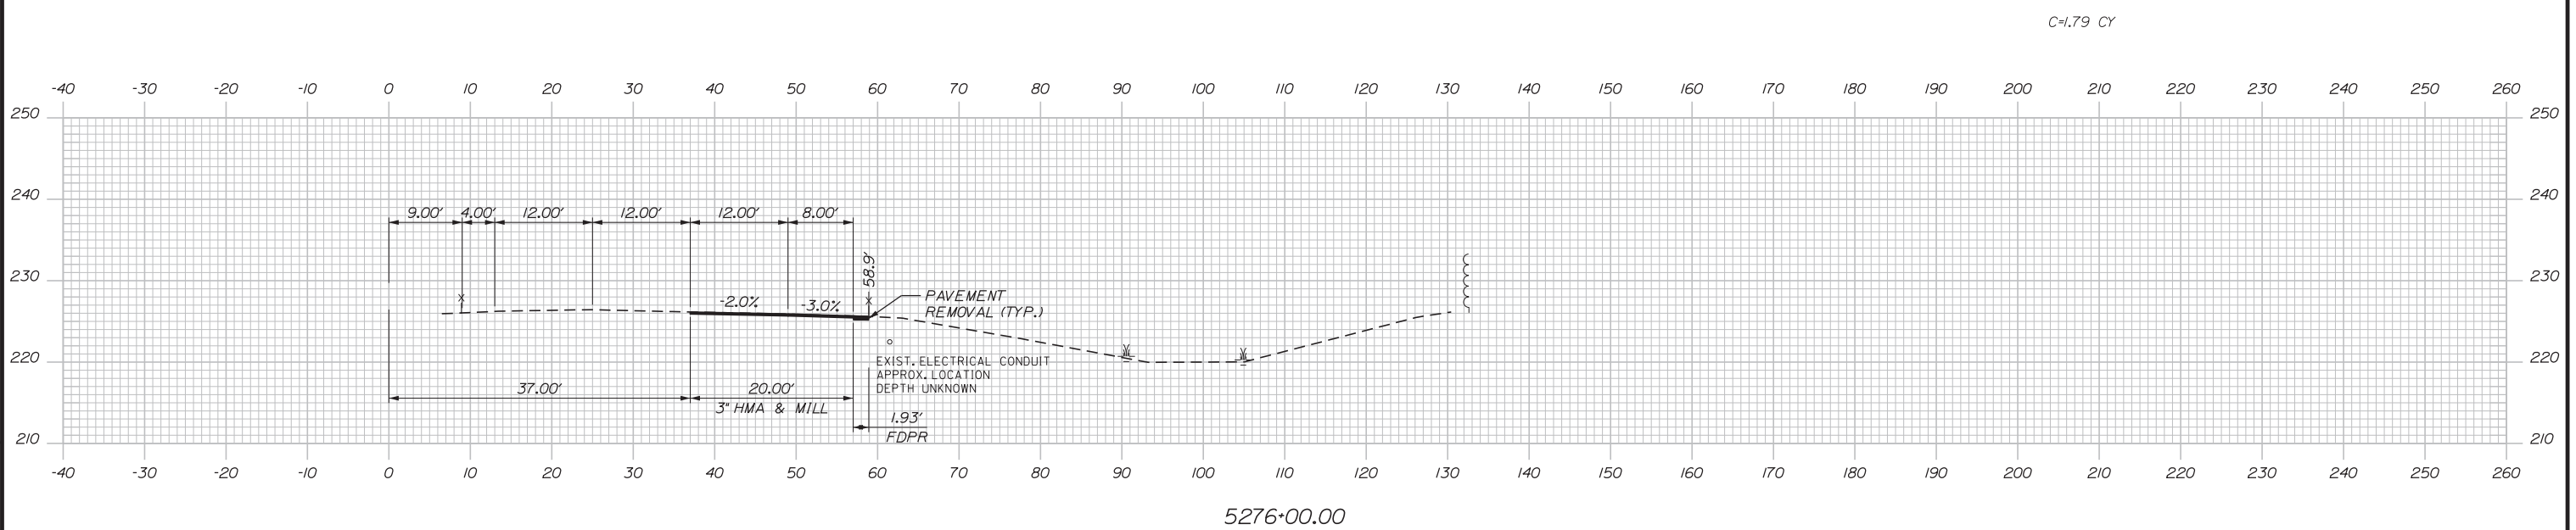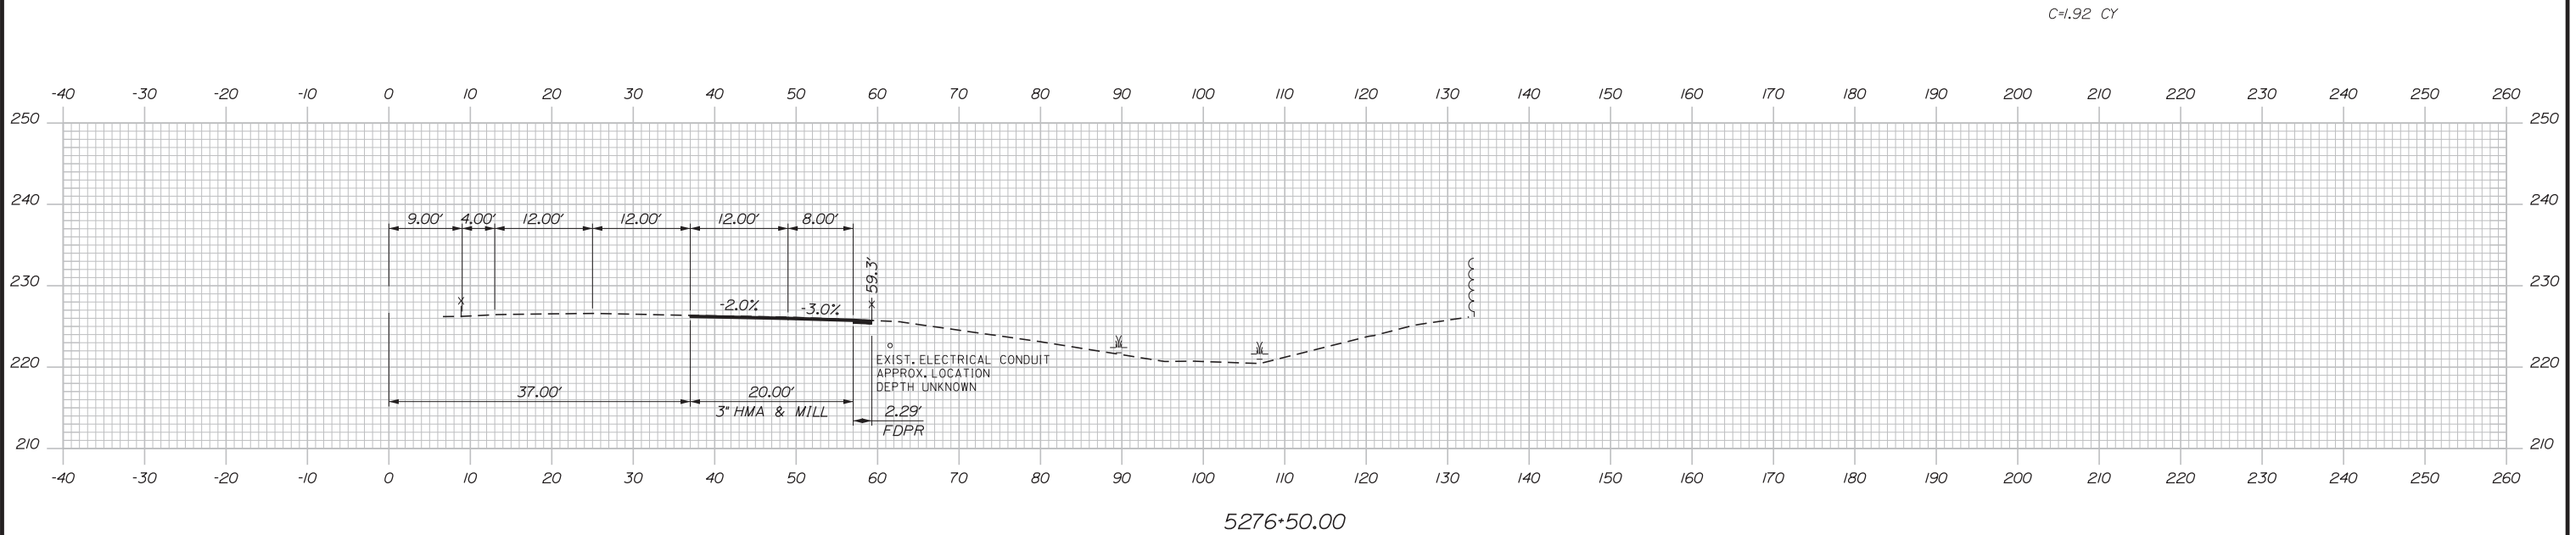

Designed by:

**Stantec**

CONSULTANT PROJECT MANAGER: LAUREN MEEK, PE

No.	Revision	By	Date

	By	Date		By	Date
Designed	PLP	3\20\19	Checked	LEM	3\20\19
Drawn	EJB	3\20\19	In Charge of	GAE	3\20\19

STANTEC CONSULTING SERVICES INC.  
482 PAYNE ROAD  
SCARBOROUGH, ME 04074  
TEL (207) 887-3448  
FAX (207) 883-3376

**MAINE TURNPIKE**

**THE GOLD STAR MEMORIAL HIGHWAY**



MTA PROJECT MANAGER: RALPH NORWOOD, IV, PE, PTOE

INTERCHANGE 103  
ORT CONVERSION  
NB ORT  
STA. 5276+00.00 TO STA. 5276+50.00

SHEET NUMBER: XS-97  
CONTRACT: 2019.04  
331 OF 503

Filename: ...\\00\HIGHWAY\MSTA\\_xsect.dgn

Date: 3/20/2019

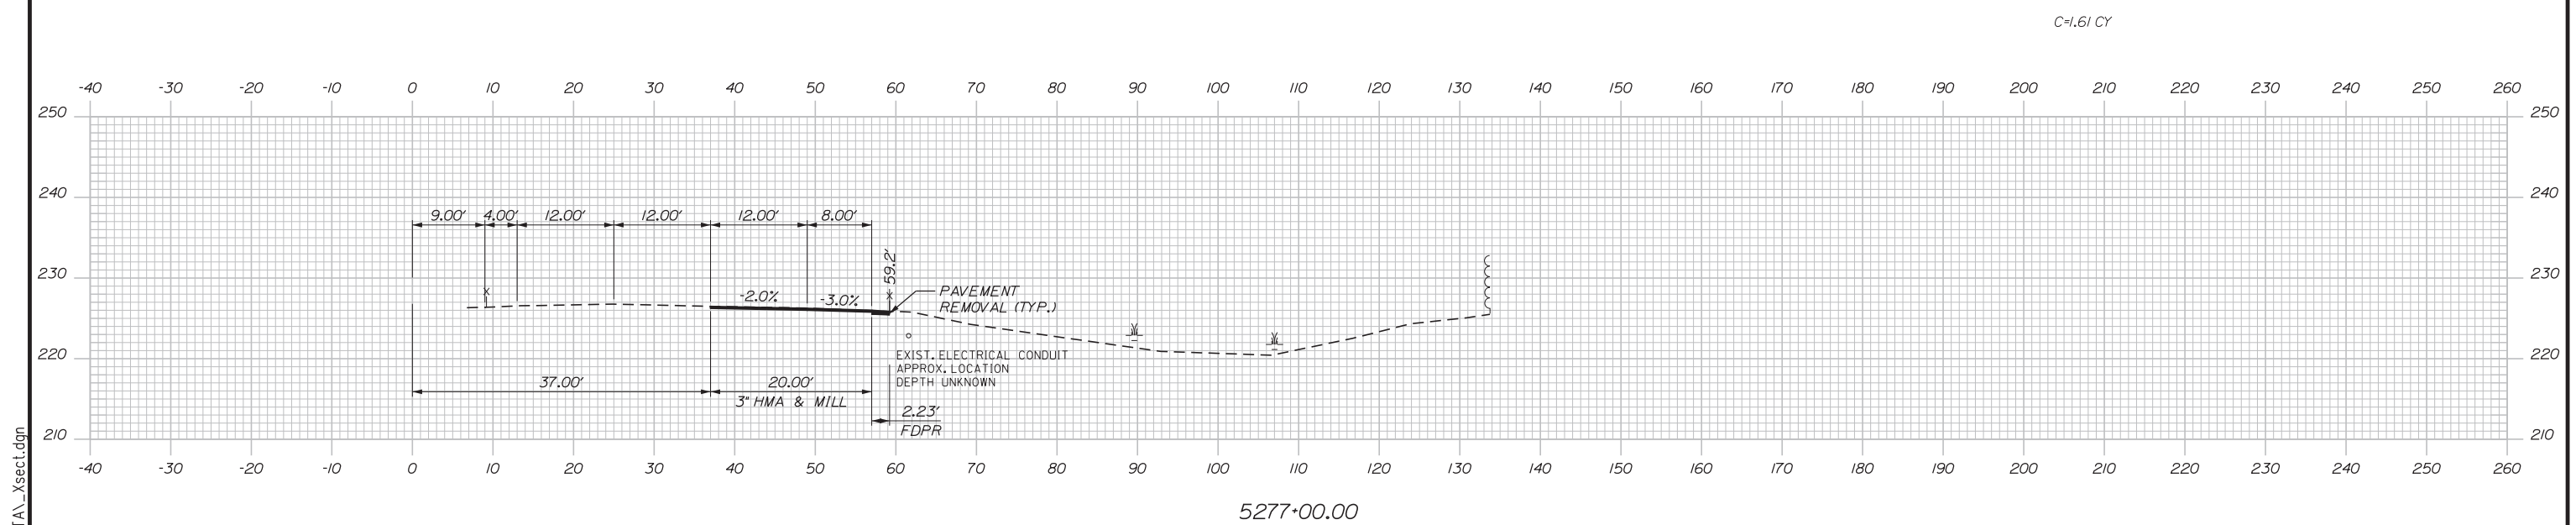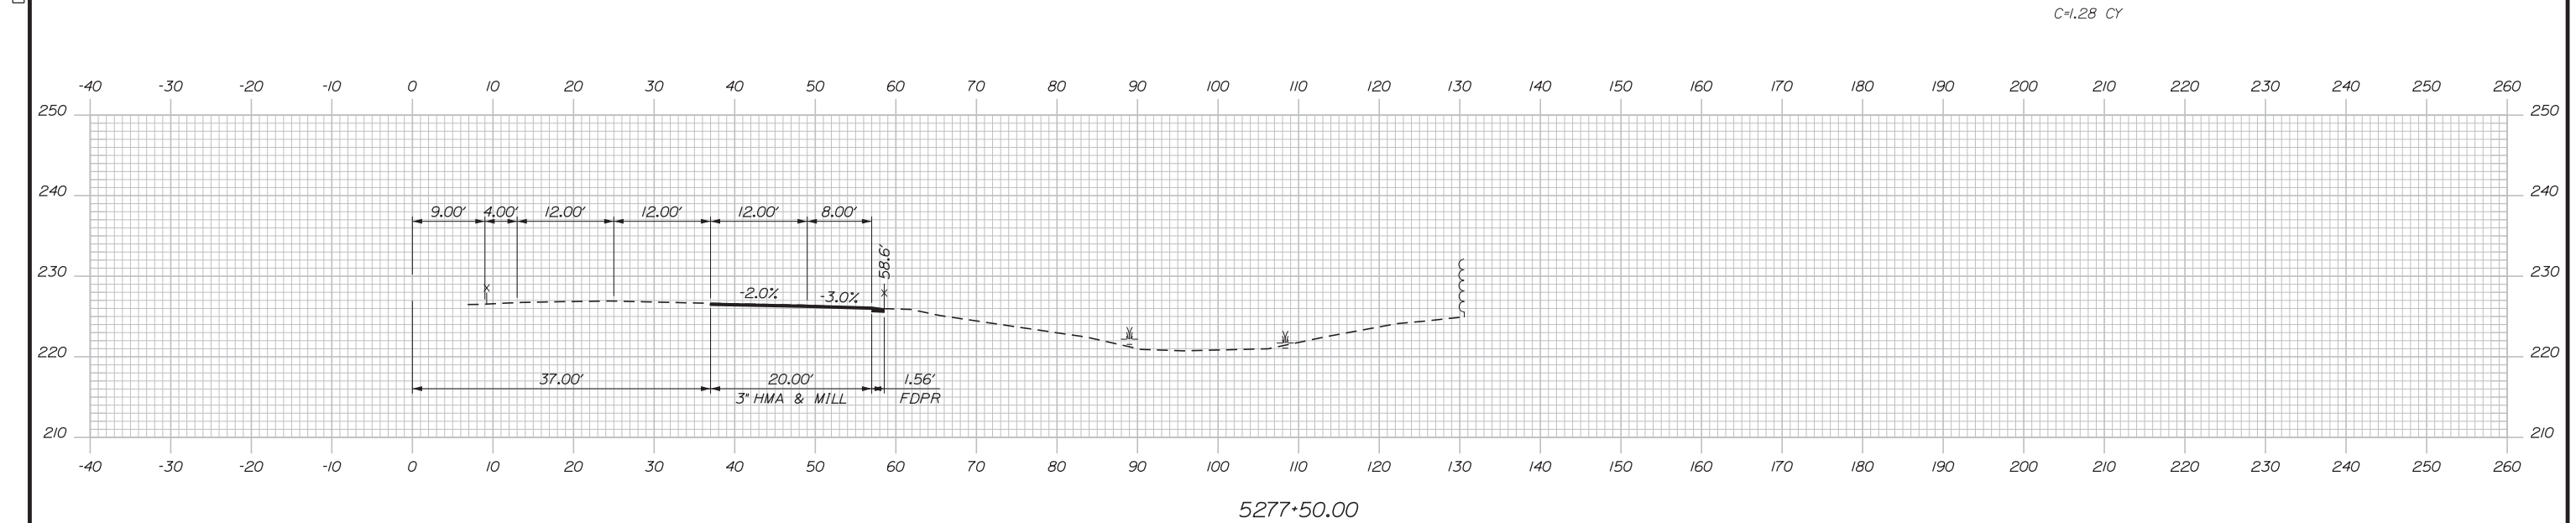

Scale: Scale of Feet


No.	Revision	By	Date

Designed by:

CONSULTANT PROJECT MANAGER: LAUREN MEEK, PE

	By	Date		By	Date
Designed	PLP	3\20\19	Checked	LEM	3\20\19
Drawn	EJB	3\20\19	In Charge of	GAE	3\20\19

STANTEC CONSULTING SERVICES INC.  
 482 PAYNE ROAD  
 SCARBOROUGH, ME 04074  
 TEL (207) 887-3448  
 FAX (207) 883-3376






**THE GOLD STAR  
 MEMORIAL HIGHWAY**

MTA PROJECT MANAGER: RALPH NORWOOD, IV, PE, PTOE

INTERCHANGE 103  
 ORT CONVERSION  
 NB ORT  
 STA. 5277+00.00 TO STA. 5277+50.00

SHEET NUMBER: XS-98  
 CONTRACT: 2019.04  
 332 OF 503

 Date: 3/20/2019

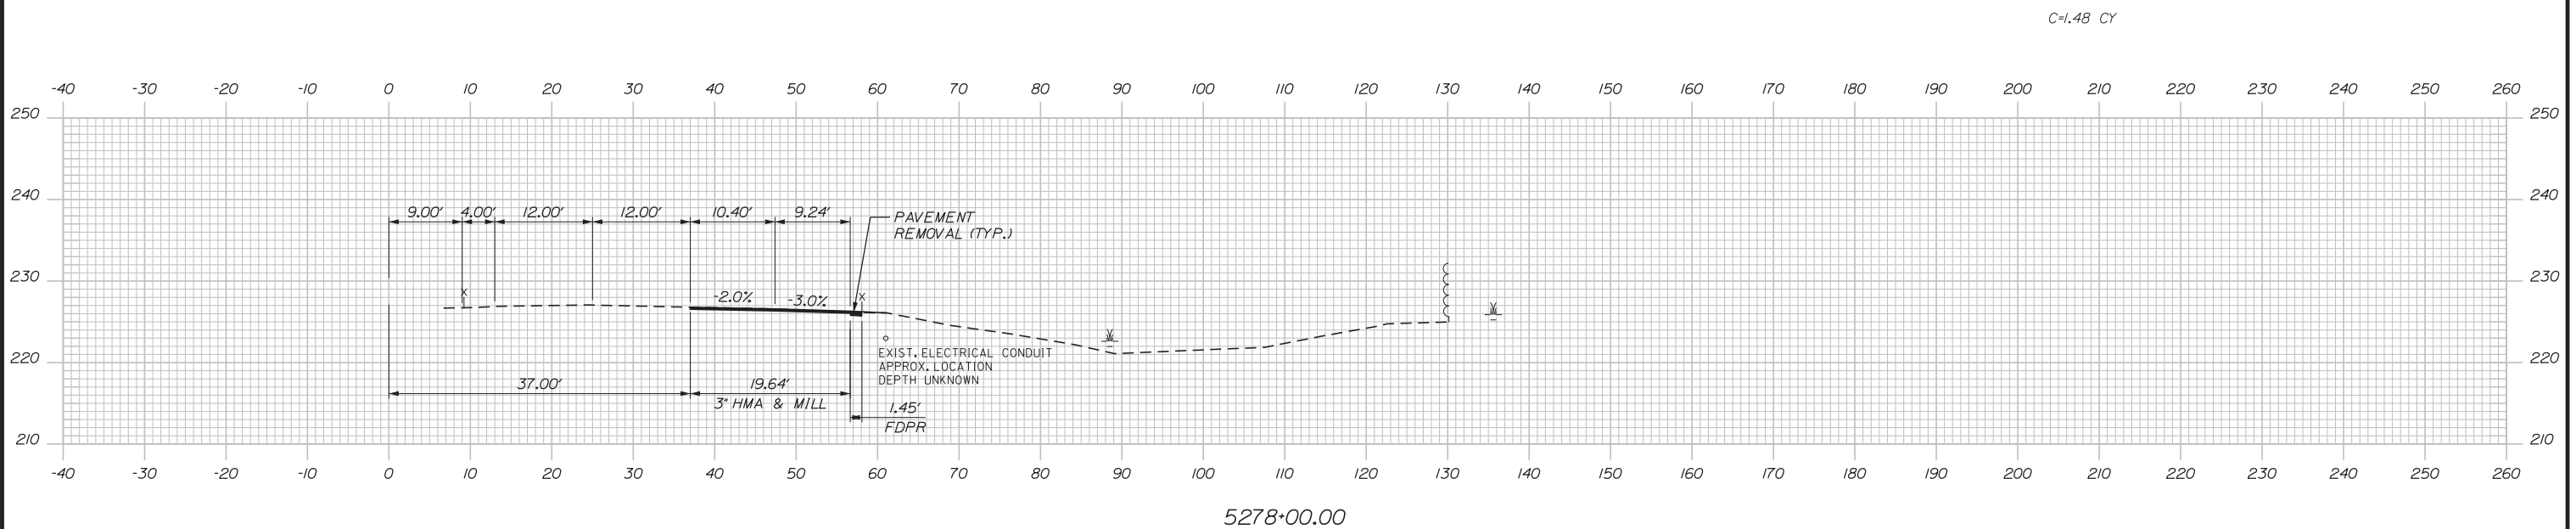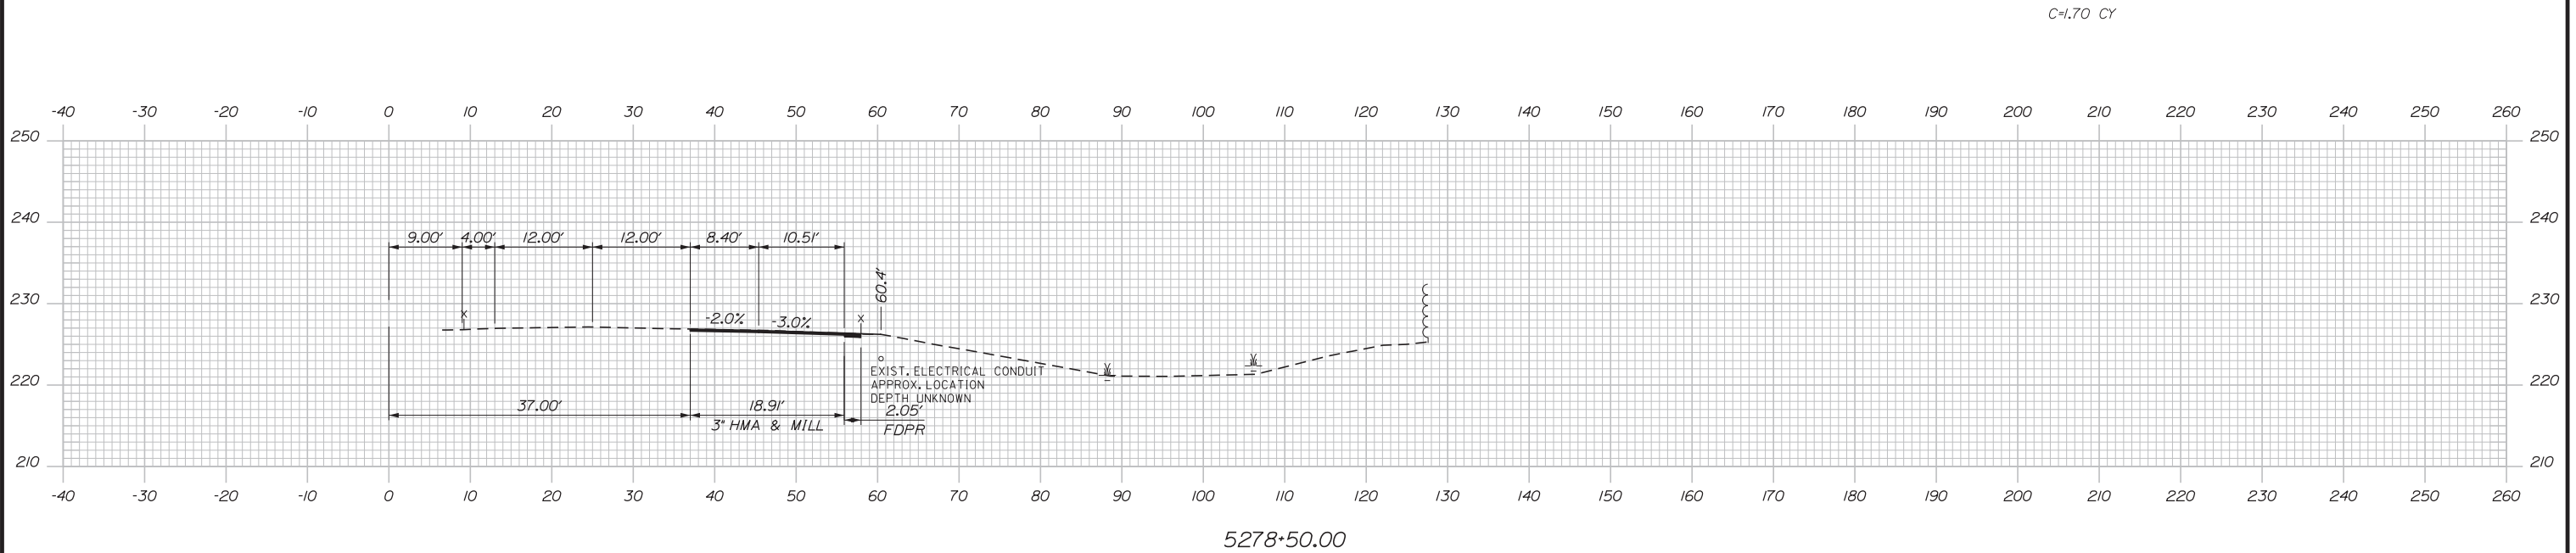

Designed by:

**Stantec**

CONSULTANT PROJECT MANAGER: LAUREN MEEK, PE

No.	Revision	By	Date

	By	Date		By	Date
Designed	PLP	3\20\19	Checked	LEM	3\20\19
Drawn	EJB	3\20\19	In Charge of	GAE	3\20\19

STANTEC CONSULTING SERVICES INC.  
 482 PAYNE ROAD  
 SCARBOROUGH, ME 04074  
 TEL (207) 887-3448  
 FAX (207) 883-3376

**THE GOLD STAR  
 MEMORIAL HIGHWAY**

MTA PROJECT MANAGER: RALPH NORWOOD, IV, PE, PTOE




INTERCHANGE 103  
 ORT CONVERSION  
 NB ORT  
 STA. 5278+00.00 TO STA. 5278+50.00

SHEET NUMBER: XS-99  
 333 OF 503

CONTRACT: 2019.04

Filename: ...00\HIGHWAY\MSTA\\_xsect.dgn

 Date: 3/20/2019

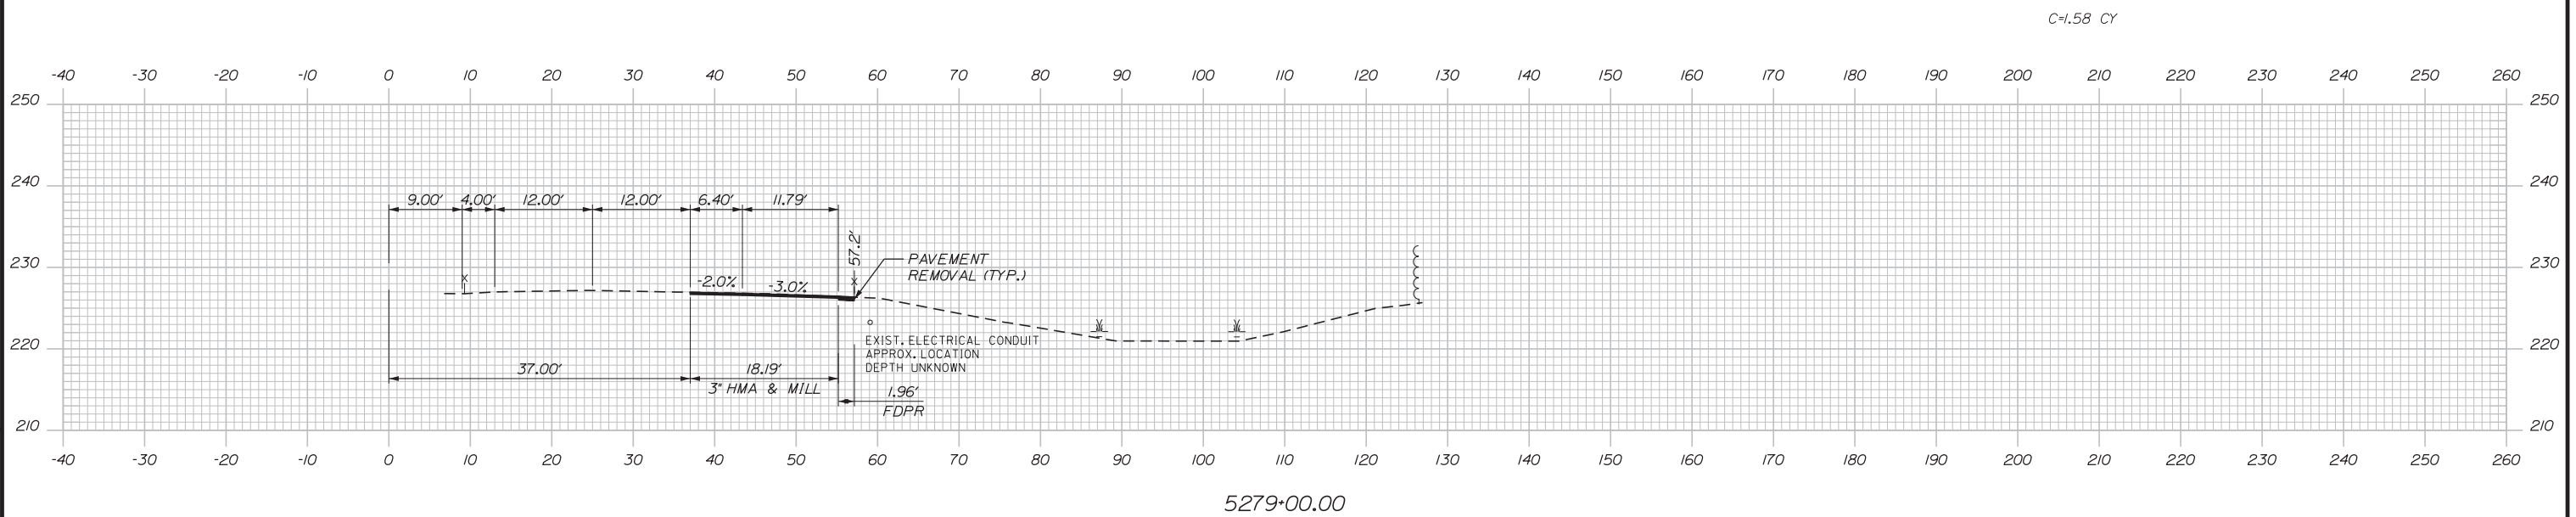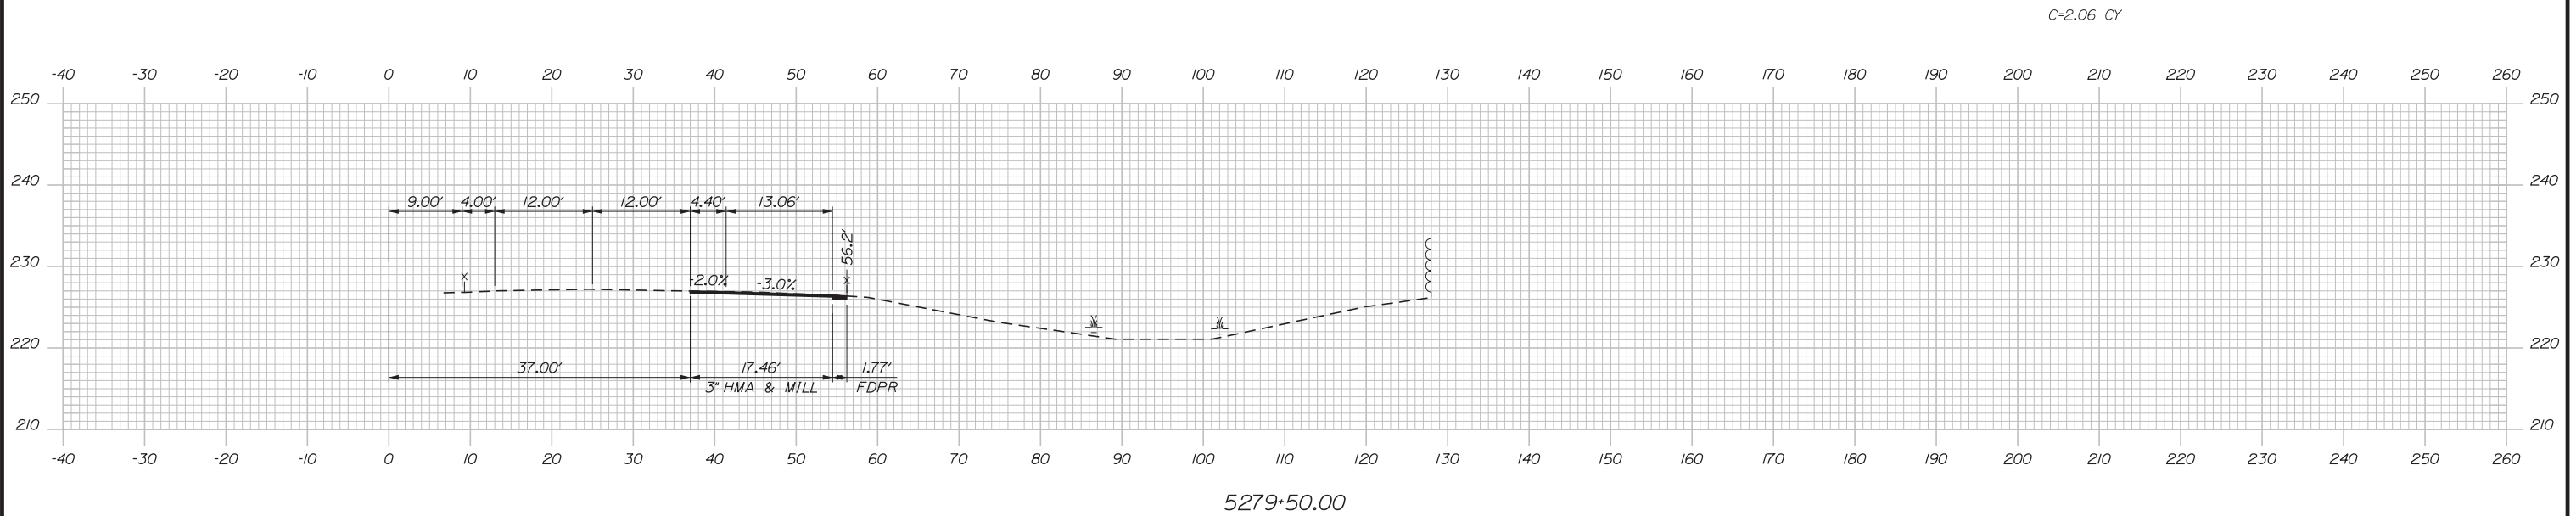

Designed by:

**Stantec**

CONSULTANT PROJECT MANAGER: LAUREN MEEK, PE

No.	Revision	By	Date

	By	Date		By	Date
Designed	PLP	3\20\19	Checked	LEM	3\20\19
Drawn	EJB	3\20\19	In Charge of	GAE	3\20\19

STANTEC CONSULTING SERVICES INC.  
482 PAYNE ROAD  
SCARBOROUGH, ME 04074  
TEL (207) 887-3448  
FAX (207) 883-3376

**MAINE TURNPIKE**

**THE GOLD STAR MEMORIAL HIGHWAY**

MTA PROJECT MANAGER: RALPH NORWOOD, IV, PE, PTOE

INTERCHANGE 103  
ORT CONVERSION  
NB ORT  
STA. 5279+00.00 TO STA. 5279+50.00


SHEET NUMBER: XS-100  
334 OF 503

CONTRACT: 2019.04


Filename: ...00\HIGHWAY\MSTA\\_xsect.dgn




Date: 3/20/2019

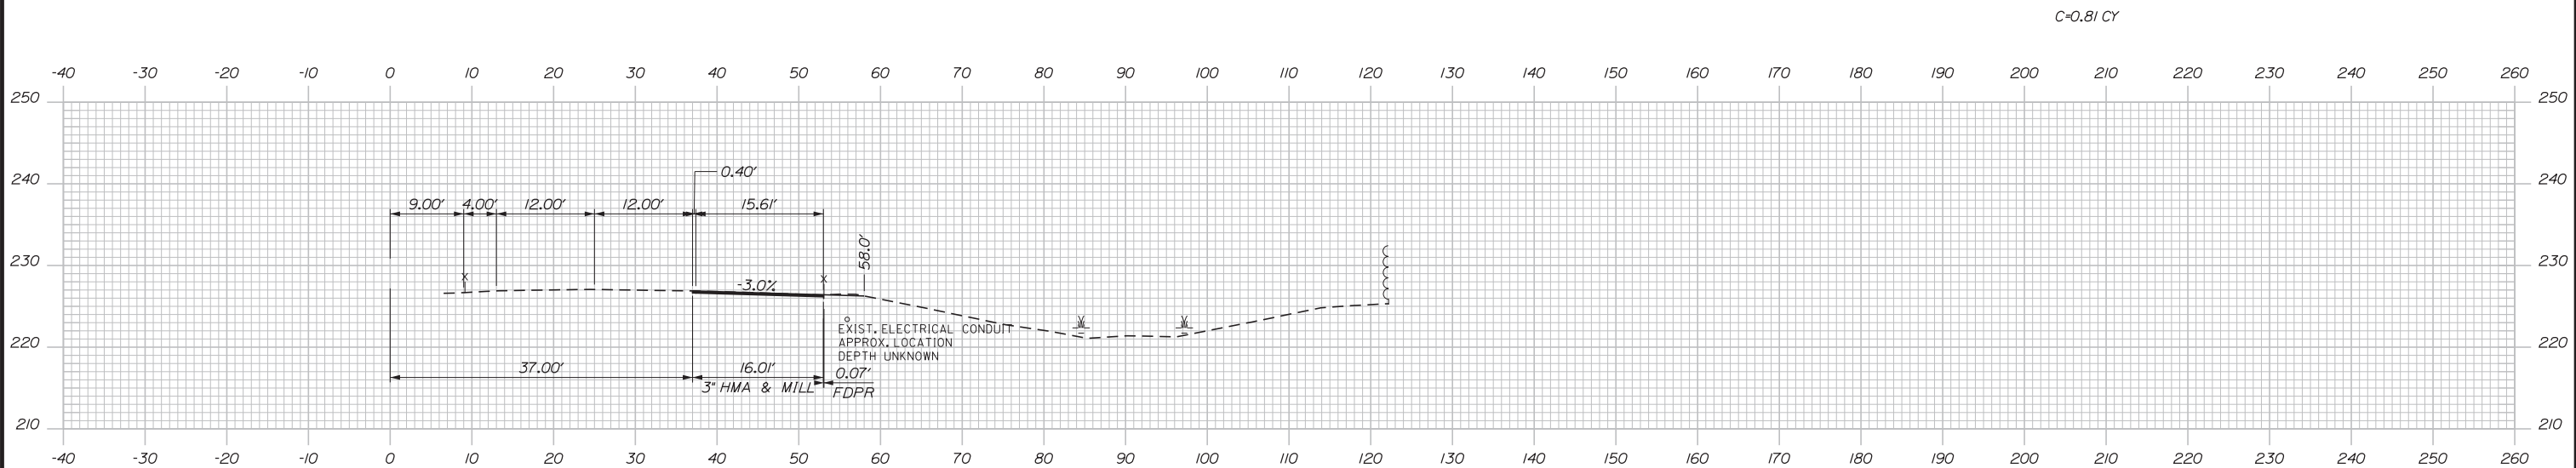

5280+50.00

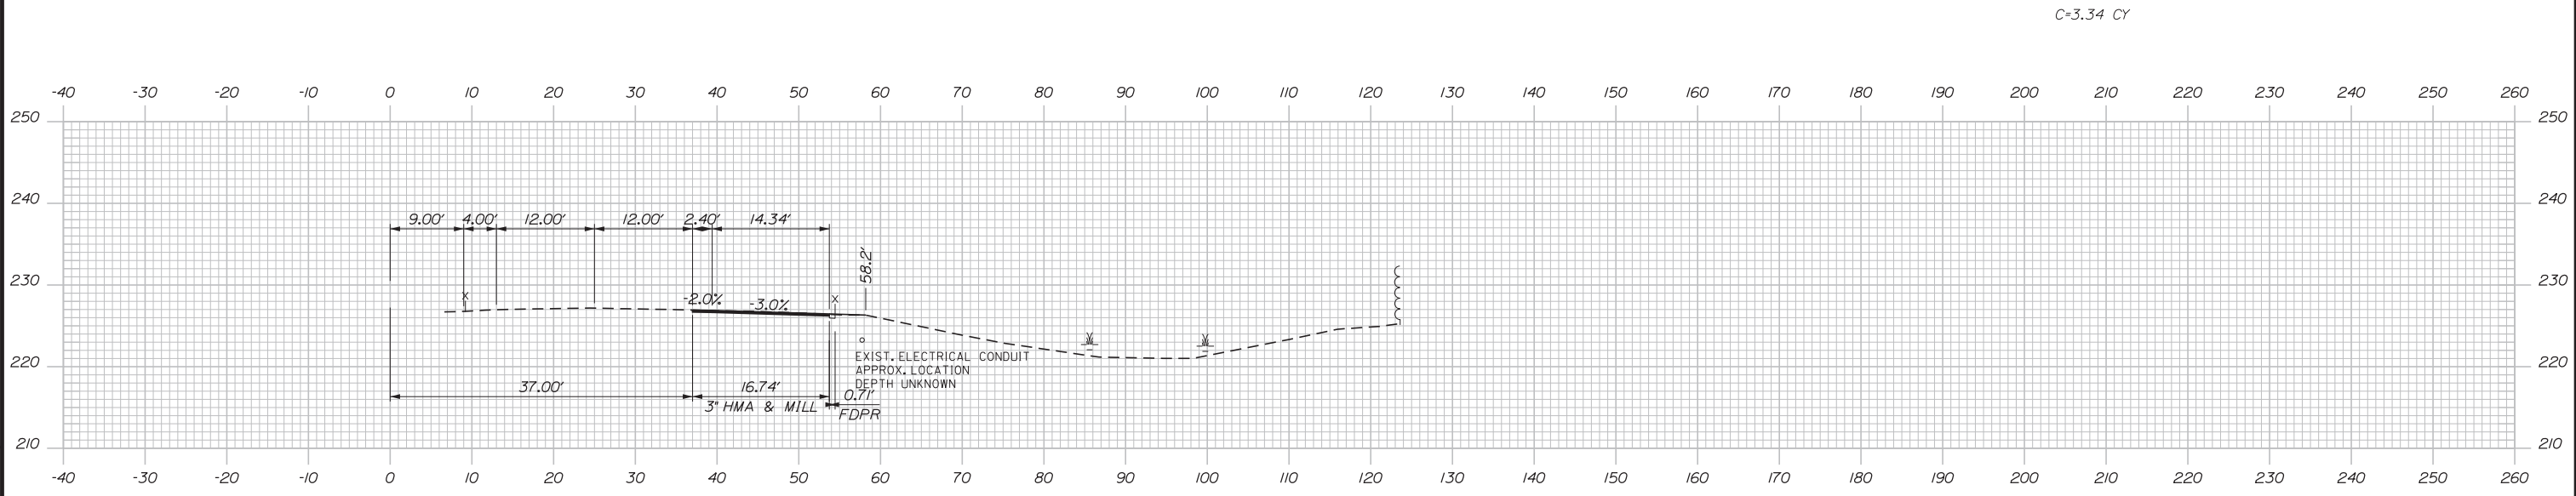

5280+00.00

 

Designed by:


**Stantec**

CONSULTANT PROJECT MANAGER: LAUREN MEEK, PE

No.	Revision	By	Date

	By	Date		By	Date
Designed	PLP	3\20\19	Checked	LEM	3\20\19
Drawn	EJB	3\20\19	In Charge of	GAE	3\20\19

STANTEC CONSULTING SERVICES INC.  
 482 PAYNE ROAD  
 SCARBOROUGH, ME 04074  
 TEL (207) 887-3448  
 FAX (207) 883-3376

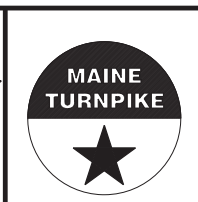



**THE GOLD STAR  
 MEMORIAL HIGHWAY**

INTERCHANGE 103  
 ORT CONVERSION  
 NB ORT  
 STA. 5280+00.00 TO STA. 5280+50.00

Filename: ...:\00\HIGHWAY\MSTA\\_xsect.dgn

Date: 3/20/2019

 Filename: ... \00\HIGHWAY\MSTA\\_xsect.dgn

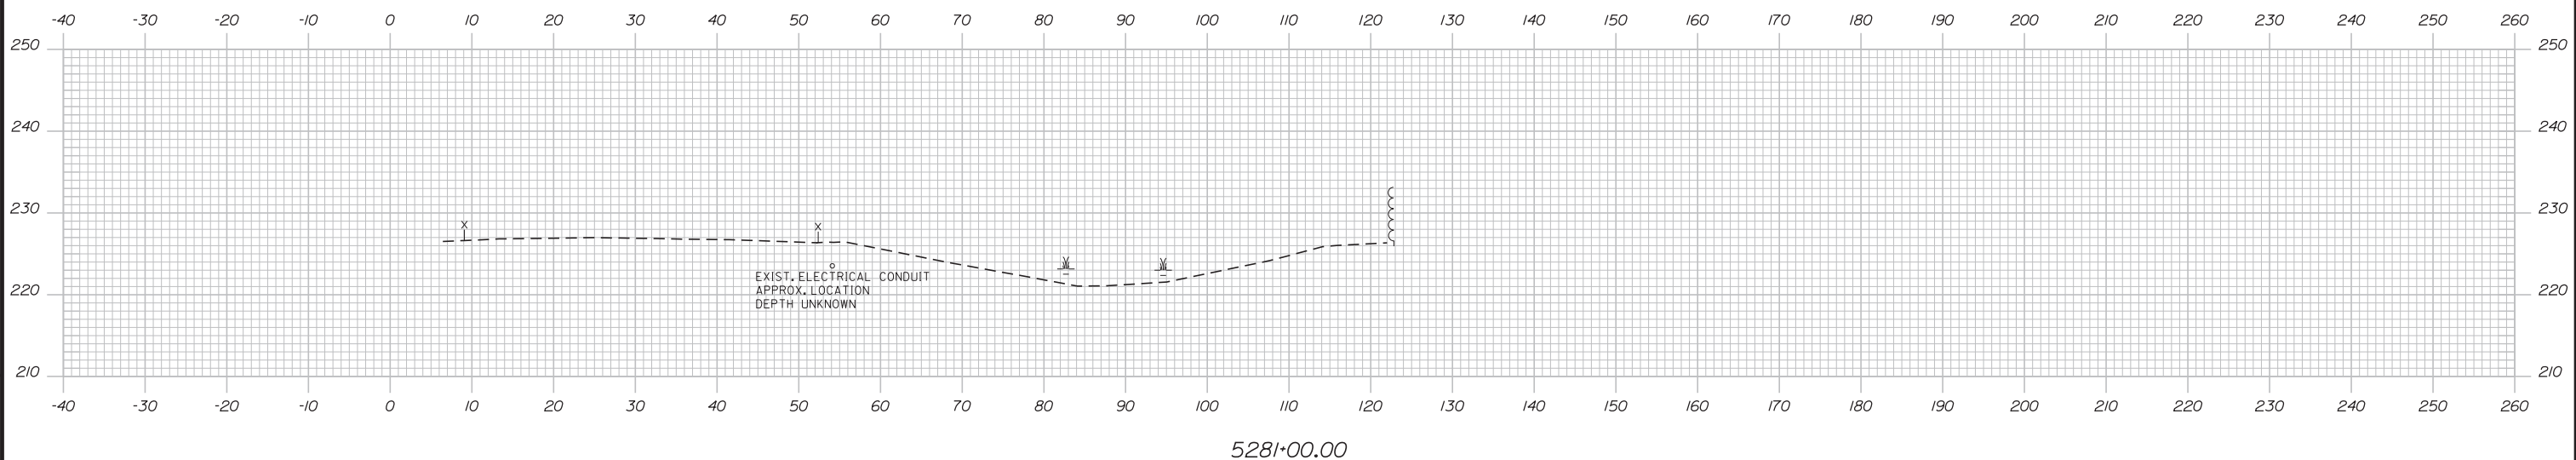

Designed by:

**Stantec**

CONSULTANT PROJECT MANAGER: LAUREN MEEK, PE

No.	Revision	By	Date

	By	Date		By	Date
Designed	PLP	3\20\19	Checked	LEM	3\20\19
Drawn	EJB	3\20\19	In Charge of	GAE	3\20\19

STANTEC CONSULTING SERVICES INC.  
 482 PAYNE ROAD  
 SCARBOROUGH, ME 04074  
 TEL (207) 887-3448  
 FAX (207) 883-3376

**THE GOLD STAR  
 MEMORIAL HIGHWAY**

MTA PROJECT MANAGER: RALPH NORWOOD, IV, PE, PTOE




INTERCHANGE 103  
 ORT CONVERSION  
 NB ORT  
 STA. 5281+00.00 TO STA. 5281+00.00

SHEET NUMBER: XS-102  
 336 OF 503

CONTRACT: 2019.04

Date: 3/20/2019

 Filename: ...00\HIGHWAY\MSTA\\_xsect.dgn

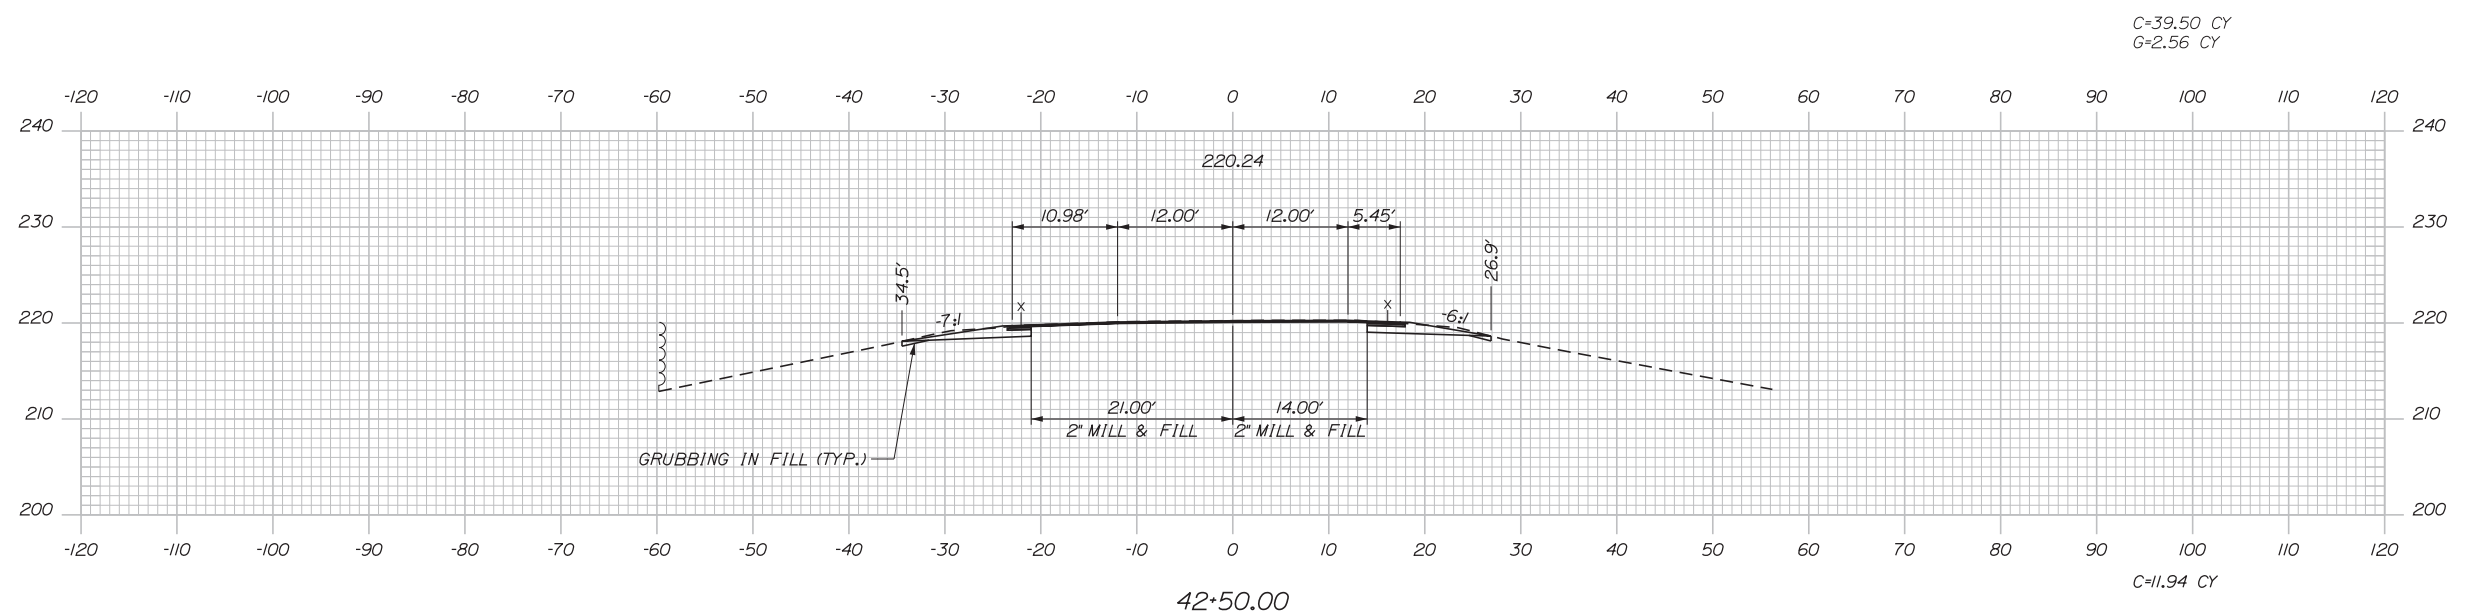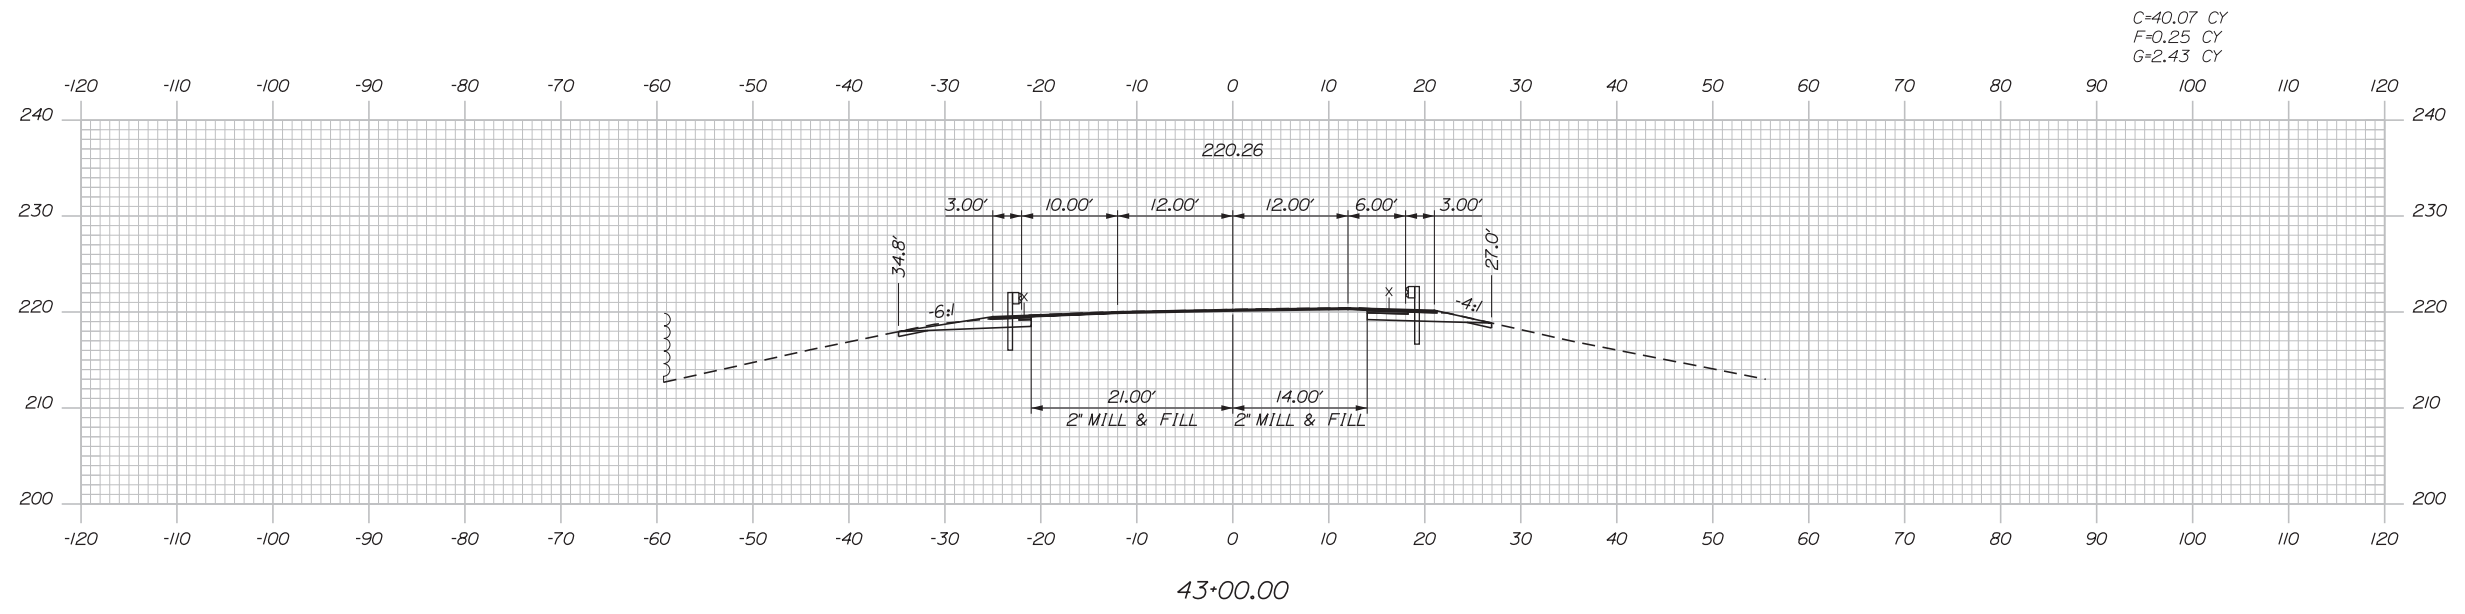

Designed by:

**Stantec**

CONSULTANT PROJECT MANAGER: LAUREN MEEK, PE

No.	Revision	By	Date

	By	Date		By	Date
Designed	PLP	3\20\19	Checked	LEM	3\20\19
Drawn	EJB	3\20\19	In Charge of	GAE	3\20\19

STANTEC CONSULTING SERVICES INC.  
 482 PAYNE ROAD  
 SCARBOROUGH, ME 04074  
 TEL (207) 887-3448  
 FAX (207) 883-3376

**MAINE TURNPIKE**

**THE GOLD STAR MEMORIAL HIGHWAY**

MTA PROJECT MANAGER: RALPH NORWOOD, IV, PE, PTOE


INTERCHANGE 103  
 ORT CONVERSION  
 SB ORT  
 STA. 42+50.00 TO STA. 43+00.00

SHEET NUMBER: XS-103  
 337 OF 503


CONTRACT: 2019.04

Date: 3/20/2019


Filename: ... \00\HIGHWAY\MSTA\\_xsect.dgn

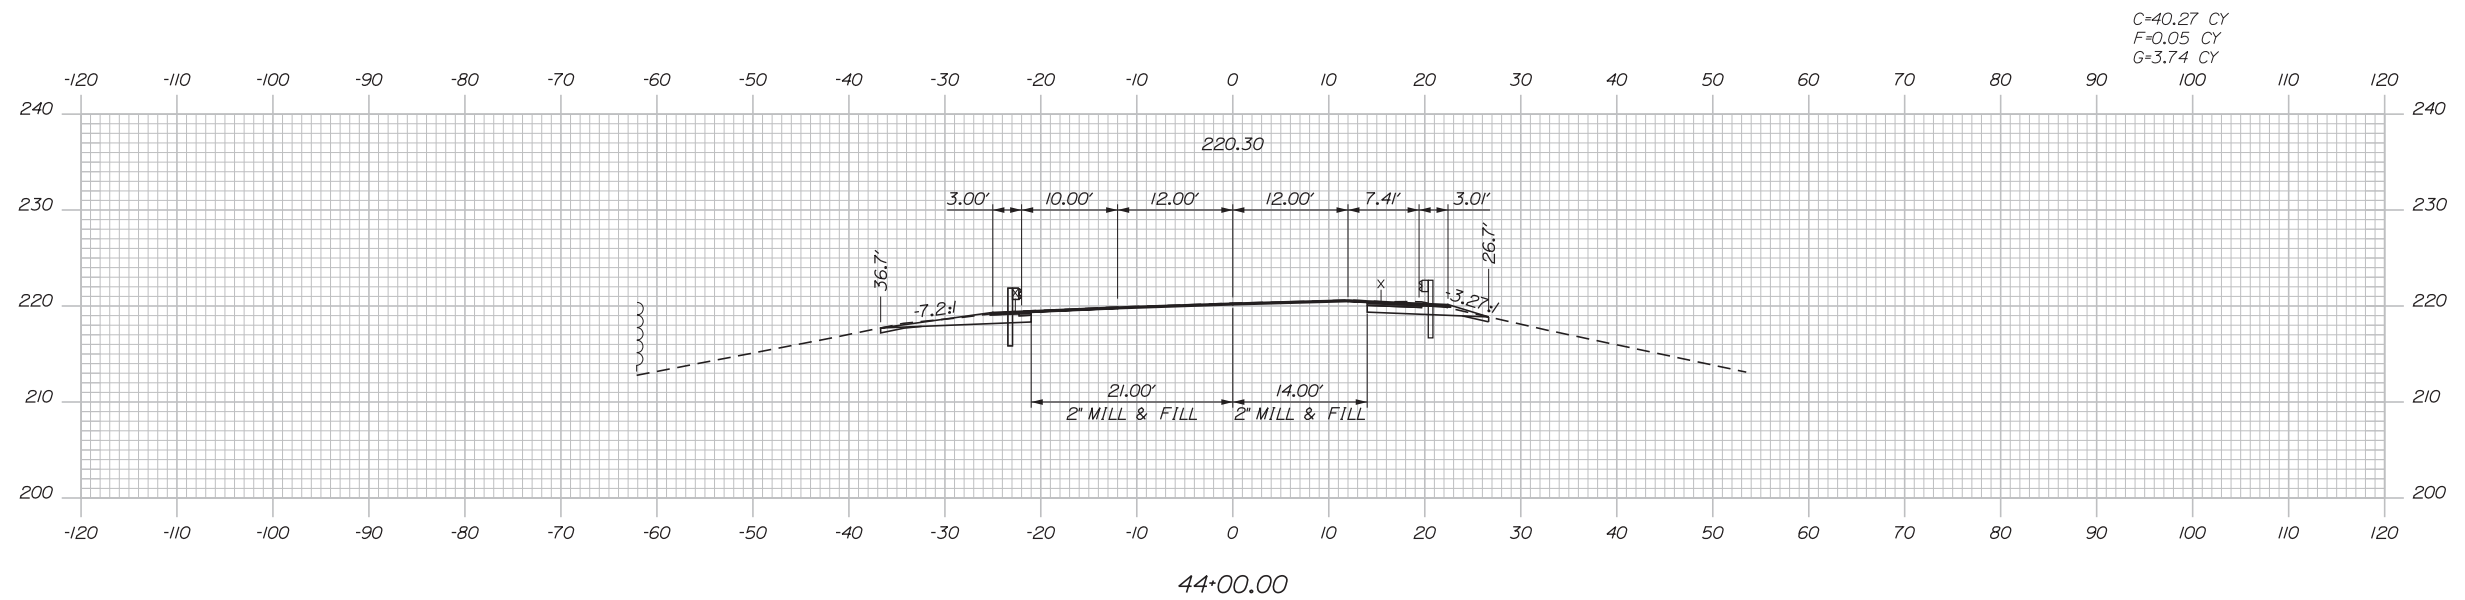

C=40.27 CY  
F=0.05 CY  
G=3.74 CY

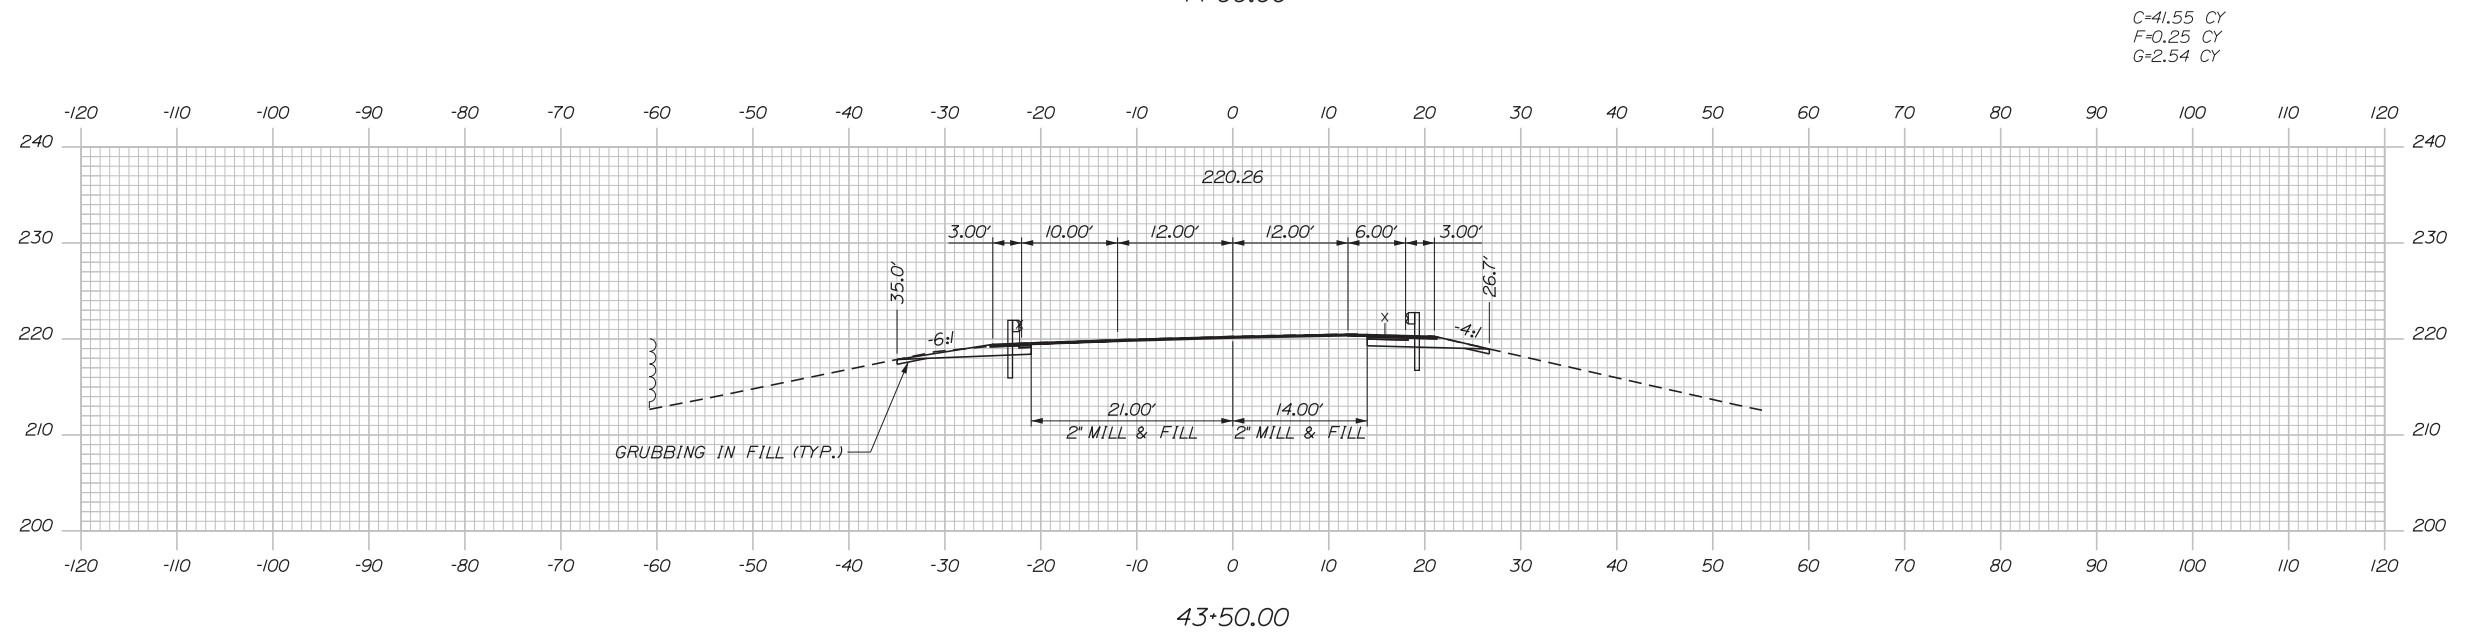

C=41.55 CY  
F=0.25 CY  
G=2.54 CY

 

Designed by:



STANTEC CONSULTING SERVICES INC.  
482 PAYNE ROAD  
SCARBOROUGH, ME 04074  
TEL (207) 887-3448  
FAX (207) 883-3376



THE GOLD STAR  
MEMORIAL HIGHWAY

INTERCHANGE 103  
ORT CONVERSION  
SB ORT  
STA. 43+50.00 TO STA. 44+00.00

No.	Revision	By	Date

CONSULTANT PROJECT MANAGER: LAUREN MEEK, PE			
Designed	By	Date	Checked
	PLP	3\20\19	LEM
Drawn	By	Date	In Charge of
	EJB	3\20\19	GAE

MTA PROJECT MANAGER: RALPH NORWOOD, IV, PE, PTOE


CONTRACT: 2019.04

SHEET NUMBER: XS-104


338 OF 503

Date: 3/20/2019


Filename: ...00\HIGHWAY\MSTA\\_xsect.dgn

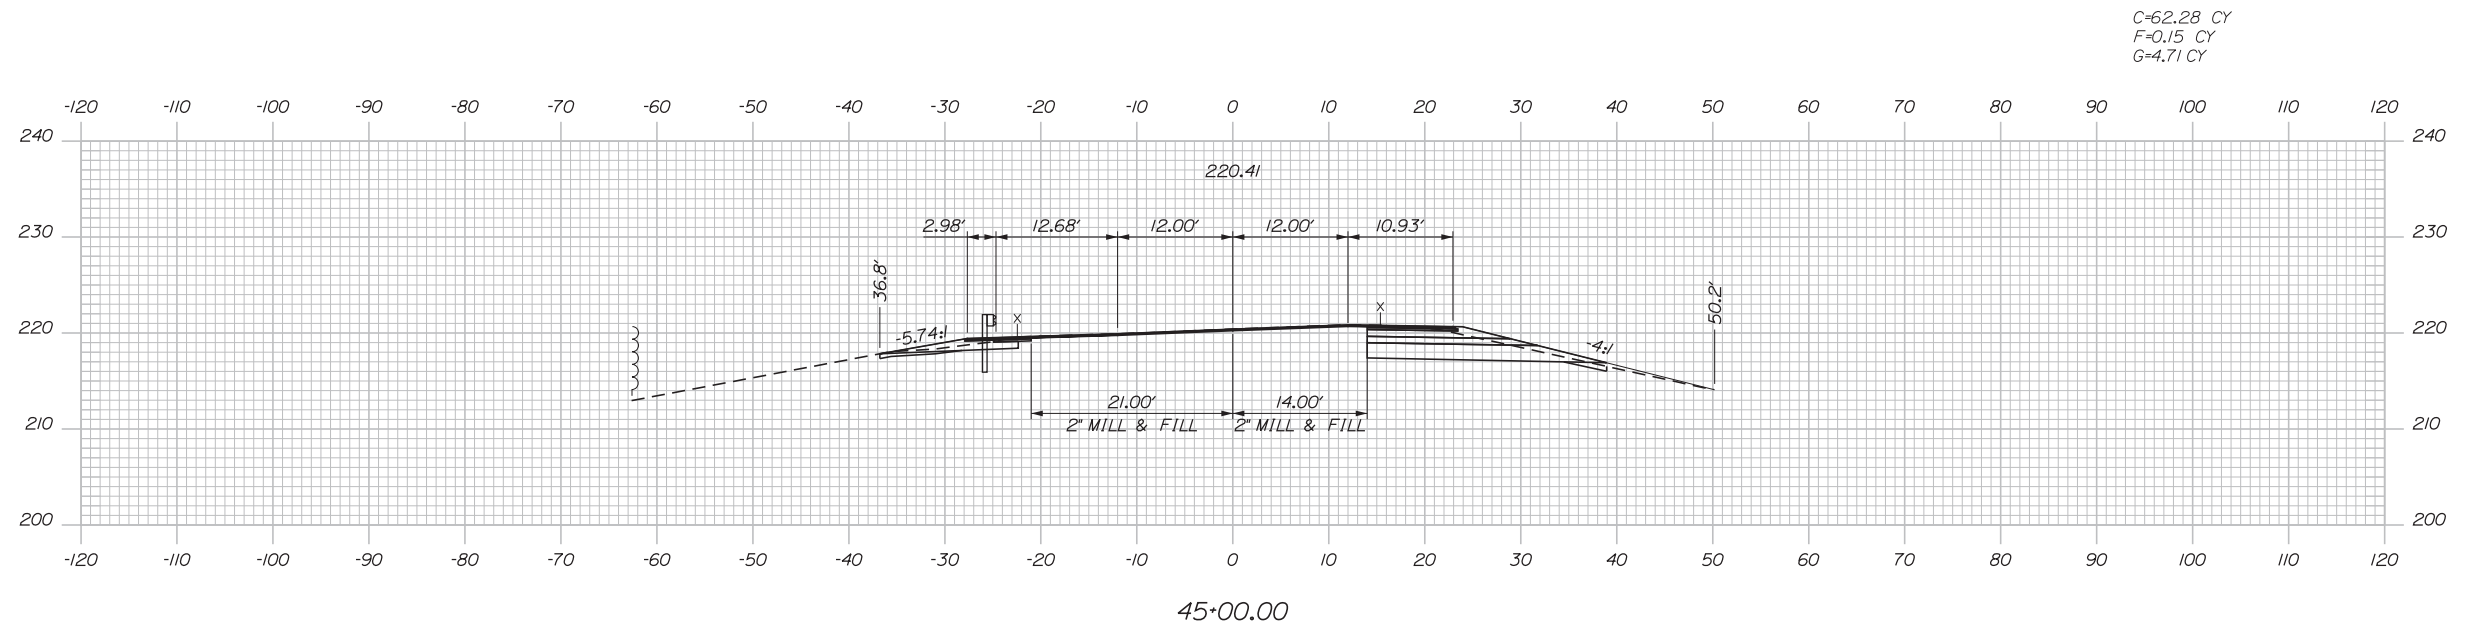

C=62.28 CY  
F=0.15 CY  
G=4.71 CY

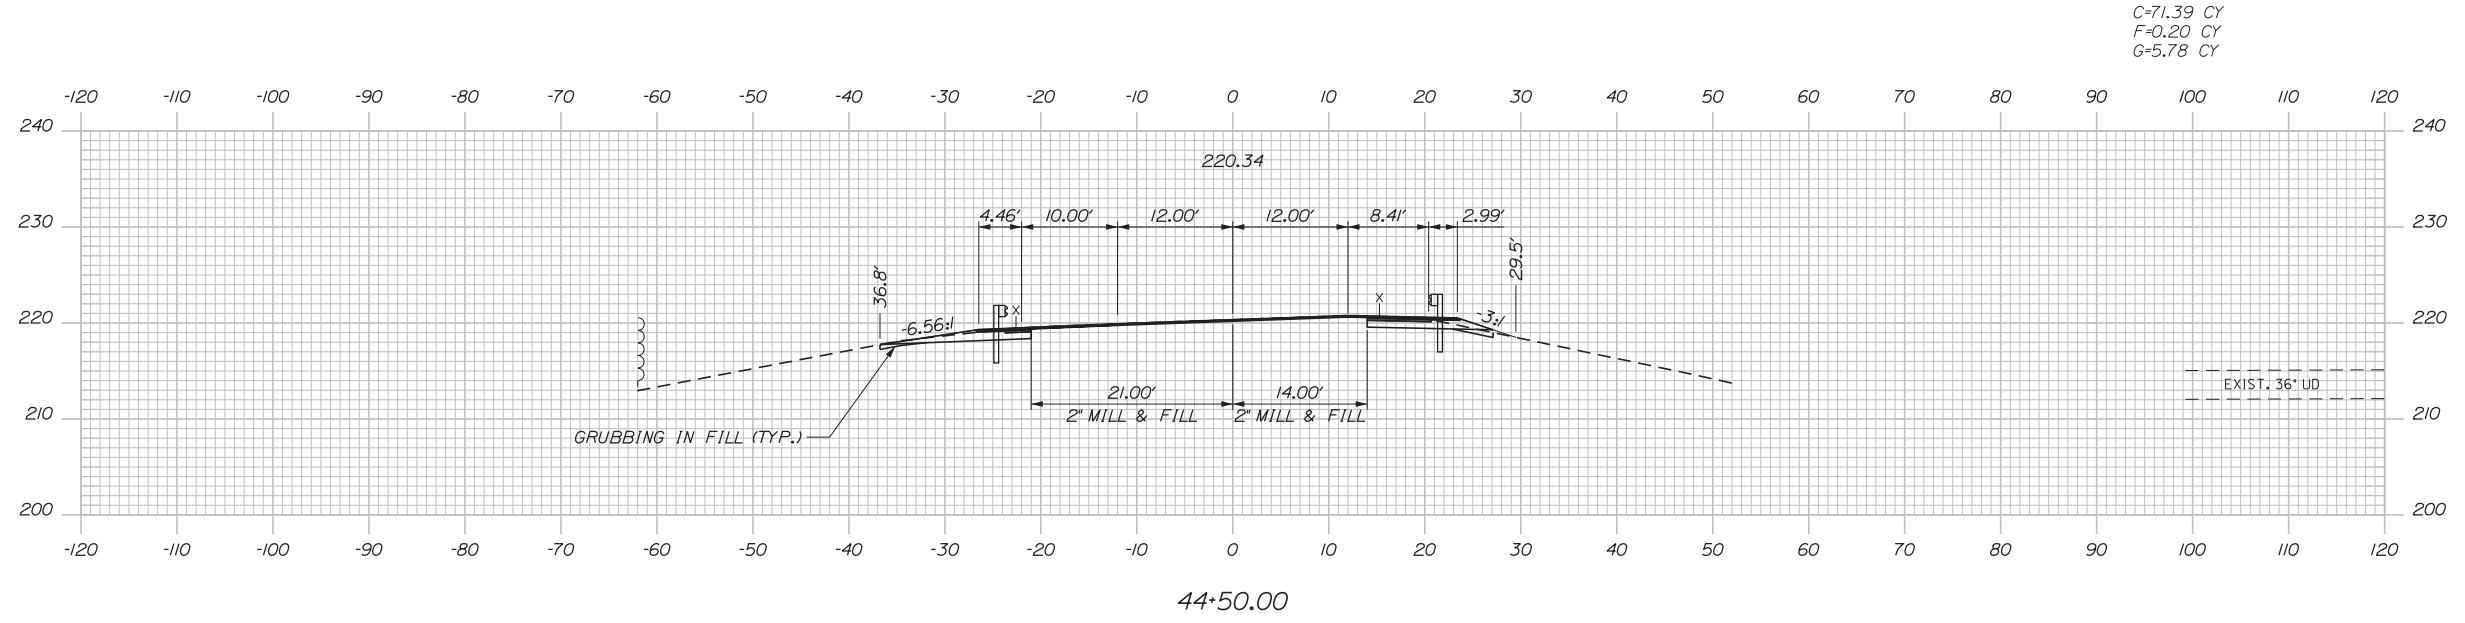

C=71.39 CY  
F=0.20 CY  
G=5.78 CY

 

Designed by:

**Stantec**

CONSULTANT PROJECT MANAGER: LAUREN MEEK, PE

No.	Revision	By	Date

	By	Date		By	Date
Designed	PLP	3\20\19	Checked	LEM	3\20\19
Drawn	EJB	3\20\19	In Charge of	GAE	3\20\19

STANTEC CONSULTING SERVICES INC.  
482 PAYNE ROAD  
SCARBOROUGH, ME 04074  
TEL (207) 887-3448  
FAX (207) 883-3376

**MAINE TURNPIKE**

**THE GOLD STAR MEMORIAL HIGHWAY**


MTA PROJECT MANAGER: RALPH NORWOOD, IV, PE, PTOE

INTERCHANGE 103  
ORT CONVERSION  
SB ORT  
STA. 44+50.00 TO STA. 45+00.00

SHEET NUMBER: XS-105  
CONTRACT: 2019.04  
339 OF 503


Date: 3/20/2019

Filename: ... \00\HIGHWAY\MSTA\\_xsect.dgn

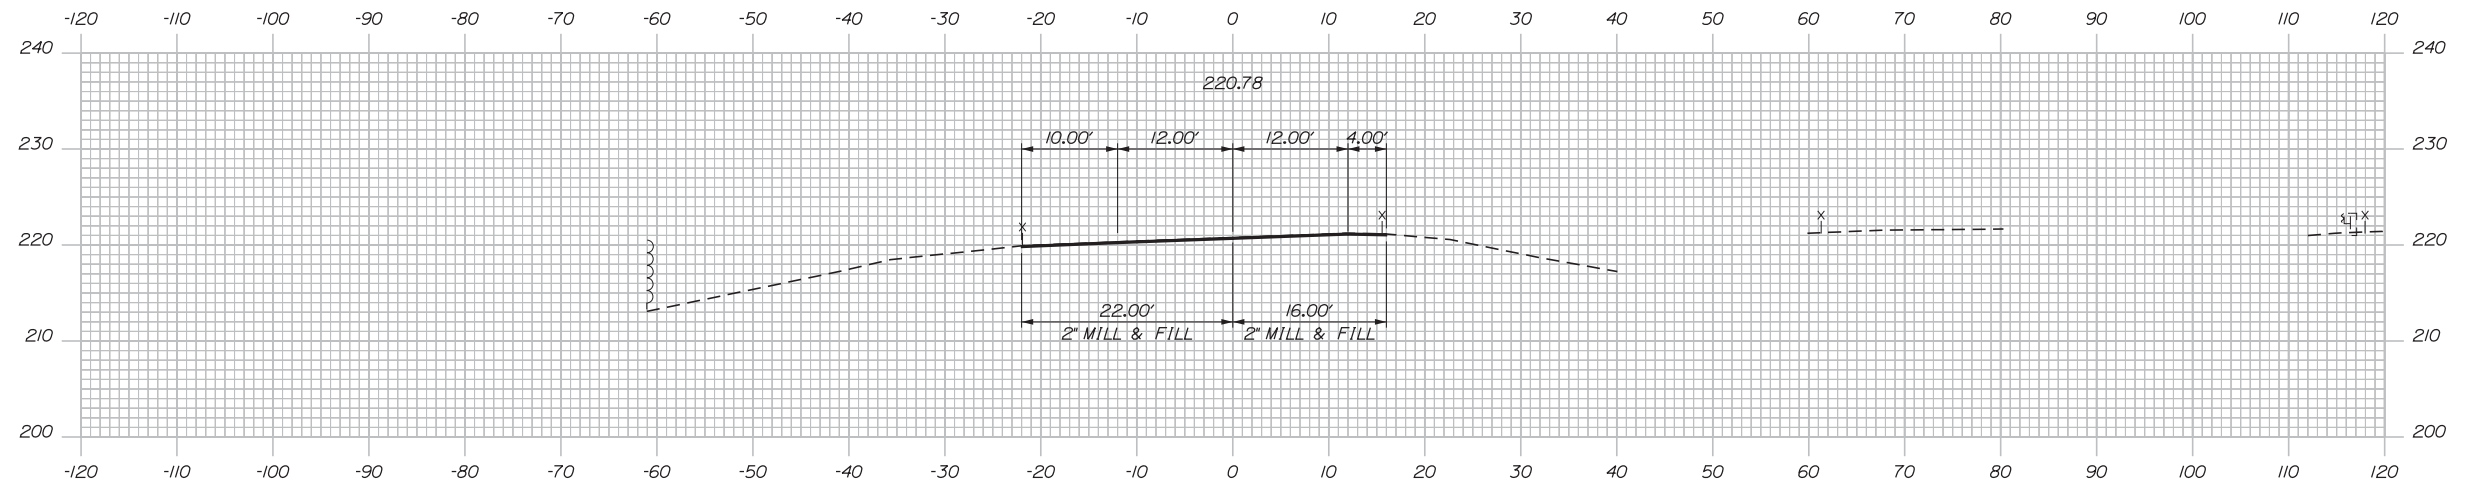


46+00.00

C=10.08 CY

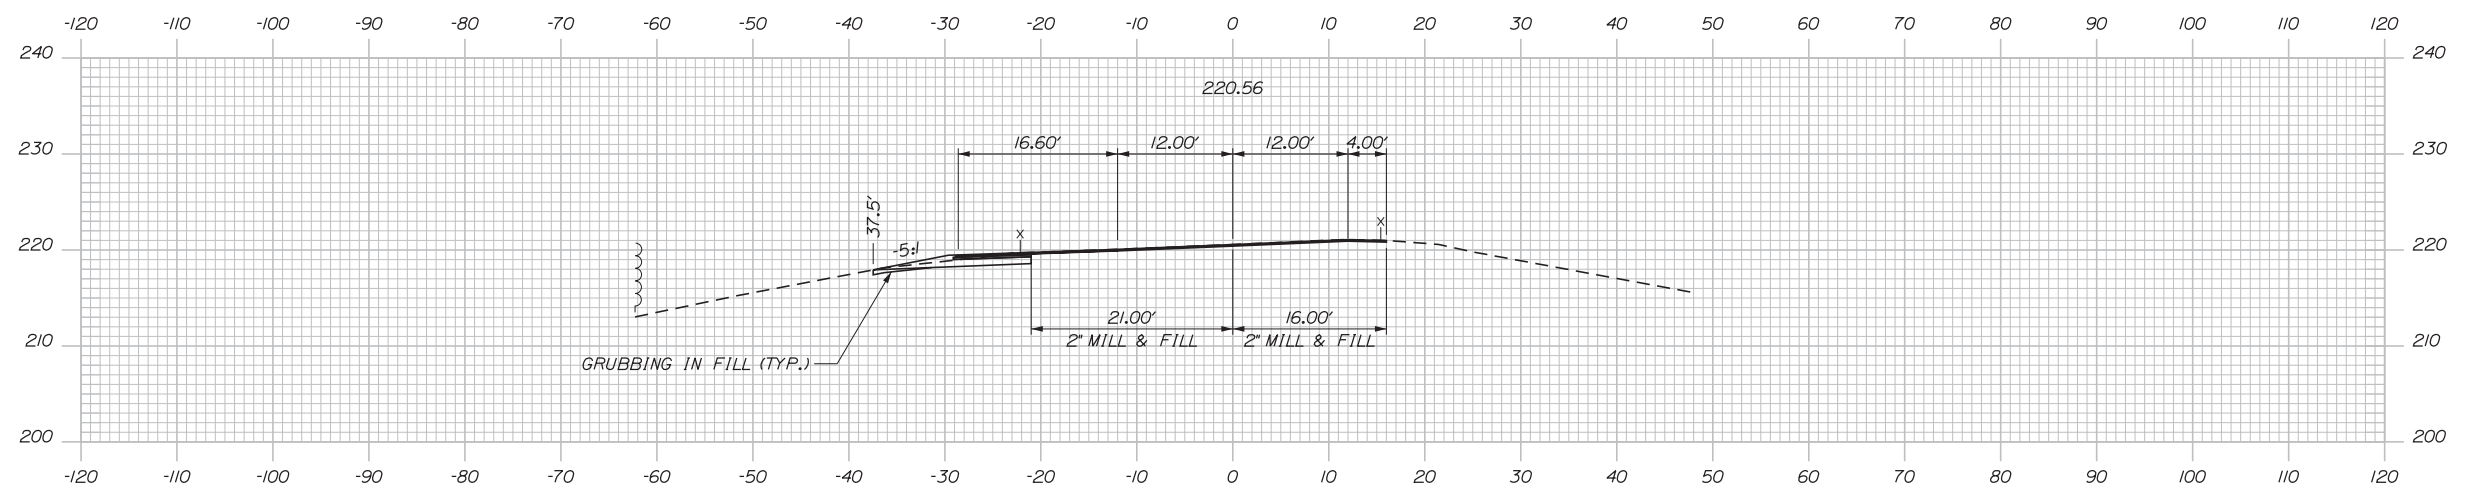

45+50.00

 

Designed by:

**Stantec**

CONSULTANT PROJECT MANAGER: LAUREN MEEK, PE

No.	Revision	By	Date

	By	Date		By	Date
Designed	PLP	3\20\19	Checked	LEM	3\20\19
Drawn	EJB	3\20\19	In Charge of	GAE	3\20\19

STANTEC CONSULTING SERVICES INC.  
482 PAYNE ROAD  
SCARBOROUGH, ME 04074  
TEL (207) 887-3448  
FAX (207) 883-3376

**MAINE TURNPIKE**

**THE GOLD STAR MEMORIAL HIGHWAY**

MTA PROJECT MANAGER: RALPH NORWOOD, IV, PE, PTOE


INTERCHANGE 103  
ORT CONVERSION  
SB ORT  
STA. 45+50.00 TO STA. 46+00.00

SHEET NUMBER: XS-106  
CONTRACT: 2019.04  
340 OF 503




Date: 3/20/2019



Filename: ...00\HIGHWAY\MSTA\\_xsect.dgn

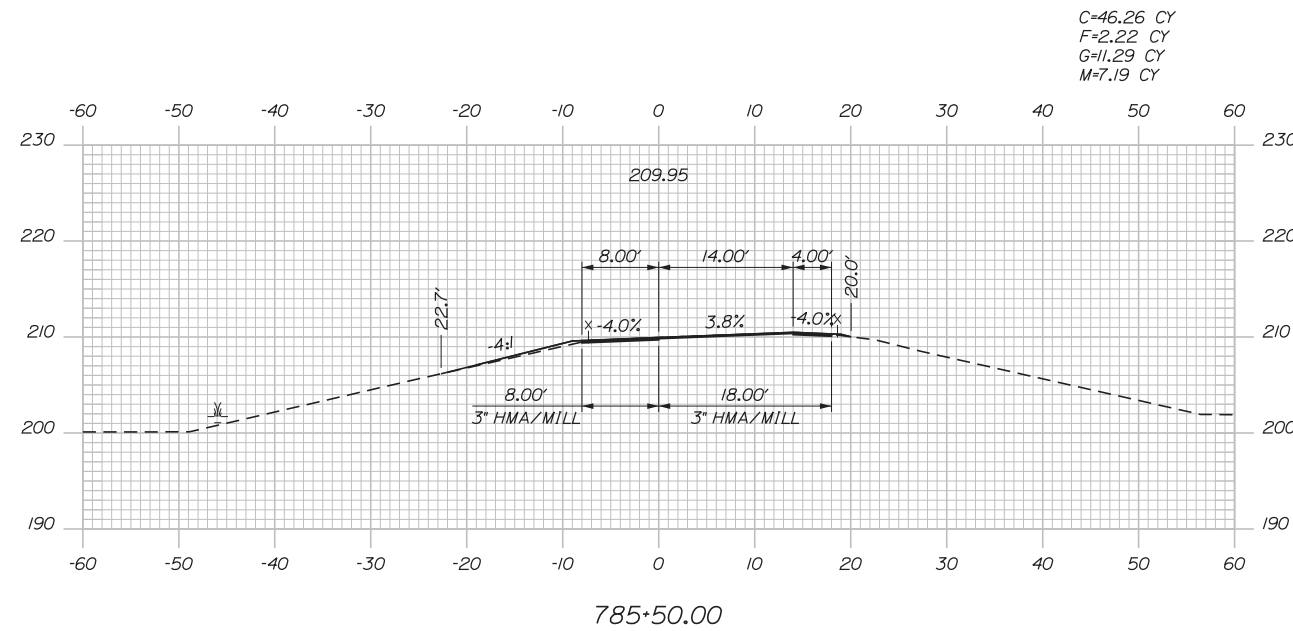

C=46.26 CY  
F=2.22 CY  
G=11.29 CY  
M=7.19 CY

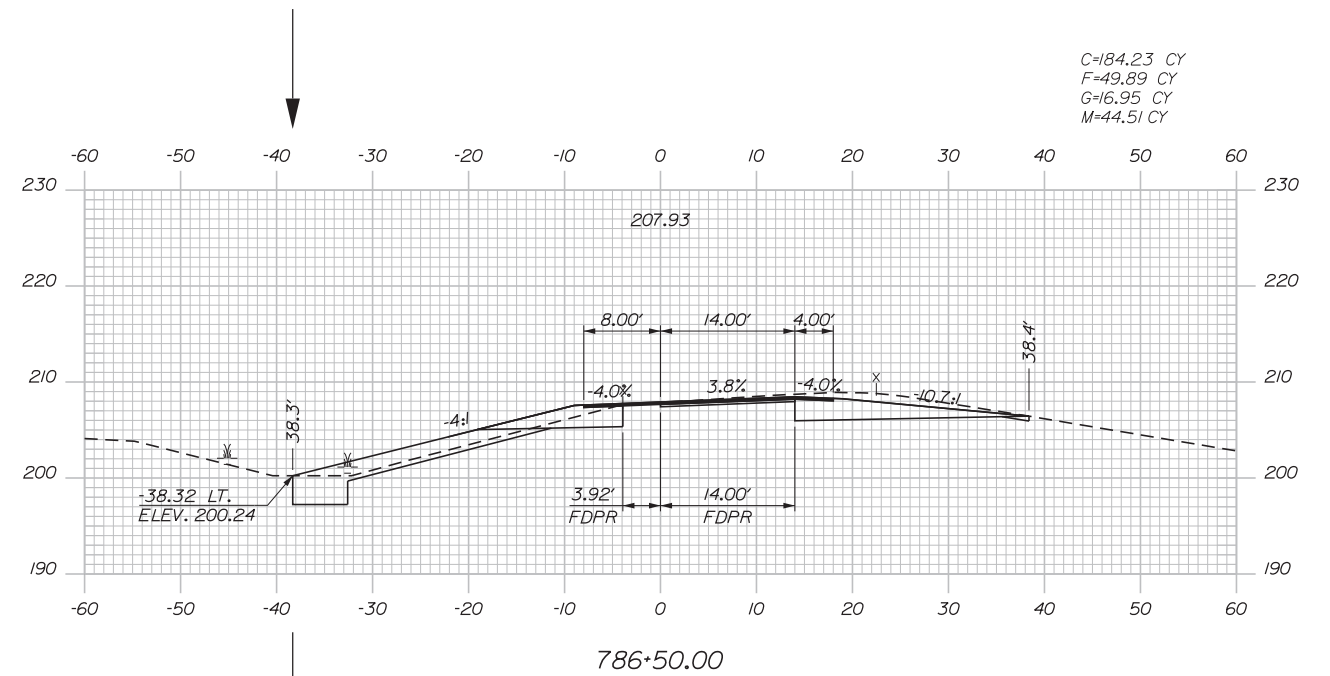


C=184.23 CY  
F=49.89 CY  
G=16.95 CY  
M=44.51 CY

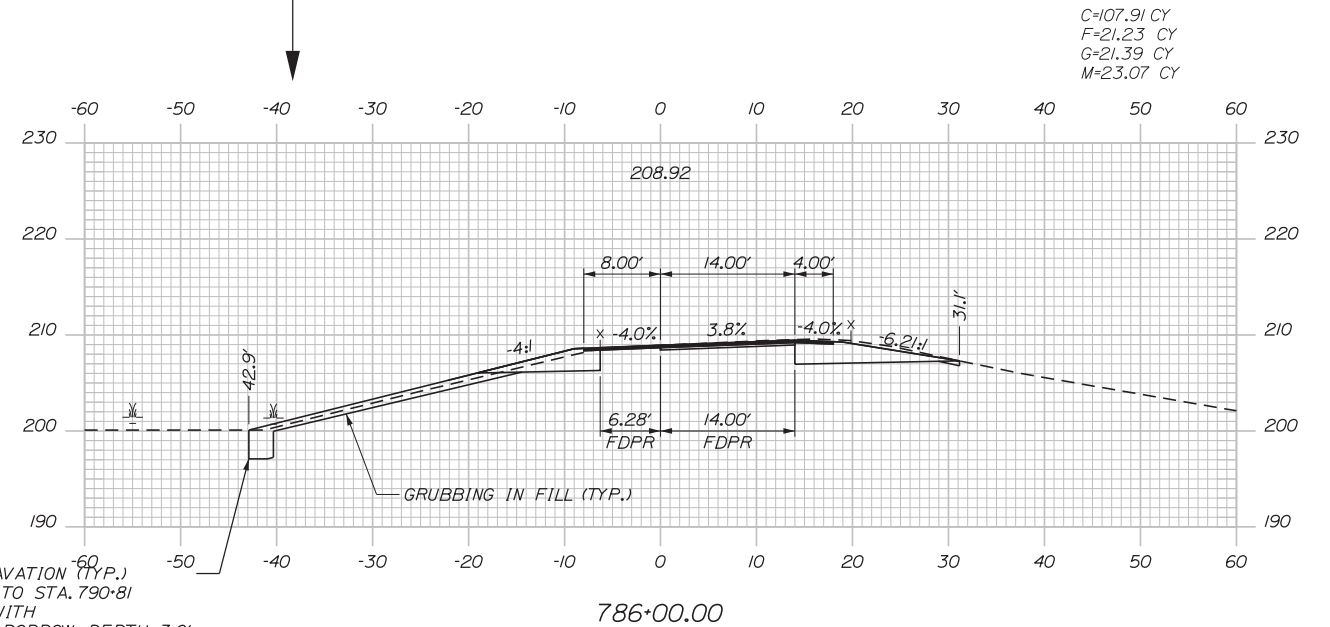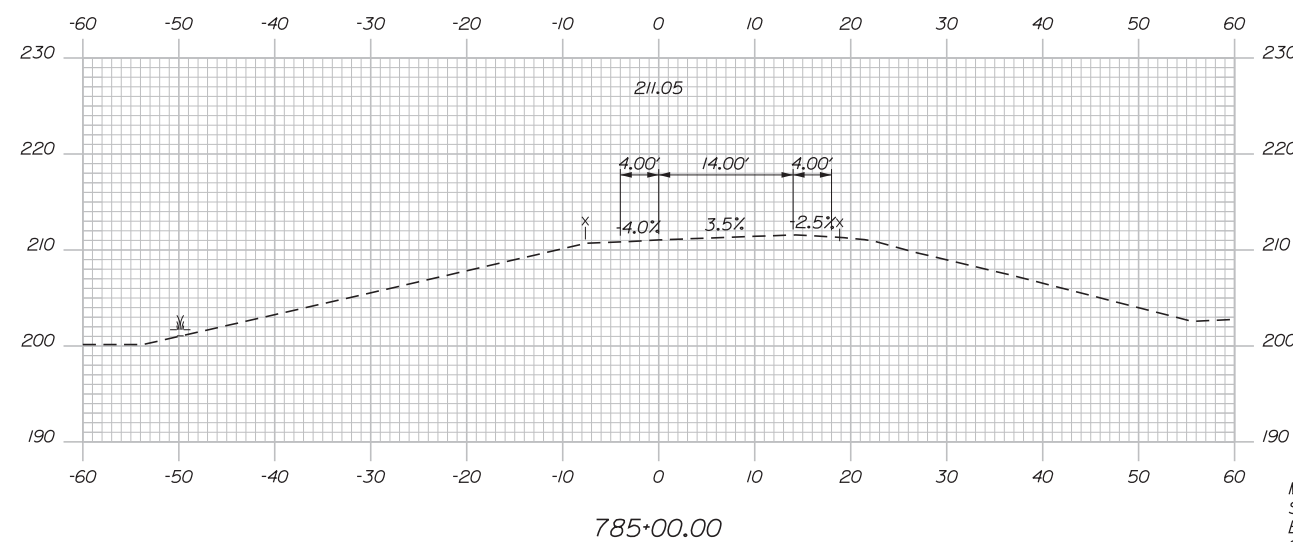

C=107.91 CY  
F=21.23 CY  
G=21.39 CY  
M=23.07 CY

 MUCK EXCAVATION (TYP.)  
STA 786+41 TO STA. 790+81  
BACKFILL WITH  
GRANULAR BORROW DEPTH: 3.0'



Designed by:



STANTEC CONSULTING SERVICES INC.  
482 PAYNE ROAD  
SCARBOROUGH, ME 04074  
TEL (207) 887-3448  
FAX (207) 883-3376



THE GOLD STAR  
MEMORIAL HIGHWAY

INTERCHANGE 103  
ORT CONVERSION  
EXIT 51 SB OFF RAMP  
STA. 785+00.00 TO STA. 786+50.00

No.	Revision	By	Date

CONSULTANT PROJECT MANAGER: LAUREN MEEK, PE			
	By	Date	
Designed	PLP	3\20\19	Checked
			LEM
			3\20\19
Drawn	EJB	3\20\19	In Charge of
			GAE
			3\20\19

MTA PROJECT MANAGER: RALPH NORWOOD, IV, PE, PTOE


CONTRACT: 2019.04

SHEET NUMBER: XS-107


341 OF 503

Date: 3/20/2019


Filename: ...00.HIGHWAY\MSTA\\_xsect.dgn

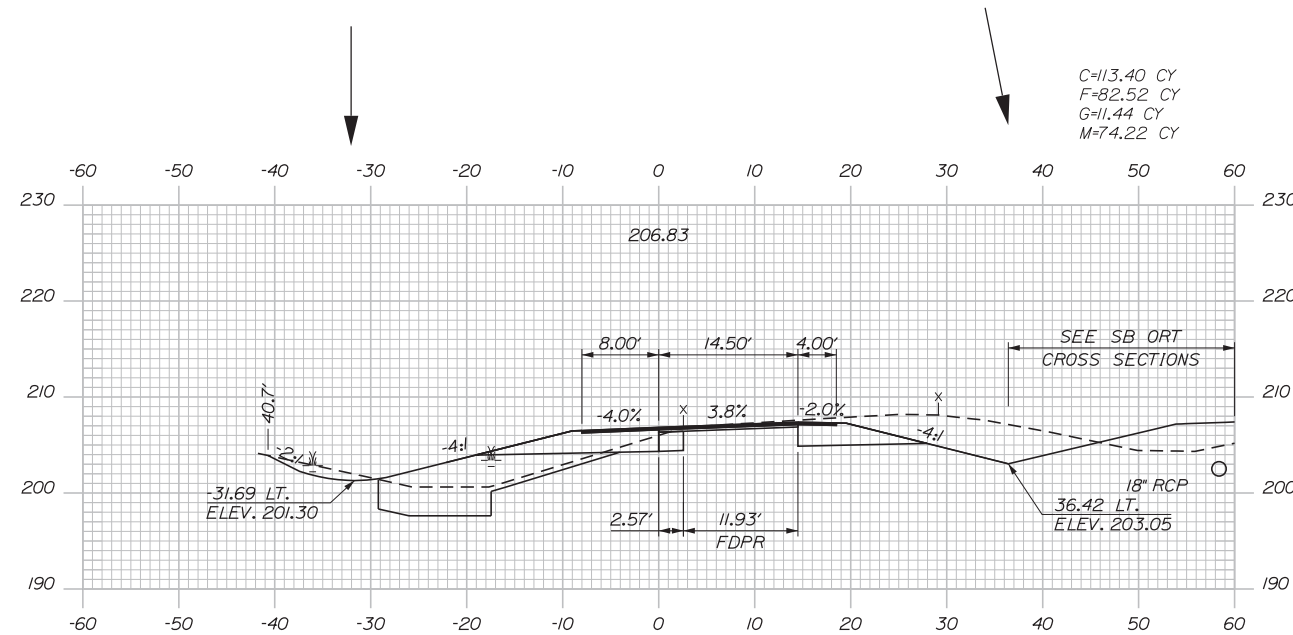


C=113.40 CY  
F=82.52 CY  
G=11.44 CY  
M=74.22 CY

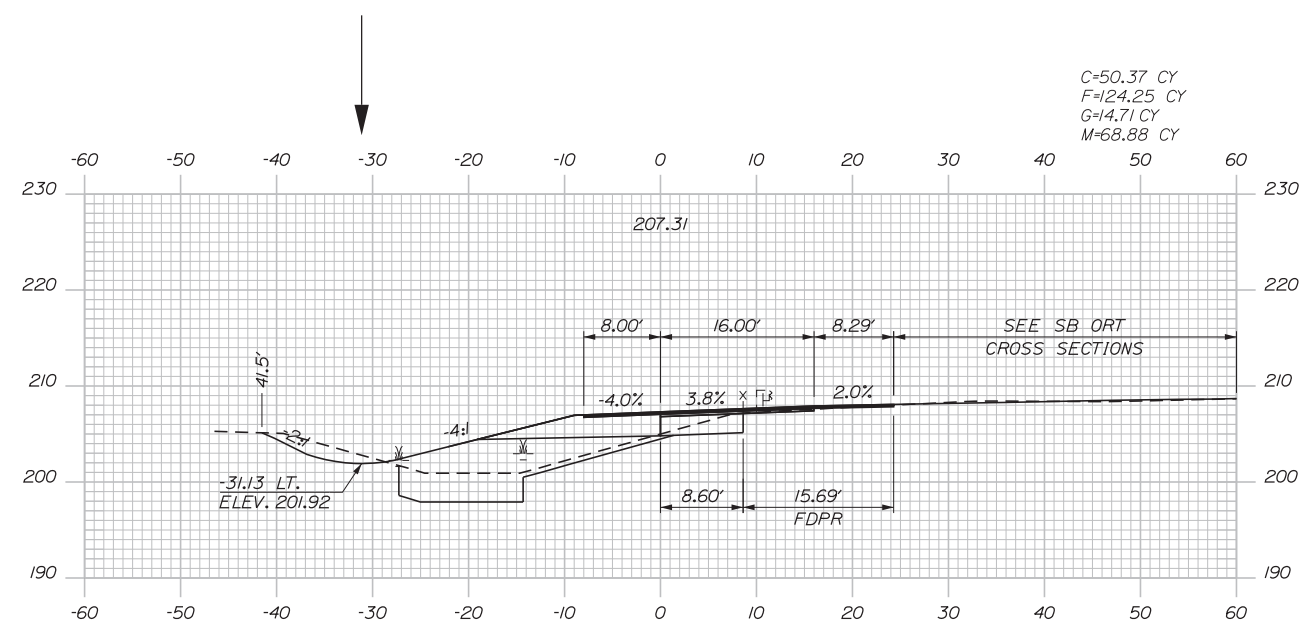


C=50.37 CY  
F=124.25 CY  
G=14.71 CY  
M=68.88 CY

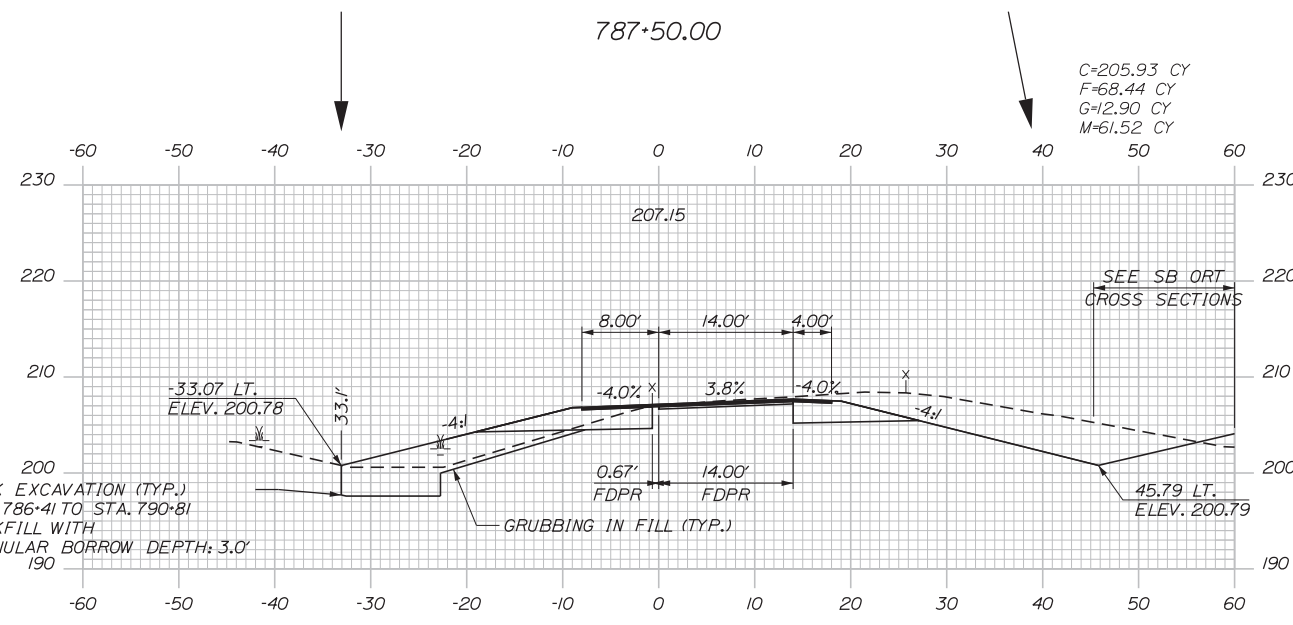

C=205.93 CY  
F=68.44 CY  
G=12.90 CY  
M=61.52 CY

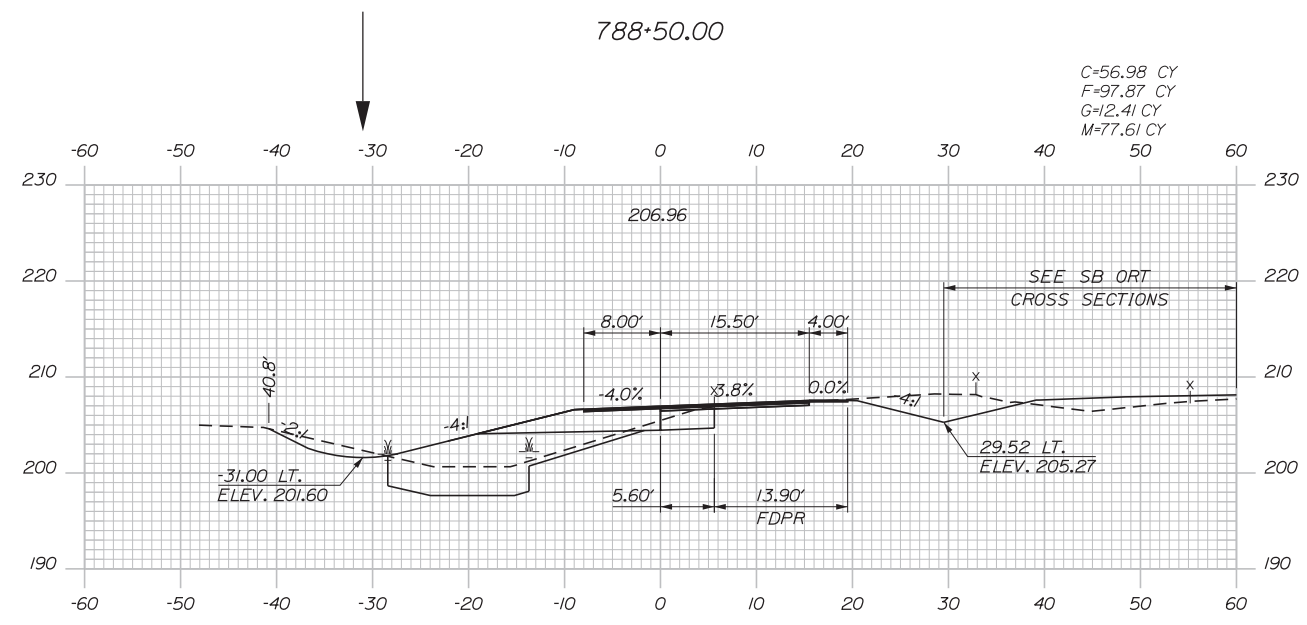

 C=56.98 CY  
F=97.87 CY  
G=12.41 CY  
M=77.61 CY



Designed by:



STANTEC CONSULTING SERVICES INC.  
482 PAYNE ROAD  
SCARBOROUGH, ME 04074  
TEL (207) 887-3448  
FAX (207) 883-3376



THE GOLD STAR  
MEMORIAL HIGHWAY

INTERCHANGE 103  
ORT CONVERSION  
EXIT 51 SB OFF RAMP  
STA. 787+00.00 TO STA. 788+50.00

No.	Revision	By	Date

CONSULTANT PROJECT MANAGER: LAUREN MEEK, PE			
	By	Date	
Designed	PLP	3\20\19	Checked LEM 3\20\19
Drawn	EJB	3\20\19	In Charge of GAE 3\20\19

MTA PROJECT MANAGER: RALPH NORWOOD, IV, PE, PTOE


CONTRACT: 2019.04

SHEET NUMBER: XS-108

342 OF 503


Date: 3/20/2019

Filename: ...00.HIGHWAY\MSTA\\_xsect.dgn

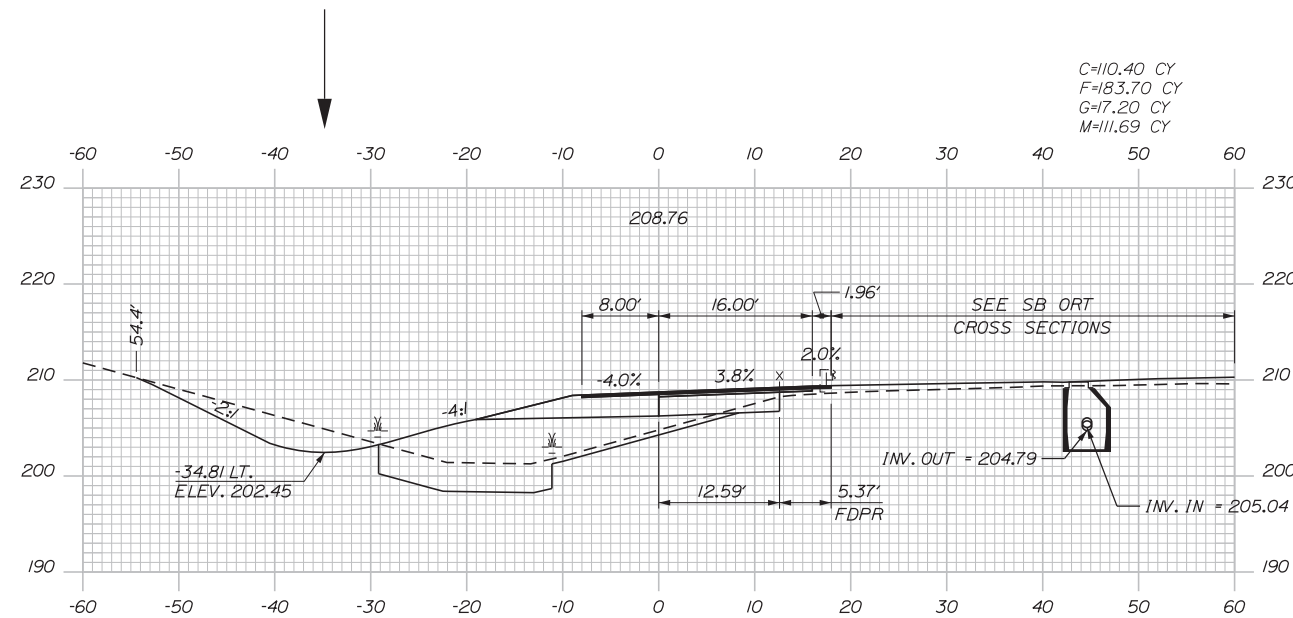


C=110.40 CY  
F=183.70 CY  
G=17.20 CY  
M=111.69 CY

STA. 789+55.10, 43.79' RT.  
INSTALL CB TYPE B5 (WITH 2' CONE)  
RIM ELEV. = 209.79  
C=77.09 CY  
F=159.32 CY  
G=16.51 CY  
M=83.63 CY

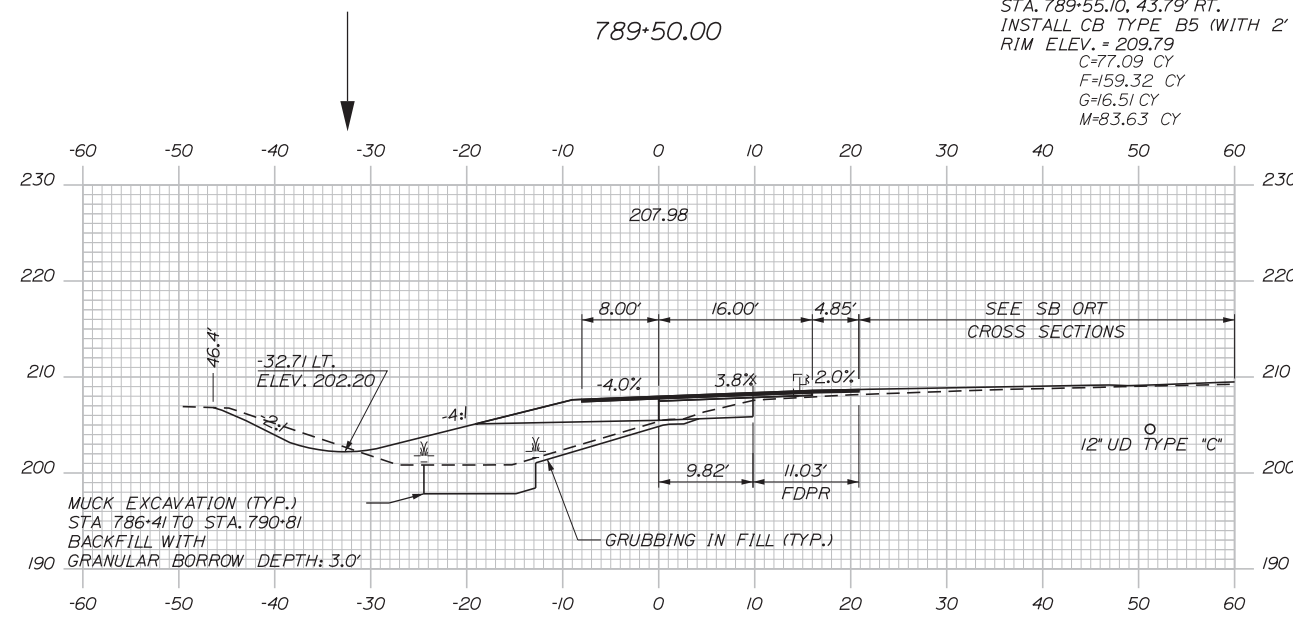


MUCK EXCAVATION (TYP.)  
STA 786+41 TO STA. 790+81  
BACKFILL WITH  
GRANULAR BORROW DEPTH: 3.0'

789+00.00

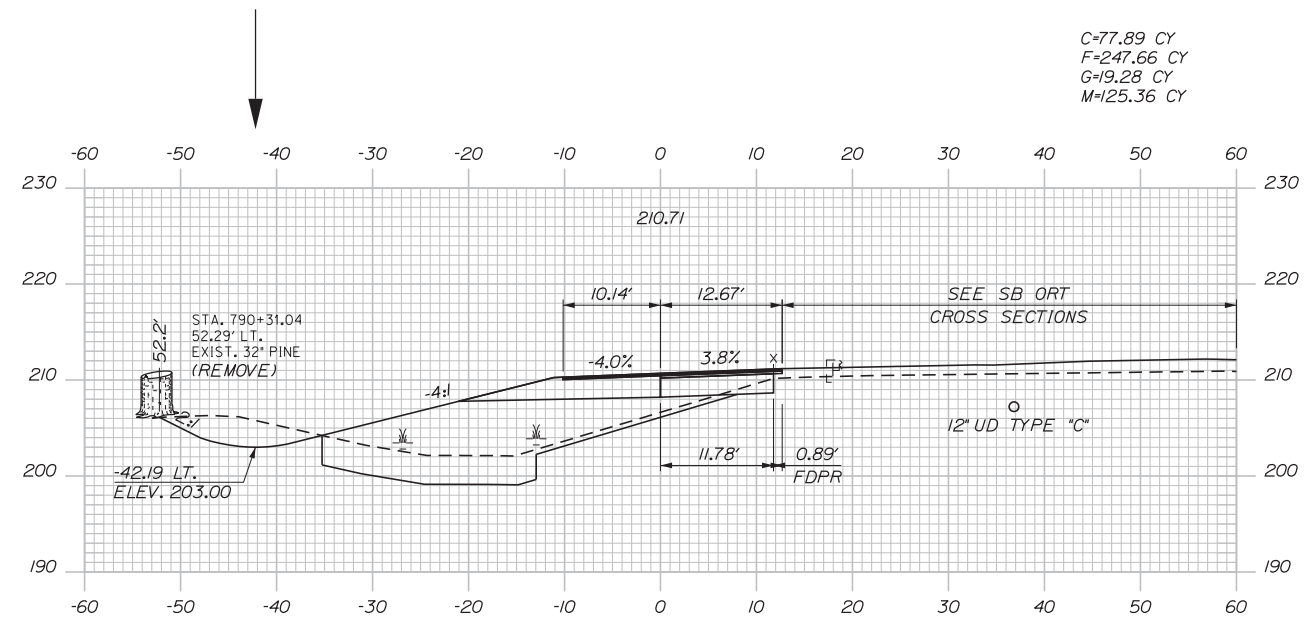


C=77.89 CY  
F=247.66 CY  
G=19.28 CY  
M=125.36 CY

C=95.72 CY  
F=219.56 CY  
G=18.02 CY  
M=123.34 CY

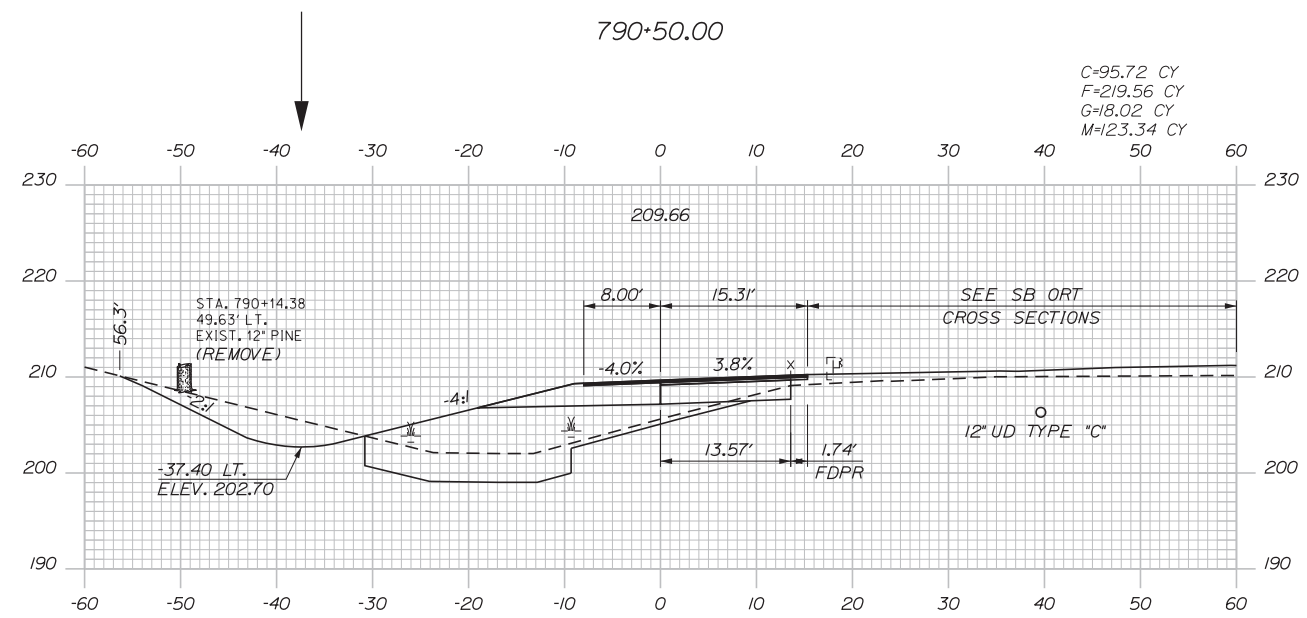

790+00.00

 

No.	Revision	By	Date

Designed by:

**Stantec**

CONSULTANT PROJECT MANAGER: LAUREN MEEK, PE

	By	Date		By	Date
Designed	PLP	3\20\19	Checked	LEM	3\20\19
Drawn	EJB	3\20\19	In Charge of	GAE	3\20\19

STANTEC CONSULTING SERVICES INC.  
482 PAYNE ROAD  
SCARBOROUGH, ME 04074  
TEL (207) 887-3448  
FAX (207) 883-3376

**MAINE TURNPIKE**

**THE GOLD STAR MEMORIAL HIGHWAY**






MTA PROJECT MANAGER: RALPH NORWOOD, IV, PE, PTOE

INTERCHANGE 103  
ORT CONVERSION  
EXIT 51 SB OFF RAMP  
STA. 789+00.00 TO STA. 790+50.00

SHEET NUMBER: XS-109  
CONTRACT: 2019.04  
343 OF 503

Date: 3/20/2019

 Filename: ...00\HIGHWAY\MSTA\\_xsect.dgn

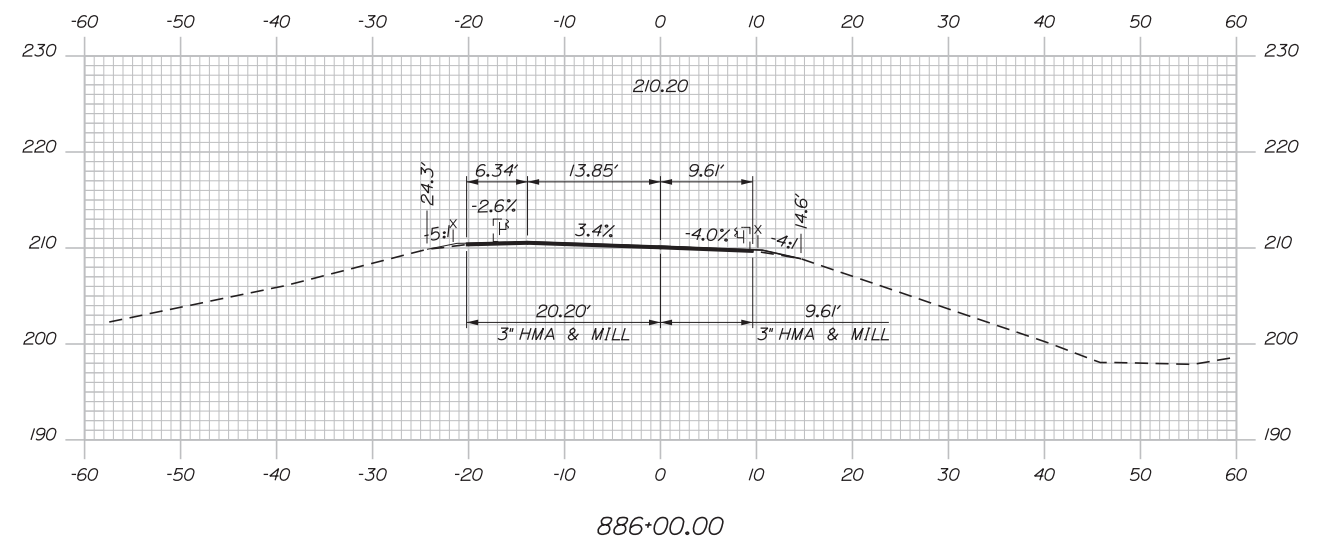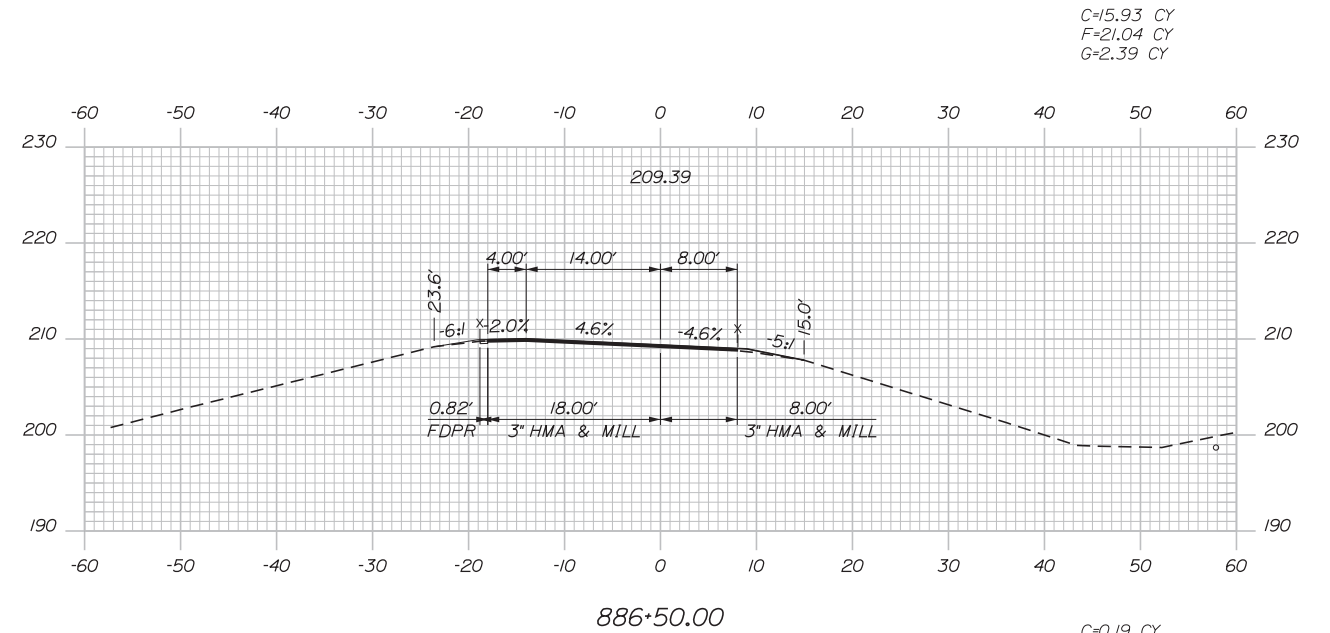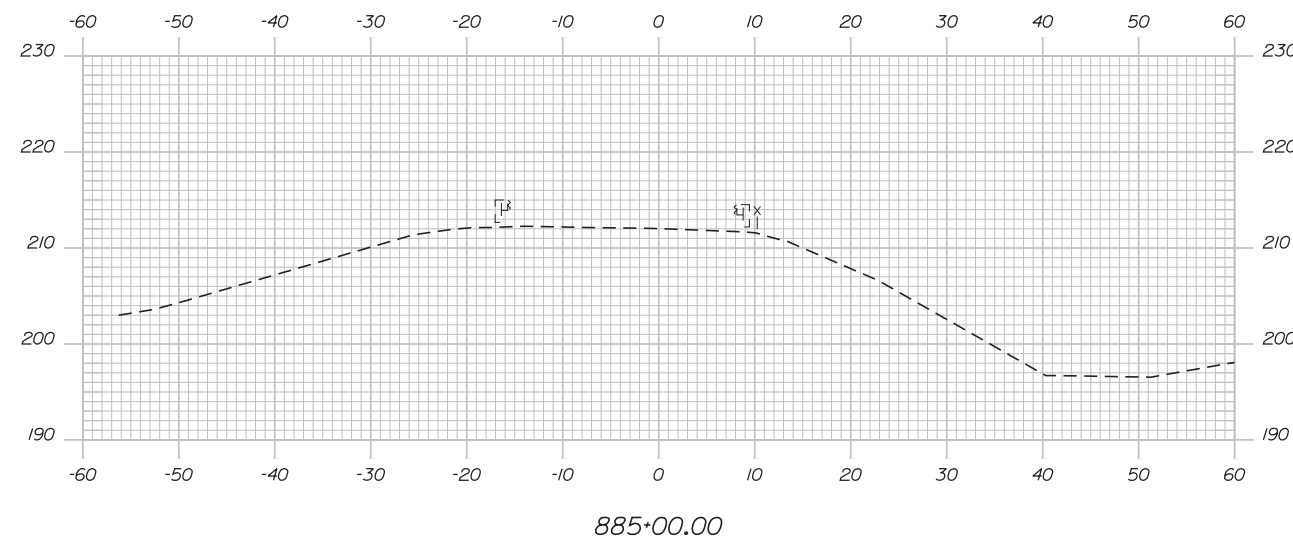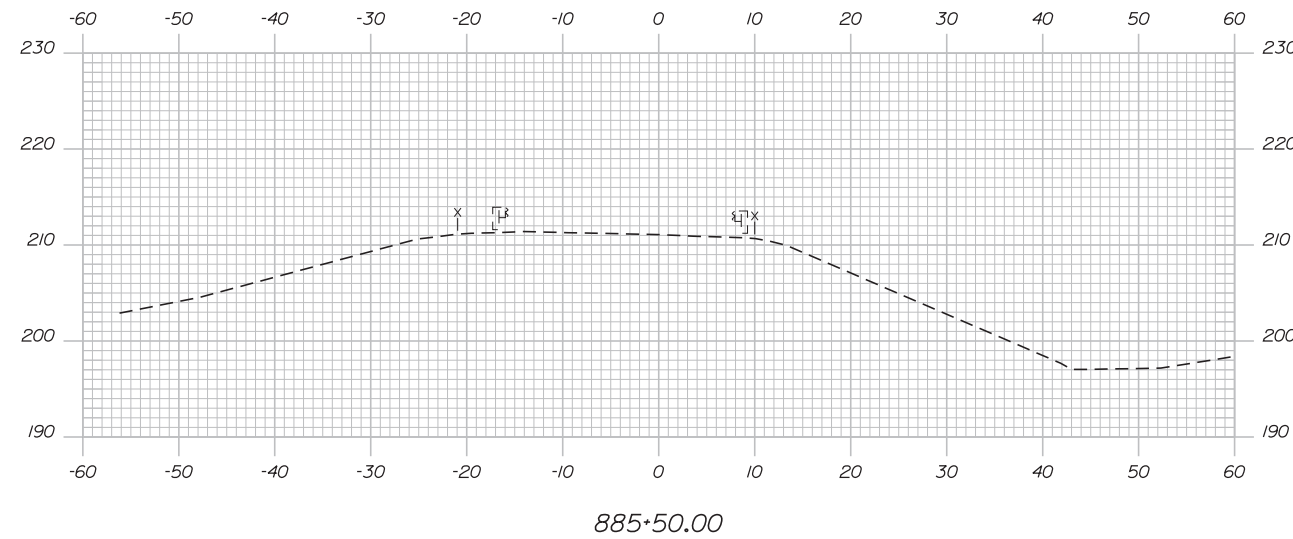

Designed by:



STANTEC CONSULTING SERVICES INC.  
482 PAYNE ROAD  
SCARBOROUGH, ME 04074  
TEL (207) 887-3448  
FAX (207) 883-3376



THE GOLD STAR  
MEMORIAL HIGHWAY

INTERCHANGE 103  
ORT CONVERSION  
EXIT 51 NB ON RAMP  
STA. 885+00.00 TO STA. 886+50.00

No.	Revision	By	Date

CONSULTANT PROJECT MANAGER: LAUREN MEEK, PE			
	By	Date	
Designed	PLP	3\20\19	Checked LEM 3\20\19
Drawn	EJB	3\20\19	In Charge of GAE 3\20\19

MTA PROJECT MANAGER: RALPH NORWOOD, IV, PE, PTOE

 




CONTRACT: 2019.04

SHEET NUMBER: XS-110

344 OF 503

Date: 3/20/2019

Filename: ...00.HIGHWAY\MSTA\\_xsect.dgn

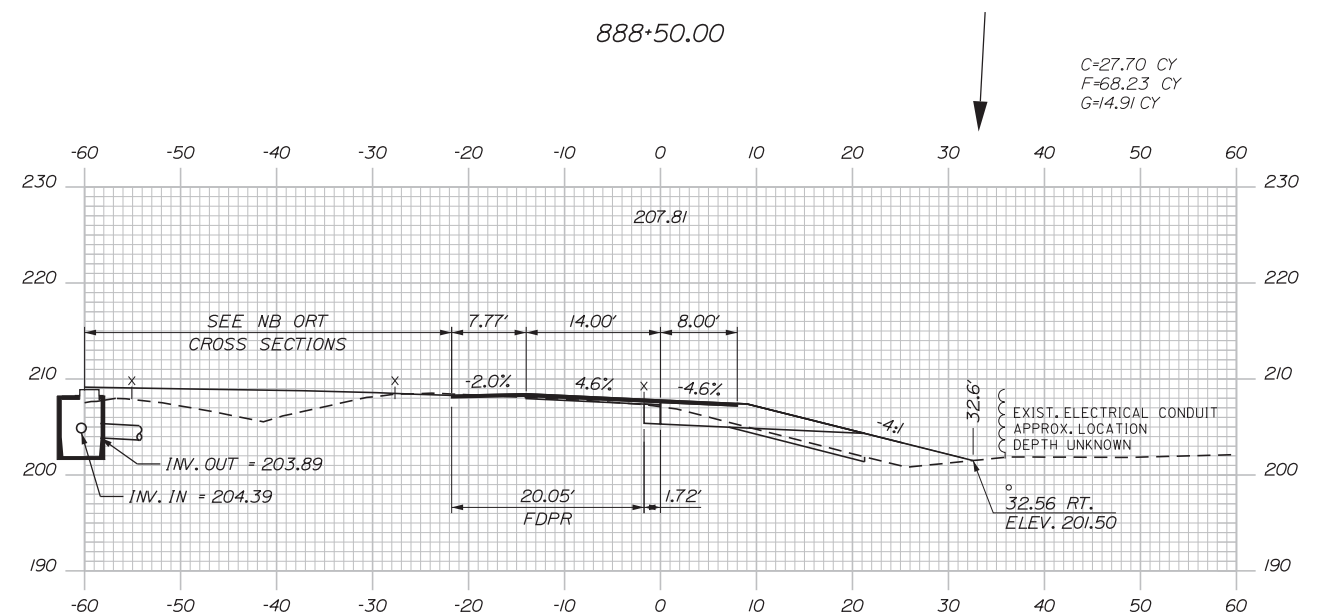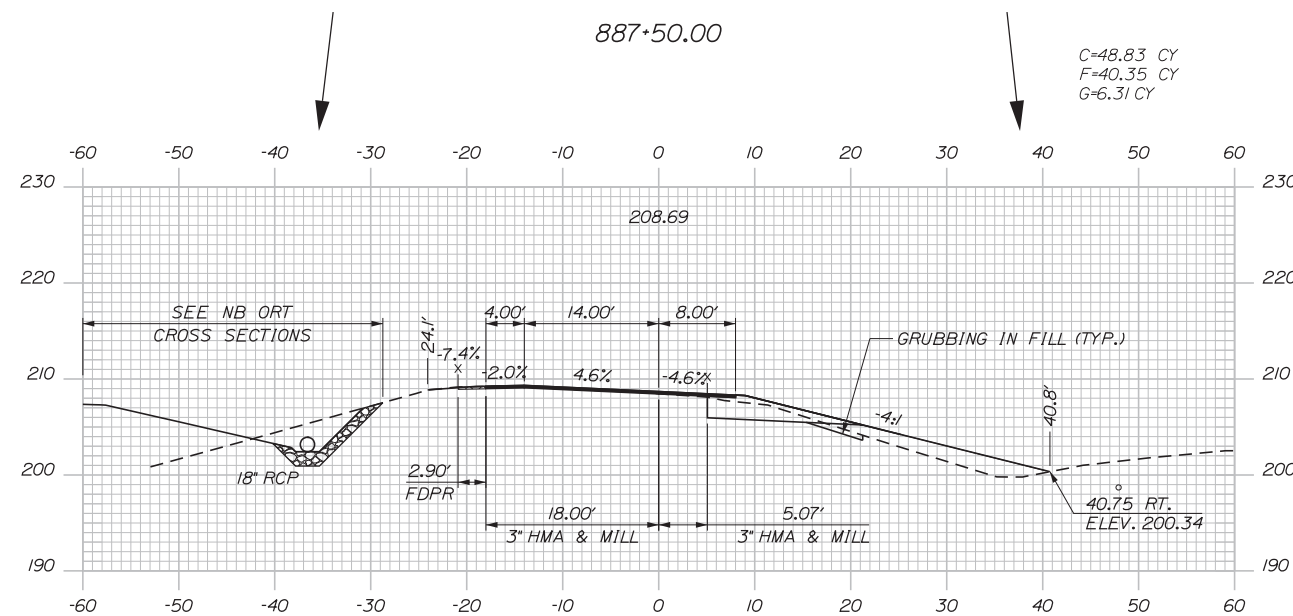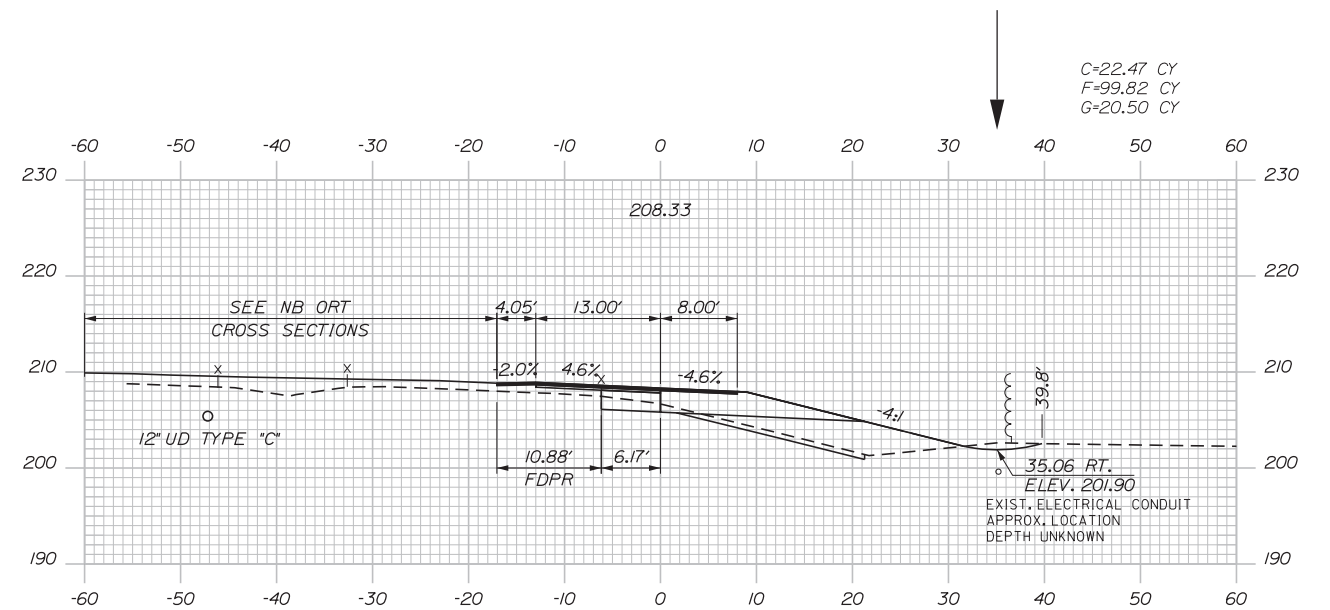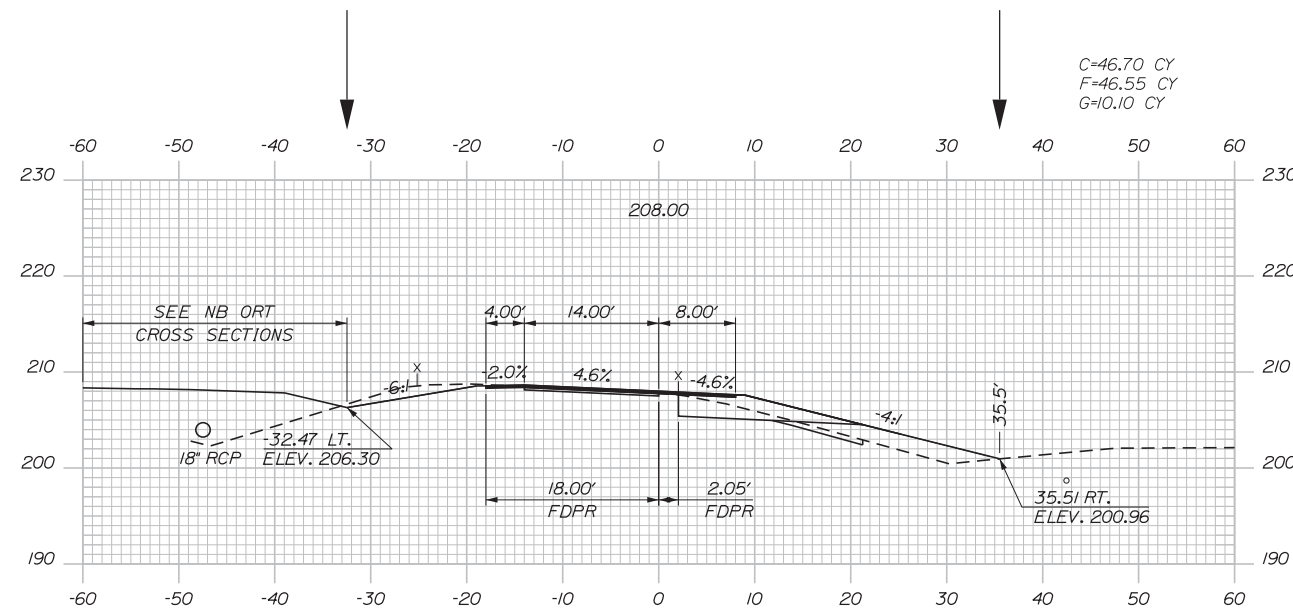

Designed by:



STANTEC CONSULTING SERVICES INC.  
 482 PAYNE ROAD  
 SCARBOROUGH, ME 04074  
 TEL (207) 887-3448  
 FAX (207) 883-3376



THE GOLD STAR  
 MEMORIAL HIGHWAY

INTERCHANGE 103  
 ORT CONVERSION  
 EXIT 51 NB ON RAMP  
 STA. 887+00.00 TO STA. 888+50.00

No.	Revision	By	Date

CONSULTANT PROJECT MANAGER: LAUREN MEEK, PE			
	By	Date	
Designed	PLP	3\20\19	Checked LEM 3\20\19
Drawn	EJB	3\20\19	In Charge of GAE 3\20\19

MTA PROJECT MANAGER: RALPH NORWOOD, IV, PE, PTOE

 


CONTRACT: 2019.04

SHEET NUMBER: XS-111

345 OF 503

Date: 3/20/2019

Filename: ... \00\HIGHWAY\MSTA\\_xsect.dgn

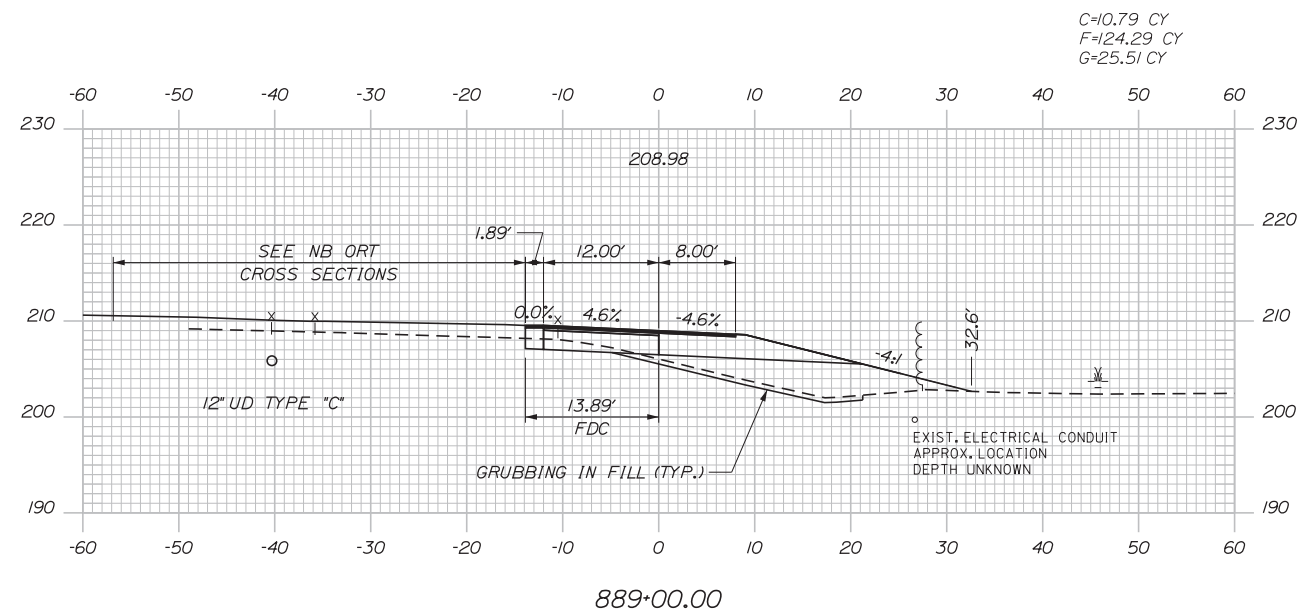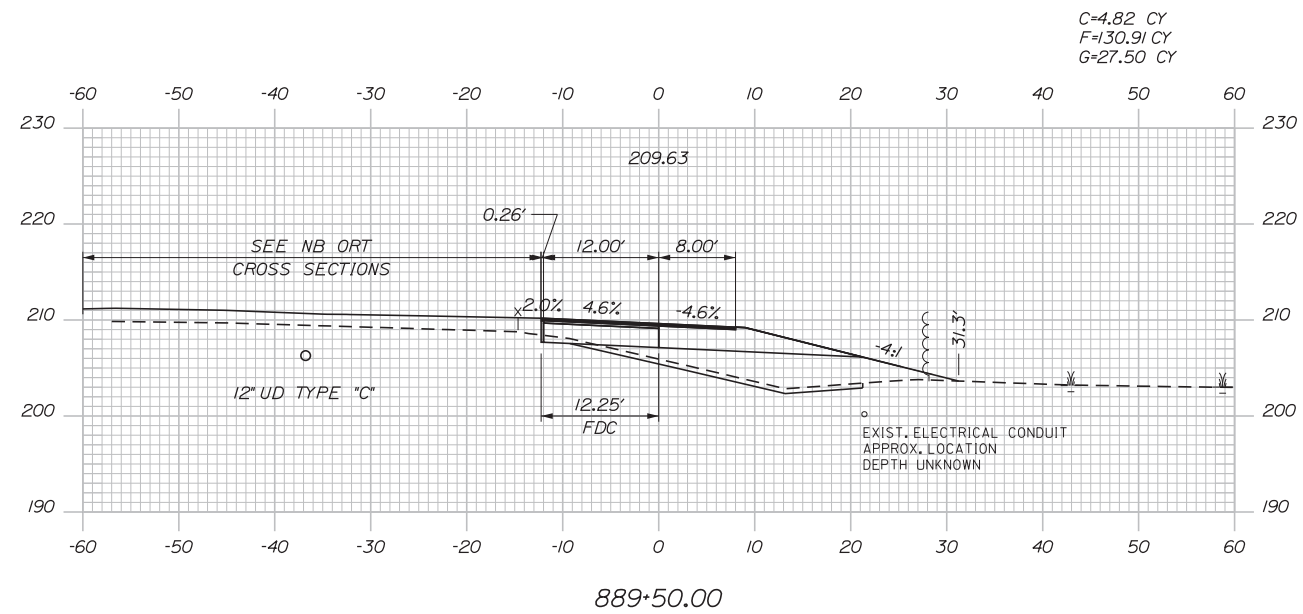

No.	Revision	By	Date

Designed by:

**Stantec**

CONSULTANT PROJECT MANAGER: LAUREN MEEK, PE

	By	Date		By	Date
Designed	PLP	3\20\19	Checked	LEM	3\20\19
Drawn	EJB	3\20\19	In Charge of	GAE	3\20\19

STANTEC CONSULTING SERVICES INC.  
 482 PAYNE ROAD  
 SCARBOROUGH, ME 04074  
 TEL (207) 887-3448  
 FAX (207) 883-3376

## THE GOLD STAR MEMORIAL HIGHWAY

MTA PROJECT MANAGER: RALPH NORWOOD, IV, PE, PTOE

INTERCHANGE 103  
 ORT CONVERSION  
 EXIT 51 NB ON RAMP  
 STA. 889+00.00 TO STA. 891+00.00

 




SHEET NUMBER: XS-112  
 CONTRACT: 2019.04  
 346 OF 503





Date: 3/20/2019

Filename: ...00\HIGHWAY\MSTA\\_xsect.dgn

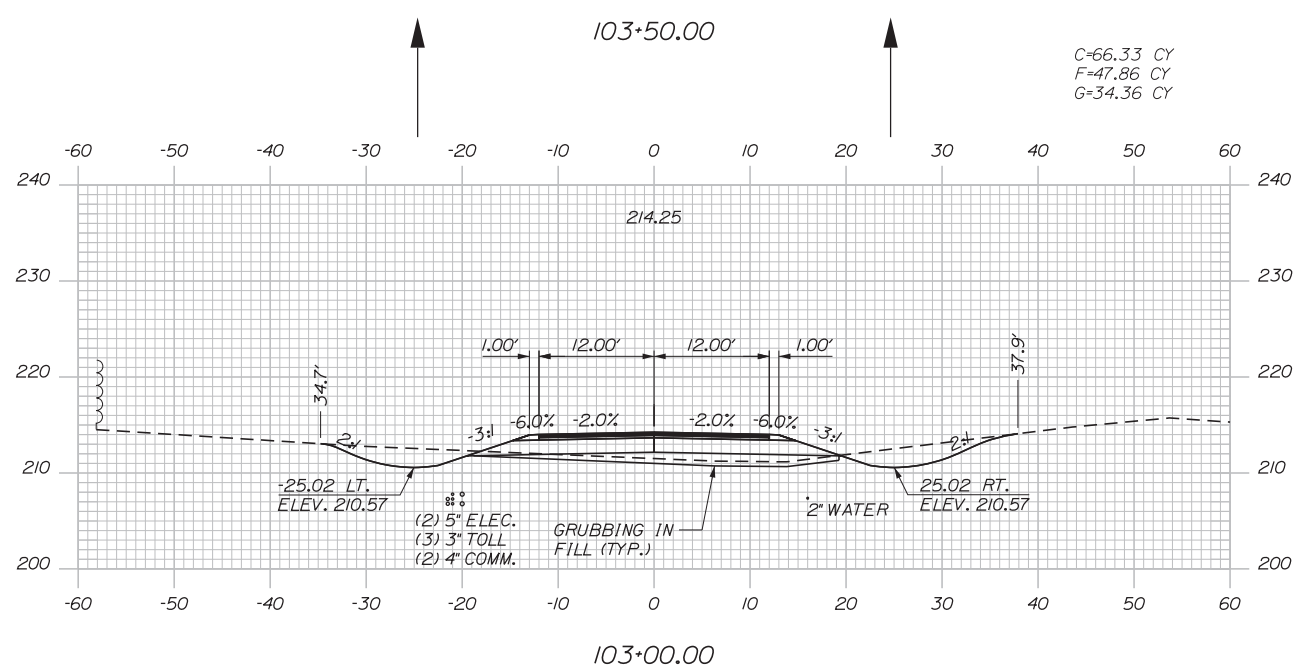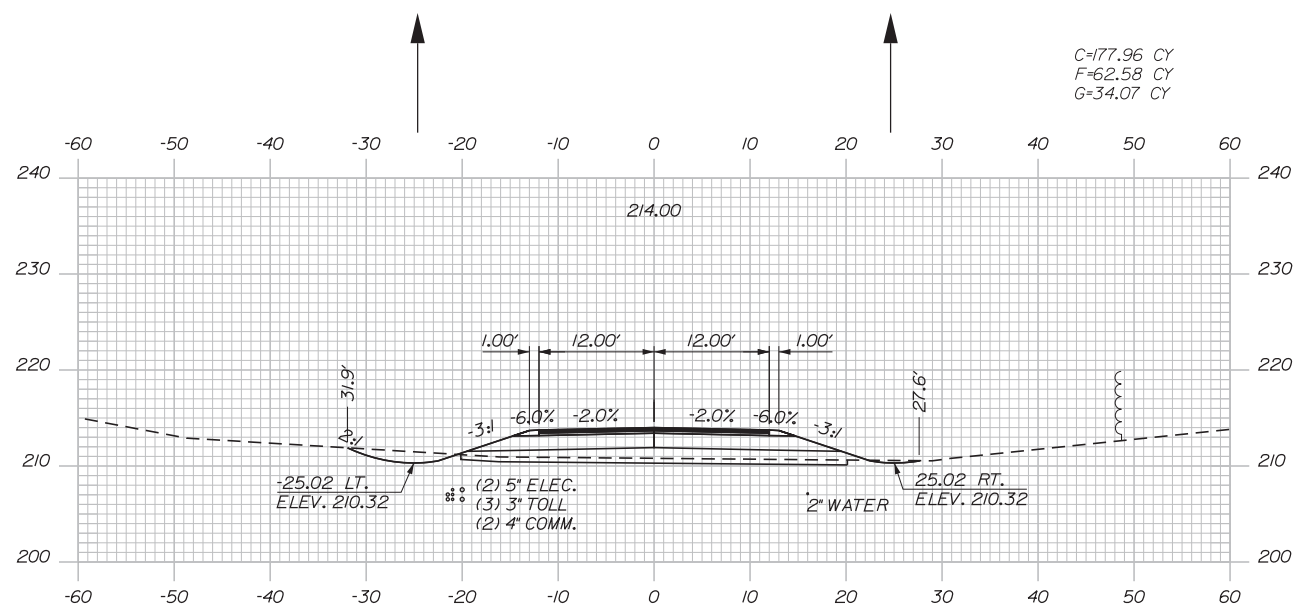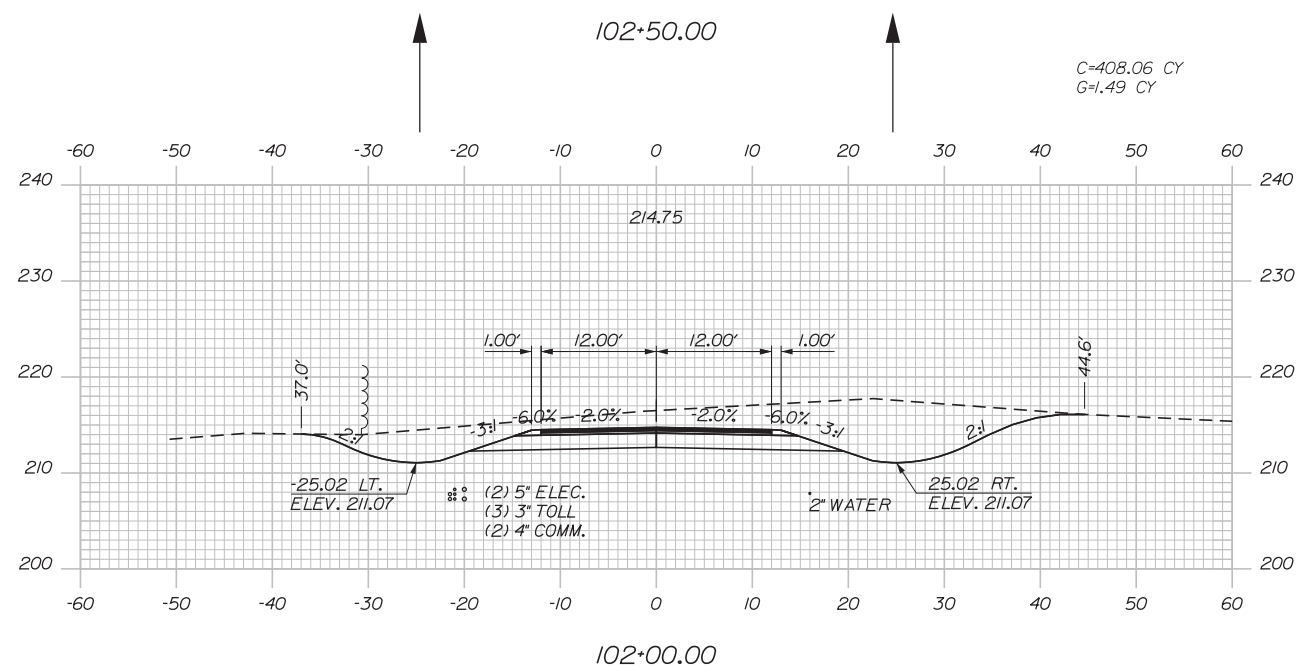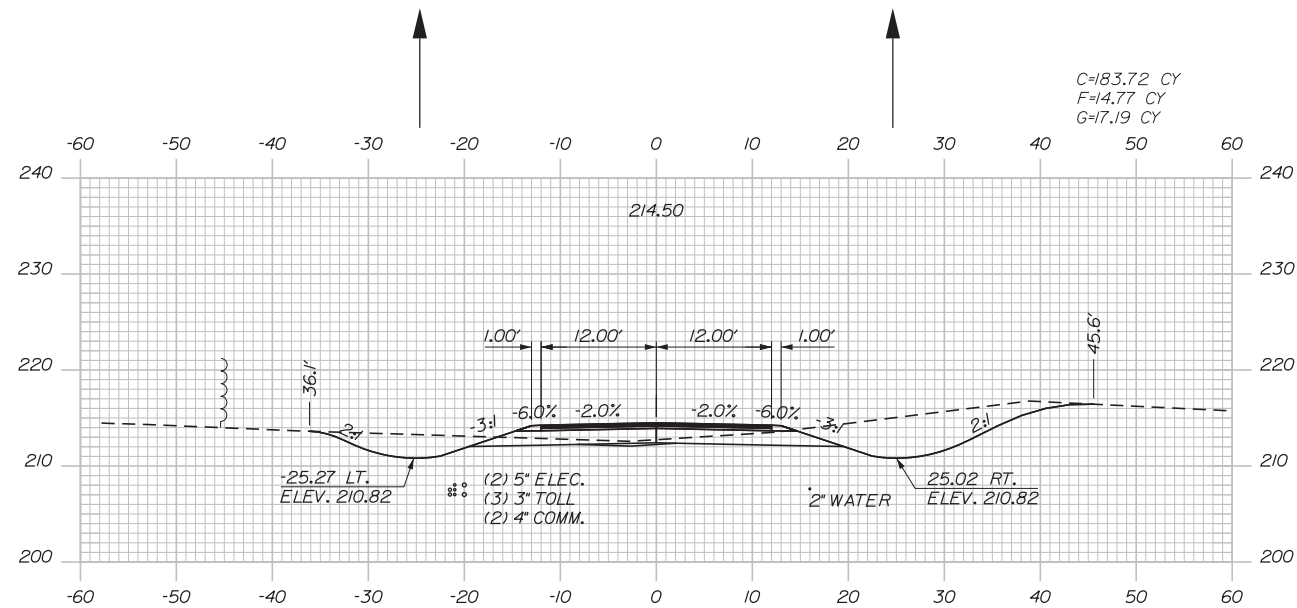

Designed by:



STANTEC CONSULTING SERVICES INC.  
482 PAYNE ROAD  
SCARBOROUGH, ME 04074  
TEL (207) 887-3448  
FAX (207) 883-3376



THE GOLD STAR  
MEMORIAL HIGHWAY

INTERCHANGE 103  
ORT CONVERSION  
ACCESS ROAD  
STA. 102+00.00 TO STA. 103+50.00

No.	Revision	By	Date

CONSULTANT PROJECT MANAGER: LAUREN MEEK, PE			
	By	Date	
Designed	PLP	3\20\19	Checked LEM 3\20\19
Drawn	EJB	3\20\19	In Charge of GAE 3\20\19

MTA PROJECT MANAGER: RALPH NORWOOD, IV, PE, PTOE

 




CONTRACT: 2019.04

SHEET NUMBER: XS-114

348 OF 503

Date: 3/20/2019

Filename: ...00\HIGHWAY\MSTA\\_xsect.dgn

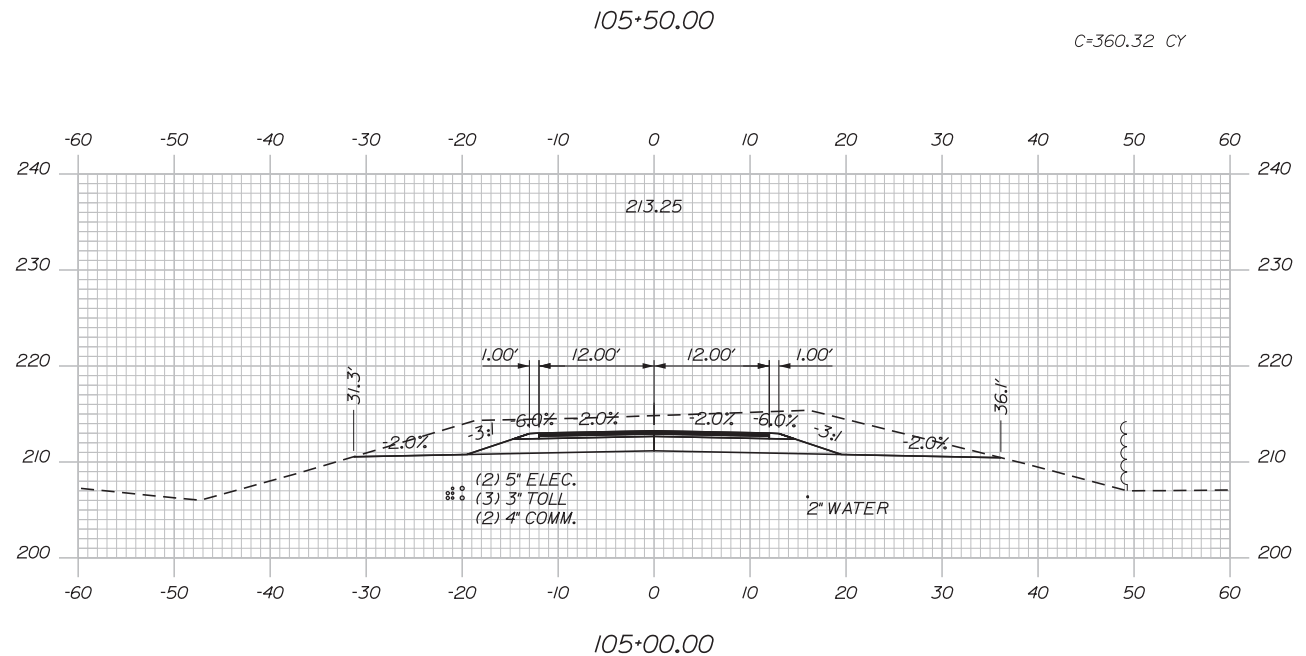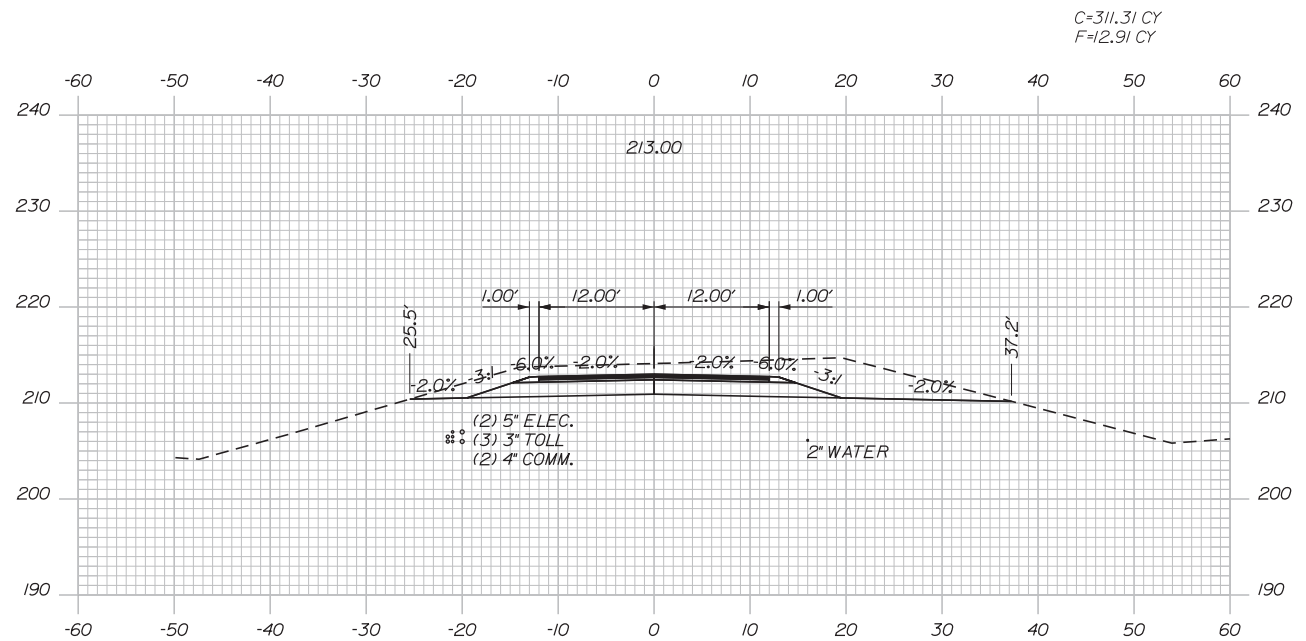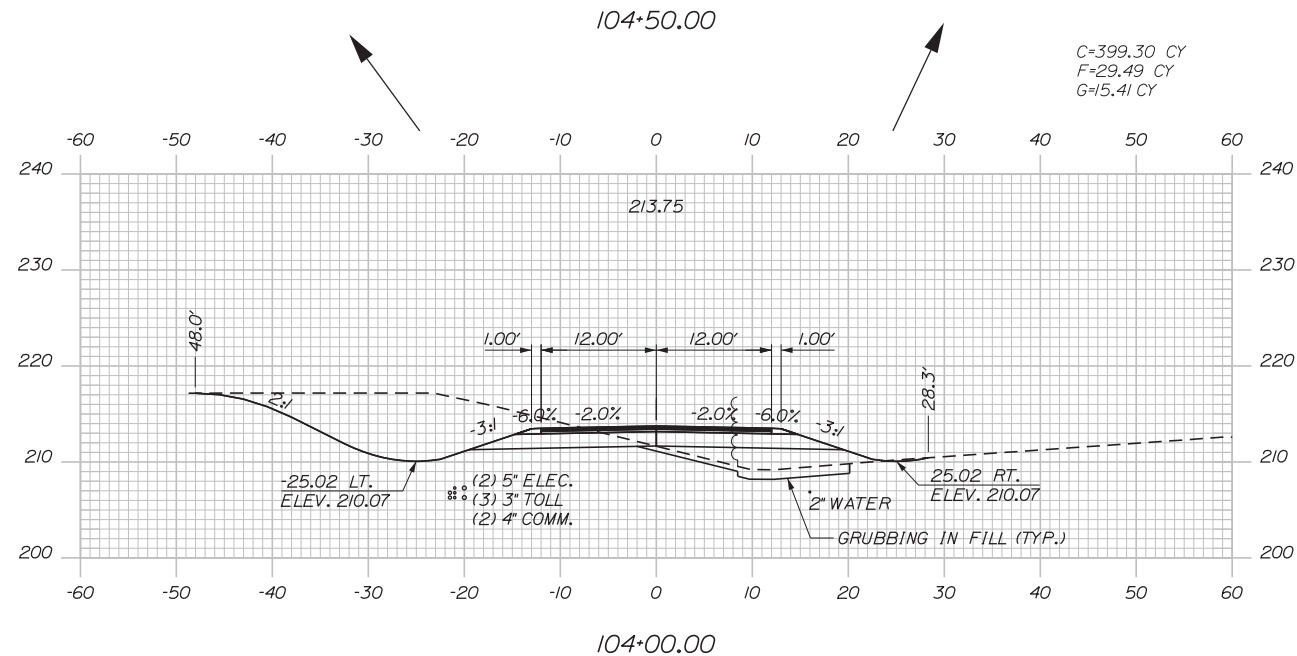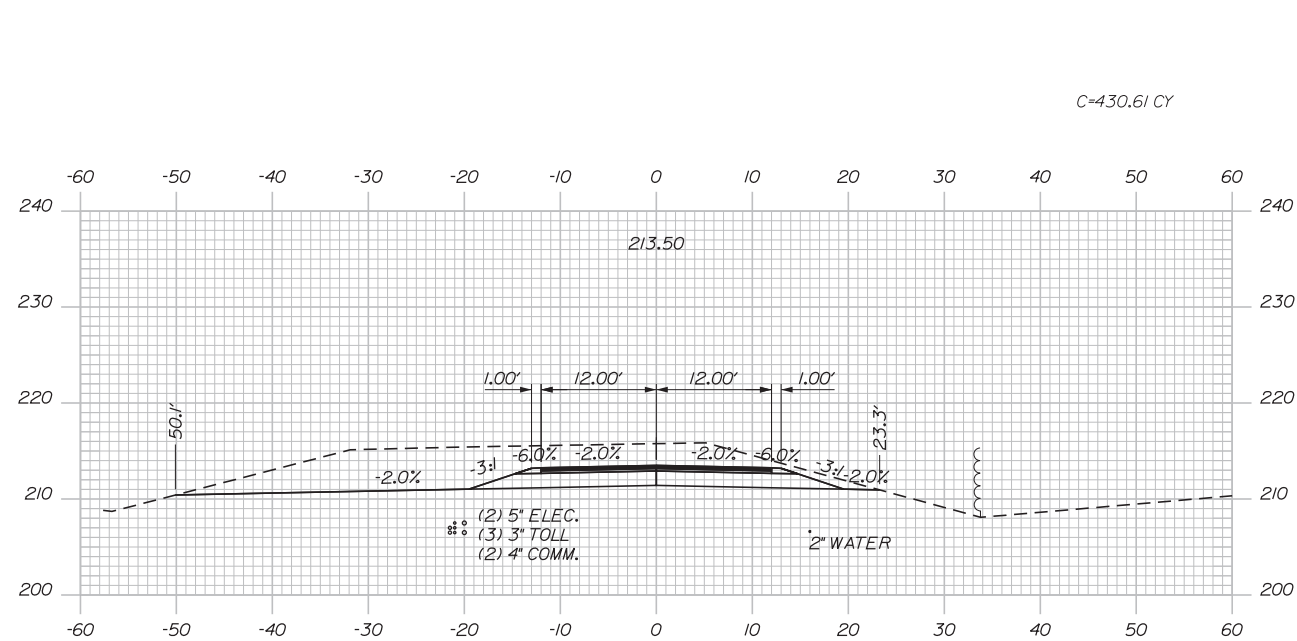

Designed by:



STANTEC CONSULTING SERVICES INC.  
482 PAYNE ROAD  
SCARBOROUGH, ME 04074  
TEL (207) 887-3448  
FAX (207) 883-3376



THE GOLD STAR  
MEMORIAL HIGHWAY

INTERCHANGE 103  
ORT CONVERSION  
ACCESS ROAD  
STA. 104+00.00 TO STA. 105+50.00

No.	Revision	By	Date

CONSULTANT PROJECT MANAGER: LAUREN MEEK, PE			
	By	Date	
Designed	PLP	3\20\19	Checked LEM 3\20\19
Drawn	EJB	3\20\19	In Charge of GAE 3\20\19

MTA PROJECT MANAGER: RALPH NORWOOD, IV, PE, PTOE

 




CONTRACT: 2019.04

SHEET NUMBER: XS-115

349 OF 503

Date: 3/20/2019

Filename: ...00\HIGHWAY\MSTA\\_xsect.dgn

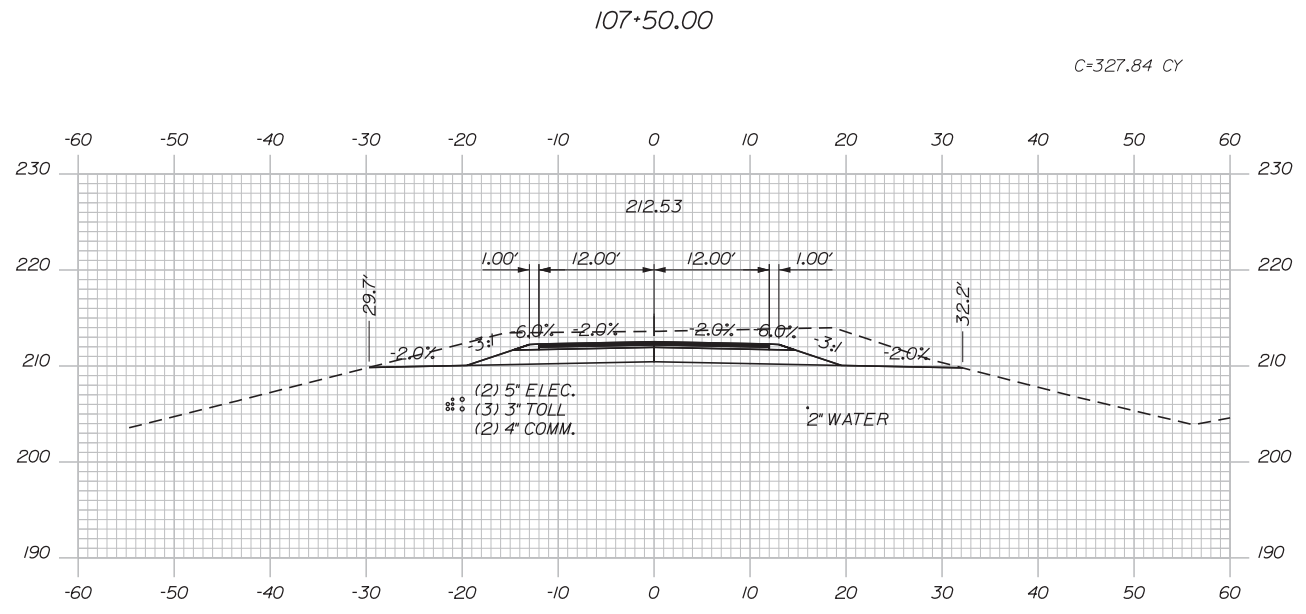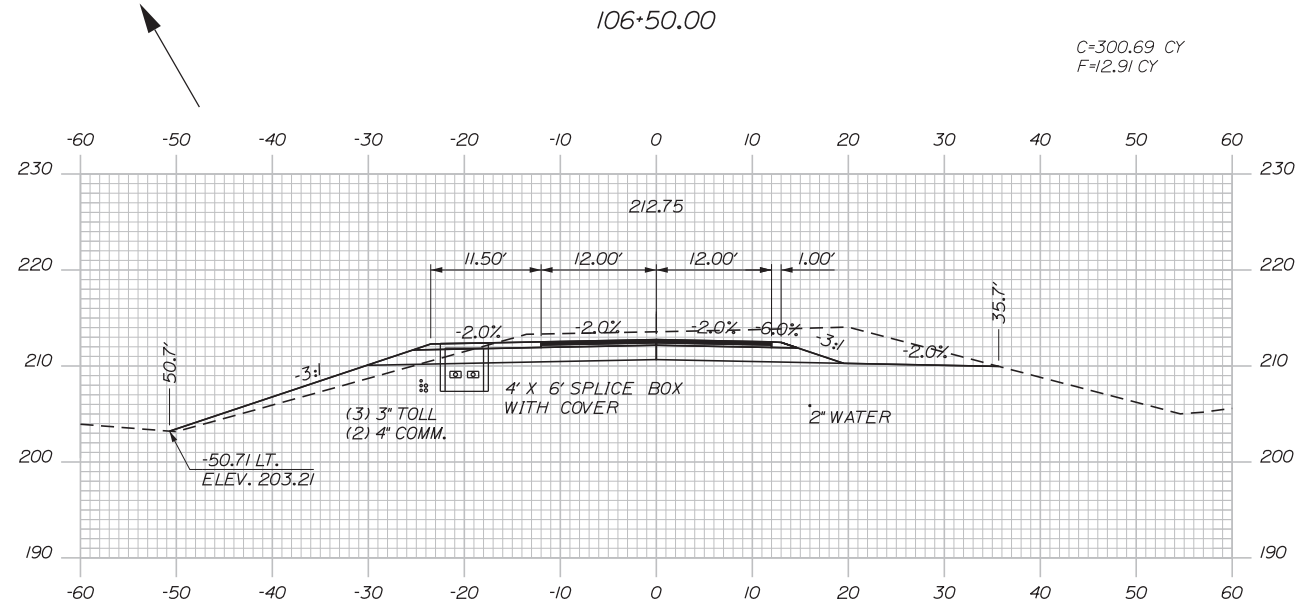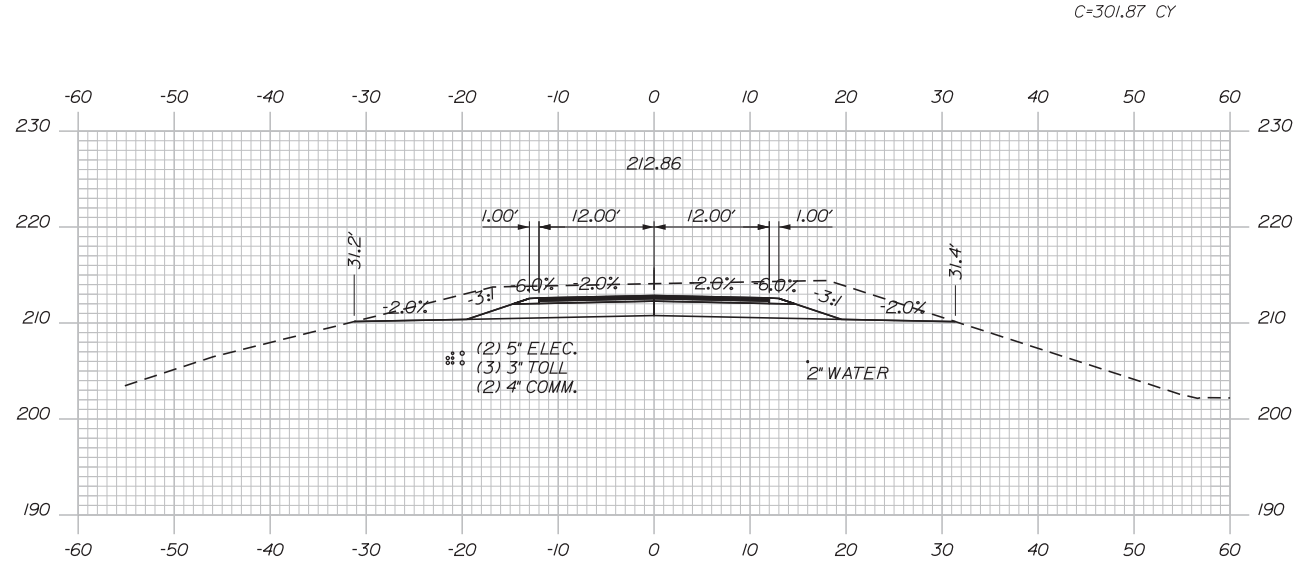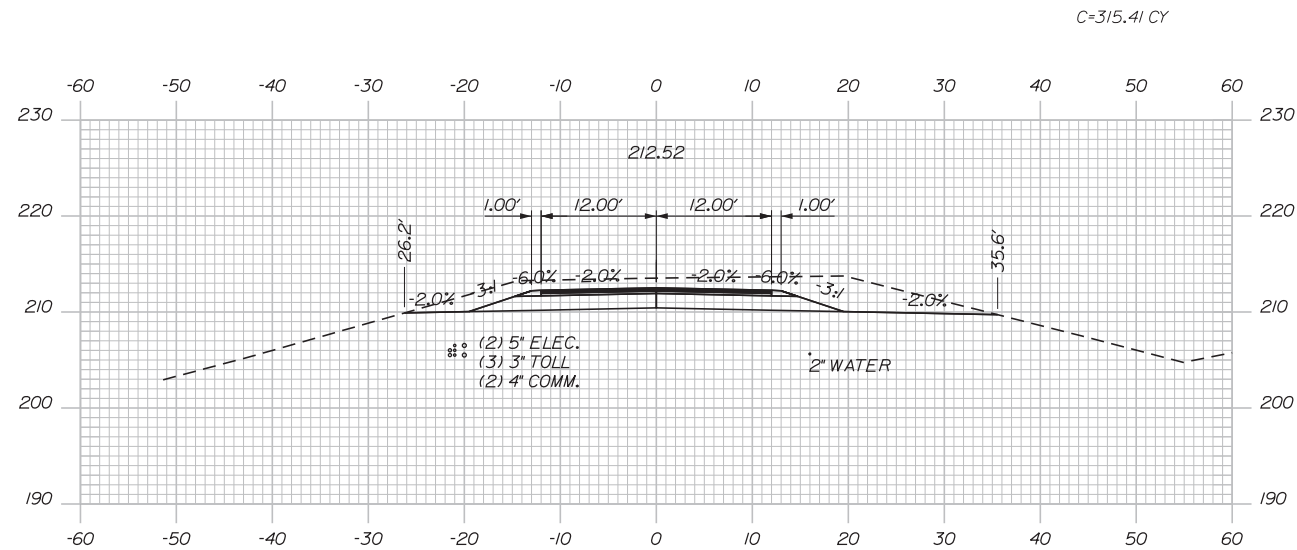

Designed by:

**Stantec**

CONSULTANT PROJECT MANAGER: LAUREN MEEK, PE

No.	Revision	By	Date

	By	Date		By	Date
Designed	PLP	3\20\19	Checked	LEM	3\20\19
Drawn	EJB	3\20\19	In Charge of	GAE	3\20\19

STANTEC CONSULTING SERVICES INC.  
 482 PAYNE ROAD  
 SCARBOROUGH, ME 04074  
 TEL (207) 887-3448  
 FAX (207) 883-3376

**MAINE TURNPIKE**

**THE GOLD STAR MEMORIAL HIGHWAY**






MTA PROJECT MANAGER: RALPH NORWOOD, IV, PE, PTOE

INTERCHANGE 103  
 ORT CONVERSION  
 ACCESS ROAD  
 STA. 106+00.00 TO STA. 107+50.00

SHEET NUMBER: XS-116  
 CONTRACT: 2019.04  
 350 OF 503

Date: 3/20/2019

 Filename: ...00\HIGHWAY\MSTA\\_xsect.dgn

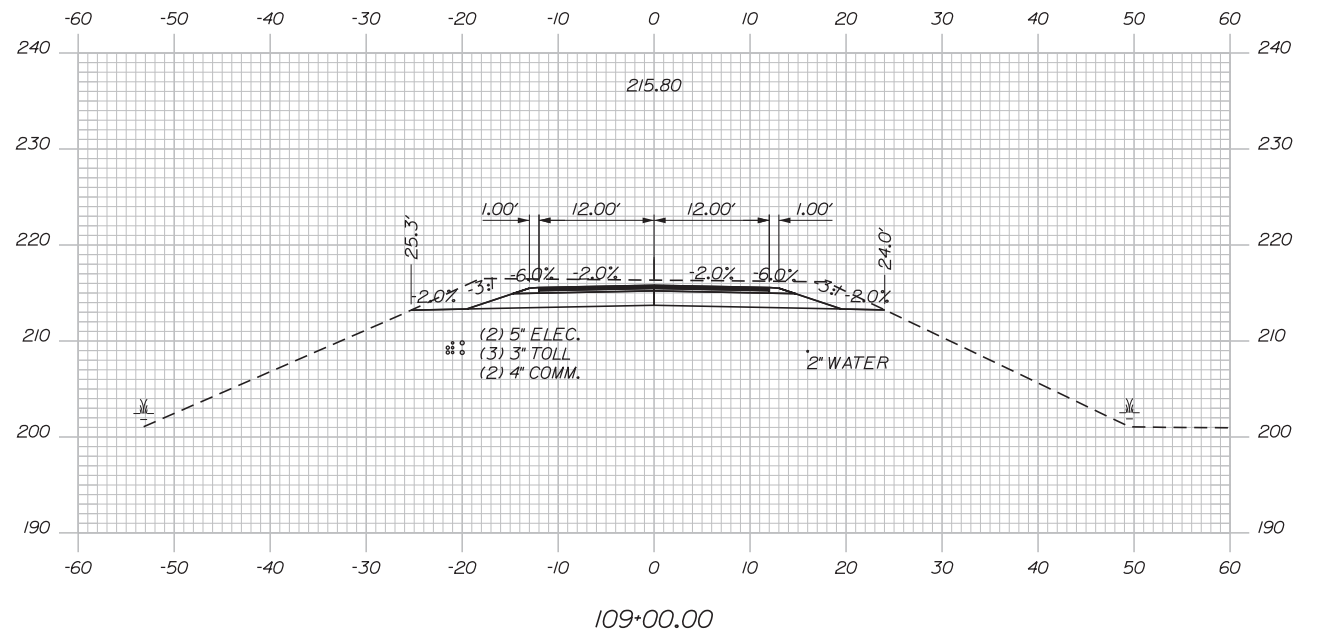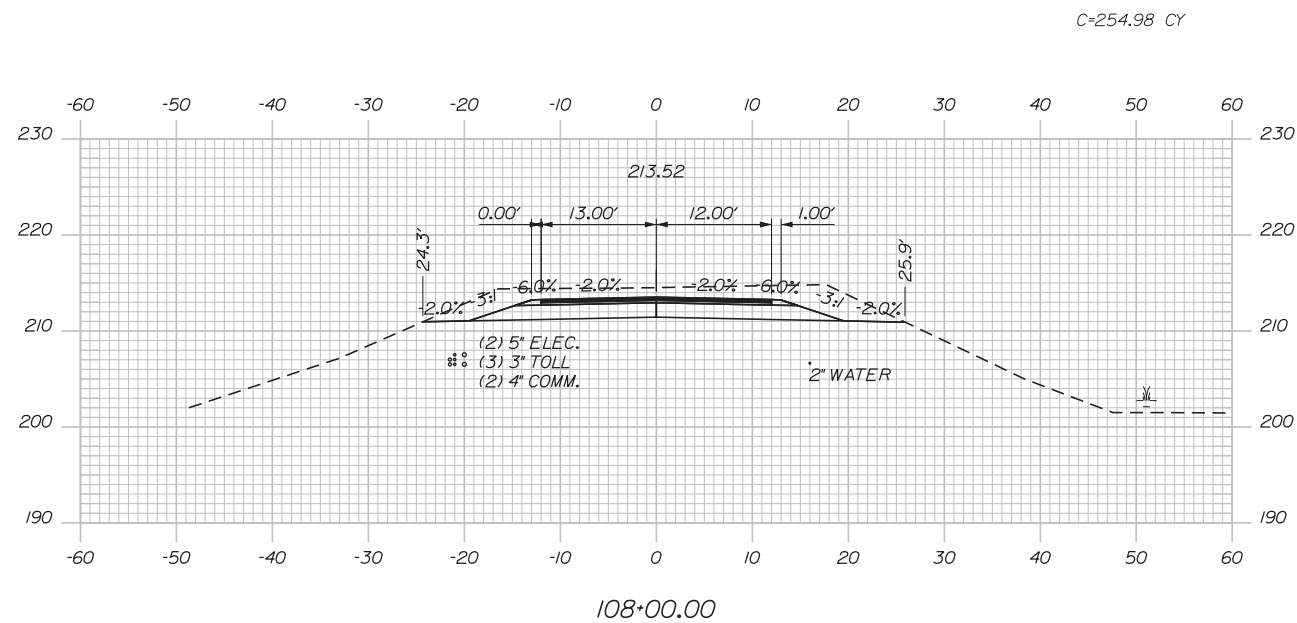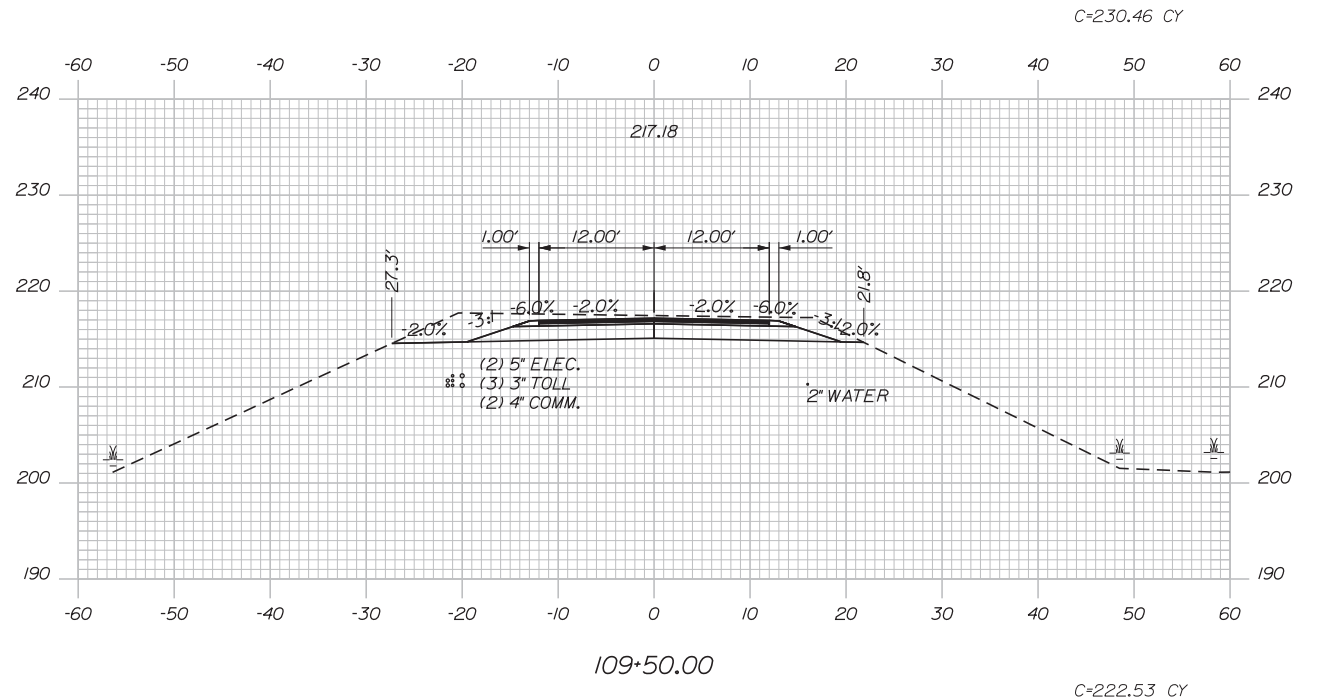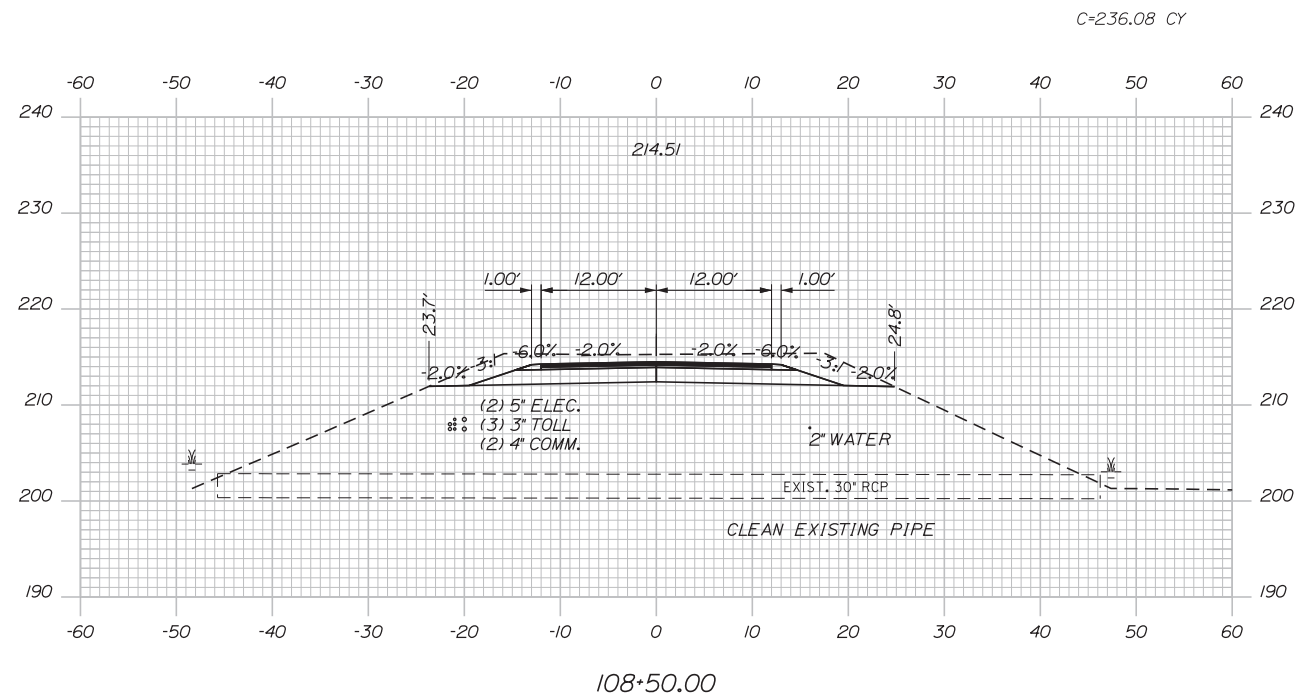

Designed by:



STANTEC CONSULTING SERVICES INC.  
482 PAYNE ROAD  
SCARBOROUGH, ME 04074  
TEL (207) 887-3448  
FAX (207) 883-3376



THE GOLD STAR  
MEMORIAL HIGHWAY

INTERCHANGE 103  
ORT CONVERSION  
ACCESS ROAD  
STA. 108+00.00 TO STA. 109+50.00

No.	Revision	By	Date

CONSULTANT PROJECT MANAGER: LAUREN MEEK, PE			
	By	Date	
Designed	PLP	3\20\19	Checked LEM 3\20\19
Drawn	EJB	3\20\19	In Charge of GAE 3\20\19

MTA PROJECT MANAGER: RALPH NORWOOD, IV, PE, PTOE

 




CONTRACT: 2019.04

SHEET NUMBER: XS-117

351 OF 503

Date: 3/20/2019

Filename: ...00\HIGHWAY\MSTA\\_xsect.dgn

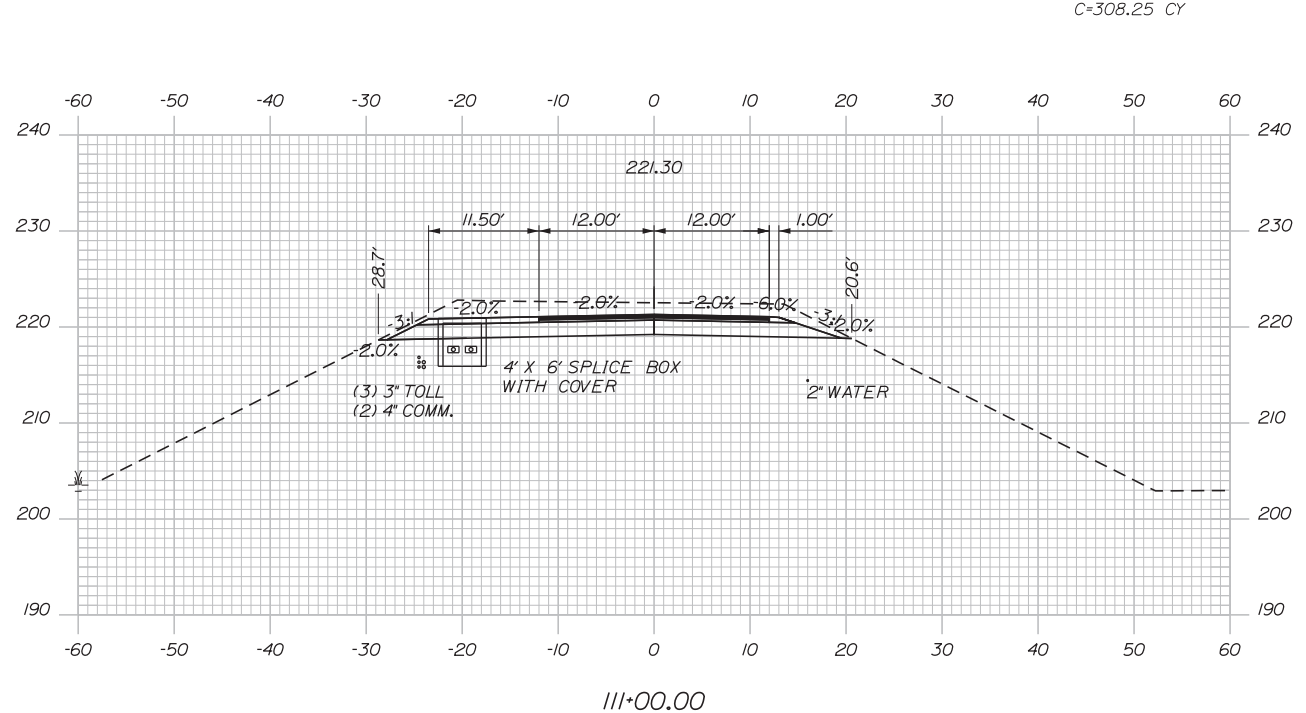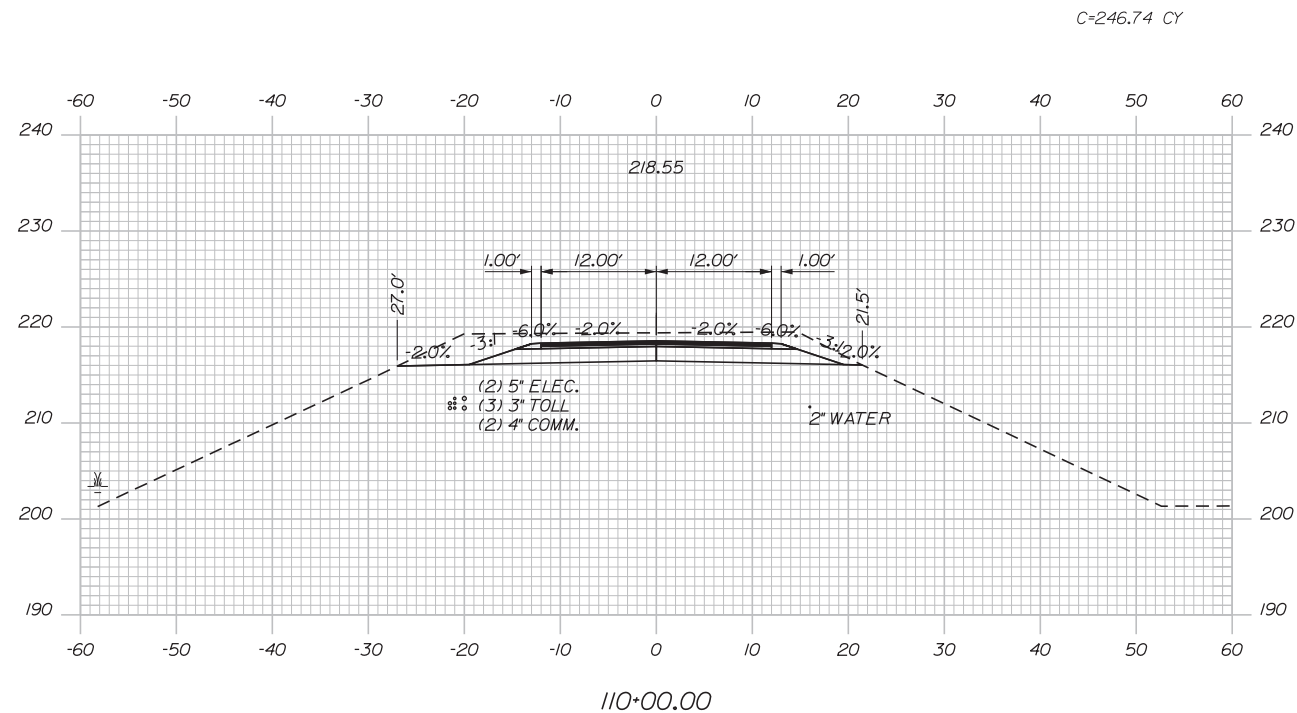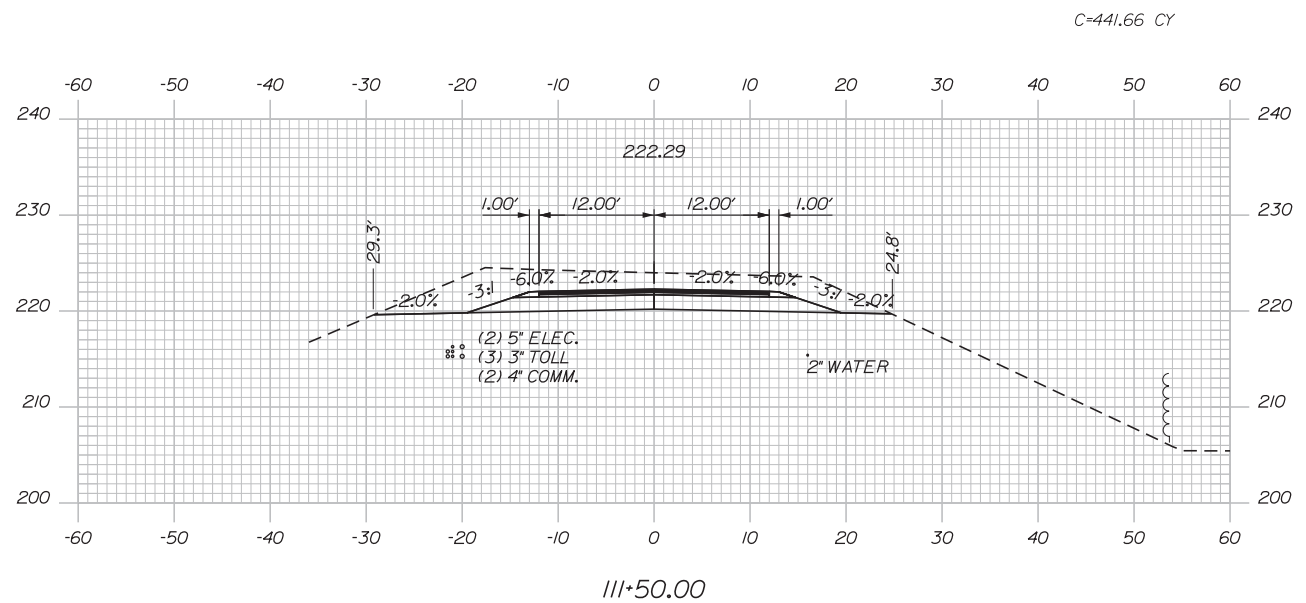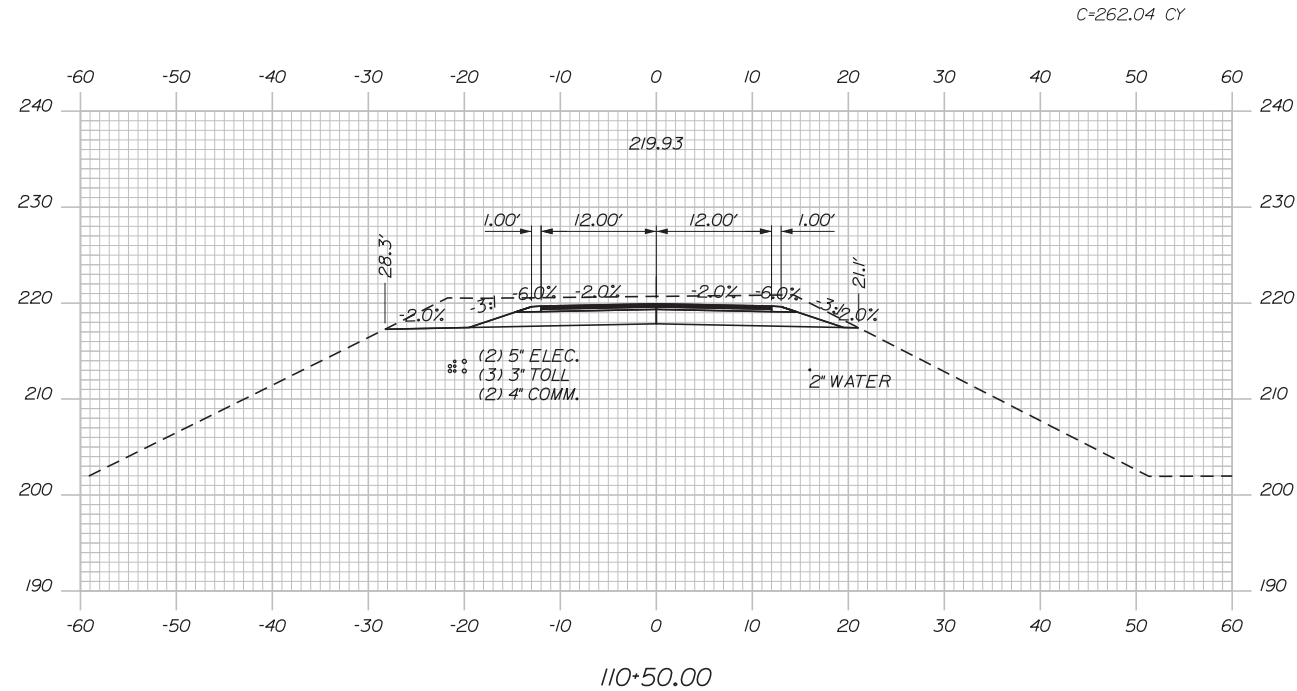

Designed by:



STANTEC CONSULTING SERVICES INC.  
482 PAYNE ROAD  
SCARBOROUGH, ME 04074  
TEL (207) 887-3448  
FAX (207) 883-3376



THE GOLD STAR  
MEMORIAL HIGHWAY

INTERCHANGE 103  
ORT CONVERSION  
ACCESS ROAD  
STA. 110+00.00 TO STA. 111+50.00

No.	Revision	By	Date

CONSULTANT PROJECT MANAGER: LAUREN MEEK, PE			
Designed	By	Date	Checked
	PLP	3\20\19	LEM
Drawn	By	Date	In Charge of
	EJB	3\20\19	GAE

MTA PROJECT MANAGER: RALPH NORWOOD, IV, PE, PTOE

CONTRACT: 2019.04

SHEET NUMBER: XS-118


352 OF 503



Date: 3/20/2019


Filename: ...00\HIGHWAY\MSTA\...xsect.dgn

C=1062.37 CY  
F=340.21 CY  
G=19.07 CY

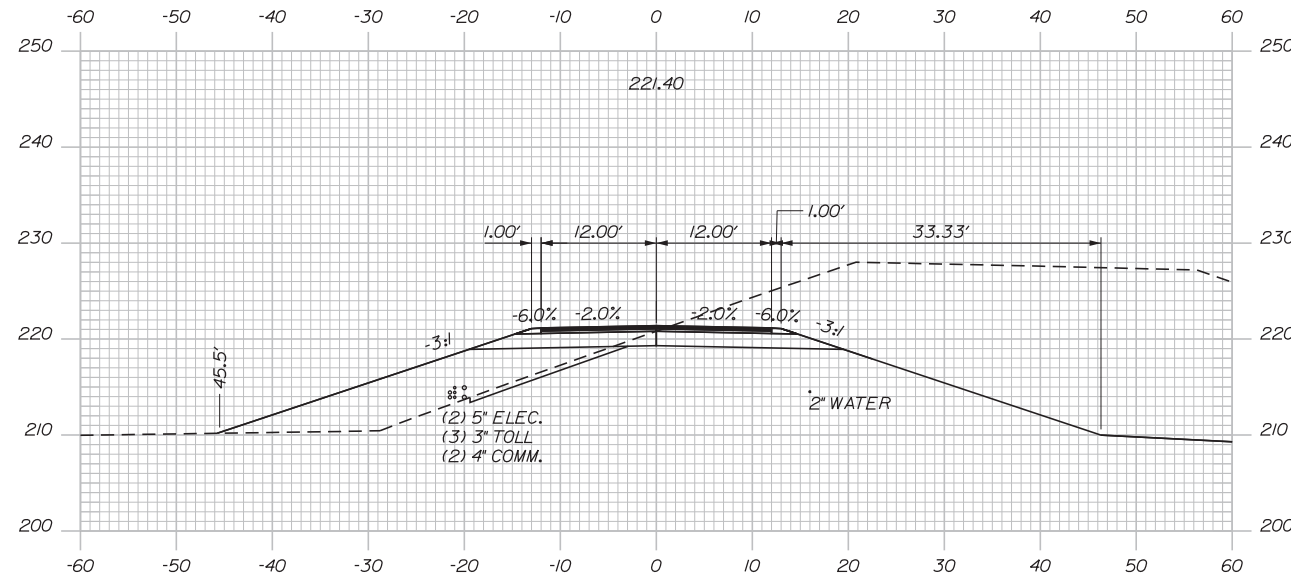


112+50.00

C=930.86 CY  
F=118.35 CY  
G=7.71 CY

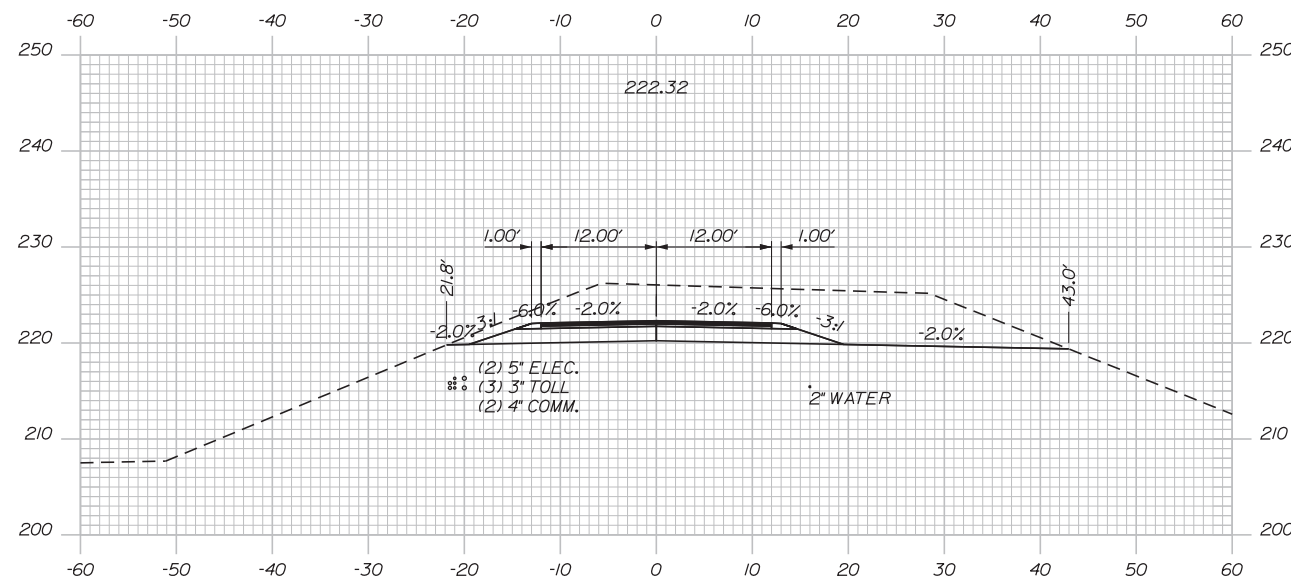


112+00.00

F=391.21 CY  
G=33.56 CY

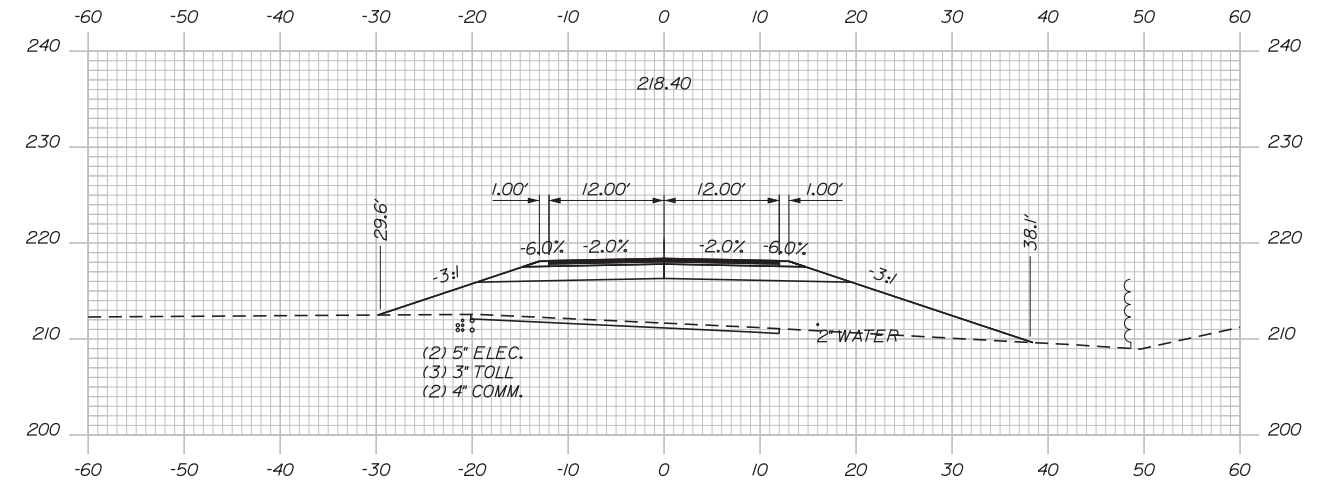


113+50.00

C=403.40 CY  
F=436.69 CY  
G=26.26 CY

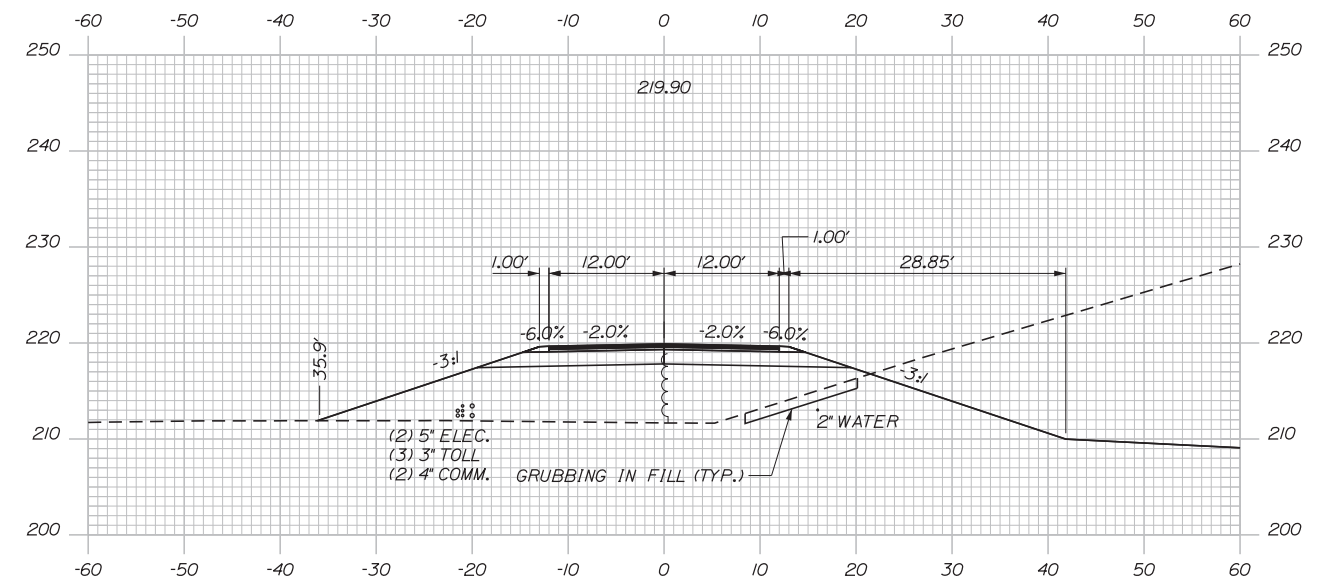

113+00.00

 

No.	Revision	By	Date

Designed by:



STANTEC CONSULTING SERVICES INC.  
482 PAYNE ROAD  
SCARBOROUGH, ME 04074  
TEL (207) 887-3448  
FAX (207) 883-3376



THE GOLD STAR  
MEMORIAL HIGHWAY

INTERCHANGE 103  
ORT CONVERSION  
ACCESS ROAD  
STA. 112+00.00 TO STA. 113+50.00

CONSULTANT PROJECT MANAGER: LAUREN MEEK, PE

	By	Date		By	Date
Designed	PLP	3\20\19	Checked	LEM	3\20\19
Drawn	EJB	3\20\19	In Charge of	GAE	3\20\19

MTA PROJECT MANAGER: RALPH NORWOOD, IV, PE, PTOE

 






CONTRACT: 2019.04

SHEET NUMBER: XS-119

353 OF 503

Date: 3/20/2019

Filename: ...00\HIGHWAY\MSTA\\_xsect.dgn

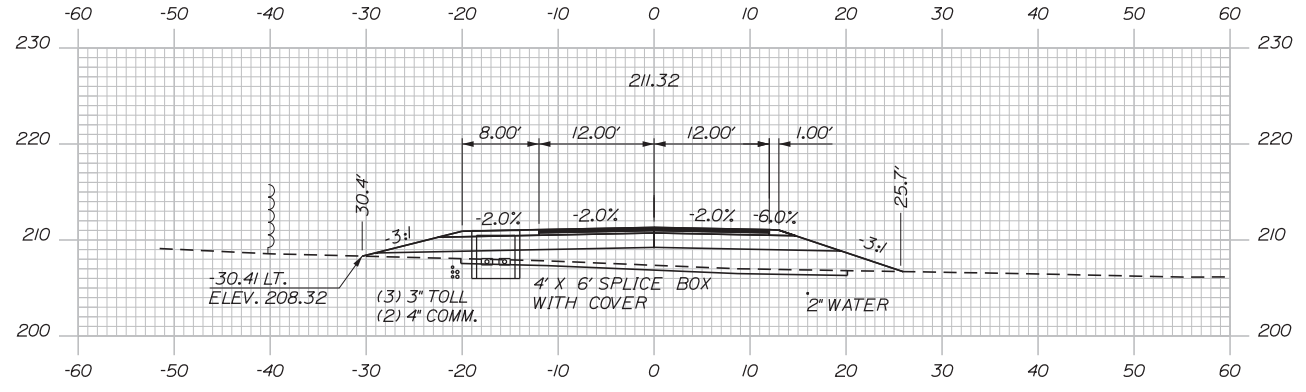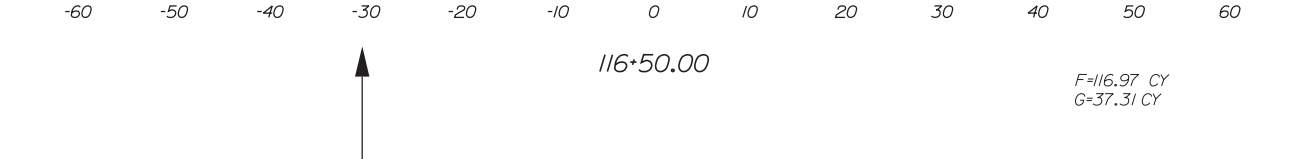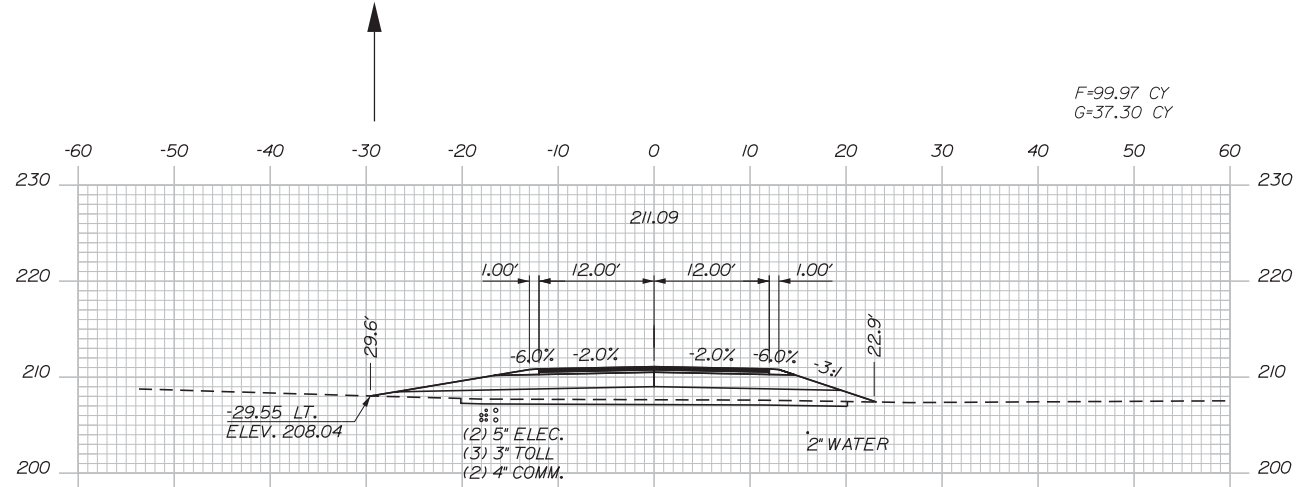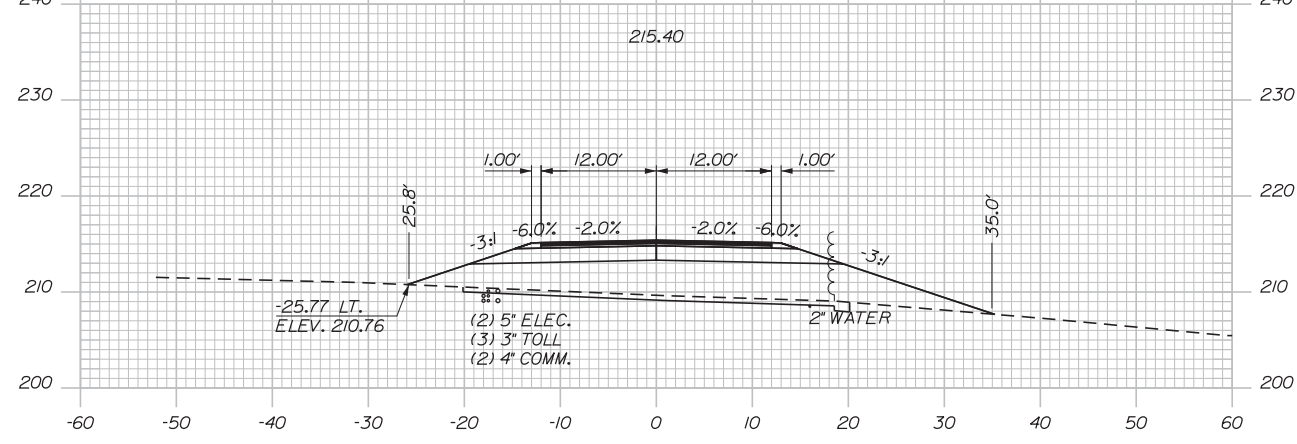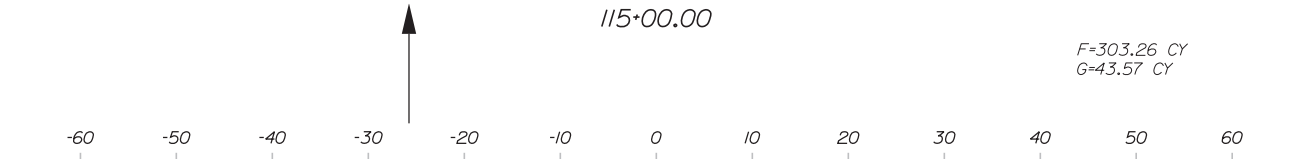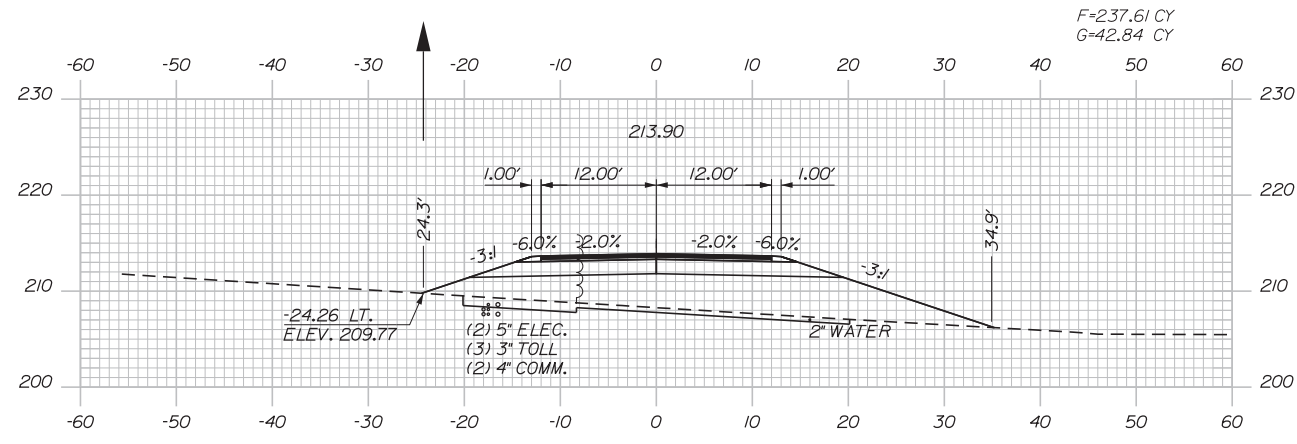

Designed by:

**Stantec**

CONSULTANT PROJECT MANAGER: LAUREN MEEK, PE

No.	Revision	By	Date

	By	Date		By	Date
Designed	PLP	3\20\19	Checked	LEM	3\20\19
Drawn	EJB	3\20\19	In Charge of	GAE	3\20\19

STANTEC CONSULTING SERVICES INC.  
 482 PAYNE ROAD  
 SCARBOROUGH, ME 04074  
 TEL (207) 887-3448  
 FAX (207) 883-3376

**MAINE TURNPIKE**

**THE GOLD STAR MEMORIAL HIGHWAY**

MTA PROJECT MANAGER: RALPH NORWOOD, IV, PE, PTOE


INTERCHANGE 103  
 ORT CONVERSION  
 ACCESS ROAD  
 STA. 114+00.00 TO STA. 116+50.00

SHEET NUMBER: XS-120  
 354 OF 503

CONTRACT: 2019.04


Date: 3/20/2019

Filename: ...00\HIGHWAY\MSTA\\_xsect.dgn

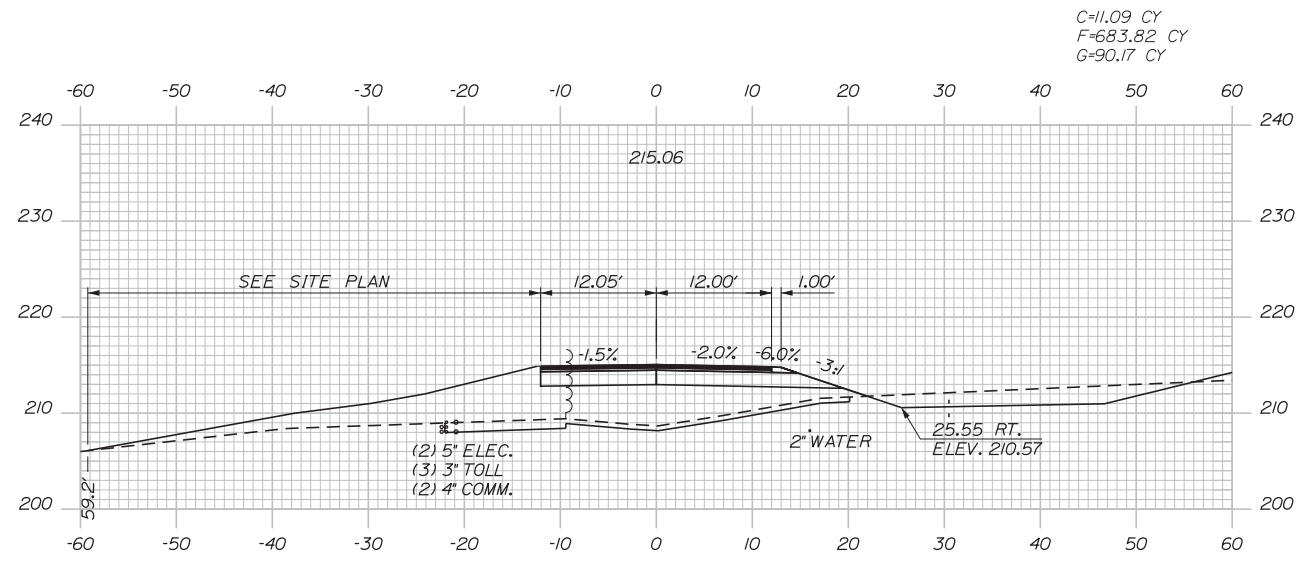


118+00.00

C=11.09 CY  
F=683.82 CY  
G=90.17 CY

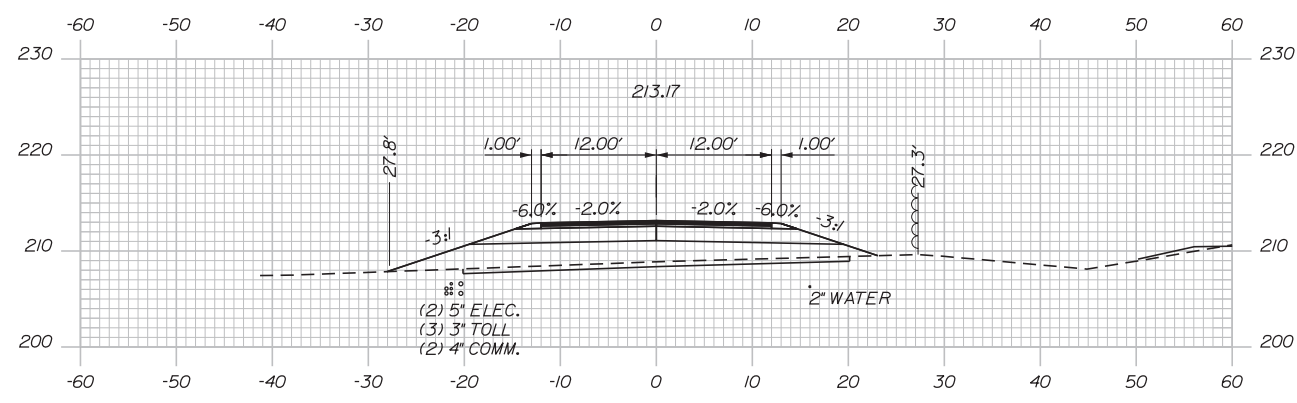


117+50.00

F=134.69 CY  
G=37.31 CY

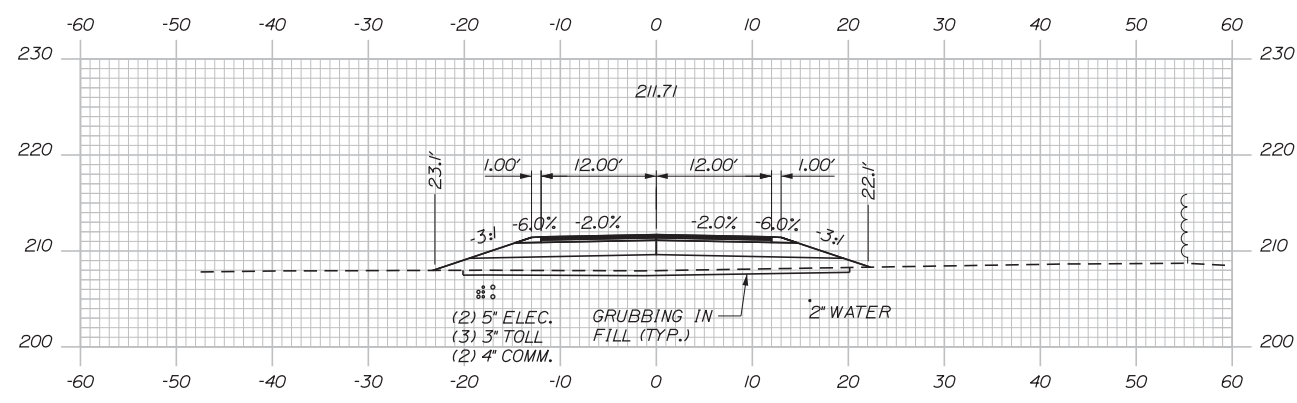

117+00.00

 

Designed by:



STANTEC CONSULTING SERVICES INC.  
482 PAYNE ROAD  
SCARBOROUGH, ME 04074  
TEL (207) 887-3448  
FAX (207) 883-3376



THE GOLD STAR  
MEMORIAL HIGHWAY

INTERCHANGE 103  
ORT CONVERSION  
ACCESS ROAD  
STA. 117+00.00 TO STA. 118+00.00

No.	Revision	By	Date

CONSULTANT PROJECT MANAGER: LAUREN MEEK, PE					
Designed	PLP	3\20\19	Checked	LEM	3\20\19
Drawn	EJB	3\20\19	In Charge of	GAE	3\20\19

MTA PROJECT MANAGER: RALPH NORWOOD, IV, PE, PTOE

 


CONTRACT: 2019.04

SHEET NUMBER: XS-121

355 OF 503

Date: 3/20/2019

Filename: ...00\HIGHWAY\MSTA\\_xsect.dgn

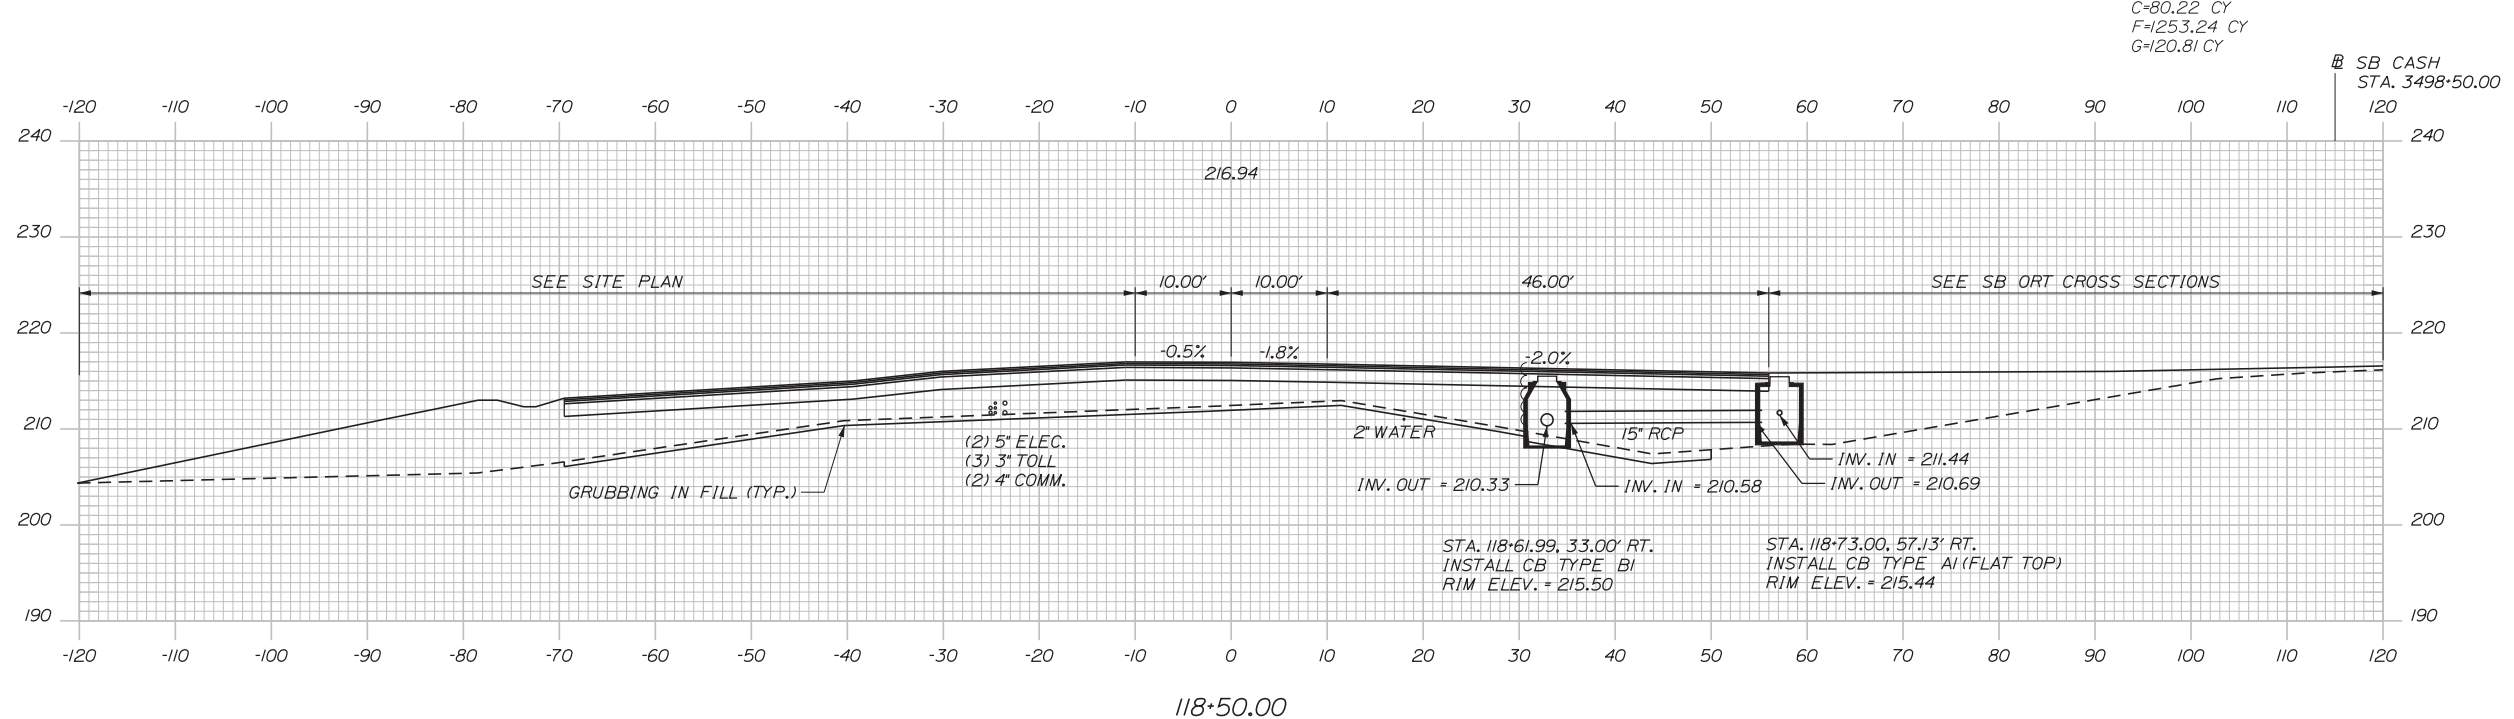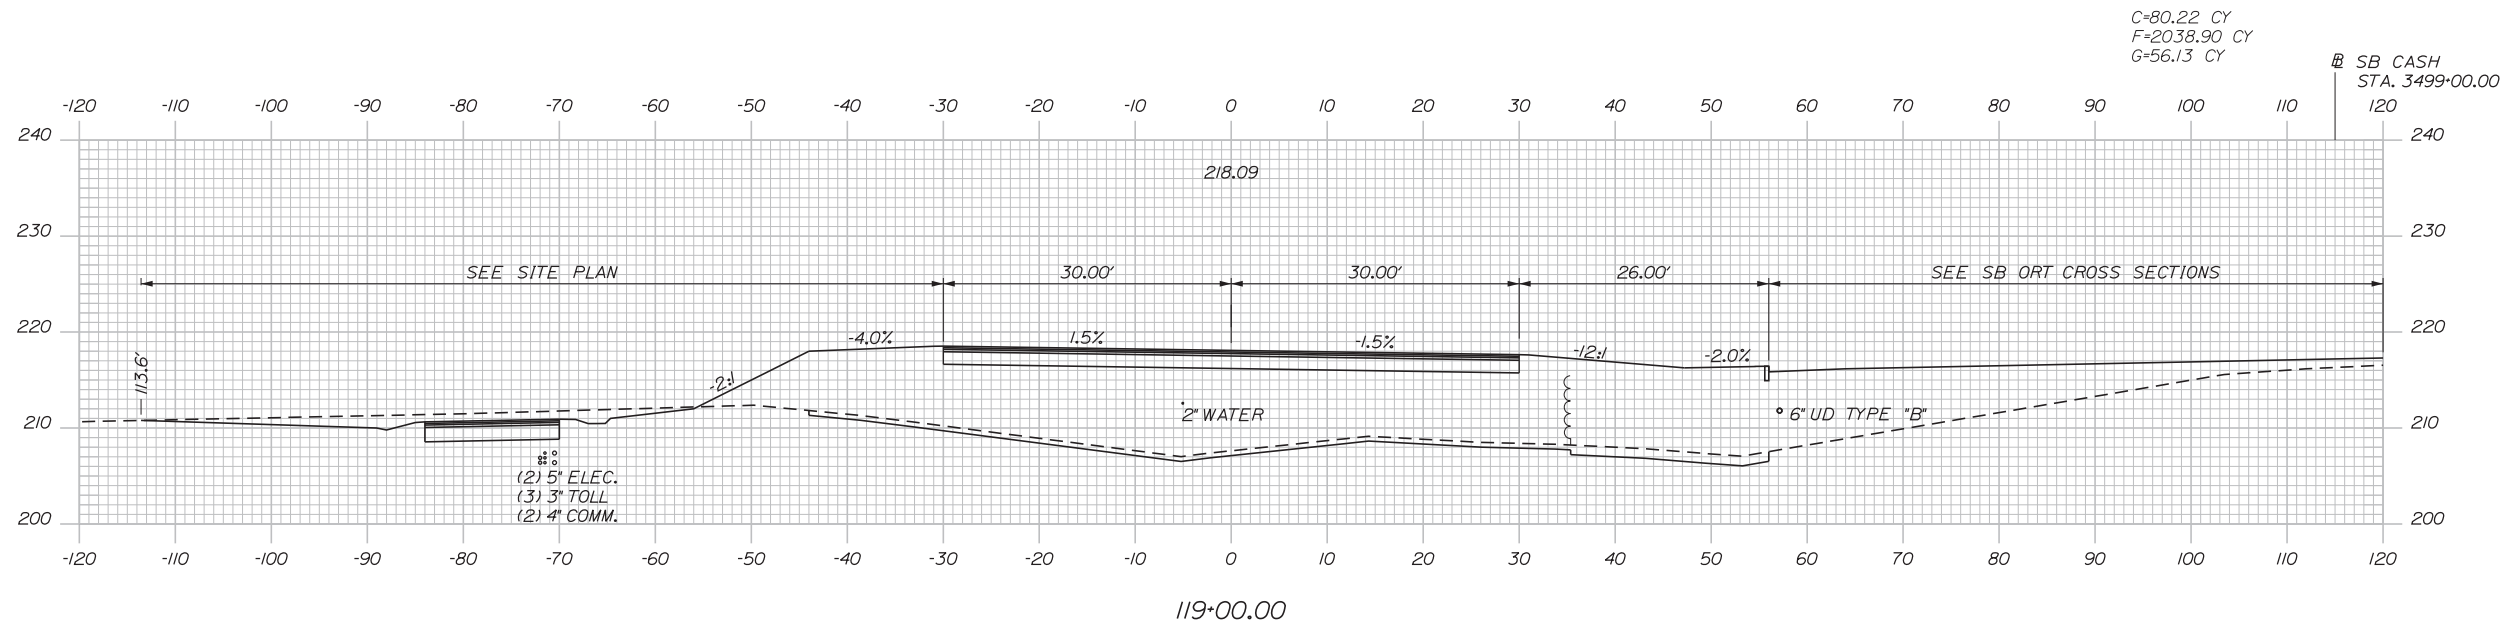

Designed by:

**Stantec**

CONSULTANT PROJECT MANAGER: LAUREN MEEK, PE

No.	Revision	By	Date

	By	Date		By	Date
Designed	PLP	3\20\19	Checked	LEM	3\20\19
Drawn	EJB	3\20\19	In Charge of	GAE	3\20\19

STANTEC CONSULTING SERVICES INC.  
 482 PAYNE ROAD  
 SCARBOROUGH, ME 04074  
 TEL (207) 887-3448  
 FAX (207) 883-3376

**MAINE TURNPIKE**

**THE GOLD STAR MEMORIAL HIGHWAY**

MTA PROJECT MANAGER: RALPH NORWOOD, IV, PE, PTOE




INTERCHANGE 103  
 ORT CONVERSION  
 ACCESS ROAD  
 STA. 118+50.00 TO STA. 119+00.00

SHEET NUMBER: XS-122  
 356 OF 503

CONTRACT: 2019.04

Date: 3/20/2019

 Filename: ...:\00\HIGHWAY\MSTA\\_xsect.dgn

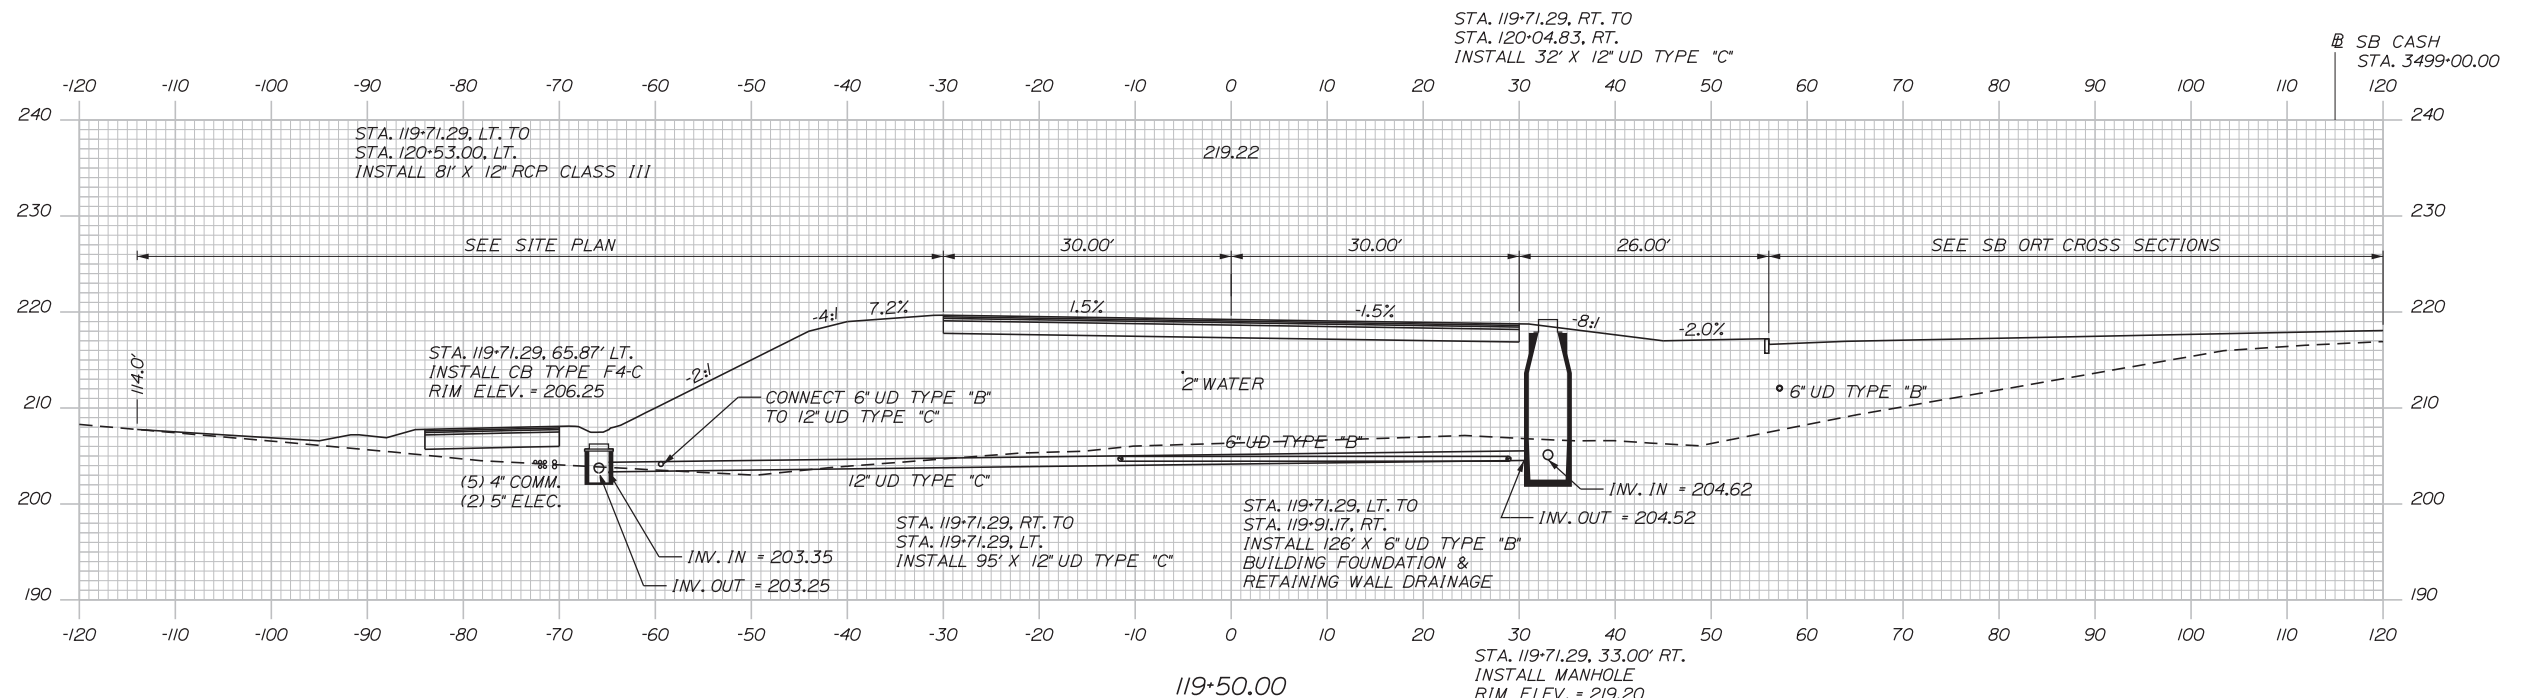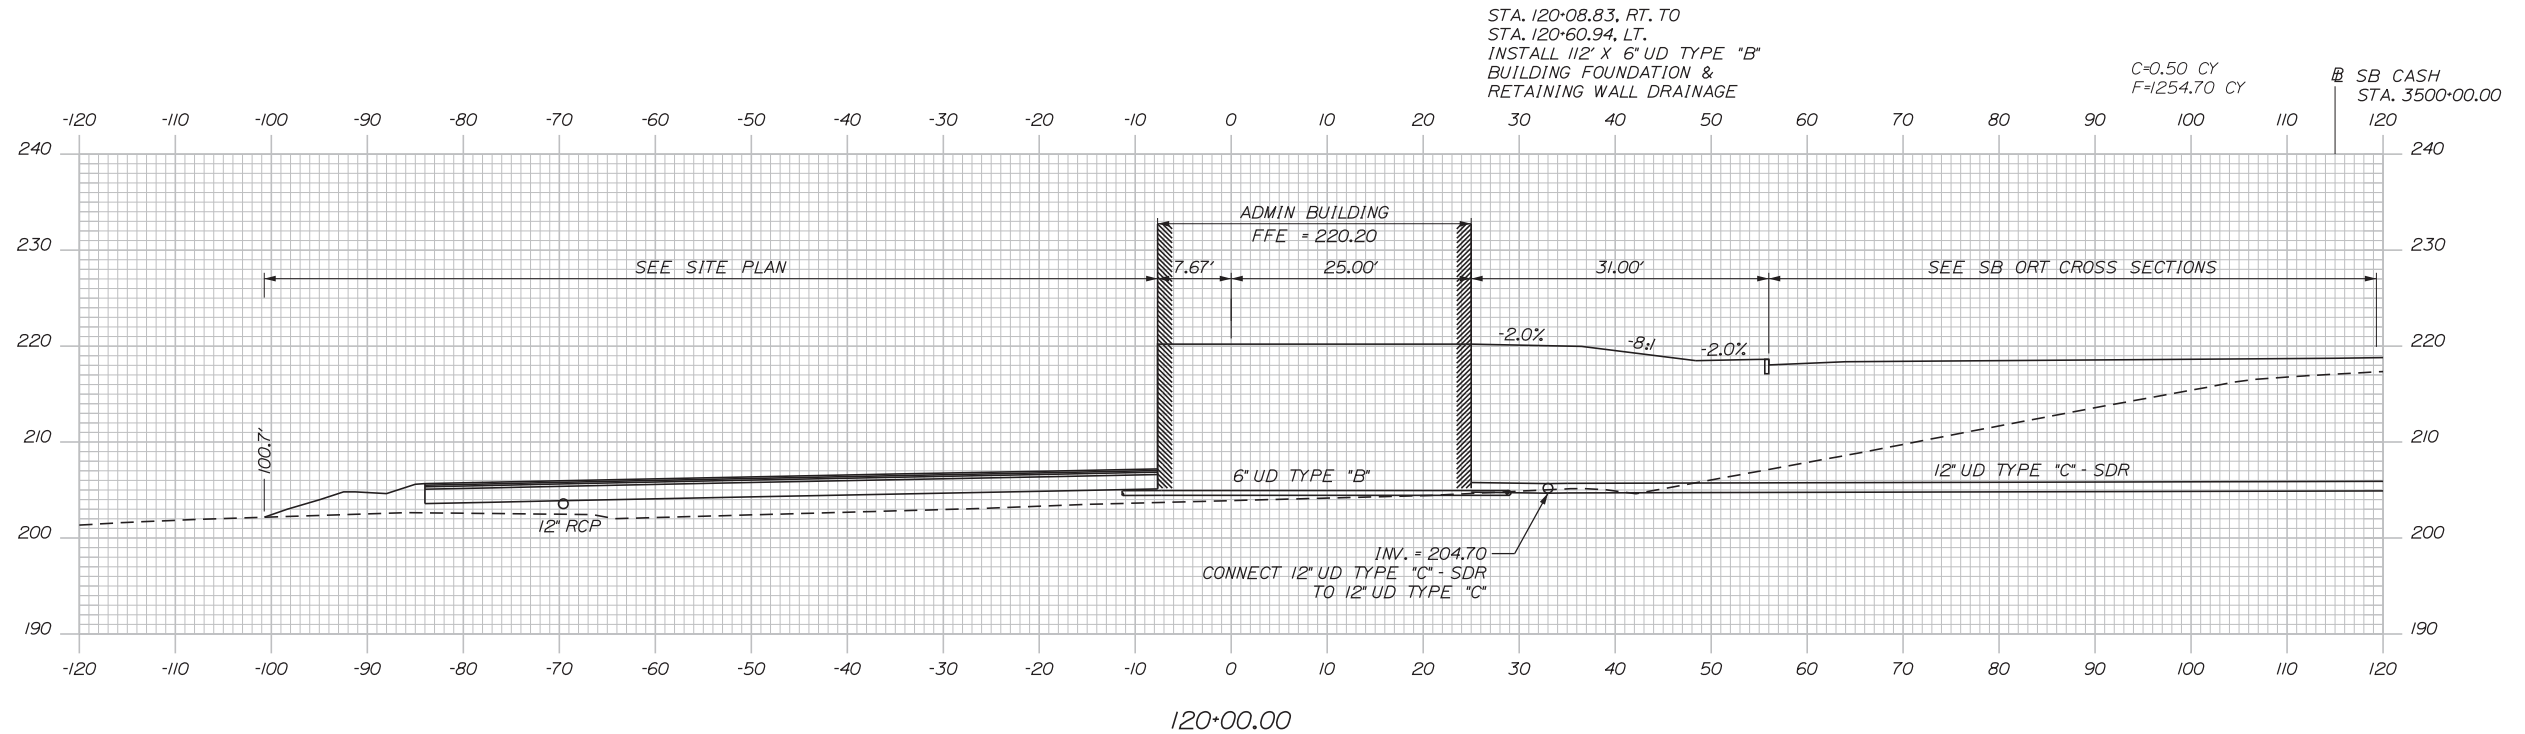

Designed by:


**Stantec**

CONSULTANT PROJECT MANAGER: LAUREN MEEK, PE

No.	Revision	By	Date

	By	Date		By	Date
Designed	PLP	3\20\19	Checked	LEM	3\20\19
Drawn	EJB	3\20\19	In Charge of	GAE	3\20\19

STANTEC CONSULTING SERVICES INC.  
 482 PAYNE ROAD  
 SCARBOROUGH, ME 04074  
 TEL (207) 887-3448  
 FAX (207) 883-3376

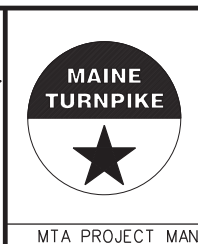

**THE GOLD STAR  
 MEMORIAL HIGHWAY**

MTA PROJECT MANAGER: RALPH NORWOOD, IV, PE, PTOE




INTERCHANGE 103  
 ORT CONVERSION  
 ACCESS ROAD  
 STA. 119+50.00 TO STA. 120+00.00

SHEET NUMBER: XS-123  
 357 OF 503

CONTRACT: 2019.04

Date: 3/20/2019

 Filename: ... \00\HIGHWAY\MSTA\\_xsect.dgn

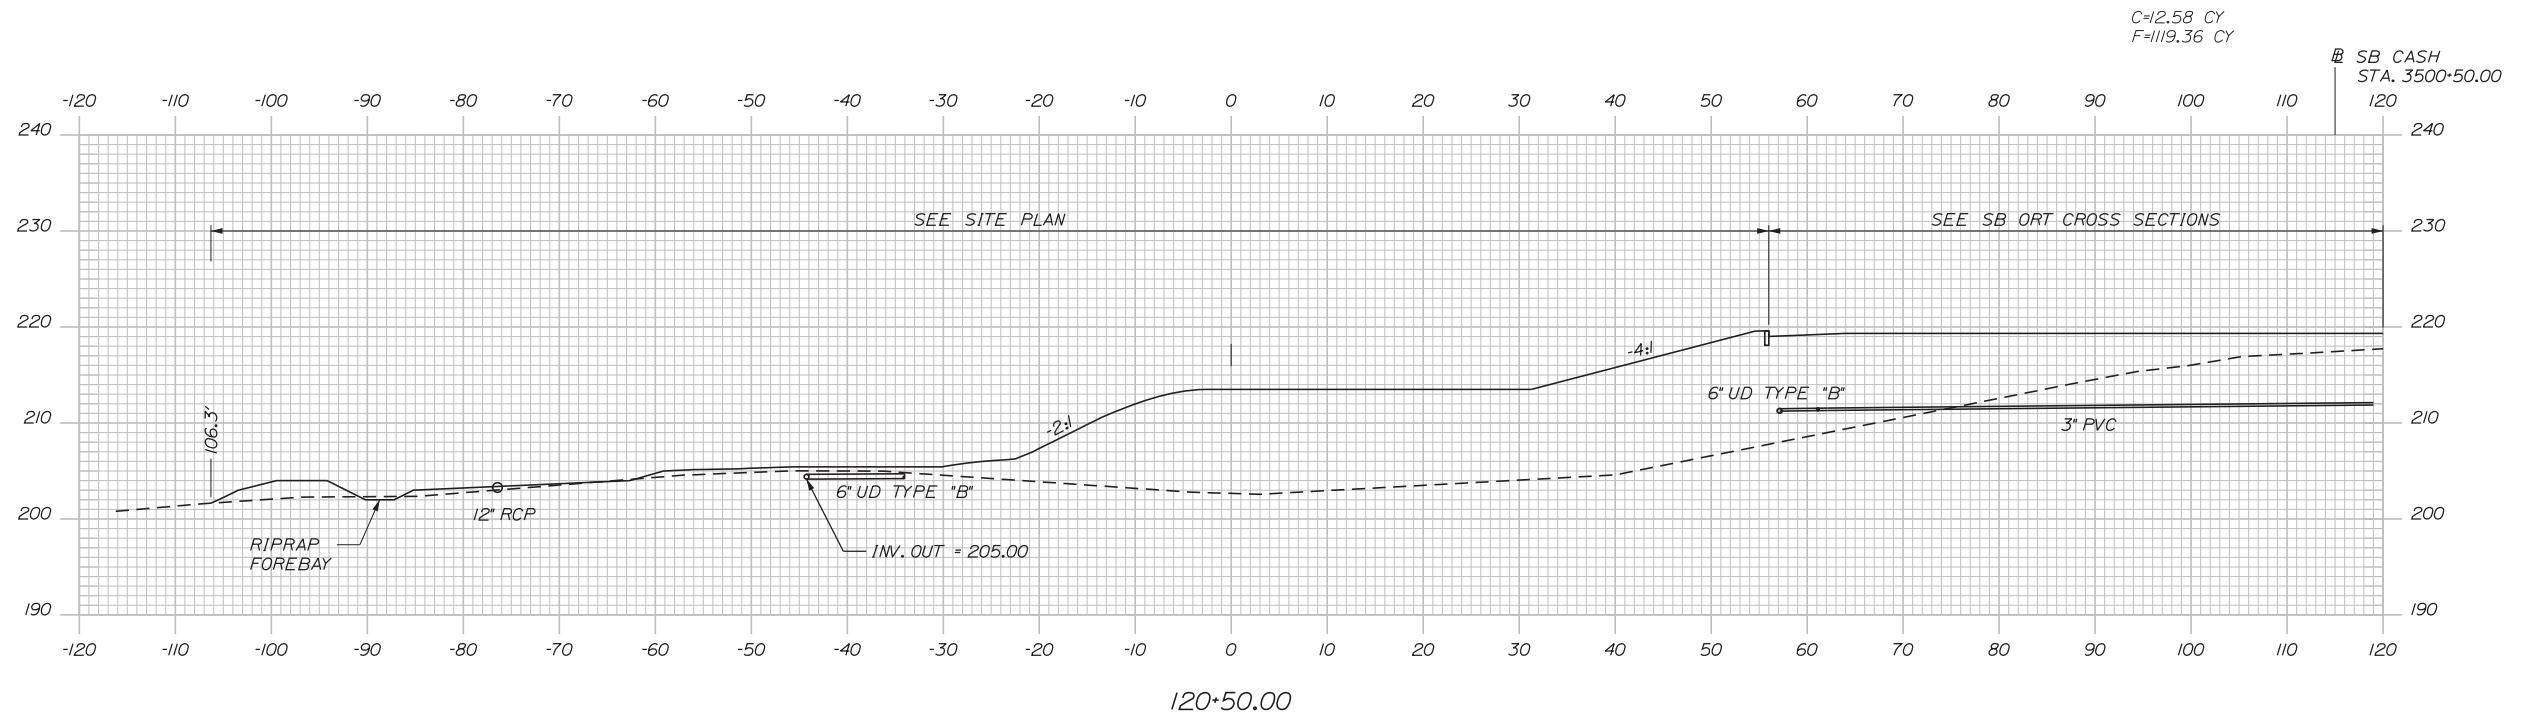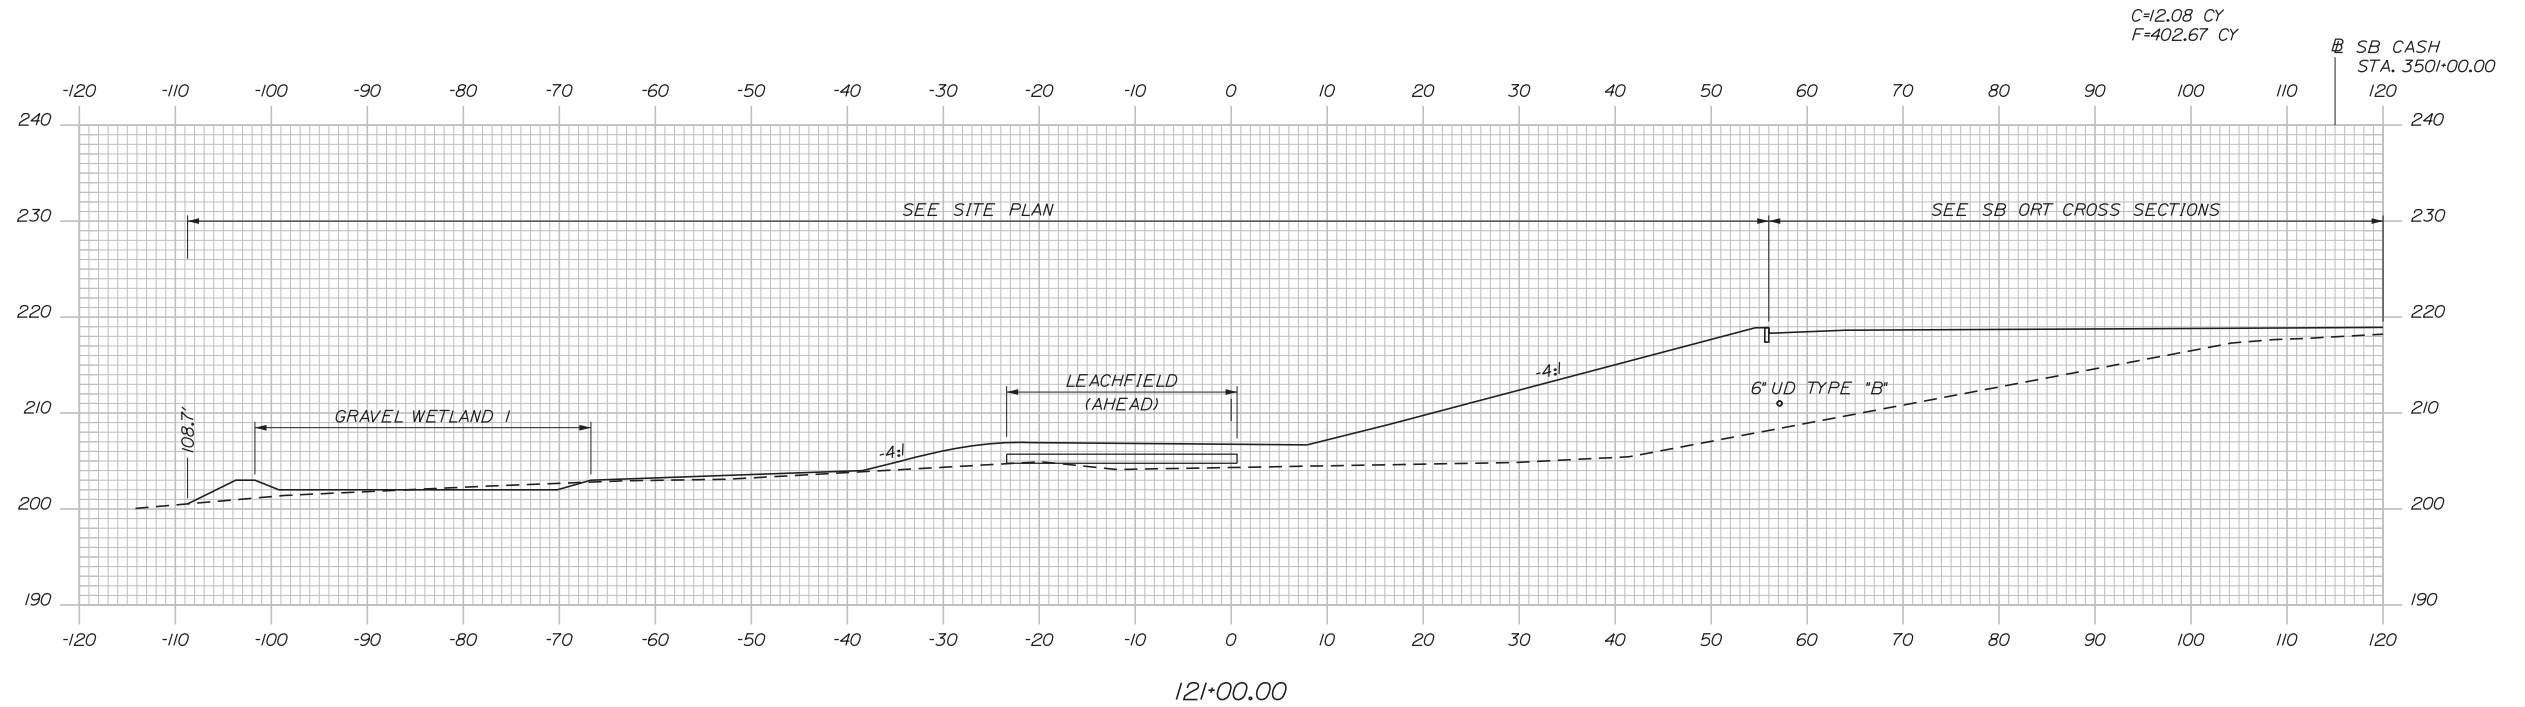

No.	Revision	By	Date

Designed by:

**Stantec**

CONSULTANT PROJECT MANAGER: LAUREN MEEK, PE

	By	Date		By	Date
Designed	PLP	3\20\19	Checked	LEM	3\20\19
Drawn	EJB	3\20\19	In Charge of	GAE	3\20\19

STANTEC CONSULTING SERVICES INC.  
 482 PAYNE ROAD  
 SCARBOROUGH, ME 04074  
 TEL (207) 887-3448  
 FAX (207) 883-3376



**THE GOLD STAR  
 MEMORIAL HIGHWAY**

MTA PROJECT MANAGER: RALPH NORWOOD, IV, PE, PTOE

INTERCHANGE 103  
 ORT CONVERSION  
 ACCESS ROAD  
 STA. 120+50.00 TO STA. 121+00.00

SHEET NUMBER: XS-124  
 358 OF 503

CONTRACT: 2019.04